



NOT FOR
CONSTRUCTION

This drawing is subject to copyright and remains the property of the consultant. Drawings shall not be reproduced or copied in part or in whole without the permission of the consultant.
Do not scale from drawings. Only figured dimensions, elevations and datums are to be taken from drawings and are to be site verified by contractor. Report any discrepancies to the consultant prior to the commencement of construction.

CLIENT

StreetSide
A QUALICO Company




MILE ARCHITECTURE
79 TUSCANY VALLEY RISE NW
CALGARY, AB
(587) 770-1155

ARCHITECTURAL

DRAWING LIST

DP0.00	COVER SHEET
DP0.01	PROJECT INFORMATION AND PHOTOS
DP0.02	VEHICLE MANUEVERING PLANS
DP1.00	SITE PLAN
DP1.01	ENLARGED SITE PLANS AND SITE SECTIONS
DP1.02	SITE DETAILS
DP2.00	PARADE FLOOR PLAN
DP2.01	LEVEL 1 FLOOR PLAN
DP2.02	LEVEL 2 FLOOR PLAN
DP2.03	LEVEL 3 FLOOR PLAN
DP2.04	LEVEL 4 FLOOR PLAN
DP2.05	ROOF PLAN
DP3.00	UNIT PLANS
DP4.00	BUILDING ELEVATIONS
DP4.01	BUILDING ELEVATIONS
DP5.00	BUILDING SECTIONS

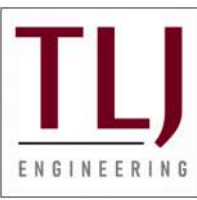


TLJ ENGINEERING
#301, 301 14 STREET NW
CALGARY, AB
(825) 609-6848

ELECTRICAL

DRAWING LIST

E1.00	SITE PLAN SITE LIGHTING LAYOUT
-------	--------------------------------

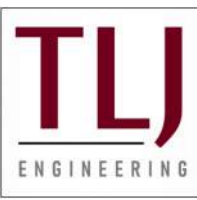

TLJ ENGINEERING
#301, 301 14 STREET NW
CALGARY, AB
(825) 609-6848

MECHANICAL



TRL & ASSOCIATES
#100, 1615 10 AVENUE SW
CALGARY, AB
(403) 244-4944

STRUCTURAL



VERITAS DEVELOPMENT SOLUTIONS
#4, 141 COMMERCIAL DRIVE
CALGARY, AB
(587) 393-5653

CIVIL

DRAWING LIST

SVC	SITE SERVICING PLAN (FOR DP)
GRAD	SITE GRADING PLAN (FOR DP)



ARCADIS PROFESSIONAL SERVICES
227 11 AVENUE SW
CALGARY, AB
(403) 271-7710

LANDSCAPE

DRAWING LIST

L1.1	TREE PROTECTION PLAN
L1.2	LANDSCAPE PLAN
L1.3	PLANTING PLAN

DEVELOPMENT
PERMIT
DECISION
RENDERED
ON THIS PLAN

PROJECT NAME / ADDRESS

RANGEVIEW MULTIFAMILY

91 RANGEVIEW GATE S.E.
CALGARY, AB


REVISIONS

DESCRIPTION	DATE
-- DEVELOPMENT PERMIT	2025-09-08
R1 DR 1 RESPONSE	2025-12-22
R2 DR 2 RESPONSE	2026-02-02
R3 DR 3 RESPONSE	2026-06-29

SHEET NUMBER / NAME

DP0.00

COVER SHEET

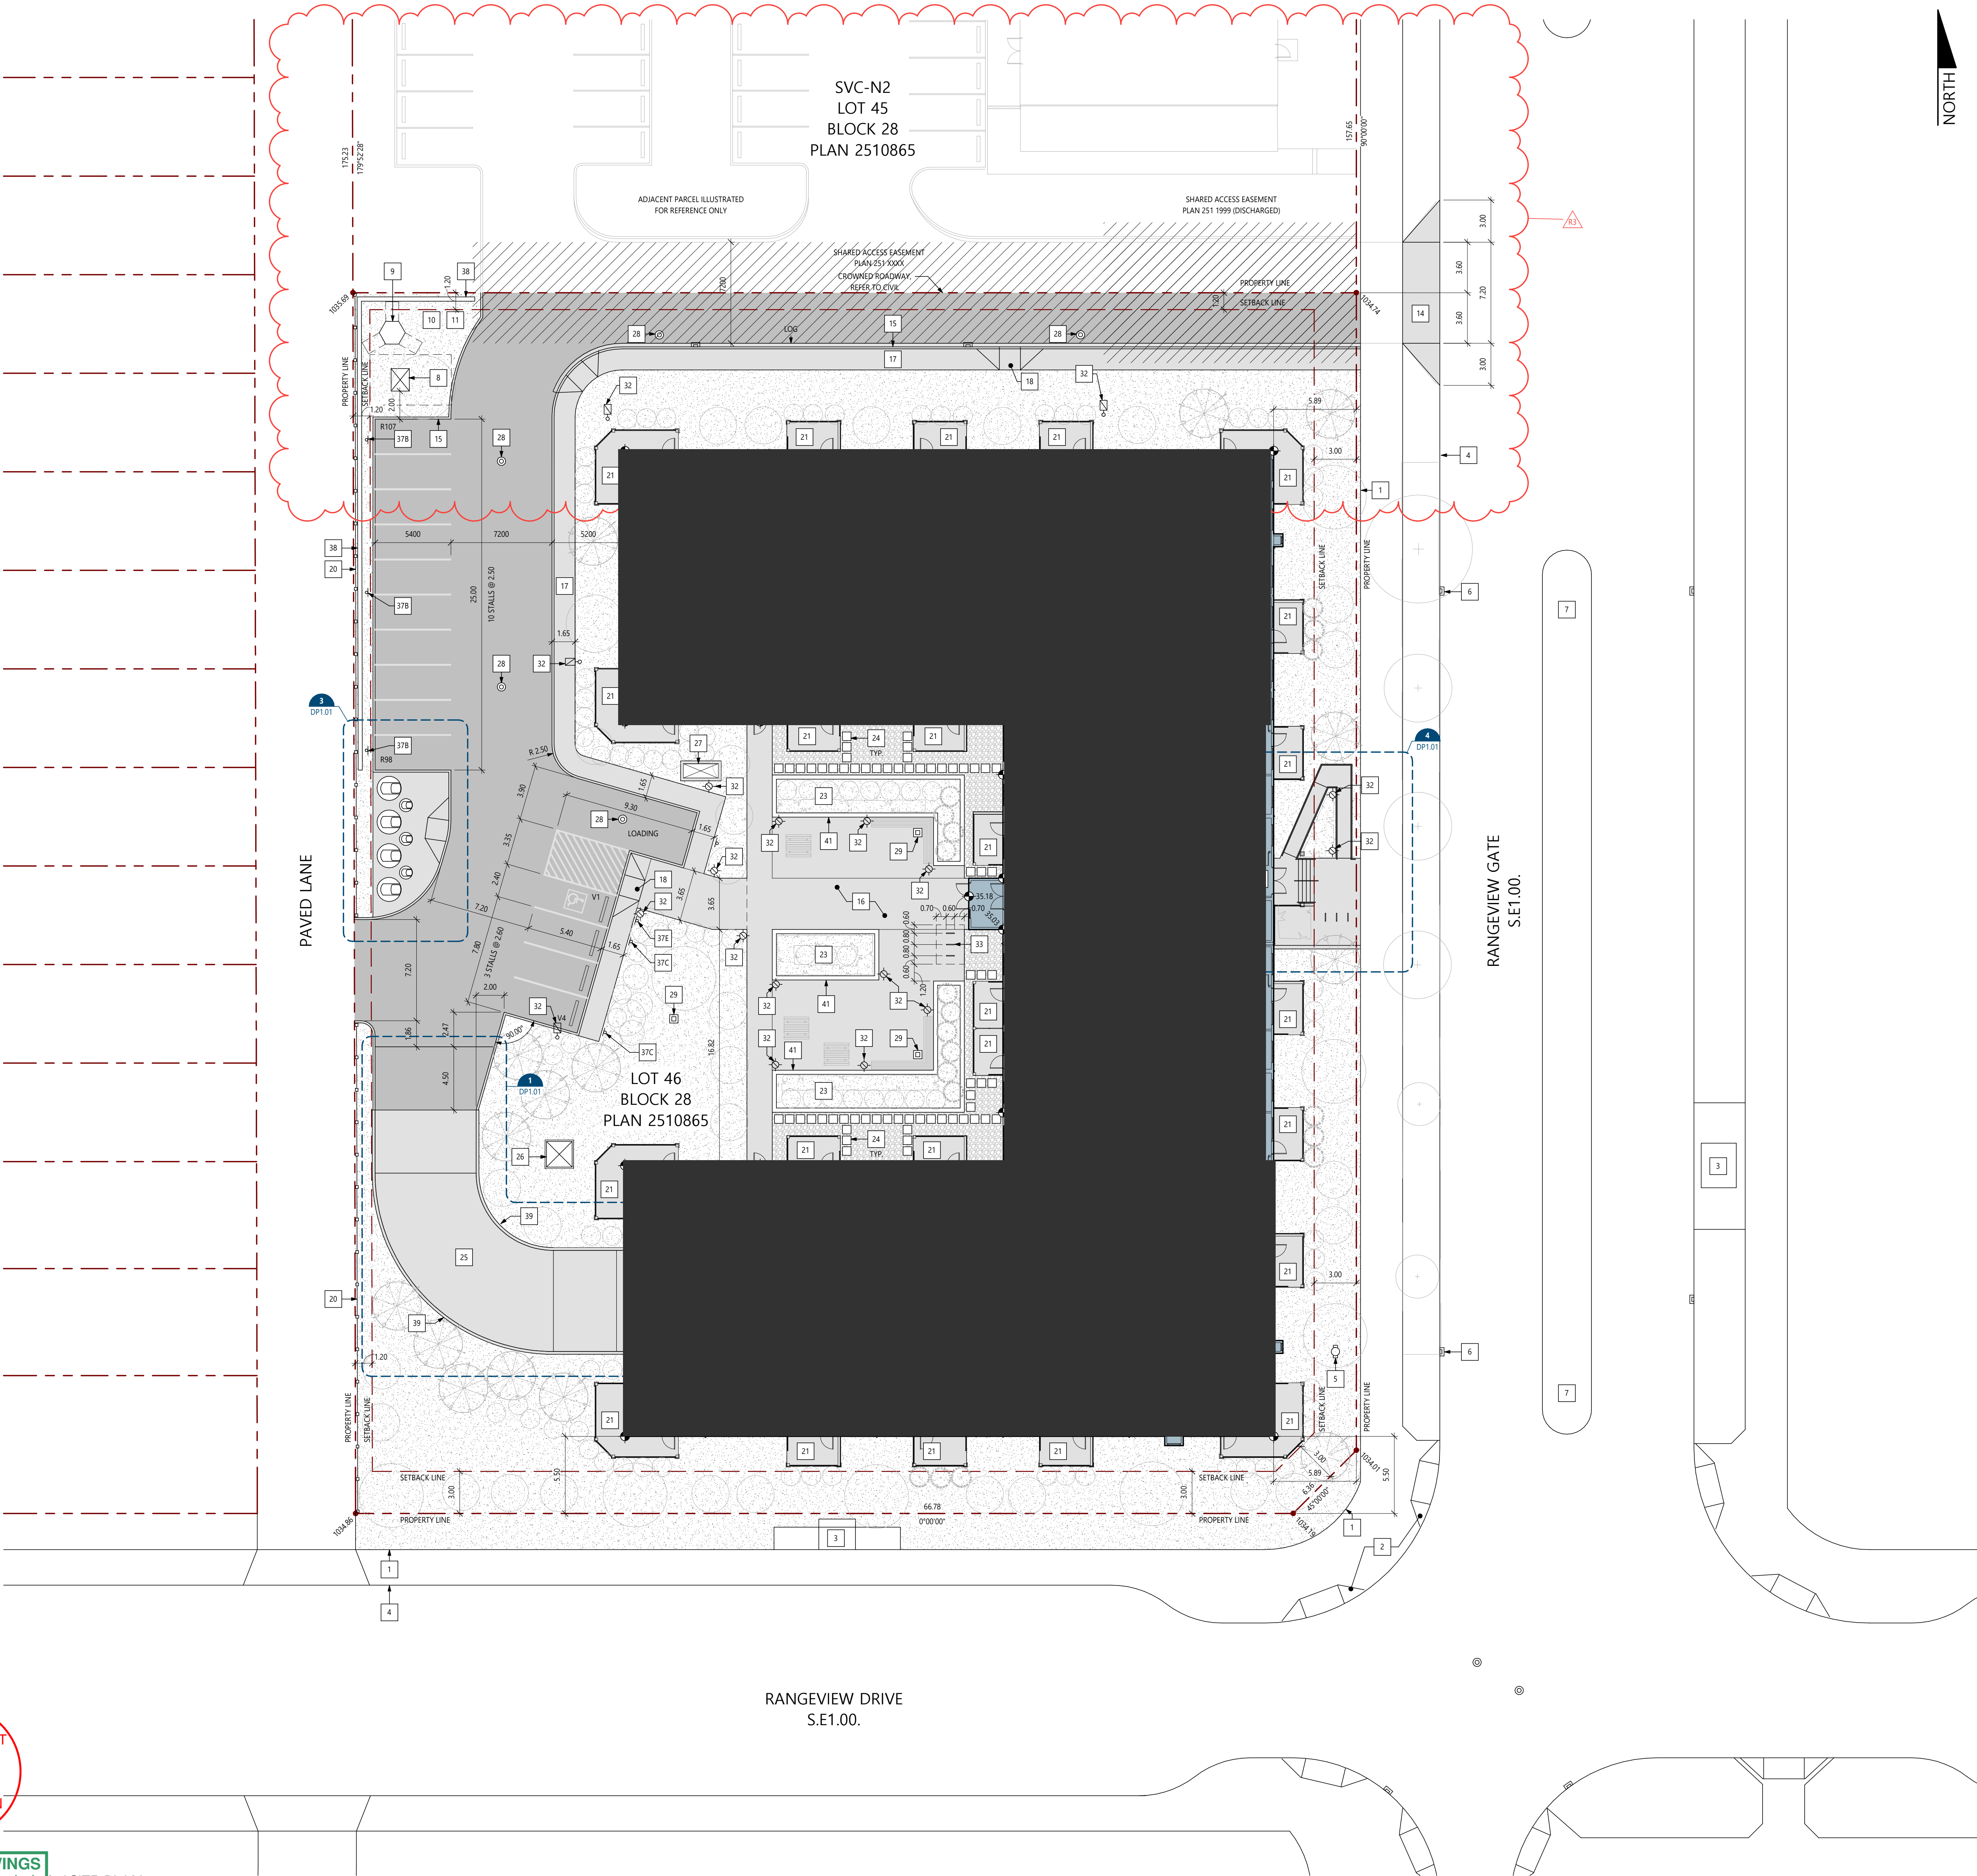

SITE GENERAL NOTES

- REFER TO CIVIL DRAWINGS FOR SITE GRADING AND UTILITY LOCATIONS
- REFER TO LANDSCAPE DRAWINGS FOR ADDITIONAL LANDSCAPING INFORMATION
- REFER TO ELECTRICAL LIGHTING DRAWINGS FOR SITE LIGHTING DETAILS

SITE SYMBOLS

- INDICATES EXTENT OF PROPOSED BUILDING
- INDICATES EXTENT OF PROPOSED ASPHALT DRIVE AISLE PAVING DESIGNED TO SUPPORT VEHICLE WEIGHT OF 38556 kg MIN.
- INDICATES EXTENT OF PROPOSED CONCRETE SIDEWALK / DRIVE APRON / PATIO
- INDICATES EXTENT OF LANDSCAPING. REFER TO LANDSCAPE DRAWINGS
- INDICATES EXTENT OF SHARED ACCESS EASEMENT
- INDICATES PROPOSED OVERHANG ABOVE
- 100.00 INDICATES PROPOSED SPOT ELEVATION. ALL ELEVATIONS REFERENCED FROM 1000 m GEODETIC DATUM
- R00 INDICATES RESIDENT PARKING STALL
- V00 INDICATES VISITOR PARKING STALL

SITE KEYNOTES

- | # | DESCRIPTION |
|----|--|
| 1 | FUTURE CITY CONCRETE SIDEWALK (BOW) |
| 2 | FUTURE CITY CONCRETE WHEELCHAIR RAMP |
| 3 | FUTURE BUS STOP LOCATION AS PER NSP |
| 4 | FUTURE FACE OF CITY CONCRETE CURB |
| 5 | PROPOSED FIRE HYDRANT WITHIN 45 m OF PRINCIPAL ENTRANCE. REFER TO CIVIL DRAWINGS |
| 6 | FUTURE CITY CATCH BASIN |
| 7 | FUTURE CITY LIGHT STANDARD |
| 8 | FUTURE TRANSFORMER BY ENMAX |
| 9 | FUTURE PULLBOX BY ENMAX |
| 10 | FUTURE TELLS INFRASTRUCTURE. LOCATION TO BE CONFIRMED |
| 11 | FUTURE ROGERS INFRASTRUCTURE. LOCATION TO BE CONFIRMED |
| 12 | PROPOSED PRINCIPAL ENTRANCE |
| 13 | PROPOSED FIRE DEPARTMENT CONNECTION |
| 14 | PROPOSED CONCRETE DRIVE AISLE APRON AND CURB CUT TO CITY STANDARDS. DESIGNED TO SUPPORT VEHICLE WEIGHT OF 38556 kg MIN. |
| 15 | PROPOSED BARRIER CONCRETE CURB. REFER TO CIVIL DRAWINGS |
| 16 | PROPOSED LANDSCAPE AND SITE AMENITY AREA. REFER TO LANDSCAPE DRAWINGS FOR DETAILS |
| 17 | PROPOSED CONCRETE SIDEWALK WITH BROOM FINISH TO MEET CITY STANDARDS |
| 18 | PROPOSED MONOLITHIC SIDEWALK WHEEL CHAIR RAMP. REFER TO DETAIL 1/DP1.02 |
| 19 | PROPOSED PAINTED CROSSWALK |
| 20 | PROPOSED WOOD PRIVACY FENCE, 1.83 m HIGH. REFER TO DETAIL 7/DP1.02 |
| 21 | PROPOSED CONCRETE PATIO WITH BROOM FINISH (PRIVATE AMENITY) |
| 22 | PROPOSED BALCONY SUPPORT POST. REFER TO FLOOR PLANS |
| 23 | PROPOSED AREA OF SOFT LANDSCAPING. REFER TO LANDSCAPE DRAWINGS |
| 24 | PROPOSED CONCRETE PAVEMENT. REFER TO LANDSCAPE DRAWINGS |
| 25 | PROPOSED HEATED CONCRETE DRIVEWAY RAMP WITH BROOM FINISH |
| 26 | PROPOSED PREFABRICATED METAL LOUVERED MECHANICAL PENTHOUSE. FINISH GREY. REFER TO DETAIL 8/DP1.02 |
| 27 | PROPOSED MECHANICAL EXHAUST WELL FROM PARKADE |
| 28 | PROPOSED MANHOLE. REFER TO CIVIL DRAWINGS |
| 29 | PROPOSED AREA DRAIN. REFER TO CIVIL DRAWINGS |
| 30 | PROPOSED MECHANICAL TRENCH DRAIN SYSTEM |
| 31 | PROPOSED SHALLOW UTILITY RIGHT OF WAY. TO BE CONFIRMED |
| 32 | PROPOSED LIGHT STANDARD. REFER TO ELECTRICAL DRAWINGS |
| 33 | PROPOSED SURFACE MOUNTED U-TYPE BIKE RACK (2 CLASS-2 STALLS PER RACK) |
| 34 | PROPOSED 6.5 yd ³ DEEP WASTE COLLECTION CONTAINER (WASTE / RECYCLING). REFER TO DETAIL 6/DP1.02 |
| 35 | PROPOSED 1.7 yd ³ DEEP WASTE COLLECTION CONTAINER (ORGANICS). REFER TO DETAIL 6/DP1.02 |
| 36 | PROPOSED MOLLOK WASTE COLLECTION TRUCK CRANE REACH, 7.62 m MIN. OVERHEAD CLEARANCE REQUIRED |
| 37 | A - PROPOSED POST MOUNTED 'STOP' SIGN
B - PROPOSED POST MOUNTED 'RESIDENT PARKING' SIGN
C - PROPOSED POST MOUNTED 'VISITOR PARKING' SIGN
D - PROPOSED POST MOUNTED 'NO PARKING' SIGN
E1.00 - PROPOSED POST MOUNTED 'BARRIER FREE' SIGN |
| 38 | PROPOSED UNIT MASONRY RETAINING WALL. WALL TO BE LESS THAN 1.2 m IN HEIGHT. REFER TO CIVIL DRAWINGS FOR DETAILS |
| 39 | PROPOSED CAST-IN-PLACE CONCRETE WALL, SACK RUBBED FINISH, WITH 1.07 m HIGH PREFINISHED METAL FENCE / GUARD. REFER TO DETAIL 5/DP1.02 |
| 40 | PROPOSED CAST-IN-PLACE CONCRETE RETAINING WALL. EXPOSED AGGREGATE FINISH |
| 41 | PROPOSED RAISED UNIT MASONRY PLANTER. REFER TO LANDSCAPE DRAWINGS |
| 42 | PROPOSED CAST-IN-PLACE CONCRETE RAMP, BROOM HORIZONTAL FINISH, EXPOSED AGGREGATE VERTICAL FINISH |
| 43 | PROPOSED CAST-IN-PLACE CONCRETE STAIRS, BROOM HORIZONTAL FINISH, EXPOSED AGGREGATE VERTICAL FINISH. REFER TO DETAIL 2/DP1.02 |
| 44 | PROPOSED STEEL PIPE HANDRAIL WITH EDGE PROTECTION. BLACK FINISH. REFER TO DETAIL 4/DP1.02 |
| 45 | PROPOSED STEEL PIPE HANDRAIL, BLACK FINISH. REFER TO DETAIL 3/DP1.02 |
| 46 | PROPOSED 1.07 m HIGH PREFINISHED ALUMINUM RAILING SYSTEM WITH GLASS INFILL PANEL, WHITE |
| 47 | PROPOSED FIRE ALARM PANEL |
| 48 | PROPOSED FIRE DEPARTMENT LOCK-BOX |
| 49 | PROPOSED BARRIER-FREE AUTO-DOOR OPERATOR BUTTON |

NOT FOR
CONSTRUCTION

This drawing is subject to copyright and remains the property of the consultant. Drawings shall not be reproduced or copied in part or in whole without the permission of the consultant.
Do not scale from drawings. Only figured dimensions, elevations and datums are to be taken from drawings and are to be site verified by contractor. Report any discrepancies to the consultant prior to the commencement of construction.

CLIENT

PROJECT NAME / ADDRESS

RANGEVIEW MULTIFAMILY

91 RANGEVIEW GATE S.E.
CALGARY, AB

REVISIONS

DESCRIPTION	DATE
DEVELOPMENT PERMIT	2025-09-08
R1 DR 1 RESPONSE	2025-12-22
R2 DR 2 RESPONSE	2026-02-02
R3 DR 3 RESPONSE	2026-06-29

SHEET NUMBER / NAME

DP1.00

SITE PLAN

DEVELOPMENT
PERMIT
DECISION
RENDERED
ON THIS PLAN

AMENDED DRAWINGS
DP No Date Received
DP2025-05389 JUNE 25, 2026
THESE DRAWINGS REFER TO THE
ABOVE DEVELOPMENT PERMIT NO.

1 SITE PLAN
SCALE: 1:200



1 | EAST ELEVATION
DP4.00 | SCALE: 3/32" = 1'-0"



2 | NORTH ELEVATION
DP4.00 | SCALE: 3/32" = 1'-0"



3 | SOUTH ELEVATION
DP4.00 | SCALE: 3/32" = 1'-0"

ELEVATION KEYNOTES

#	DESCRIPTION
1	VINYL CLADDING, VERTICAL BOARD AND BATTEN PROFILE, WHITE
2	VINYL CLADDING, HORIZONTAL, WHITE
3	HARDBOARD TRIM, WHITE
4	HARDBOARD TRIM, CHARCOAL GREY (BALCONY POSTS AND FASCIA)
5	HARDBOARD TRIM, GREY
6	HARDBOARD DOOR AND WINDOW TRIM, WHITE
7	HARDBOARD DOOR AND WINDOW TRIM, GREY
8	HARDBOARD PANEL, WHITE
9	HARDBOARD PANEL, CHARCOAL GREY
10	HARDBOARD WOOD GRAINED PANEL, STAINED
11	ASPHALT SHINGLES, DARK GREY / BLACK MIX
12	VINYL WINDOW FRAMES, BLACK, WITH CLEAR INSULATED GLASS UNITS
13	PREFINISHED TRIM, GUTTERS, AND DOWNSPOUTS, GREY
14	PREFINISHED ALUMINUM BALCONY RAILING SYSTEM WITH WIDE PROFILE VERTICAL PICKETS, BLACK
15	PREFINISHED ALUMINUM RAILING SYSTEM WITH GLASS INFILL PANEL, WHITE
16	MECHANICALLY FASTENED CULTURED STONE RAINSCREEN SYSTEM, 'CHARCOAL'
17	CEMENT PARGING, NATURAL
18	FIBREGLASS EXTERIOR DOOR, GREY
19	PREFINISHED ALUMINUM ENTRY DOOR / FRAMES, BLACK, SVC/W CLEAR INSULATED GLAZING UNITS
20	INSULATED METAL DOOR, GREY
21	OVERHEAD GARAGE DOOR, GREY
22	PREFINISHED PROFILED METAL SIDING, WHITE
23	FIRE DEPARTMENT CONNECTION
24	ADDRESS SIGNAGE TBD
25	PREFINISHED METAL LOUVER, WHITE
26	CEMENTITIOUS CLADDING, HORIZONTAL, WHITE

DESCRIPTION	DATE
DEVELOPMENT PERMIT	2025-09-08
R1 DR 1 RESPONSE	2025-12-22
R2 DR 2 RESPONSE	2026-02-02
R3 DR 3 RESPONSE	2026-06-29

DEVELOPMENT
PERMIT
DECISION
RENDERED
ON THIS PLAN




1 | WEST ELEVATION
DP4.01 | SCALE: 3/32" = 1'-0"




2 | NORTH COURTYARD ELEVATION
DP4.01 | SCALE: 3/32" = 1'-0"



3 | SOUTH COURTYARD ELEVATION
DP4.01 | SCALE: 3/32" = 1'-0"

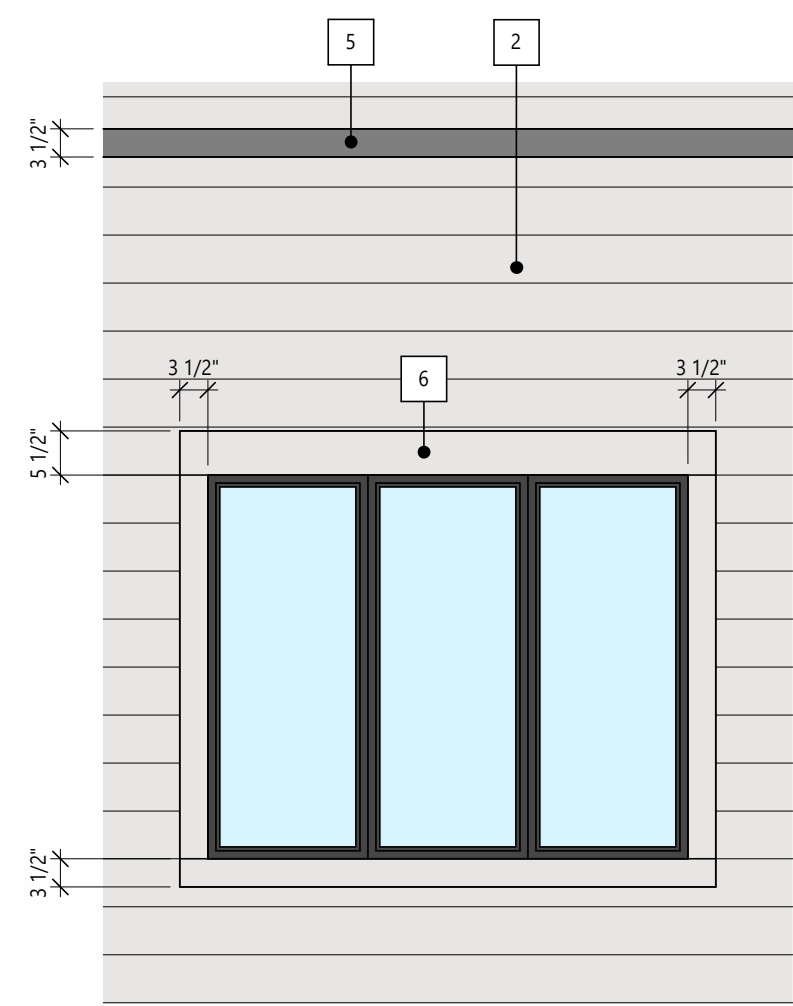

4 | ENLARGED WINDOW ELEVATION
DP4.01 | SCALE: 1/2" = 1'-0"

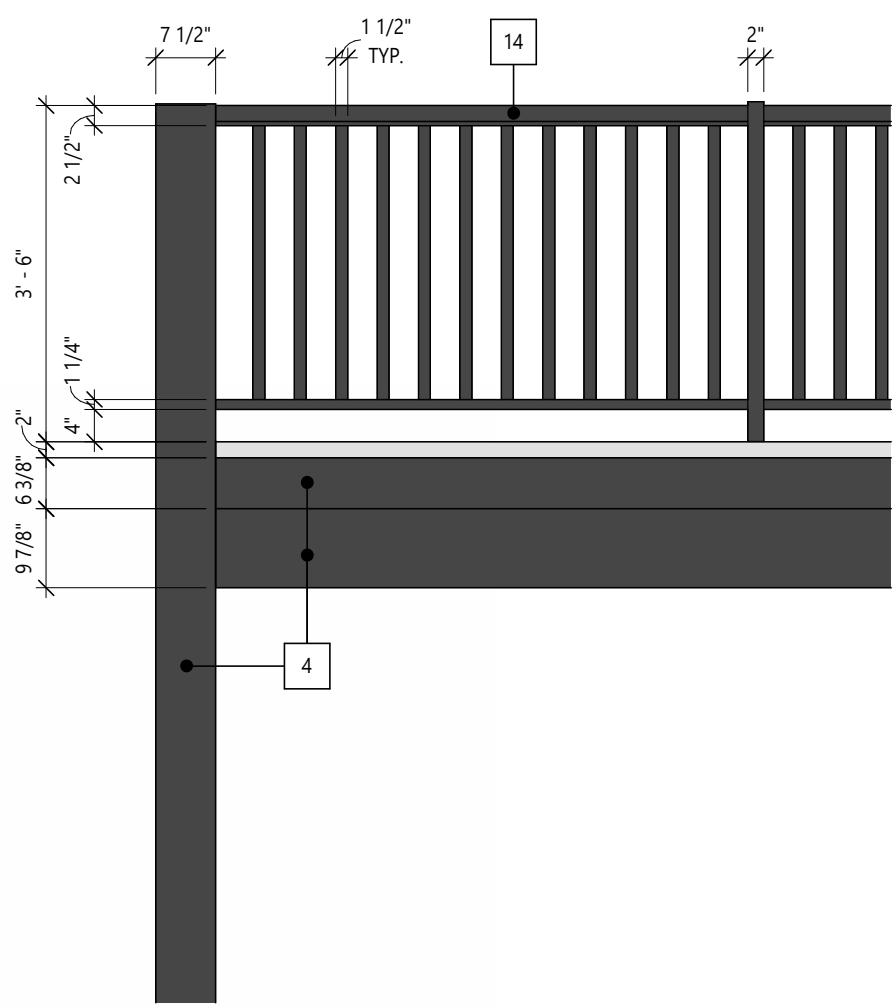


5 | ENLARGED BALCONY ELEVATION
DP4.01 | SCALE: 1/2" = 1'-0"

ELEVATION KEYNOTES

#	DESCRIPTION
1	VINYL CLADDING, VERTICAL BOARD AND BATTEN PROFILE, WHITE
2	VINYL CLADDING, HORIZONTAL, WHITE
3	HARDBOARD TRIM, WHITE
4	HARDBOARD TRIM, CHARCOAL GREY (BALCONY POSTS AND FASCIA)
5	HARDBOARD TRIM, GREY
6	HARDBOARD DOOR AND WINDOW TRIM, WHITE
7	HARDBOARD DOOR AND WINDOW TRIM, GREY
8	HARDBOARD PANEL, WHITE
9	HARDBOARD PANEL, CHARCOAL GREY
10	HARDBOARD WOOD GRAINED PANEL, STAINED
11	ASPHALT SHINGLES, DARK GREY / BLACK MIX
12	VINYL WINDOW FRAMES, BLACK, WITH CLEAR INSULATED GLASS UNITS
13	PREFINISHED TRIM, GUTTERS, AND DOWNSPOUTS, GREY
14	PREFINISHED ALUMINUM BALCONY RAILING SYSTEM WITH WIDE PROFILE VERTICAL PICKETS, BLACK
15	PREFINISHED ALUMINUM RAILING SYSTEM WITH GLASS INFILL PANEL, WHITE
16	MECHANICALLY FASTENED CULTURED STONE RAINSCREEN SYSTEM, 'CHARCOAL'
17	CEMENT PARGING, NATURAL
18	FIBREGLASS EXTERIOR DOOR, GREY
19	PREFINISHED ALUMINUM ENTRY DOOR / FRAMES, BLACK, SVC/W CLEAR INSULATED GLAZING UNITS
20	INSULATED METAL DOOR, GREY
21	OVERHEAD GARAGE DOOR, GREY
22	PREFINISHED PROFILED METAL SIDING, WHITE
23	FIRE DEPARTMENT CONNECTION
24	ADDRESS SIGNAGE TBD
25	PREFINISHED METAL LOUVER, WHITE
26	CEMENTITIOUS CLADDING, HORIZONTAL, WHITE

DESCRIPTION	DATE
DEVELOPMENT PERMIT	2025-09-08
R1 DR 1 RESPONSE	2025-12-22
R2 DR 2 RESPONSE	2026-02-02
R3 DR 3 RESPONSE	2026-06-29

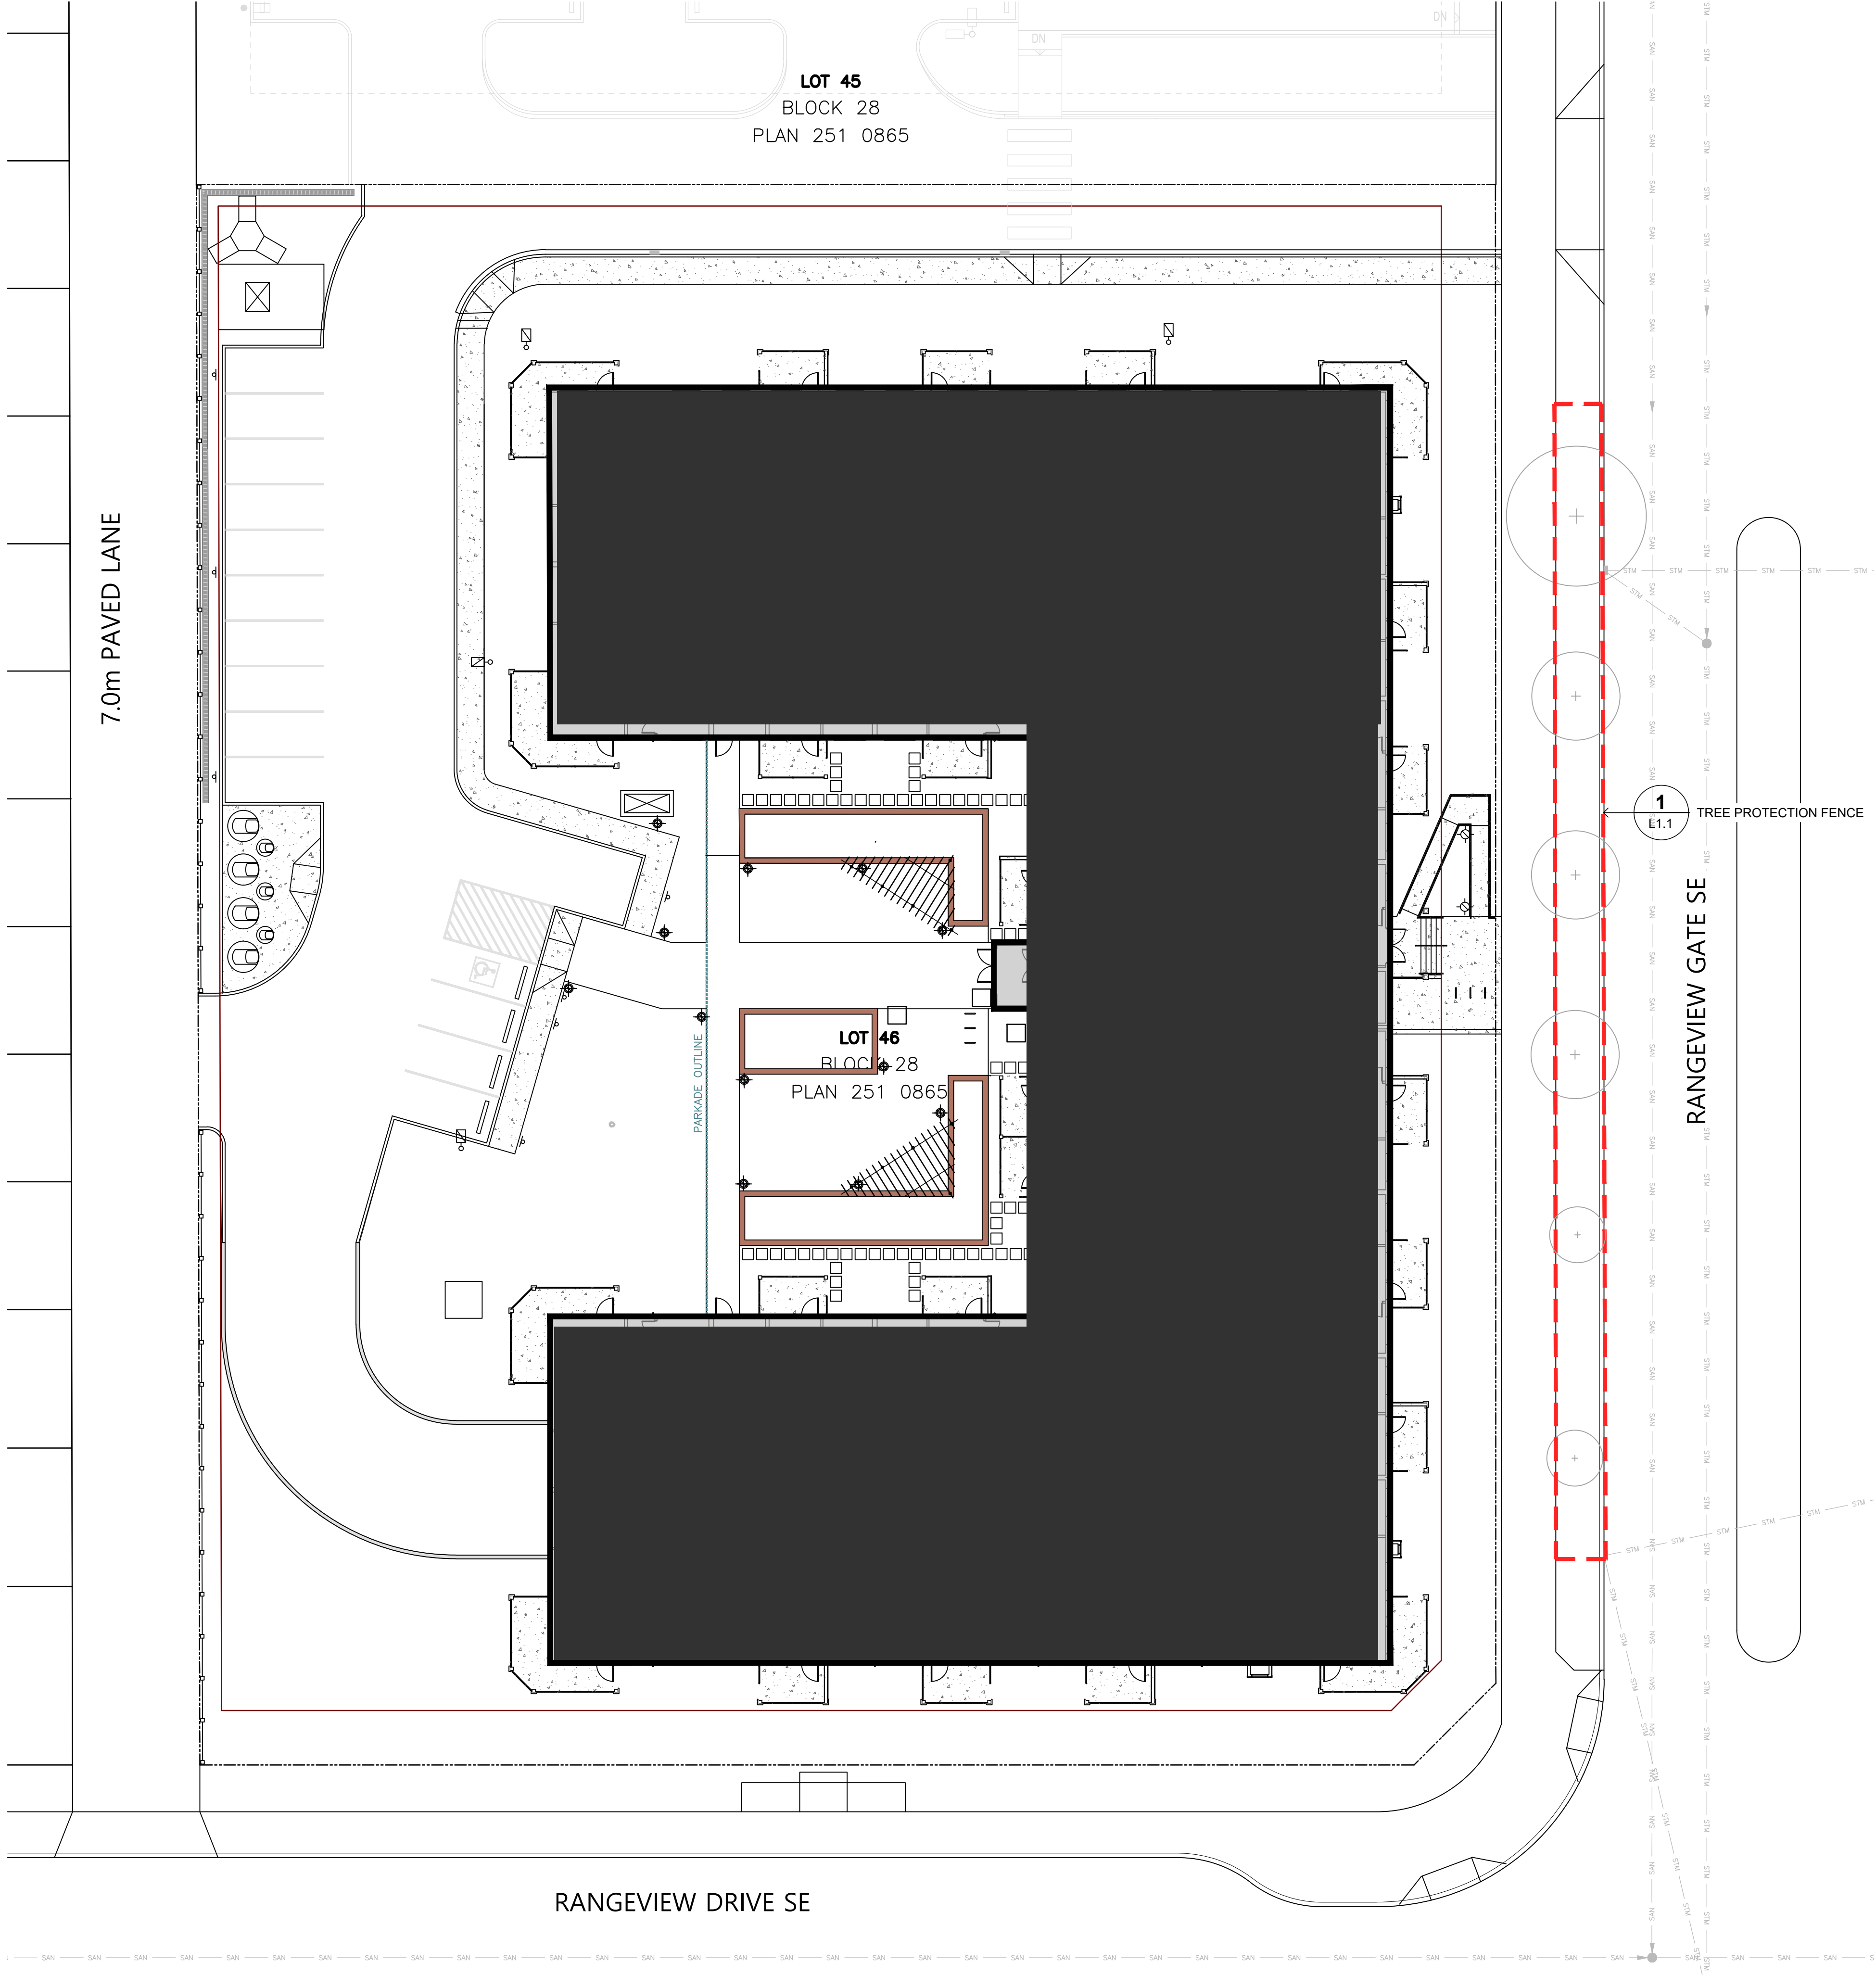

1
L1.1
TREE PROTECTION PLAN
SCALE 1:200

DEVELOPMENT
PERMIT
DECISION
RENDERED
ON THIS PLAN

AMENDED DRAWINGS
DP No Date Received
DP2025-05389 JUNE 25, 2026
THESE DRAWINGS REFER TO THE
ABOVE DEVELOPMENT PERMIT NO.

LEGEND


----- PROPERTY LINE

+ DECIDUOUS STREET TREE TO REMAIN AND PROTECT

• FUTURE BOULEVARD PLANTING (NOT A PART OF THE DP SUBMISSION)

1
L1.1 EXTENT OF TREE PROTECTION FENCE

- NOTES**
1. TREE SURVEY INFORMATION PROVIDED BY IBI GROUP AND BASED ON CITY OF CALGARY APPROVED LINE ASSIGNMENT DRAWINGS
 2. TREE PROTECTION MEASURES AS PER CITY OF CALGARY TREE PLAN GUIDELINES. (SEE PAGE 62 CURRENT EDITION OF THE CITY OF CALGARY PARKS DEVELOPMENT GUIDELINES AND STANDARD SPECIFICATIONS LANDSCAPE CONSTRUCTION
 3. TEMPORARY TREE PROTECTION FENCING OR BARRIER MATERIAL SHALL BE A BRIGHT OR CONTRASTING COLOUR AND BE DURABLE. FENCE POSTS SHALL BE COMPARABLE TO METAL T-POSTS OR HEAVIER. FENCE WILL BE MAINTAINED IN AN UPRIGHT POSITION THROUGHOUT THE DURATION OF THE PROJECT, AS PER CITY OF CALGARY PARKS TREE PROTECTION PLAN SPECIFICATIONS.
 4. TREE PROTECTION FENCING TO REMAIN IN PLACE FOR DURATION OF SITE CONSTRUCTION
 5. ALL TREES WITHIN 6.0m OF THE PROJECT BOUNDARY SHALL BE PROTECTED BY FENCING DESCRIBED IN THE NOTES ABOVE.
 6. PRIOR TO CONSTRUCTION, AND AFTER TEMPORARY FENCE INSTALLATION, THE CONTRACTOR SHALL CONTACT CITY OF CALGARY URBAN FORESTRY AND ARRANGE AN ON SITE MEETING PRIOR TO COMMENCING CONSTRUCTION.
 7. THE CONTRACTOR SHALL ADHERE TO ALL CITY OF CALGARY URBAN FORESTRY REQUIREMENTS AND APPROVALS PRIOR TO COMMENCING CONSTRUCTION.
 8. (SEE CITY OF CALGARY "TREE PROTECTION PLANS FOR CAPITAL PROJECTS" BROCHURE.)
 9. NO STORAGE OF CONSTRUCTION MATERIALS SHALL OCCUR WITHIN FENCED TREE PROTECTION ZONES.

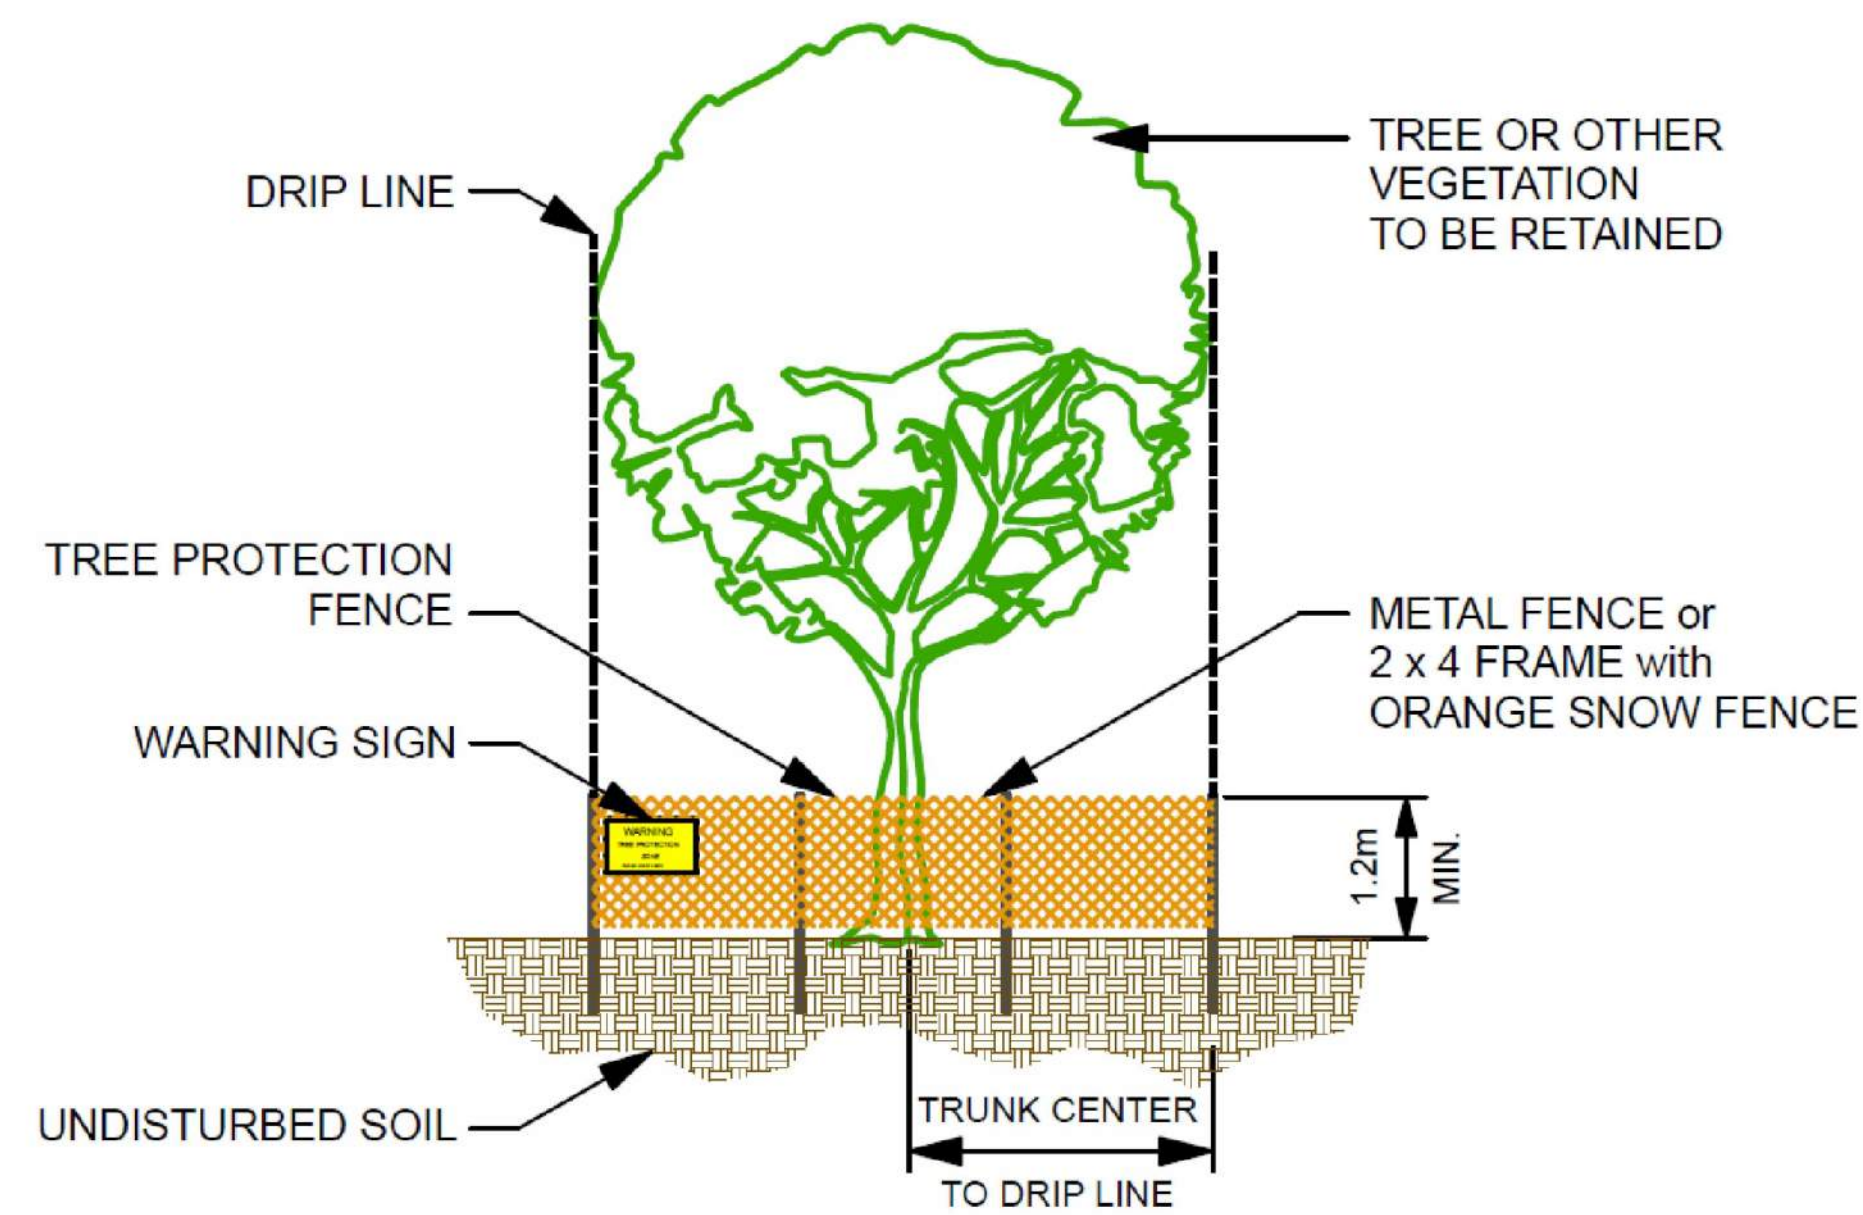

1
L1.1
TREE PROTECTION DETAIL
NTS

This drawing is subject to copyright and remains the property of the consultant. Drawings shall not be reproduced or copied in part or in whole without the permission of the consultant.
Do not scale from drawings. Only figured dimensions, elevations, and datums are to be taken from drawings and are to be site verified by contractor. Report any discrepancies to the consultant prior to the commencement of construction.

CLIENT

StreetSide
A QUALICO Company

PROJECT NAME / ADDRESS

RANGEVIEW MULTIFAMILY

RANGEVIEW GATE S.E.
CALGARY, AB


ISSUED


1	DEVELOPMENT PERMIT	2025-02-21
2	DEVELOPMENT PERMIT	2025-09-04
3	DEVELOPMENT PERMIT	2026-02-04
4	DTR 3 SUBMISSION	2026-04-29

The Alberta
Association of
Landscape
Architects
Nataliya Imshenetska
Nataliya Imshenetska


SHEET NUMBER / NAME

L1.1
TREE PROTECTION PLAN

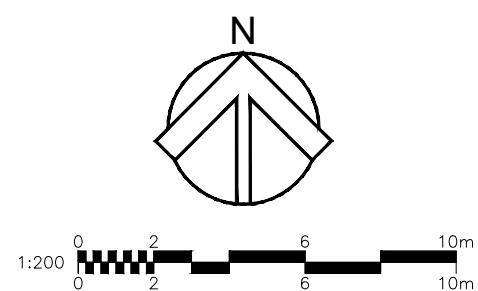

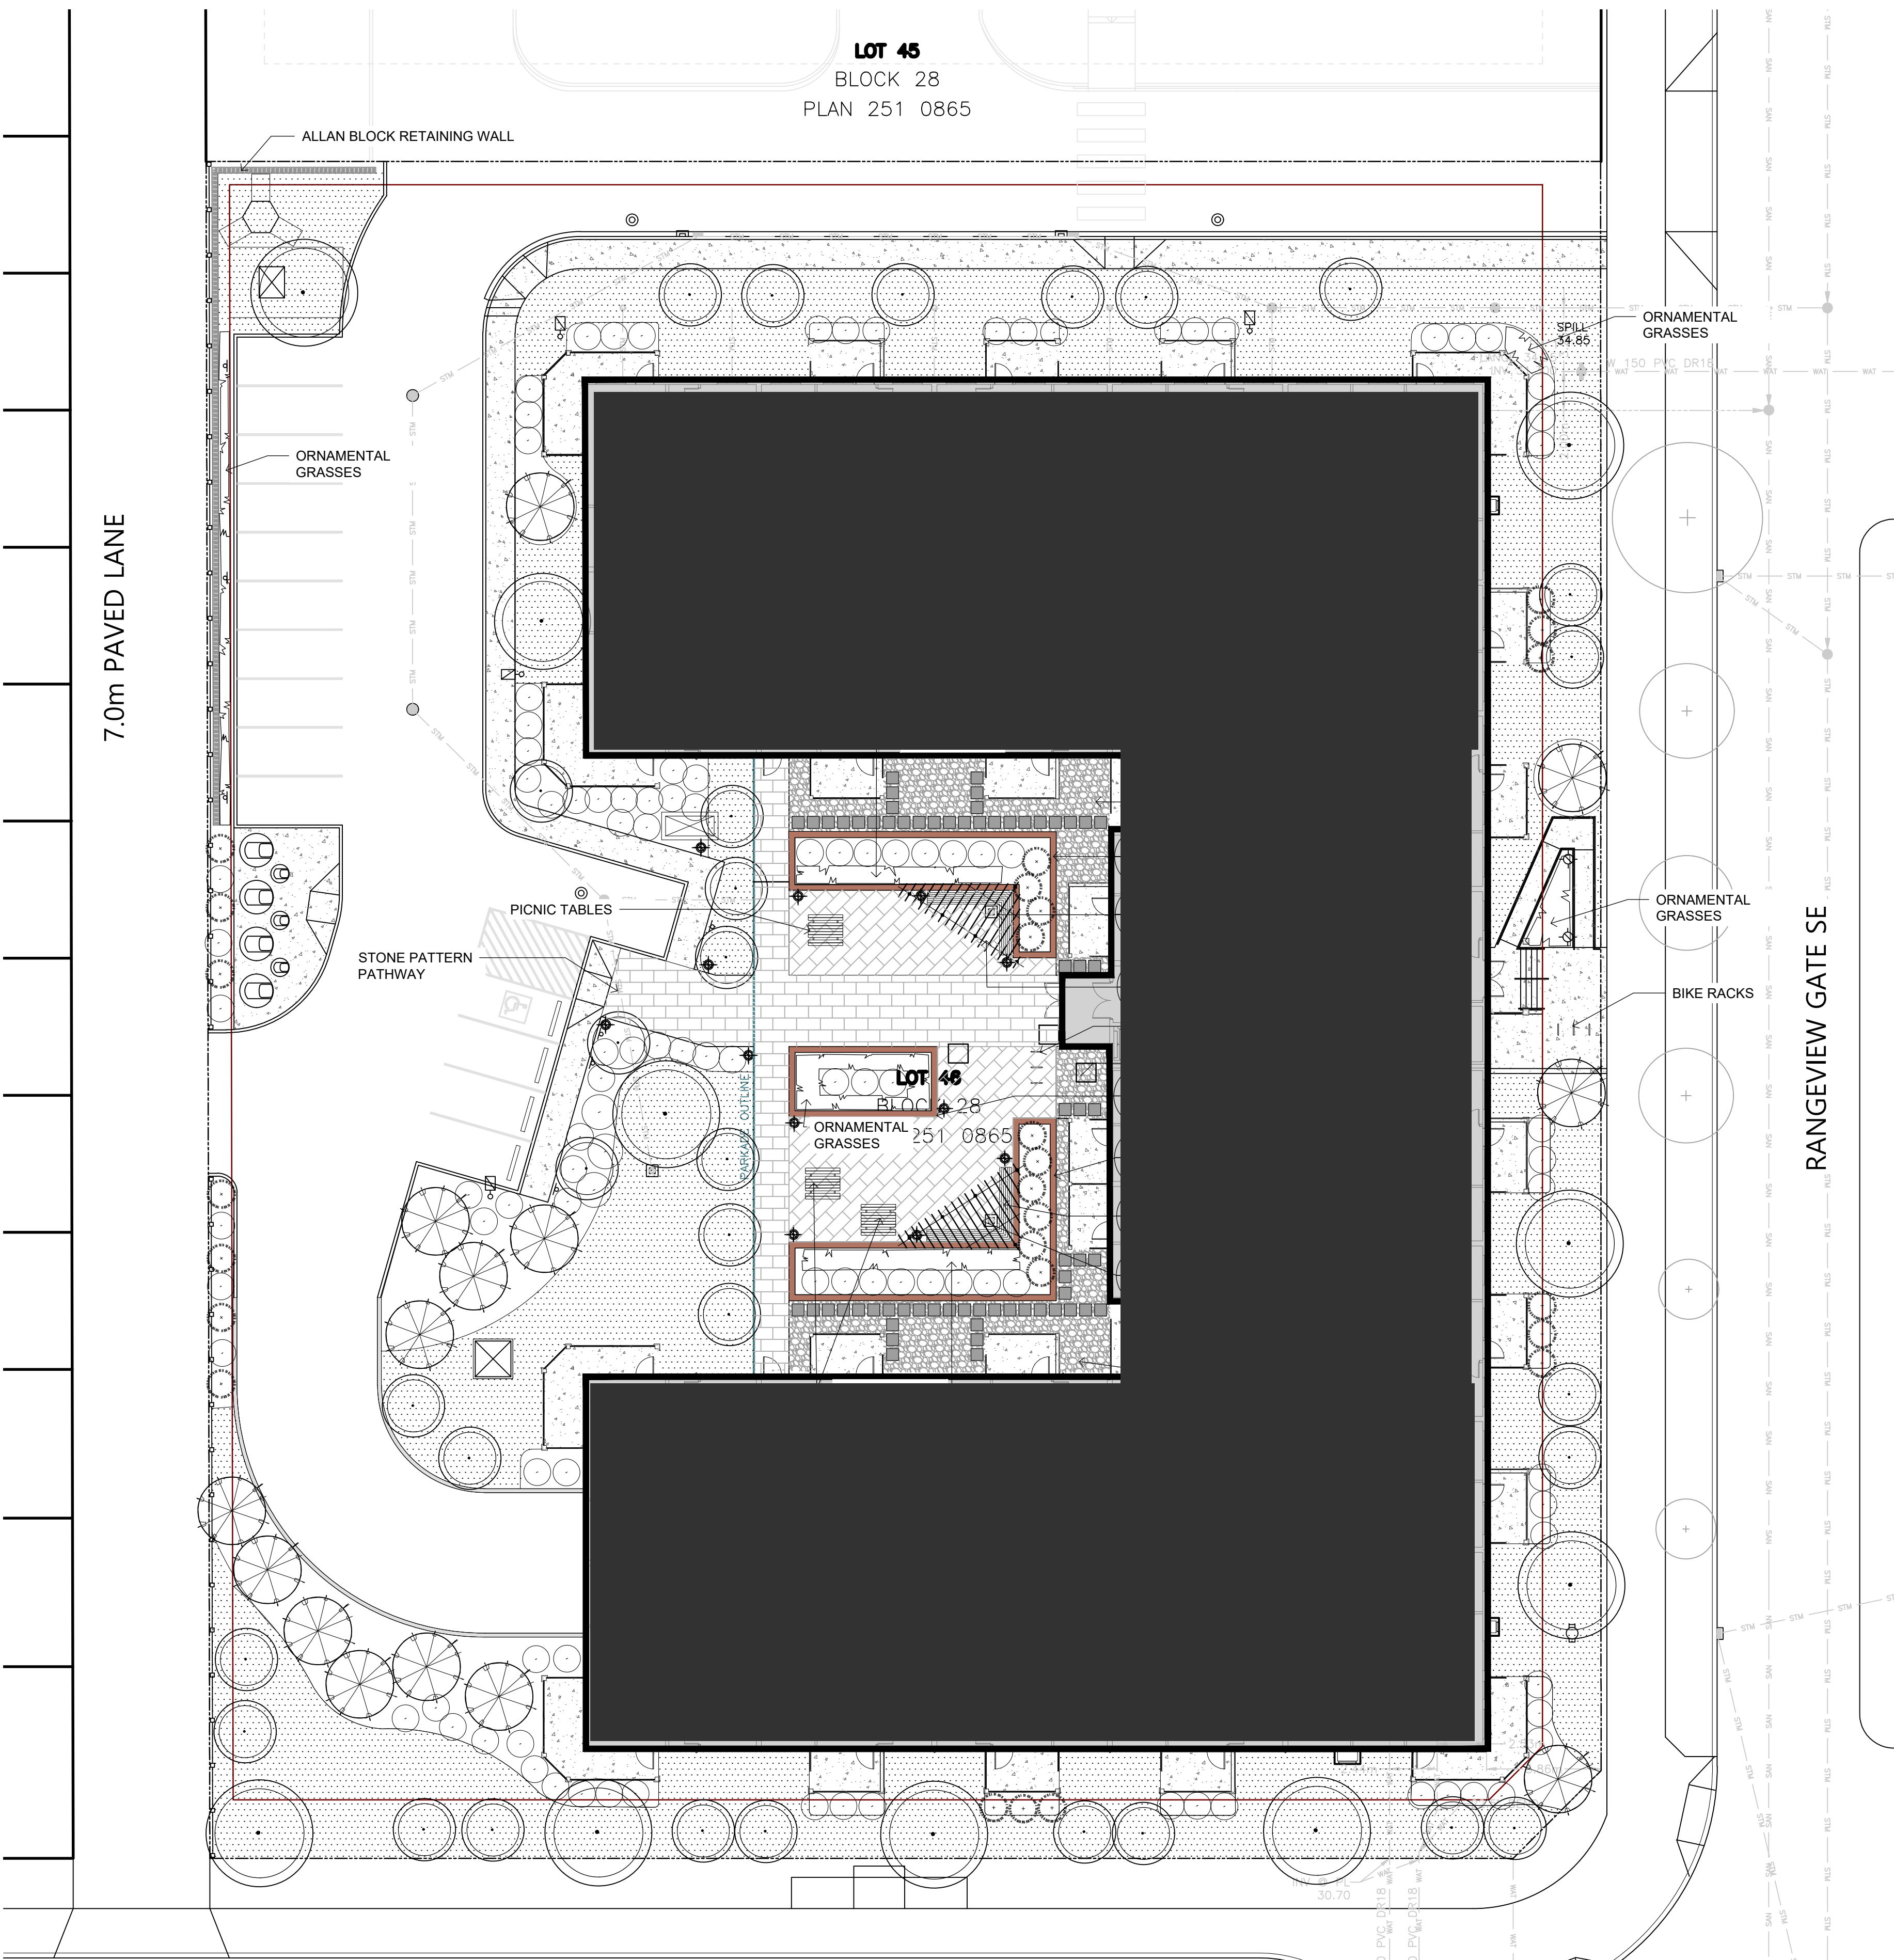

1 LANDSCAPE PLAN
L1.2 SCALE 1:200

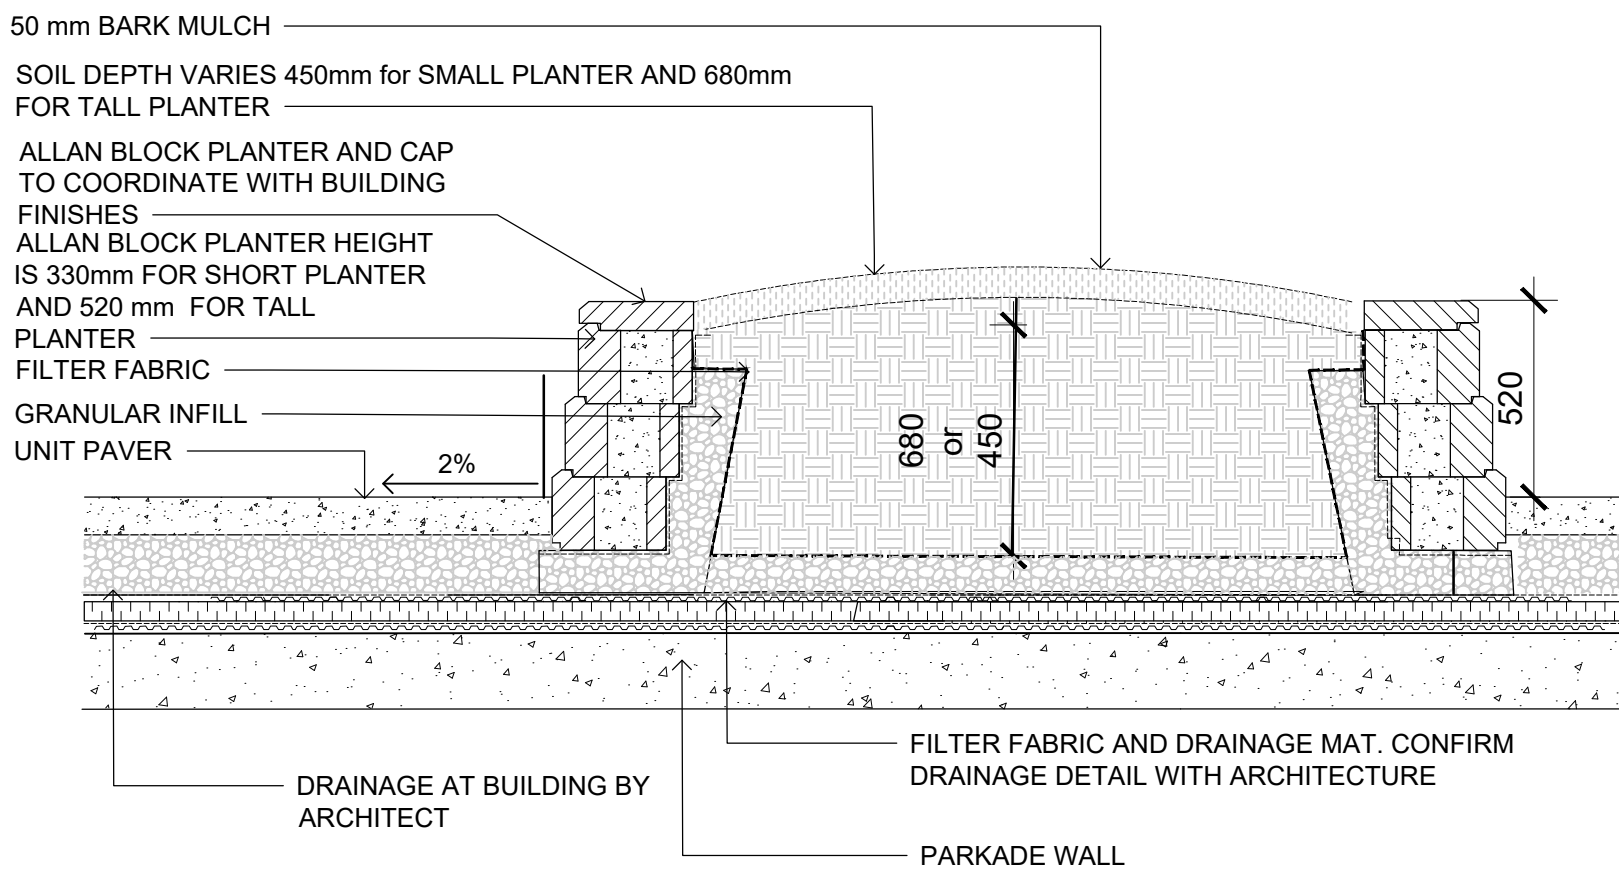

2 ALLAN BLOCK PLANTER (TYP)
L1.2 SCALE 1:25



SITE STATISTICS			
LAND USE BYLAW: M-1 Multi-Residential - Low Profile			
Total Site Development Area	6,191.89m ²	100%	
Building Footprint	2,385.95m ²	38.50%	
Roads and Parking	1,123.04m ²	18.20%	
Landscape Area Required (Including patios, decks and pathways)	2,476.75m ²	40.00%	
Landscape Area Provided	2,682.90m ²	43.30%	
Soft Landscape Area	1,676.42m ²	62.50%	
Hard Landscape Area	1,006.48m ²	37.50%	
Requires 2 shrubs / 45m ² of landscape	132	Shrubs	
Requires 1 tree / 45m ² of landscape	49	Trees	
A minimum of 25% of all trees provided must be coniferous	14	Coniferous	
	42	Deciduous	
Proposed Deciduous Trees (50mm cal.)		Trees	
Proposed Deciduous Trees (min 50% - 80mm cal.)		Trees	
Proposed Coniferous Trees (2000mm ht.)		Trees	
Proposed Coniferous Trees (min 50% - 3000mm ht.)		Trees	
Total Trees Provided	49	Trees	
Total Shrubs Provided	132	Shrubs	
Proposed Deciduous Shrubs			
Proposed Coniferous Shrubs			

- NOTES**
- ALL AREAS OF SOFT LANDSCAPING SHALL BE PROVIDED WITH AN UNDERGROUND SPRINKLER IRRIGATION SYSTEM (EXCLUDING THE NATURALIZED SEEDED AREA)
 - ALL CONSTRUCTION AND PLANTING DETAILS TO BE IN ACCORDANCE WITH THE CITY OF CALGARY PARKS AND RECREATION, STANDARD SPECIFICATIONS FOR LANDSCAPE CONSTRUCTION, CURRENT EDITION
 - ALL PLANT MATERIALS TO BE HIGH QUALITY / SPECIMEN.
 - DRAINAGE FLOWS TO BE DIRECTED AWAY FROM ALL BUILDINGS AT A MINIMUM GRADE OF 2% (SEE ENGINEERING DRAWING FOR GRADING PLAN)
 - ALL CONIFEROUS TREES AND SHRUBS SHALL BE PLANTED IN BEDS WITH A MINIMUM 75mm DEPTH OF CLEAN WOOD MULCH (MAXIMUM 100mm)
 - LIGHT BOLLARDS & COLUMNS TO BE SURFACE MOUNTED ON CONCRETE PAVING / OR SONO TUBE CONCRETE PILE IN SOFT LANDSCAPE AREAS (SEE ELECTRICAL DWGS)
 - ALL SUBSOIL TO BE PRE-SCARIFIED TO A DEPTH OF 100mm OR MORE AT ALL LOCATIONS WHERE TOPSOIL IS TO BE APPLIED
 - SEE ENGINEERING DRAWINGS FOR GRADING INFORMATION.





3 ARCO BOLD OR RIVA BOLD PERGOLA BY STUR DESIGN (TBD)
L1.2 NTS



4 OGDEN BENCH BY MAGLIN (TBD)
L1.2 NTS

LEGEND	
	PROPERTY LINE
	PROPOSED CONIFEROUS TREE
	PROPOSED DECIDUOUS TREE
	CONIFEROUS SHRUBS (MIN 600mm SPREAD)
	DECIDUOUS SHRUBS (MIN. 600mm HT.)
	PROPOSED PERENNIALS AND GRASSES
	IRRIGATED SOD WITH 300mm TOP SOIL
	CONCRETE SIDEWALKS AND ENTRANCE PATHWAYS WITH SAW CUT JOINTS, LIGHT SANDBLAST AND/OR BROOM FINISH
	STONE PATTERNED PATHWAY
	25mm WASHED ROCKS
	LIGHT FIXTURE SEE SITE LIGHTING PLAN
	LIGHTING BOLLARD SEE LIGHTING PLAN

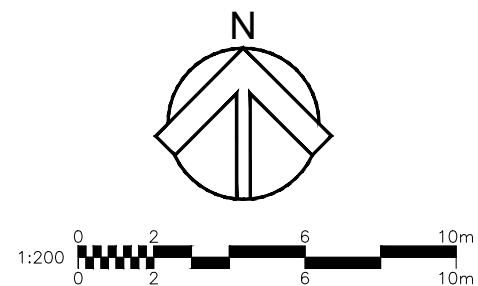

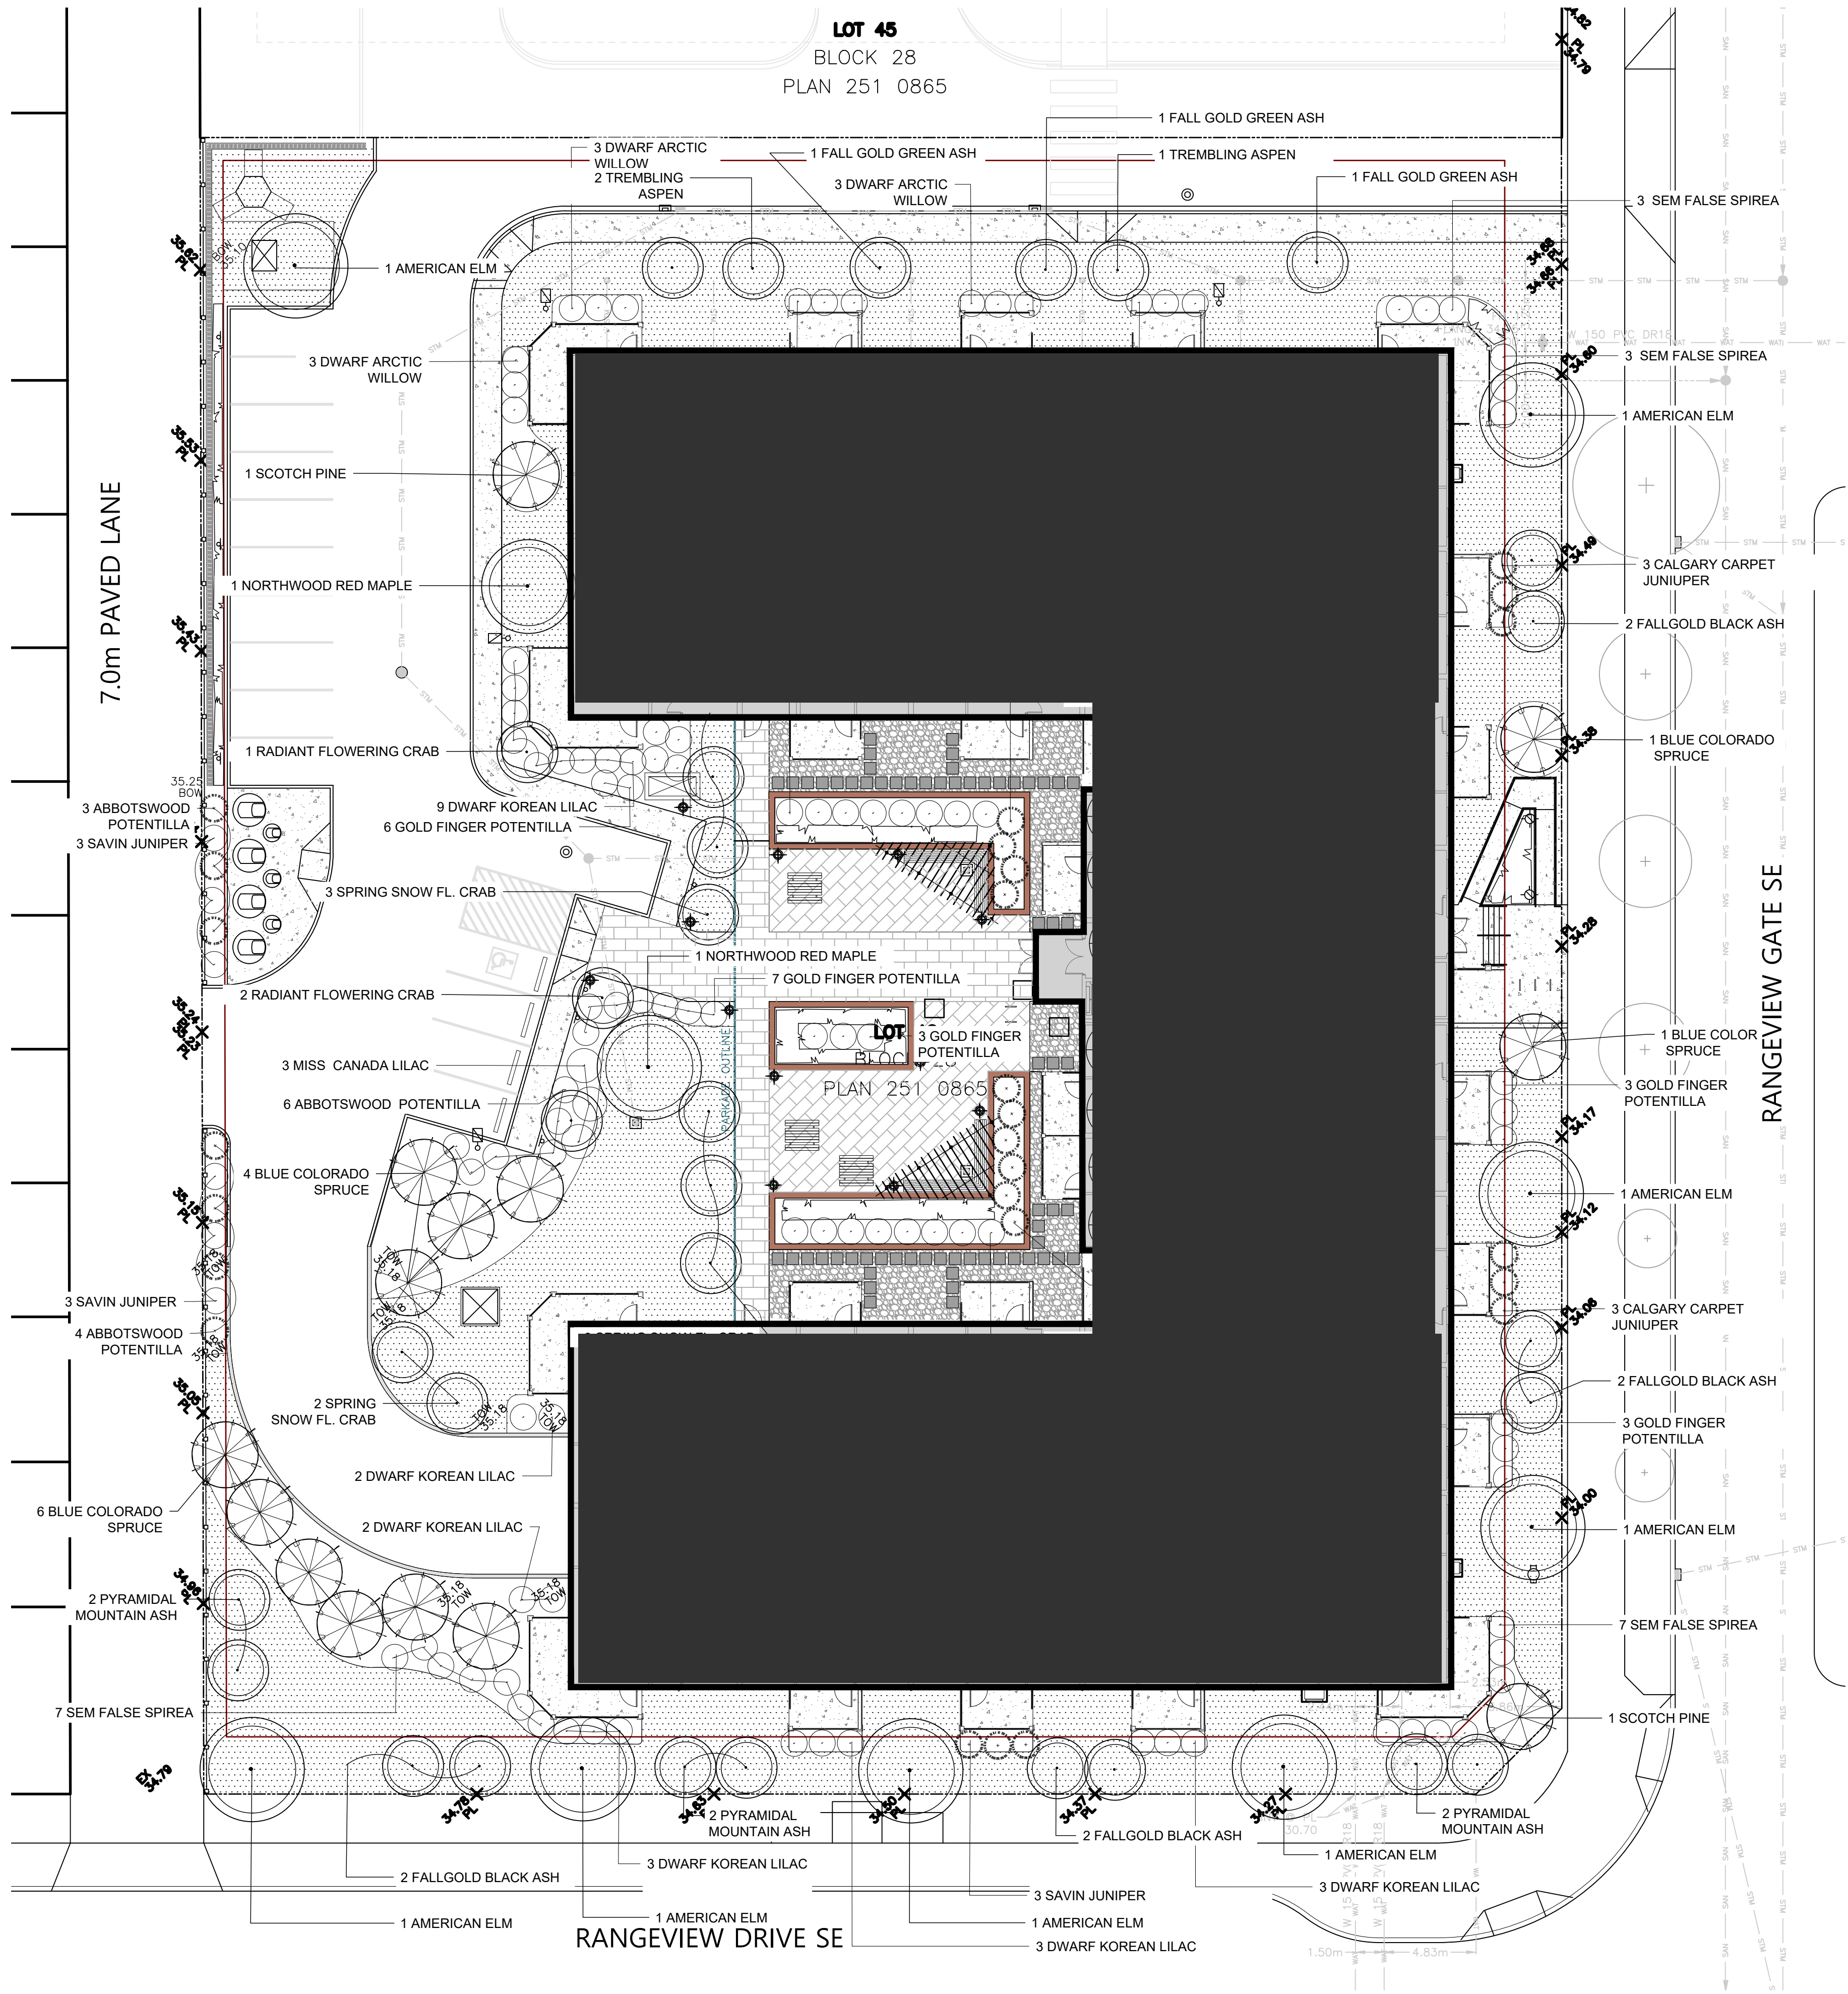

1 PLANTING PLAN
L1.3
SCALE 1:200

DEVELOPMENT
PERMIT
DECISION
RENDERED
ON THIS PLAN

AMENDED DRAWINGS
DP No Date Received
DP2025-05389 JUNE 25, 2026
THESE DRAWINGS REFER TO THE
ABOVE DEVELOPMENT PERMIT NO.

NOTES

- ALL AREAS OF SOFT LANDSCAPING SHALL BE PROVIDED WITH AN UNDERGROUND SPRINKLER IRRIGATION SYSTEM (EXCLUDING THE NATURALIZED SEEDED AREA)
- ALL CONSTRUCTION AND PLANTING DETAILS TO BE IN ACCORDANCE WITH THE CITY OF CALGARY PARKS AND RECREATION, STANDARD SPECIFICATIONS FOR LANDSCAPE CONSTRUCTION, CURRENT EDITION.
- ALL PLANT MATERIALS TO BE HIGH QUALITY / SPECIMEN.
- DRAINAGE FLOWS TO BE DIRECTED AWAY FROM ALL BUILDINGS AT A MINIMUM GRADE OF 2% (SEE ENGINEERING DRAWING FOR GRADING PLAN)
- ALL CONIFEROUS TREES AND SHRUBS SHALL BE PLANTED IN BEDS WITH A MINIMUM 75mm DEPTH OF CLEAN WOOD MULCH (MAXIMUM 100mm)
- LIGHT BOLLARDS & COLUMNS TO BE SURFACE MOUNTED ON CONCRETE PAVING / OR SONO TUBE CONCRETE PILE IN SOFT LANDSCAPE AREAS (SEE ELECTRICAL DWGS)
- ALL SUBSOIL TO BE PRE-SCARIFIED TO A DEPTH OF 100mm OR MORE AT ALL LOCATIONS WHERE TOPSOIL IS TO BE APPLIED.
- SEE ENGINEERING DRAWINGS FOR GRADING INFORMATION.

LEGEND

-----	PROPERTY LINE		IRRIGATED SOD WITH 300mm TOP SOIL
	PROPOSED CONIFEROUS TREE		STONE PATTERNED PATHWAY
	PROPOSED DECIDUOUS TREE		CONCRETE SIDEWALKS AND ENTRANCE PATHWAYS WITH SAW CUT JOINTS, LIGHT SANDBLAST AND/OR BROOM FINISH
	CONIFEROUS SHRUBS (MIN. 600mm SPREAD)		25mm WASHED ROCKS
	DECIDUOUS SHRUBS (MIN. 600mm HT.)		LIGHT FIXTURE SEE SITE LIGHTING PLAN
	PROPOSED PERENNIALS AND GRASSES		LIGHTING BOLLARD SEE LIGHTING PLAN

TREE PLANTING SCHEDULE

QTY.	BOTANICAL NAME	COMMON NAME	SIZE	CONDITION
CONIFEROUS TREES				
10	PICEA PUNGENS	COLORADO SPRUCE	2000mm HT.	B&B
2	PINUS SILVESTRIS	SCOTCH PINE	3000mm HT.	B&B
DECIDUOUS TREES				
2	ACER RUBRUM 'NORTHWOOD'	NORTHWOOD RED MAPLE	50mm CAL.	B&B
9	FRAXINUS NIGRA 'FALL GOLD'	FALL GOLD BLACK ASH	50mm CAL.	B&B
3	MALUS x 'RADIANT'	RADIANT FLOWERING CRABAPPLE	80mm CAL.	B&B
6	MALUS x 'SPRING SNOW'	SPRING SNOW FLOWER CRABAPPLE	80mm CAL.	B&B
3	POPULUS TREMULA 'ERECTA'	TREMBLING ASPEN	50mm CAL.	B&B
6	SORBUS AUCUPARIA	PYRAMIDAL MOUNTAIN ASH	50mm CAL.	B&B
8	ULMUS AMERICANA	AMERICAN ELM	80mm CAL.	B&B

SHRUB PLANTING SCHEDULE

QTY.	BOTANICAL NAME	COMMON NAME	SIZE	CONDITION
CONIFEROUS SHRUBS				
19	JUNIPERUS SABINA	SAVIN JUNIPER	600mm SPR.	#5 CONT.
6	JUNIPERUS SABINA 'CALGARY CARPET'	CALGARY CARPET JUNIPER	600mm SPR.	#5 CONT.
DECIDUOUS SHRUBS				
6	CORNUS SERICEA	RED OSIER DOGWOOD	600mm HT.	#5 CONT.
20	SORBARIA SORBIFOLIA 'SEM'	SEM FALSE SPIREA	600mm HT.	#5 CONT.
21	POTENTILLA FRUTICOSA 'GOLD FINGER'	GOLD FINGER POTENTILLA	600mm HT.	#5 CONT.
21	POTENTILLA FRUTICOSA 'ABBOTSWOOD'	ABBOTSWOOD POTENTILLA	600mm HT.	#5 CONT.
8	POTENTILLA FRUTICOSA 'HACHLISS'	BELLA BELLISSIMA POTENTILLA	600mm HT.	#5 CONT.
22	SYRINGA MEYERI PALIBIN'	DWARF KOREAN LILAC	600mm HT.	#5 CONT.
3	SYRINGA PRESTONIAE 'MISS CANADA'	MISS CANADA LILAC	600mm HT.	#5 CONT.
6	SALIX PURPUREA 'NANA'	DWARF ARCTIC WILLOW	600mm HT.	#5 CONT.
PERENNIALS & GRASSES				
0	CALAMAGROSTIS ACUTIFOLIA	KARL FOERSTER 'FEATHER REED GRASS		15cm CONT.
0	FESTUCA OVINA	BLUE FESCUE		15cm CONT.
0	HELIOTRICHON SEMPERVIRENS	BLUE OAT GRASS		15cm CONT.
0	HEMEROCALLIS	DAY LILY		15cm CONT.
0	MOLINA CAERULEA 'VARIEGATA'	VARIEGATED MOOR GRASS		15cm CONT.
0	PENNISETUM ALOPECUROIDES 'HAMELN'	HAMELN DWARF FOUNTAIN GRASS		15cm CONT.

