

Consultants

- This drawing is the property of the Architect and unauthorized reproduction is prohibited under the Copyright Act.
- Electronic files when provided are instruments of service and the sole property of Sahuri + partners architecture inc. No alteration or reproduction shall be made without written authorization from Sahuri + partners architecture inc.
- The Contractor shall check and verify all dimensions and report any discrepancies to the Architect prior to construction; do not scale this drawing.
- This drawing shall not be used for construction unless properly noted as 'ISSUED FOR CONSTRUCTION' by the Architect.
- All dimensions are in millimeters unless noted otherwise.

ISSUES/REVISIONS

DATE	DESCRIPTION	#
2025-04-17	ISSUED FOR CLIENT REVIEW	1
2025-05-13	ISSUED FOR CLIENT REVIEW	2
2025-06-18	ISSUED FOR DEMOLITION PERMIT	3
2025-08-21	ISSUED FOR BUDGET PRICING	5
2025-12-12	ISSUED FOR DEVELOPMENT PERMIT	6
2026-02-06	ISSUED FOR REVISED DP	7

Seal

Client



Project Title
SKYRIDE RELOCATION
1701 Big Four Trail SE,
Calgary, AB

Drawing Title
COVER PAGE

Drawing info	Project Number
Scale 1 : 1	2025-008
Date 2025-06-18	Drawing Number
Drawn KA	A000
Checked KEVIN PARSONS	
Partner	

SKYRIDE TERMINAL RELOCATION

1701 BIG FOUR TRAIL SE, CALGARY, AB

DEVELOPMENT
PERMIT
DECISION
RENDERED
ON THIS PLAN




ARCHITECTURAL

Unit 145, 550 - 71 Avenue SE
Calgary, Alberta T2H 0S6
Phone: 587.577.5473
Contact: Kevin Parson
e-mail: kevin.parsons@sahuri.com

ARCHITECTURAL SHEET LIST

SHEET LIST	SHEET NAME
A000	COVER PAGE
A100	SITE EASEMENT PLAN
A101	SITE PLAN
A101a	OVERALL SITE PLAN
A201	FLOOR PLAN
A204	MAIN FLOOR PLAN
A301	ELEVATIONS & VIEWS

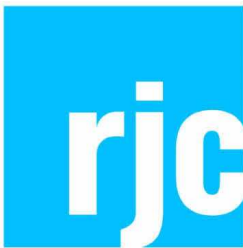

Creative Thinking
Practical Results

STRUCTURAL

1816 Crowchild Trail NW, Suite 200
Calgary, AB T2N 3Y7
Phone: (403) 519-0856
Contact: Chris Davis
e-mail: cdavis@rjc.ca

STRUCTURAL SHEET LIST

SHEET NUMBER	SHEET NAME
S100	GENERAL NOTES AND TYPICAL DETAILS
S101	GENERAL NOTES AND TYPICAL DETAILS
S102	GENERAL NOTES AND TYPICAL DETAILS
S200	MAIN FLOOR PLAN, SECTIONS AND DETAILS



Smith + Andersen

MECHANICAL

1205 - 330 5th Avenue SW,
Calgary, AB, T2P 0L4
Phone: 403 681 9939
Contact: Andrew Caller
e-mail: andrew.caller@smithandandersen.com

MECHANICAL SHEET LIST

SHEET NUMBER	SHEET NAME
M-001	COVER SHEET
M-002	LEGENDS AND DETAILS
M-003	LEVEL 1 - MECHANICAL PLAN





ELECTRICAL

100, 4723 1st Street SW
Calgary, AB, T2C 4Y8
Phone: 403-875-3341
Contact: Eric Chomistek
e-mail: echomistek@designcore.ca

ELECTRICAL SHEET LIST

SHEET NUMBER	SHEET NAME
E1.0	COVER PAGE
E1.1	SITE PLAN
E2.0	ELECTRICAL LAYOUTS
E3.0	DISTRIBUTION CENTRE SCHEMATIC
E3.1	DISTRIBUTION CENTRE DETAILS
E3.2	COMMUNICATION SYSTEM DETAILS
E4.0	ELECTRICAL SPECIFICATION

Consultants

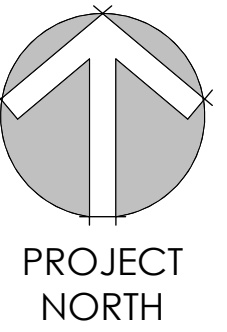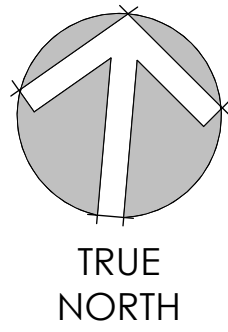

- This drawing is the property of the Architect and unauthorized reproduction is prohibited under the Copyright Act.
- Electronic files when provided are instruments of service and the sole property of Sahuri + partners architecture inc. No alteration or reproduction shall be made without written authorization from Sahuri + partners architecture inc.
- The Contractor shall check and verify all dimensions and report any discrepancies to the Architect prior to construction; do not scale this drawing.
- This drawing shall not be used for construction unless properly noted as 'ISSUED FOR CONSTRUCTION' by the Architect.
- All dimensions are in millimeters unless noted otherwise.

ISSUES/REVISIONS

DATE	DESCRIPTION	#
2025-07-16	ISSUED FOR REVIEW	4
2025-08-21	ISSUED FOR BUDGET PRICING	5
2025-12-12	ISSUED FOR DEVELOPMENT PERMIT	6
2026-02-06	ISSUED FOR REVISED DP	7

Seal

PRELIMINARY
NOT FOR CONSTRUCTION

Client

CS
Calgary Stampede

Project Title
SKYRIDE RELOCATION
1701 Big Four Trail SE,
Calgary, AB

Drawing Title
SITE EASEMENT PLAN


Drawing info	Project Number
Scale 1 : 200	2025-008
Date 2025-06-18	Drawing Number
Drawn KA	A100
Checked KEVIN PARSONS	
Partner	

**DEVELOPMENT
PERMIT
DECISION
RENDERED
ON THIS PLAN**



1 SITE PLAN - EASEMENT
1 : 200

Consultants

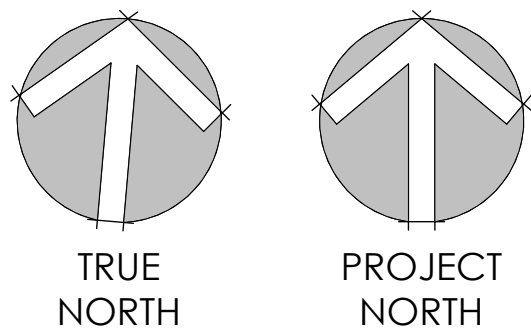

- This drawing is the property of the Architect and unauthorized reproduction is prohibited under the Copyright Act.
- Electronic files when provided are instruments of service and the sole property of Sahuri + partners architecture inc. No alteration or reproduction shall be made without written authorization from Sahuri + partners architecture inc.
- The Contractor shall check and verify all dimensions and report any discrepancies to the Architect prior to construction; do not scale this drawing.
- This drawing shall not be used for construction unless properly noted as 'ISSUED FOR CONSTRUCTION' by the Architect.
- All dimensions are in millimeters unless noted otherwise.

ISSUES/REVISIONS

DATE	DESCRIPTION	#
2025-07-16	ISSUED FOR REVIEW	4
2025-08-21	ISSUED FOR BUDGET PRICING	5
2025-12-12	ISSUED FOR DEVELOPMENT PERMIT	6
2025-02-05	ISSUED FOR REVISED DP	7

Seal


Client



Project Title
SKYRIDE RELOCATION
1701 Big Four Trail SE,
Calgary, AB

Drawing Title
SITE PLAN

Drawing info	Project Number
Scale	As indicated
Date	2025-06-18
Drawn	KA
Checked	KEVIN PARSONS
Partner	
	Drawing Number
	A101

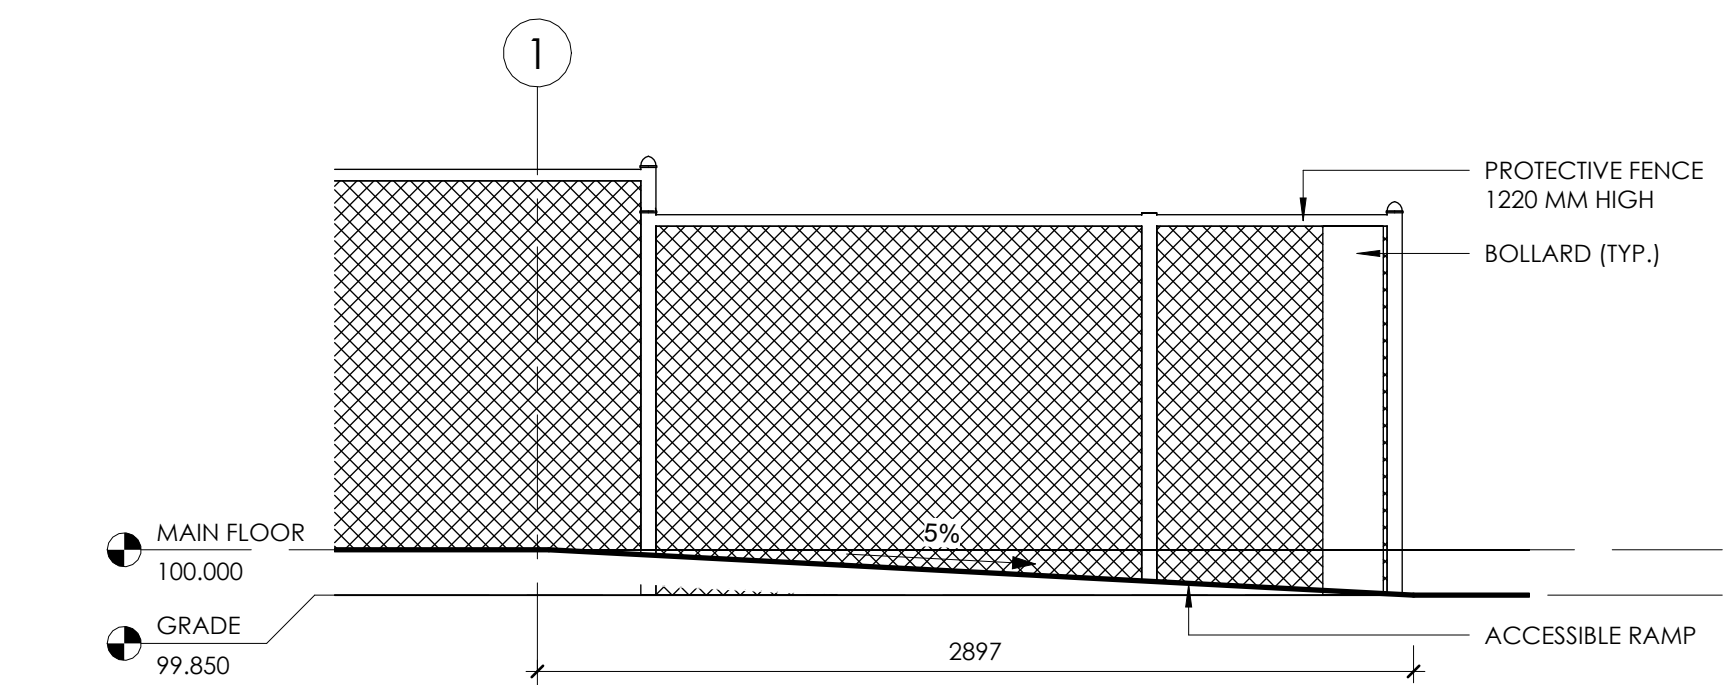

3 RAMP DETAIL
1 : 25




1 SITE PLAN - EXISTING
1 : 200


The proposed width of the Skyride walkway is 1525mm (5'-0")

The proposed width of the Skyride walkway is 1525mm (5'-0")

DEVELOPMENT
PERMIT
DECISION
RENDERED
ON THIS PLAN

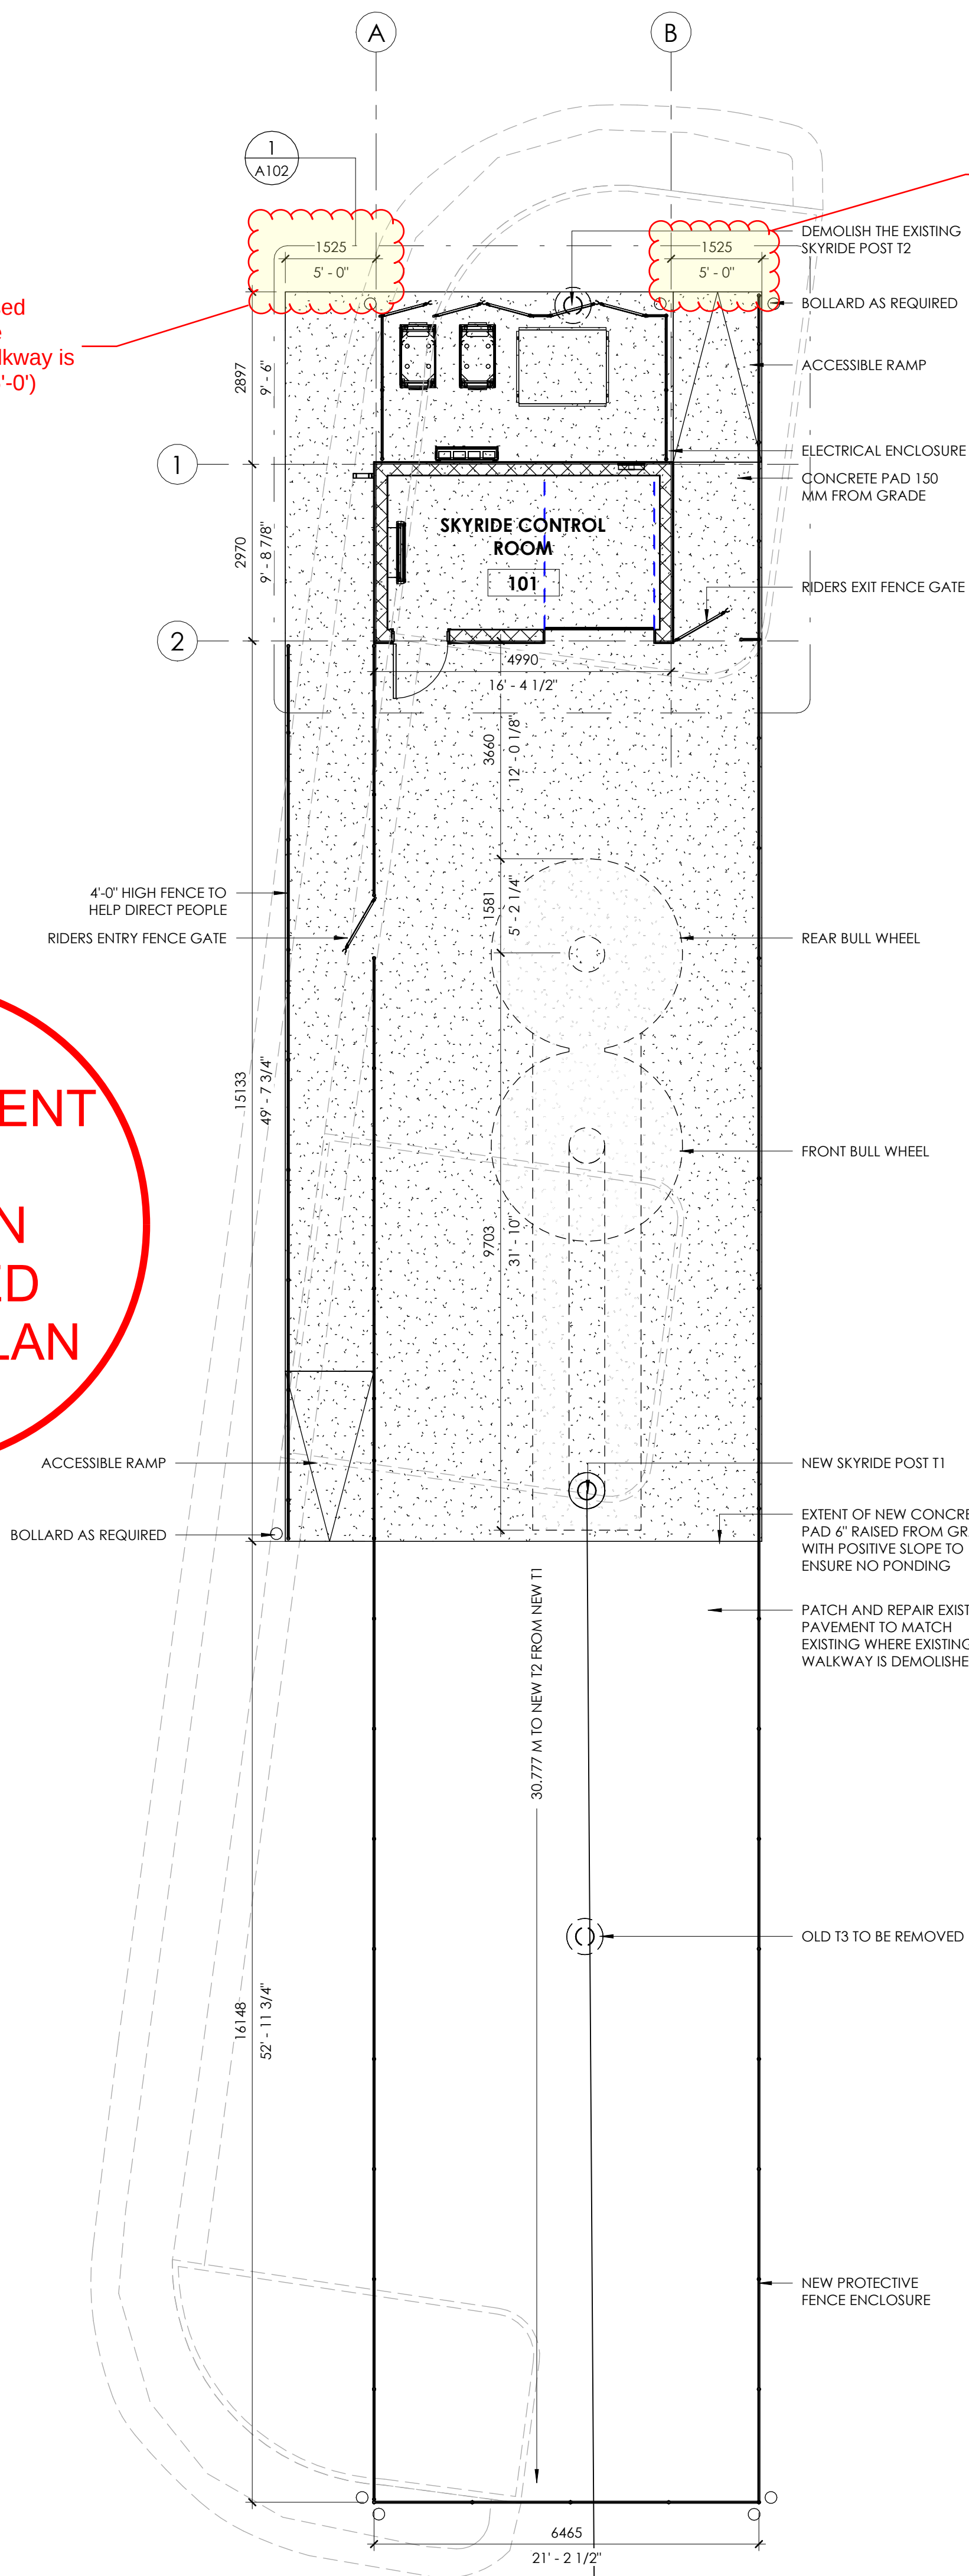

2 SITE PLAN - PROPOSED
1 : 75

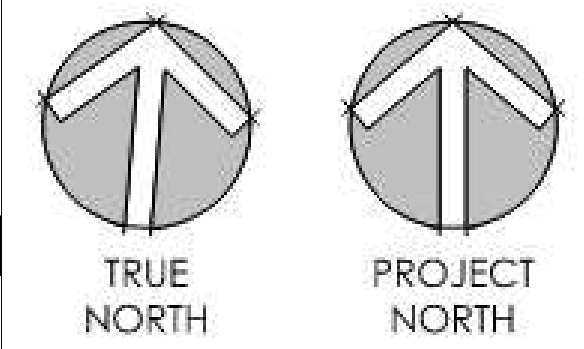

HALL A1

HALL C

HALL B

HALL A2

DEVELOPMENT
PERMIT
DECISION
RENDERED
ON THIS PLAN

- This drawing is the property of the Architect and unauthorized reproduction is prohibited under the Copyright Act.
- Electronic files when provided are instruments of service and the sole property of Sahuri + partners architecture inc. No alteration or reproduction shall be made without written authorization from Sahuri + partners architecture inc.
- The Contractor shall check and verify all dimensions and report any discrepancies to the Architect prior to construction; do not scale this drawing.
- This drawing shall not be used for construction unless properly noted as 'ISSUED FOR CONSTRUCTION' by the Architect.
- All dimensions are in millimeters unless noted otherwise.

ISSUES/REVISIONS

DATE	DESCRIPTION	#
2026-02-06	ISSUED FOR DP REV'S	

Seal

Client



drawing title
Site Plan


drawing info
drawn ####
date 2026-02-04
scale ####
checked ####

project number
#####

drawing number
A101a

LEGEND

- ITEMS TO BE REMOVED
- NEW SKYRIDE LAYOUT
- SHARED ACCESS AGREEMENT
- PROPOSED HOTEL PROPERTY LINE

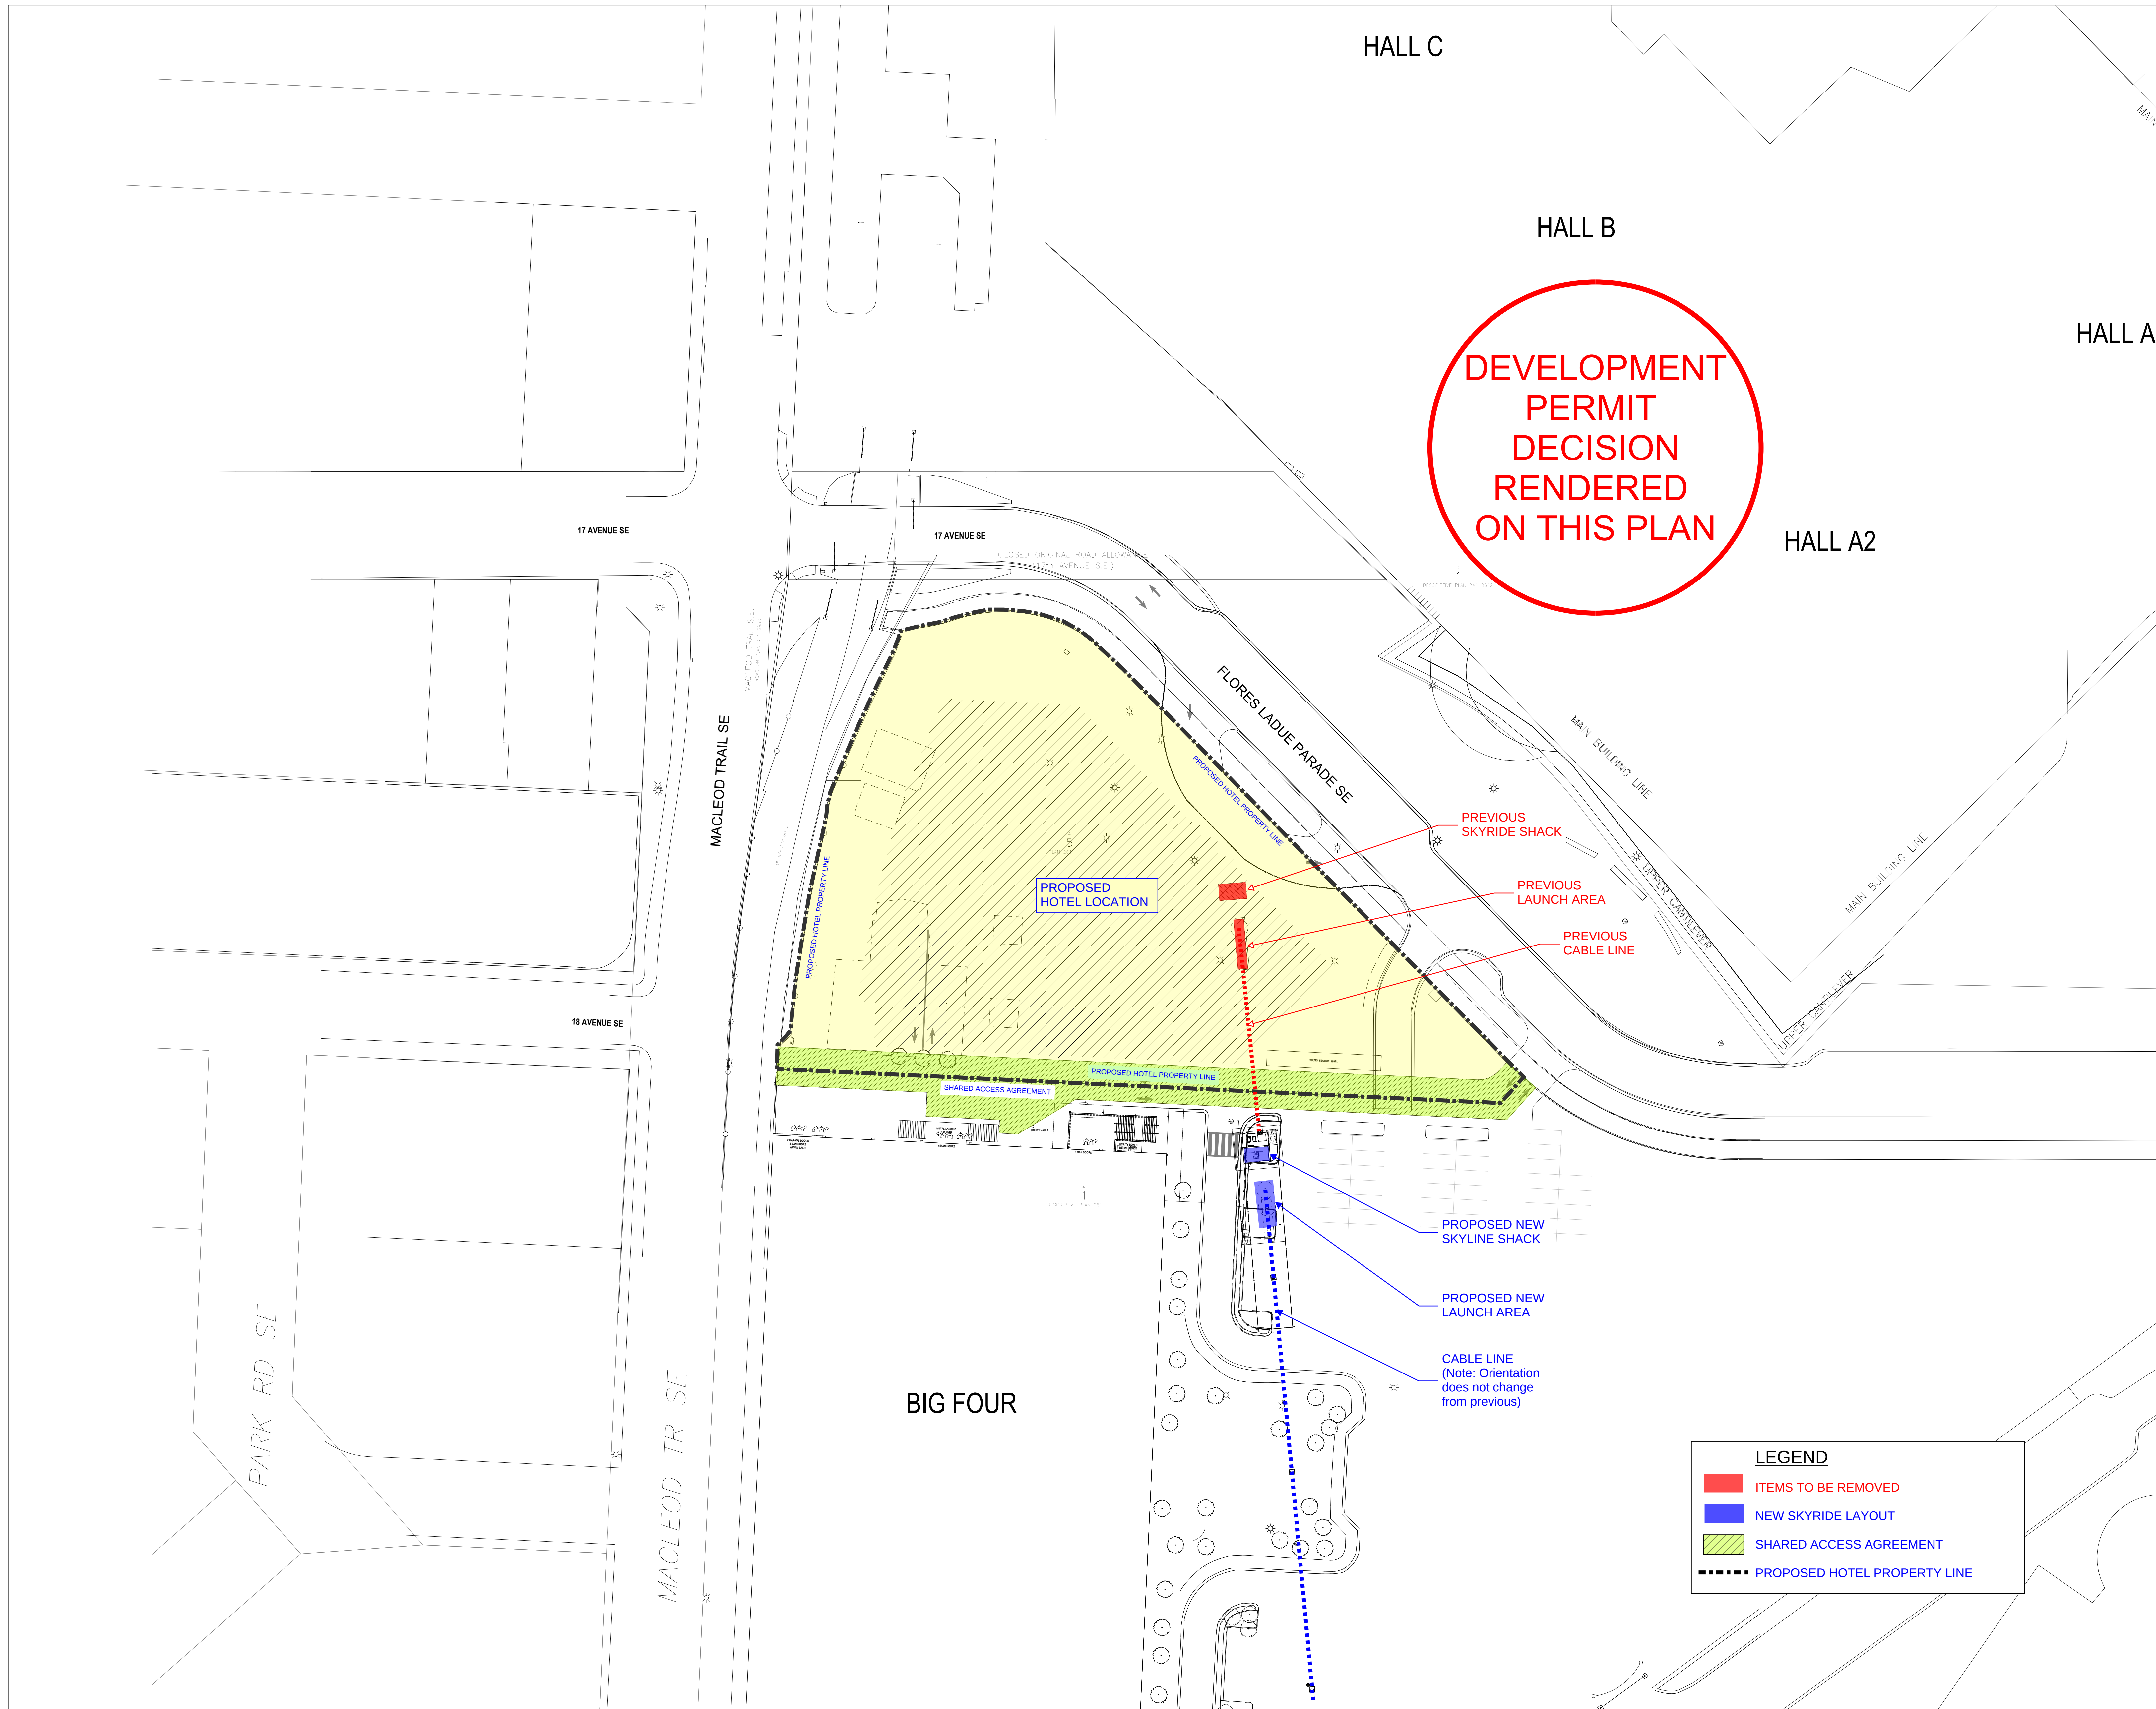

Consultants

- This drawing is the property of the Architect and unauthorized reproduction is prohibited under the Copyright Act.
- Electronic files when provided are instruments of service and the sole property of Sahuri + partners architecture inc. No alteration or reproduction shall be made without written authorization from Sahuri + partners architecture inc.
- The Contractor shall check and verify all dimensions and report any discrepancies to the Architect prior to construction; do not scale this drawing.
- This drawing shall not be used for construction unless properly noted as 'ISSUED FOR CONSTRUCTION' by the Architect.
- All dimensions are in millimeters unless noted otherwise.

ISSUES/REVISIONS

DATE	DESCRIPTION	#
2025-07-16	ISSUED FOR REVIEW	4
2025-08-21	ISSUED FOR BUDGET PRICING	5
2025-12-12	ISSUED FOR DEVELOPMENT PERMIT	6
2026-02-06	ISSUED FOR REVISED DP	7

Seal







Client



Project Title
SKYRIDE RELOCATION
1701 Big Four Trail SE,
Calgary, AB

Drawing Title
ELEVATIONS & VIEWS

Drawing info	Project Number
Scale 1 : 50	2025-008
Date 2025-06-18	Drawing Number
Drawn KA	A301
Checked KEVIN PARSONS	
Partner	

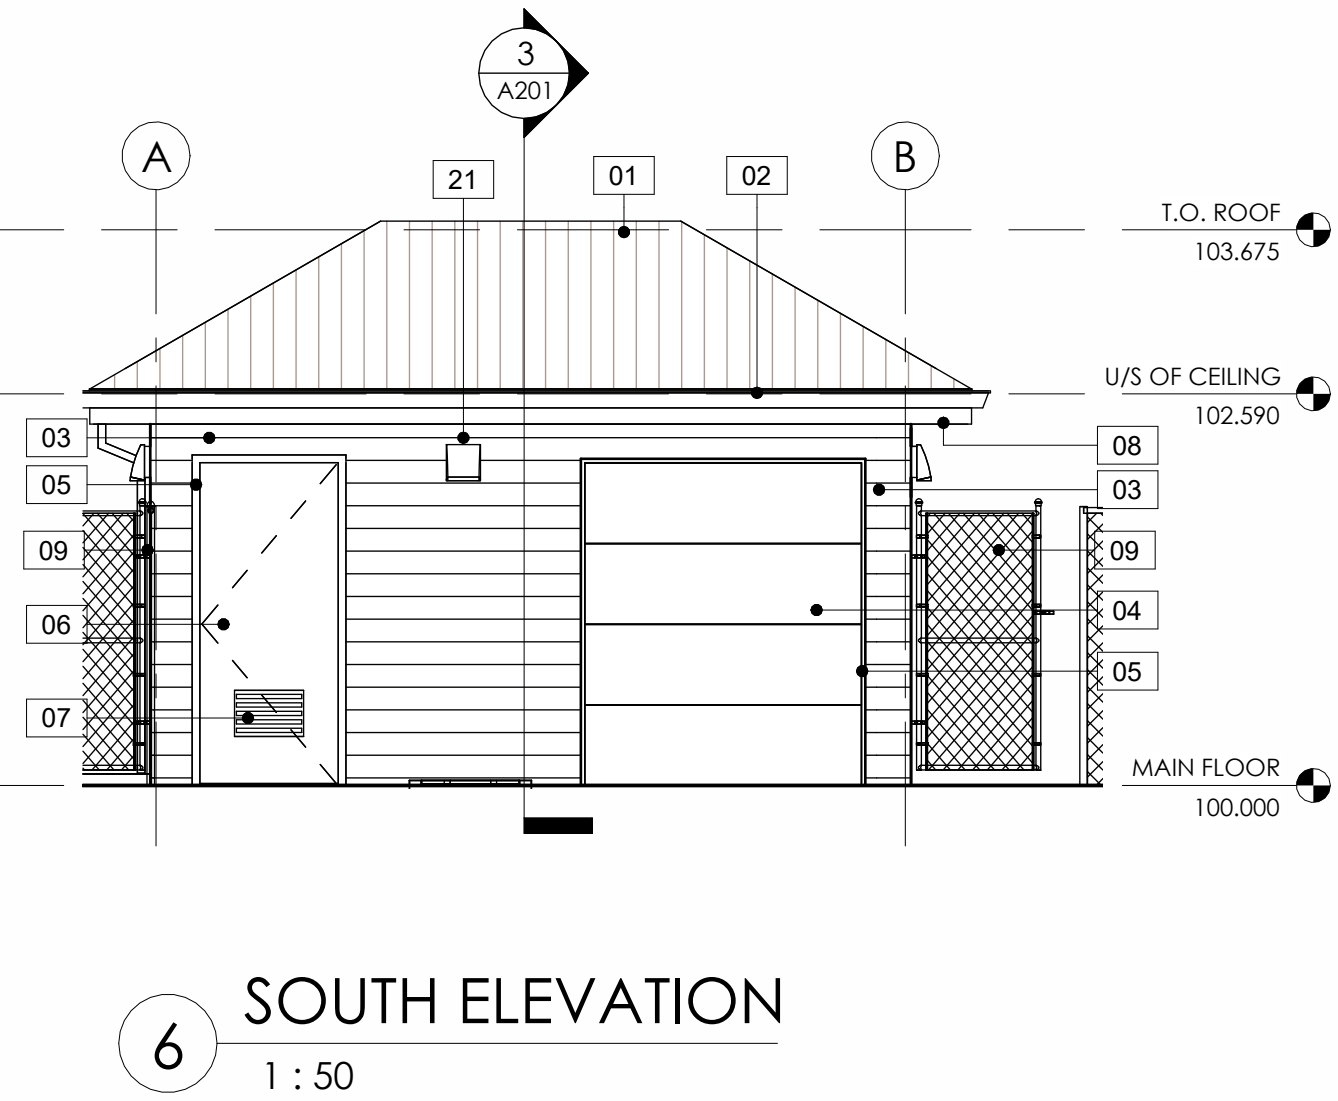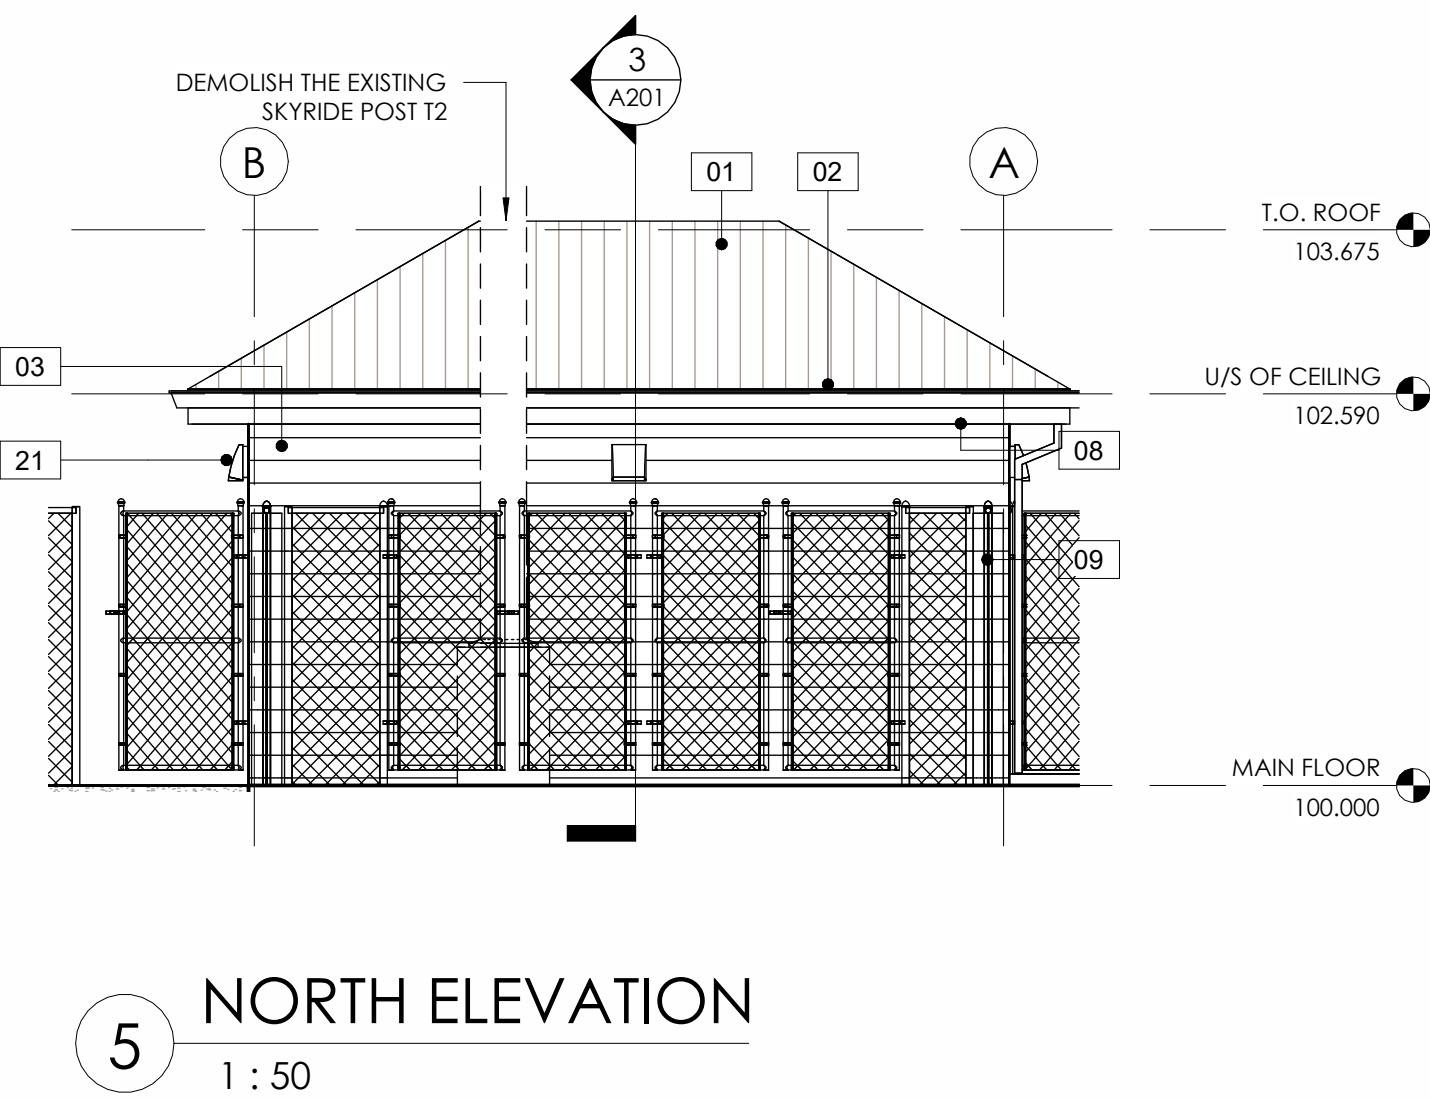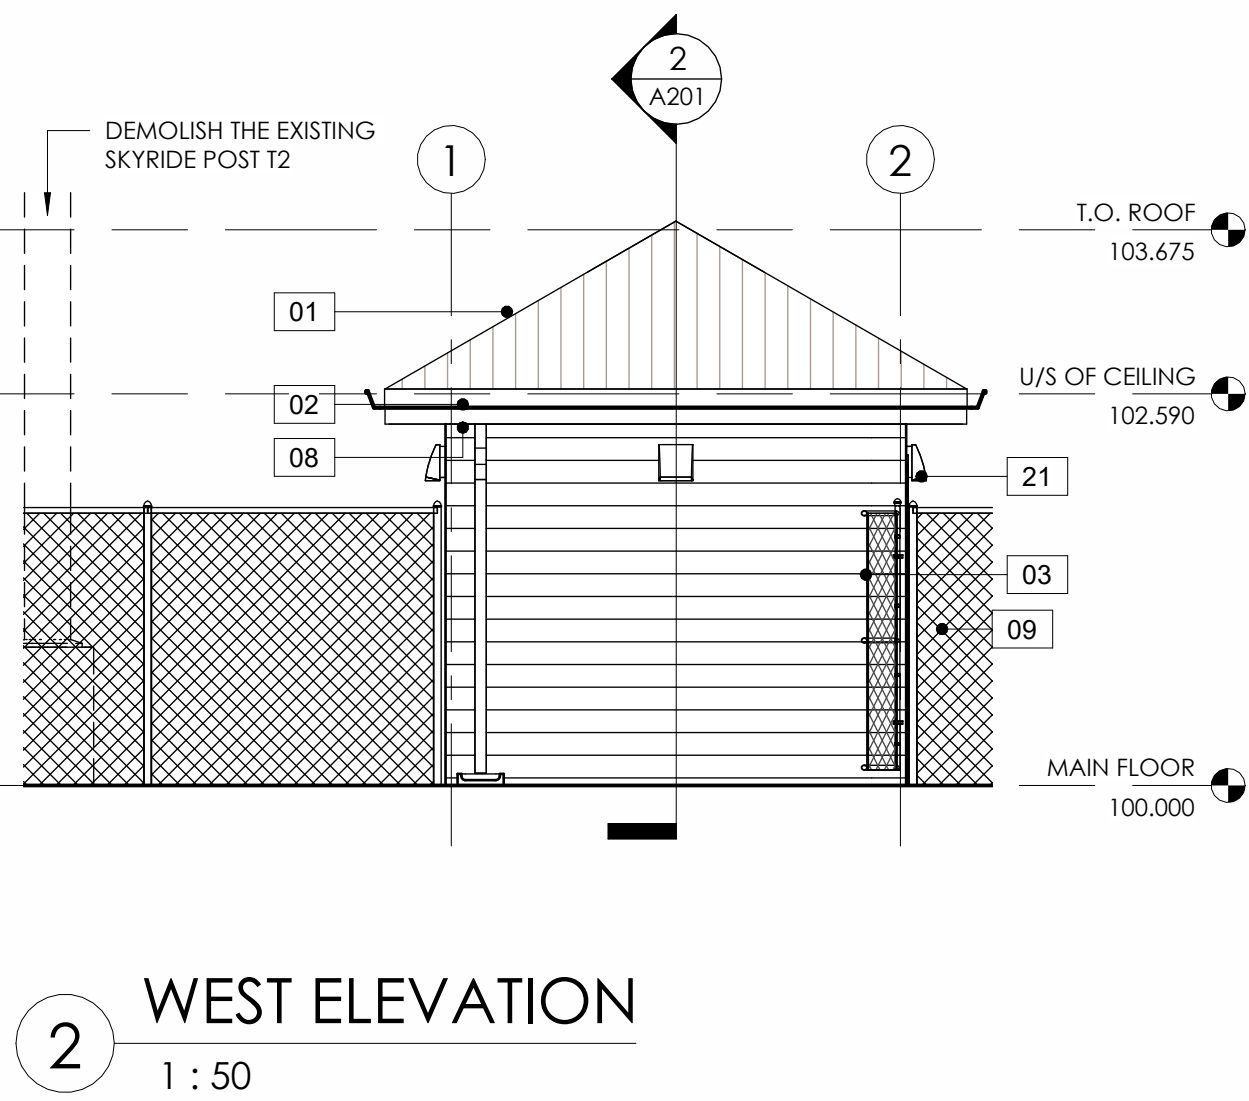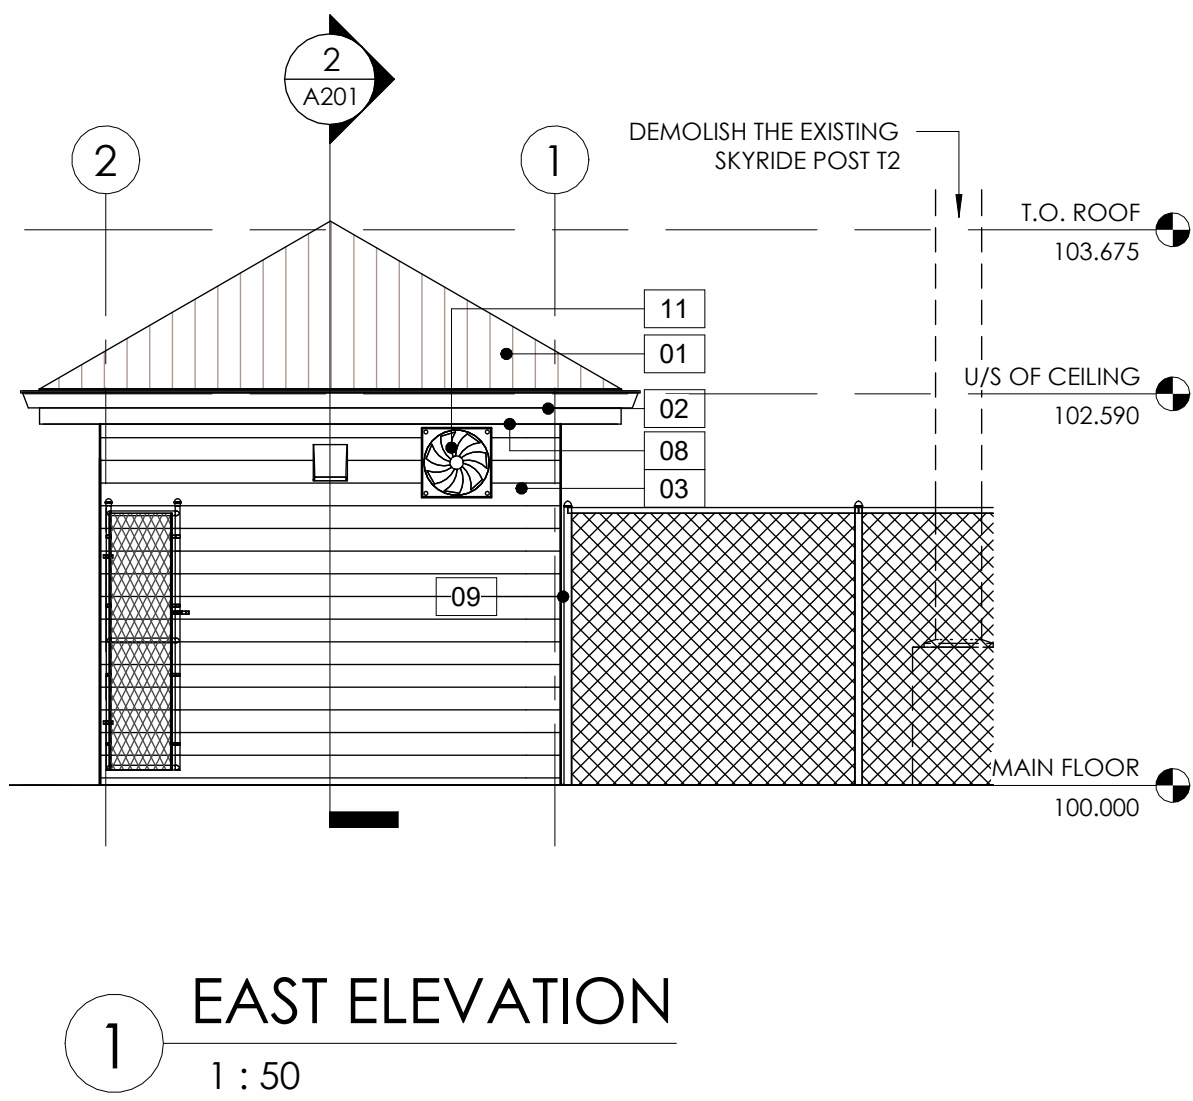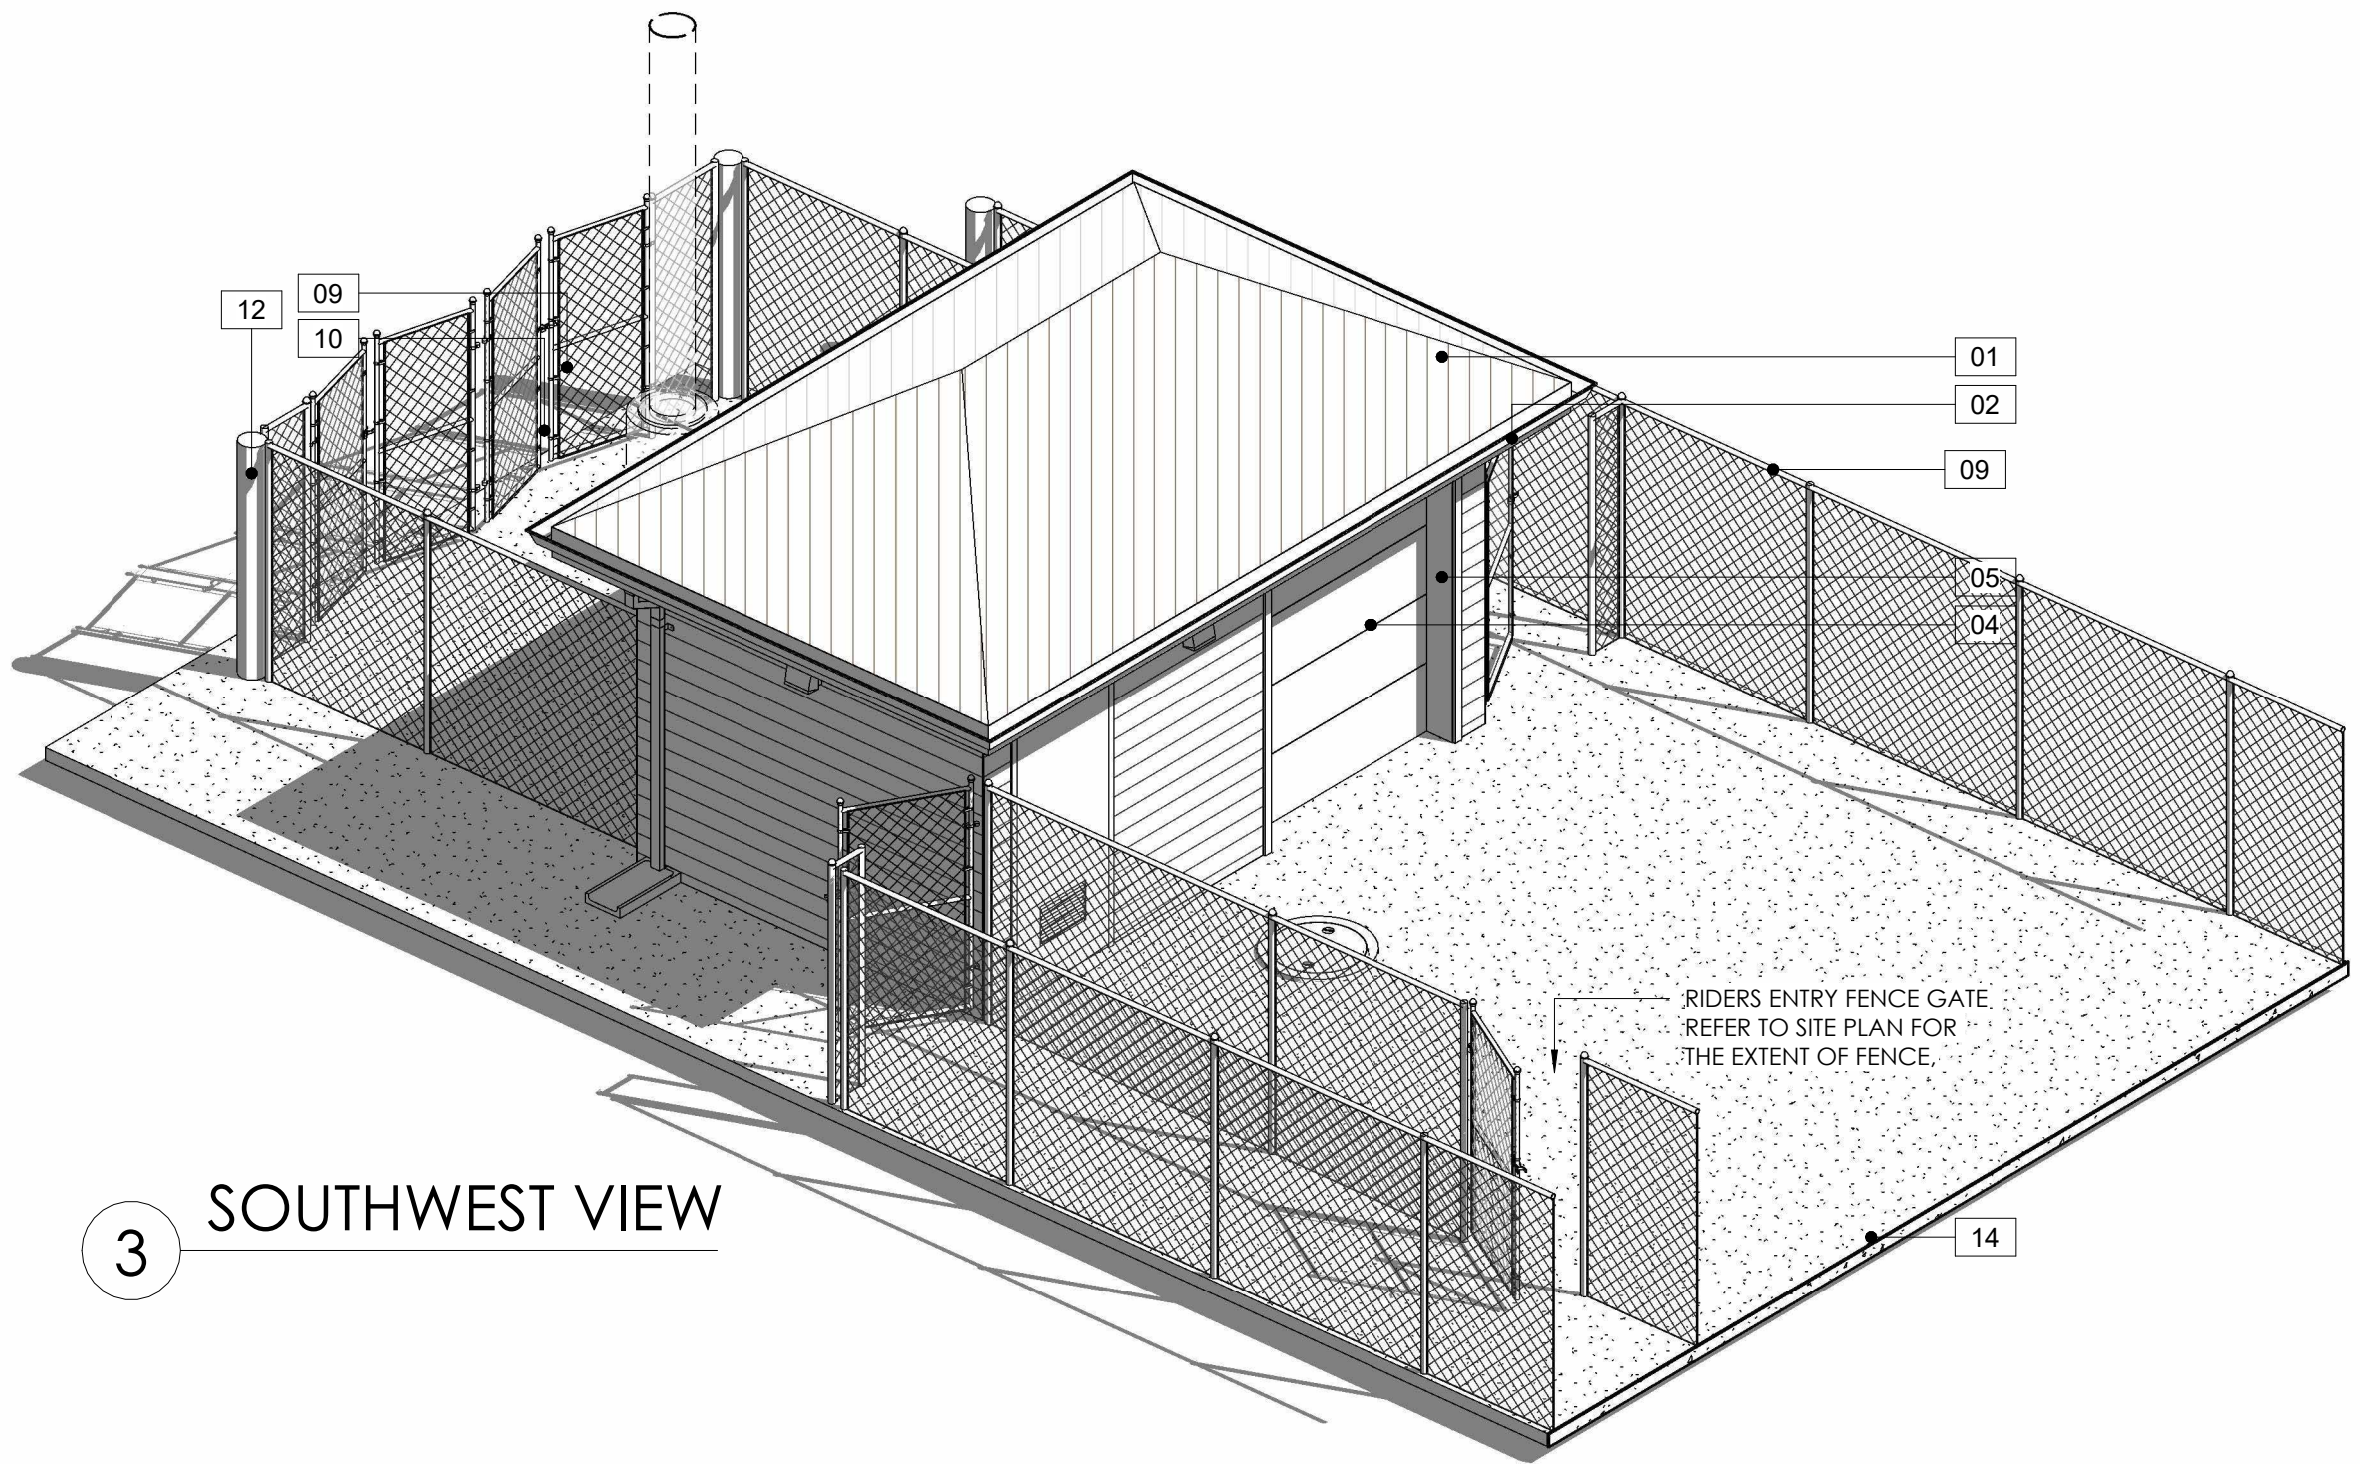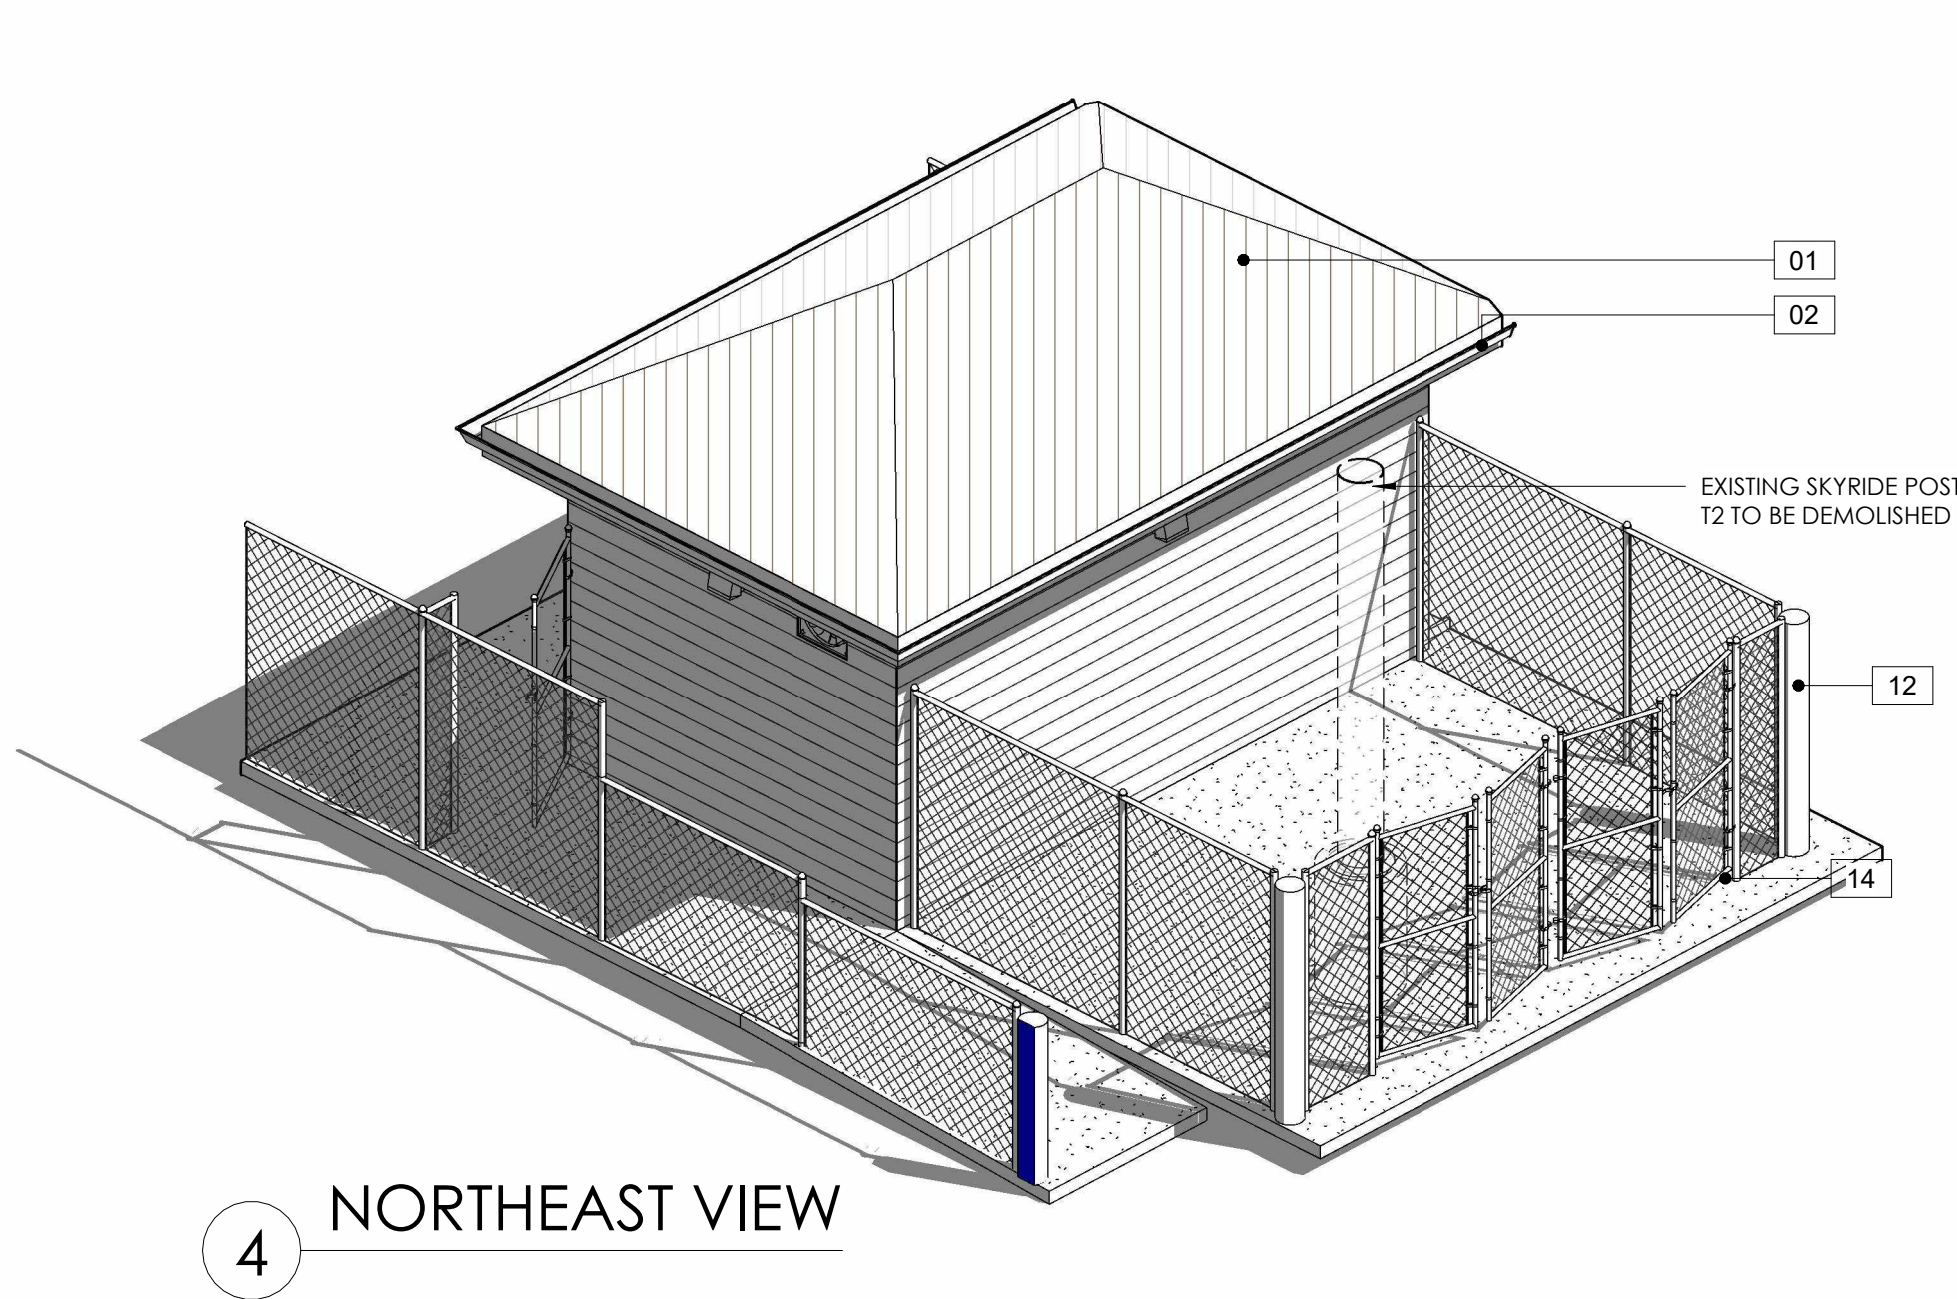

DEVELOPMENT
PERMIT
DECISION
RENDERED
ON THIS PLAN

EXTERIOR ELEVATION LEGEND	
KEYNOTE	KEYNOTE TEXT
01	PRE-FINISHED METAL ROOF ON WOODEN TRUSSES - COLOR TBD.
02	PRE-FINISHED METAL FASCIA, WITH GUTTERS AND DOWN SPOUTS AS NEEDED - COLOR TBD.
03	HARDIE BOARD SIDING - COLOR TBD.
04	PRE-FINISHED OVERHEAD DOOR.
05	METAL DOOR FRAME - COLOR TBD.
06	EXTERIOR METAL DOOR - COLOR TBD.
07	PASSIVE/ NON-POWERED AIR VENT - COLOR TBD.
08	PRE-FINISHED PERFORATED/ VENTED METAL SOFFIT.
09	6'-6" HIGH CHAIN LINK FENCE WITH GATE/S.
10	ELECTRICAL CABINETS/ TRANSFORMER. SEE ELECTRICAL DRAWINGS.
11	EXHAUST FAN/ VENT.
12	CONCRETE FILLED 150MM DIA STEEL BOLLARD - HEIGHT TO MATCH ADJACENT FENCE, COORDINATE WITH STRUCTURAL DRAWINGS.
14	CONCRETE PAD. REFER TO STRUCTURAL.
21	NEW EXTERIOR LIGHT FIXTURE, COORDINATE WITH ELECTRICAL DRAWINGS.