


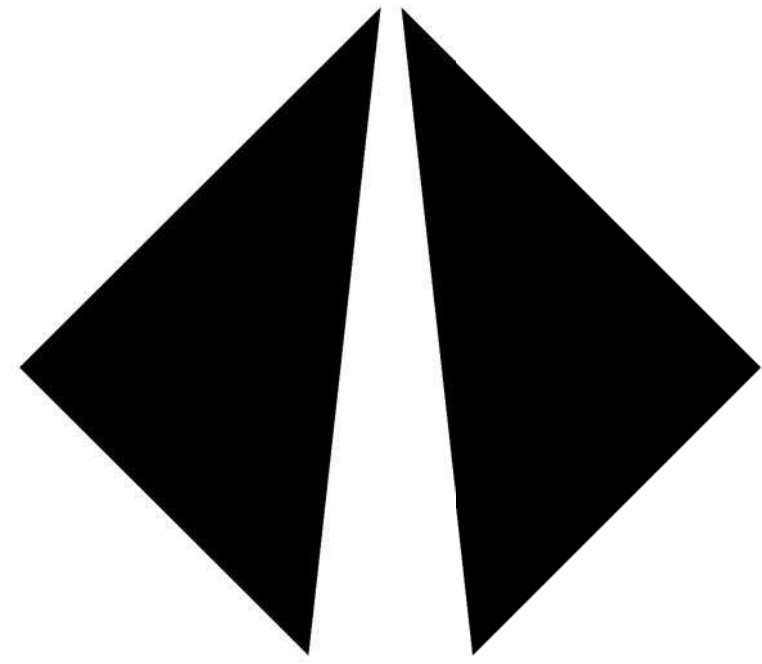

INTERNATIONAL Bosch Truck Group Inc.



PROPOSED SITE LOCATION

PANOTINI PARK
7270 96 AVENUE SE, CALGARY
PROPOSED LOT: 4 BLOCK: 7 PLAN: 241 0408

ZONED : I-G
15.02 ACRES / 6.08 HECTARES

BUILDING DETAILS

BUILDING CLASSIFICATION
NATIONAL BUILDING CODE - 2023 ALBERTA EDITION -
3.2.2.76. GROUP F, DIVISION 2, ANY HEIGHT, ANY AREA, SPRINKLERED

BUILDING FOOT PRINT = 93,842.29 ft² / 8,718.23 m²
GROSS FLOOR AREA = 108,315.42 ft² / 10,062.83 m²

PAGE	TITLE
A1	EXISTING SITE PLAN
A1.1	PROPOSED BUILDING LOCATION ON SITE
A1.2	PROPOSED GRADING / LIGHTING PLAN
A1.3	PROPOSED LANDSCAPING / PARKING
A2	MAIN FLOOR PLAN FULL
A2.1	MAIN FLOOR PLAN FRONT
A2.2	MAIN FLOOR PLAN BACK
A2.3	2ND FLOOR / MEZZ
A3	ELEVATIONS FULL
A3.1	ELEVATION DETAILS NORTH
A3.2	ELEVATION DETAILS SOUTH
A3.3	ELEVATION DETAILS EAST / WEST
A3.4	FLOOR AREAS BY TYPE

DO NOT SCALE THIS DRAWING THESE DRAWINGS ARE THE SOLE PROPERTY OF BOYCHUK DESIGN BUILD ANY REPRODUCTION OR USE OF THESE DRAWINGS REQUIRES THE WRITTEN CONSENT OF BOYCHUK DESIGN BUILD	REV #	Date:	Revision Description:	 TEL: 403-236-1840 office@boychukdb.com	DESIGN: DB DRAWN: JP CHECKED: DB DATE: 12/26/25 SCALE: As Indicated	DESTROY ALL COPIES OF THIS DRAWING PRIOR TO THIS DATE: 12/26/25	
	1	10/01/20	ISSUED FOR CONSTRUCTION			PROJECT NAME: BOSCH TRUCK GROUP INC. LOCATION: CALGARY, ALBERTA PROJECT TYPE: COMMERCIAL DEALERSHIP TITLE: COVER PAGE	SHEET: A0



BOYCHUK DESIGN BUILD



① SITE EXISTING
1 : 700

DESIGN: DB	PROJECT NAME: BOSCH TRUCK GROUP INC.		SHEET: A1
DRAWN: JP	LOCATION: CALGARY, ALBERTA		
CHECKED: DB	PROJECT TYPE: COMMERCIAL DEALERSHIP		
DATE: 12/26/25	TITLE: EXISTING SITE		
SCALE: 1/200			

DESTROY ALL COPIES OF THIS DRAWING
PRIOR TO THIS DATE: **12/26/25**


PROJECT NAME: **BOSCH TRUCK GROUP INC.**

LOCATION:
CALGARY, ALBERTA

PROJECT TYPE:
COMMERCIAL DEALERSHIP

TITLE: EXISTING SITE

SHEET
A1

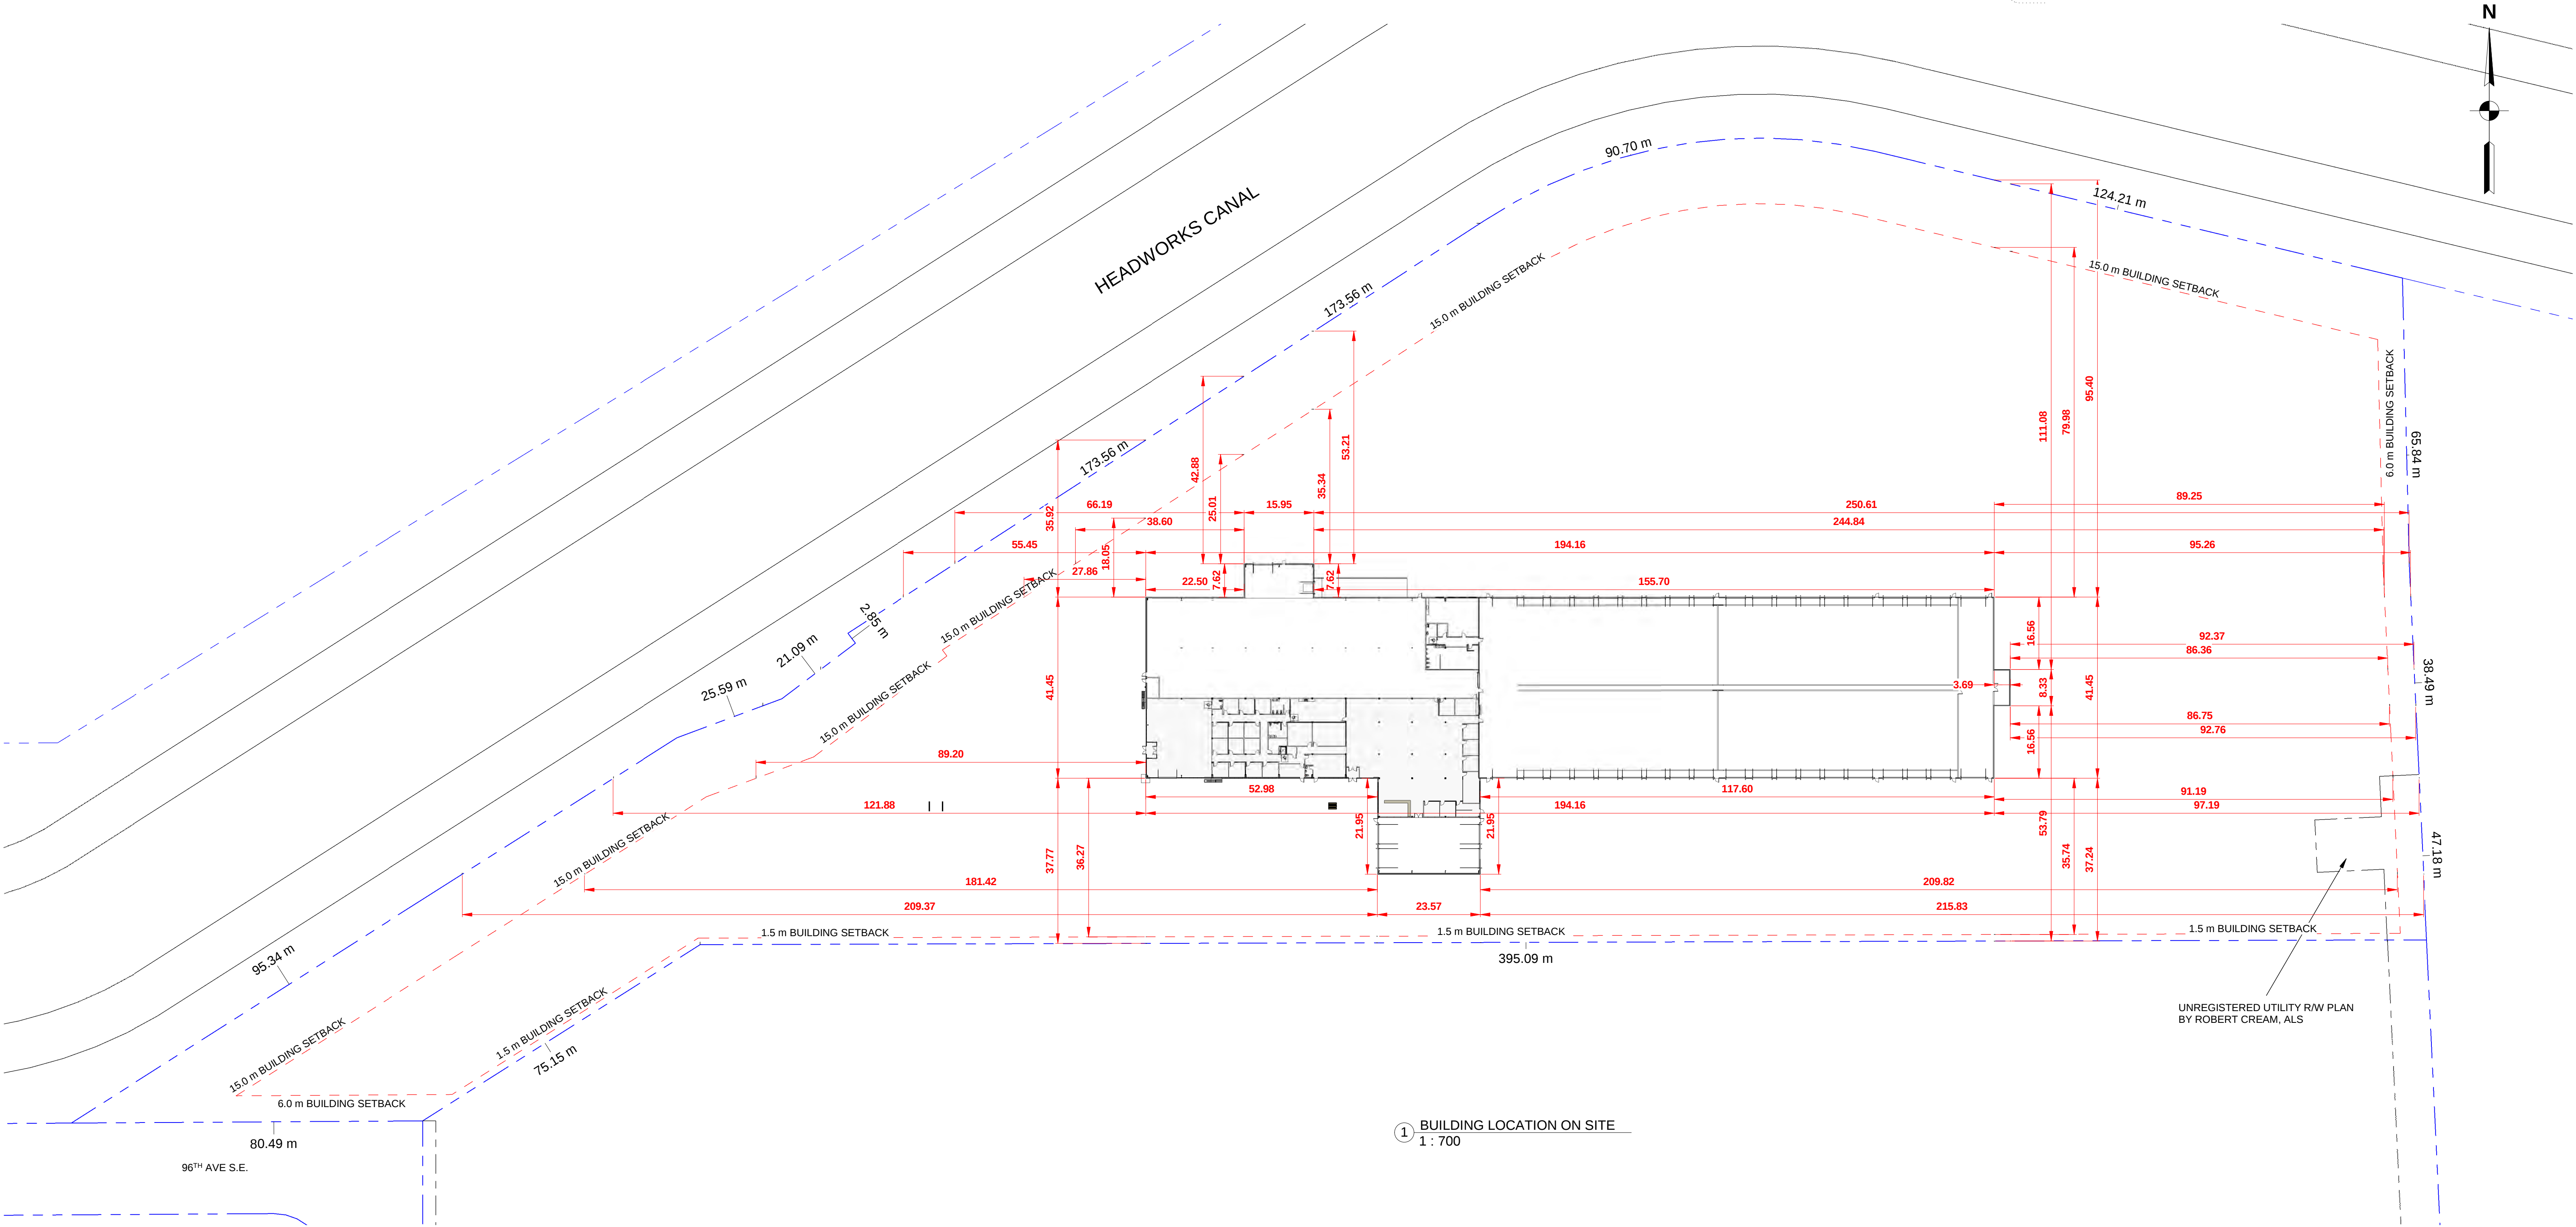

① BUILDING LOCATION ON SITE
1 : 700


DO NOT SCALE THIS DRAWING
THESE DRAWINGS ARE THE
SOLE PROPERTY OF BOYCHUK
DESIGN BUILD
ANY REPRODUCTION OR USE
OF THESE DRAWINGS
REQUIRES THE WRITTEN
CONSENT OF BOYCHUK
DESIGN BUILD

REV #	Date	Revision Description



DESIGN: D8
DRAWN: JP
CHECKED: D8
DATE: 12/26/25
SCALE: 1 : 700

DESTROY ALL COPIES OF THIS DRAWING PRIOR TO THIS DATE: 12/26/25	
PROJECT NAME: BOSCH TRUCK GROUP INC.	
LOCATION: CALGARY, ALBERTA	SHEET: A1.1
PROJECT TYPE: COMMERCIAL DEALERSHIP	
TITLE: BUILDING LOCATION ON SITE	

 

LANDSCAPING CALCULATIONS

REQUIRED LANDSCAPING IN SETBACK AREA = 10,465.82 m²
1 TREE AND 2 SHRUBS PER 35 m²
TREES = 10,465.82 m² / 35 m² = 299.02
SHRUBS = (10,465.82 m² / 35 m²) X 2 = 598.05

REQUIRED TREES = 299

MINIMUM 25% CONIFEROUS
299 X 0.25 = 74.75 = MINIMUM 75 CONIFEROUS TREES

DECIDUOUS TREES MINIMUM CALLIPER = 50 mm
CONIFEROUS TREES MINIMUM HEIGHT = 2.0 m

REQUIRED SHRUBS = 598

SHRUB MINIMUM HEIGHT OR SPREAD = 0.6 m

PROPOSED LANDSCAPING

WEST LANDSCAPED AREA (TO END OF ASPHALT PAVING) = 4,306.79 m²

TREES = 4,306.79 m² / 35 m² = 123.05 = 123 TREES
MINIMUM 25% CONIFEROUS
123 X 0.25 = 30.75 = MINIMUM 31 CONIFEROUS TREES

PROPOSED CONIFEROUS TREES = 50
PROPOSED DECIDUOUS TREES = 73

SHRUBS = (4,306.79 m² / 35 m²) X 2 = 246.1 = 246 SHRUBS

AREA TO BE SOFT LANDSCAPED WITH DROUGHT RESISTANT GRASS AND DECORATIVE LANDSCAPE ROCK
AREA TO BE IRRIGATED WITH UNDERGROUND SYSTEM.

EAST LANDSCAPED AREA = 5,651.48 m²

NO TREES OR SHRUBS PROPOSED
AREA TO BE SOFT LANDSCAPED WITH HYDRO SEEDING.
AREA TO BE NATURALLY IRRIGATED.

LANDSCAPE LEGEND

- EXTERIOR CONCRETE, BROOM FINISH
ON SITE = 1,421.30 m²
ON BOULEVARD = 112.78 m²
- ASPHALT PAVEMENT = 7,045.54 m²
- LANDSCAPE ROCK, GRAY = 890.16 m²
- GRASS, UNDERGROUND IRRIGATED
DROUGHT RESISTANT
ON PROPERTY = 4,371.52 m²
BOULEVARD = 245.48 m²
- HYDRO SEEDED AREA, NATURALLY IRRIGATED
= 5741.28 m²
- GRAVEL YARD = 32,467.39 m²


BARRIER FREE PARKING STALL CALCULATION

TOTAL OFFICE AREA = 2,492.72 m²
4 PARKING STALLS PER 100 m² =
(2,492.72 / 100) X 4 = 99.71 STALLS REQUIRED

TOTAL WAREHOUSE & SHOP AREA = 7,492.50 m²
1 PARKING STALL PER 100 m² =
(7,492.50 / 100) X 1 = 74.93 STALLS REQUIRED

TOTAL REQUIRED STALLS = 99.71 + 74.93 = 174.64 = 175 STALLS

N.B.C. - 2023 ALBERTA EDITION TABLE 3.8.2.5 = 5 BARRIER FREE STALLS REQUIRED.

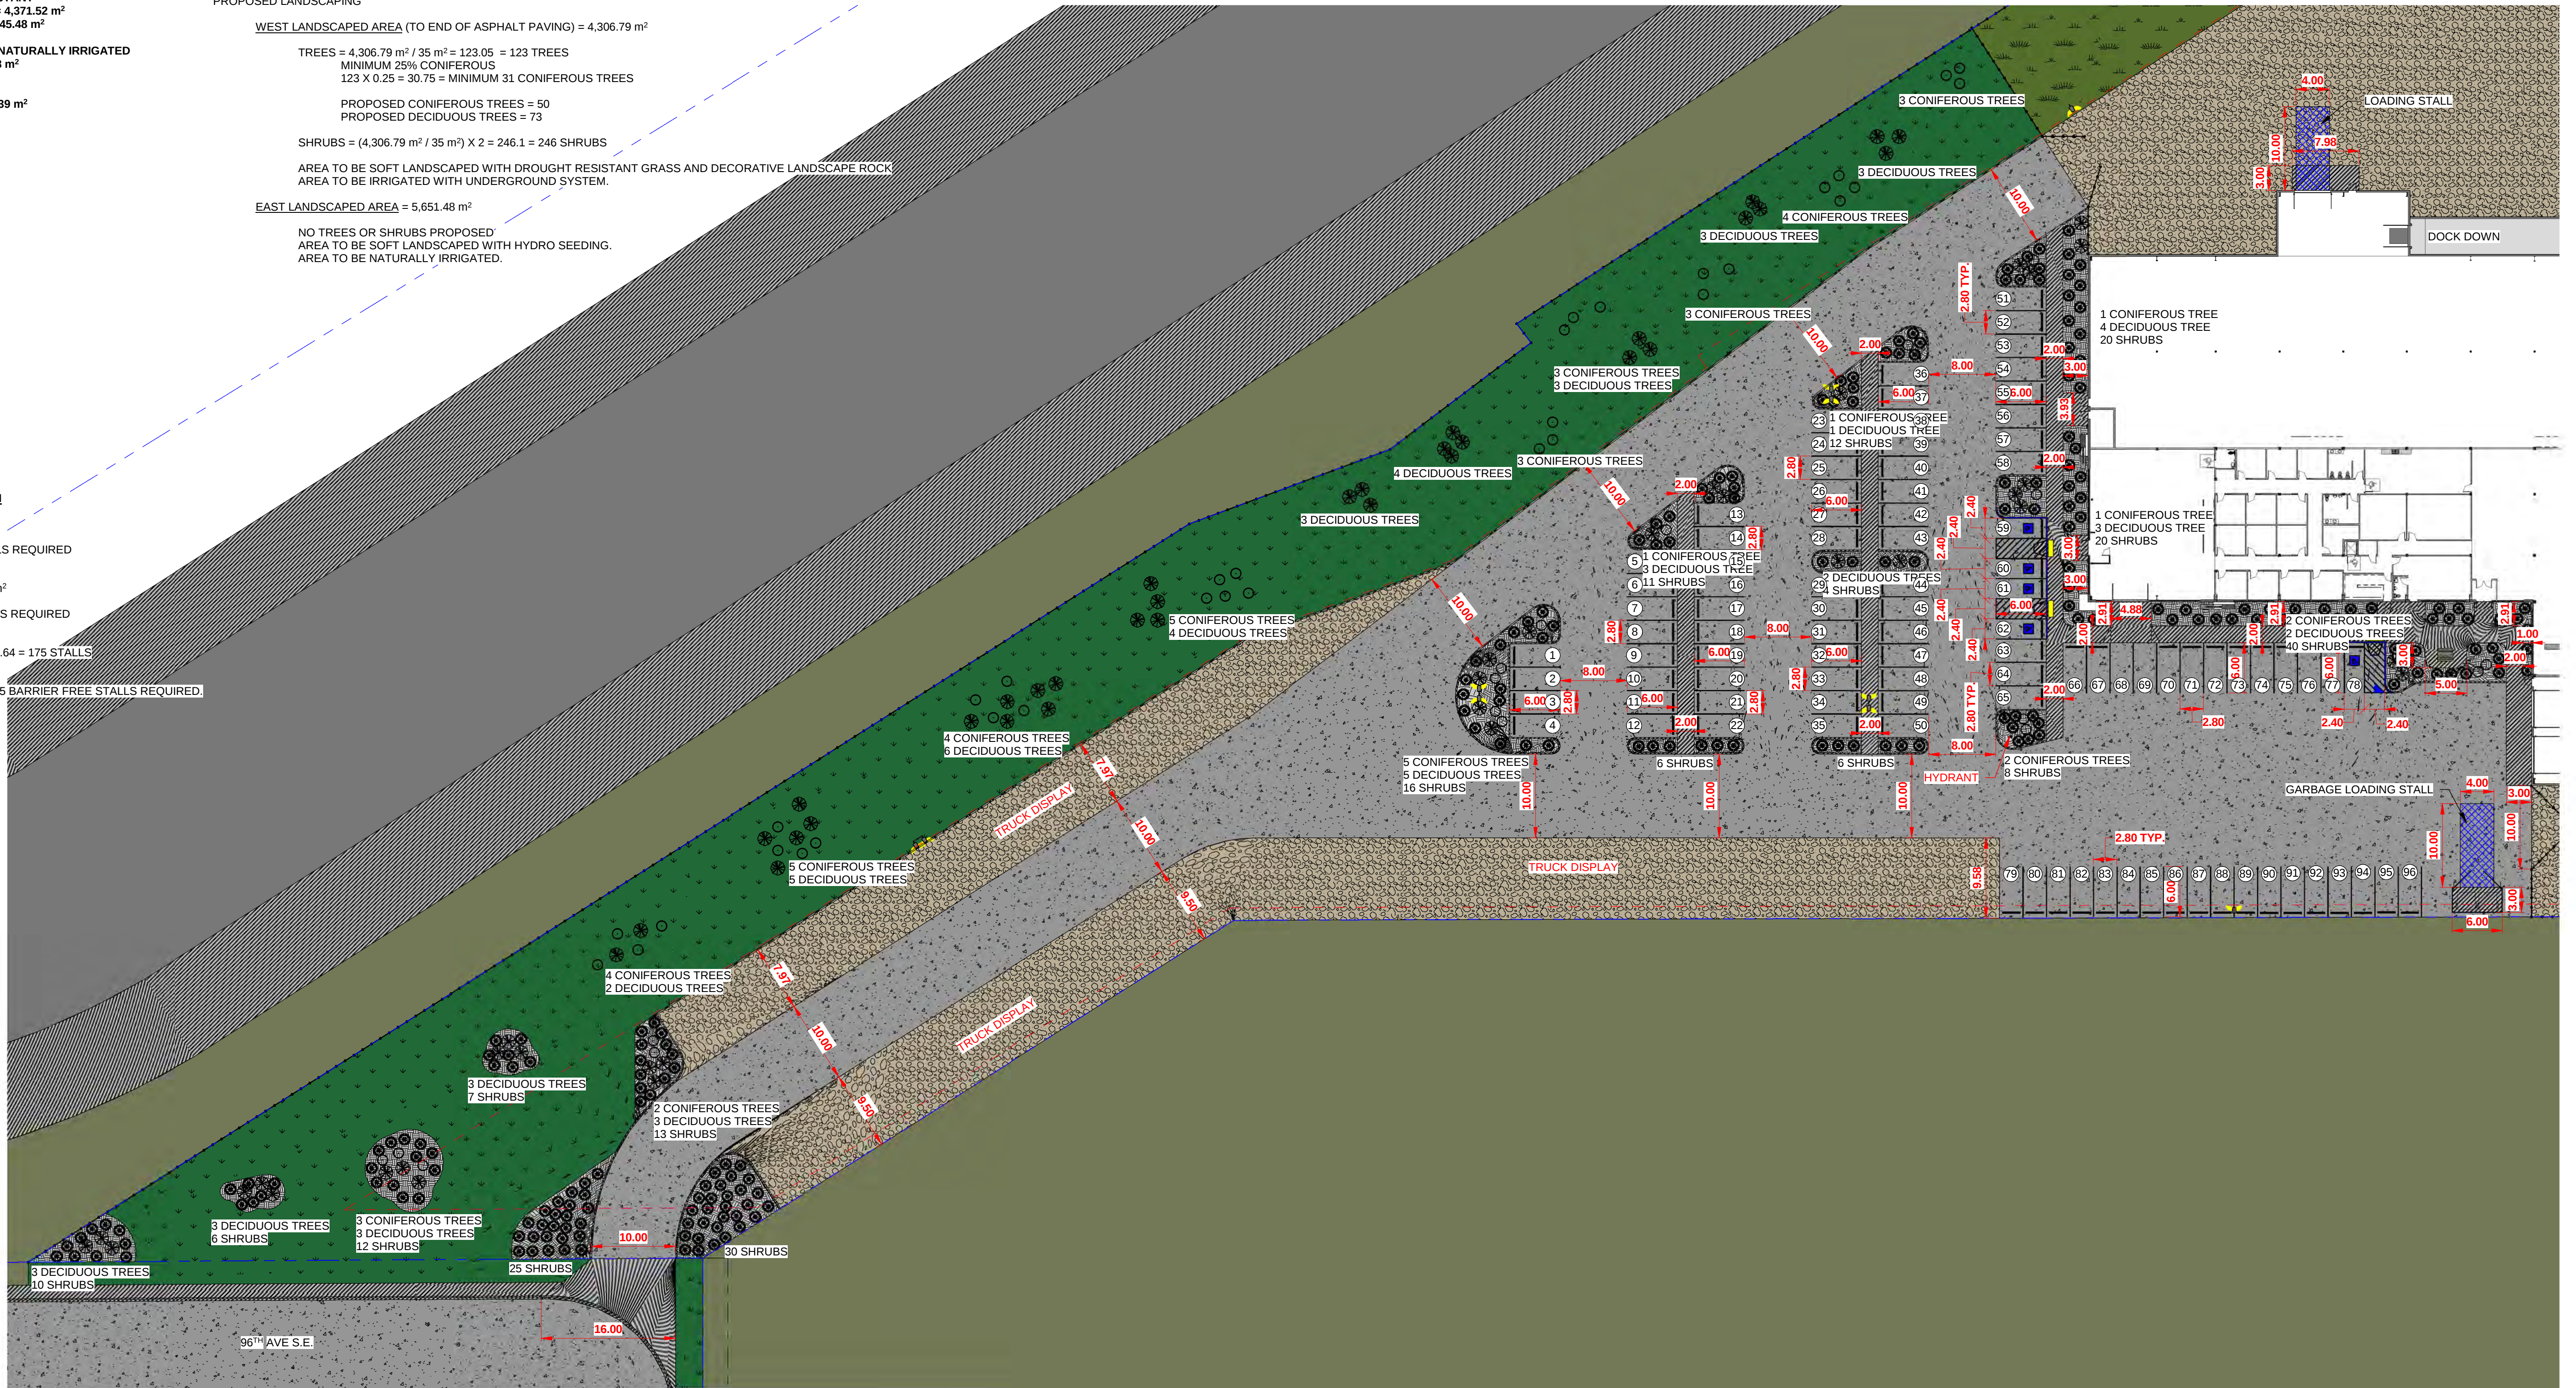

1 PROPOSED LANDSCAPING / PARKING
1 : 400


DO NOT SCALE THIS DRAWING
THESE DRAWINGS ARE THE
SOLE PROPERTY OF BOYCHUK
DESIGN BUILD
ANY REPRODUCTION OR USE
OF THESE DRAWINGS
REQUIRES THE WRITTEN
CONSENT OF BOYCHUK
DESIGN BUILD

REV #	Date:	Revision Description:





DESIGN:
DJB
DRAWN:
JP
CHECKED:
DJB
DATE:
12/26/25
SCALE:
As Indicated



DESTROY ALL COPIES OF THIS DRAWING PRIOR TO THIS DATE: 12/26/25		
PROJECT NAME: BOSCH TRUCK GROUP INC.		
LOCATION: CALGARY, ALBERTA	SHEET: A1.3	
PROJECT TYPE: COMMERCIAL DEALERSHIP		
TITLE: PROP. LANDSCAPING / PARKING		

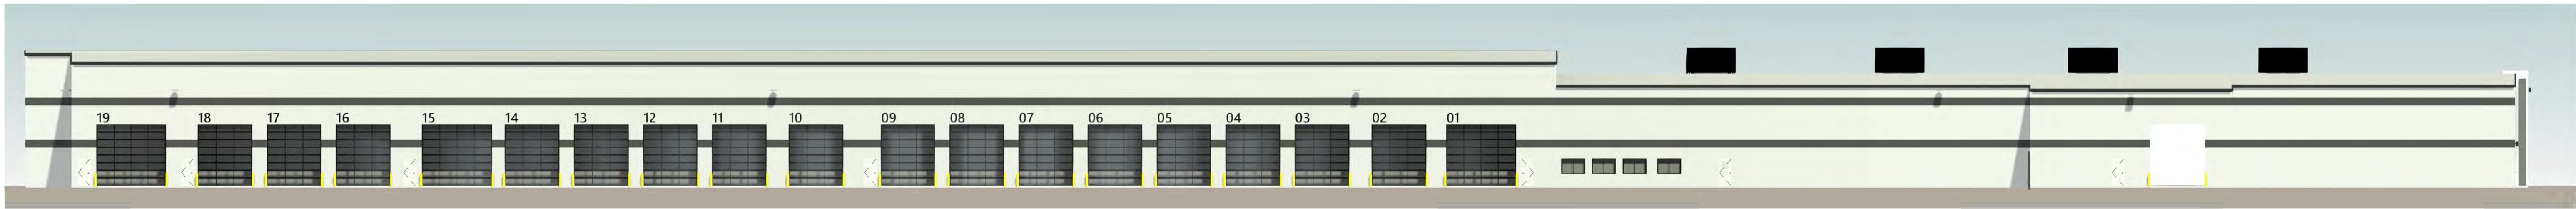


① NORTH ELEVATION
1 : 250

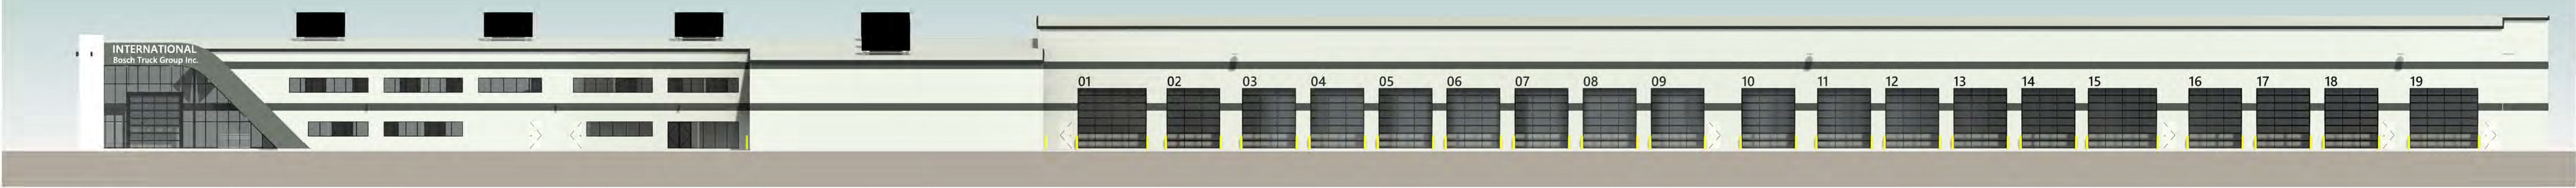 


② SOUTH ELEVATION
1 : 250

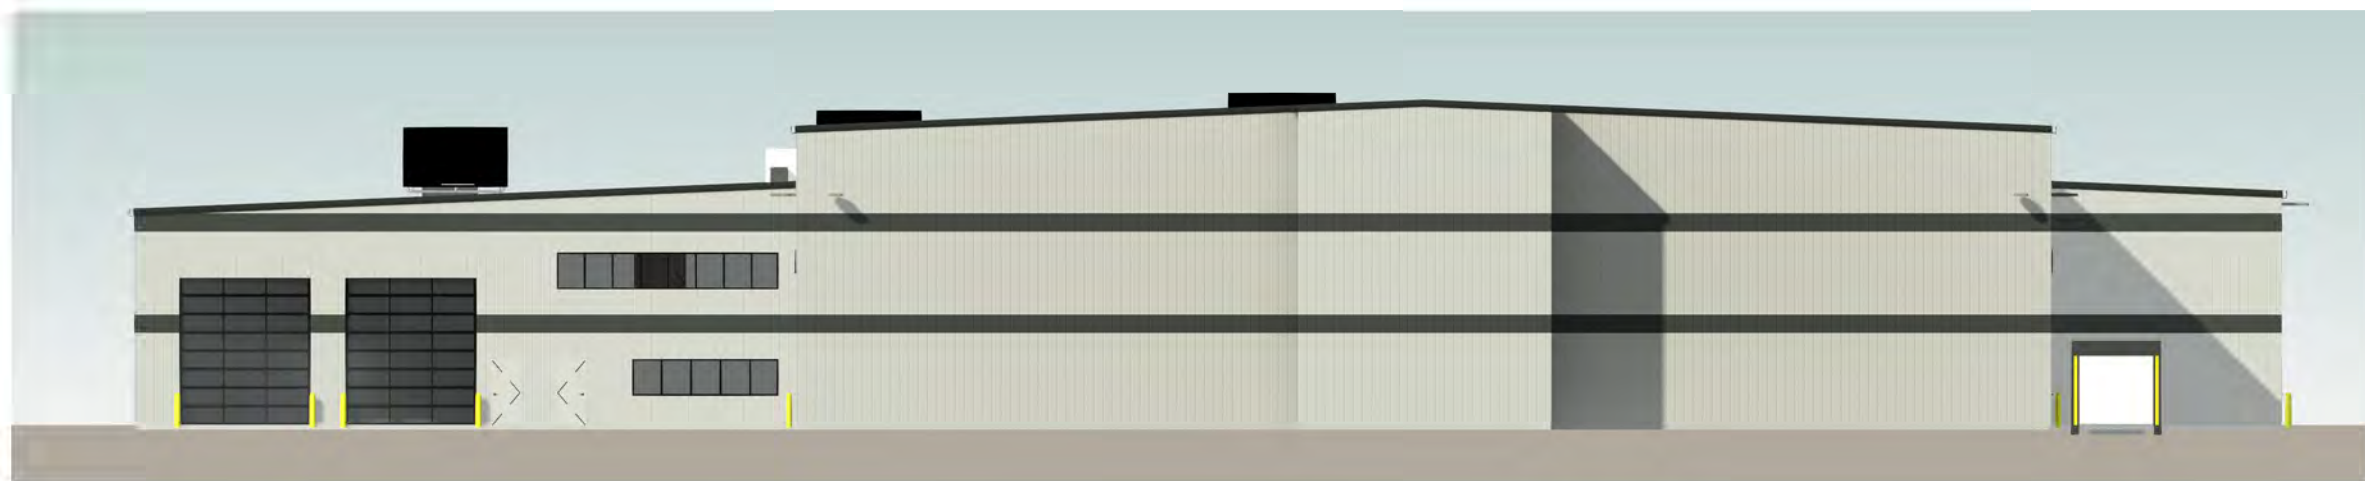 

③ EAST ELEVATION
1 : 250

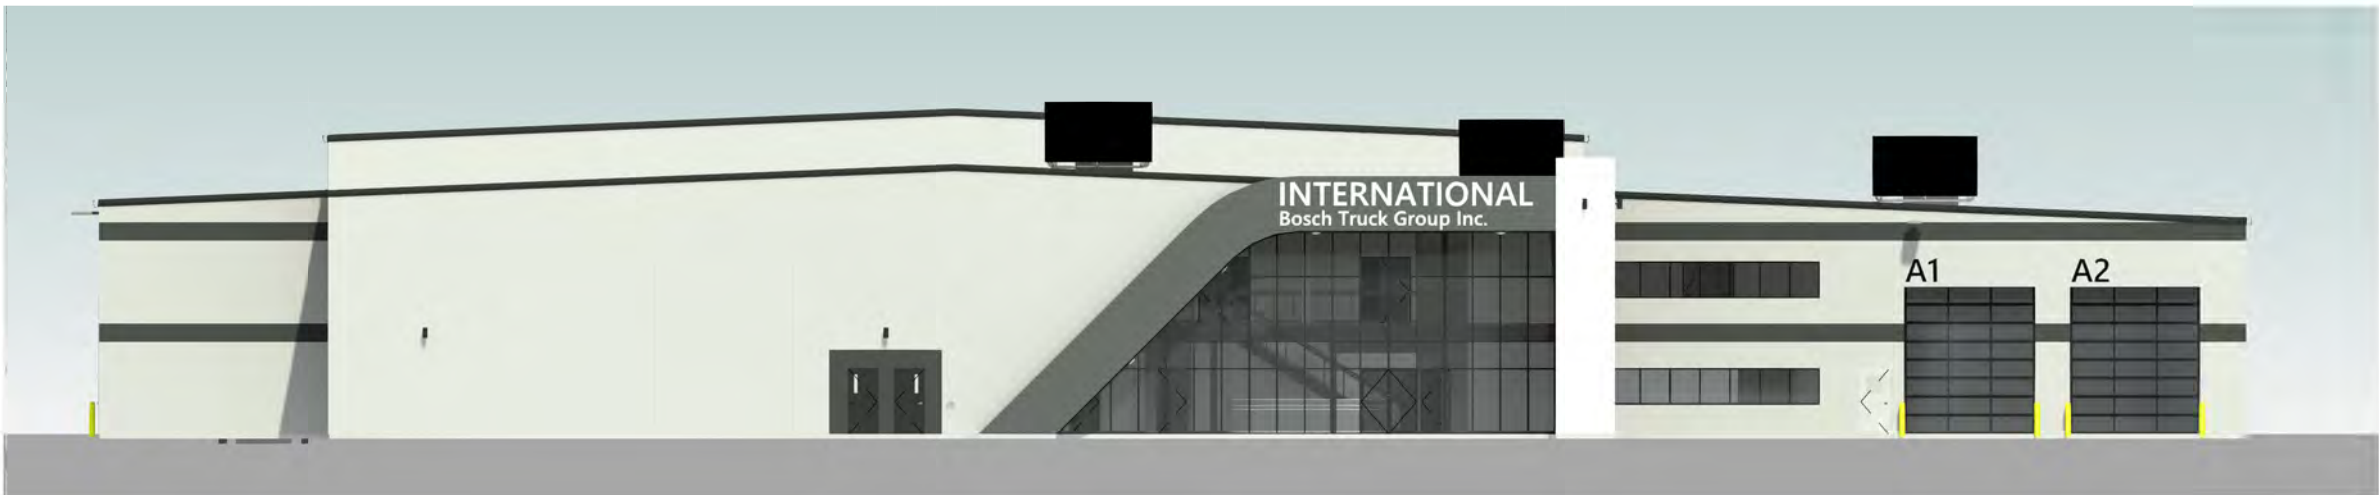


④ WEST ELEVATION

 



DO NOT SCALE THIS DRAWING
THESE DRAWINGS ARE THE
SOLE PROPERTY OF BOYCHUK
DESIGN BUILD
ANY REPRODUCTION OR USE
OF THESE DRAWINGS
REQUIRES THE WRITTEN
CONSENT OF BOYCHUK
DESIGN BUILD

REV #	Date:	Revision Description:

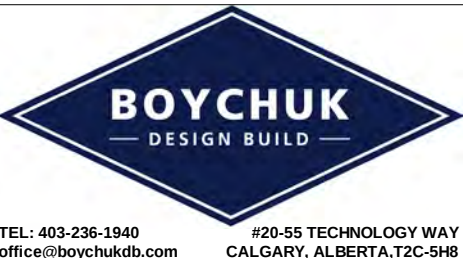


DESIGN:
D8
DRAWN:
JP
CHECKED:
D8
DATE:
12/26/25
SCALE:
1 : 250

DESTROY ALL COPIES OF THIS DRAWING PRIOR TO THIS DATE: 12/26/25		
PROJECT NAME: BOSCH TRUCK GROUP INC.		
LOCATION: CALGARY, ALBERTA	SHEET: A3	
PROJECT TYPE: COMMERCIAL DEALERSHIP		
TITLE: ELEVATIONS FULL		

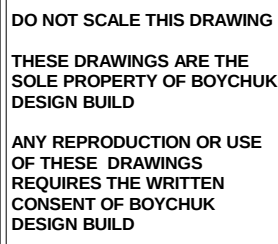
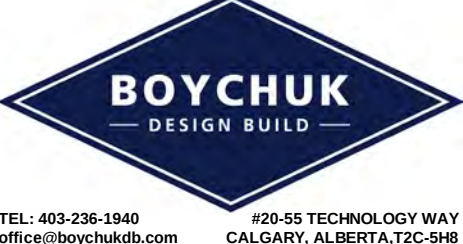
[illegible]

DESIGN:	DB
DRAWN:	JP
CHECKED:	DB
DATE:	12/26/25
SCALE:	1:150


PROJECT NAME: BOSCH TRUCK GROUP INC.		SHEET: A3.1
LOCATION: CALGARY, ALBERTA		
PROJECT TYPE: COMMERCIAL DEALERSHIP		
TITLE: ELEVATION DETAILS S EXP.		

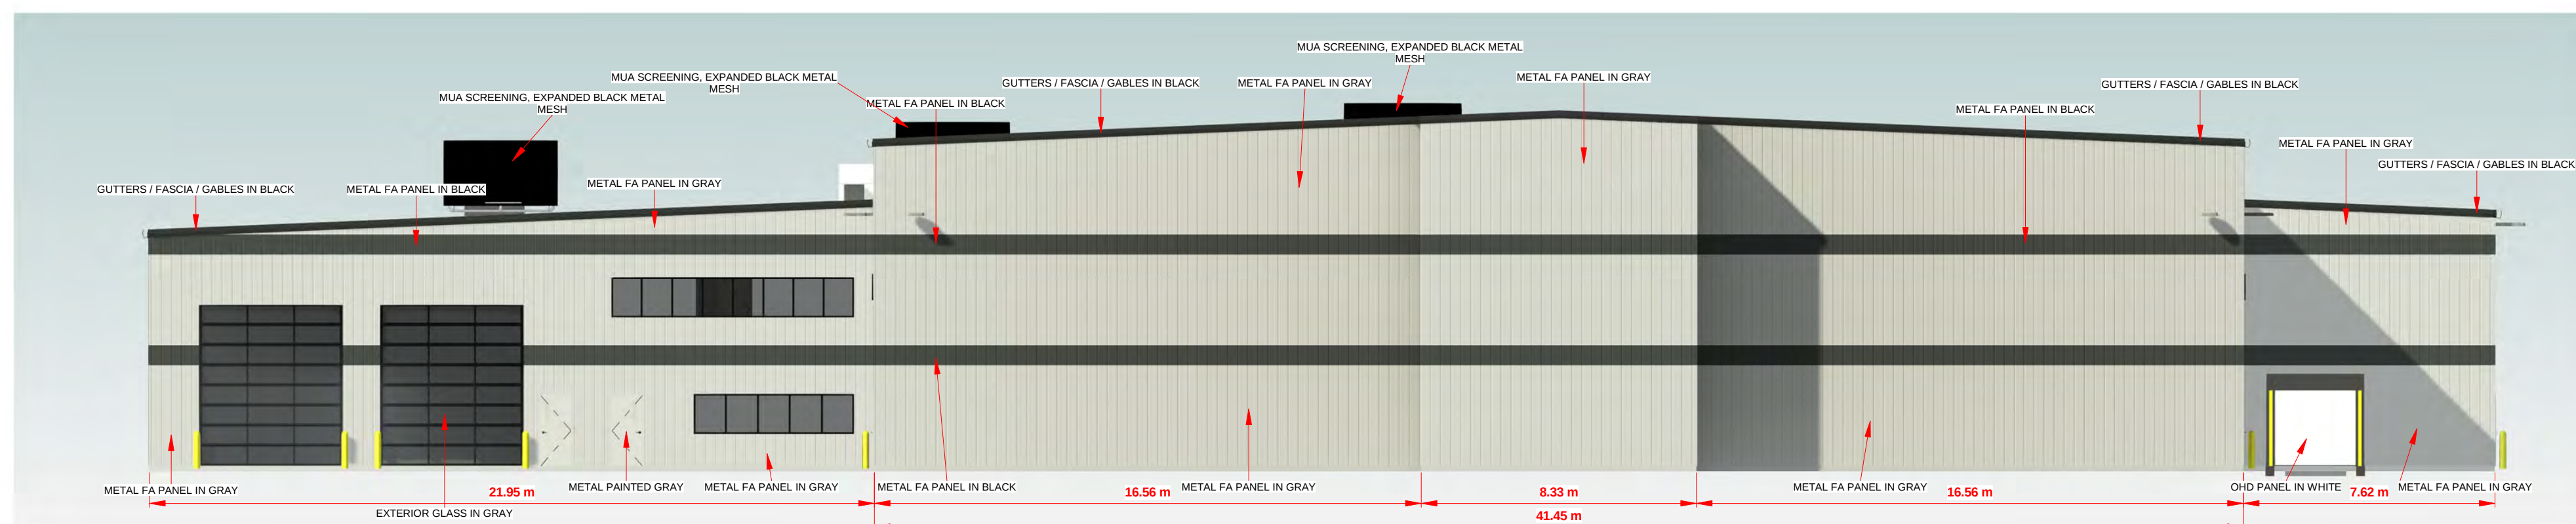

① EAST ELEVATION LARGE
1 : 150

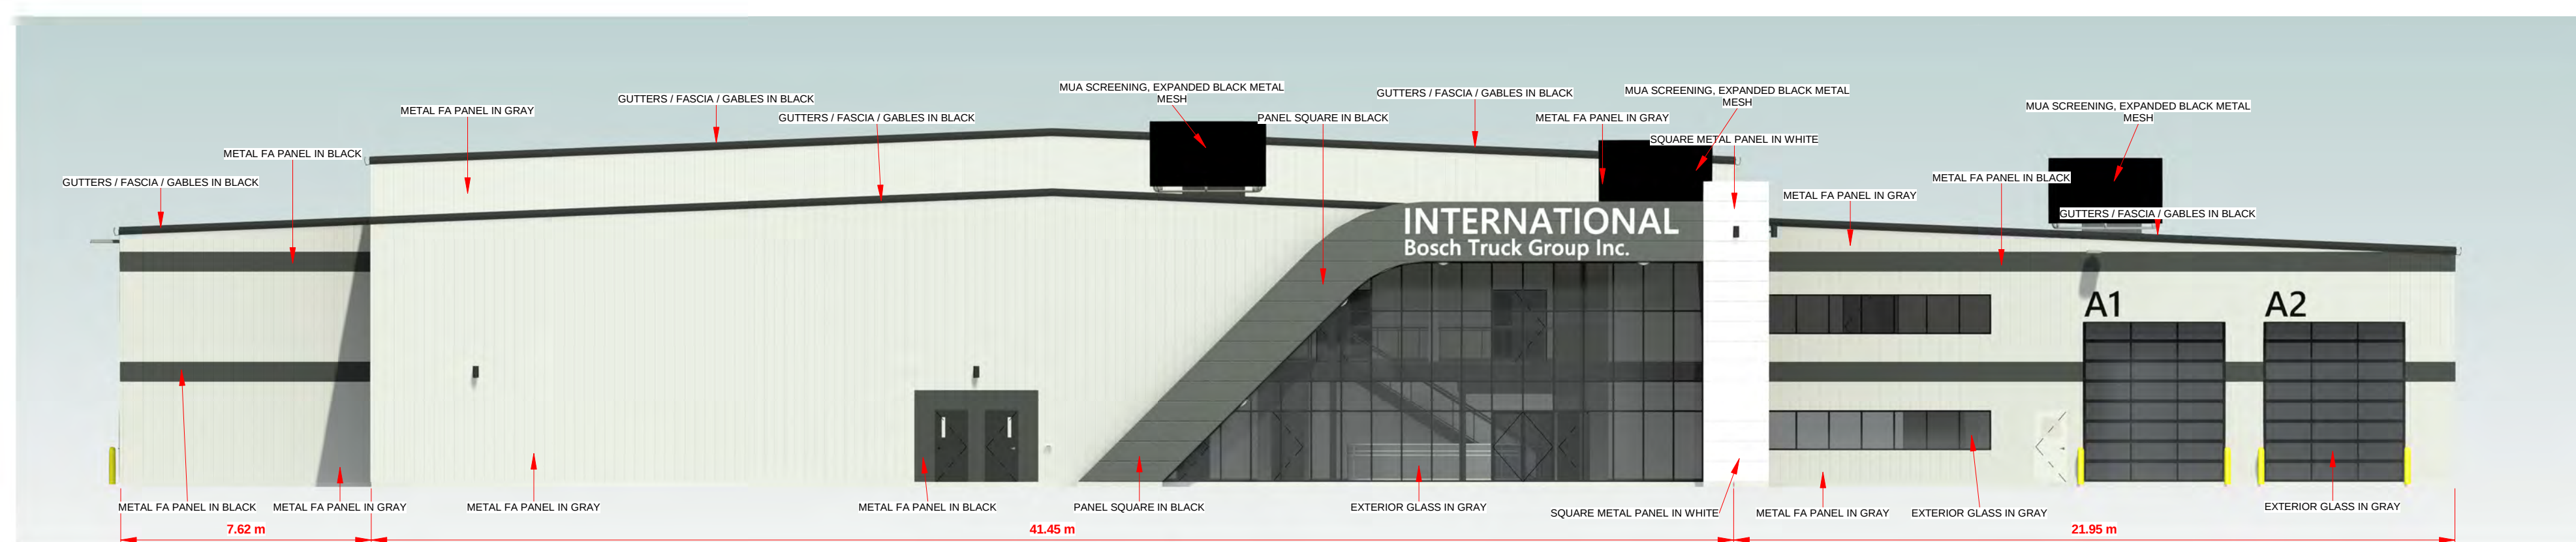 

③ WEST ELEVATION LARGE
1 : 150

 


1:150

THESE DRAWINGS ARE THE
SOLE PROPERTY OF BOYCHUK
DESIGN BUILD

ANY REPRODUCTION OR USE
OF THESE DRAWINGS
REQUIRES THE WRITTEN
CONSENT OF BOYCHUK
DESIGN BUILD

JUK						
E						

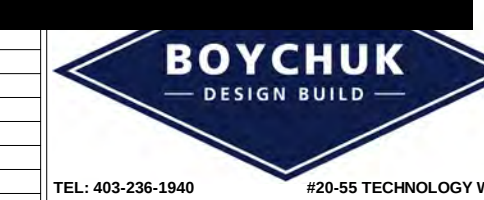

DESIGN:	DB
DRAWN:	JP
CHECKED:	DB
DATE:	12/26/25
SCALE:	1"=150'

DESTROY ALL COPIES OF THIS DRAWING
PRIOR TO THIS DATE: **12/26/25**

PROJECT NAME: **BOSCH TRUCK GROUP INC.**

LOCATION:	CALGARY, ALBERTA
PROJECT TYPE:	

COMMERCIAL DEALERSHIP

TITLE: ELEVATION DETAILS E/W EXP

SHEET:
A3.3