

EVERSYDE AFFORDABLE HOUSING



NOTE: IMAGES SHOWN ON THIS PAGE ARE FOR REPRESENTATIONS ONLY. EXACT CONFIGURATION MAY VARY. ALL BUILDING AND SITE DESIGN SUBJECT TO APPROVAL BY THE APPROVING AUTHORITY.

ISSUED FOR: DR1

2026-06-16

DRAWING INDEX

ARCHITECTURE

- DP.10.01 CONTEXT PLAN & PROJECT STATISTICS
- DP10.02 OVERALL SITE RENDERS
- DP10.03 EXISTING SITE PLAN
- DP10.04 PROPOSED SITE PLAN
- DP10.05 PROPOSED PHASING PLAN
- DP10.06 SITE PLAN SERVICING - FIRE TRUCK
- DP10.07 SITE PLAN SERVICING - WASTE AND RECYCLING
- DP10.08 SITE & BIKE STORAGE DETAILS
- DP20.01 TOWNHOUSE BLOCK PLANS - GROUND FLOOR
- DP20.02 TOWNHOUSE BLOCK PLANS - SECOND FLOOR
- DP20.03 MAIN FLOOR PLANS & SECOND FLOOR PLAN
- DP20.04 AMENITY BUILDING FLOOR PLAN
- DP20.05 ROOF PLAN - TOWNHOUSE BLOCKS & AMENITY
- DP40.01 EXTERIOR ELEVATIONS - BLOCK 1
- DP40.02 EXTERIOR ELEVATIONS - BLOCK 2
- DP40.03 EXTERIOR ELEVATIONS - BLOCK 3
- DP40.04 EXTERIOR ELEVATIONS - BLOCK 4
- DP40.05 EXTERIOR ELEVATIONS - BLOCK 5
- DP40.06 EXTERIOR ELEVATIONS - BLOCK 6
- DP40.07 EXTERIOR ELEVATIONS - BLOCK 7
- DP40.08 EXTERIOR ELEVATIONS - AMENITY BUILDING
- DP50.01 SITE SECTIONS

CIVIL

- 244-04 SVC SITE SERVICING PLAN (FOR DP)
- 244-04 GRAD SITE GRADING PLAN (FOR DP)
- 244-04 GRAD GRADING SECTIONS
- UNTITLED LOW PROFILE ROLLED CURB DETAIL

LANDSCAPE

- DP L01 BYLAW PLAN
- DP L02 LAYOUT PLAN

ELECTRICAL

- DP E101 SITE PLAN
- DP E102 PHOTOMETRIC CALCULATION
- DP E103 LUMINAIRE SCHEDULE



NOTES:
• DIMENSION TO FACE OF STUD (INTERIOR PARTITIONS), CONCRETE, CONCRETE BLOCK, EXTERIOR WALL SHEATHING - UNLESS NOTED OTHERWISE.
• NOTE WHEN REQUIRED MINIMUM CLEAR DIMENSIONS WILL BE IDENTIFIED.
• VERIFY ALL DIMENSIONS, ELEVATIONS, AND DATUM, REPORT ANY ERRORS AND/OR DISCREPANCIES TO THE ARCHITECT PRIOR TO CONSTRUCTION.
• DO NOT SCALE DRAWINGS.
• THIS DRAWING SUPERCEDES PREVIOUS ISSUES.

NORTH WEST CORNER RENDER



COURTYARD VIEW FROM ACCESSIBLE UNITS



INTERIOR STREET LOOKING SOUTH



COMMUNITY BUILDING




NOTE: IMAGES SHOWN ON THIS PAGE ARE FOR REPRESENTATIONS ONLY. EXACT CONFIGURATION MAY VARY. ALL BUILDING AND SITE DESIGN SUBJECT TO APPROVAL BY THE APPROVING AUTHORITY


Project	Project Number: 25059
HOMESPACE SOCIETY	
EVERSYDE AFFORDABLE	
HOUSING	
2525 Eversyde Ave SW, Calgary AB	
Legal Description Lot 55, Blk 1, 041 2677 (Proposed Sub-Div.) Development Permit No. DP2026-00773	Building Permit No. DSSP No.
	
Drawing Title OVERALL SITE RENDERS	
LF	Scale
Tech Review:	Date (YYYY-MM-DD)
Drawing Number DP10.02	Drawing Package Revision Number

NOTES:
• DIMENSION TO FACE OF STUD (INTERIOR PARTITIONS), CONCRETE, CONCRETE BLOCK, EXTERIOR WALL SHEATHING - UNLESS NOTED OTHERWISE.
• NOTE WHEN REQUIRED MINIMUM CLEAR DIMENSIONS WILL BE IDENTIFIED.
• VERIFY ALL DIMENSIONS, ELEVATIONS, AND DATUMS. REPORT ANY ERRORS AND/OR DISCREPANCIES TO THE ARCHITECT PRIOR TO CONSTRUCTION.
• DO NOT SCALE DRAWINGS.
• THIS DRAWING SUPERCEDES PREVIOUS ISSUES.

PRELIMINARY - NOT FOR CONSTRUCTION

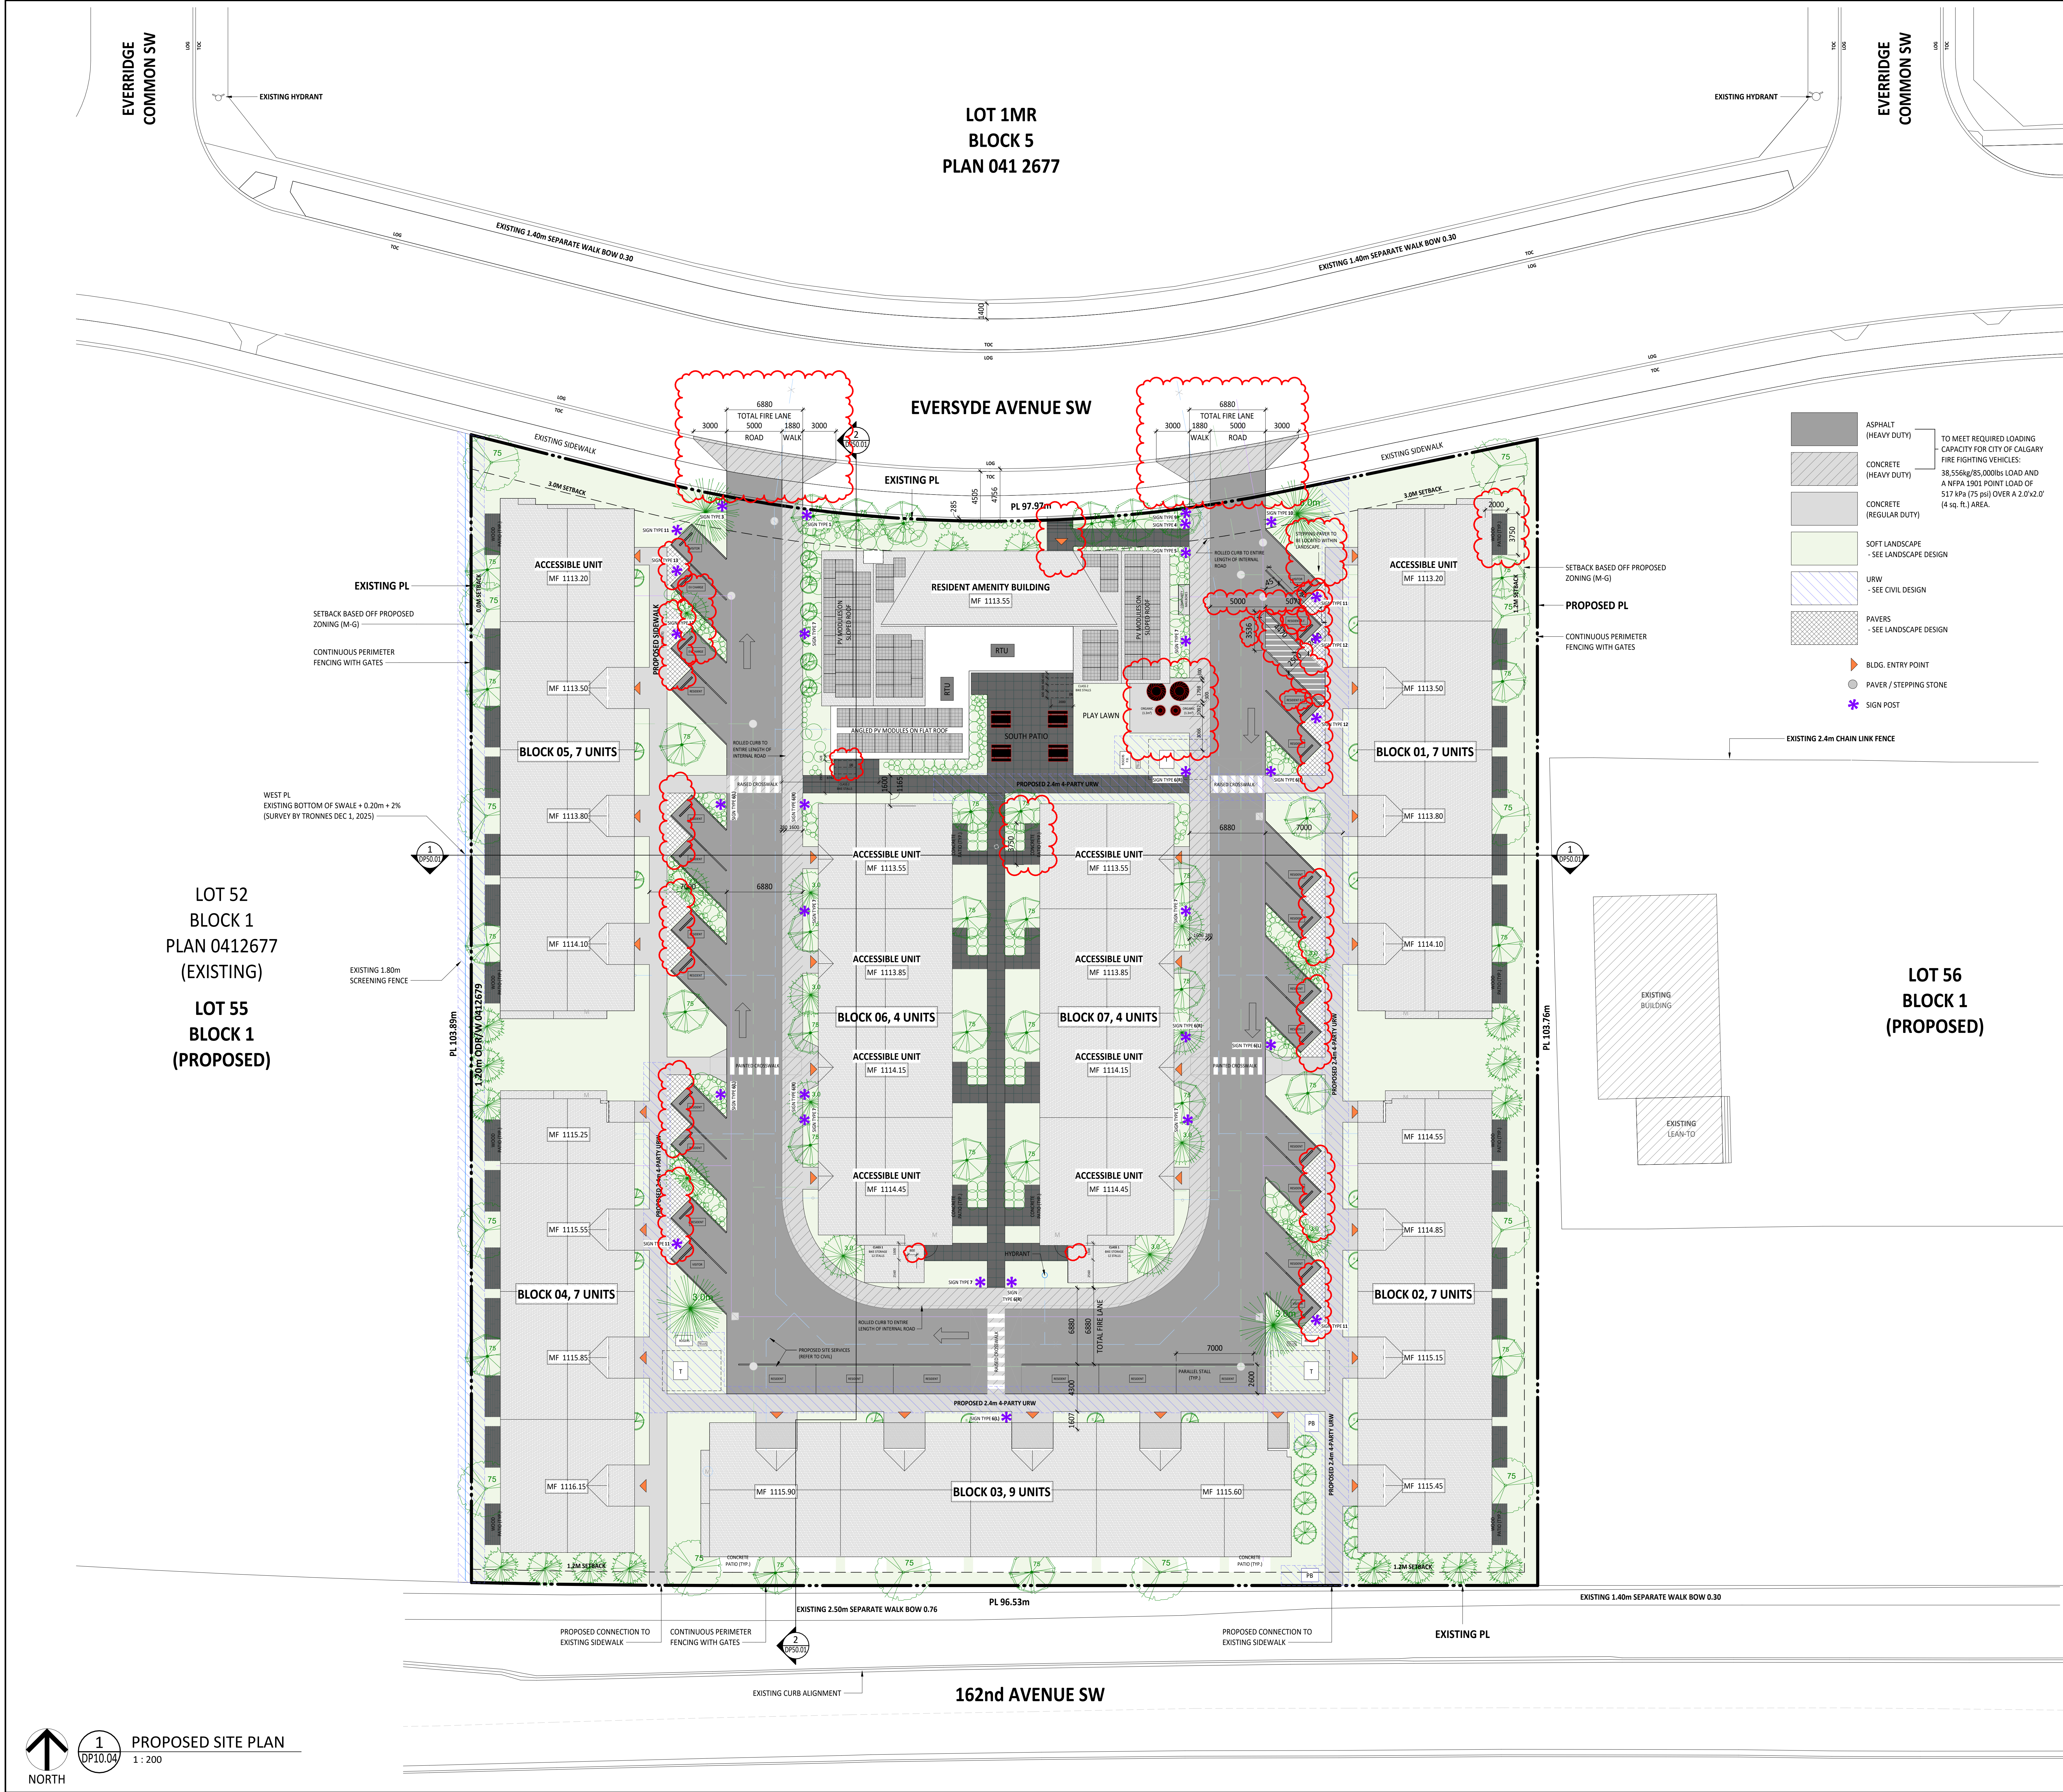

- ASPHALT (HEAVY DUTY)
 - CONCRETE (HEAVY DUTY)
 - CONCRETE (REGULAR DUTY)
 - SOFT LANDSCAPE - SEE LANDSCAPE DESIGN
 - URW - SEE CIVIL DESIGN
 - PAVERS - SEE LANDSCAPE DESIGN
- TO MEET REQUIRED LOADING - CAPACITY FOR CITY OF CALGARY FIRE FIGHTING VEHICLES:
38,556kg/85,000lb LOAD AND A NFPA 1901 POINT LOAD OF 517 kPa (75 psi) OVER A 2.0'x2.0' (4 sq. ft.) AREA.
- BLDG. ENTRY POINT
 - PAVER / STEPPING STONE
 - SIGN POST

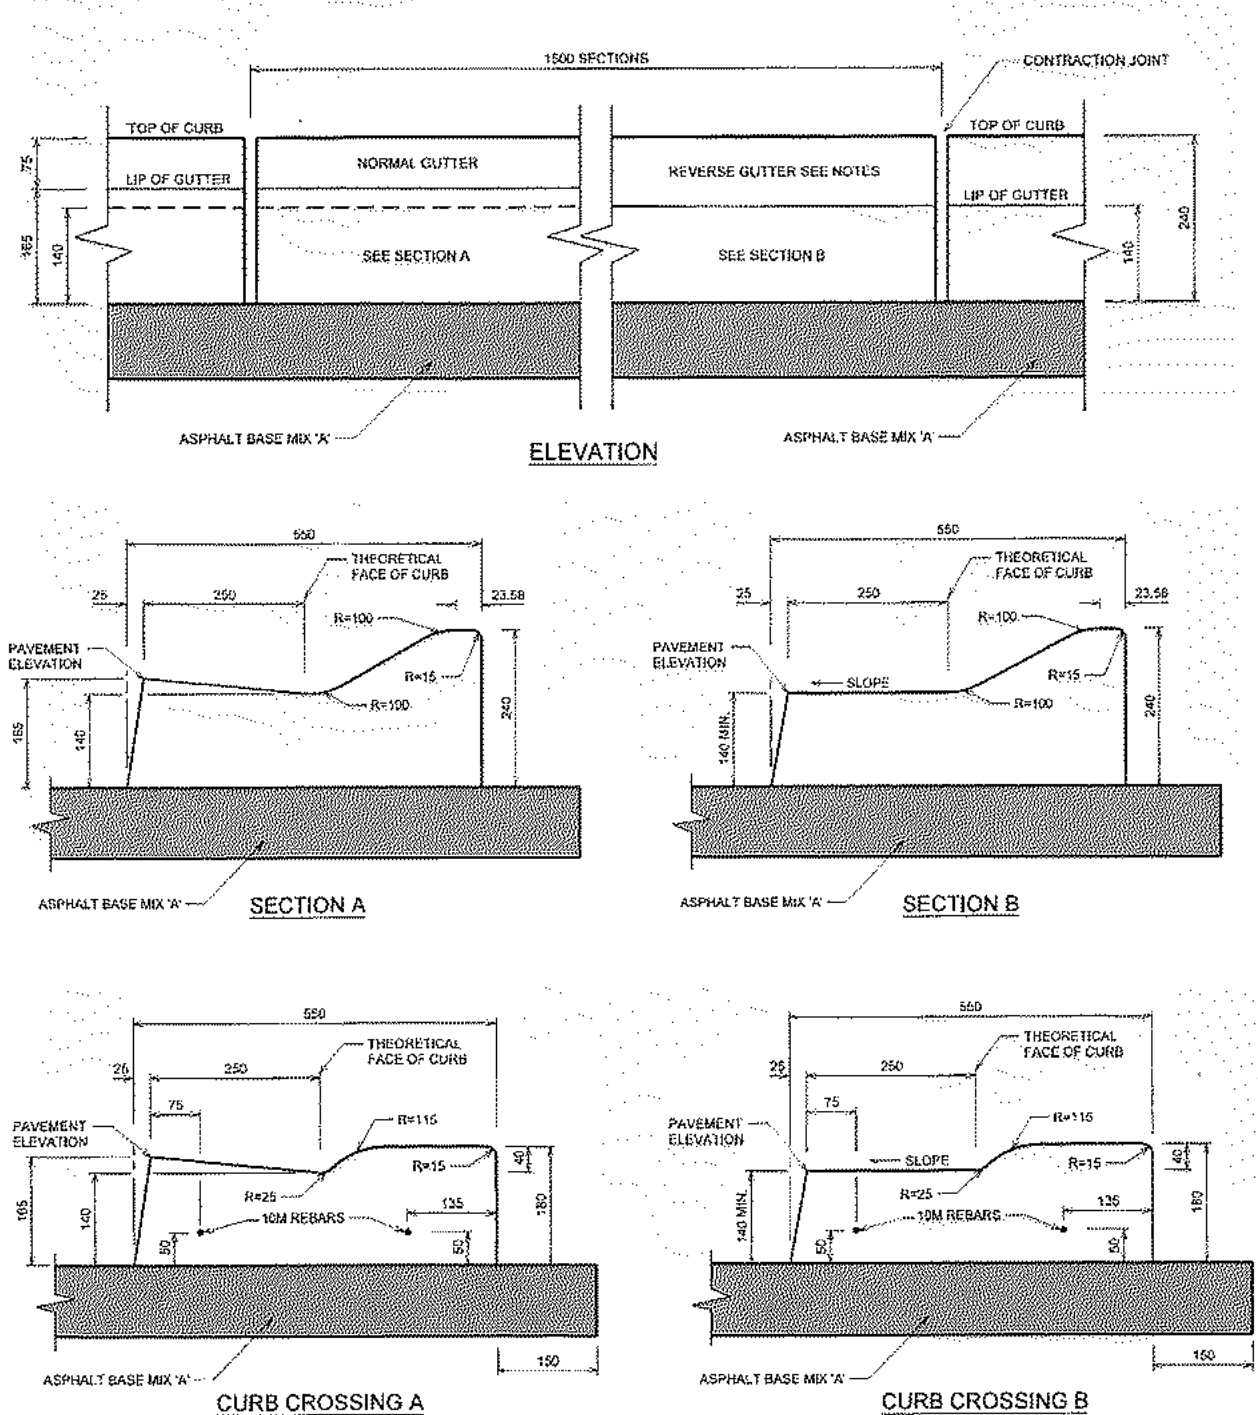

2 Rolled Curb Detail (Refer to Civil)
DP10.06 NTS

PARKING PROVIDED	
RESIDENT: 26 STALLS	
2 B.F. STALLS	
2 EV CAPABLE STALLS	
VISITOR: 4 STALLS	

E DR 1
C DP RESUBMISSION
A DP RESUBMISSION

2026-04-20
2026-03-16

Project
HOMESPACE SOCIETY
EVERSYDE AFFORDABLE
HOUSING
2525 Eversyde Ave SW, Calgary AB
Legal Description
Lot 55, Blk 1, 041 2677
(Proposed Sub-Div.)
Development Permit No.
DP2026-00773

Project Number: 25059
Building Permit No.
DSSP No.



Drawing Title
PROPOSED SITE PLAN


Scale
1 : 200
Date (YYYY-MM-DD)

Tech Review:
Drawing Number
DP10.04

Drawing Package
Revision Number
E

PRELIMINARY - NOT FOR CONSTRUCTION


- NOTES:**
- DIMENSION TO FACE OF STUD (INTERIOR PARTITIONS), CONCRETE, CONCRETE BLOCK, EXTERIOR WALL SHEATHING - UNLESS NOTED OTHERWISE.
 - NOTE WHEN REQUIRED MINIMUM CLEAR DIMENSIONS WILL BE IDENTIFIED.
 - VERIFY ALL DIMENSIONS, ELEVATIONS, AND DATUMS, REPORT ANY ERRORS AND/OR DISCREPANCIES TO THE ARCHITECT PRIOR TO CONSTRUCTION.
 - DO NOT SCALE DRAWINGS.
 - THIS DRAWING SUPERCEDES PREVIOUS ISSUES.

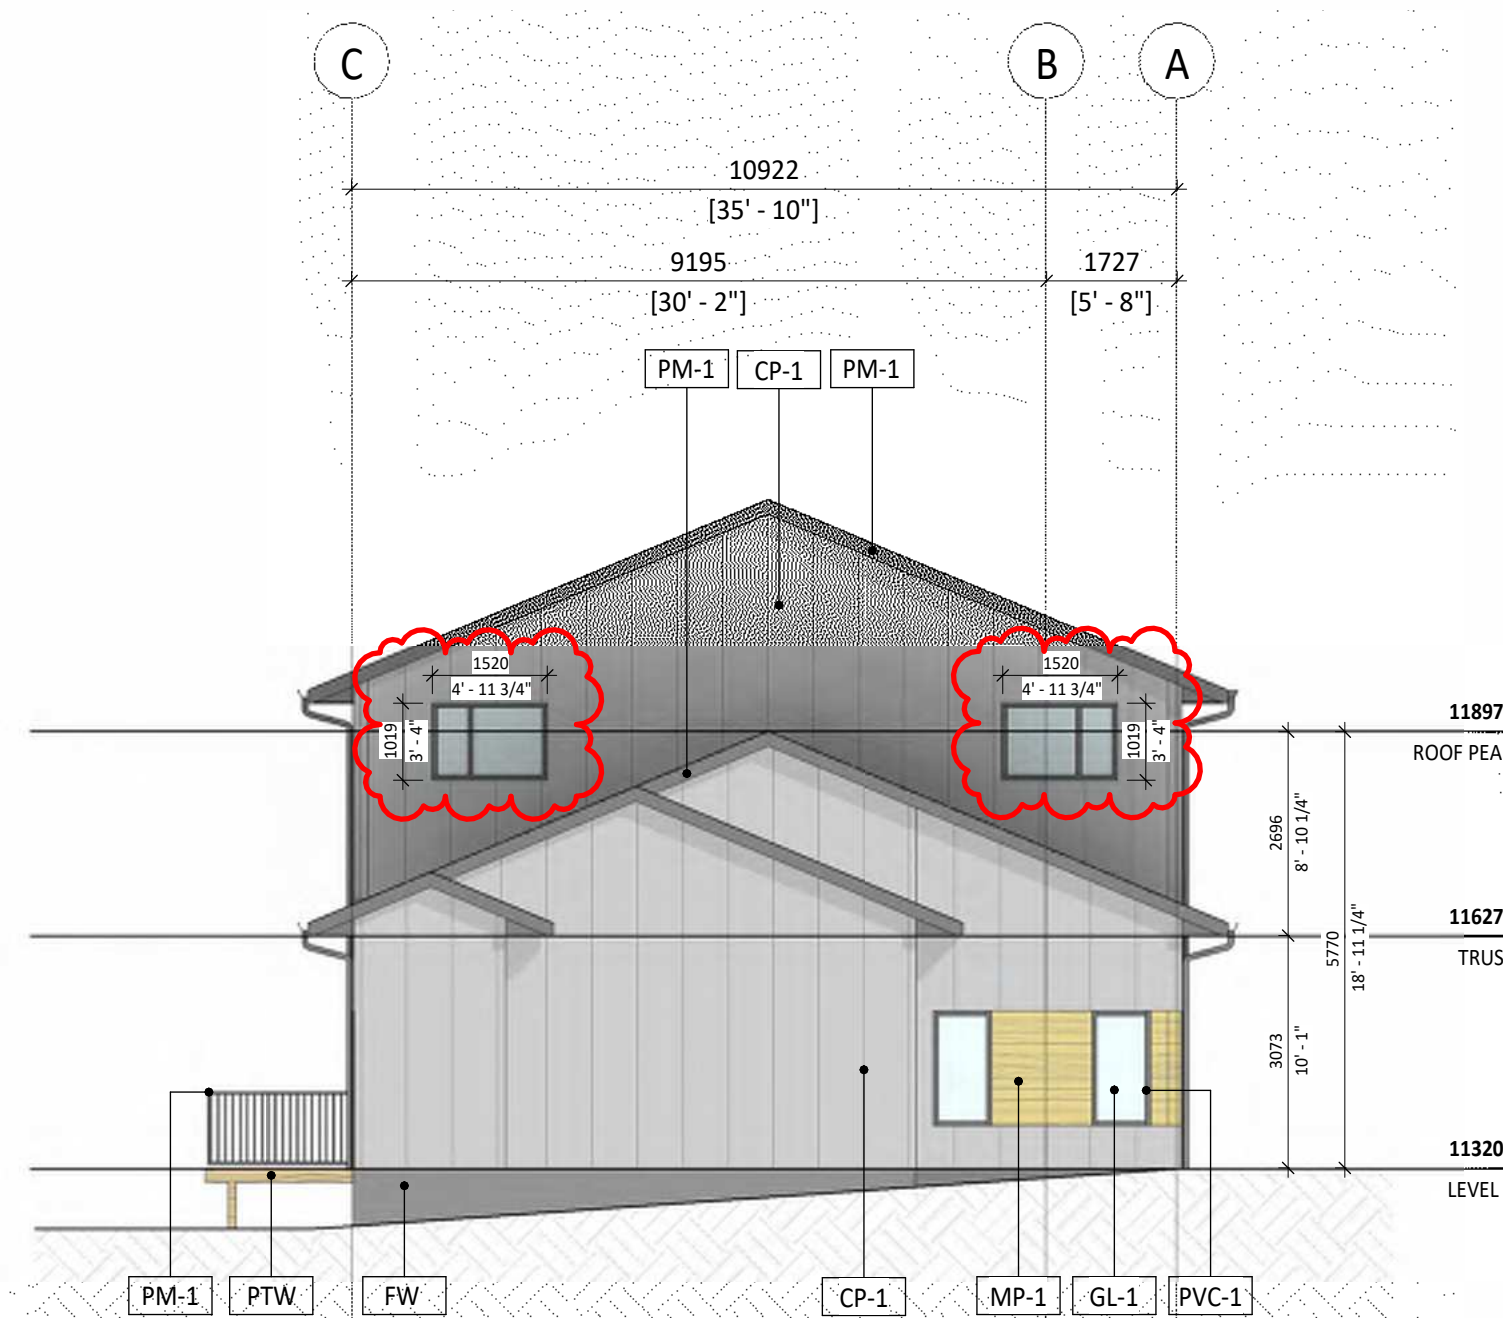

1 BLOCK 1 - NORTH ELEVATION
1:100



2 BLOCK 1 - EAST ELEVATION
1:100

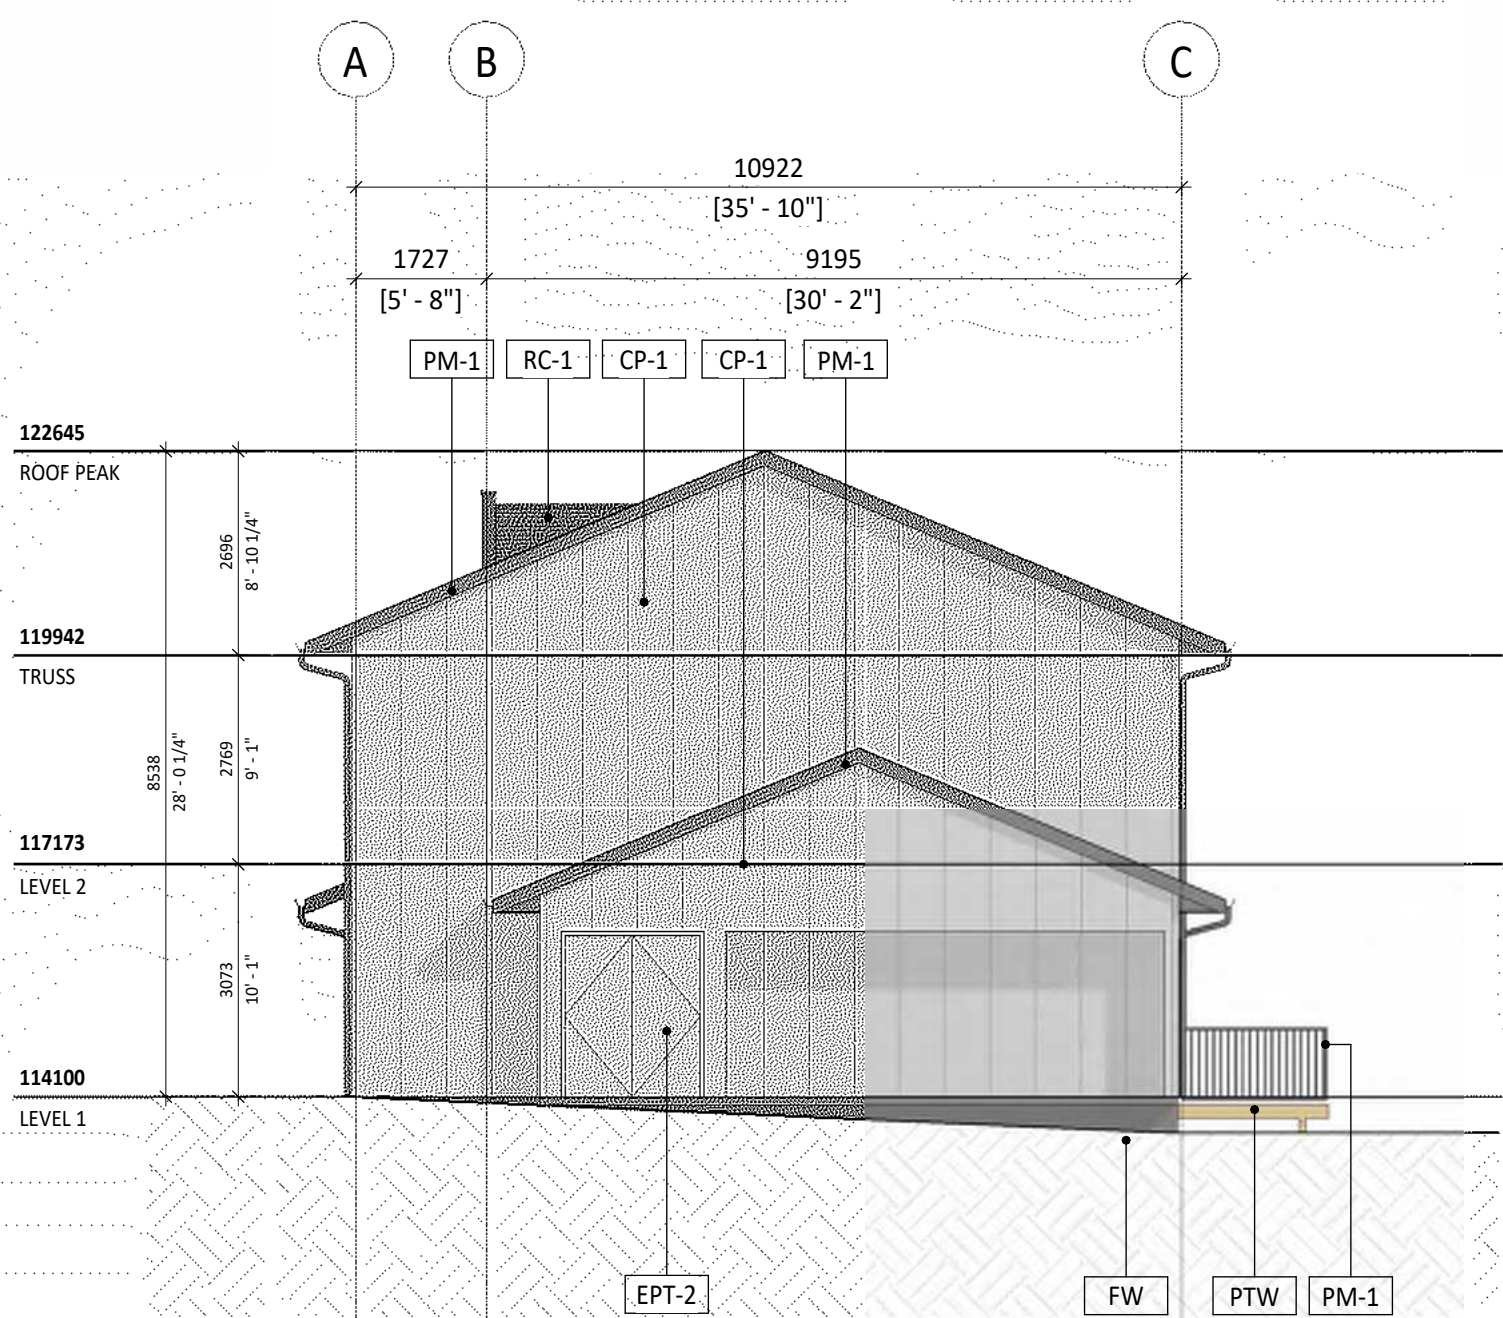

3 BLOCK 1 - SOUTH ELEVATION
1:100



4 BLOCK 1 - WEST ELEVATION
1:100

MATERIAL LEGEND

CP-1	CEMENTITIOUS BOARD & BATTEN PANEL - LIGHT GREY
CP-2	CEMENTITIOUS BOARD & BATTEN PANEL - DARK GREY
CP-3	CEMENTITIOUS LAP SIDING - LIGHT GREY
CP-4	CEMENTITIOUS LAP SIDING - DARK GREY
CP-5	CEMENTITIOUS FLAT PANEL - DARK GREY
MP-1	METAL PANEL - WOOD GRAIN APPEARANCE
RC-1	ROOF CLADDING SHINGLES - BLACK
EPT-1	EXTERIOR PAINT - DARK GREY
EPT-2	EXTERIOR PAINT - LIGHT GREY
GL-1	GLASS
PVC-1	PVC FRAME - DARK GREY
AL-1	PREFINISHED ALUMINUM FRAMES
PM-1	PREFINISHED METAL - BLACK
FW	FOUNDATION WALL - CONCRETE
PTW	PRESSURE TREATED WOOD
BE	BIKE ENCLOSURE

NOTE: REFER TO EXTERIOR FINISH MATERIAL LIST FOR ADDITIONAL INFORMATION & FINISH TYPES.

E DR 1
C DP RESUBMISSION
A DP RESUBMISSION

2026-04-20
2026-03-16

Project
Project Number: 25059
HOMESPACE SOCIETY
EVERSYDE AFFORDABLE HOUSING
2525 Eversyde Ave SW, Calgary AB
Legal Description
Lot 55, Blk 1, 041 2677
(Proposed Sub-Div.)
Development Permit No.
DP2026-00773
Building Permit No.
DSSP No.



Drawing Title
EXTERIOR ELEVATIONS - BLOCK 1

Scale
As indicated
Date (YYYY-MM-DD)





Tech Review:

Drawing Number

Revision Number

DP40.01

E

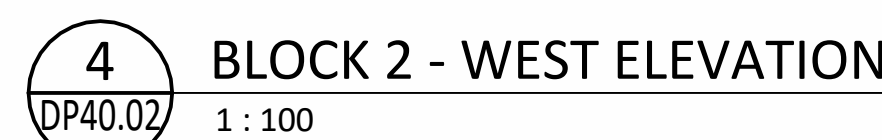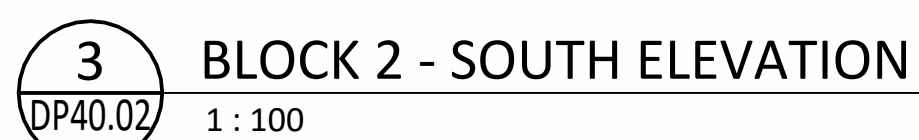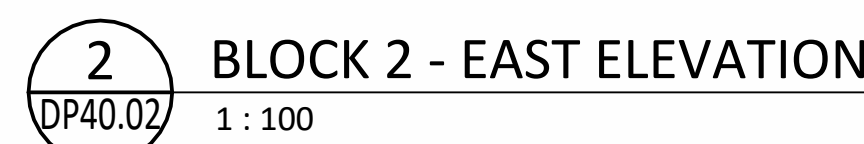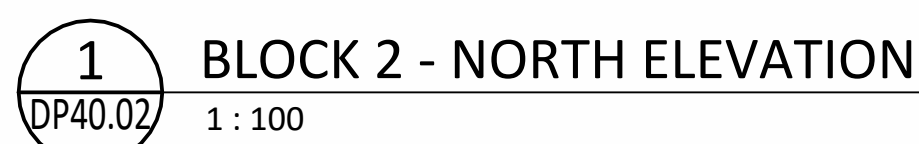

E	DR 1	
C	DP RESUBMISSION	2026-
A	DP RESUBMISSION	2026-





GGA-ARCHITECTURE

1	2	3	466
---	---	---	---	---	---	---	---	---	----	----	-----	-----	
Drawing Number	Drawing Page
----------------	--------------


2025-04-20
 2025-03-16
 er: 25059
 ETY
 ABLE
 AB
 ermit No.
 BLOCK 2
 ated
 Y-MM-DD)
 Drawing Package
 Revision Number
 E

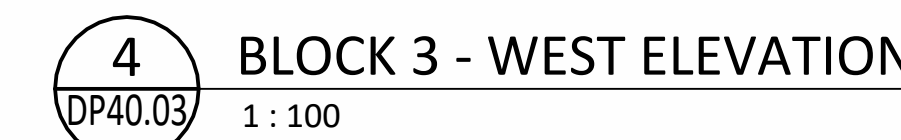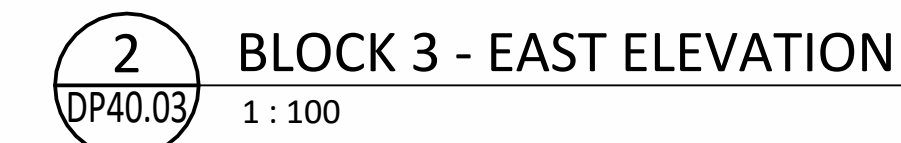

E	DR 1	
C	DP RESUBMISSION	2026-04-20
A	DP RESUBMISSION	2026-03-16

PRELIMINARY - NOT FOR CONSTRUCTION


- NOTES:**
- DIMENSION TO FACE OF STUD (INTERIOR PARTITIONS), CONCRETE, CONCRETE BLOCK, EXTERIOR WALL SHEATHING - UNLESS NOTED OTHERWISE.
 - NOTE WHEN REQUIRED MINIMUM CLEAR DIMENSIONS WILL BE IDENTIFIED.
 - VERIFY ALL DIMENSIONS, ELEVATIONS, AND DATUMS, REPORT ANY ERRORS AND/OR DISCREPANCIES TO THE ARCHITECT PRIOR TO CONSTRUCTION.
 - DO NOT SCALE DRAWINGS.
 - THIS DRAWING SUPERCEDES PREVIOUS ISSUES.

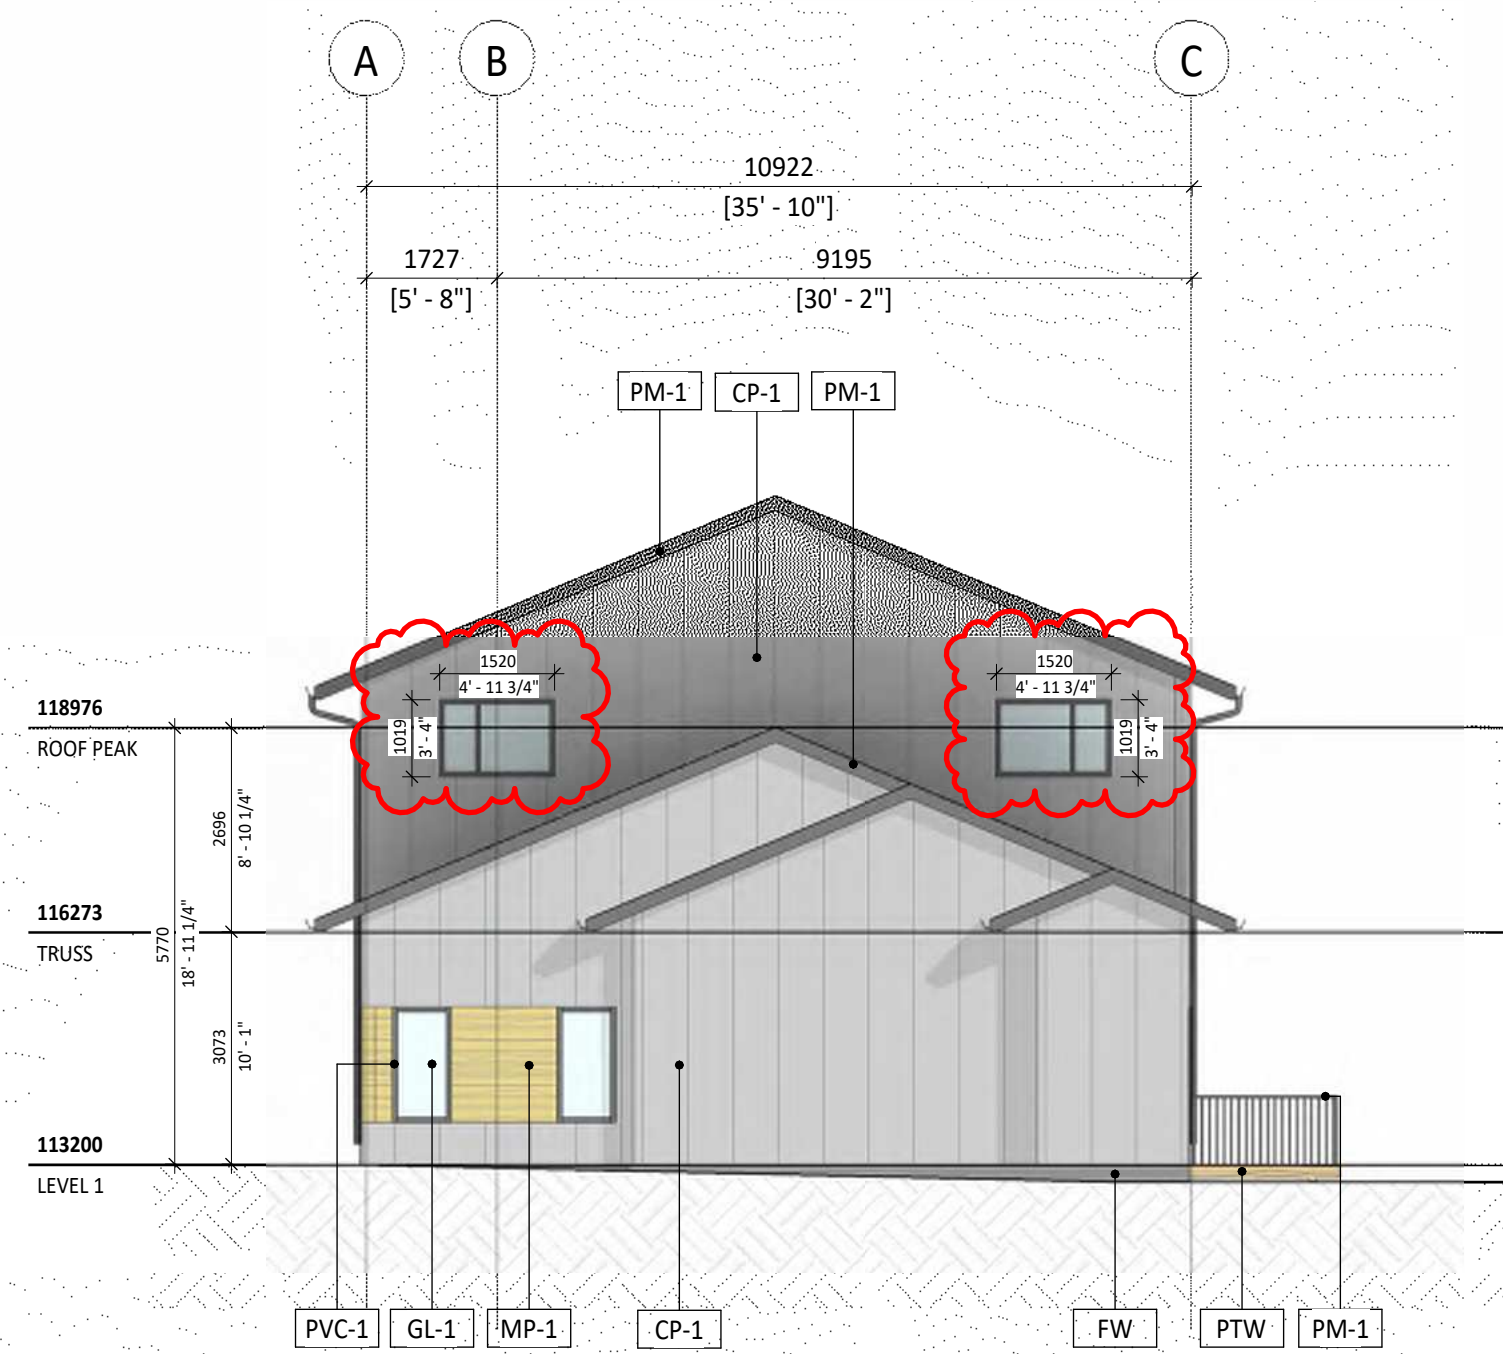

1 BLOCK 5 - NORTH ELEVATION
DP40.05 1:100



2 BLOCK 5 - EAST ELEVATION
DP40.05 1:100

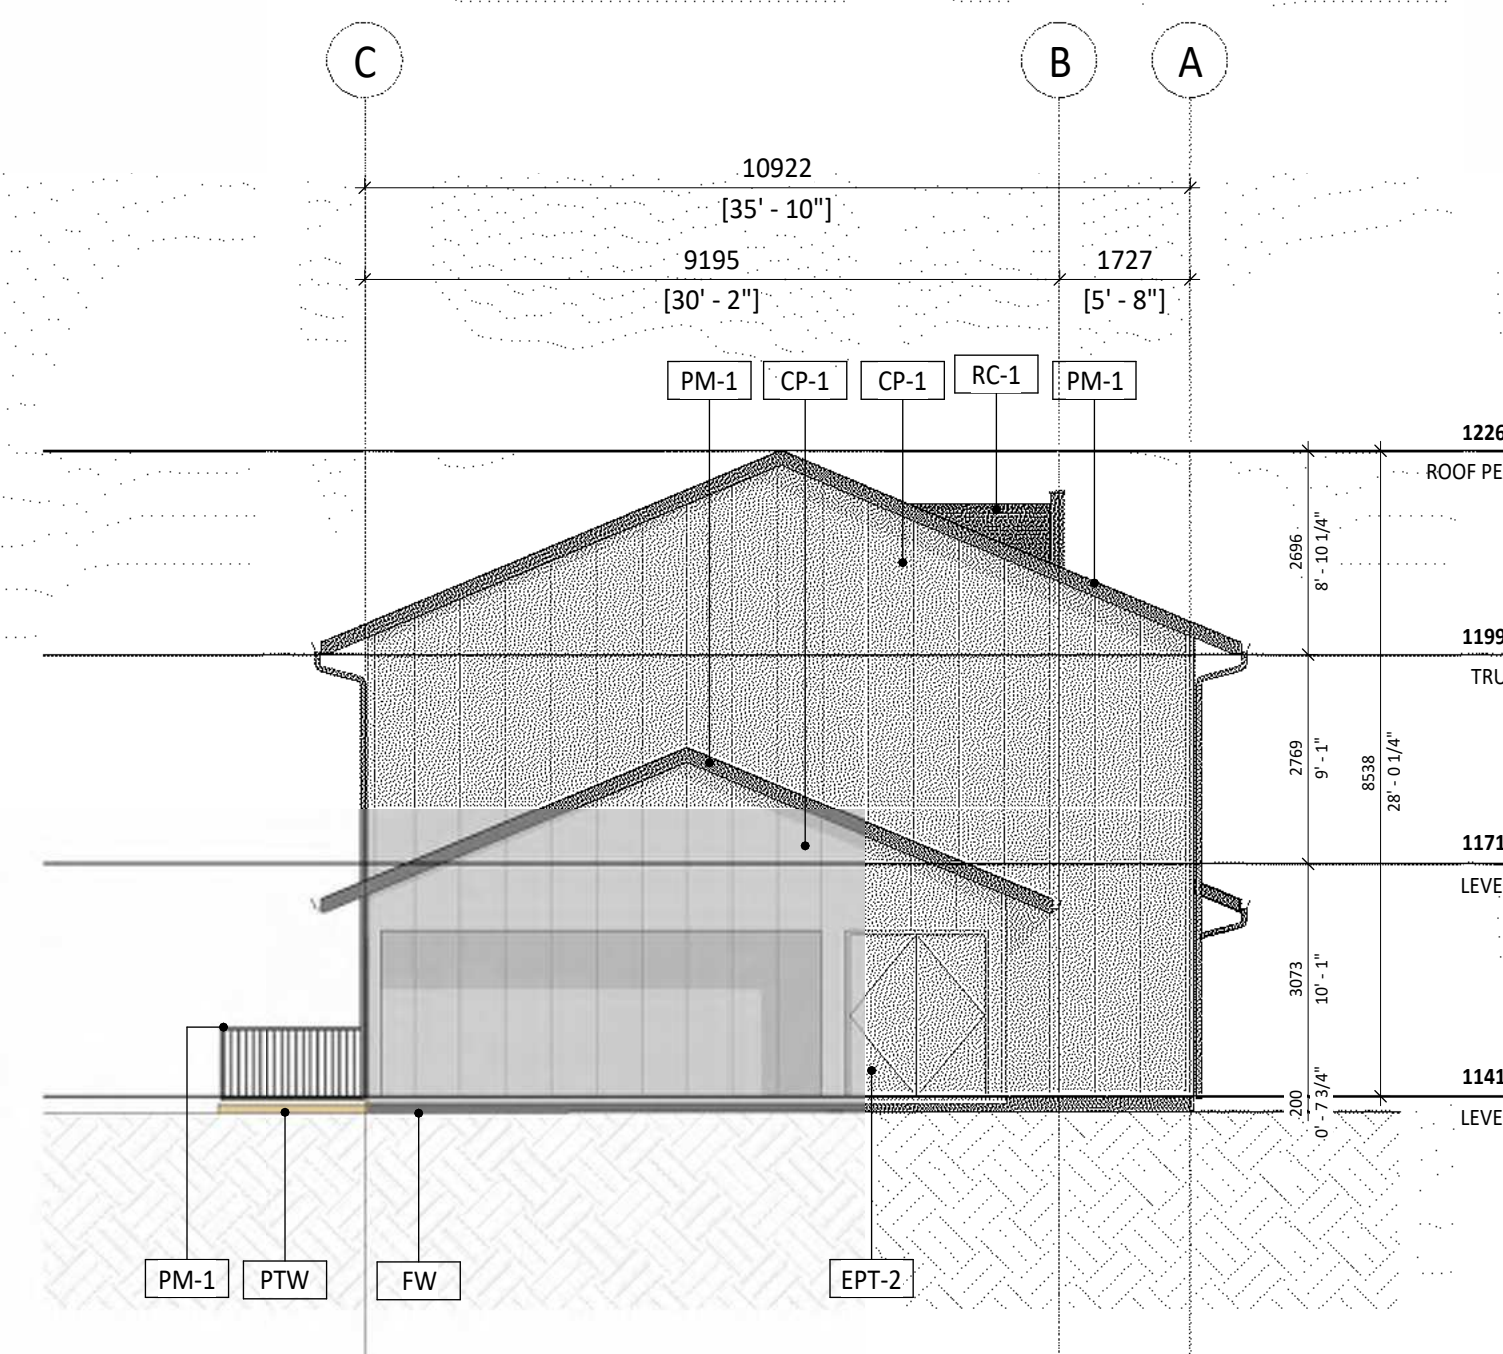

3 BLOCK 5 - SOUTH ELEVATION
DP40.05 1:100



4 BLOCK 5 - WEST ELEVATION
DP40.05 1:100

MATERIAL LEGEND

CP-1	CEMENTITIOUS BOARD & BATTEN PANEL - LIGHT GREY
CP-2	CEMENTITIOUS BOARD & BATTEN PANEL - DARK GREY
CP-3	CEMENTITIOUS LAP SIDING - LIGHT GREY
CP-4	CEMENTITIOUS LAP SIDING - DARK GREY
CP-5	CEMENTITIOUS FLAT PANEL - DARK GREY
MP-1	METAL PANEL - WOOD GRAIN APPEARANCE
RC-1	ROOF CLADDING SHINGLES - BLACK
EPT-1	EXTERIOR PAINT - DARK GREY
EPT-2	EXTERIOR PAINT - LIGHT GREY
GL-1	GLASS
PVC-1	PVC FRAME - DARK GREY
AL-1	PREFINISHED ALUMINUM FRAMES
PM-1	PREFINISHED METAL - BLACK
FW	FOUNDATION WALL - CONCRETE
PTW	PRESSURE TREATED WOOD
BE	BIKE ENCLOSURE

NOTE: REFER TO EXTERIOR FINISH MATERIAL LIST FOR ADDITIONAL INFORMATION & FINISH TYPES.

E DR 1
C DP RESUBMISSION
A DP RESUBMISSION

2026-04-20

2026-03-16

Project
Project Number: 25059
HOMESPACE SOCIETY
EVERSYDE AFFORDABLE
HOUSING
2525 Eversyde Ave SW, Calgary AB
Legal Description
Lot 55, Blk 1, 041 2677
(Proposed Sub-Div.)
Development Permit No.
DP2026-00773
Building Permit No.
DSSP No.



Drawing Title
EXTERIOR ELEVATIONS - BLOCK 5

Scale
As indicated
Date (YYYY-MM-DD)

Tech Review:

Drawing Number

Drawing Package


Revision Number

DP40.05


E

NOTES:


- DIMENSION TO FACE OF STUD (INTERIOR PARTITIONS), CONCRETE, CONCRETE BLOCK, EXTERIOR WALL SHEATHING - UNLESS NOTED OTHERWISE.
- NOTE WHEN REQUIRED MINIMUM CLEAR DIMENSIONS WILL BE IDENTIFIED.
- VERIFY ALL DIMENSIONS, ELEVATIONS, AND DATUMS, REPORT ANY ERRORS AND/OR DISCREPANCIES TO THE ARCHITECT PRIOR TO CONSTRUCTION.
- DO NOT SCALE DRAWINGS.
- THIS DRAWING SUPERCEDES PREVIOUS ISSUES.

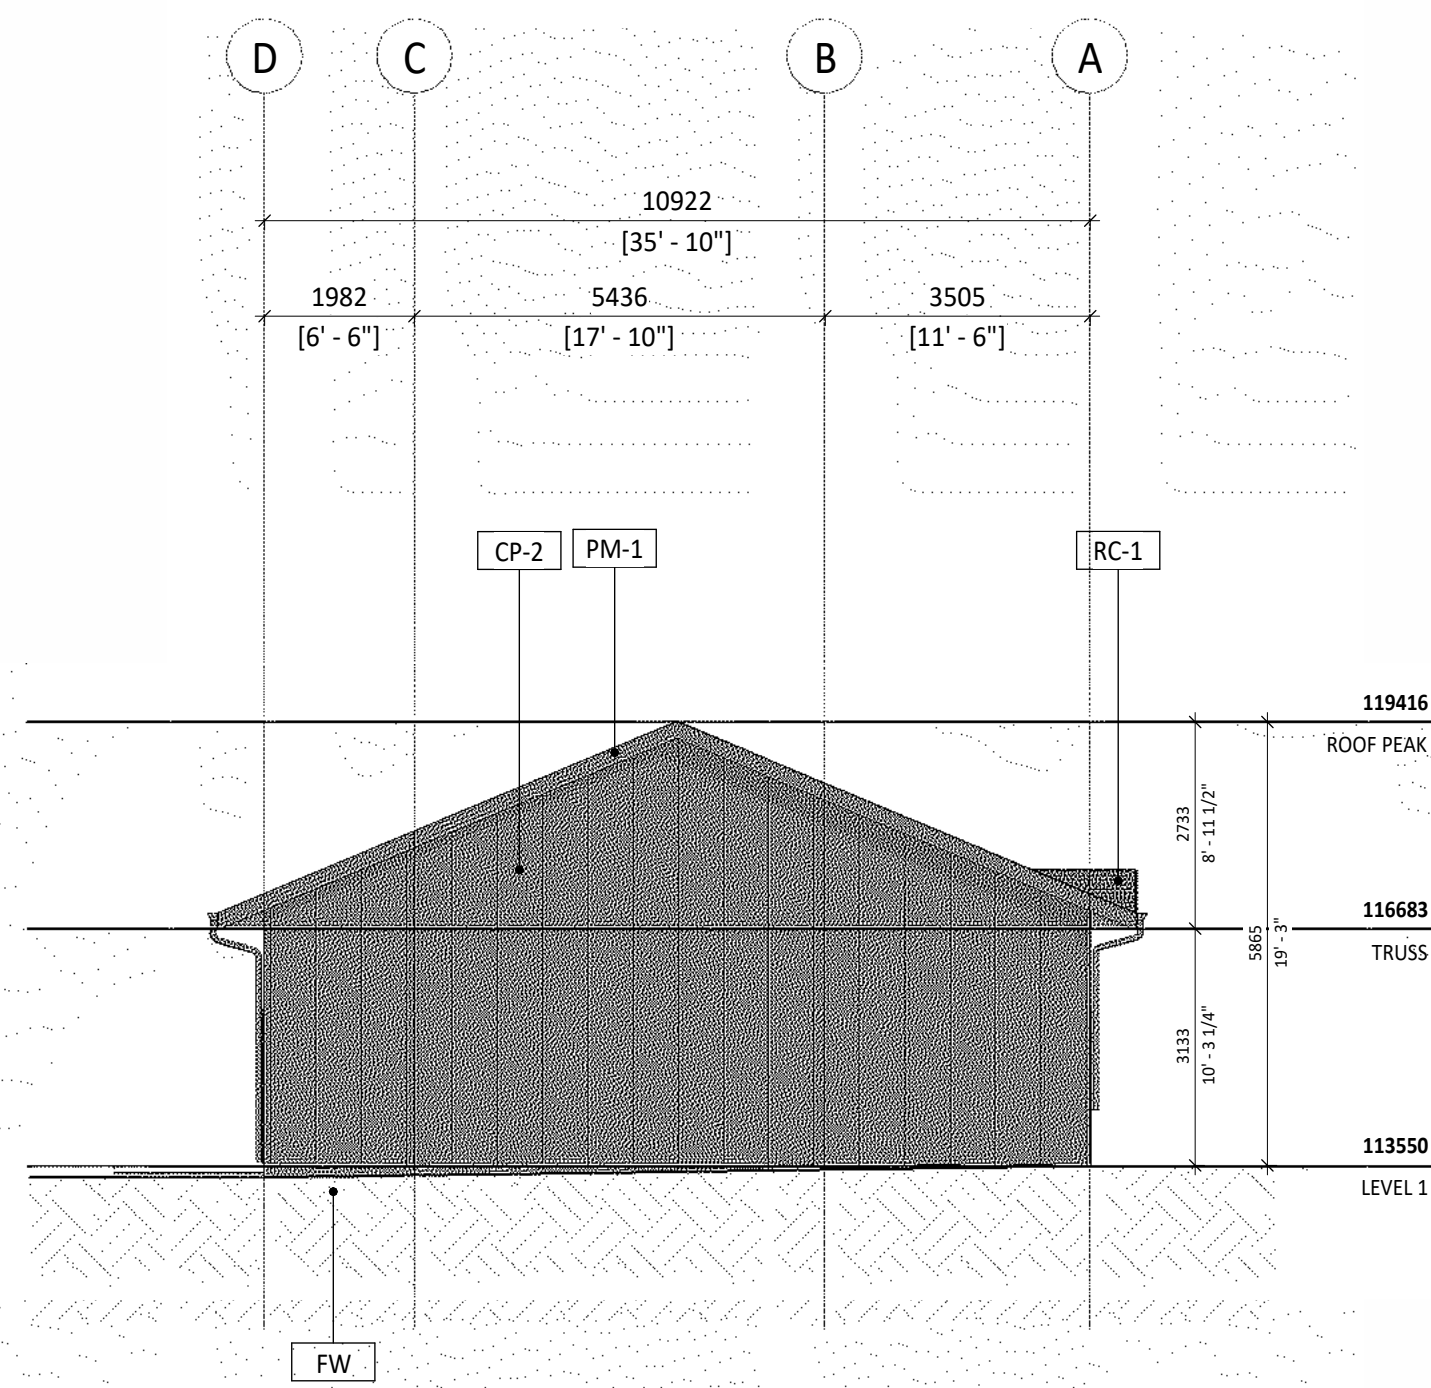


1 BLOCK 6 - NORTH ELEVATION
1 : 100

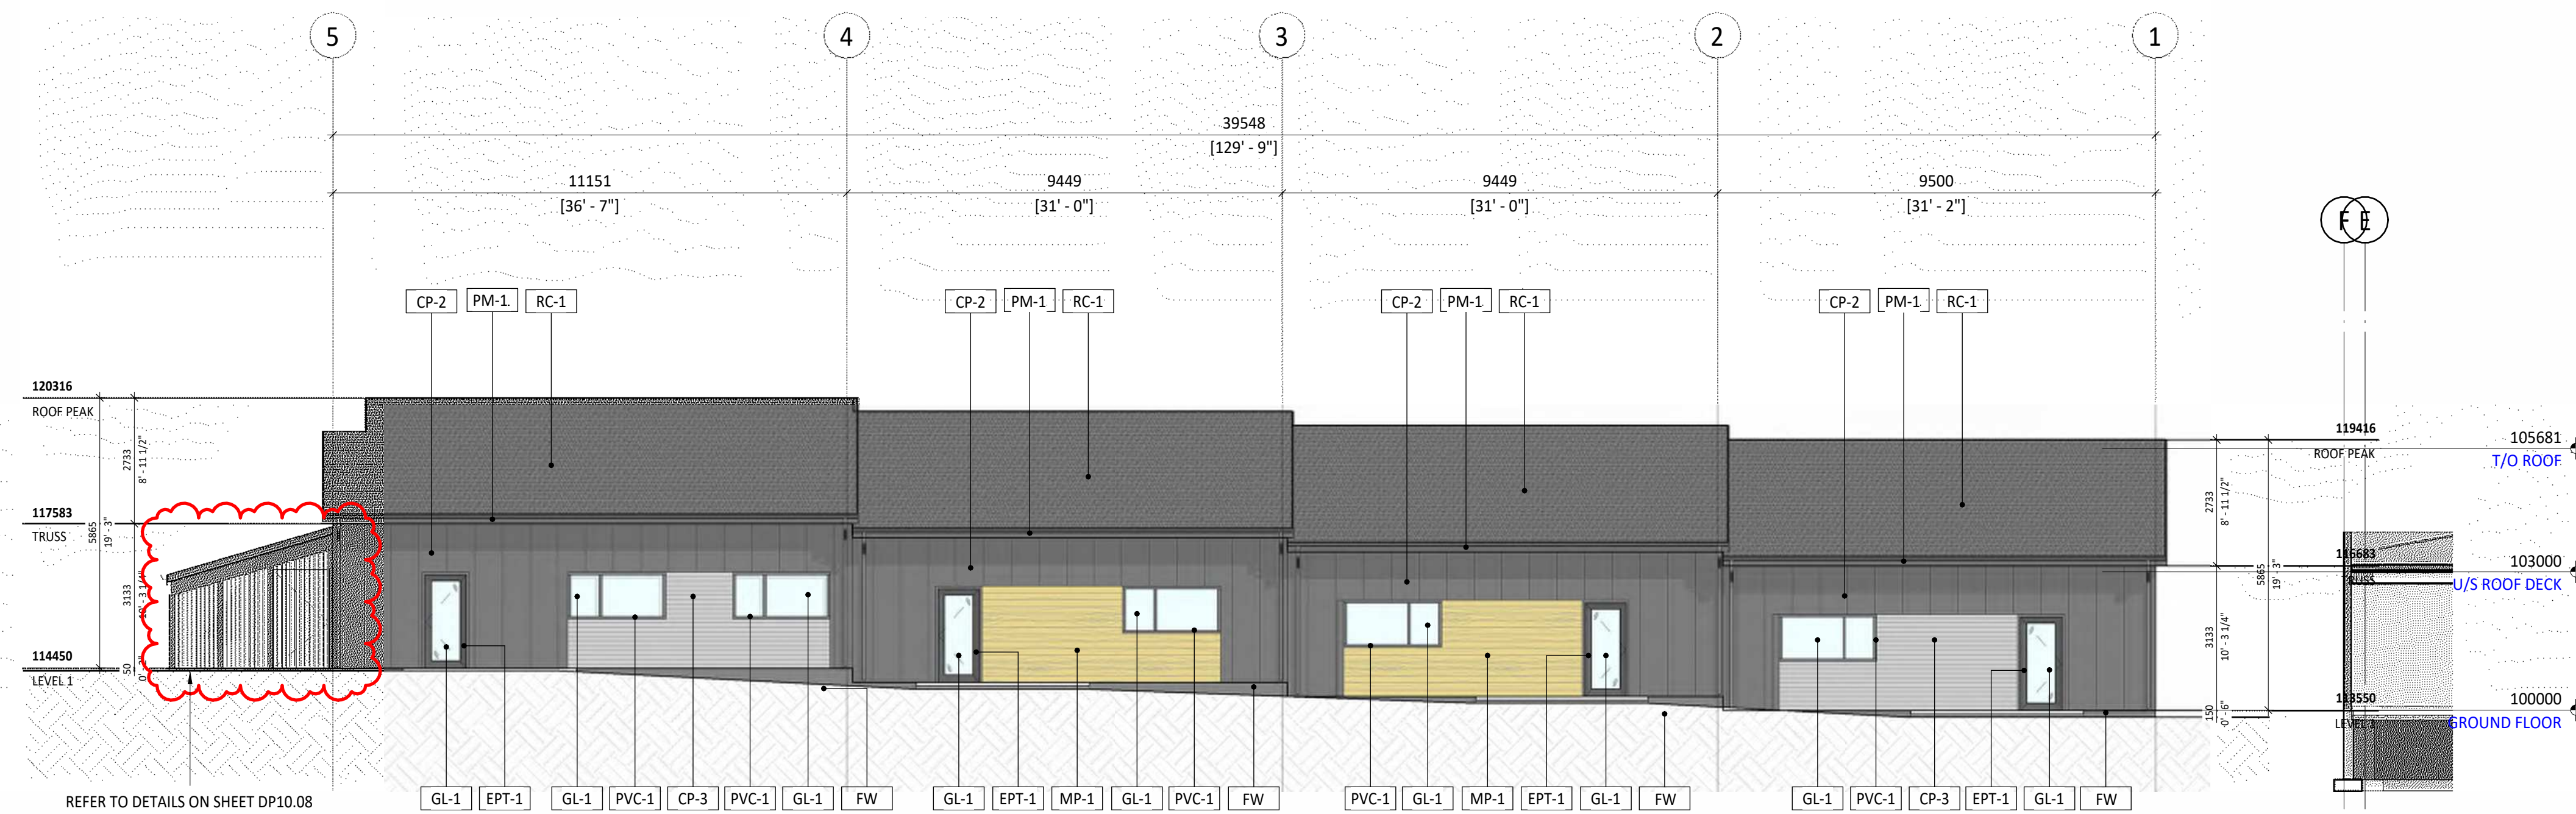

2 BLOCK 6 - EAST ELEVATION
1 : 100

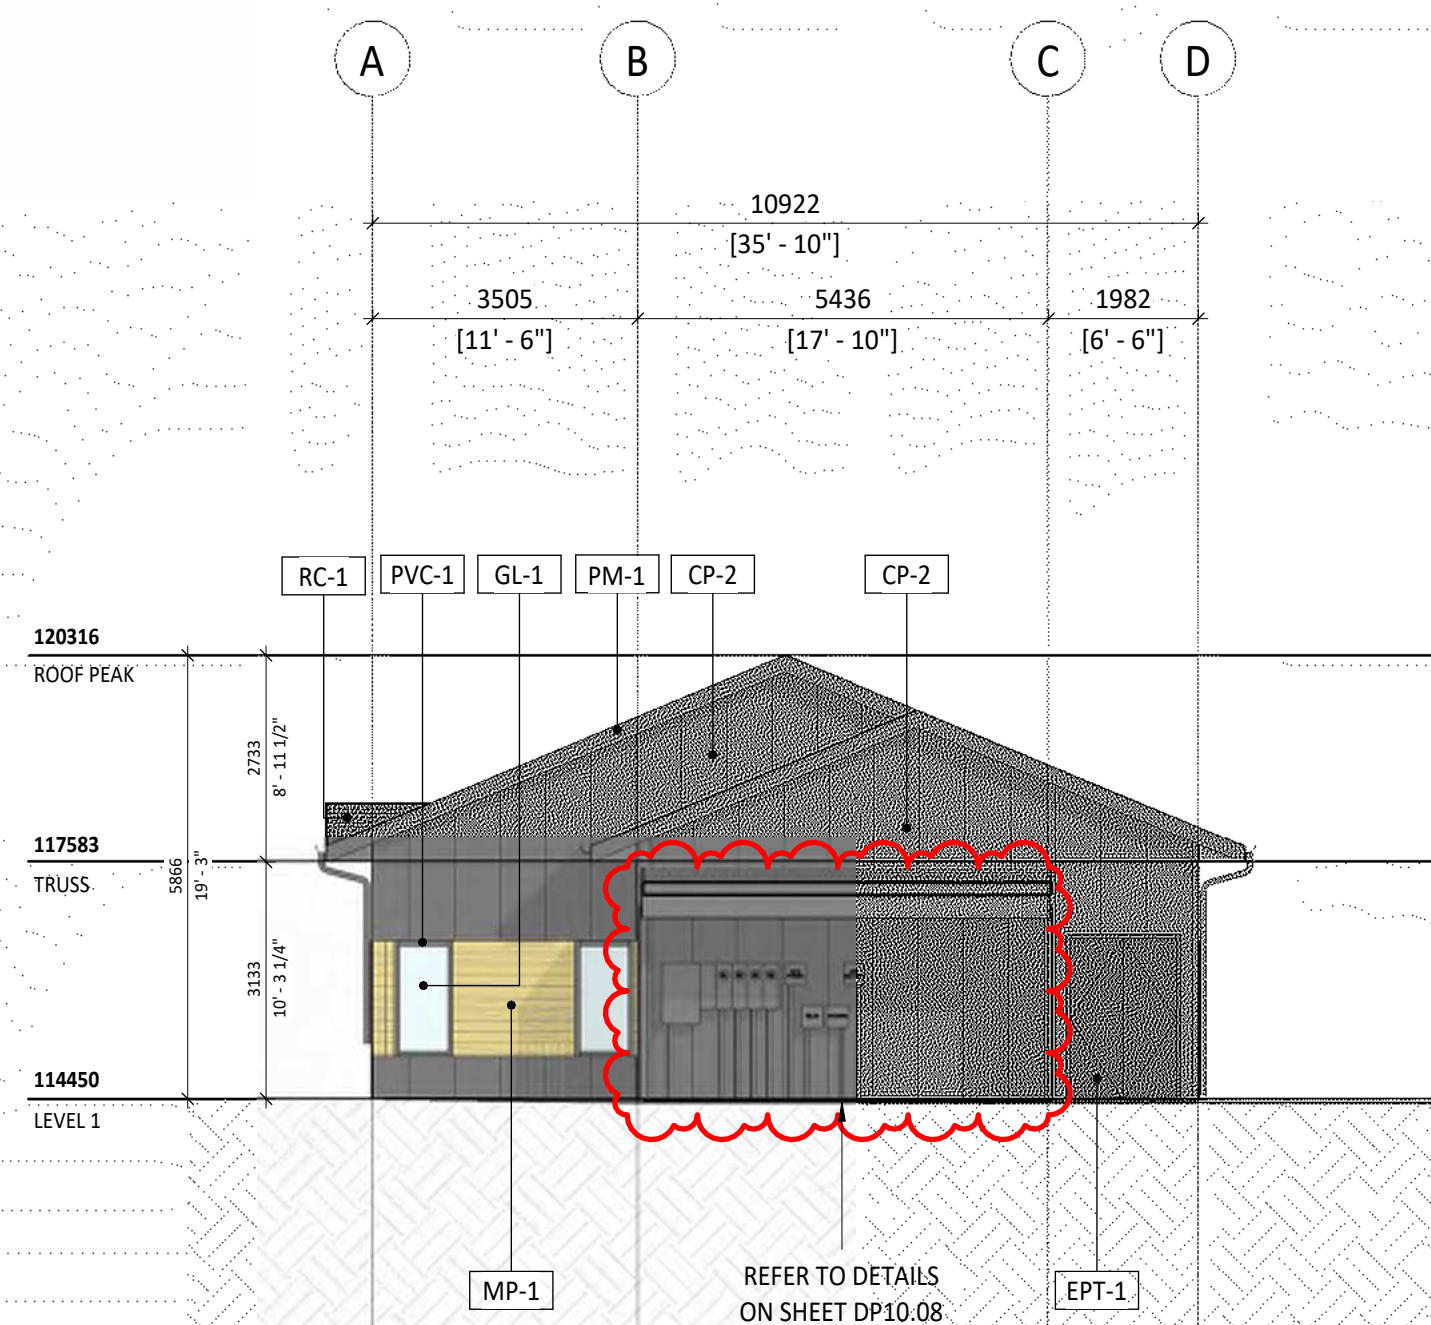

3 BLOCK 6 - SOUTH ELEVATION
1 : 100

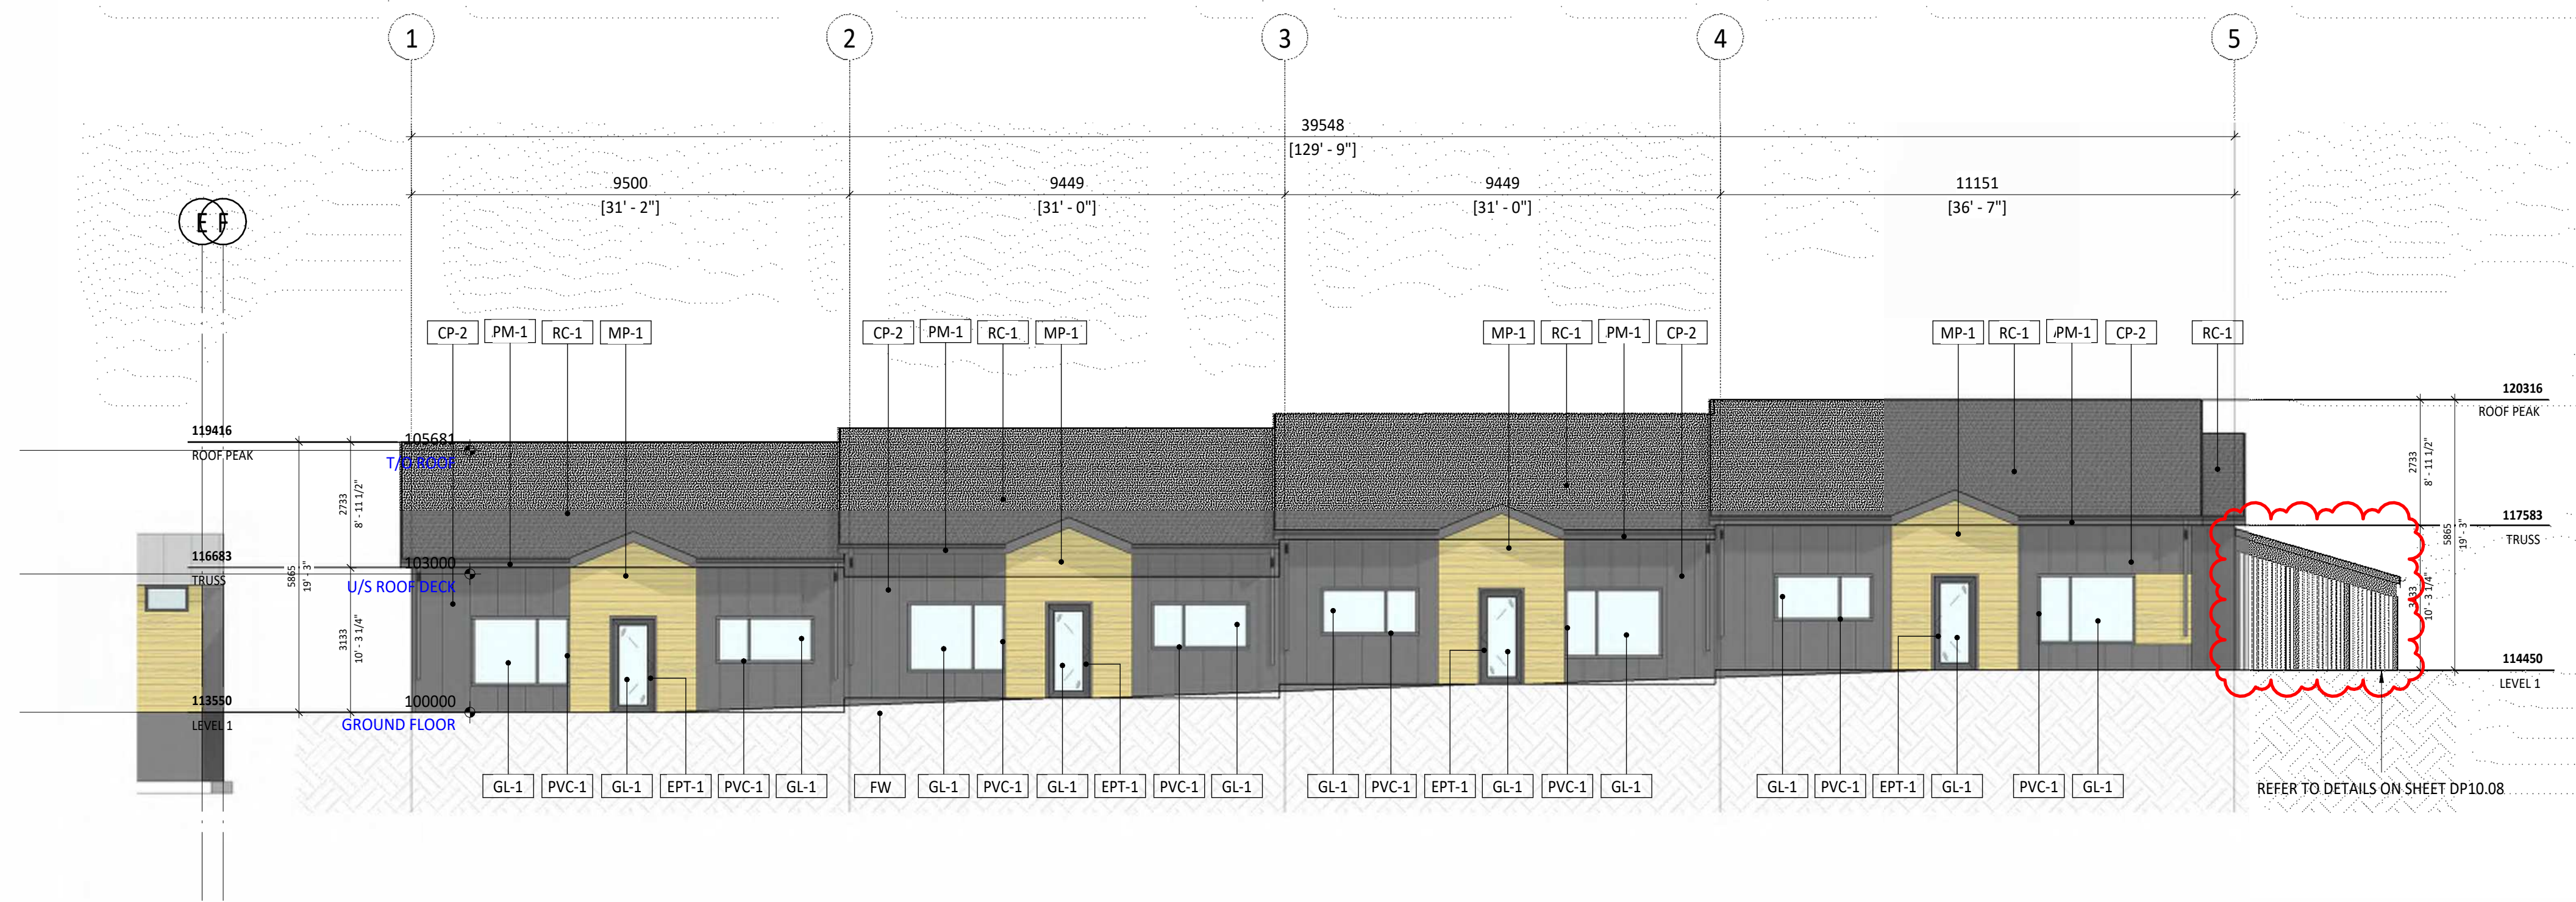

4 BLOCK 6 - WEST ELEVATION
1 : 100

MATERIAL LEGEND

CP-1	CEMENTITIOUS BOARD & BATTEN PANEL - LIGHT GREY
CP-2	CEMENTITIOUS BOARD & BATTEN PANEL - DARK GREY
CP-3	CEMENTITIOUS LAP SIDING - LIGHT GREY
CP-4	CEMENTITIOUS LAP SIDING - DARK GREY
CP-5	CEMENTITIOUS FLAT PANEL - DARK GREY
MP-1	METAL PANEL - WOOD GRAIN APPEARANCE
RC-1	ROOF CLADDING SHINGLES - BLACK
EPT-1	EXTERIOR PAINT - DARK GREY
EPT-2	EXTERIOR PAINT - LIGHT GREY
GL-1	GLASS
PVC-1	PVC FRAME - DARK GREY
AL-1	PREFINISHED ALUMINUM FRAMES
PM-1	PREFINISHED METAL - BLACK
FW	FOUNDATION WALL - CONCRETE
PTW	PRESSURE TREATED WOOD
BE	BIKE ENCLOSURE

NOTE: REFER TO EXTERIOR FINISH MATERIAL LIST FOR ADDITIONAL INFORMATION & FINISH TYPES.

E DR 1
C DP RESUBMISSION
A DP RESUBMISSION

2026-04-20
2026-03-16

Project
Project Number: 25059
HOMESPACE SOCIETY
EVERSYDE AFFORDABLE
HOUSING
2525 Eversyde Ave SW, Calgary AB
Legal Description
Lot 55, Blk 1, 041 2677
(Proposed Sub-Div.)
Development Permit No.
DP2026-00773

Building Permit No.
DSSP No.

GGA-ARCHITECTURE

Drawing Title
EXTERIOR ELEVATIONS - BLOCK 6

Scale
As indicated
Date (YYYY-MM-DD)

Tech Review:

Drawing Number
DP40.06

Drawing Package
Revision Number
E


PRELIMINARY - NOT FOR CONSTRUCTION

NOTES:
• DIMENSION TO FACE OF STUD (INTERIOR PARTITIONS), CONCRETE, CONCRETE BLOCK, EXTERIOR WALL SHEATHING - UNLESS NOTED OTHERWISE.
• NOTE WHEN REQUIRED MINIMUM CLEAR DIMENSIONS WILL BE IDENTIFIED.
• VERIFY ALL DIMENSIONS, ELEVATIONS, AND DATUMS, REPORT ANY ERRORS AND/OR DISCREPANCIES TO THE ARCHITECT PRIOR TO CONSTRUCTION.
• DO NOT SCALE DRAWINGS.
• THIS DRAWING SUPERCEDES PREVIOUS ISSUES.

MATERIAL LEGEND

CP-1	CEMENTITIOUS BOARD & BATTEN PANEL - LIGHT GREY
CP-2	CEMENTITIOUS BOARD & BATTEN PANEL - DARK GREY
CP-3	CEMENTITIOUS LAP SIDING - LIGHT GREY
CP-4	CEMENTITIOUS LAP SIDING - DARK GREY
CP-5	CEMENTITIOUS FLAT PANEL - DARK GREY
MP-1	METAL PANEL - WOOD GRAIN APPEARANCE
RC-1	ROOF CLADDING SHINGLES - BLACK
EPT-1	EXTERIOR PAINT - DARK GREY
EPT-2	EXTERIOR PAINT - LIGHT GREY
GL-1	GLASS
PVC-1	PVC FRAME - DARK GREY
AL-1	PREFINISHED ALUMINUM FRAMES
PM-1	PREFINISHED METAL - BLACK
FW	FOUNDATION WALL - CONCRETE
PTW	PRESSURE TREATED WOOD
BE	BIKE ENCLOSURE


NOTE: REFER TO EXTERIOR FINISH MATERIAL LIST FOR ADDITIONAL INFORMATION & FINISH TYPES.

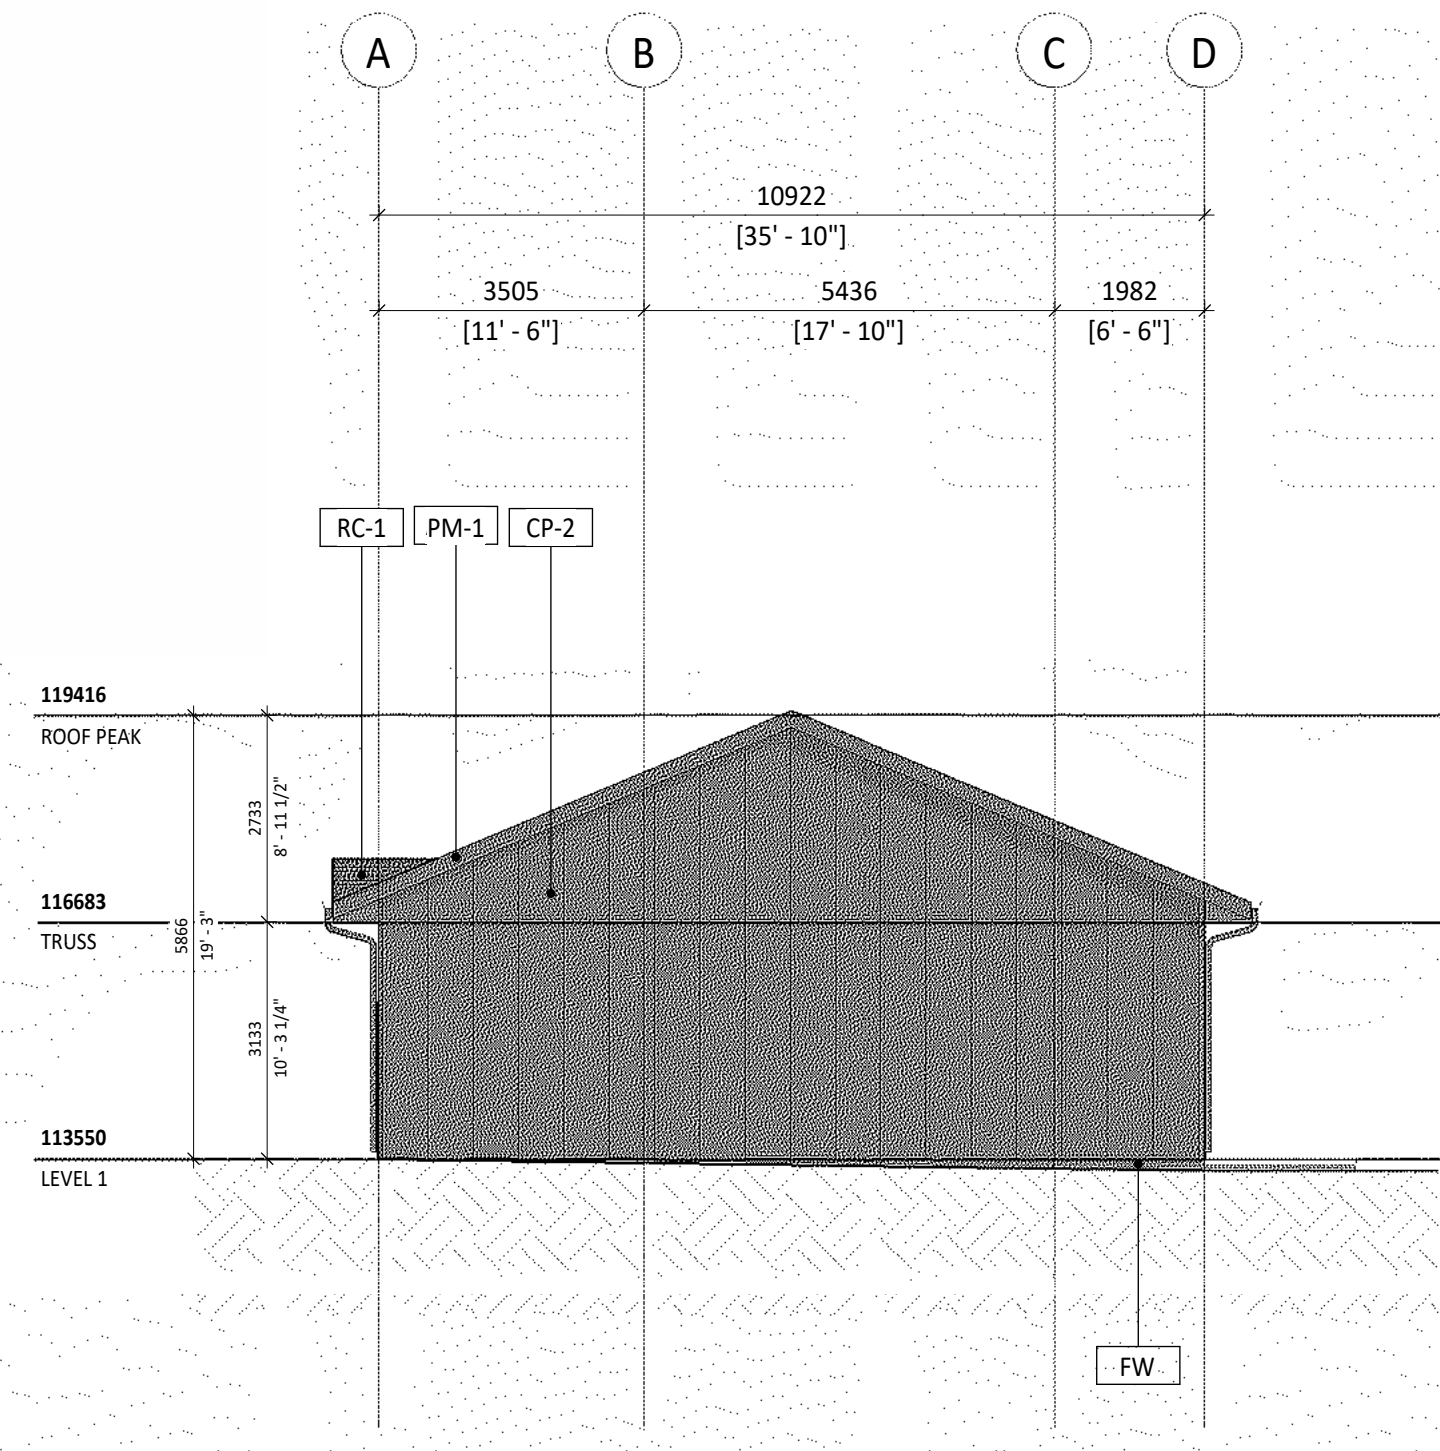


1 BLOCK 7 - NORTH ELEVATION
DP40.07 1:100



2 BLOCK 7 - EAST ELEVATION
DP40.07 1:100

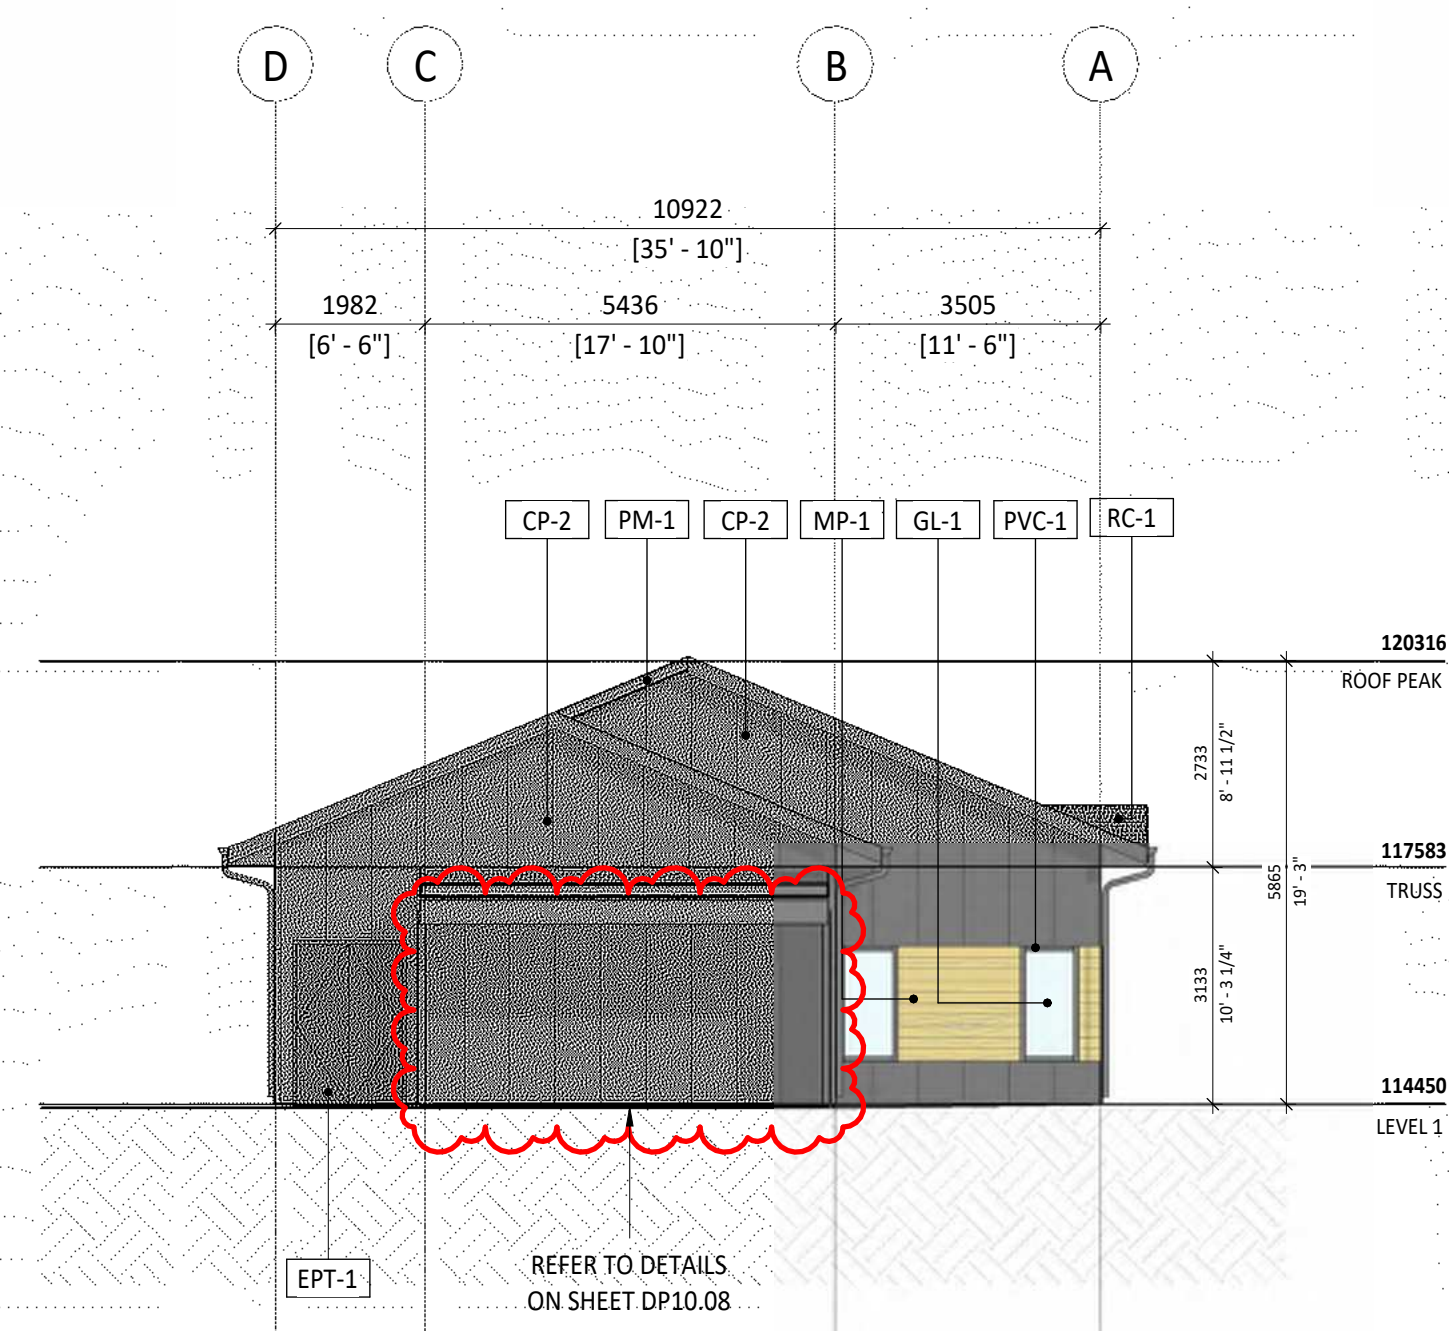

3 BLOCK 7 - SOUTH ELEVATION
DP40.07 1:100

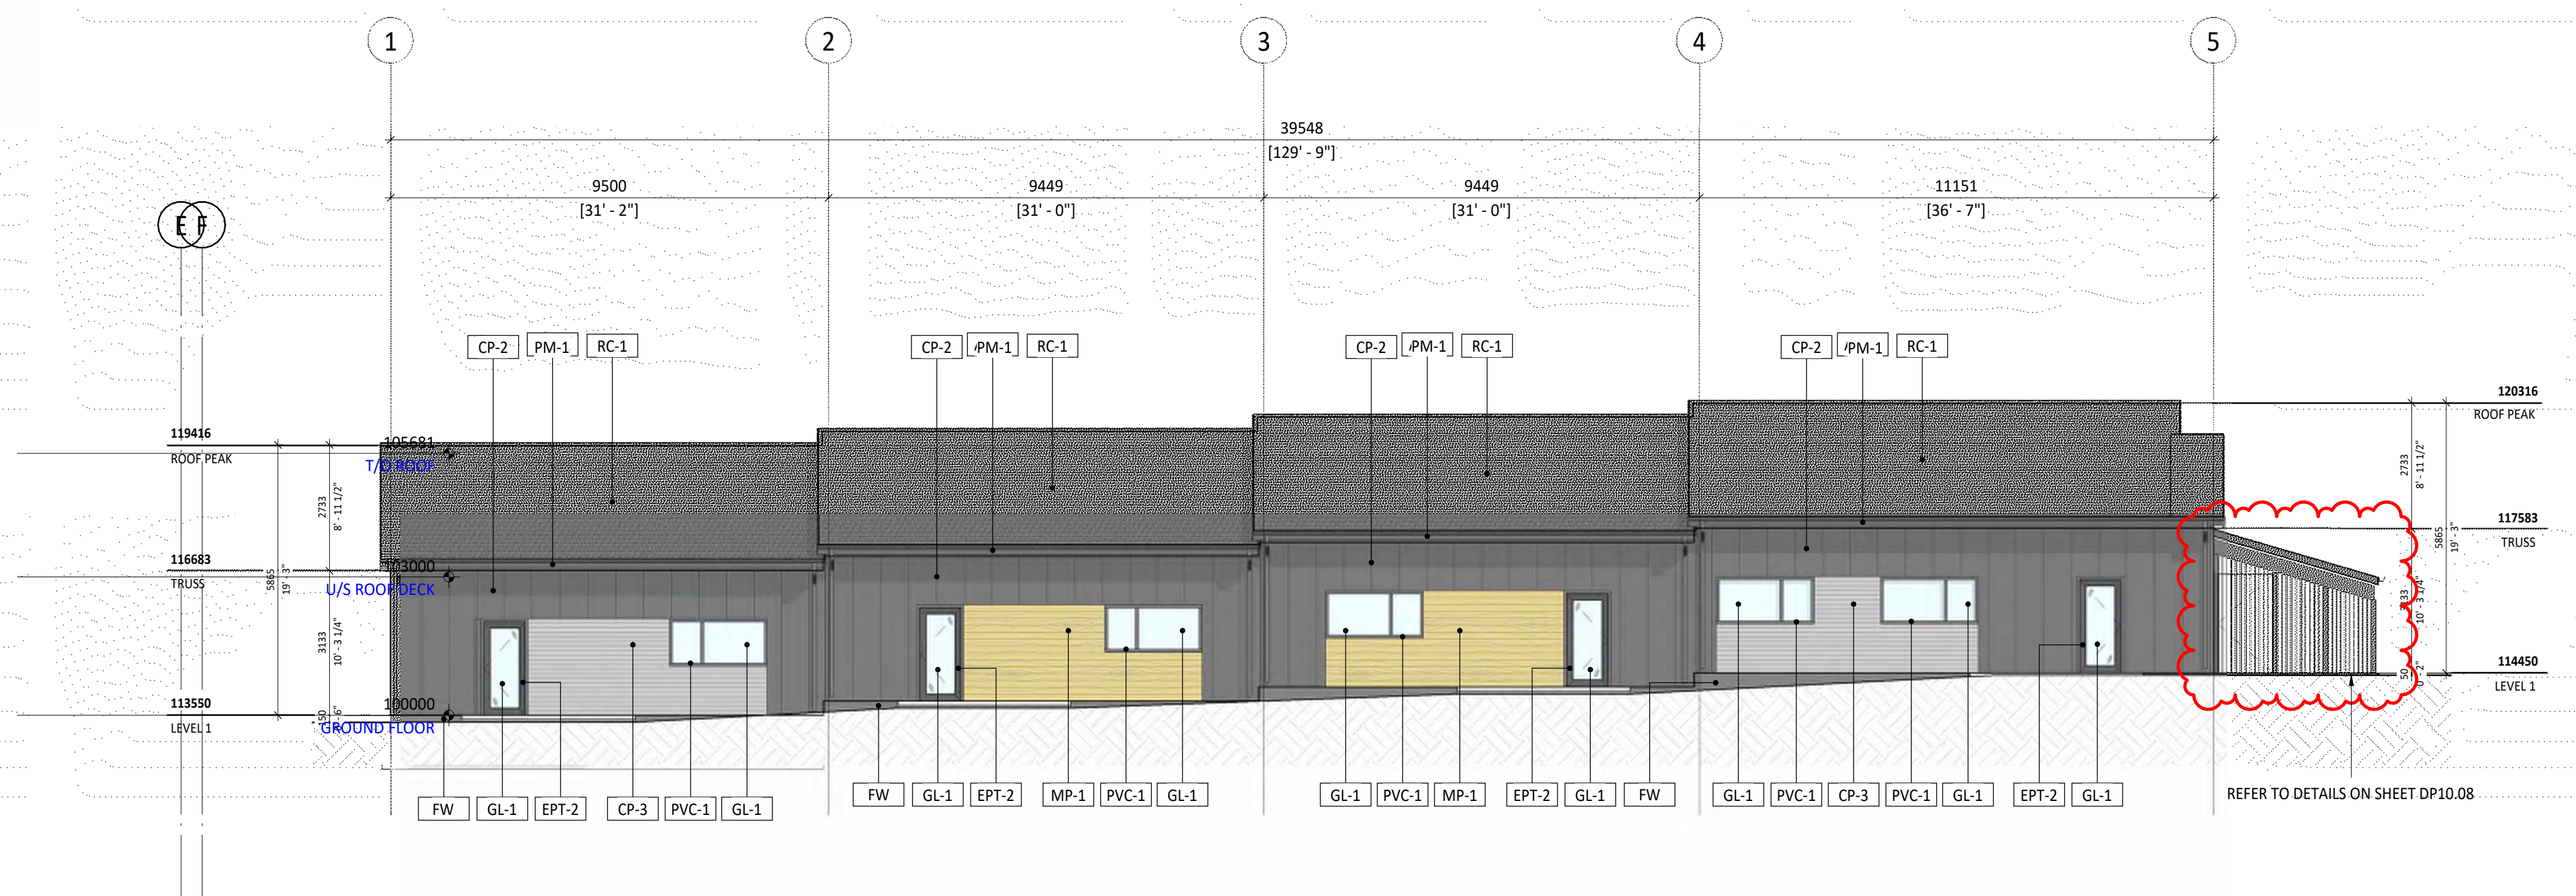

4 BLOCK 7 - WEST ELEVATION
DP40.07 1:100

E DR 1
C DP RESUBMISSION
A DP RESUBMISSION

2026-04-20
2026-03-16

Project
Project Number: 25059
HOMESPACE SOCIETY
EVERSYDE AFFORDABLE
HOUSING
2525 Eversyde Ave SW, Calgary AB
Legal Description
Lot 55, Blk 1, 041 2677
(Proposed Sub-Div.)
Development Permit No.
DP2026-00773
Building Permit No.
DSSP No.

GGA-ARCHITECTURE

Drawing Title
EXTERIOR ELEVATIONS - BLOCK 7

Scale
As indicated
Date (YYYY-MM-DD)

Tech Review:
Drawing Number
DP40.07
Revision Number
E


6/16/2026 4:39:49 PM

- NOTES:**
- DIMENSION TO FACE OF STUD (INTERIOR PARTITIONS), CONCRETE, CONCRETE BLOCK, EXTERIOR WALL SHEATHING - UNLESS NOTED OTHERWISE.
 - NOTE WHEN REQUIRED MINIMUM CLEAR DIMENSIONS WILL BE IDENTIFIED.
 - VERIFY ALL DIMENSIONS, ELEVATIONS, AND DATUMS, REPORT ANY ERRORS AND/OR DISCREPANCIES TO THE ARCHITECT PRIOR TO CONSTRUCTION.
 - DO NOT SCALE DRAWINGS.
 - THIS DRAWING SUPERCEDES PREVIOUS ISSUES.


MATERIAL LEGEND

CP-1	CEMENTITIOUS BOARD & BATTEN PANEL - LIGHT GREY
CP-2	CEMENTITIOUS BOARD & BATTEN PANEL - DARK GREY
CP-3	CEMENTITIOUS LAP SIDING - LIGHT GREY
CP-4	CEMENTITIOUS LAP SIDING - DARK GREY
CP-5	CEMENTITIOUS FLAT PANEL - DARK GREY
MP-1	METAL PANEL - WOOD GRAIN APPEARANCE
RC-1	ROOF CLADDING SHINGLES - BLACK
EPT-1	EXTERIOR PAINT - DARK GREY
EPT-2	EXTERIOR PAINT - LIGHT GREY
GL-1	GLASS
PVC-1	PVC FRAME - DARK GREY
AL-1	PREFINISHED ALUMINUM FRAMES
PM-1	PREFINISHED METAL - BLACK
FW	FOUNDATION WALL - CONCRETE
PTW	PRESSURE TREATED WOOD
BE	BIKE ENCLOSURE


NOTE: REFER TO EXTERIOR FINISH MATERIAL LIST FOR ADDITIONAL INFORMATION & FINISH TYPES.

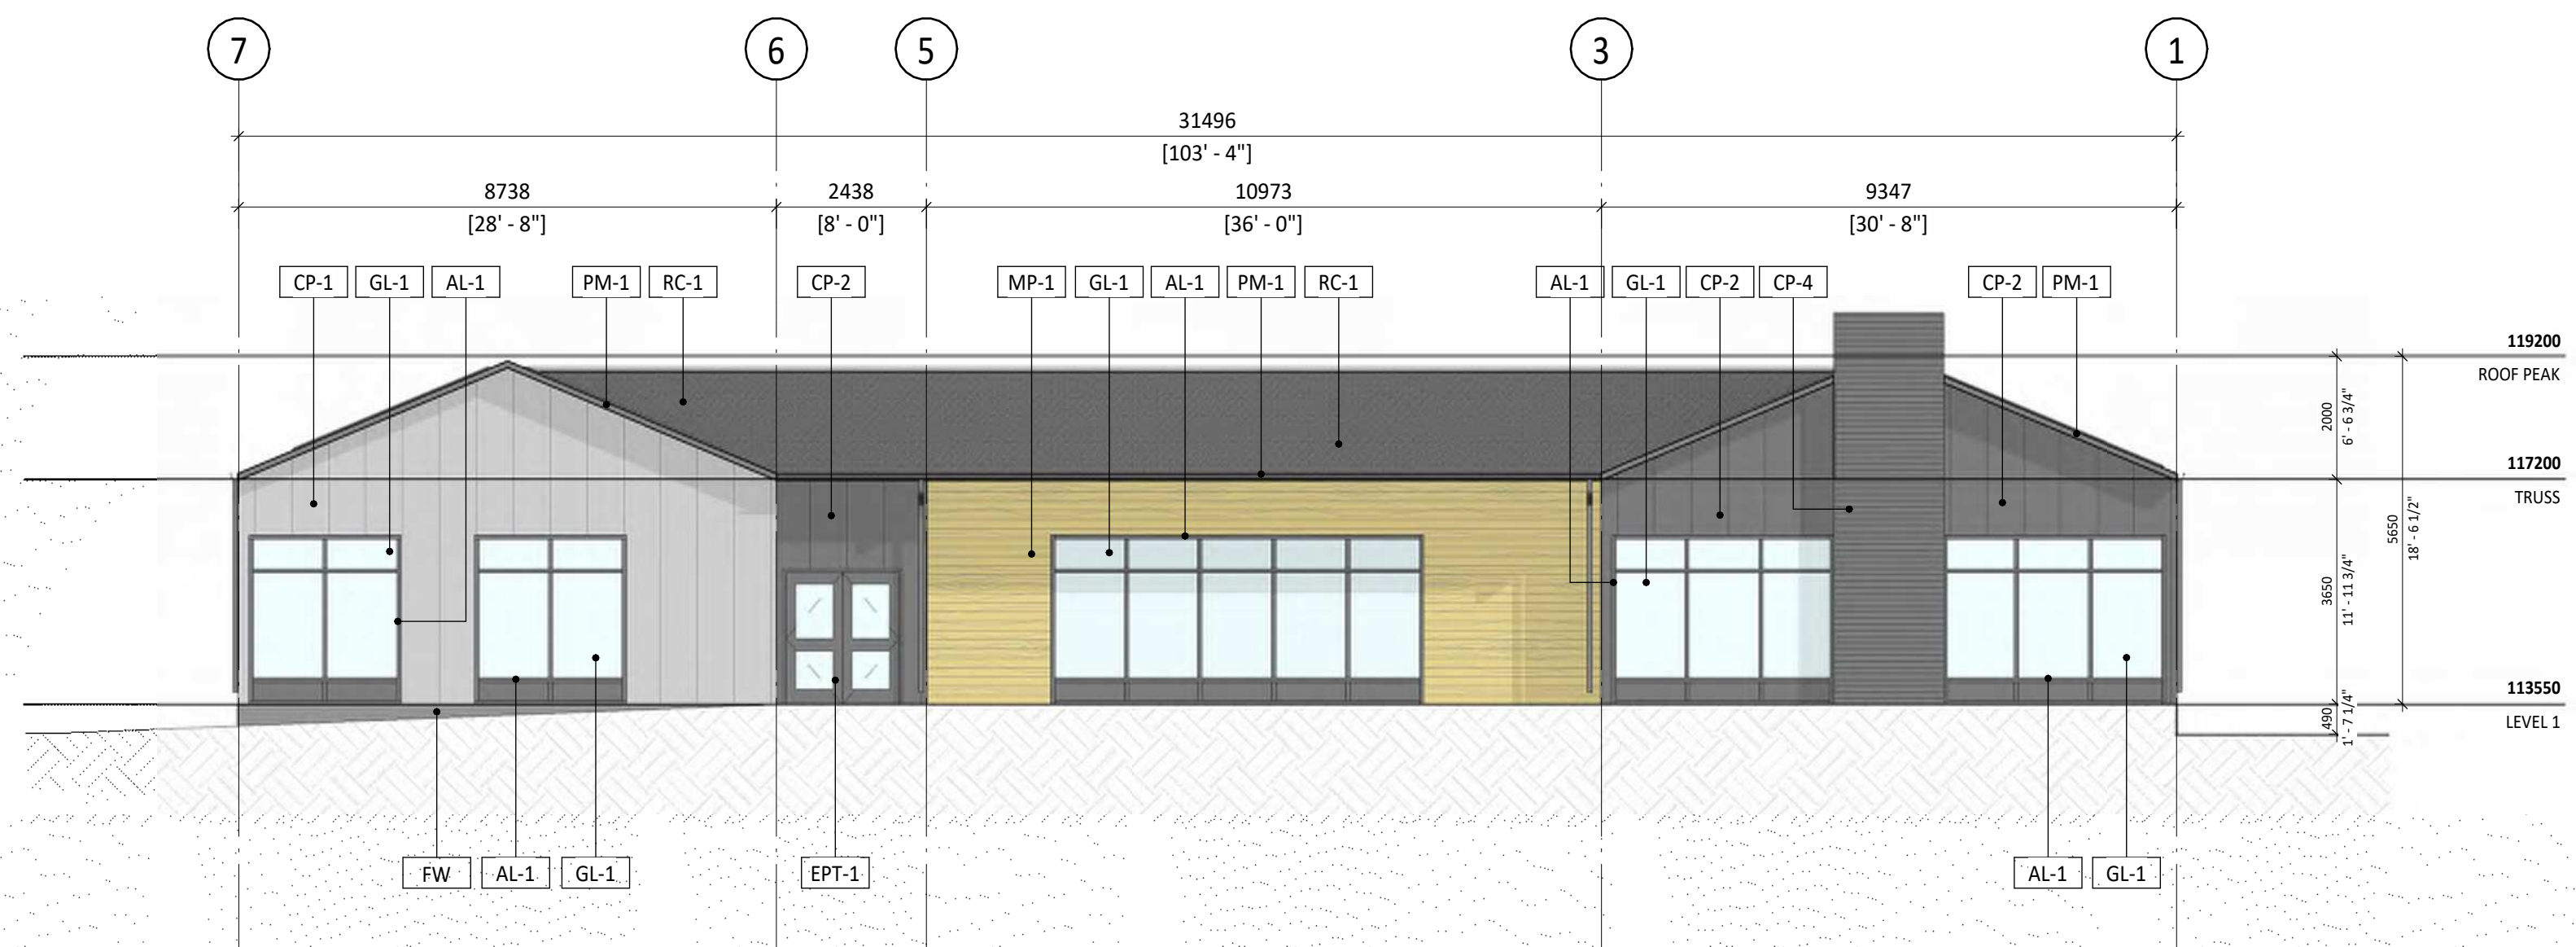


1 AMENITY - NORTH ELEVATION
DP40.08 1:100

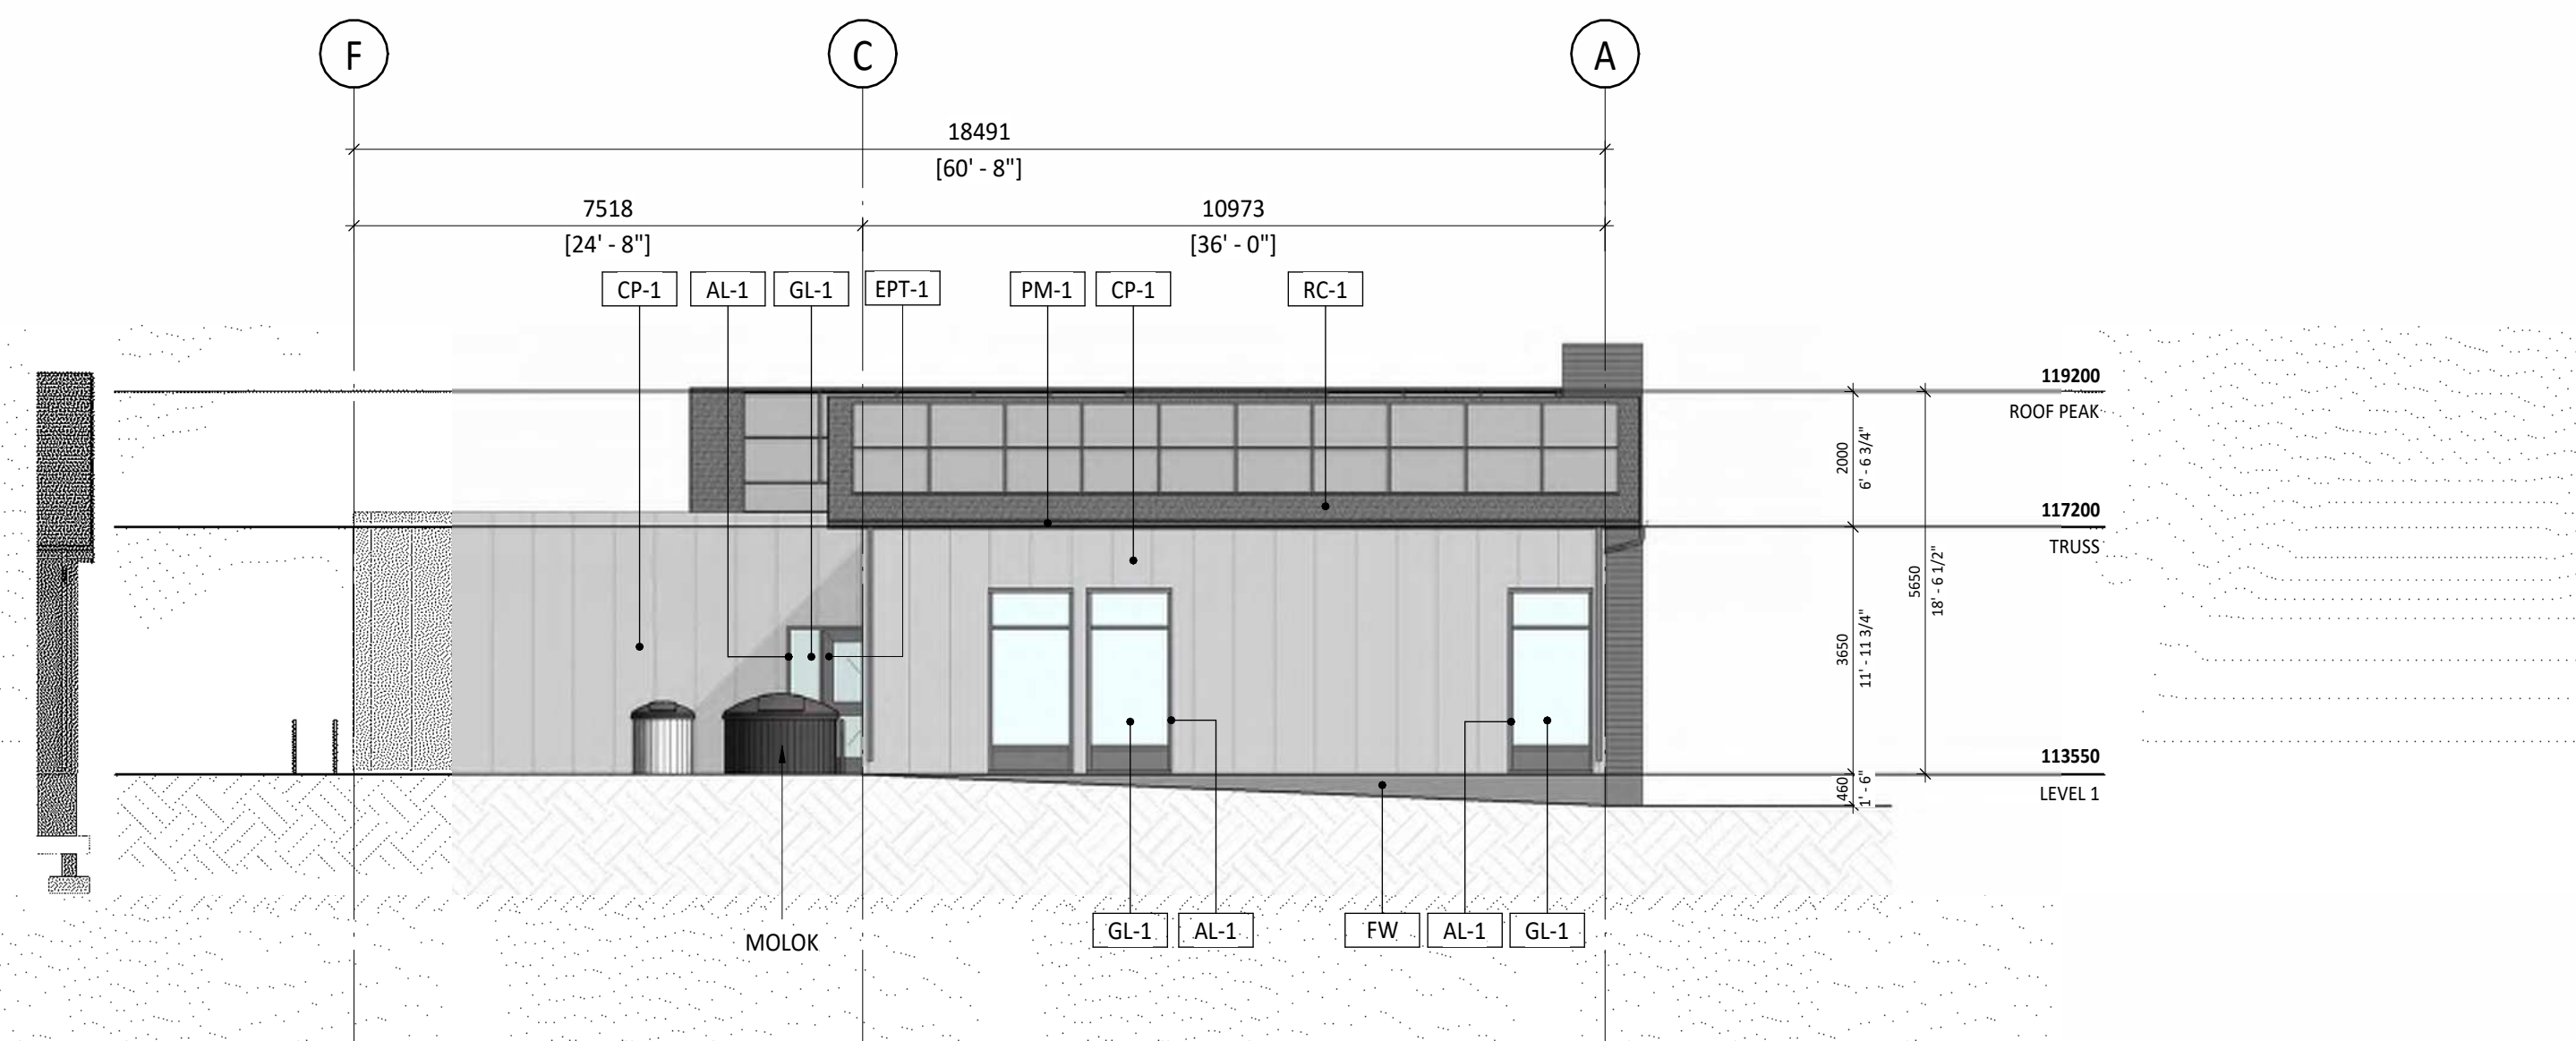

2 AMENITY - EAST ELEVATION
DP40.08 1:100

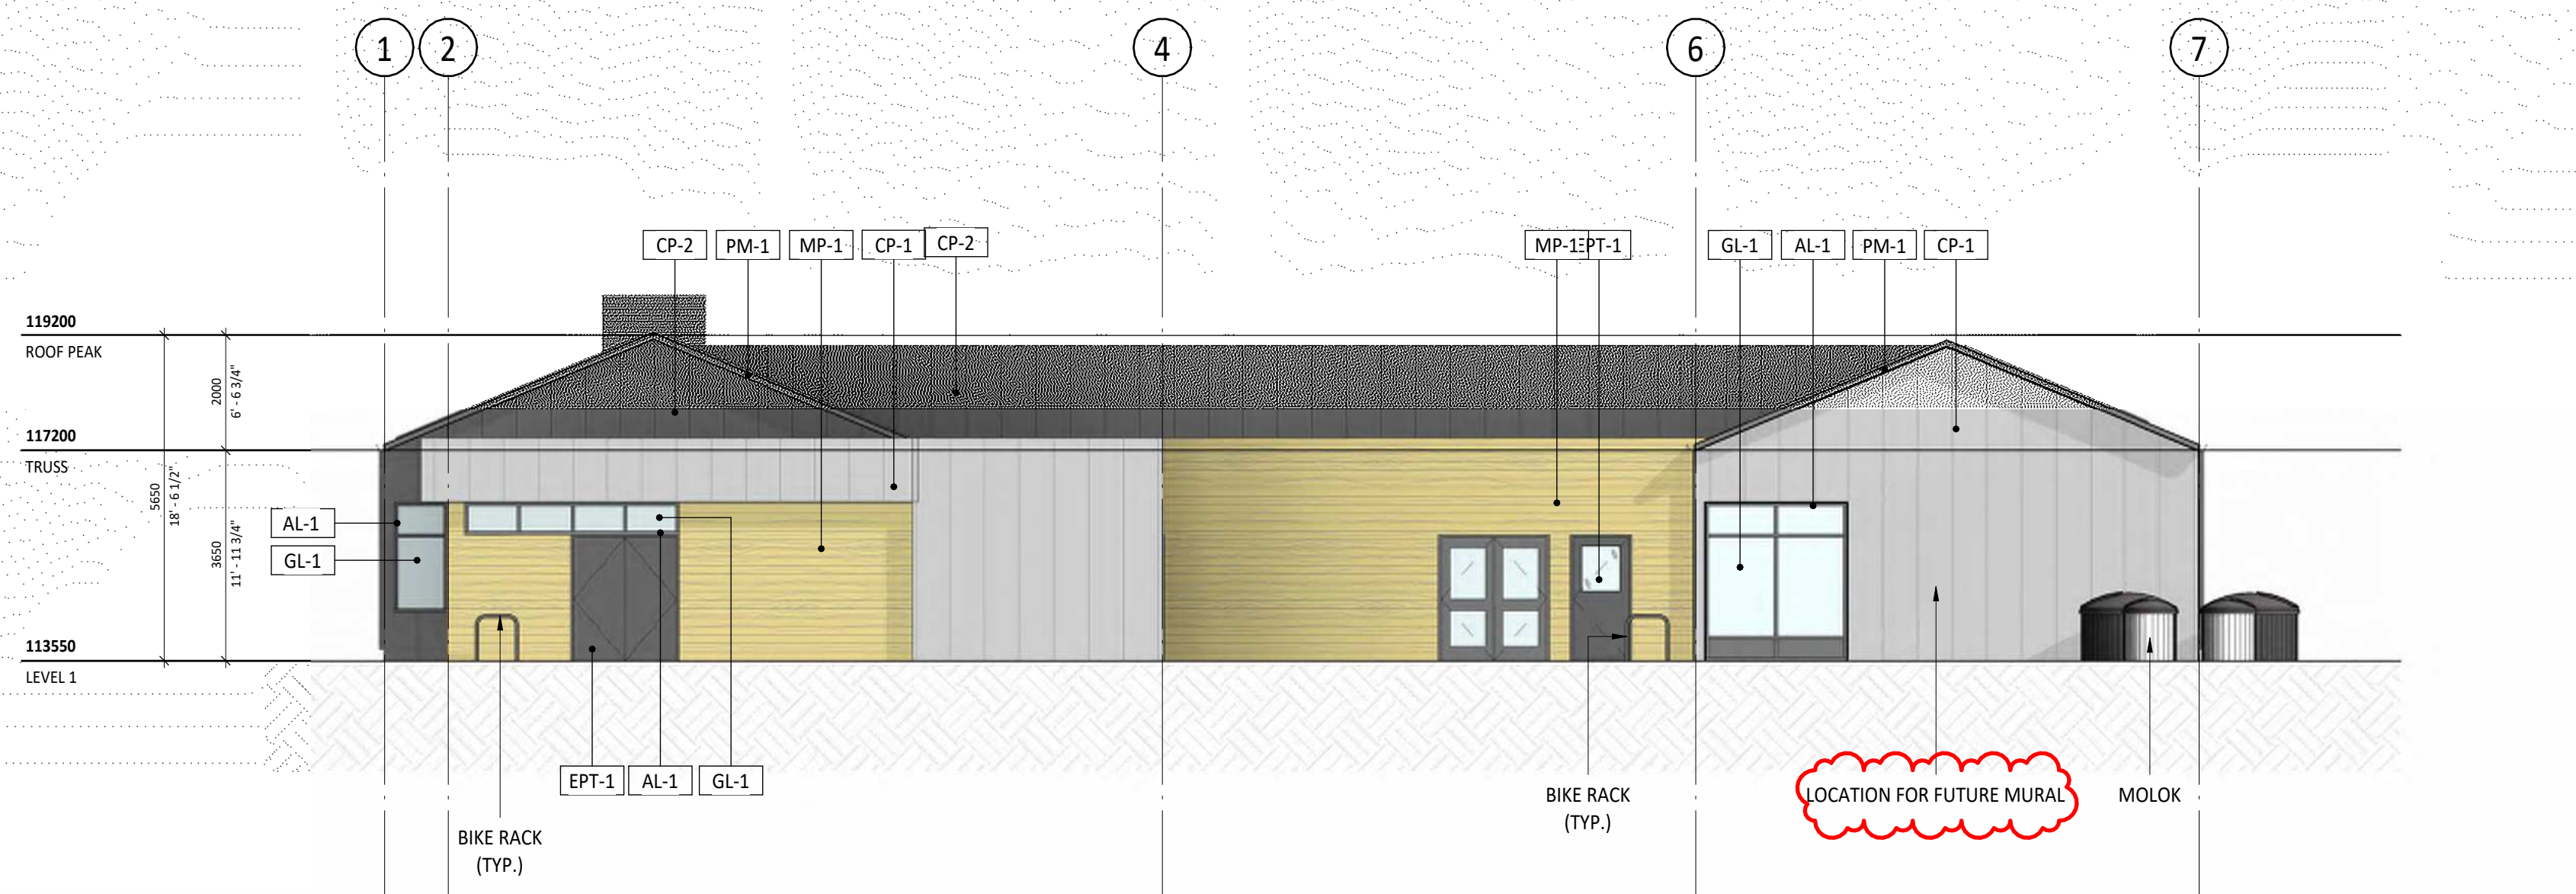

3 AMENITY - SOUTH ELEVATION
DP40.08 1:100

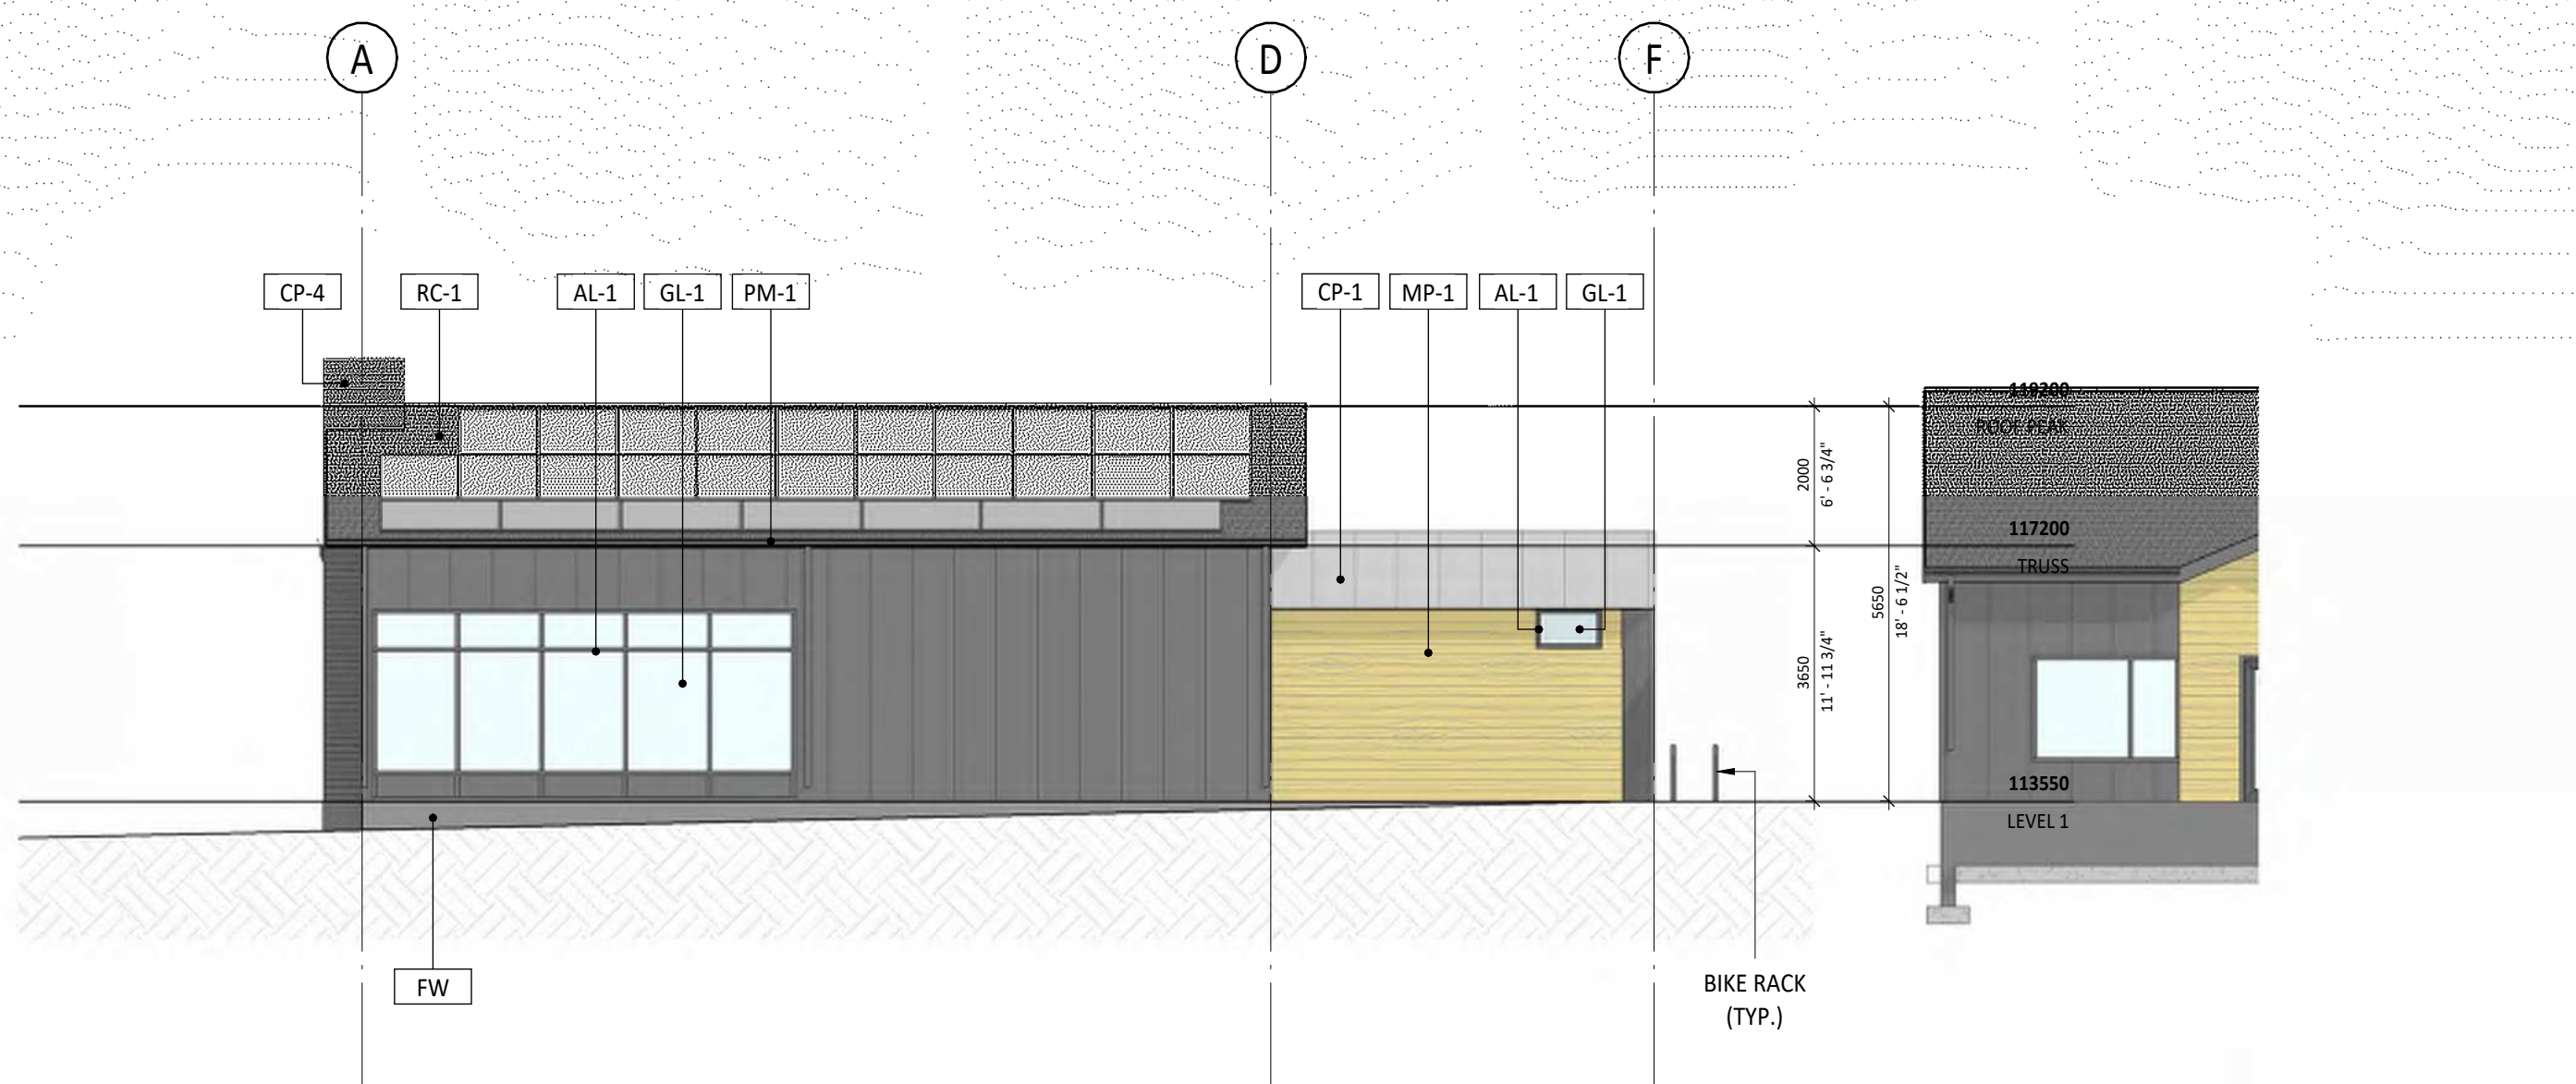

4 AMENITY - WEST ELEVATION
DP40.08 1:100

E DR 1
C DP RESUBMISSION
A DP RESUBMISSION

2026-04-20
2026-03-16

Project
Project Number: 25059
**HOMESPACE SOCIETY
EVERSYDE AFFORDABLE
HOUSING**
2525 Eversyde Ave SW, Calgary AB
Legal Description
Lot 55, Blk 1, 041 2677
(Proposed Sub-Div.)
Development Permit No.
DP2026-00773
Building Permit No.
DSSP No.



Drawing Title
**EXTERIOR ELEVATIONS -
AMENITY BUILDING**

Scale
As indicated
Date (YYYY-MM-DD)

Tech Review:

Drawing Number

Revision Number

DP40.08

E