



LEGEND

SAN	---
STORM	---
GAS	---
WATER	---
ELECT.	---
ACT	---
CABLE	---
GOAL POST	□
BASEBALL BACKSTOP	▽

NOTE
 DRAWING DATA BASE ORIGINATES FROM CITY OF CALGARY-JUCC PLANS.
 ITEMS AVAILABLE BUT ARE FROZEN: CONTOUR LINES, SPOT ELEVATIONS, TREES, RESIDENTIAL HOUSES, ETC.

NO.	REVISIONS	DATE

LEGAL DESCRIPTION:
 BLOCK: 12
 PLAN: 6455 OS

MUNICIPAL ADDRESS:
 226 NORTHMOUNT DR NW




Calgary Board of Education
 DESIGN AND CONSTRUCTION SERVICES DEPT.

PROJECT
 COLONEL SANDERS
 ELEMENTARY

DETAIL
 SITE PLAN

SCALE 1 : 1000	DRWN JMB	PROJ. NO.
DATE JUL/98	CHK'D.	FILE NO. 23

DRAWING NO.
 1 / OF 1

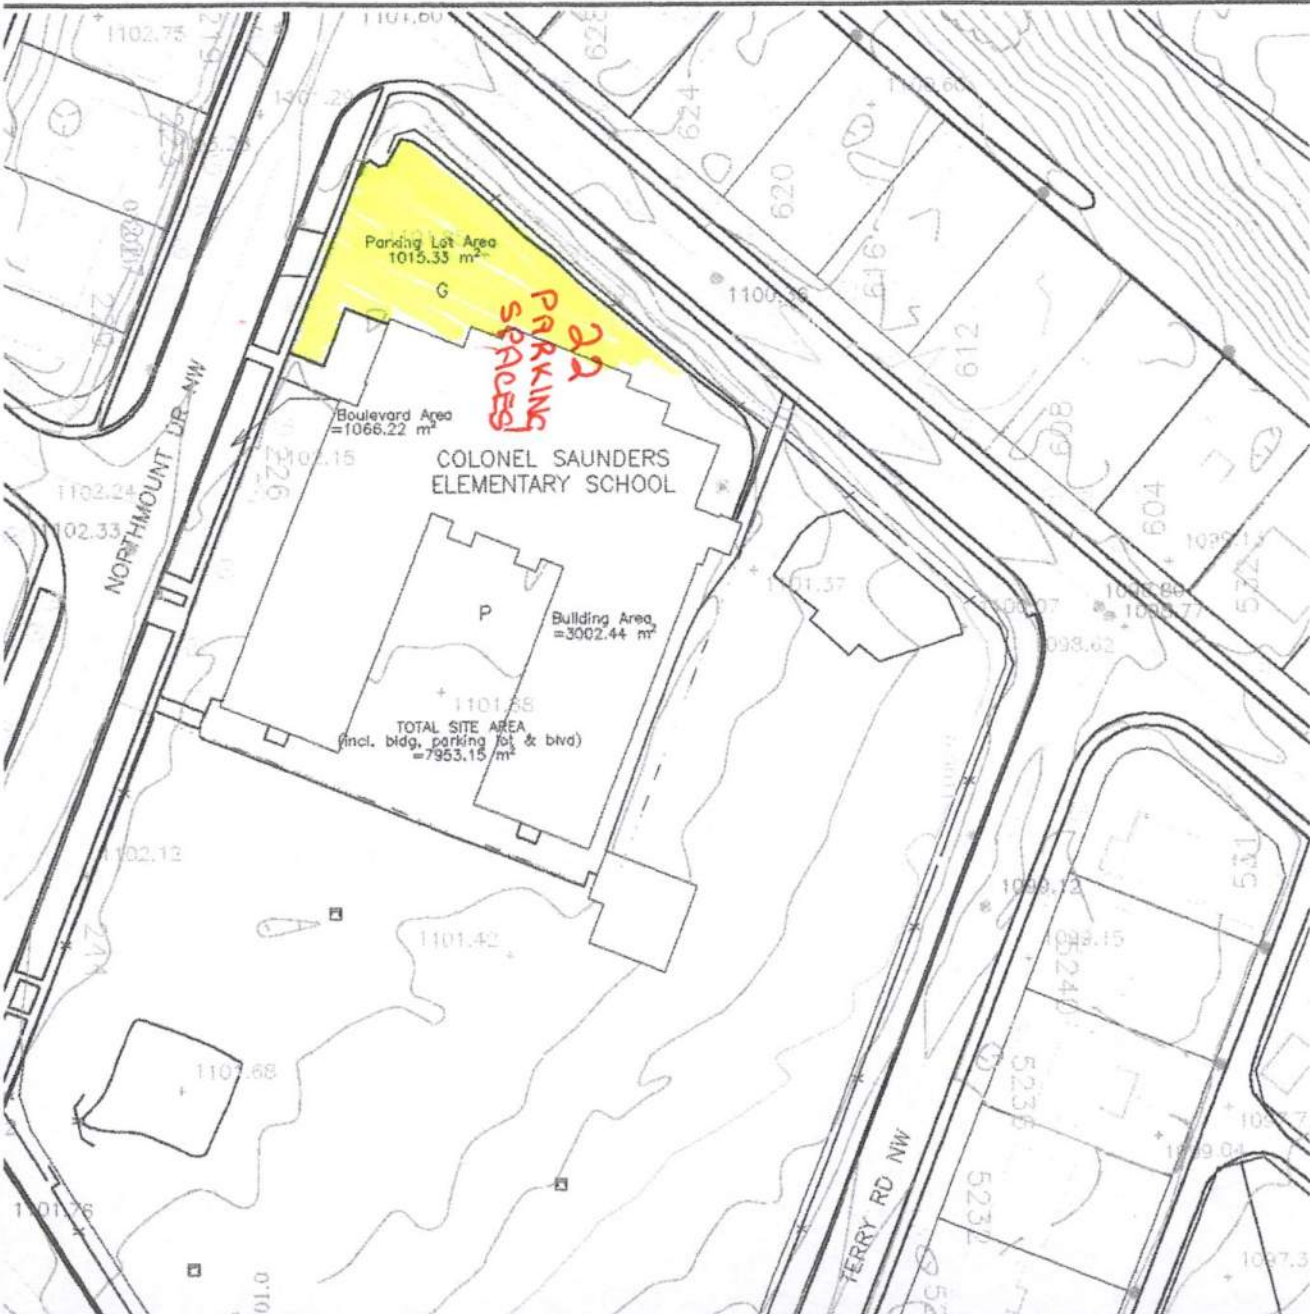

LEGEND

- SAH.
- STORM
- GAS
- WATER
- ELECT.
- AGT
- CABLE
- GOAL POST
- BASEBALL BACKSTOP

NOTE

DRAWING DATA BASE ORIGINATES FROM CITY OF CALGARY-JUCC PLANS.
 ITEMS AVAILABLE BUT ARE FROZEN:
 CONTOUR LINES, SPOT ELEVATIONS,
 TREES, RESIDENTIAL HOUSES, ETC.

NO.	REVISIONS	DATE

LEGAL DESCRIPTION:
 BLOCK: 12
 PLAN: 6455 GS

MUNICIPAL ADDRESS:
 226 NORTHMOUNT DR NW



Calgary Board of Education
 DESIGN AND CONSTRUCTION SERVICES DEPT.

PROJECT
 COLONEL SANDERS
 ELEMENTARY