


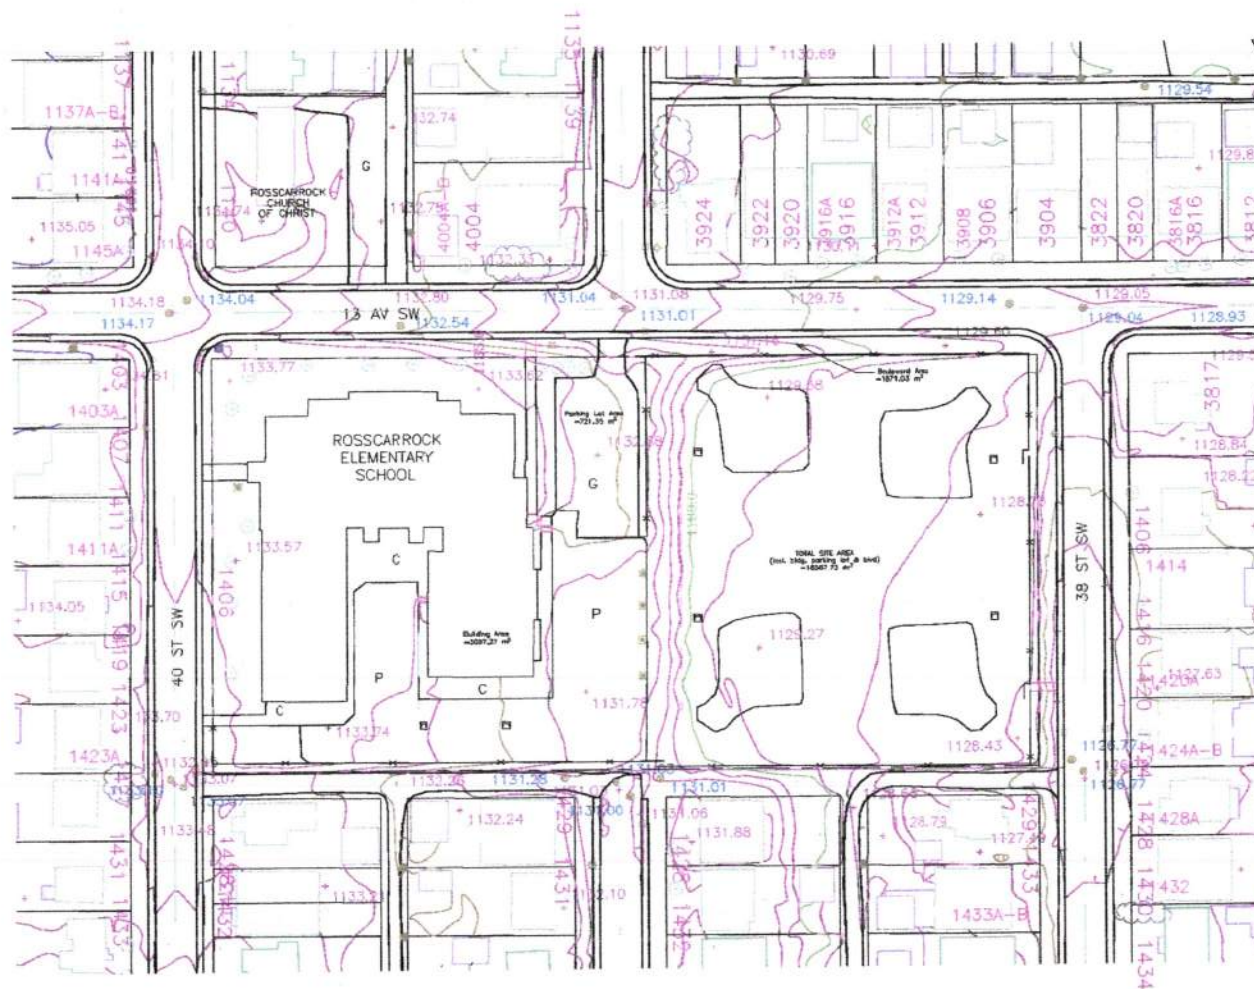

LEGEND
 SAN
 STORM
 GAS
 WATER
 ELECT
 AST
 CABLE
 GOAL POST
 BASEBALL BACKSTOP

NOTE
 DRAWING DATA BASE ORIGINATES FROM
 CITY OF CALGARY-JUCC PLANS
 ITEMS AVAILABLE BUT ARE FROZEN:
 CONTOUR LINES, SPOT ELEVATIONS,
 TREES, RESIDENTIAL HOUSES, ETC.

NO.	REVISIONS	DATE

LEGAL DESCRIPTION:
 BLOCK 4
 PLAN 796

MUNICIPAL ADDRESS:
 1406 - 40 ST SW



Calgary Board of Education
 DESIGN AND CONSTRUCTION SERVICES DEPT.

PROJECT
 ROSSICARROCK ELEMENTARY

DETAIL
 SITE PLAN

SCALE 1 : 1000	DRAWN JMT	PROJ. NO.
DATE AUG/98	CHK'D. 	FILE NO. 120

DRAWING NO.
 1
 OF 1

Rossicarrock School
 1406 40 Street SW

Site Plan

