

SECONDARY SUITE
106 NOLAN HILL DR N.W.
CALGARY, ALBERTA



PROJECT

NOLAN HILL DR NW
SECONDARY SUITE

STAMP

ISSUED:

NO.	ISSUE	DATE
1	ISSUE FOR REVIEW	04/26/2026

NOTES

DRAWING LISTS:

ARCHITECTURAL	
A.00	COVER PAGE
A.01	GENERAL NOTES
A.02	EXISTING SITE PLAN
A.03	PROPOSED SITE PLAN
A.04	EXISTING BASEMENT FLOOR PLAN
A.05	PROPOSED BASEMENT PLAN
A.06	EXISTING MAIN FLOOR PLAN
A.06B	PROPOSED MAIN FLOOR PLAN
A.07	EXISTING SECOND FLOOR PLAN
A.08	EXISTING EAST ELEVATION
A.09	EXISTING SOUTH ELEVATION
A.10	PROPOSED SOUTH ELEVATION
A.11	EXISTING NORTH ELEVATION
A.12	PROPOSED NORTH ELEVATION
A.13	EXISTING WEST ELEVATION
A.14	DOORS & WINDOWS SCHEDULE
A.15	WINDOW CUTOUT DETAILS
A.16	PROPOSED SECTIONS

ELECTRICAL	
E.01	PROPOSED BASEMENT ELECTRICAL PLAN

STRUCTURAL	

DRAWING INFORMATION:

CLIENT:
ADDRESS: 106 NOLAN HILL DR N.W.
LOCATION: CALGARY, ALBERTA
DRAWN BY: KT
LEGAL PLAN: LOT 28, BLK 09, PLAN 121 2448

DRAWING NO: 00
DRAWING TITLE: COVER PAGE
SHEET: A.00
SCALE: NA
REV. 0

PROJECT

NOLAN HILL DR NW
SECONDARY SUITE

STAMP

ISSUED:


NO.	ISSUE	DATE
1	ISSUE FOR REVIEW	04/26/2026

NOTES

DRAWING INFORMATION:

CLIENT:
ADDRESS: 106 NOLAN HILL DR N.W.
LOCATION: CALGARY, ALBERTA
DRAWN BY: KT
LEGAL PLAN: LOT 28, BLK 09, PLAN 121 2448

DRAWING NO: 01
DRAWING TITTLE: EXISTING SITE PLAN
SHEET: A.02
SCALE: 3/32 = 1'-0"
REV. 0

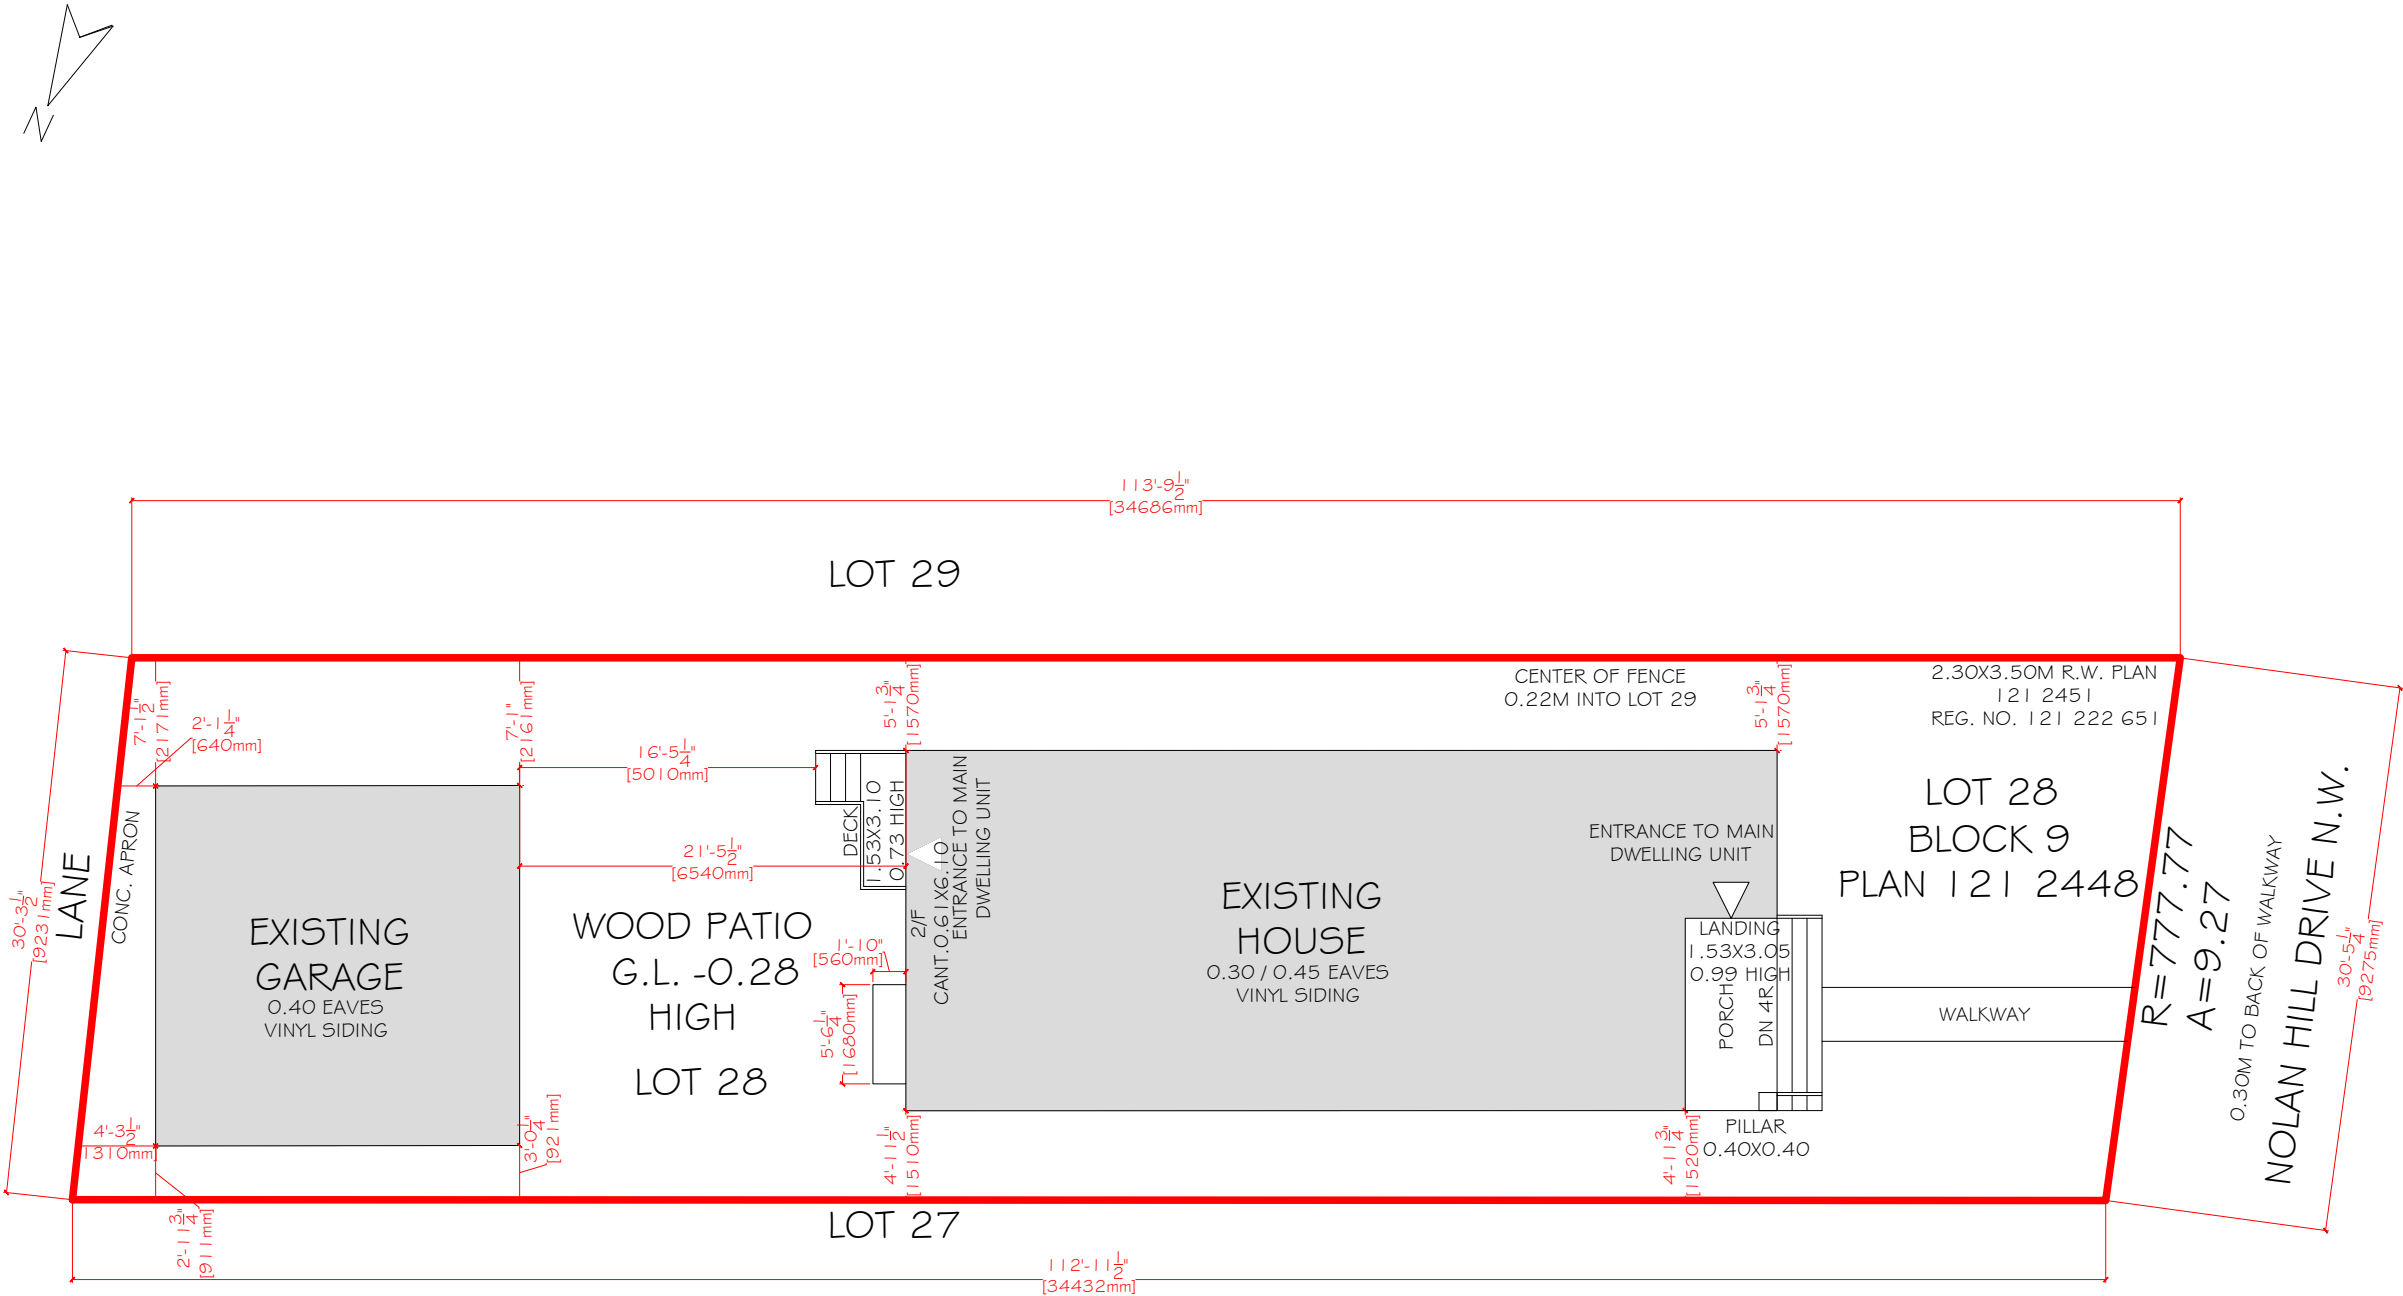




STAMP

NO.	ISSUE	DATE
1	ISSUE FOR REVIEW	04/26/2026

REV. 0

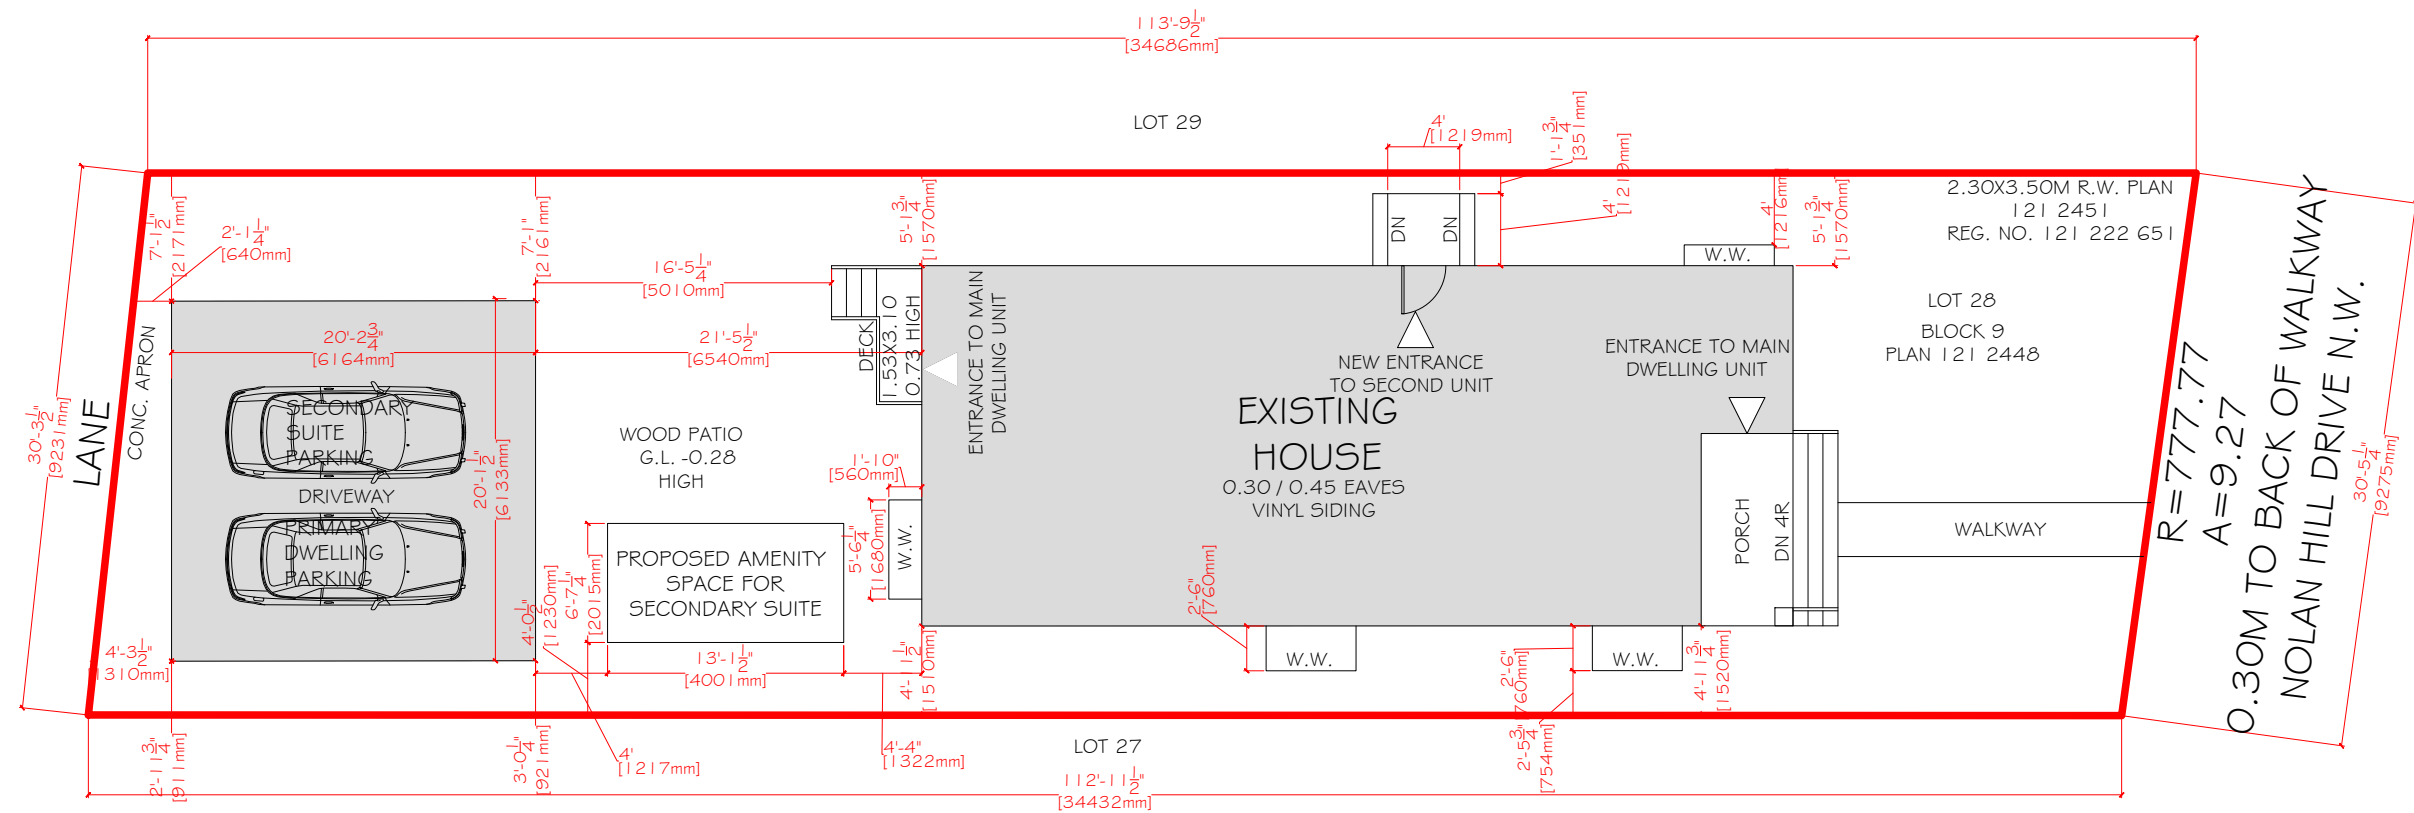

PROJECT

NOLAN HILL DR NW
SECONDARY SUITE

STAMP

ISSUED:

NO.	ISSUE	DATE
1	ISSUE FOR REVIEW	04/26/2026

NOTES

DRAWING INFORMATION:

CLIENT:
ADDRESS: 106 NOLAN HILL DR N.W.
LOCATION: CALGARY, ALBERTA
DRAWN BY: KT
LEGAL PLAN: LOT 28, BLK 09, PLAN 121 2448

DRAWING NO:	01
DRAWING TITTLE:	EXISTING EAST ELEVATION
SHEET:	A.08
SCALE:	3/16 = 1'-0"
REV.	0



PROJECT

NOLAN HILL DR NW
SECONDARY SUITE

STAMP

ISSUED:


NO.	ISSUE	DATE
1	ISSUE FOR REVIEW	04/26/2026

NOTES

DRAWING INFORMATION:

CLIENT:
ADDRESS: 106 NOLAN HILL DR N.W.
LOCATION: CALGARY, ALBERTA
DRAWN BY: KT
LEGAL PLAN: LOT 28, BLK 09, PLAN 121 2448

DRAWING NO:	01
DRAWING TITTLE:	EXISTING SOUTH ELEVATION
SHEET:	A.09
SCALE:	1/8" = 1'-0"
REV.	0

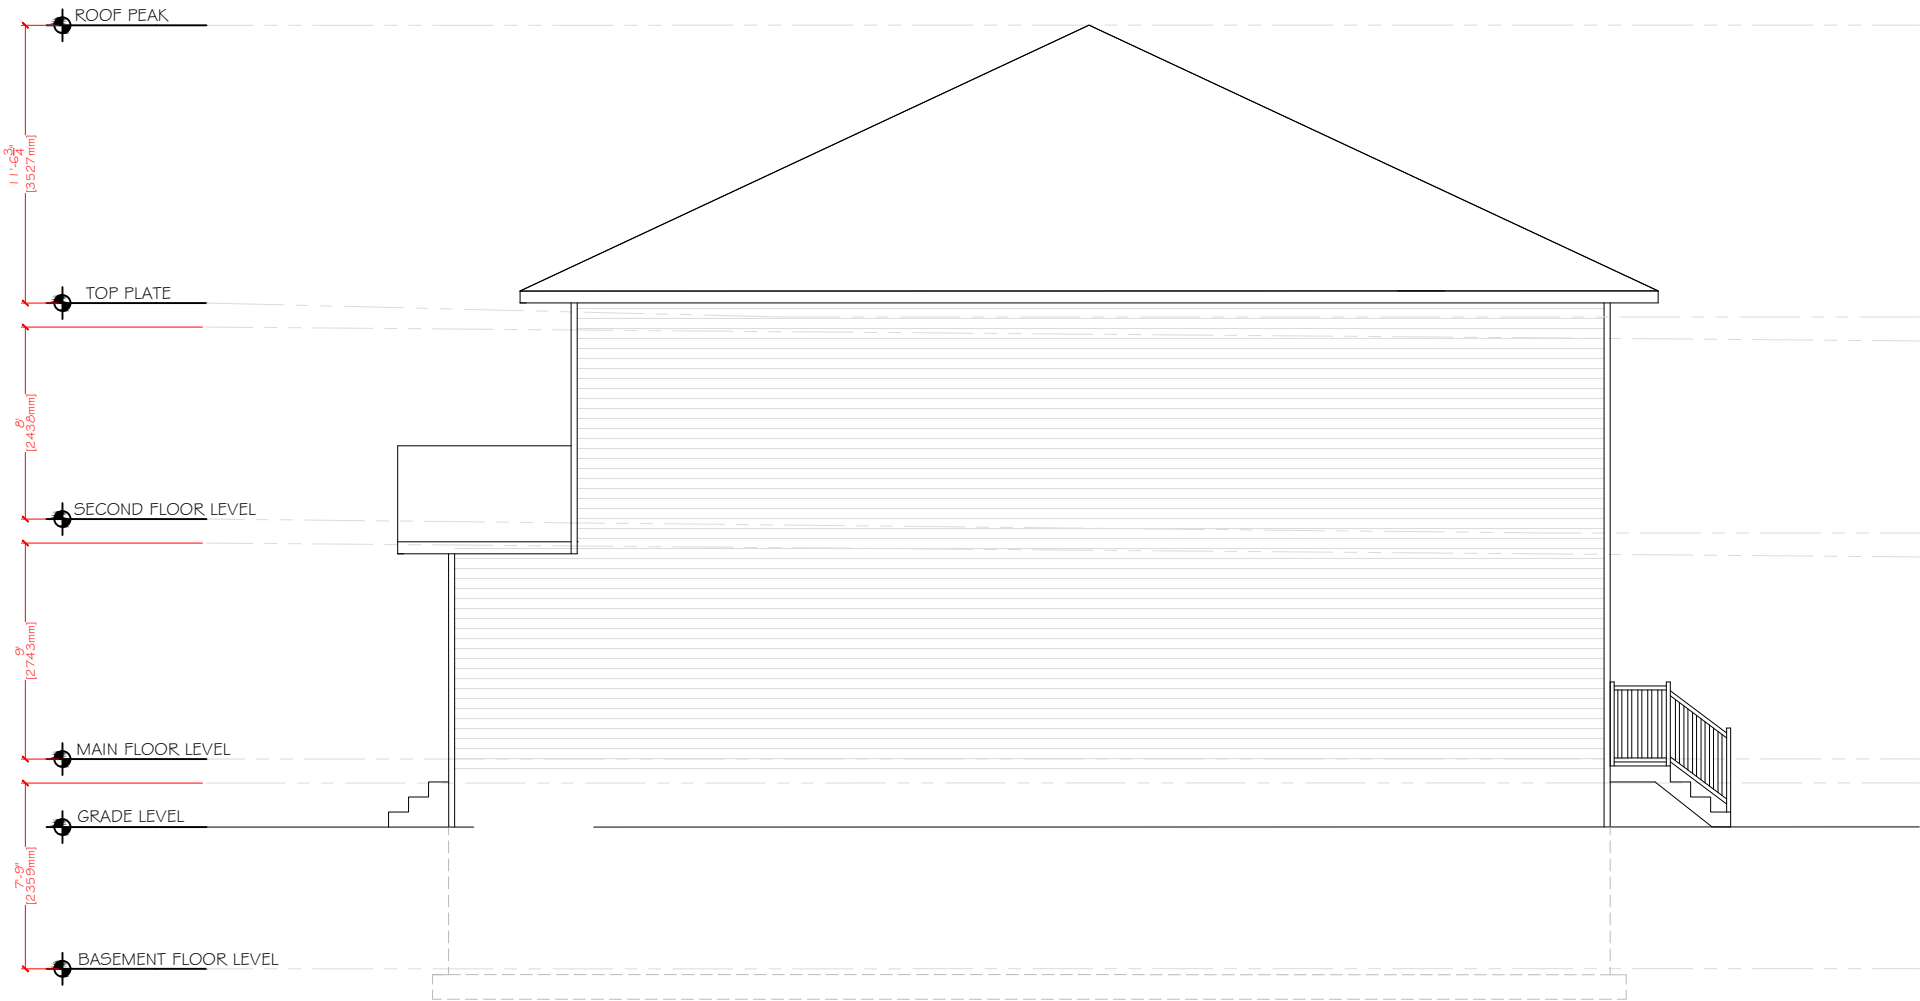

PROJECT

NOLAN HILL DR NW
SECONDARY SUITE

STAMP

ISSUED:


NO.	ISSUE	DATE
1	ISSUE FOR REVIEW	04/26/2026

NOTES

DRAWING INFORMATION:

CLIENT:
ADDRESS: 106 NOLAN HILL DR N.W.
LOCATION: CALGARY, ALBERTA
DRAWN BY: KT
LEGAL PLAN: LOT 28, BLK 09, PLAN 121 2448

DRAWING NO:	01
DRAWING TITTLE:	PROPOSED SOUTH ELEVATION
SHEET:	A.10
SCALE:	1/8" = 1'-0"
REV.	0

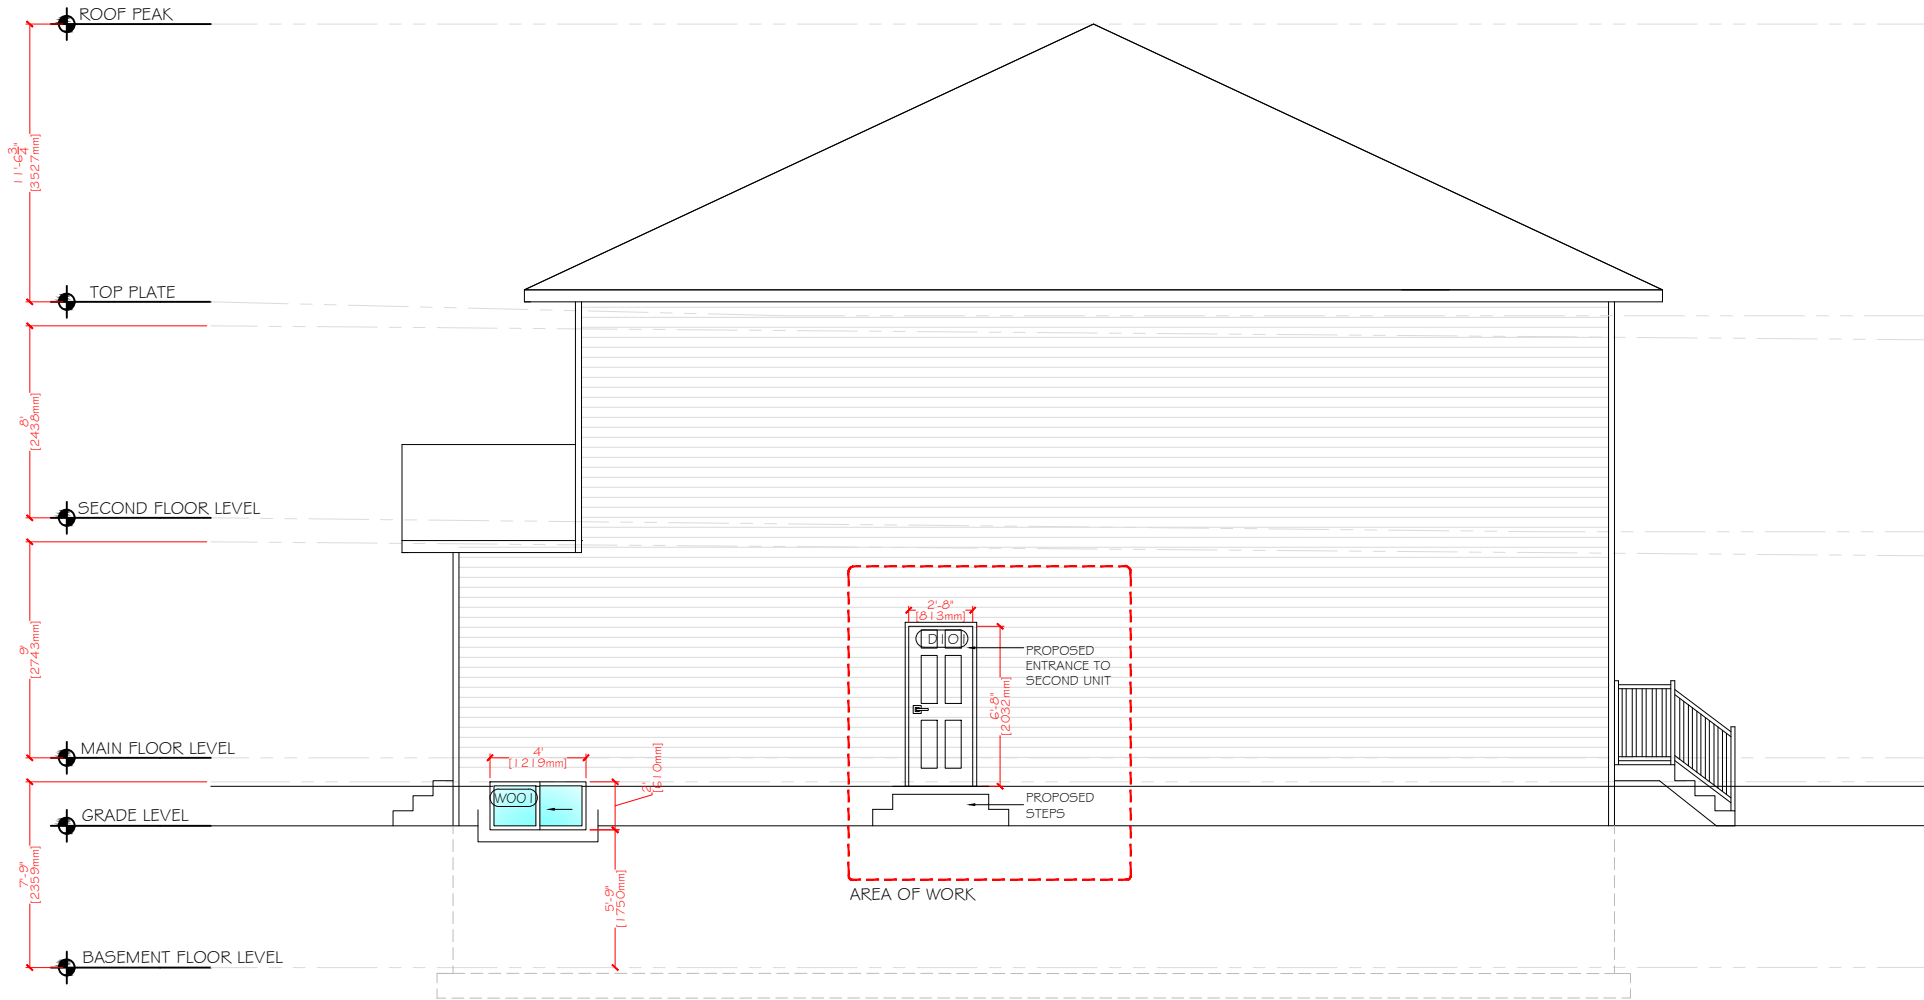

PROJECT

NOLAN HILL DR NW
SECONDARY SUITE

STAMP

ISSUED:


NO.	ISSUE	DATE
1	ISSUE FOR REVIEW	04/26/2026

NOTES

DRAWING INFORMATION:

CLIENT:
ADDRESS: 106 NOLAN HILL DR N.W.
LOCATION: CALGARY, ALBERTA
DRAWN BY: KT
LEGAL PLAN: LOT 28, BLK 09, PLAN 121 2448

DRAWING NO:	01
DRAWING TITTLE:	EXISTING NORTH ELEVATION
SHEET:	A.11
SCALE:	1/8" = 1'-0"
REV.	0

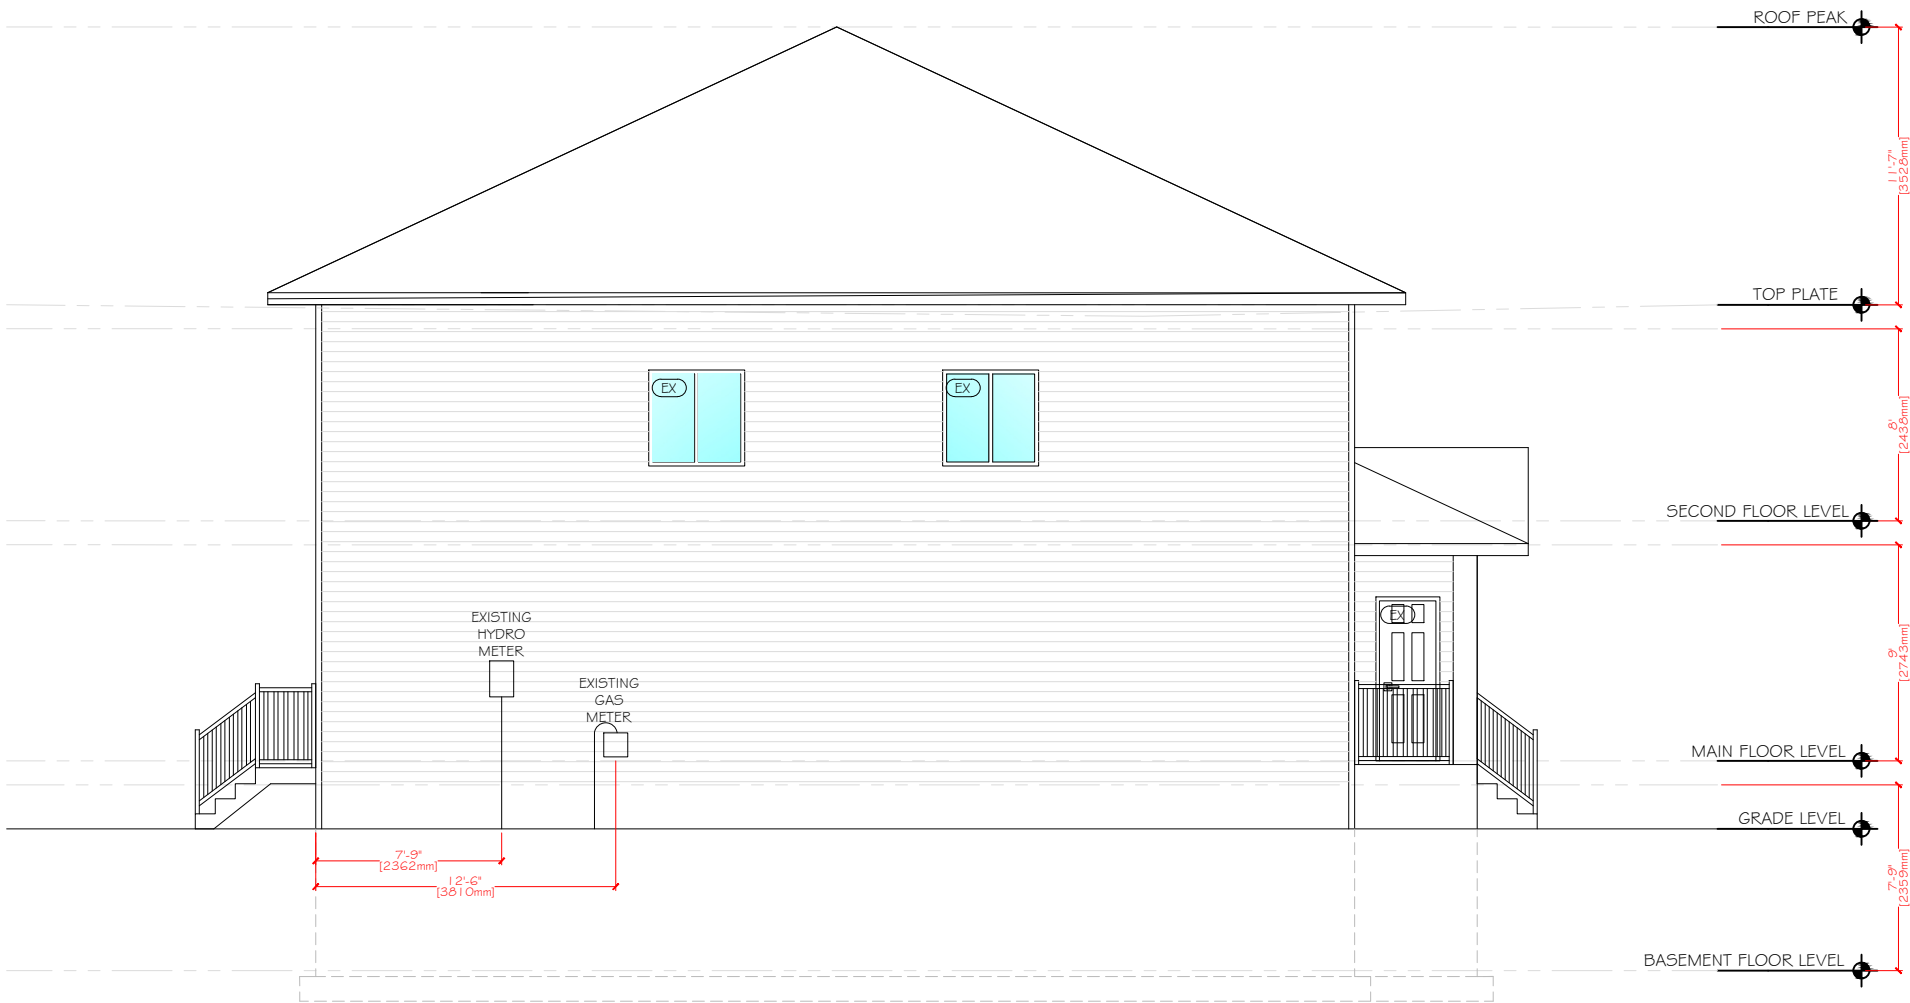

PROJECT

NOLAN HILL DR NW
SECONDARY SUITE

STAMP

ISSUED:


NO.	ISSUE	DATE
1	ISSUE FOR REVIEW	04/26/2026

NOTES

DRAWING INFORMATION:

CLIENT:
ADDRESS: 106 NOLAN HILL DR N.W.
LOCATION: CALGARY, ALBERTA
DRAWN BY: KT
LEGAL PLAN: LOT 28, BLK 09, PLAN 121 2448

DRAWING NO:	01
DRAWING TITTLE:	PROPOSED NORTH ELEVATION
SHEET:	A.12
SCALE:	1/8" = 1'-0"
REV.	0

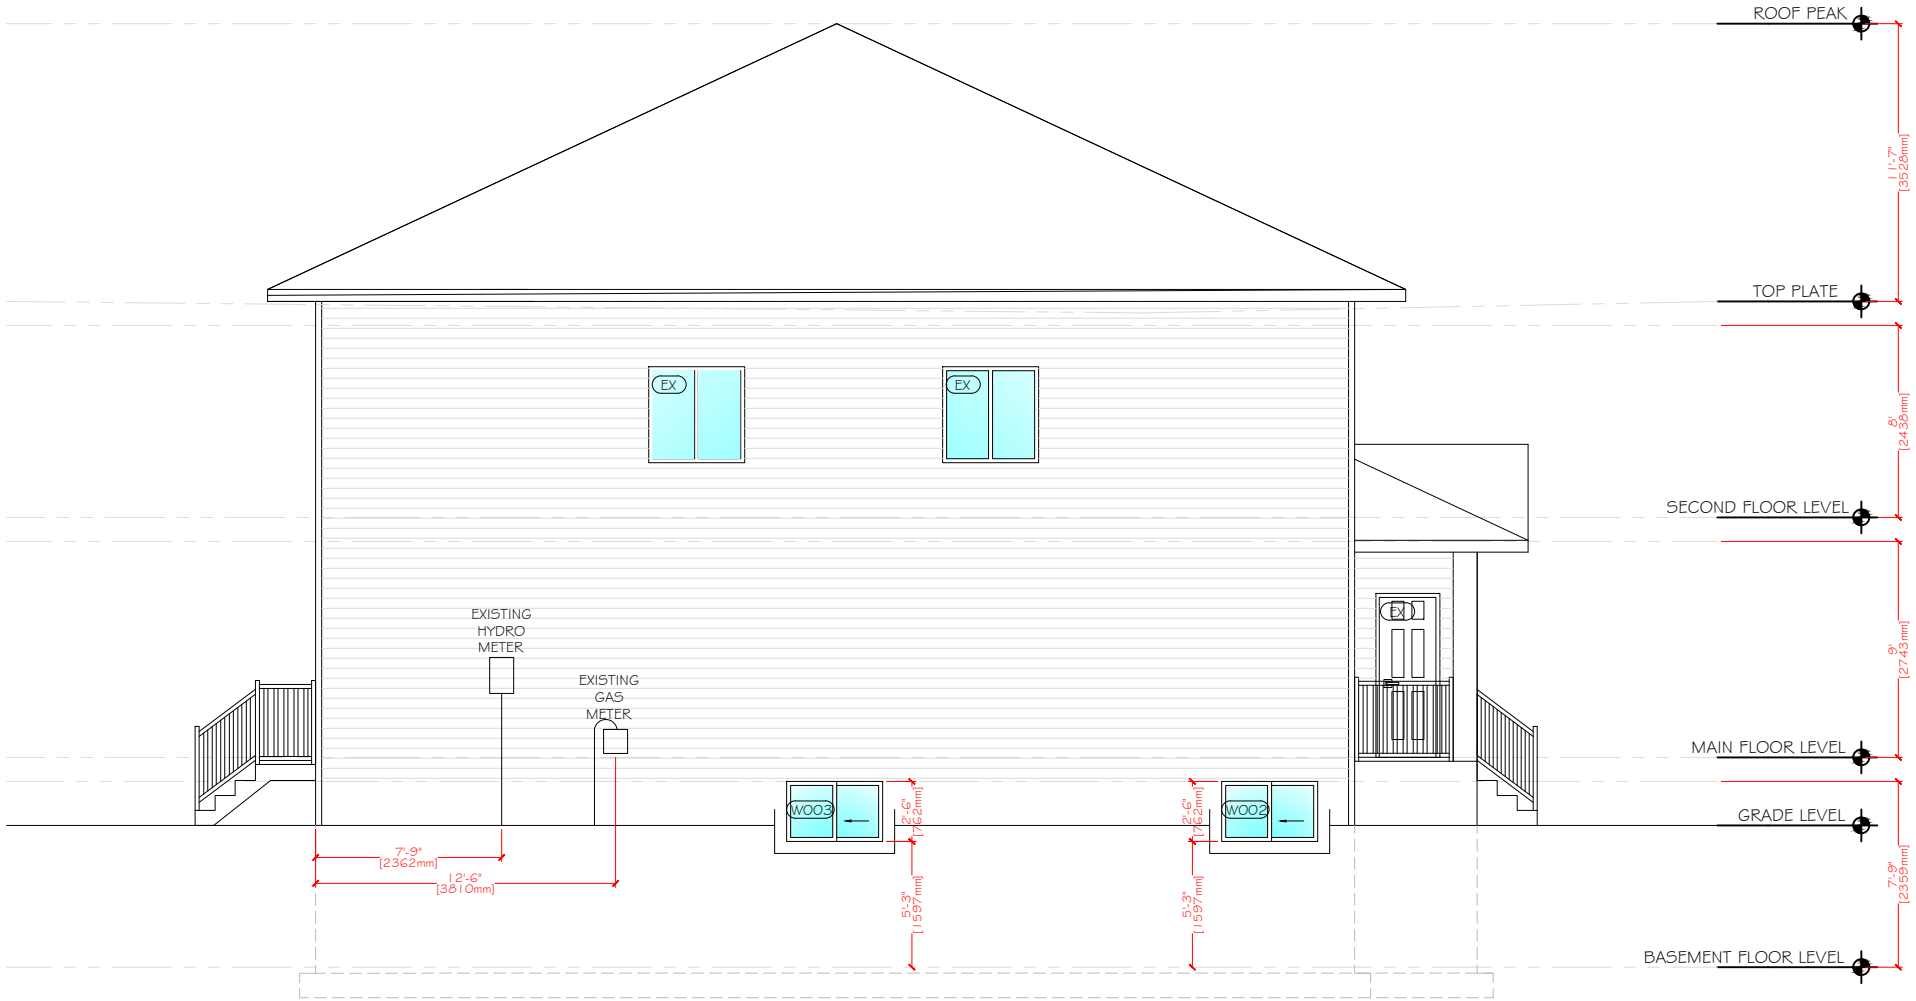

PROJECT

NOLAN HILL DR NW
SECONDARY SUITE

STAMP

ISSUED:

NO.	ISSUE	DATE
1	ISSUE FOR REVIEW	04/26/2026

NOTES

DRAWING INFORMATION:

CLIENT:
ADDRESS: 106 NOLAN HILL DR N.W.
LOCATION: CALGARY, ALBERTA
DRAWN BY: KT
LEGAL PLAN: LOT 28, BLK 09, PLAN 121 2448

DRAWING NO:	01
DRAWING TITTLE:	EXISTING WEST ELEVATION
SHEET:	A.13
SCALE:	3/16 = 1'-0"
REV.	0

