

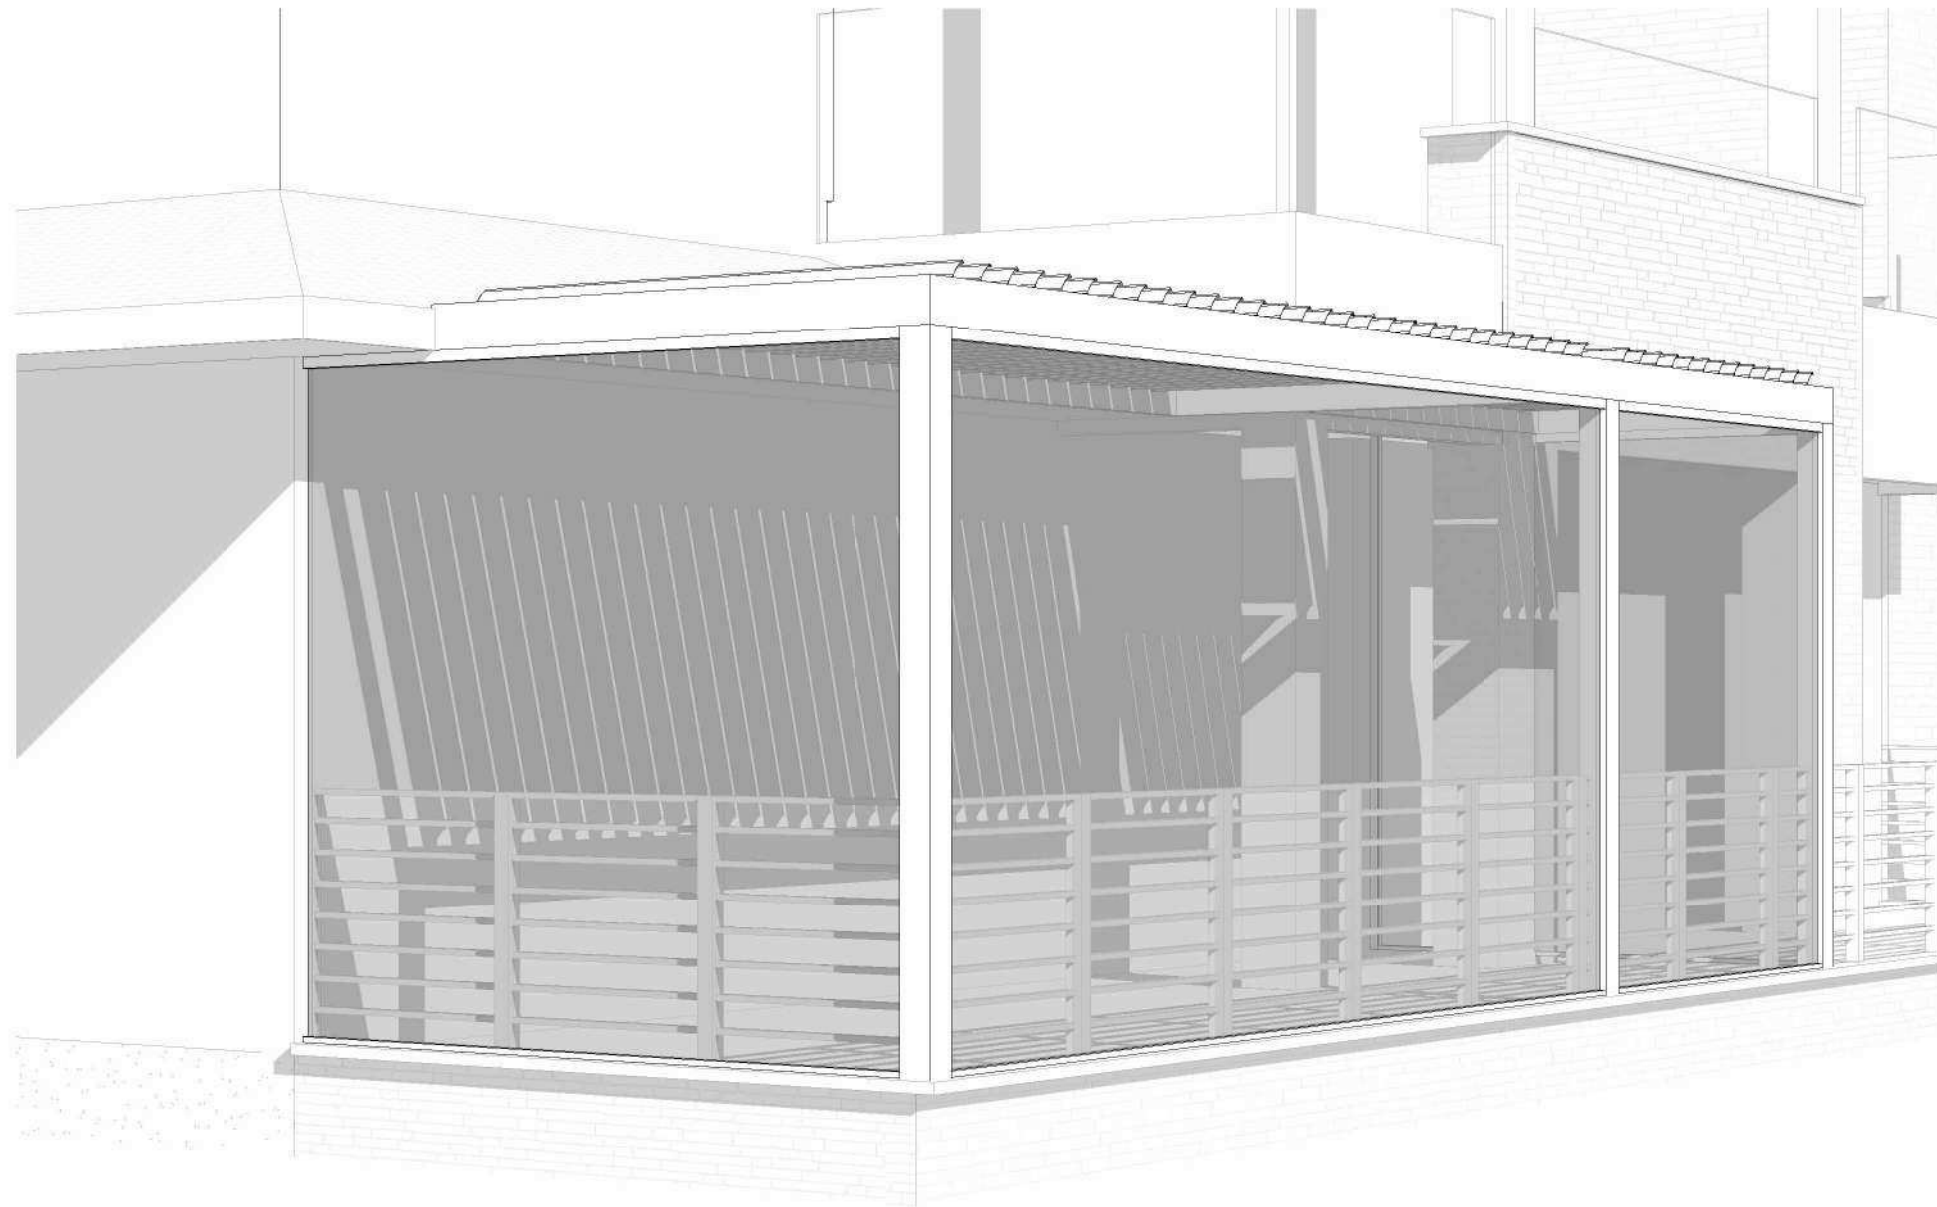
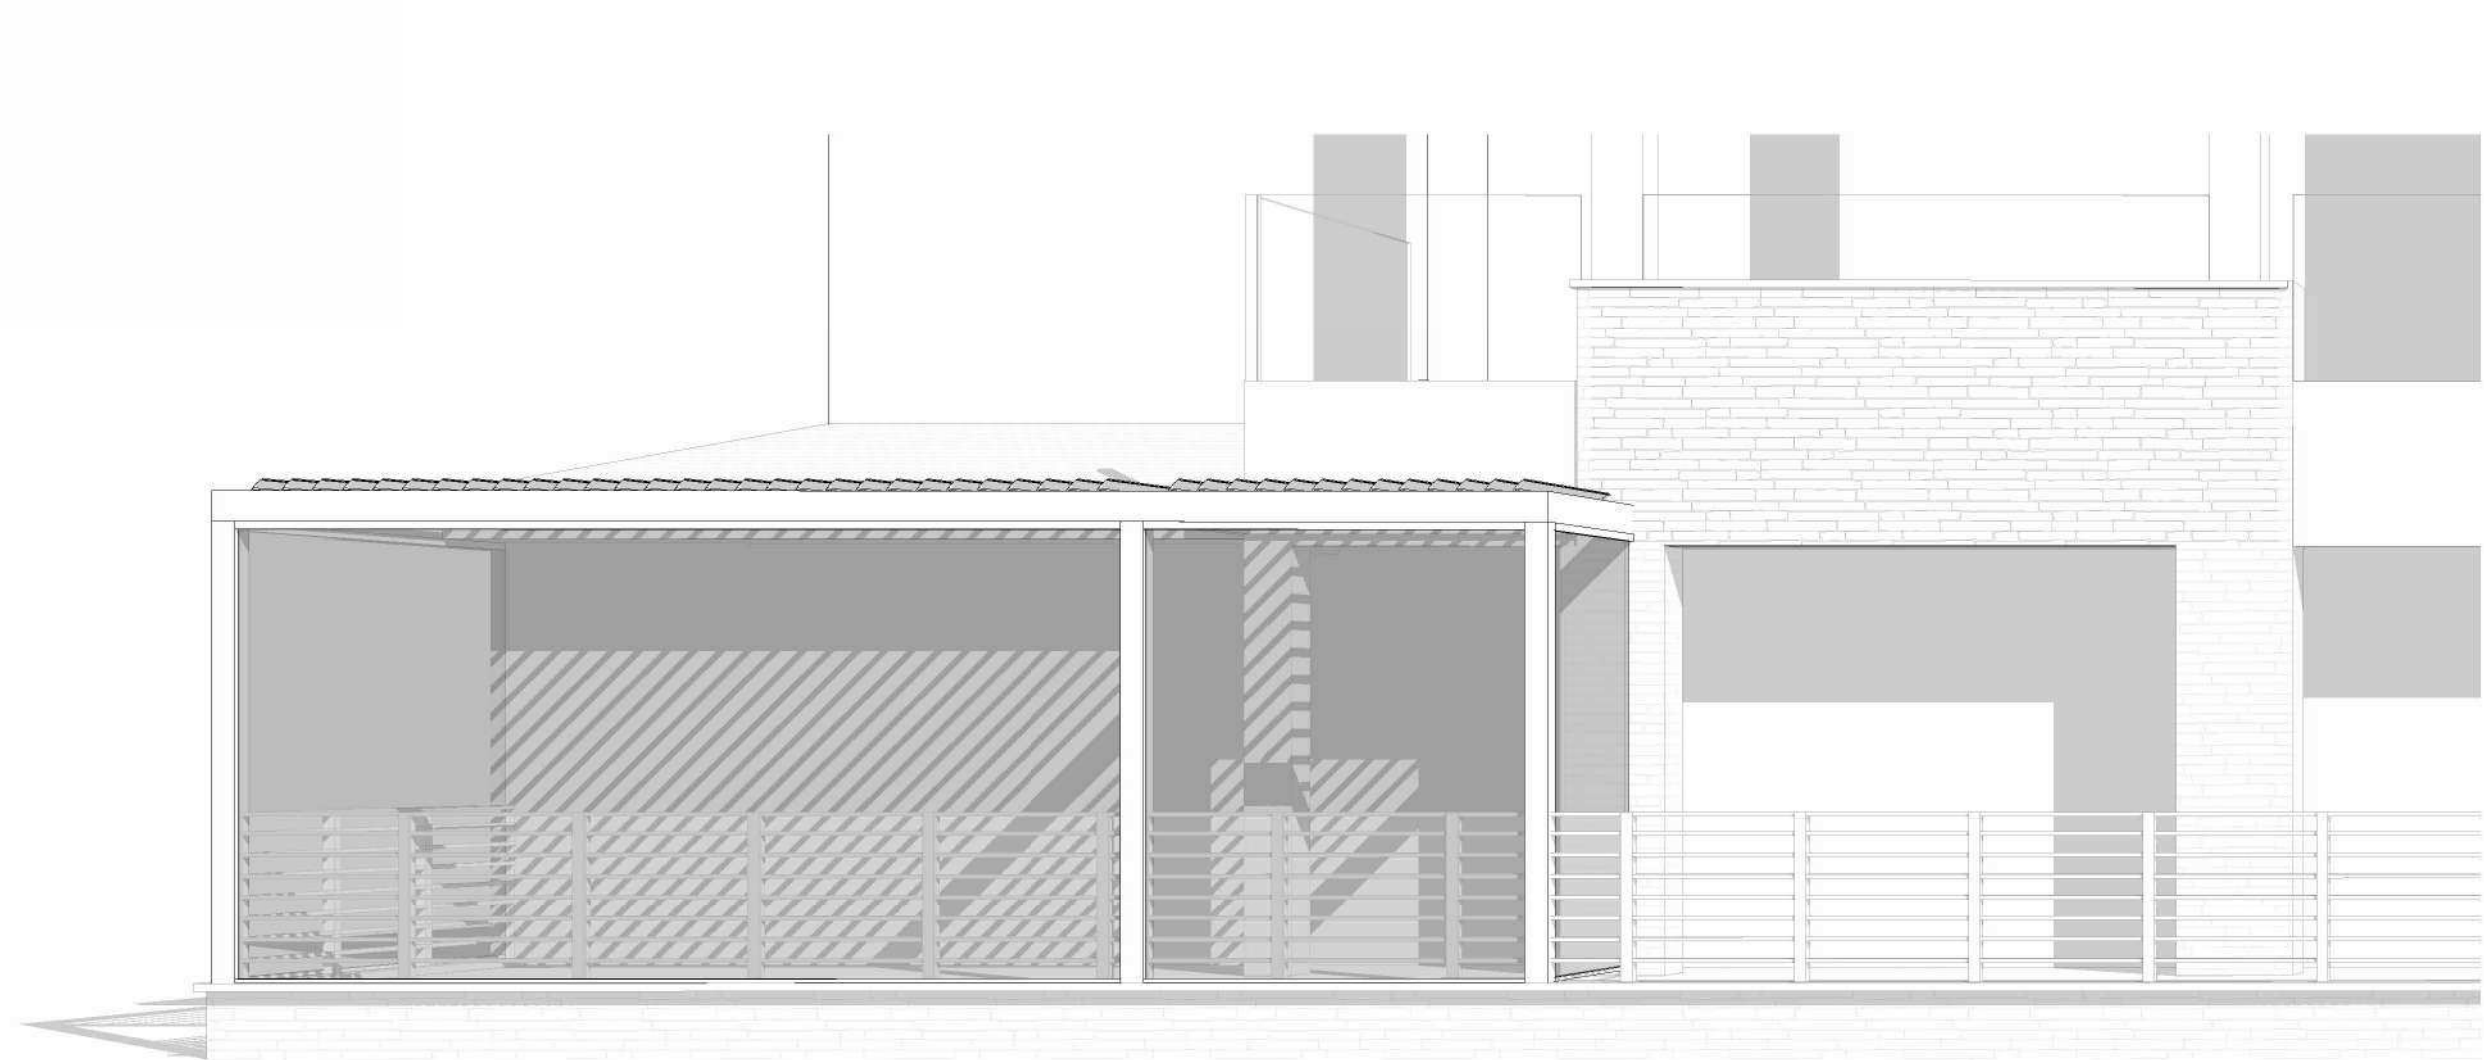


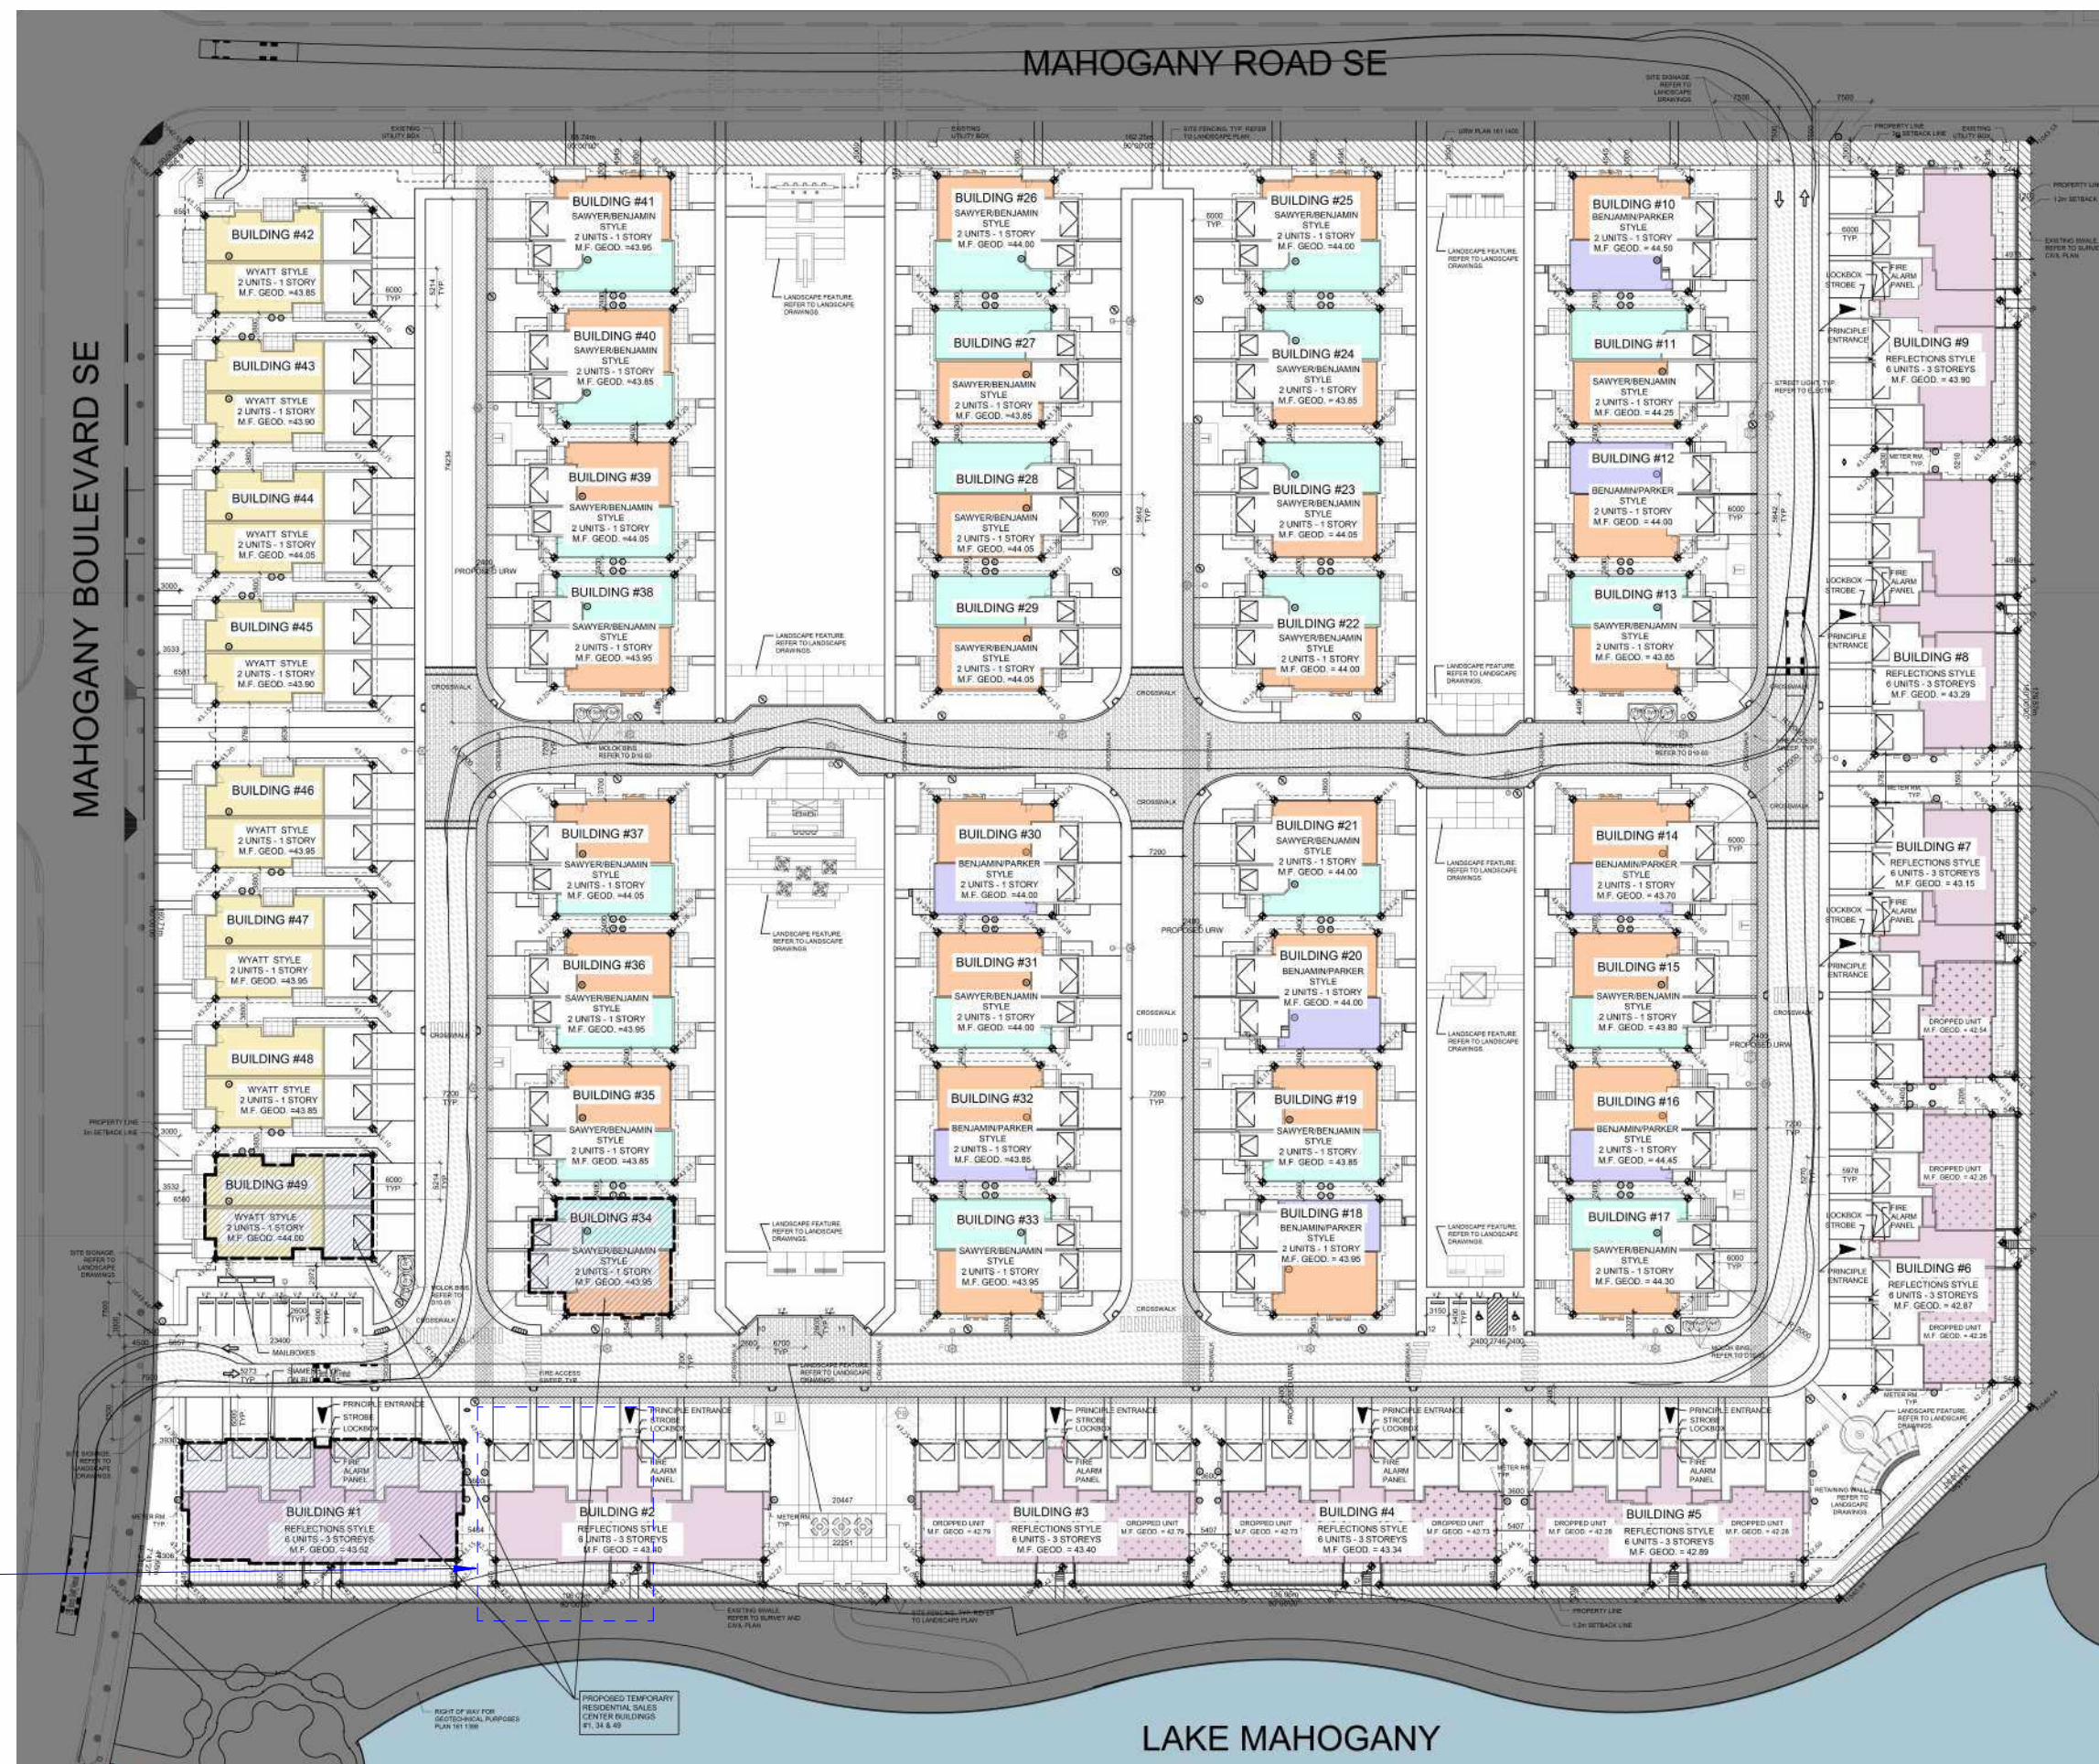

LINE STYLES	TEXT STYLES	Drawing List
PROPERTY LINE	TYPICAL NOTES	
EAVES	STRUCTURAL NOTES	
ELECTRICAL PLAN	PENG COMMENTS	
BEAM	DETAILED NOTES	
FURNITURE	ELEVATION CALLOUT	A1.0 Site Plan
REVISIONS 1	ROOM DESIGNATION	A2.0 Plans
PROJECT SCOPE	EXISTING GEO	S1.0 Louver Details
	PROPOSED GEO	S1.1 Louver Details
		S1.2 Louver (Misc. Details)
GENERAL NOTES: - DRAWINGS ARE NOT TO BE SCALED. - ALL DIMENSIONS ARE TO FACE OF DRYWALL, CENTER LINE OF WALL OR FACE OF CONCRETE UNLESS OTHERWISE STATED. - ALL CONSTRUCTION METHODS AND SPECIFICATIONS SHALL CONFORM TO THE LATEST ALBERTA BUILDING CODE AND ALL LOCAL BUILDING ORDINANCES. - BUILDER SHALL BE RESPONSIBLE TO CONFIRM ALL DIMENSIONS AND INFORMATION ON DRAWINGS. ANY DISCREPANCIES SHALL BE REPORTED TO THE DESIGNER FOR CONFIRMATION PRIOR TO THE COMMENCEMENT OF CONSTRUCTION. - STANDARD EAVE OVERHANG AS PER ELEVATIONS.		

DEVELOPMENT
PERMIT
DECISION
RENDERED
ON THIS PLAN

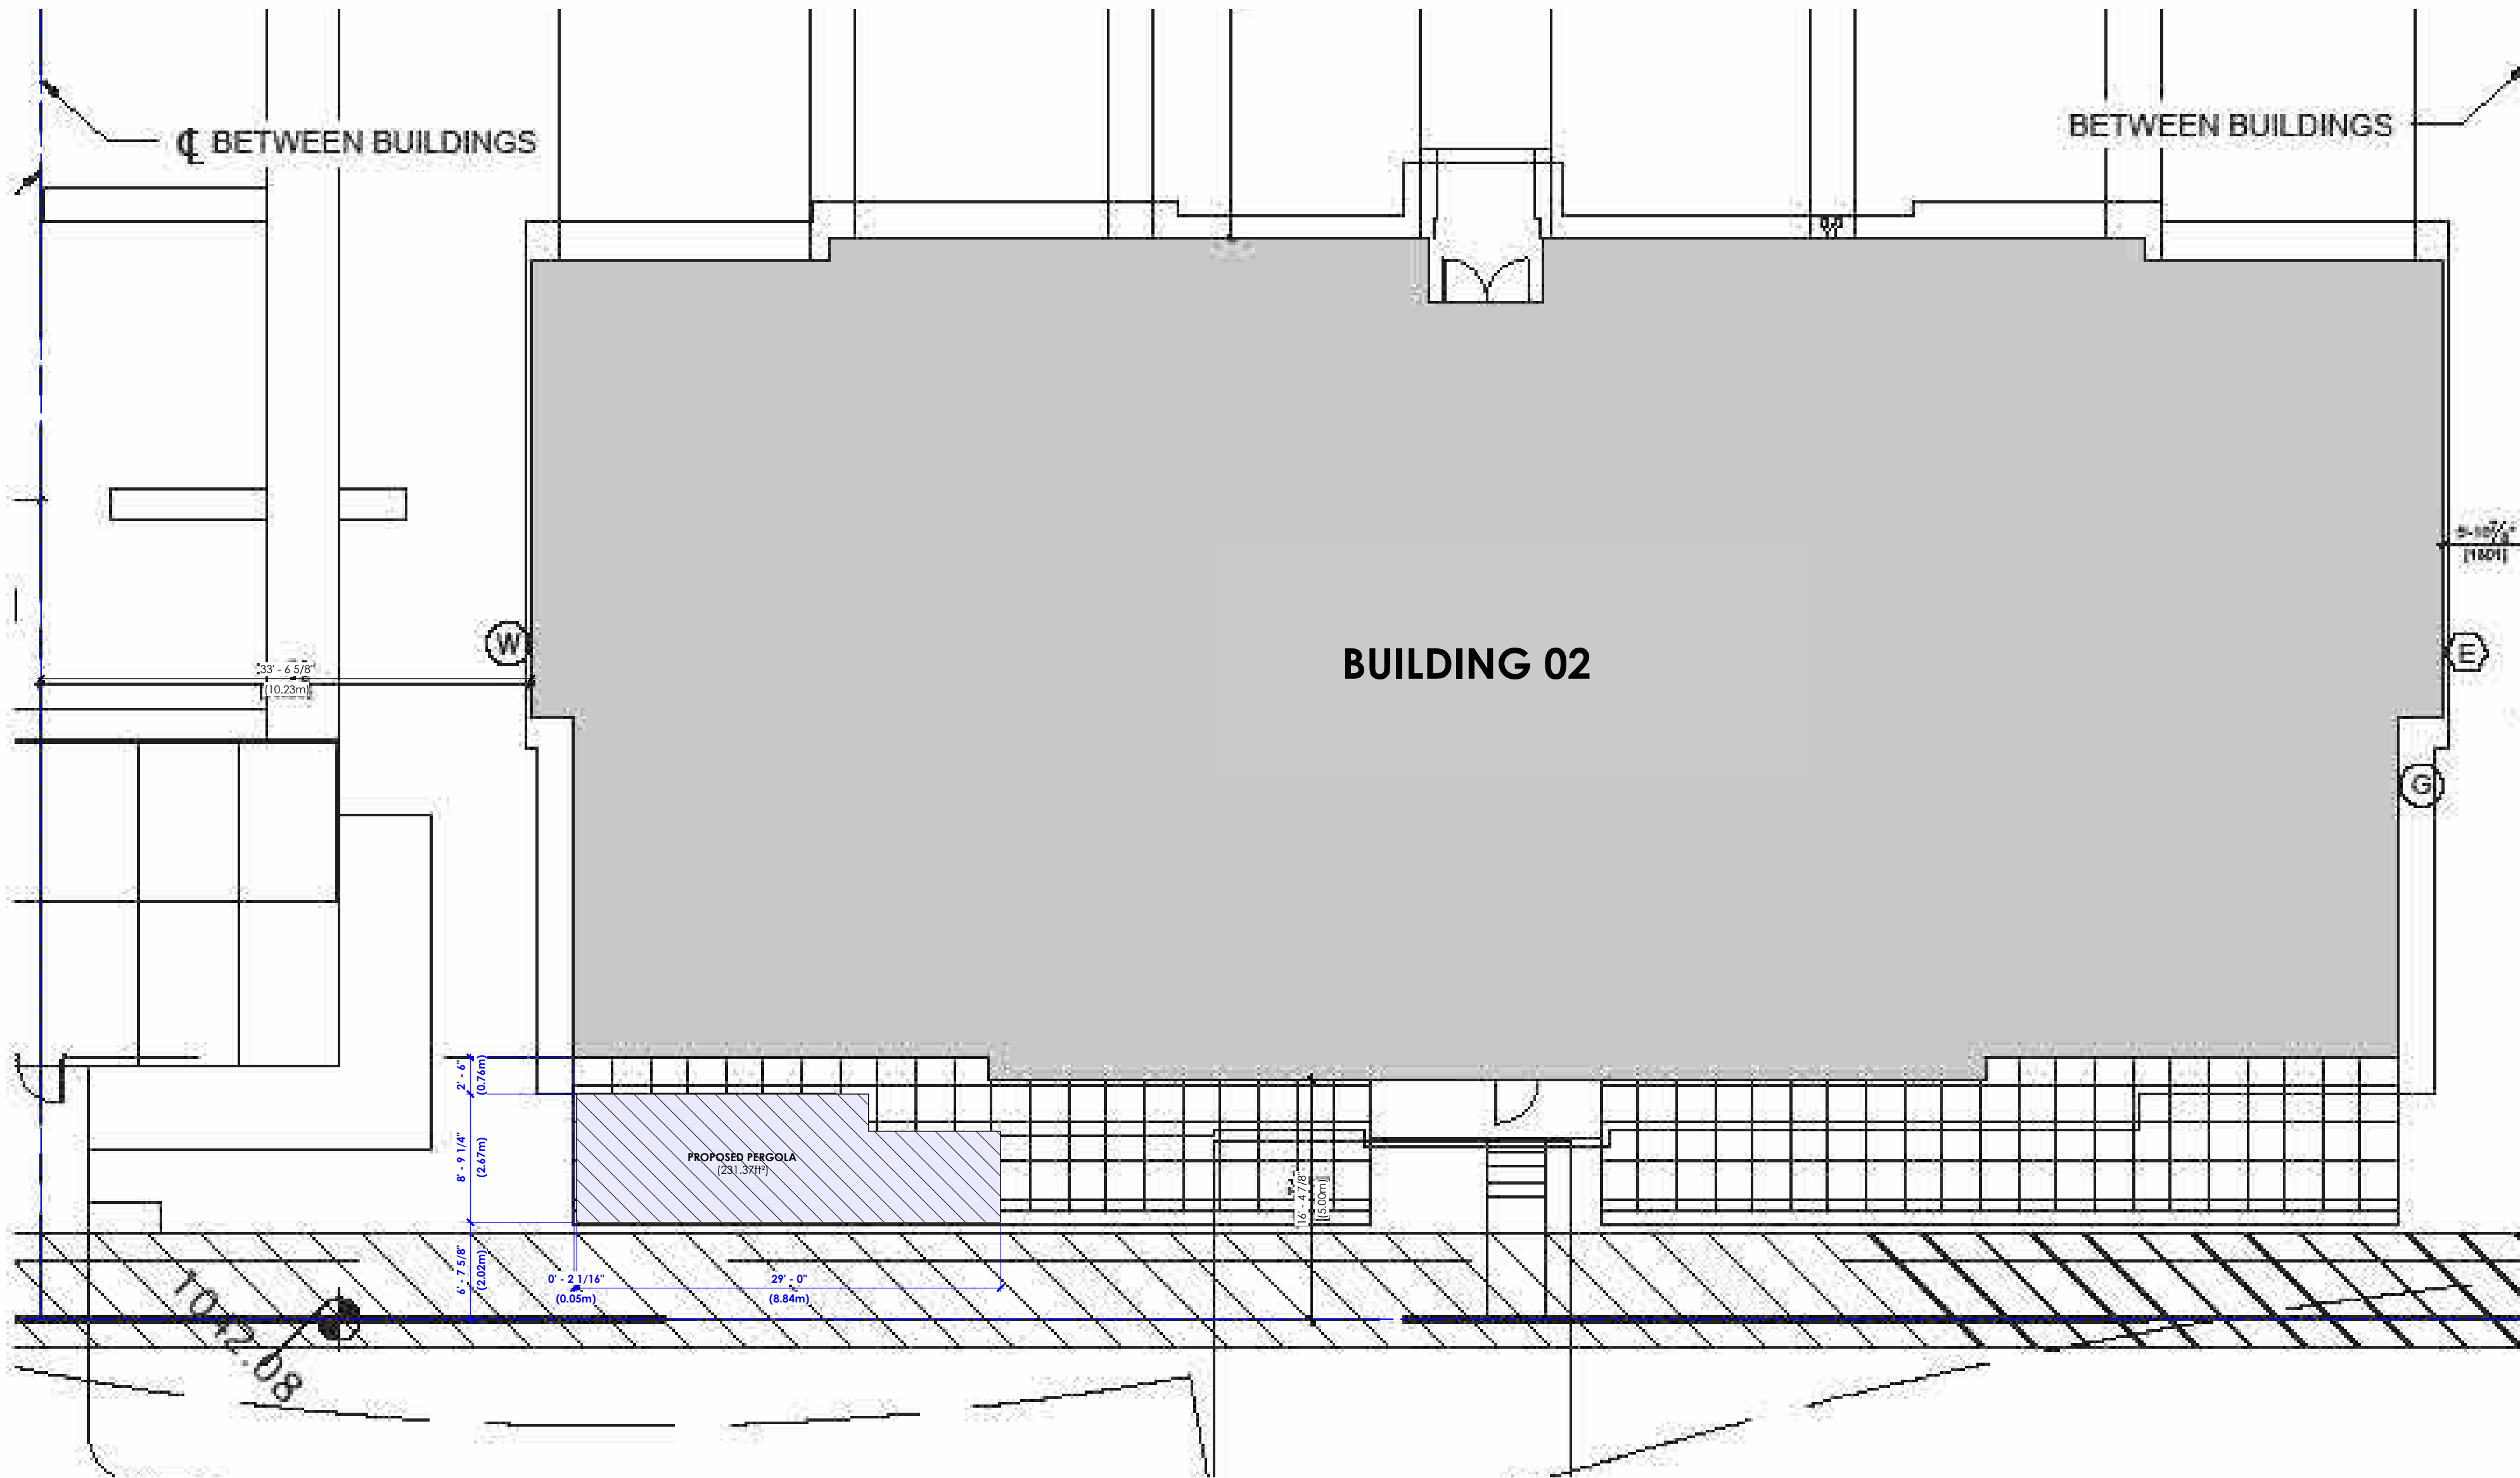

2 Site (Detailed)
1:100

1 Site (Overall)
1:1000



SEVEN
DAY
PERMITS
Robert Carpenter
Phone: 403.701.2025
Email: info@seven-daypermits.ca
Web: www.sevendaypermits.ca

THIS DRAWING IS AN INSTRUMENT OF SERVICE AND IS THE PROPERTY OF THE DESIGNER. IT MAY NOT BE REPRODUCED WITHOUT THE DESIGNER'S PERMISSION, NOR WITHOUT THE DESIGNER'S NAME ON THE REPRODUCTION IN WHOLE OR IN PART.
ALL WORK SHALL BE DONE IN ACCORDANCE WITH AND GOVERNED BY ALL CURRENT NATIONAL, PROVINCIAL AND LOCAL CODES AND REGULATIONS.
BUILDER OR OWNER IS RESPONSIBLE FOR CONTACTING DESIGNER PRIOR TO CONSTRUCTION IF THERE ARE DISCREPANCIES ON PLANS.

IF P.ENG IS REQUIRED:
BUILDER/OWNER TO SEND PHOTOS OF ANY APPLICABLE ENGINEERED SCOPE, INCLUDING (BUT NOT LIMITED TO):
• CONCRETE: REBAR + FORM WORK PRIOR TO POUR
• FRAMING: ENGINEERED BEAMS/JUNCTIONS/POSTS/TALL WALLS/ETC.
• SCREW PILES: TORQUE REPORT
• SCREEN ROOMS + SUNROOMS: EXISTING STRUCTURE + CONNECTIONS
EMAIL PHOTOS TO ROBB@SEVENDAYPERMITS.CA
CONTACT SEVEN DAY PERMITS FOR ANY QUESTIONS.



REVISIONS:	
1. Client Review	dd / mm / yyyy
2. -	dd / mm / yyyy
3. -	dd / mm / yyyy
4. -	dd / mm / yyyy
5. -	dd / mm / yyyy

180 MARINA COVE #102
CALGARY, AB
Attached Pergola
6/1/2026 10:22:54 PM

Site Plan
Project : 2026-238DP
Drawn By: RFC Scale: As indicated
A1.0