




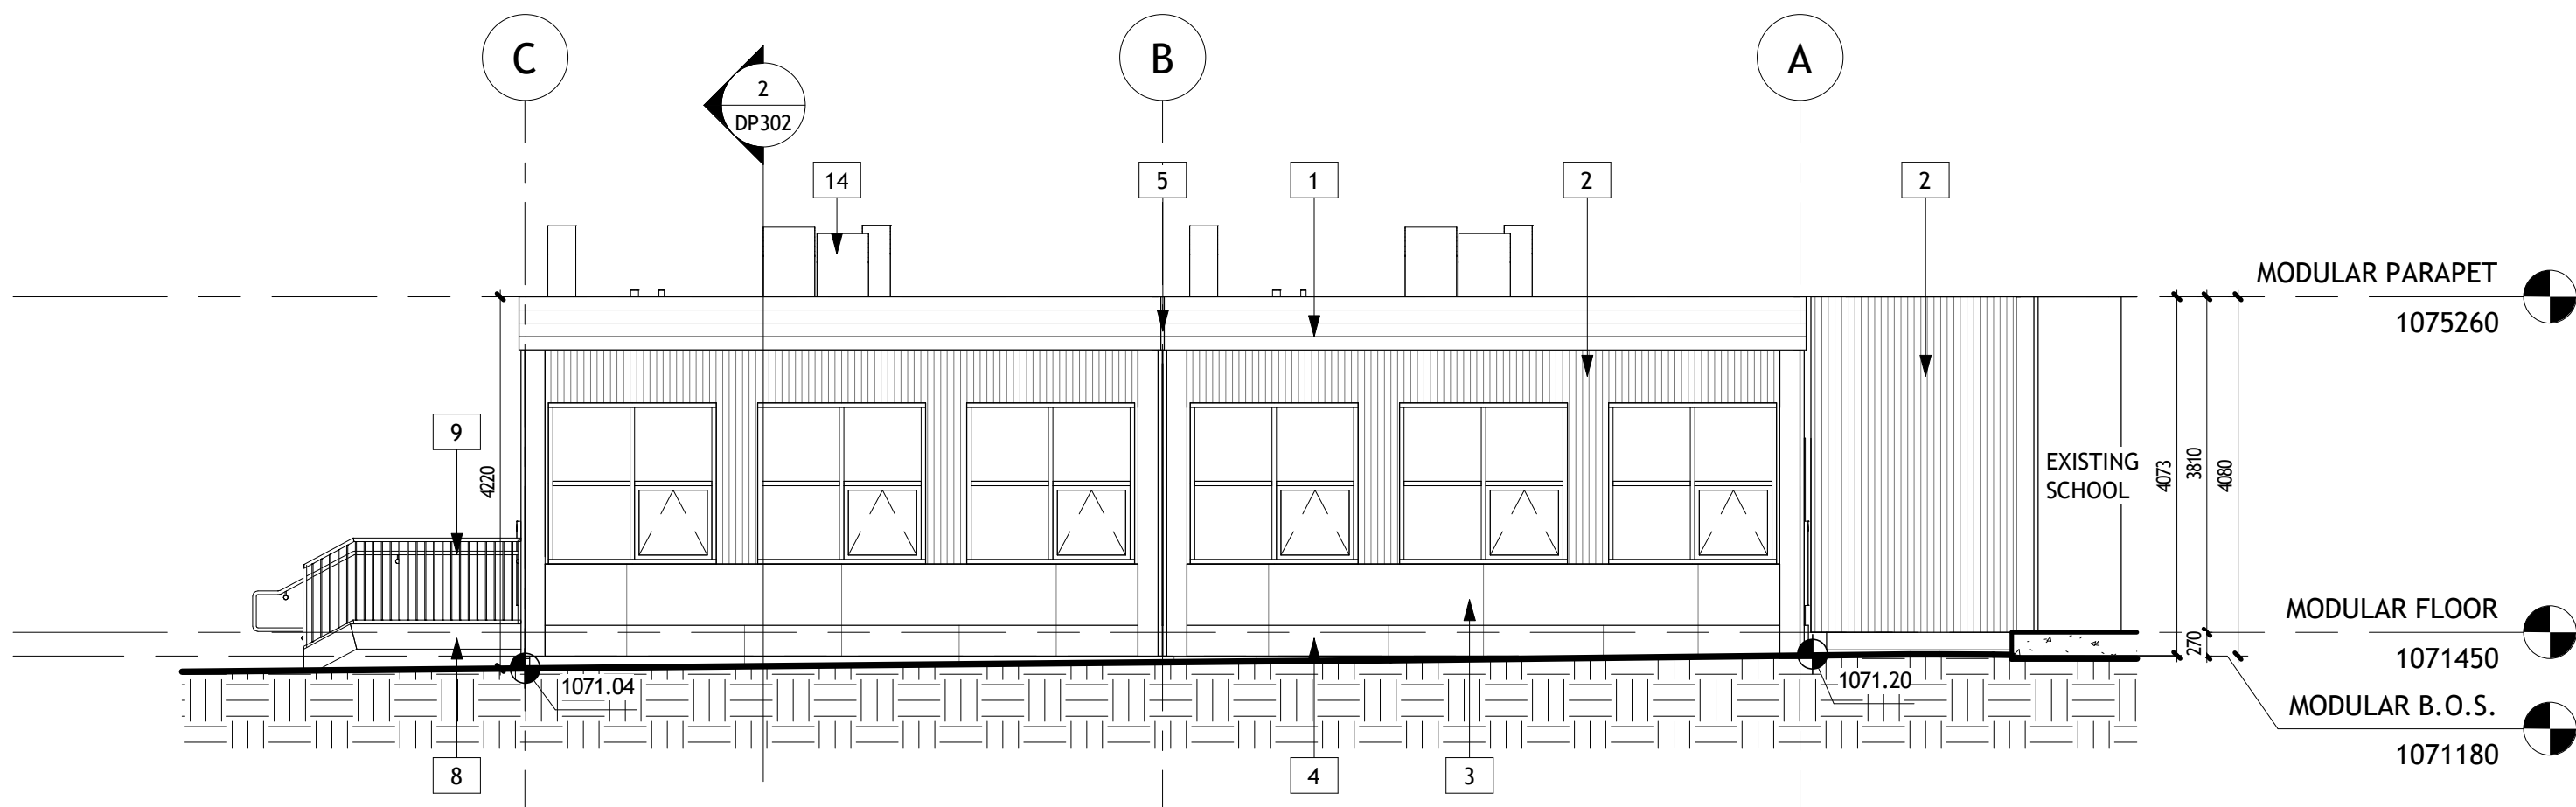


1 NORTH-EAST ELEVATION
1 : 75

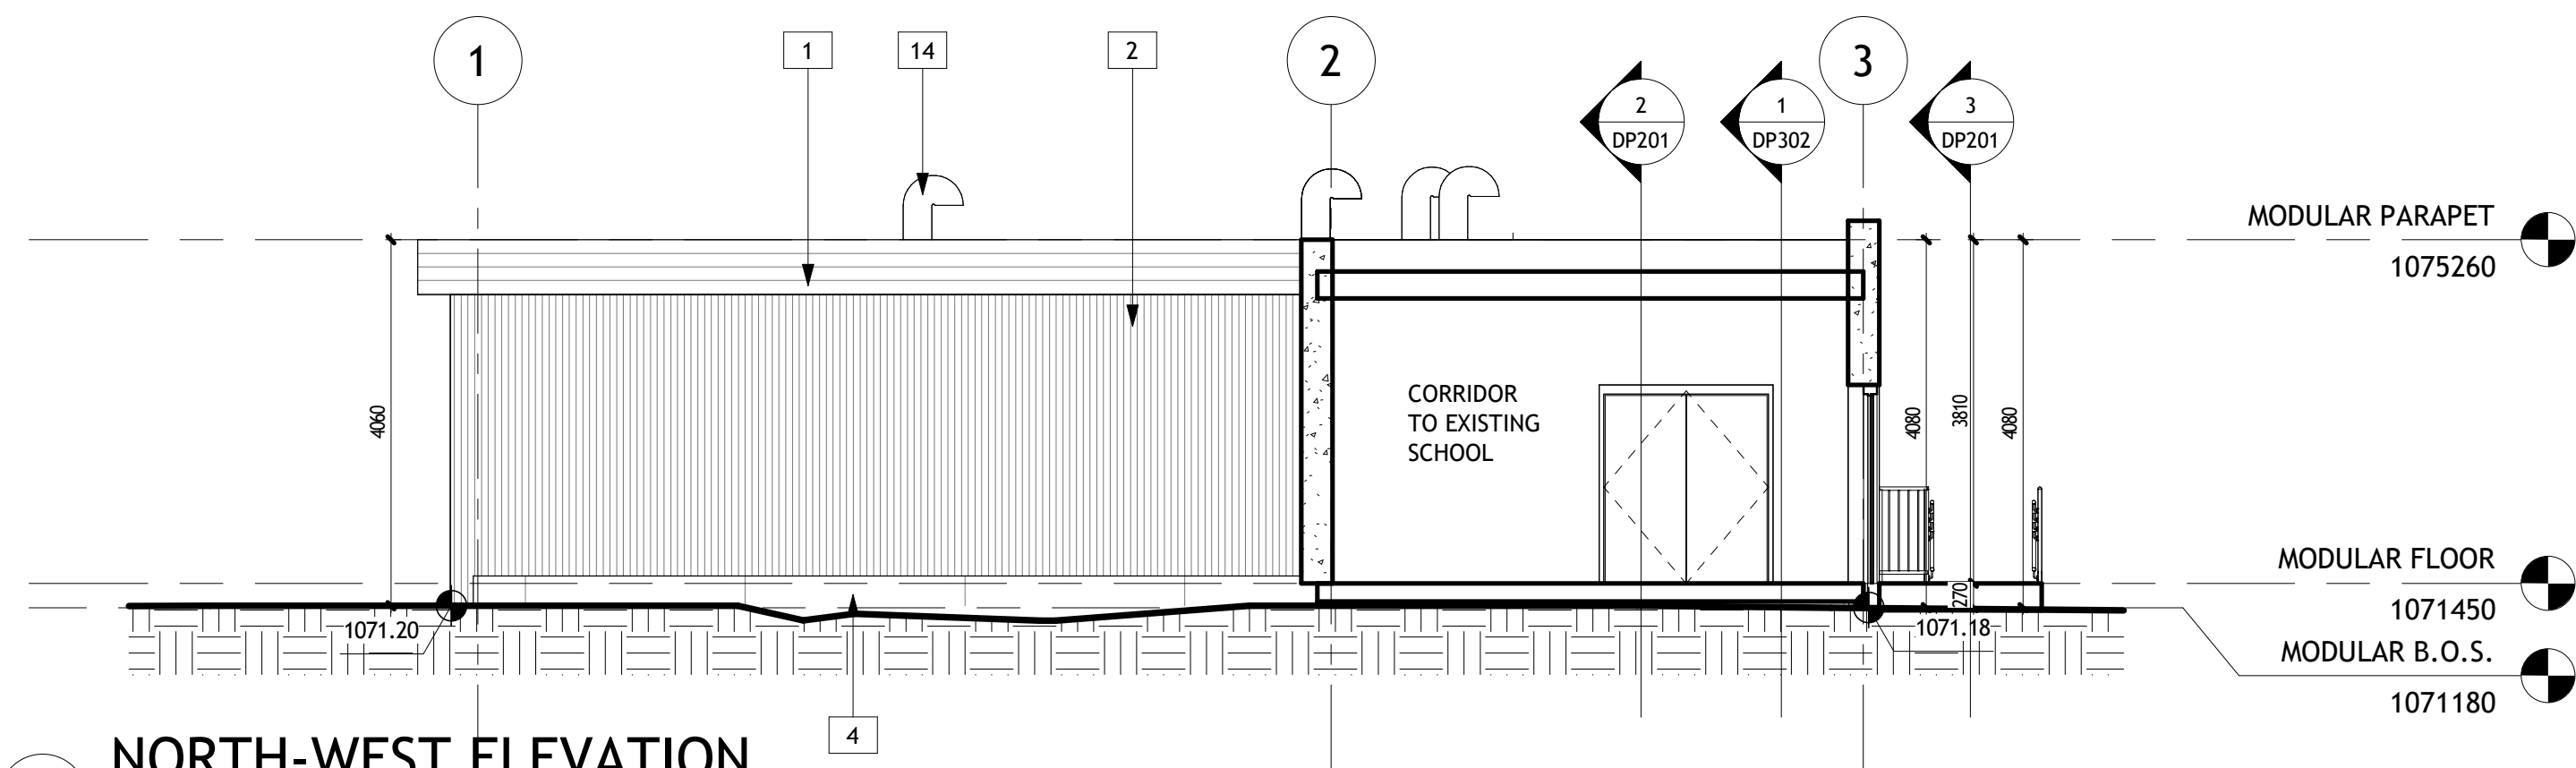

2 NORTH-WEST ELEVATION
1 : 75

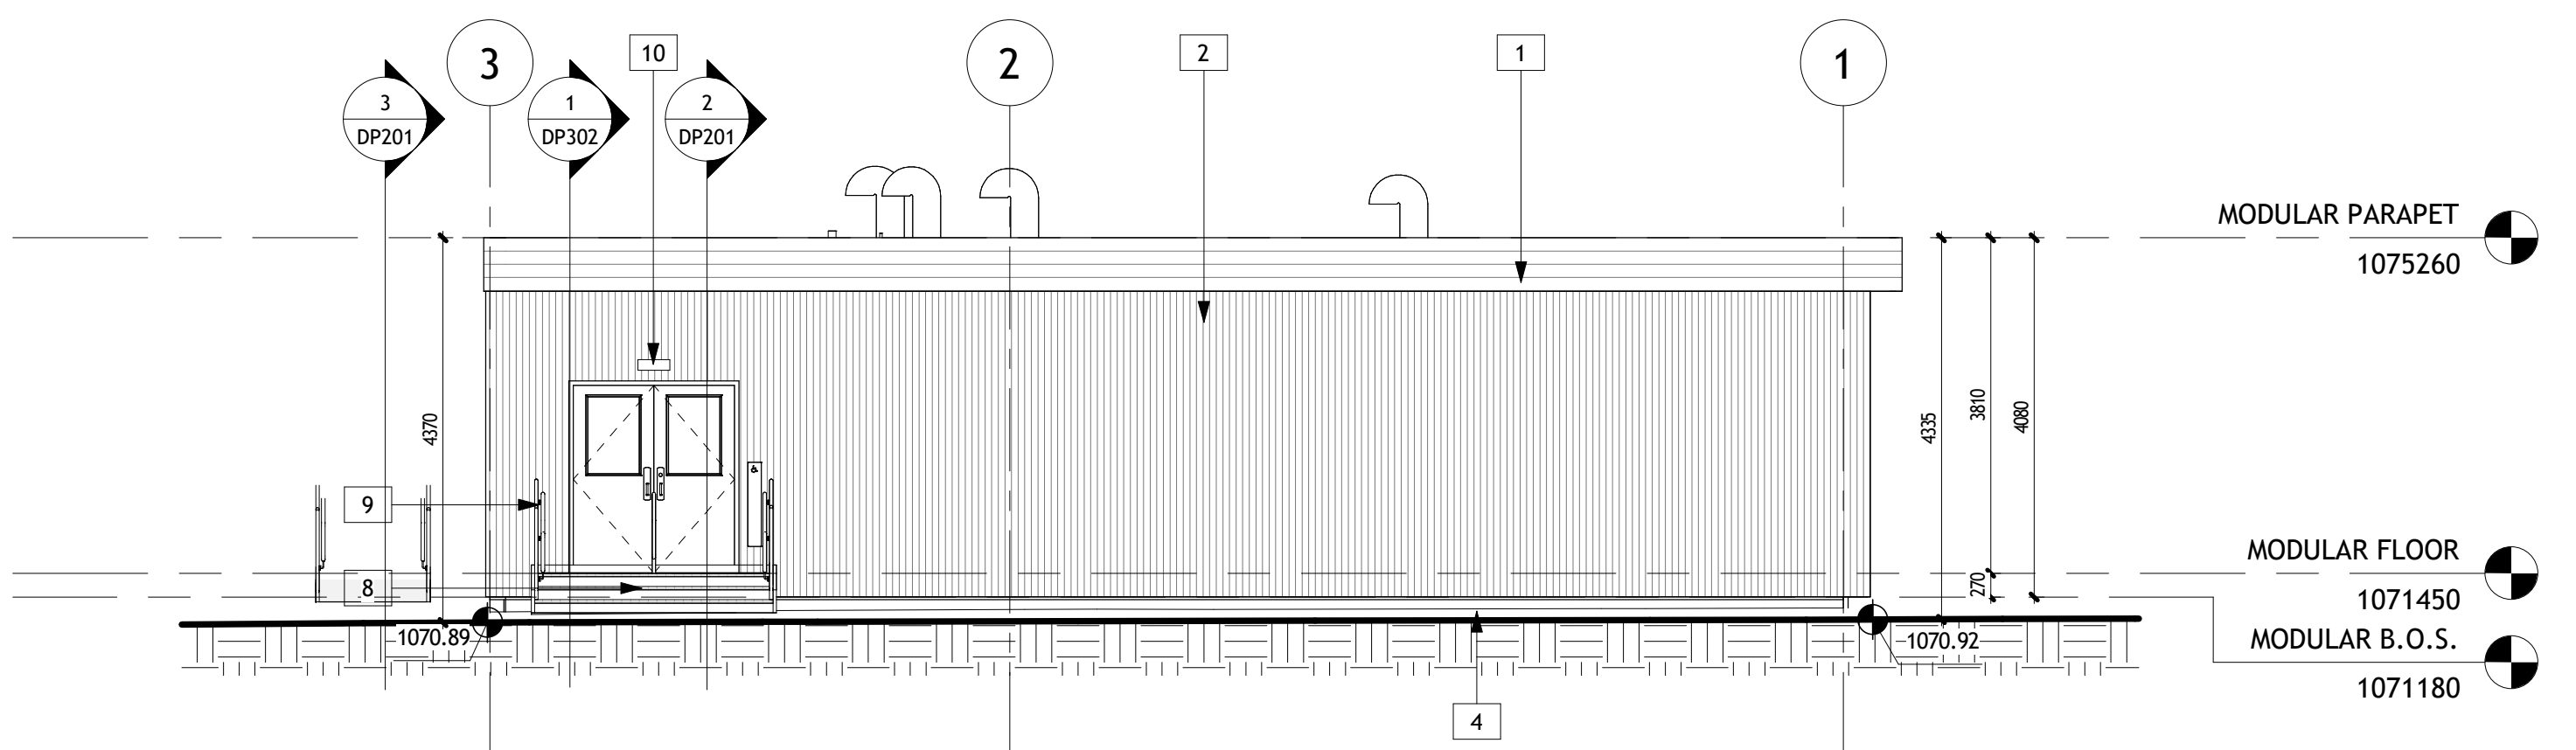

3 SOUTH-EAST ELEVATION
1 : 75

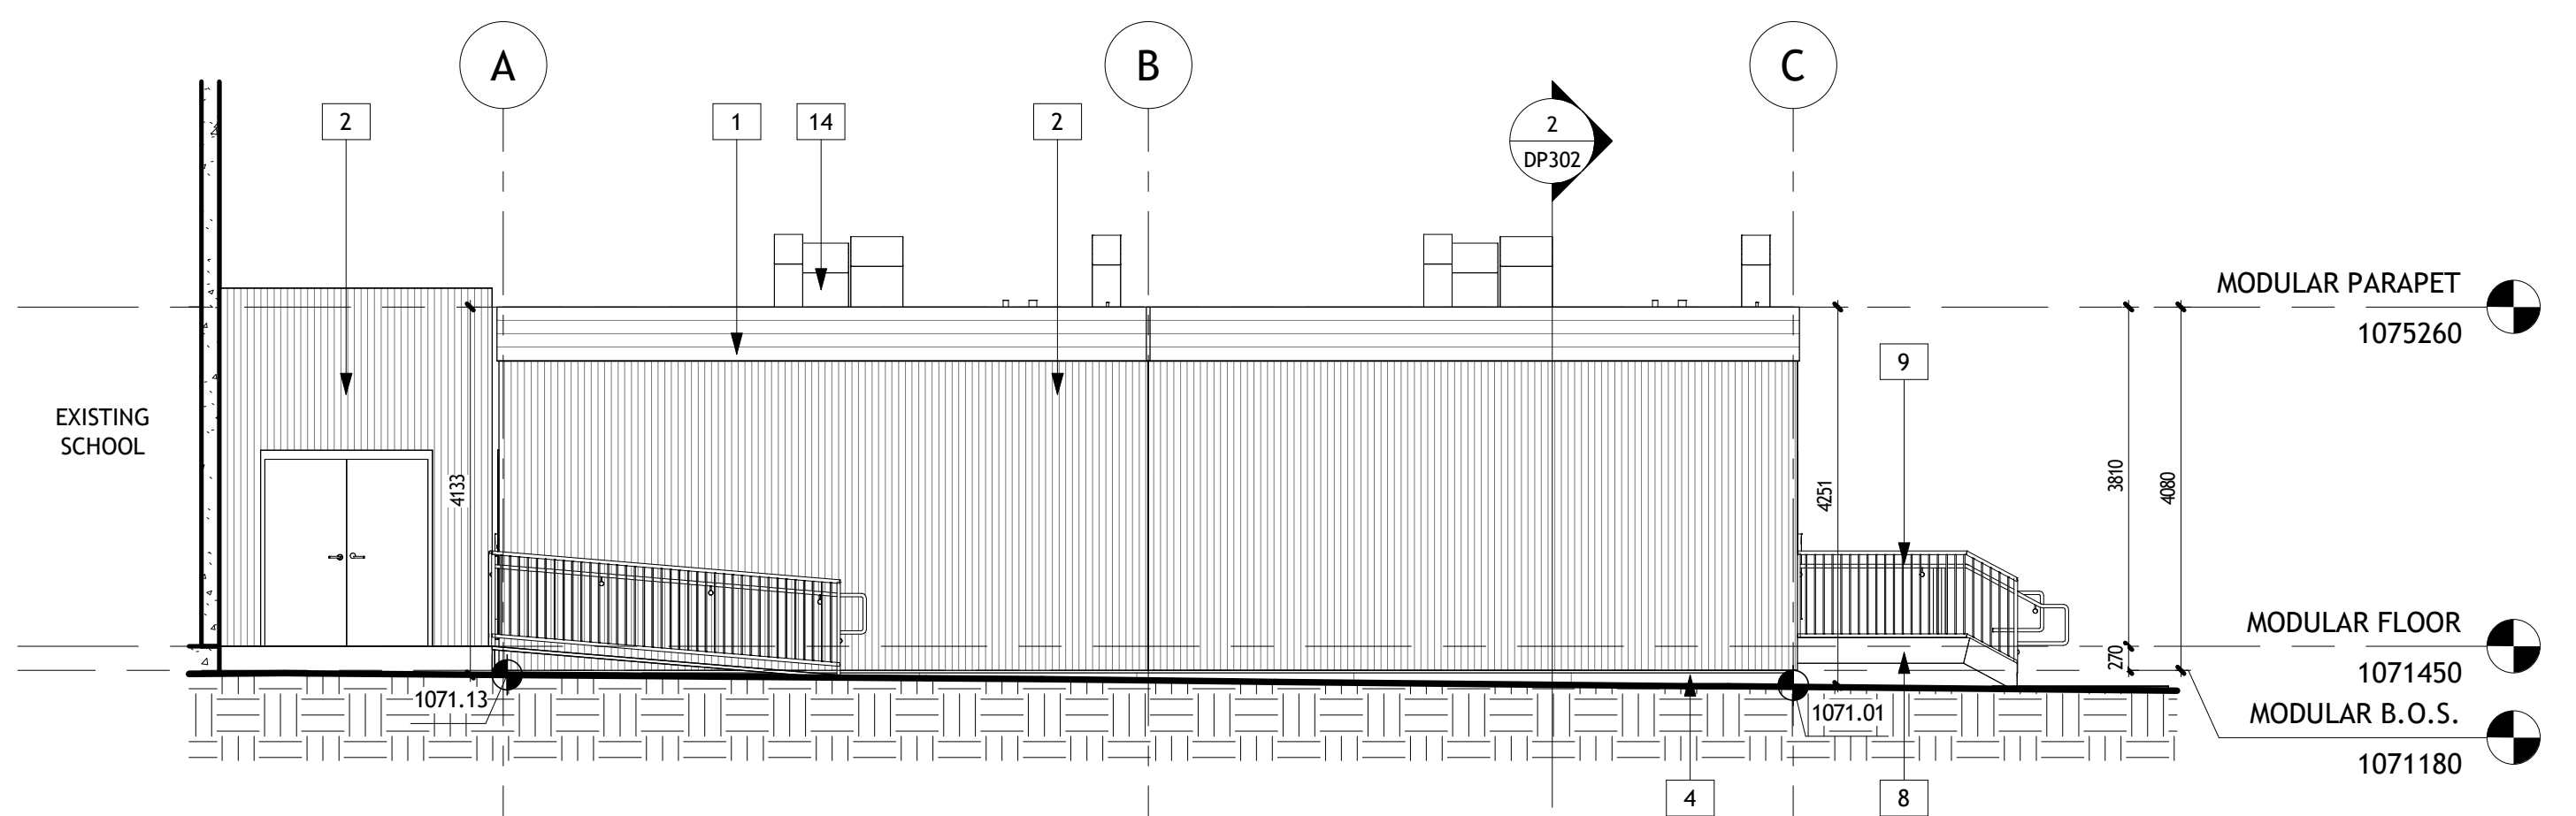

4 SOUTH-WEST ELEVATION
1 : 75

FINISHES LEGEND

- 1 EXISTING PREFINISHED 26-ga. RIBBON (CHARCOAL GREY)
- 2 EXISTING PREFINISHED 26-ga. CORRUGATED METAL (STONE GREY)
- 3 EXISTING TEXTURED CEMENT BOARD (CALIFORNIA TAUPE)
- 4 CONTRACTOR TO PROVIDE AND INSTALL NEW PLYWOOD SKIRTING TO SUIT. BENEATH ALL STAIRS, RAMPS AND ALONG MODULAR PERIMETER. (CALIFORNIA TAUPE)
- 5 CONTRACTOR TO PROVIDE AND INSTALL NEW PREFINISHED METAL FLASHING BETWEEN MODULAR UNITS (CHARCOAL GREY)
- 6 CONTRACTOR TO PROVIDE AND INSTALL NEW METAL VENT (STONE GREY) 900 X 300. VERIFY LOCATION W GRADING
- 7 CONTRACTOR TO PROVIDE AND INSTALL NEW METAL ACCESS VENT (STONE GREY) 500 X 900. VERIFY LOCATION W GRADING.
- 8 CONTRACTOR TO PROVIDE AND INSTALL NEW GALVANIZED METAL STAIR W/ GALVANIZED METAL RAILINGS
- 9 CONTRACTOR TO PROVIDE AND INSTALL NEW GALVANIZED METAL RAMP W/ GALVANIZED METAL RAILINGS
- 10 CONTRACTOR TO PROVIDE AND INSTALL NEW EXTERIOR LIGHT (SEE ELEC)
- 11 CONTRACTOR TO PROVIDE AND INSTALL NEW CARD READER (SEE ELEC)
- 12 CONTRACTOR TO INSATLL SLEEVE AND ADDITIONAL ABS PIPE C/W ELBOW TO DRAIN ON TO A PRE-CAST CONCRETE SPLASH PAD. THE SPLASH PAD SHOULD BE MIN. 24" LONG AND PINNED TO THE GROUND. REFER TO 4/A402 FOR VISUAL REFERENCE.
- 13 CONTRACTOR TO PROVIDE AND INSTALL NEW CONCRETE PAD
- 14 CONTRACTOR TO INSTALL MODUS PROVIDED TYP. MODULAR MECH GOOSENECK, AND PROVIDE ANY OTHER ROOF REQUIRED EQUIPMENT ITEMS (REFER TO A202 DETAILS) .
- 15 CONTRACTOR TO PROVIDE AND INSTALL NEW UTILITY SHROUD FOR ELEC & MECH TIE-INS (CHARCOAL GREY)

GENERAL ELEVATION NOTES:


1. CONTRACTOR TO REMOVE EXISTING WALL MOUNT LIGHTING, SPEAKER, AND RECEPTACLE IN THE IMPACTED AREA. REFER TO ELEC. DWGS.
2. NEW CARD READER TO BE INSTALLED. REFER TO ELEC. DWGS.
3. ALL CONTRACTORS ARE RESPONSIBLE FOR ANY/ALL DAMAGES TO THE EXISTING PREFINISHED STEEL SIDING. ALL AFFECTED AREAS TO BE REPAIRED AND MADE GOOD. MATCH EXISTING PREPAINTED, HOT DIPPED GALVANIZED, COMMERCIAL QUALITY SHEET AND CORRUGATED STEEL. PREPAINTED WITH KYNAR 500/HYLAR 5000 BY FIRESTONE UNA CLAD.

Client:



Consultant:

Seal:

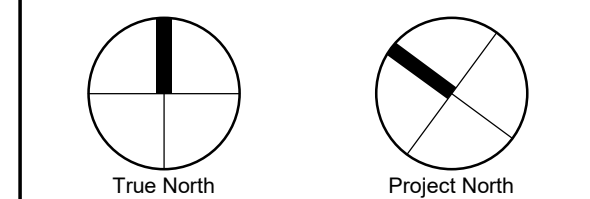

THIS COMPUTER GENERATED DRAWING IS AN INSTRUMENT OF SERVICE AND IS COPYRIGHT MATERIAL. USE ONLY FOR THIS PROJECT OR AS DIRECTED BY CYNCR ARCHITECTURE.

THIS IS A COPYRIGHT DRAWING AND SHALL NOT BE REPRODUCED OR REVISED WITHOUT WRITTEN PERMISSION AND MUST BE RETURNED AT COMPLETION OF WORK OR UPON REQUEST.


1	ISSUED FOR DP	2026-06-19
#	Revision	Date

MARLBOROUGH SCHOOL MODULAR ADDITION

Enter address here
Address Line 2

EXTERIOR ELEVATIONS

Project:	Project Number	DP301
Date:	03/31/22	
Drawn by:	Author	
Checked by:	Checker	
Scale:	As indicated	

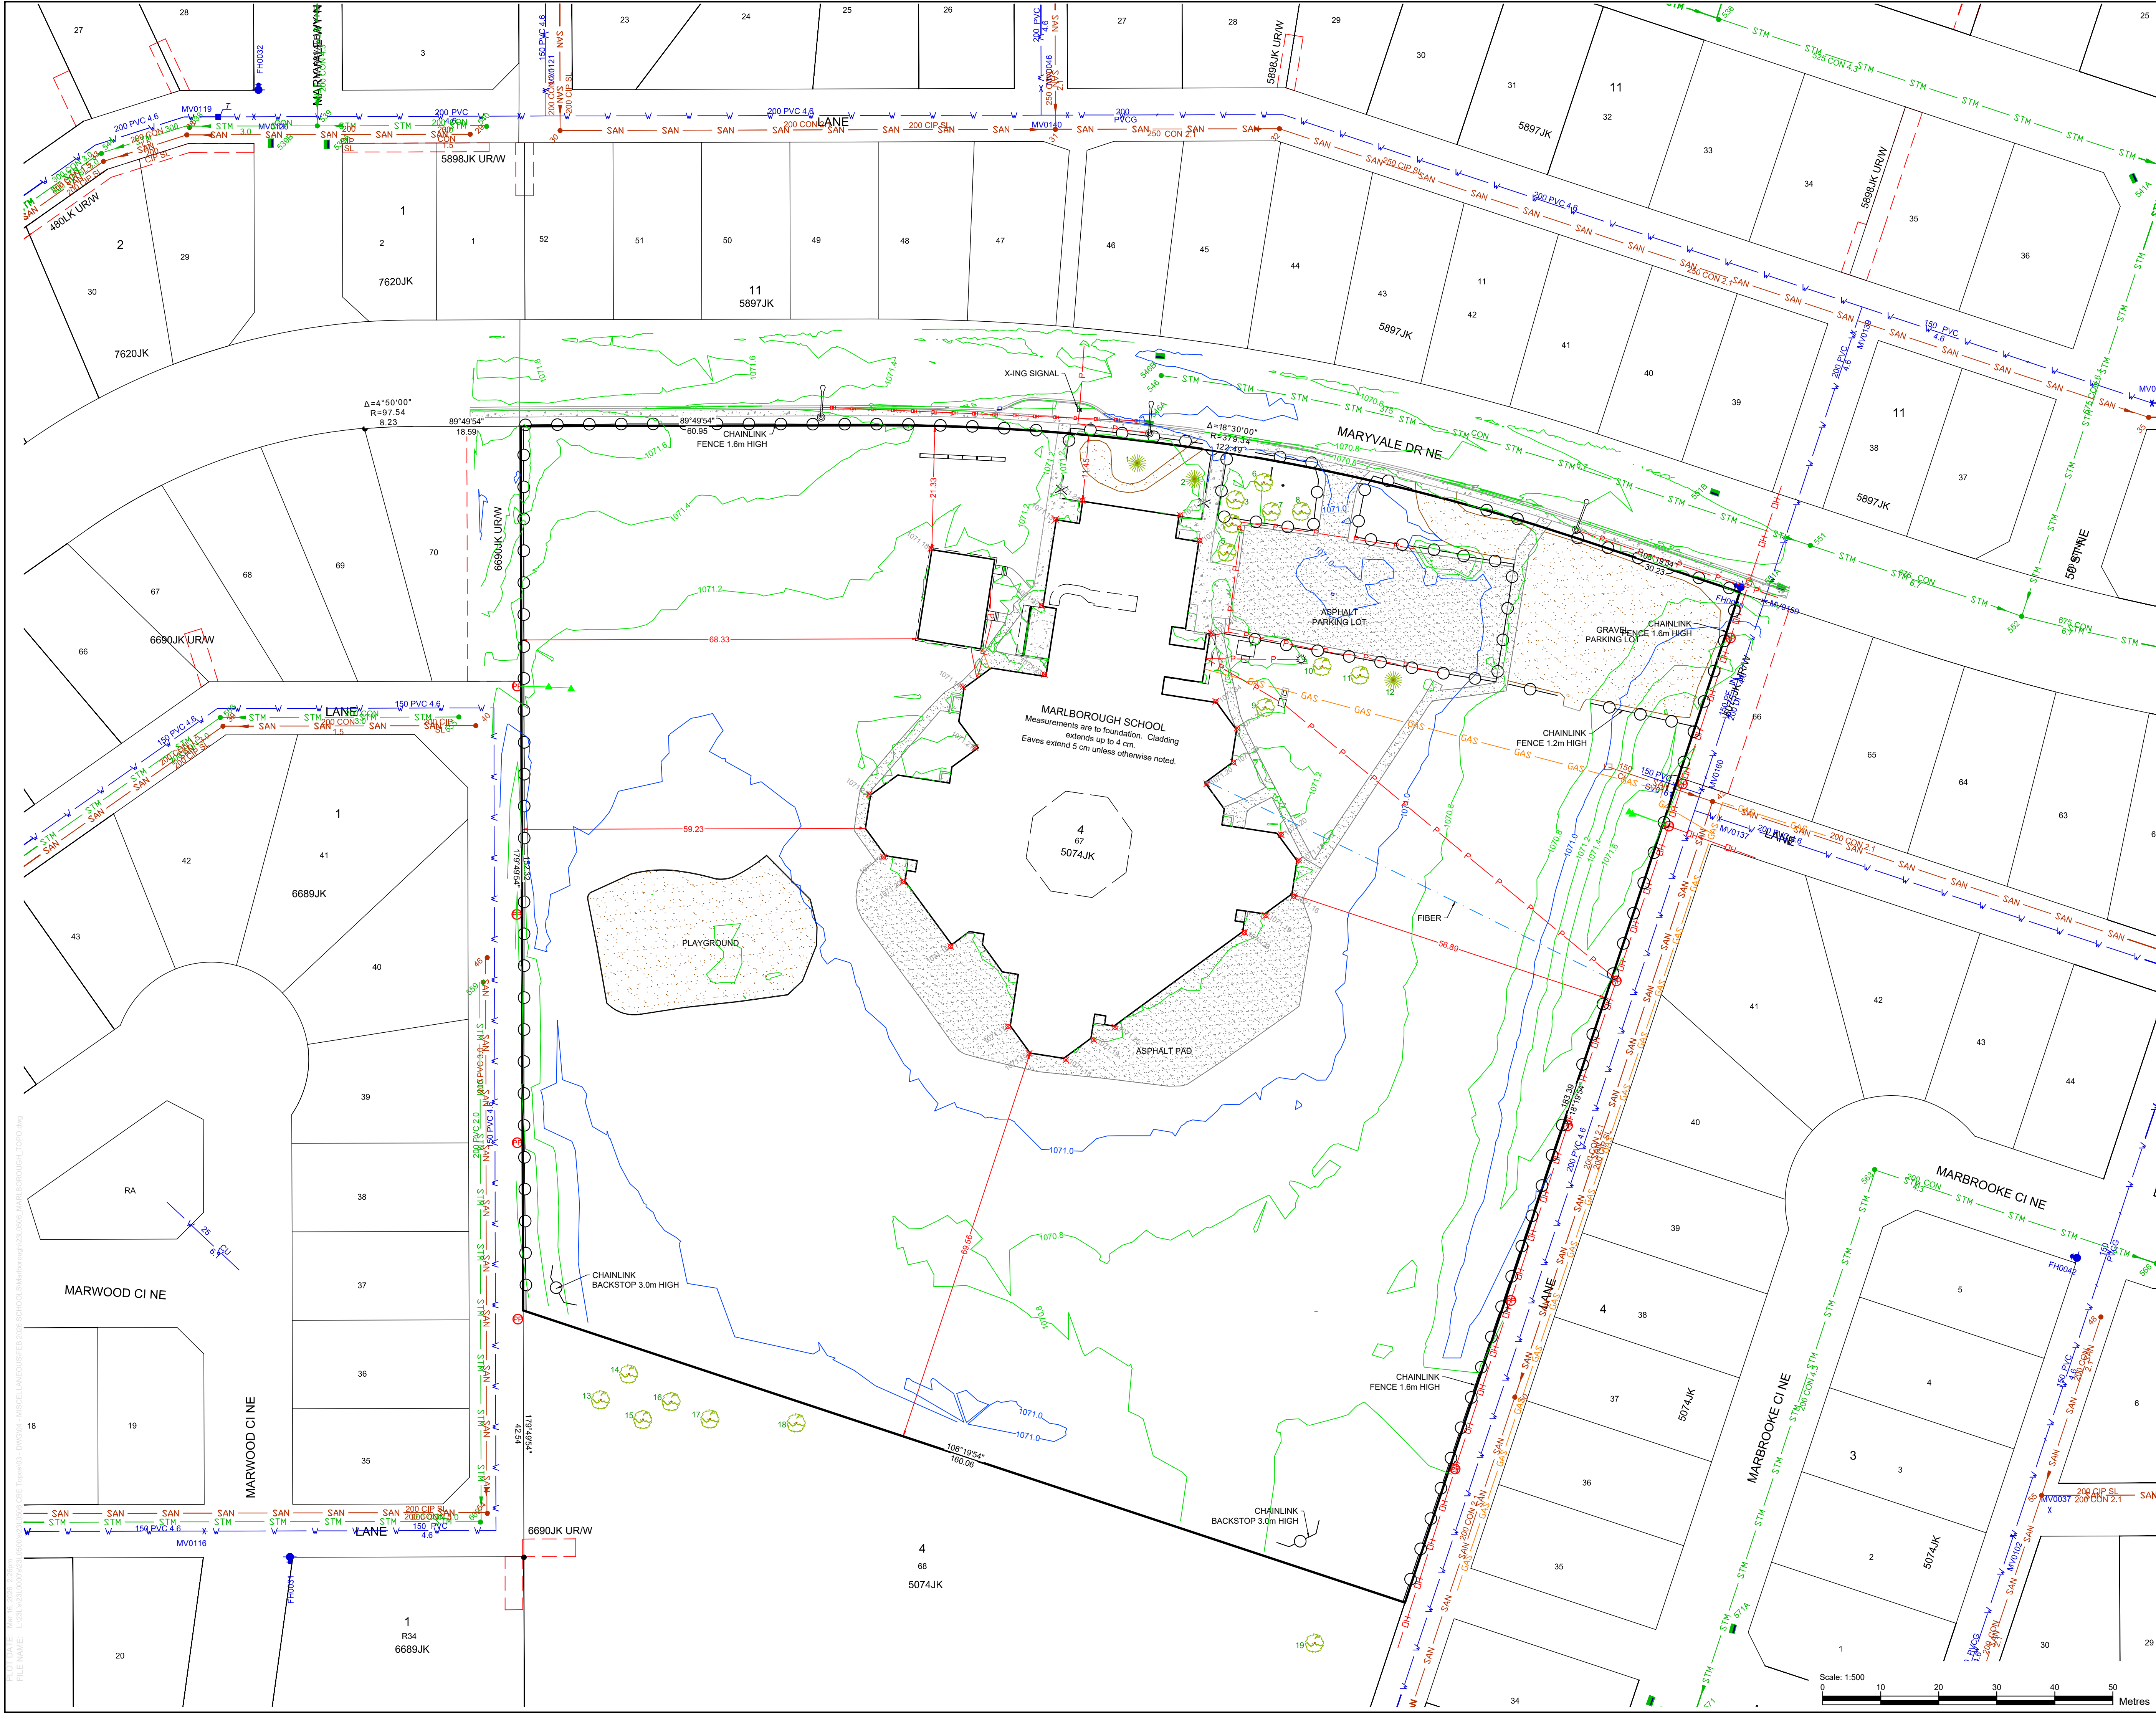

- Notes:
- DISTANCES ARE IN METERS AND DECIMALS THEREOF.
 - COORDINATES ARE BASED ON SURVEY TIES TO ASCM 114249.
 - COORDINATES ARE IN GROUND USING COMBINED SCALE FACTOR = 0.999734.
 - PROJECTION: 3 DEGREE TRANSVERSE MERCATOR (STM).
 - HORIZONTAL DATUM: NORTH AMERICA DATUM 1983 (NAD83).
 - ADOPTED VERTICAL DATUM: CANADIAN VERTICAL DATUM 1928 (CVD28) VIA HT2.0 GEOD MODEL.
 - ORTHOMETRIC REFERENCE MERIDIAN: 114° W.
 - ELEVATIONS SHOWN ARE GROUND SPOT ELEVATIONS.
 - ON-SITE BURIED UTILITIES WERE LOCATED USING INDIRECT DETECTION PROCEDURES AND ARE SHOWN FOR REFERENCE PURPOSES ONLY.
 - THE CONTRACTOR IS RESPONSIBLE FOR CONTACTING THE INDIVIDUAL UTILITY OWNERS, OPERATORS, OR AUTHORITIES TO OBTAIN ANY REQUIRED PERMITS AND METHODS OF LOCATING AND EXPOSING ANY BURIED FACILITIES PRIOR TO ANY PLANNED GROUND DISTURBANCE.
 - DEEP UTILITY LOCATIONS (STORM, SANITARY, WATER) WERE EXTRACTED FROM INFORMATION PUBLISHED BY THE CITY OF CALGARY.
 - THE LANDS DESCRIBED WITHIN THIS PLAN ARE/ARE NOT WITHIN THE CITY OF CALGARY FLOOD FRINGE.
 - PROPERTY IS SUBJECT TO CAVEAT 2070KD.

- Legend:
- 1110.0 - MAJOR CONTOUR 1.0m. INTERVAL
 - 1110.2 - MINOR CONTOUR 0.2m. INTERVAL
 - SPOT ELEVATION
 - FOUND STATUTORY IRON POST
 - SUBJECT PARCEL BOUNDARY
 - ADJACENT PARCEL LINEWORK
 - RIGHT OF WAY BOUNDARY
 - FENCE
 - FENCE - CHAINLINK
 - FENCE - POST AND CABLE
 - POWER POLE
 - GUY WIRE
 - LIGHT STANDARD
 - MANHOLE
 - FIRE HYDRANT
 - VALVE
 - SIGN
 - OUTLET ON CONC. BASE
 - SPOTLIGHT ON CONC. BASE
 - ELECTRICAL LINES - BURIED
 - ELECTRICAL LINES - OVERHEAD
 - GAS LINE
 - STORM LINE
 - SANITARY LINE
 - COMMUNICATIONS - BURIED LINE
 - COMMUNICATIONS - OVERHEAD LINE
 - WATER MAIN
 - CULVERT
 - DECIDUOUS TREE
 - CONIFEROUS TREE
 - SHRUBS/BUSHES

00	ISSUED TO CLIENT	J.D.	MAR. 16, 2026	J.D.
No.	Revision Description	By	Date	Appr

Title: TOPOGRAPHIC SITE SURVEY
SITE FEATURES

Job Description:
LOT 67, BLOCK 4, PLAN 5074JK
4711 Maryvale Drive N.E.
Calgary Alberta

Client:
 Calgary Board of Education

Watt Consulting Group Ltd.
1300, 736 6th Avenue S.W.
Calgary, AB, T2P 3T7
T. 403.273.9001
F. 403.273.3440
www.wattconsultinggroup.com

Drawn: N.K.	Field Surveyor(s): R.K./N.K.
Draft Chk: J.D.	Survey Date: MAR. 3-4, 2026
Approved: J.D.	Date: MAR. 10, 2026
Scale: 1:500	File #: 23L0506
	Sheet: 01
	Total Sheets: 02