



BOWDALE CRESCENT NW

THE REMAINDER OF LOT 11
EXISTING RESIDENTIAL

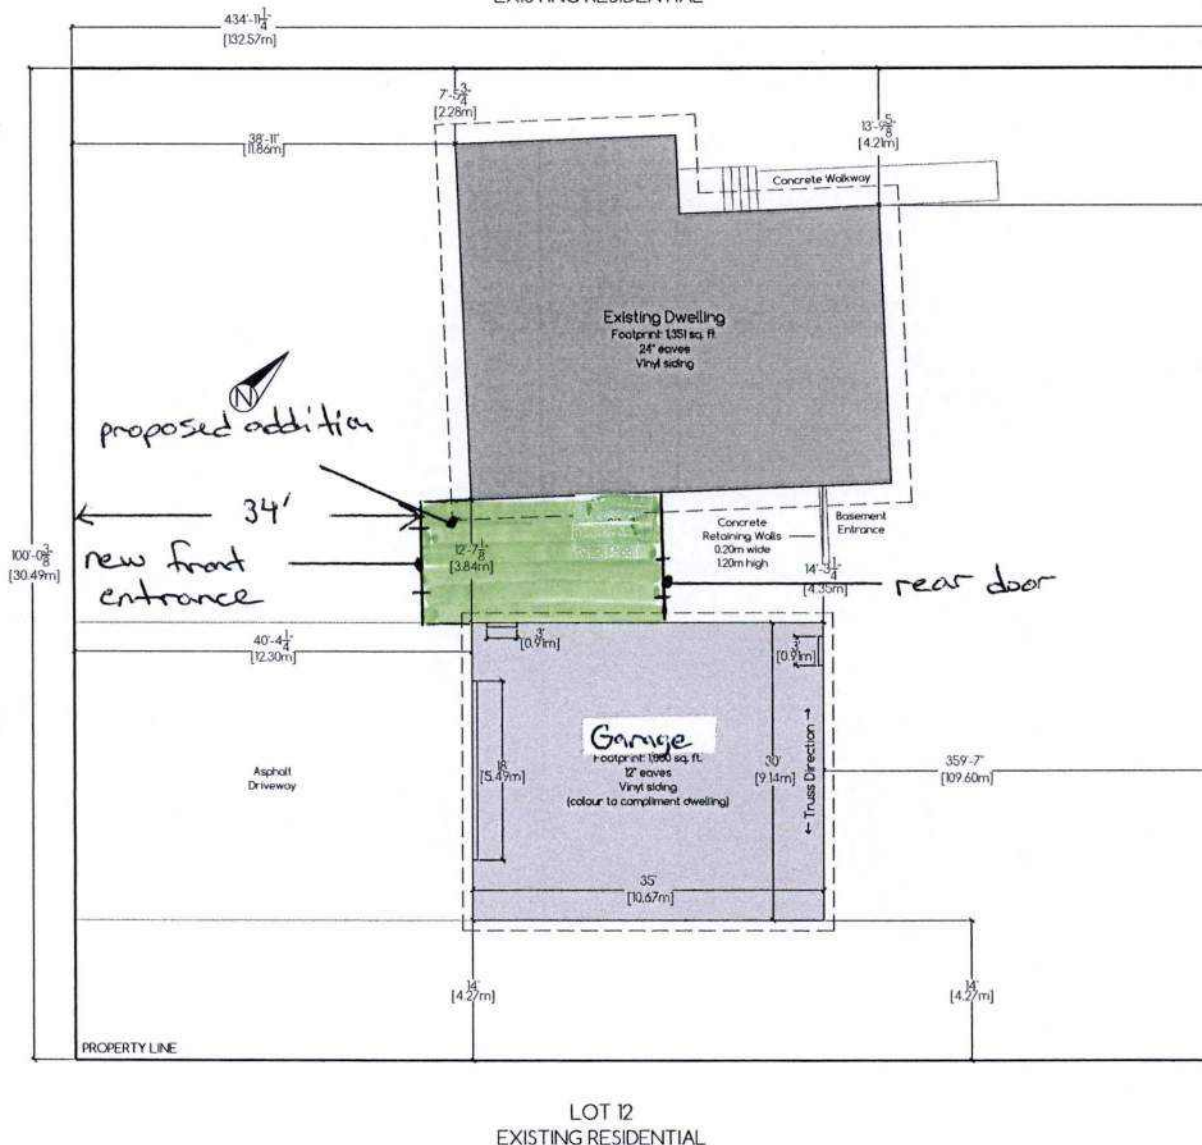

1:150

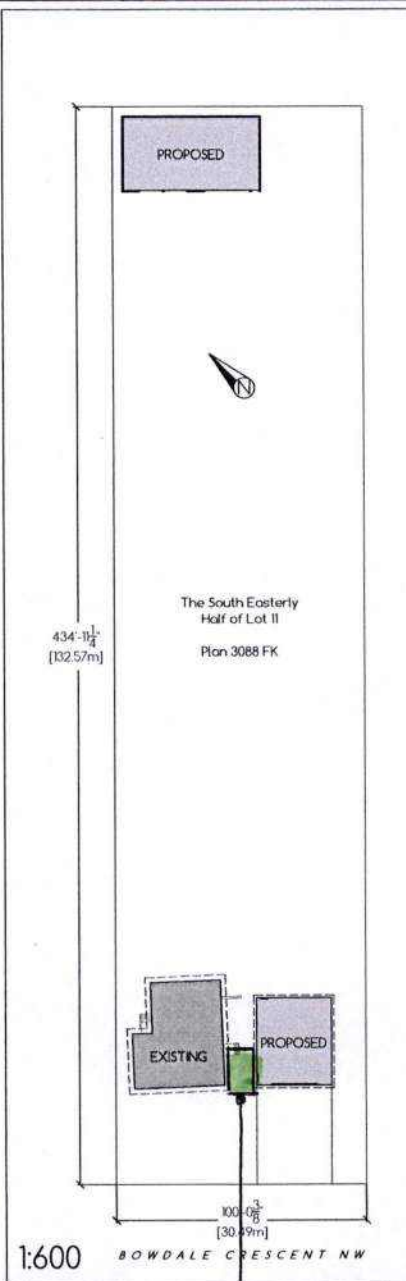

1:600

44 Bowdale
Crescent NW

Calgary, AB

Site Plan

The South Easterly
Half of Lot 11
Plan 3088 FK

Parcel
Coverage: 12.39%

 
ARB
Coverage: 250.84m²

A5.0

Address: 44 Bowdale Cr NW
Date: May 2020
Drawn By: Chad Ruppert
Scale: *varies*

garage
permits.ca

proposed addition
to connect home and garage



- A2.1 Main Floor Plan
- A2.2 Roof Plan
- A3.1 Elevations
- A4.1 Building Sections
- A6.1 Interior Views
- E1.1 Electrical/Lighting Plans

[illegible]

Project number	007-2026
Revision Date	06/16/2026
Drawn by	H.Meaney
Checked by	HM

A3.1

SCALE 1" = 1'

END WALL
HOUSE

16'

END WALL
GARAGE

13'3"

20'

