
 


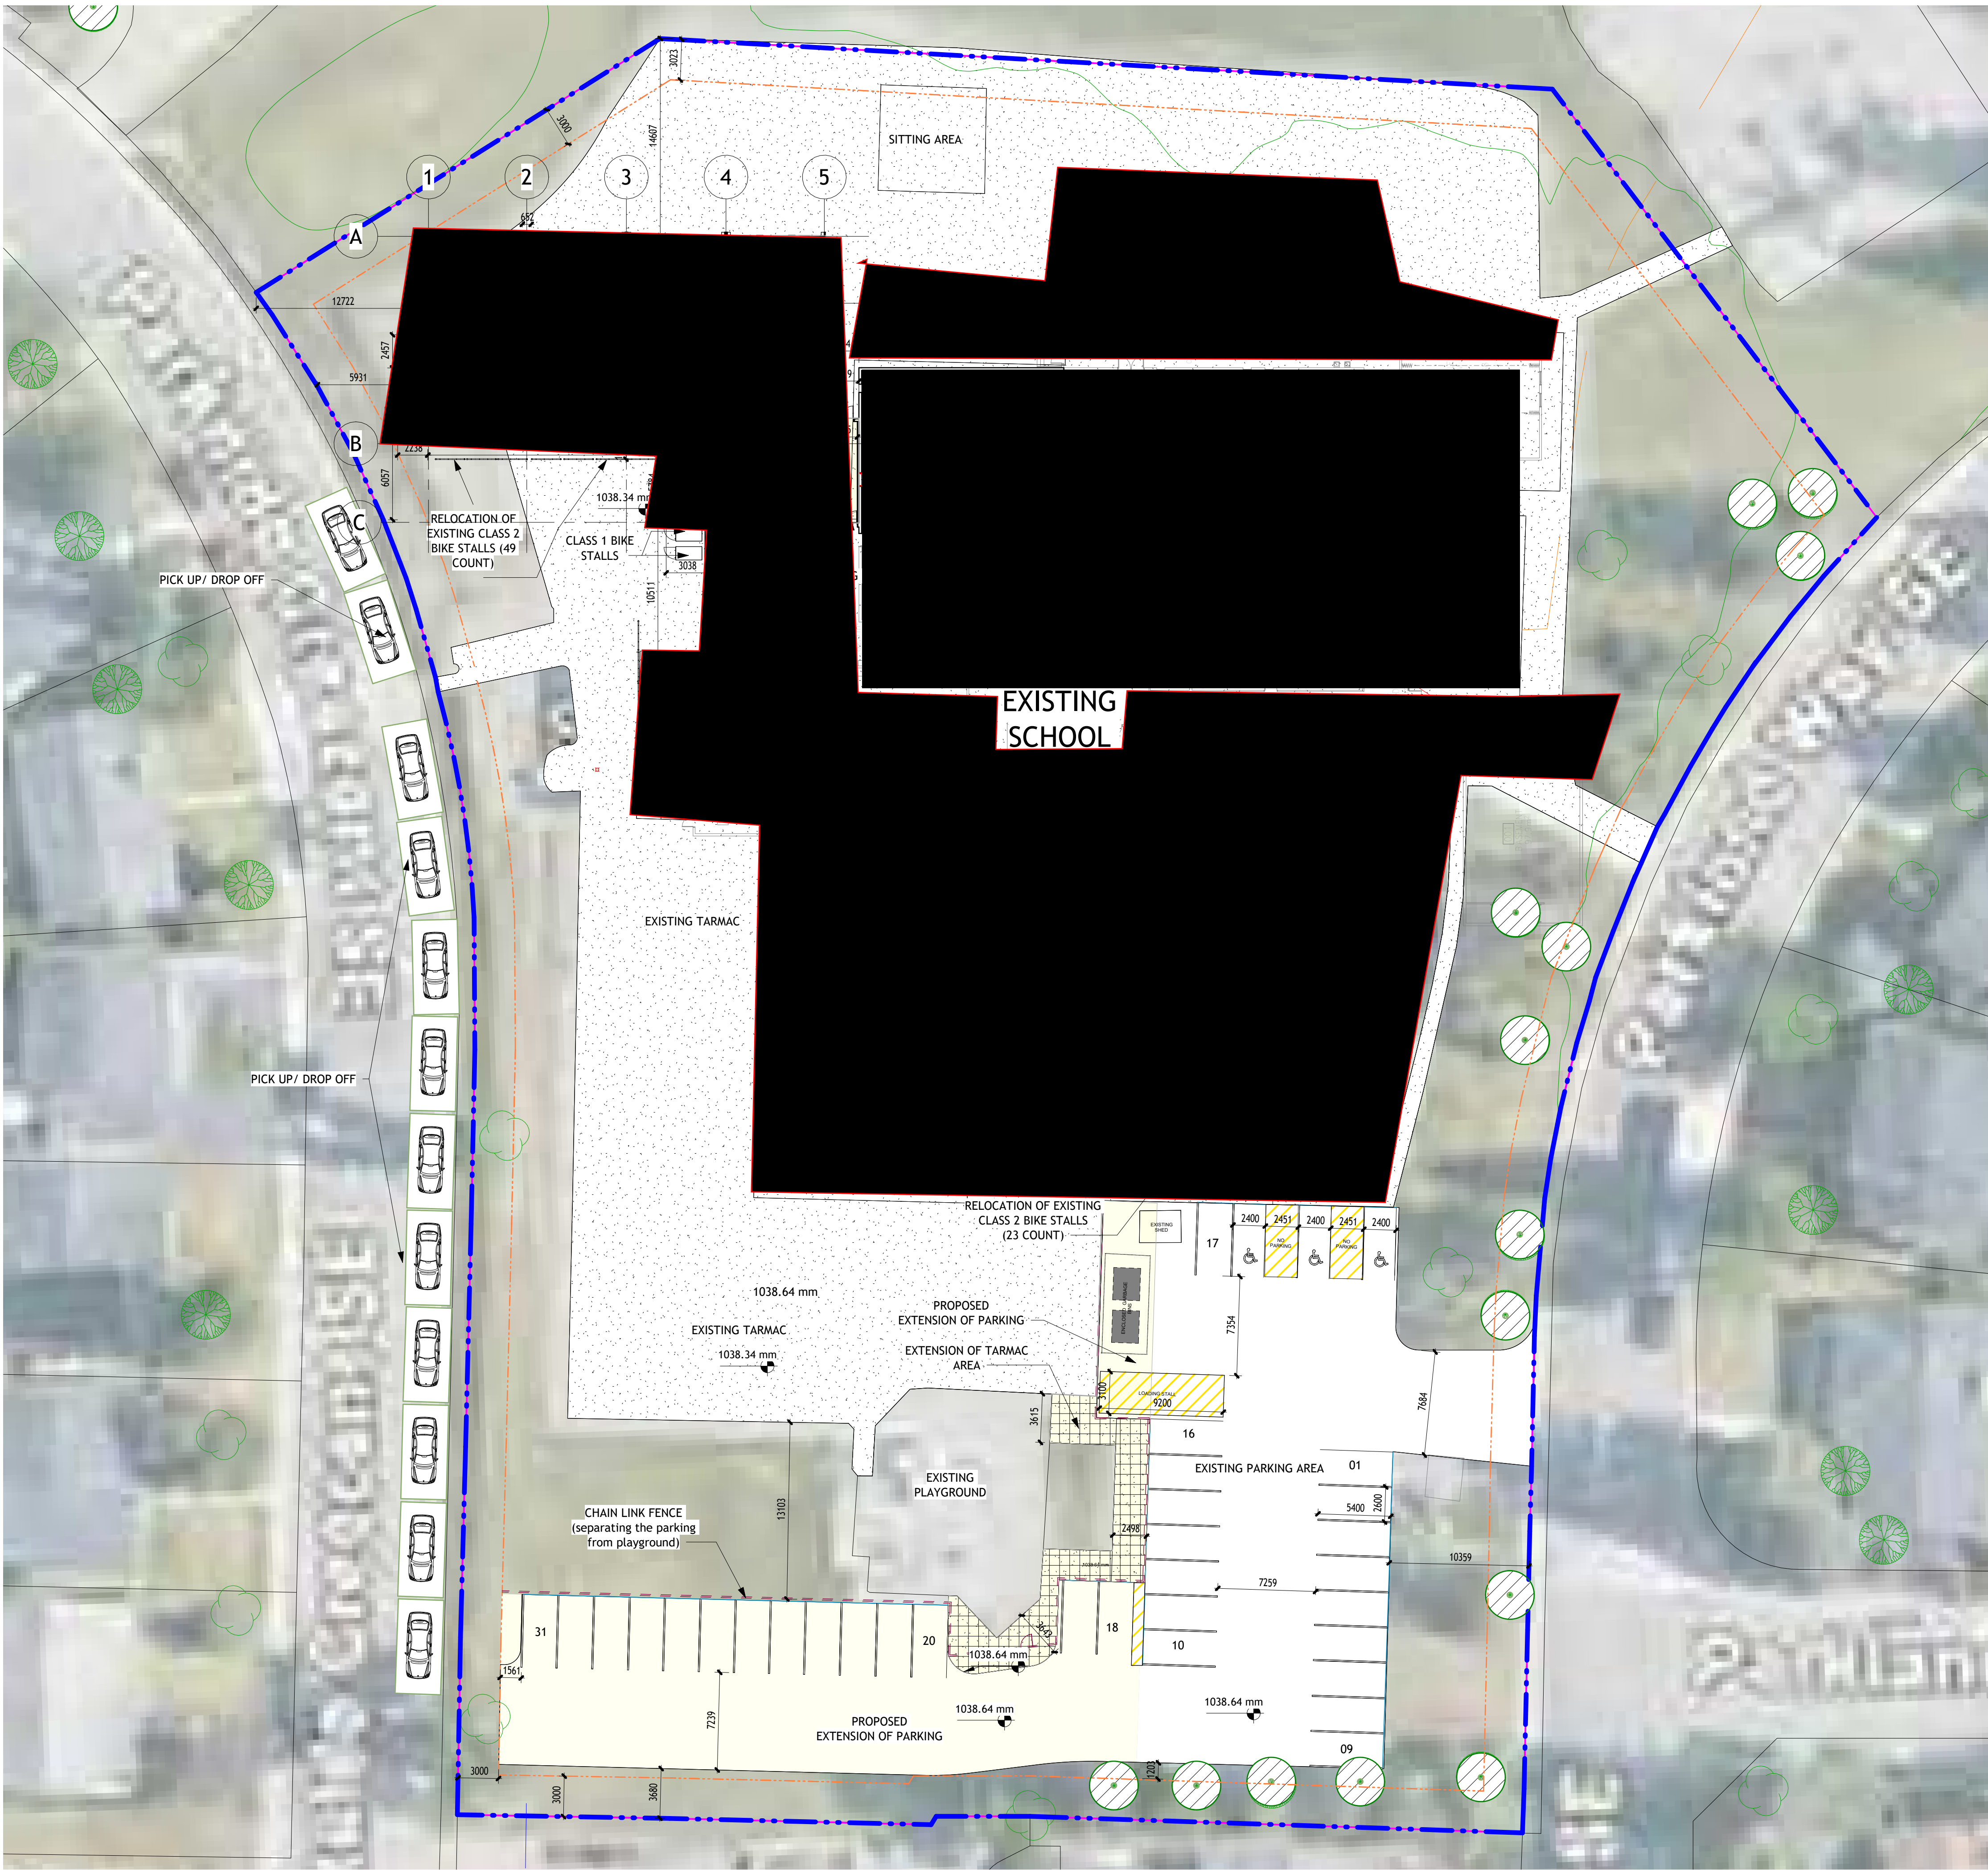

1 Site Plan
1 : 250


- KEY NOTES**
-  PICK UP AND DROP OFF
 -  PROPOSED DESIGN
 -  PROPERTY LINE
 -  SET BACK

Client:



Consultant:

Seal:

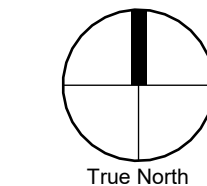

THIS COMPUTER GENERATED DRAWING IS AN INSTRUMENT OF SERVICE AND IS COPYRIGHT MATERIAL. USE ONLY FOR THIS PROJECT OR AS DIRECTED BY CYNC ARCHITECTURE.

THIS IS A COPYRIGHT DRAWING AND SHALL NOT BE REPRODUCED OR REVISED WITHOUT WRITTEN PERMISSION AND MUST BE RETURNED AT COMPLETION OF WORK OR UPON REQUEST.

01	ISSUE FOR DP	2026.08.21

**PRINCE OF WALES SCHOOL
MODULAR
ADDITION**

253 Parkland Way SE, Calgary, AB

SITE PLAN


Project:	2026-14	A101
Date:	03/31/22	
Drawn by:	Author	
Checked by:	Checker	
Scale:	As indicated	

GENERAL ELEVATION NOTES:


1. CONTRACTOR TO REMOVE EXISTING WALL MOUNT LIGHTING, SPEAKER, AND RECEPTACLE IN THE IMPACTED AREA. REFER TO ELEC. DWGS.
2. NEW CARD READER TO BE INSTALLED. REFER TO ELEC. DWGS.
3. ALL CONTRACTORS ARE RESPONSIBLE FOR ANYALL DAMAGES TO THE EXISTING PREFINISHED STEEL SIDING. ALL AFFECTED AREAS TO BE REPAIRED AND MADE GOOD. MATCH EXISTING PREPAINTED, HOT DIPPED GALVANIZED, COMMERCIAL QUALITY SHEET AND CORRUGATED STEEL. PREPAINTED WITH KYNAR 500/HYLAR 5000 BY FIRESTONE UNA CLAD.

FLOOR PLAN GENERAL NOTES:


1. EXISTING PREFINISHED 26-ga. RIBBON (CHARCOAL GREY)
2. EXISTING PREFINISHED 26-ga. CORRUGATED METAL (STONE GREY)
3. EXISTING TEXTURED CEMENT BOARD (CALIFORNIA TAUPE)
4. CONTRACTOR TO PROVIDE AND INSTALL NEW PLYWOOD SKIRTING TO SUIT BENEATH ALL STAIRS, RAMPS AND ALONG MODULAR PERIMETER. (CALIFORNIA TAUPE)
5. CONTRACTOR TO PROVIDE AND INSTALL NEW PREFINISHED METAL FLASHING BETWEEN MODULAR UNITS (CHARCOAL GREY)
6. CONTRACTOR TO PROVIDE AND INSTALL NEW METAL VENT (STONE GREY) 900 X 300. VERIFY LOCATION W GRADING
7. CONTRACTOR TO PROVIDE AND INSTALL NEW METAL ACCESS VENT (STONE GREY) 500 X 900. VERIFY LOCATION W GRADING.
8. CONTRACTOR TO PROVIDE AND INSTALL NEW GALVANIZED METAL STAIR W/ GALVANIZED METAL RAILINGS
9. CONTRACTOR TO PROVIDE AND INSTALL NEW GALVANIZED METAL RAMP W/ GALVANIZED METAL RAILINGS.
10. CONTRACTOR TO PROVIDE AND INSTALL NEW EXTERIOR LIGHT (SEE ELEC)
11. CONTRACTOR TO PROVIDE AND INSTALL NEW CARD READER (SEE ELEC)
12. CONTRACTOR TO INSATLL SLEEVE AND ADDITIONAL ABS PIPE C/W ELBOW TO DRAIN ON TO A PRE-CAST CONCRETE SPLASH PAD. THE SPLASH PAD SHOULD BE MIN. 24" LONG AND PINNED TO THE GROUND. REFER TO 4/A402 FOR VISUAL REFERENCE.
13. CONTRACTOR TO PROVIDE AND INSTALL NEW CONCRETE PAD
14. CONTRACTOR TO INSTALL MODUS PROVIDED TYP. MODULAR MECH GOOSENECK, AND PROVIDE ANY OTHER ROOF REQUIRED EQUIPMENT ITEMS (REFER TO A202 DETAILS).
15. CONTRACTOR TO PROVIDE AND INSTALL NEW UTILITY SHROUD FOR ELEC & MECH TIE-INS (CHARCOAL GREY)

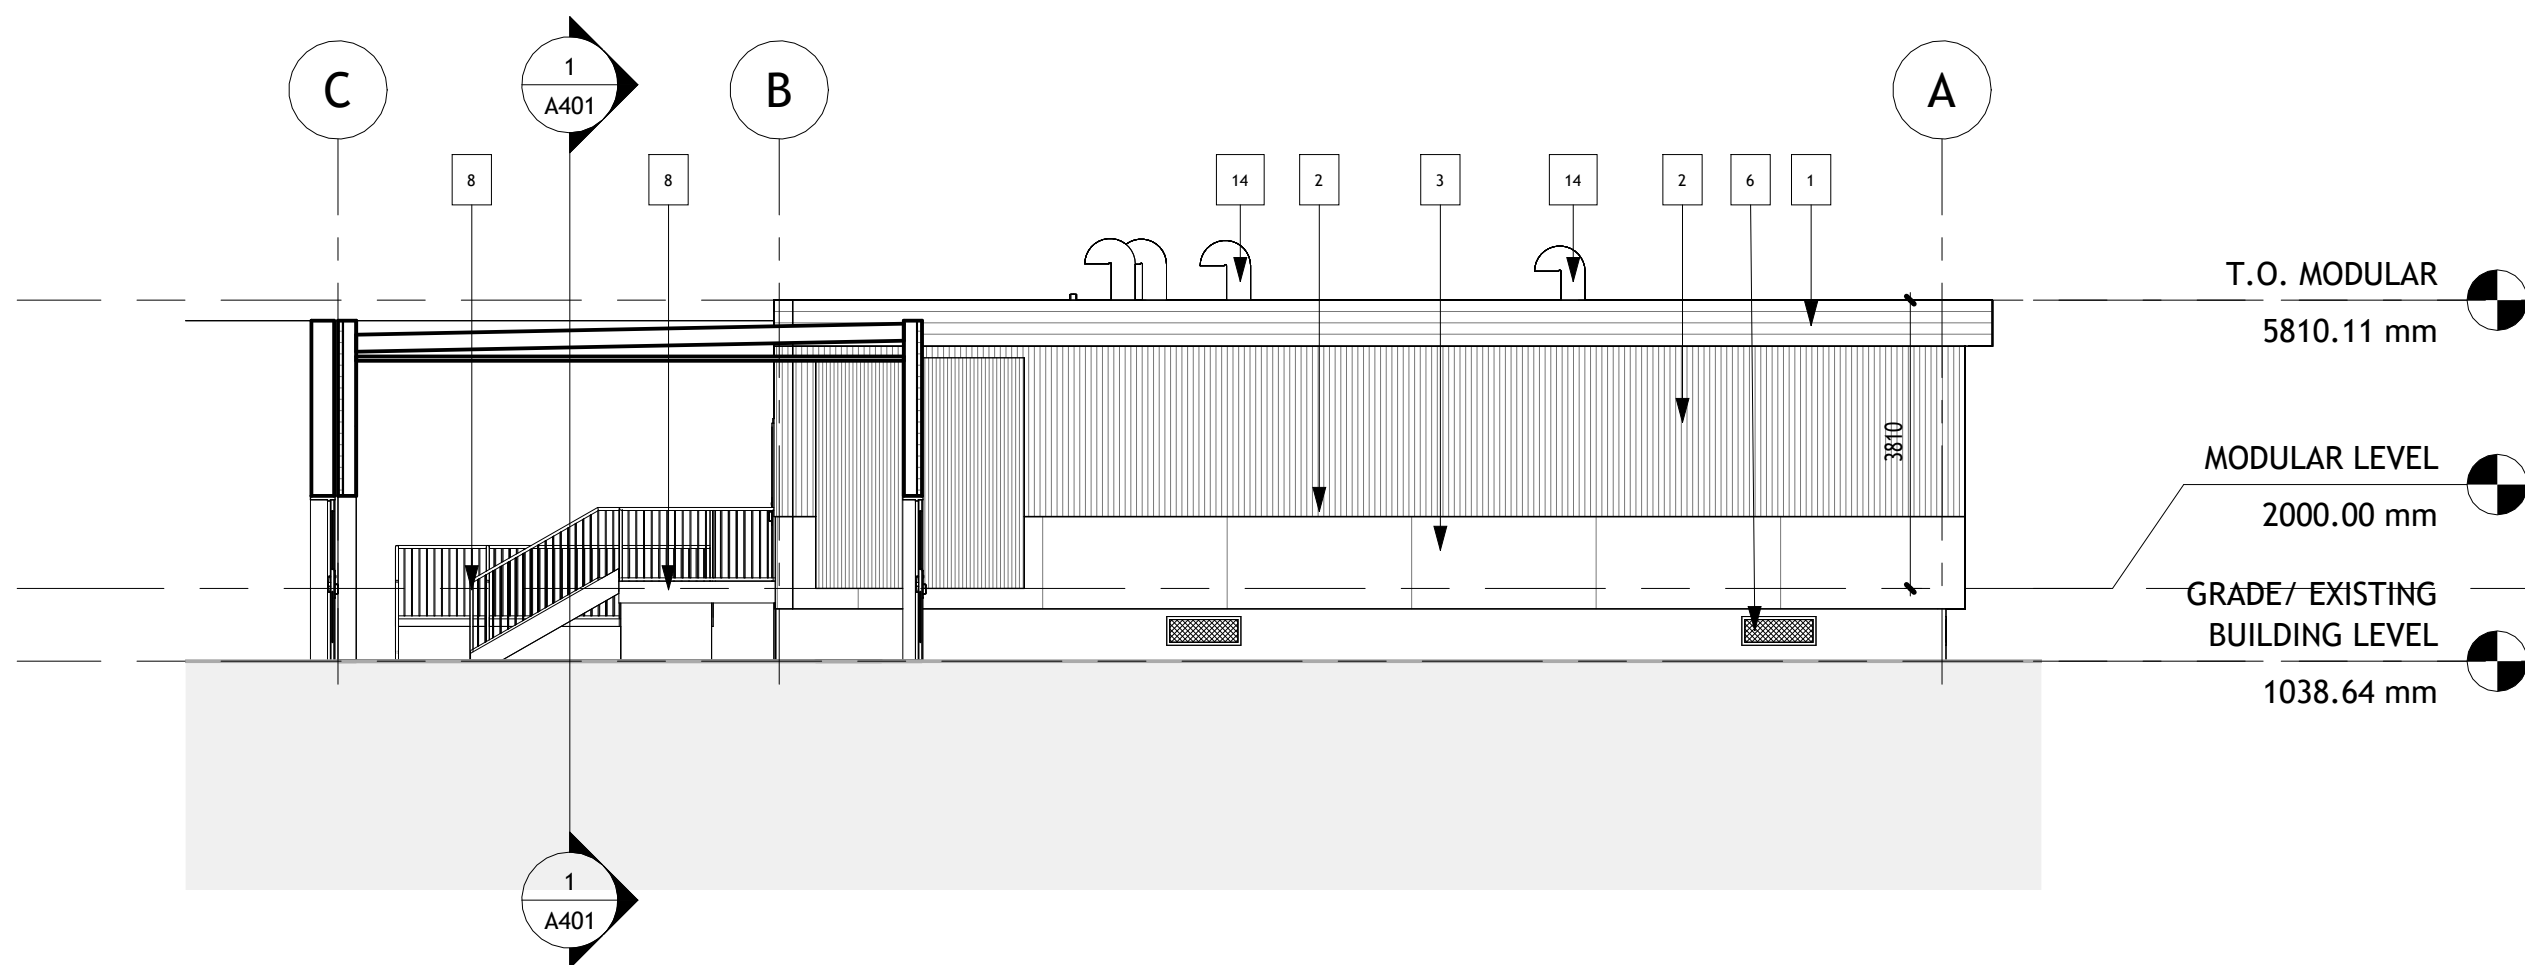


1 EAST ELEVATION
1 : 100

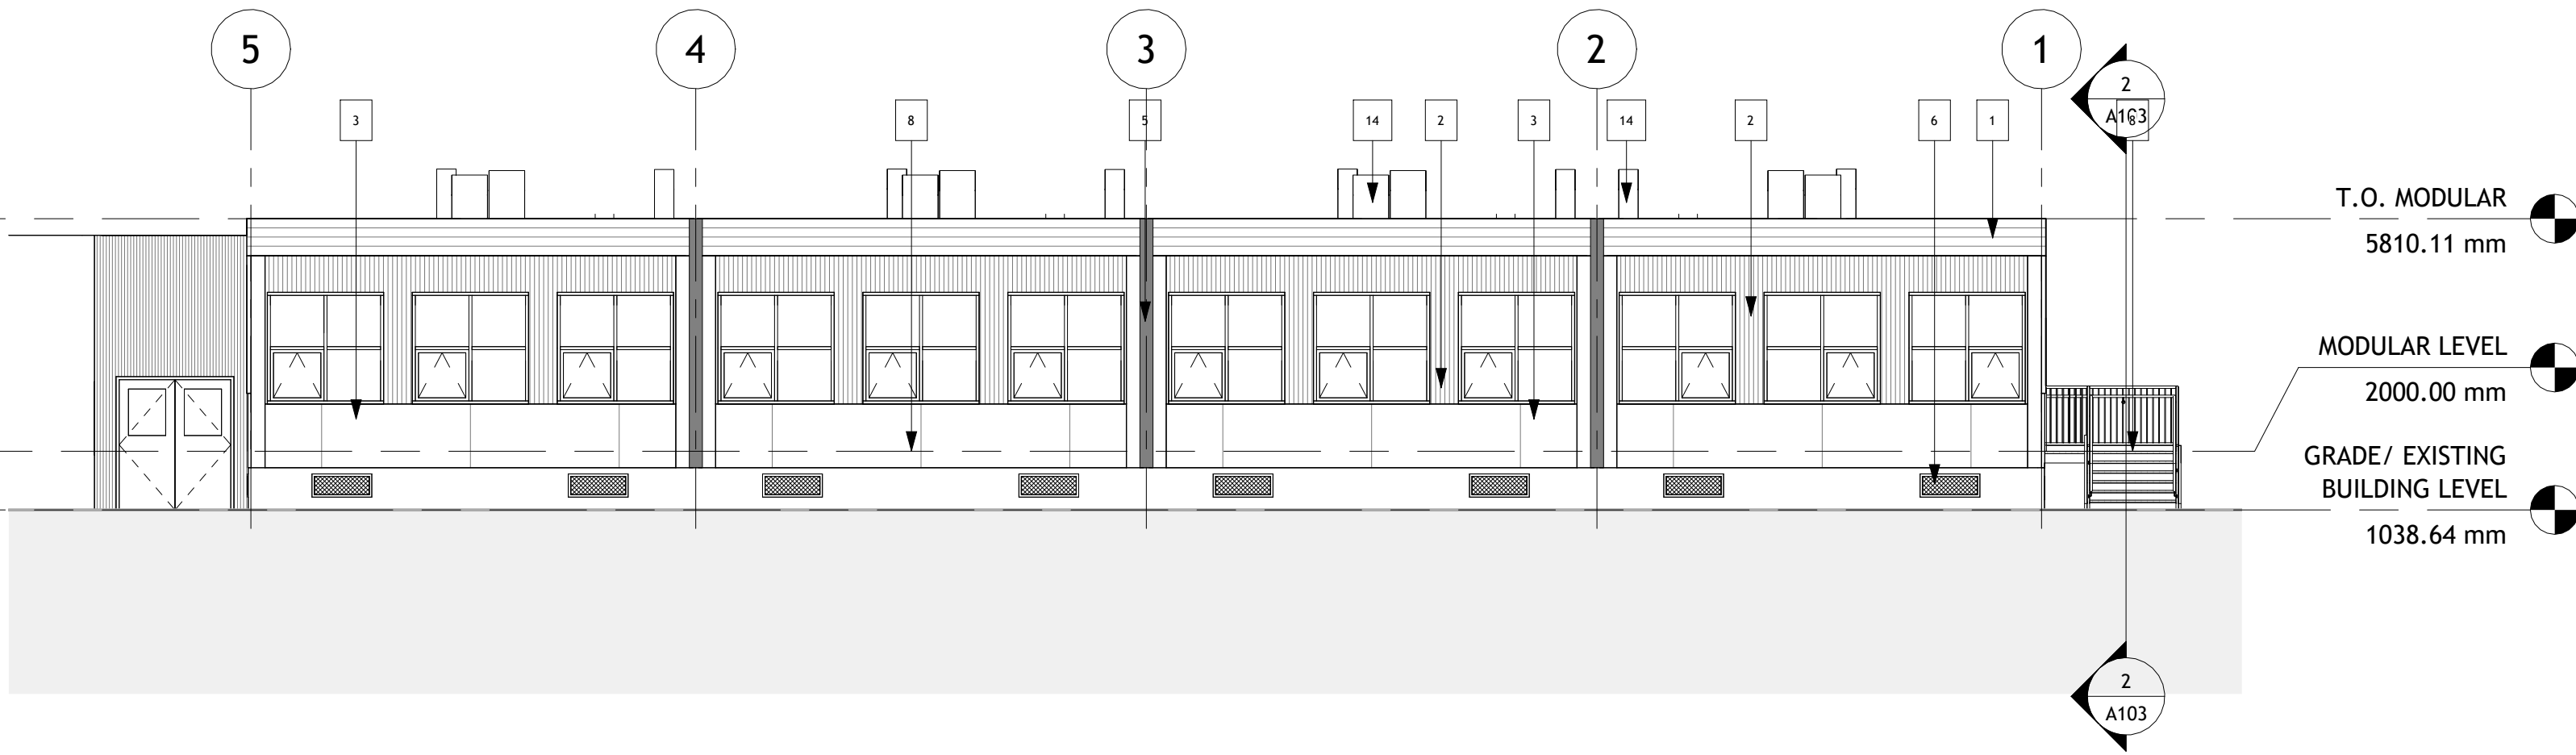

2 NORTH ELEVATION
1 : 100

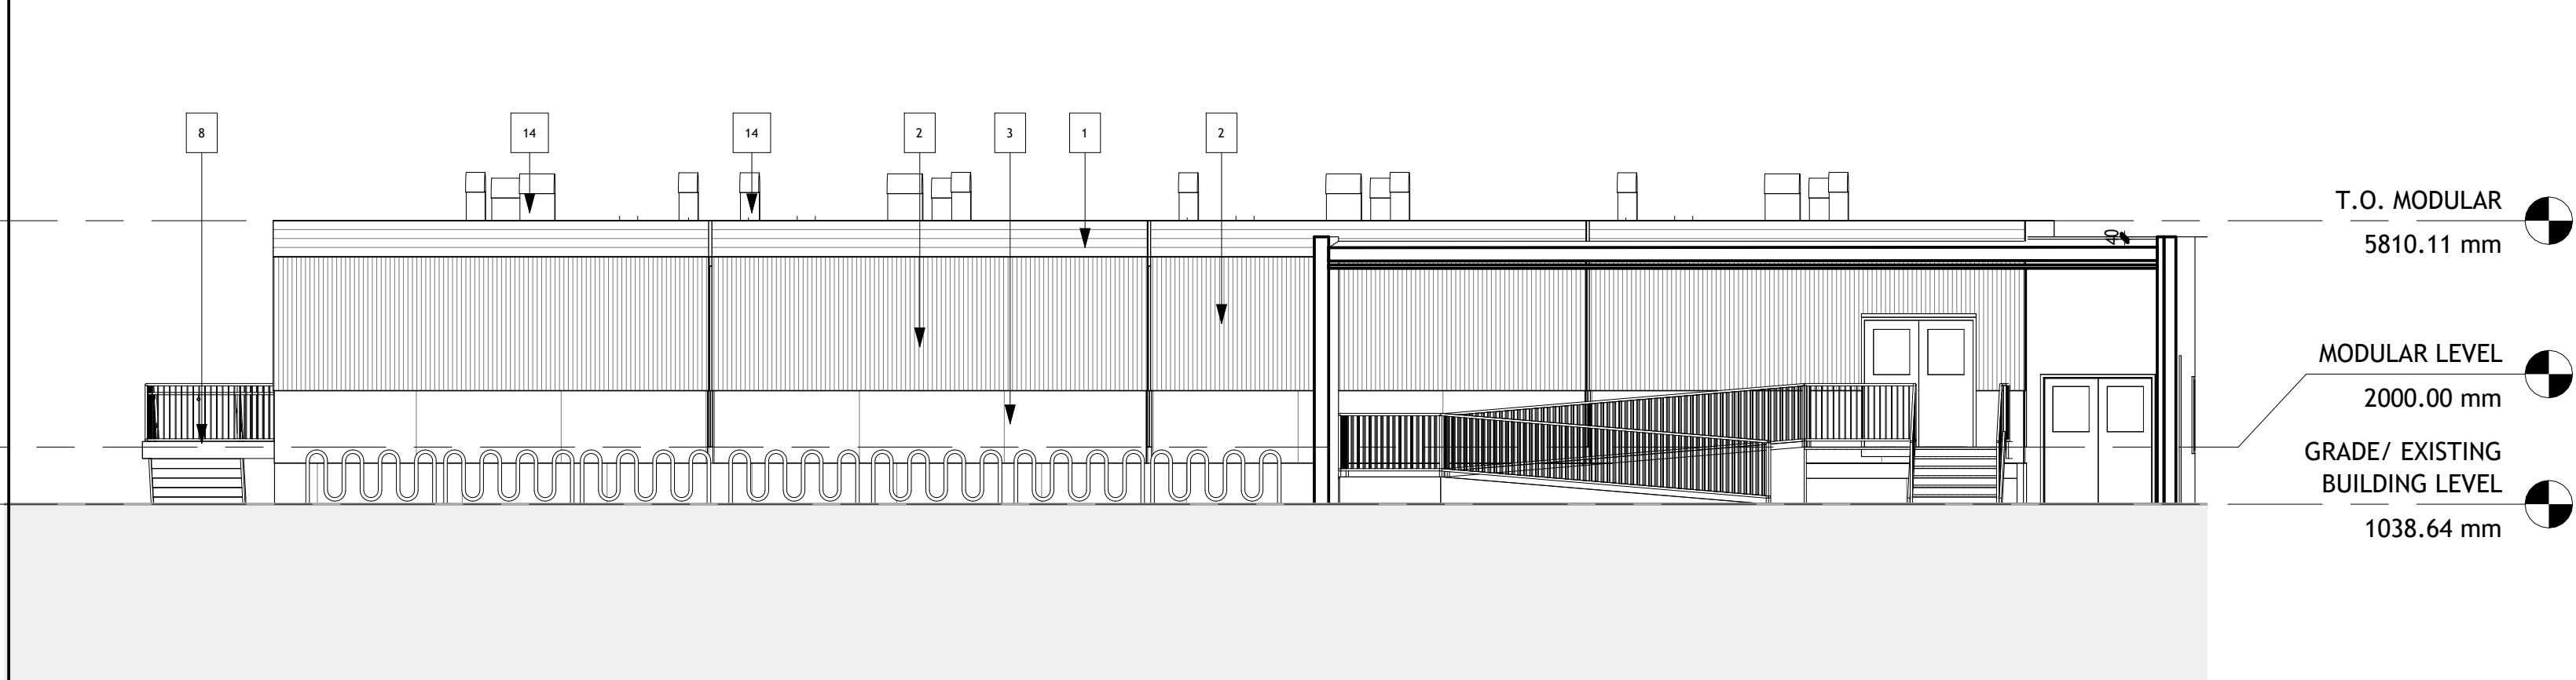

3 SOUTH ELEVATION
1 : 100

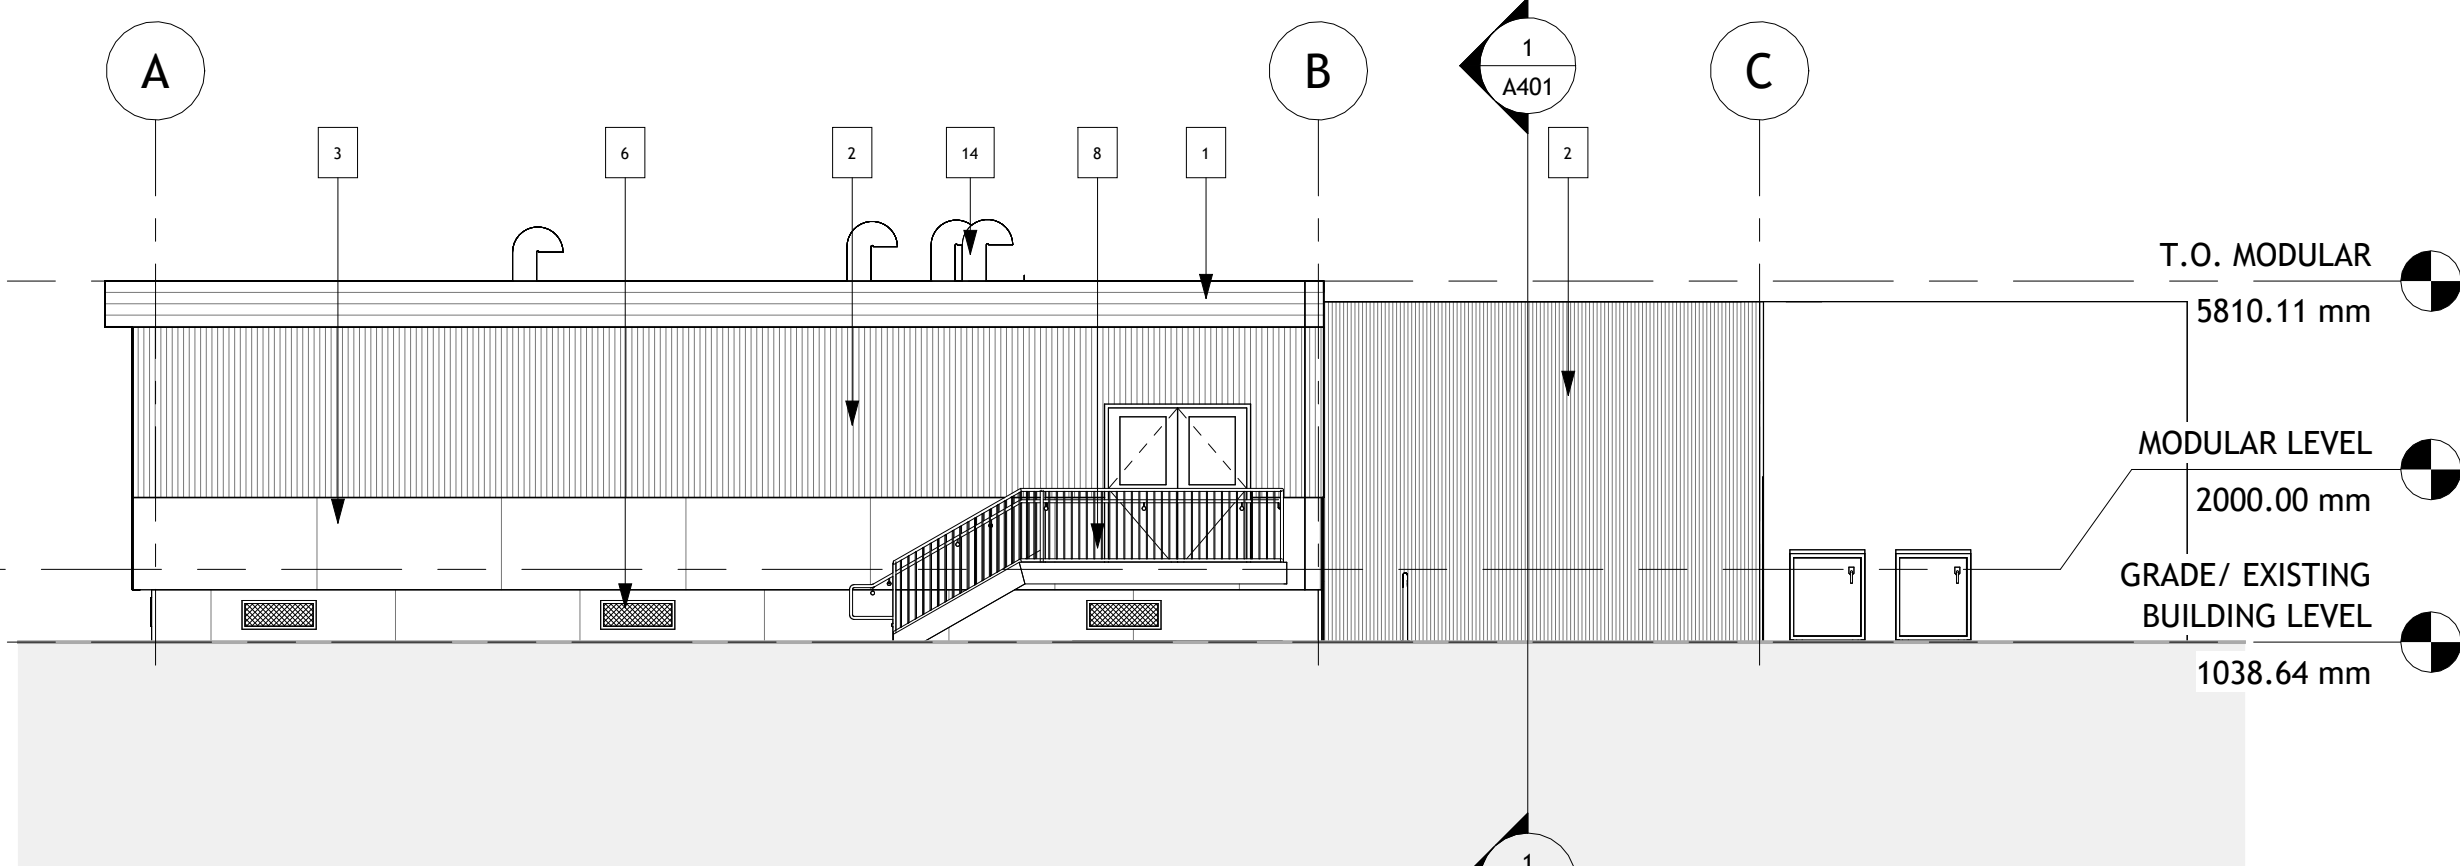

4 WEST ELEVATION
1 : 100

CYNC
ARCHITECTURE
INC.

Address:
Suite #204
337 17 AVE SW
Calgary, AB
T2S0A5

Phone:
403-269-7782

Website:
www.cync.ca


Client:



Calgary Board
of Education

Consultant:

Seal:

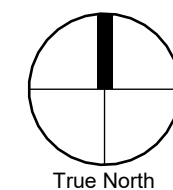

THIS COMPUTER GENERATED DRAWING IS AN INSTRUMENT OF SERVICE AND IS COPYRIGHT MATERIAL. USE ONLY FOR THIS PROJECT OR AS DIRECTED BY CYNCR ARCHITECTURE.

THIS IS A COPYRIGHT DRAWING AND SHALL NOT BE REPRODUCED OR REVISED WITHOUT WRITTEN PERMISSION AND MUST BE RETURNED AT COMPLETION OF WORK OR UPON REQUEST.

01	ISSUE FOR DP	2026.08.21

PRINCE OF
WALES SCHOOL
MODULAR
ADDITION

253 Parkland Way SE, Calgary, AB

ARCHITECTURAL
ELEVATION

Project:	2026-14
Date:	03/31/22
Drawn by:	Author
Checked by:	Checker
Scale:	As indicated

A301