




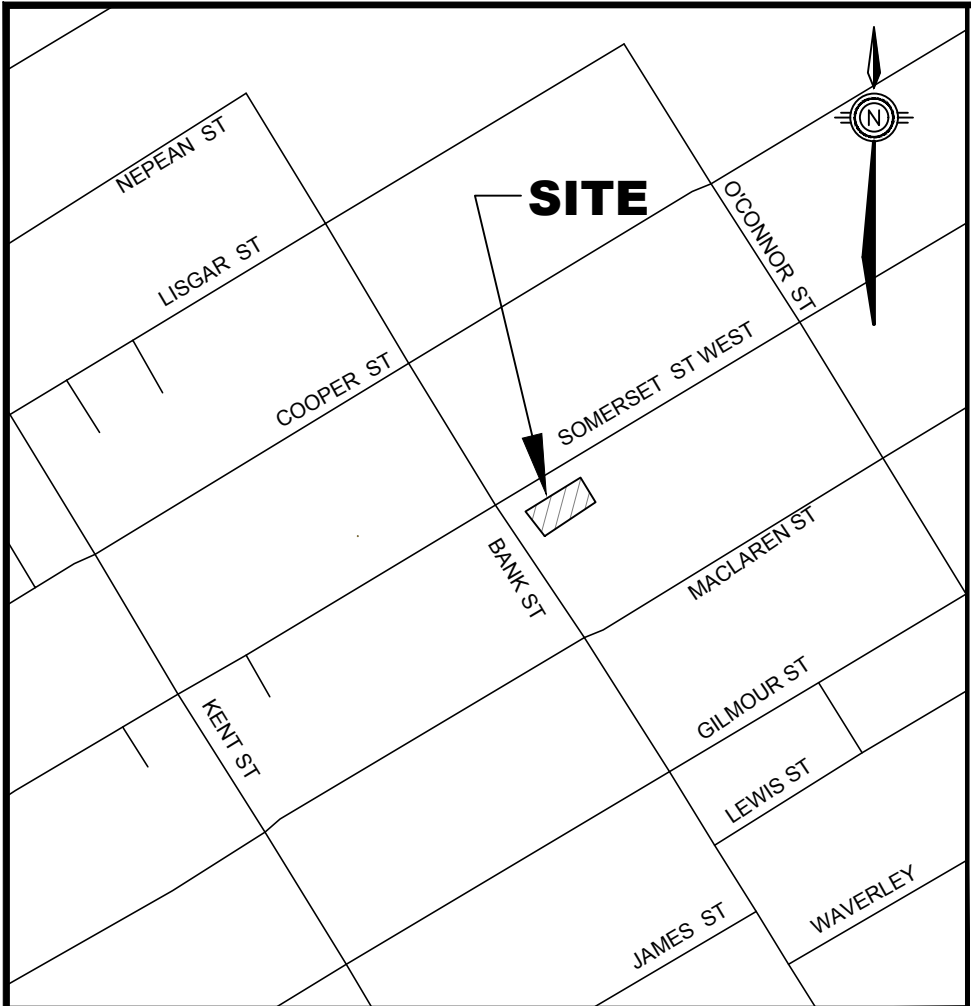


KEY MAP
SCALE: N.T.S.

LEGEND

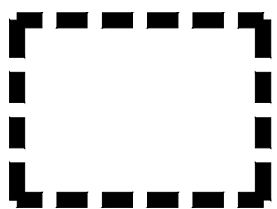

STORM DRAINAGE AREA

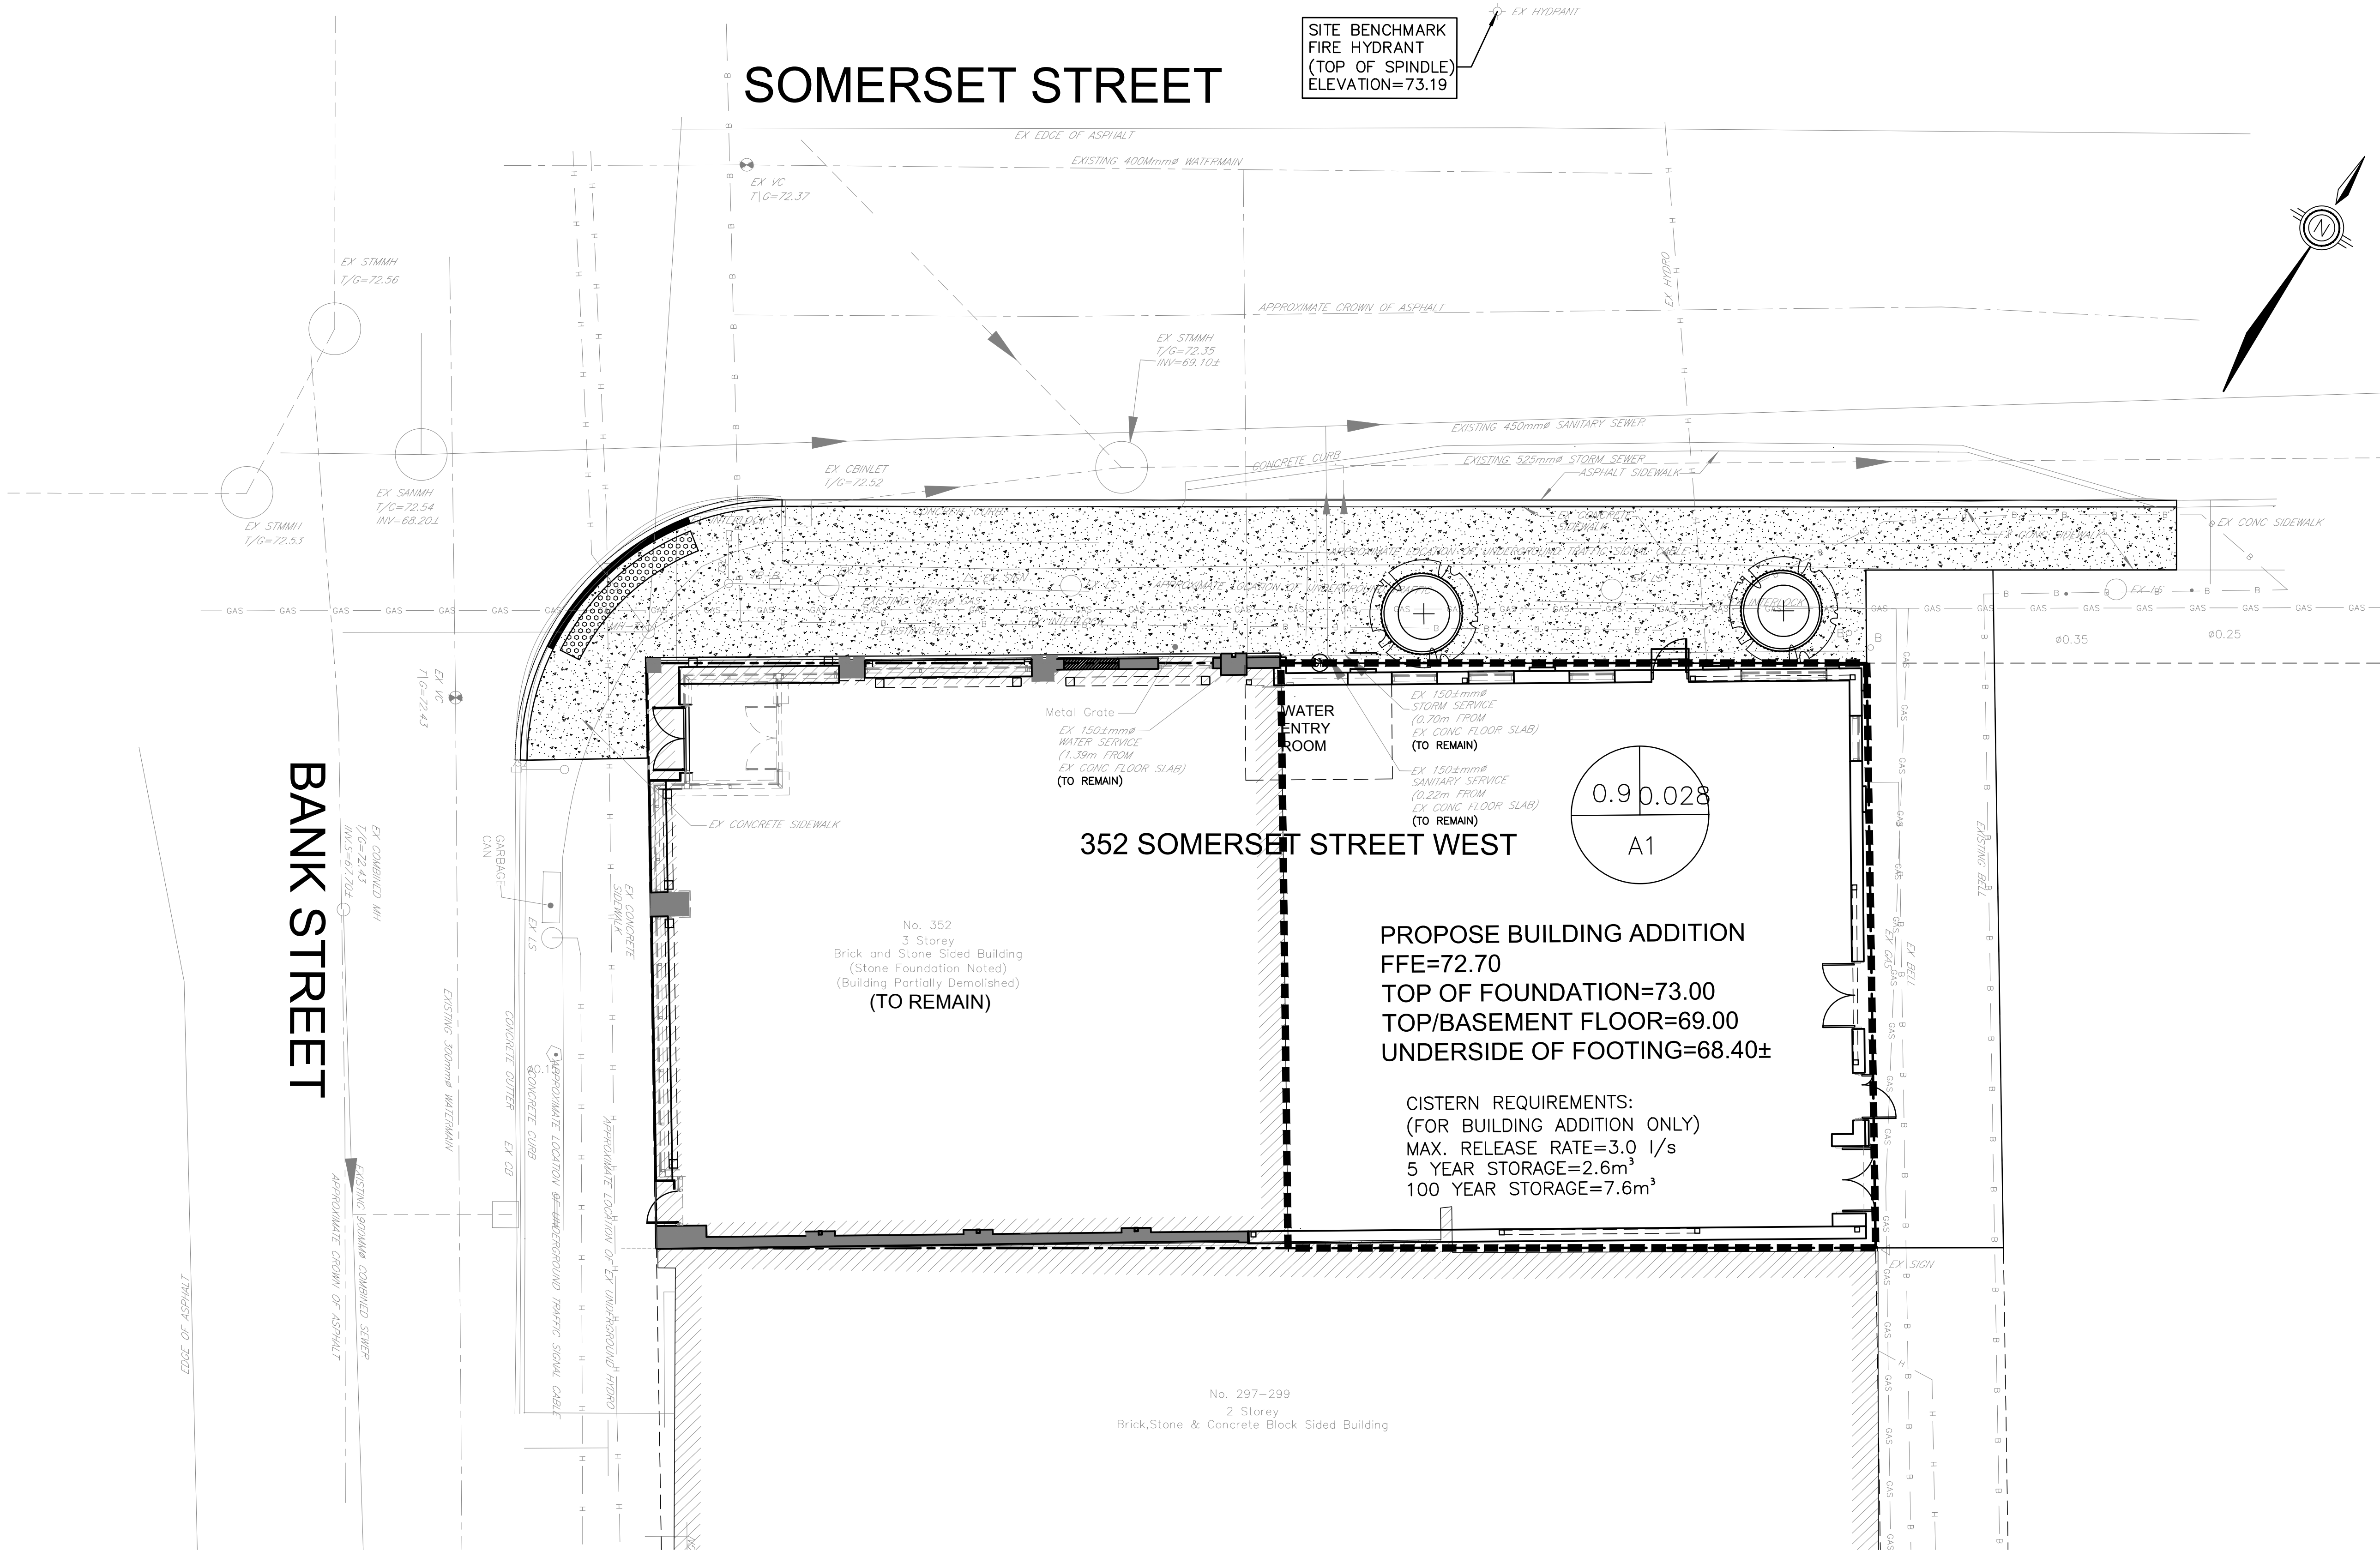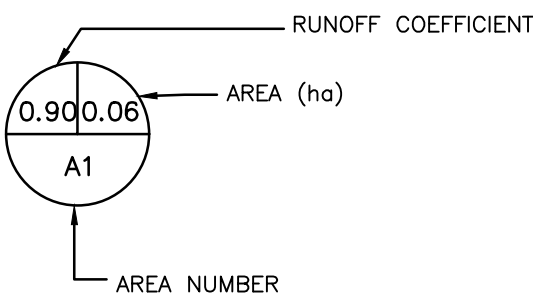

CONTRACT DRAWINGS:
Contractor must verify all dimensions and be responsible for same. Any discrepancies must be reported to the Engineer before commencing work. Drawings are not to be copied, distributed or used by others without the express written consent of Anley, Graham & Associates Limited. The recipient is responsible for confirming the accuracy and completeness of the information with the originator. The recipient assumes all risks and liabilities associated with the use of the drawings. The recipient will save and hold harmless Anley, Graham & Associates Limited for any claims whatsoever associated with or related to the use of the drawings. The recipient will not reuse any portion of the drawings for any future project without the express written permission of Anley, Graham & Associates Limited.

NO.	REVISIONS	DATE	INITIAL
2	REVISED PER CITY COMMENTS	AUG 11/23	JX
1	ISSUED FOR SITE PLAN APPROVAL	MAR 29/23	JX

Not Valid Unless Signed And Dated
Professional Engineers
Ontario
AUGUST 11, 2023
Limited Licensee
Name: J.W.XU
Number: 100171806
Category: CIVIL-see limitation
Limitations:
This licence is subject to the limitations as detailed on the certificate.
Association of Professional Engineers of Ontario

SCALE: 1 : 100
DESIGN: JX
DRAWN: JX
CHECKED: GSC/JX
DATE: AUG 2022

SOMERSET HOUSE
352 SOMERSET STREET WEST
CITY OF OTTAWA

STORMWATER MANAGEMENT PLAN



CONSULTING
ENGINEERS
PLANNERS

CONTRACT No. 21038

003-21038-SWM1

#18975

D07-12-22-0003