

No.	DATE	REVISION
1	JAN 26-26	ISSUED FOR APPROVAL



KEY PLAN

D. B. GRAY ENGINEERING INC.
 Professional Engineers - Consulting & Planning - Storm & Sanitary Services - Drainage
 700 Long Point Circle
 Ottawa, Ontario K1L 1A1
 d.gray@dbgrayengineering.com
 613-425-8044

Project
PROPOSED 6-STORY APARTMENT BUILDINGS
475 TERRY FOX DRIVE
 OTTAWA, ONTARIO




Drawing Title
PRE-DEVELOPMENT DRAINAGE PLAN

Drawn	D.B.G.
H. Scale	1:400
V. Scale	1:400
Date	JAN 26-26
Job No.	24103

Engineer's Seal

 NOT VALID UNLESS SIGNED & DATED

Drawing No.
C-14
 of 19

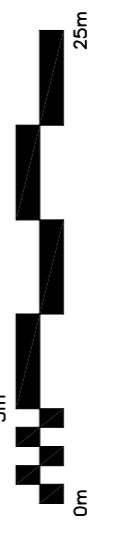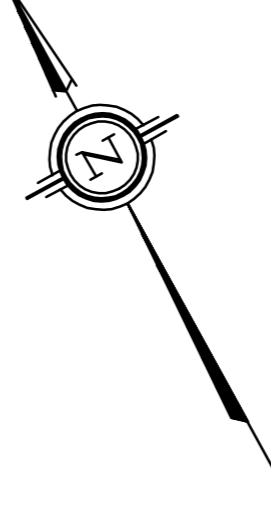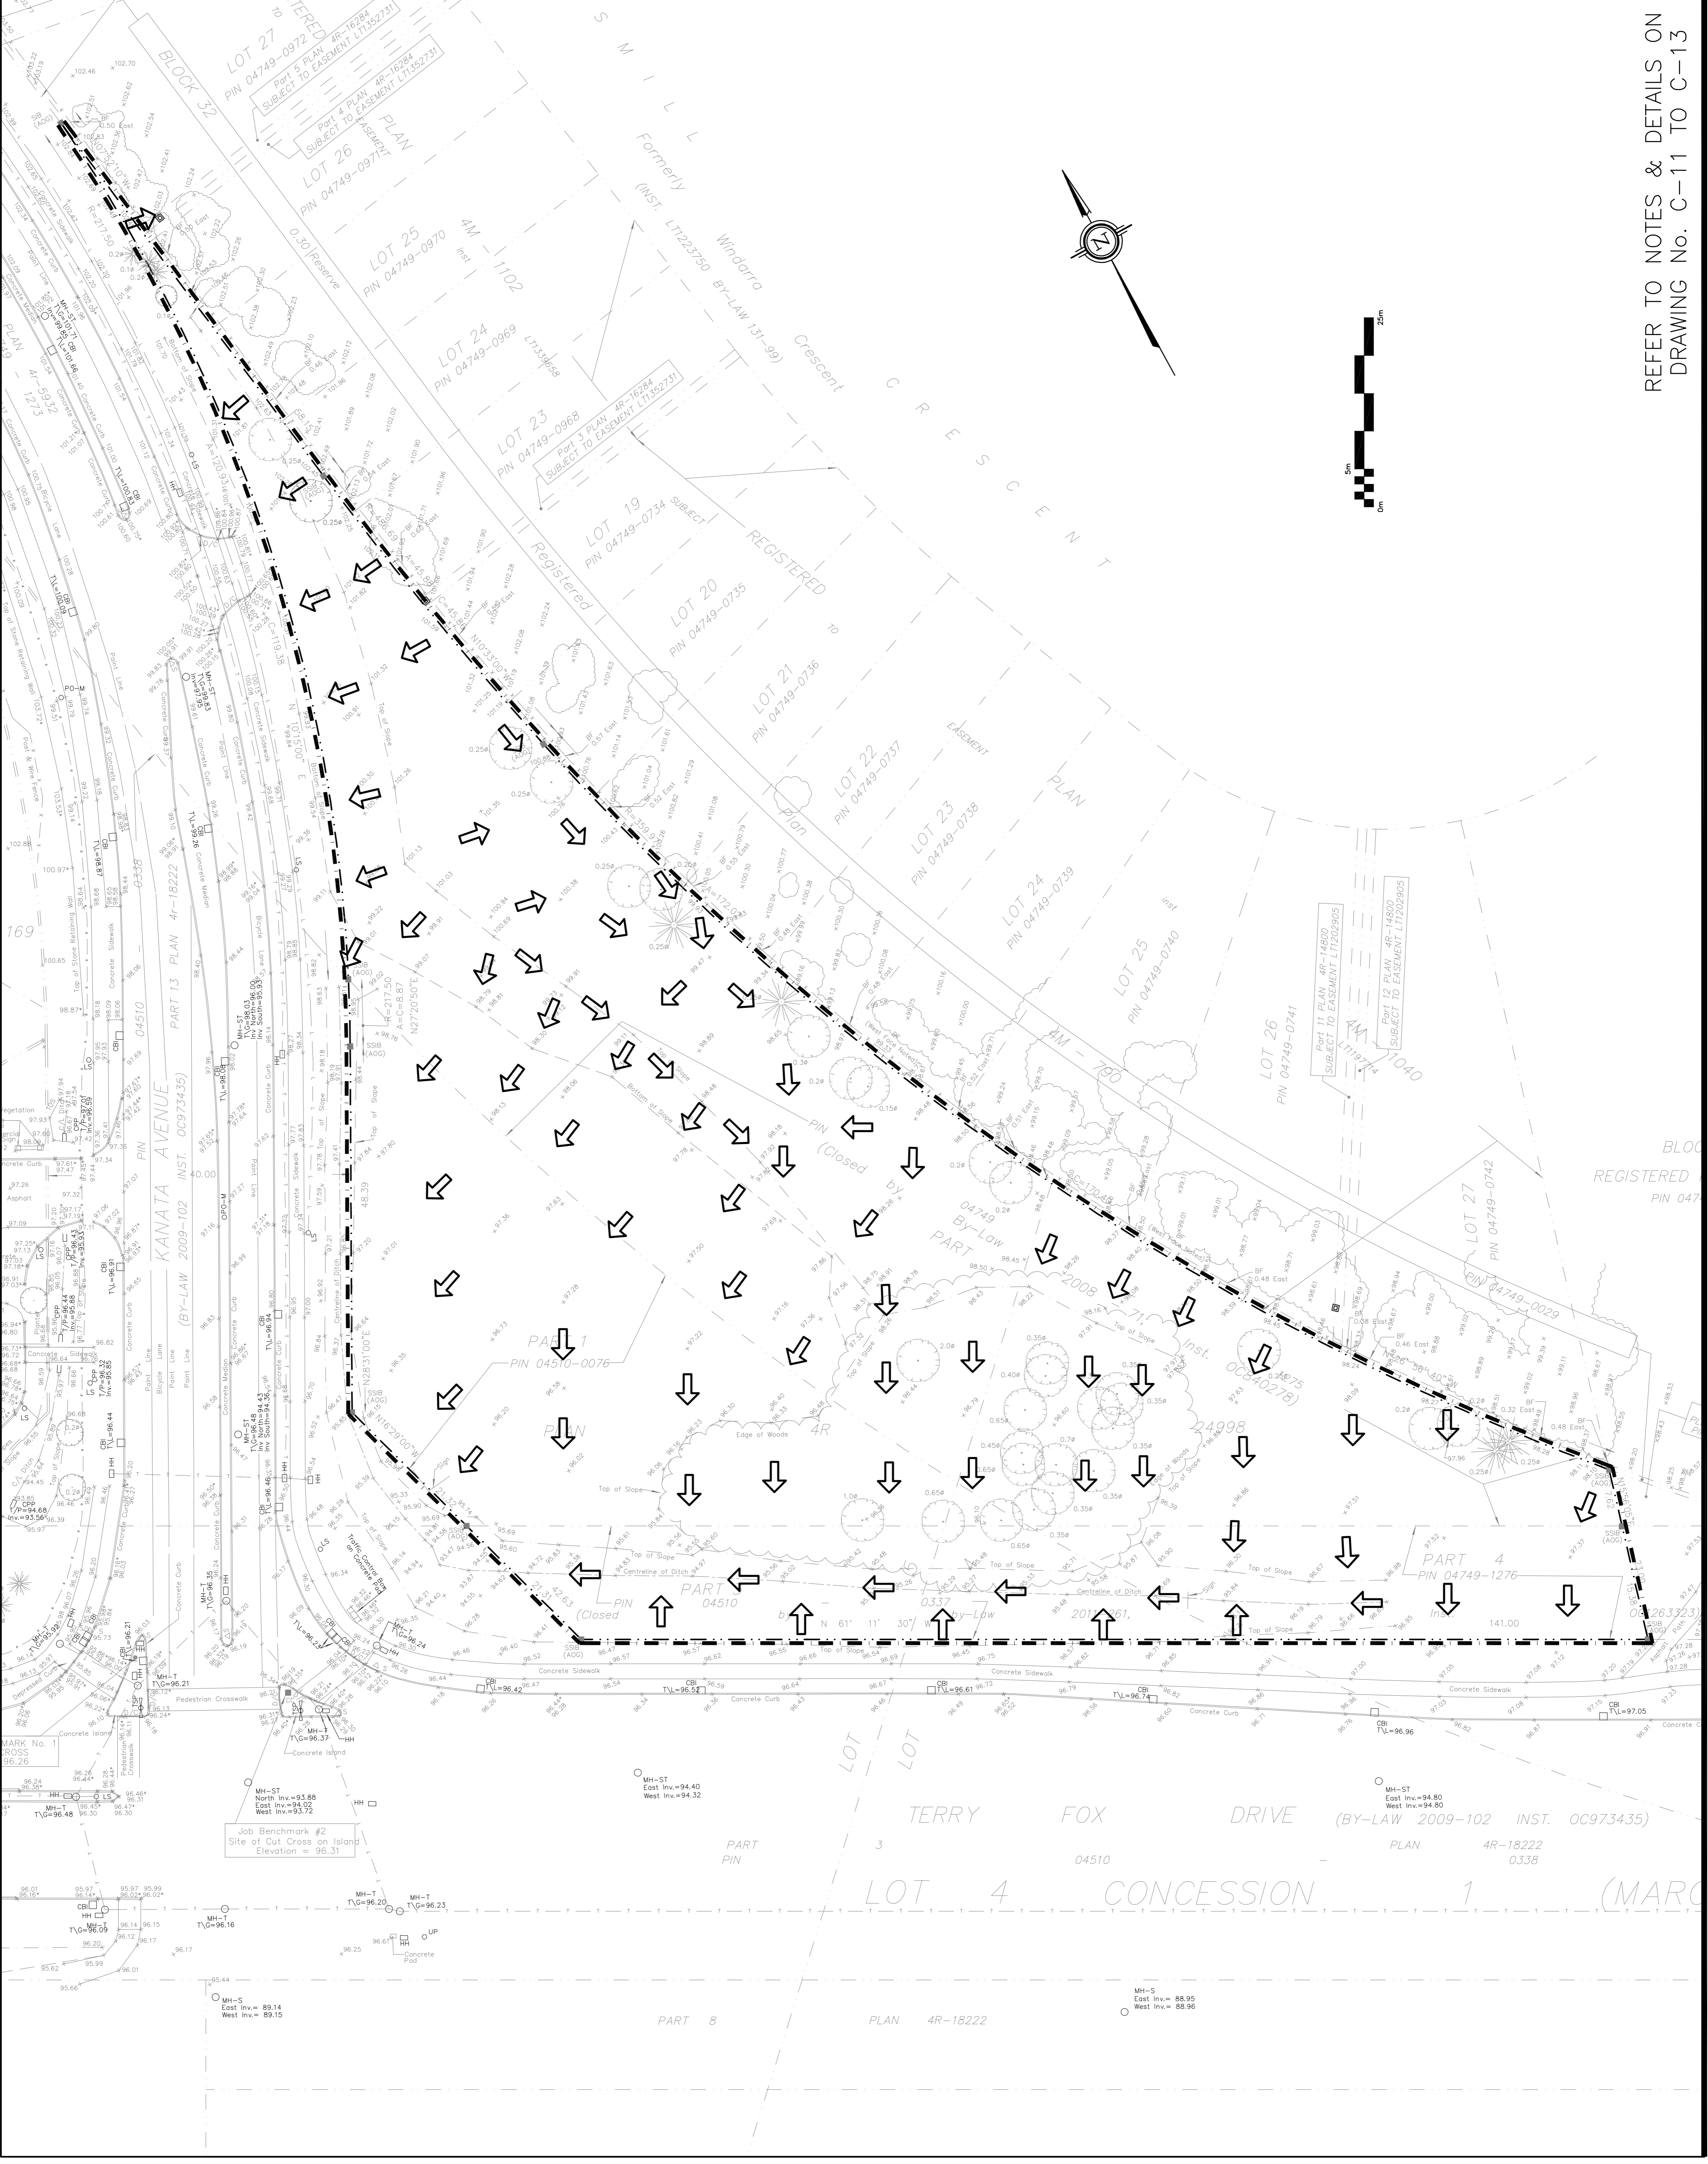

REFER TO NOTES & DETAILS ON
 DRAWING No. C-11 TO C-13