


**LEGEND**

FFL	FINISHED FLOOR ELEVATION
BFL	BASEMENT FLOOR ELEVATION
USF	UNDERSIDE OF FOOTING
---	PROPERTY LINE
CB	CATCH-BASIN
MH	STORM MANHOLE
CB/MH	CATCH-BASIN/MANHOLE
MH	SANITARY MANHOLE
DMAC	DMA CHAMBER
FH	FIRE HYDRANT
FDC	FIRE DEPARTMENT CONNECTION
VB	VALVE & VALVE BOX
SAN	SANITARY SEWER
ST	STORM SEWER
WS/WM	WATER SERVICE/WATERMAIN
SPL	SPRINGLINE
INV	INVERT
US	UNDERSIDE

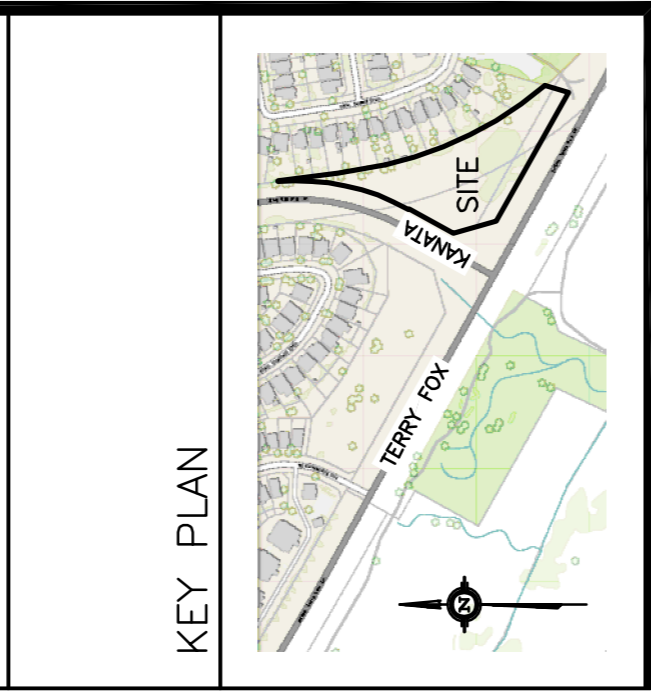

No.	DATE	REVISION
3	JAN 26-26	RE-ISSUED FOR APPROVAL
2	OCT 28-25	RE-ISSUED FOR APPROVAL
1	JUL 11-25	ISSUED FOR APPROVAL

**D. B. GRAY ENGINEERING INC.**  
 Structural Management - Consulting & Engineering - Storm & Sanitary Services - Fire Services  
 700 Long Point Circle  
 Ottawa, Ontario K1M 1S7  
 613-425-8044  
 d.gray@dbgrayengineering.com

**PROPOSED 6-STORY APARTMENT BUILDINGS**  
 475 TERRY FOX DRIVE  
 OTTAWA, ONTARIO


Drawing Title  
**SITE PLAN**

Drawn D.B.G.	H. Scale 1:400
Checked V. Scale	Date JUL 11-25
Job No. 24103	

Engineer's Seal  

 NOT VALID UNLESS SIGNED & DATED

Drawing No.  
**C-1**  
 of 19

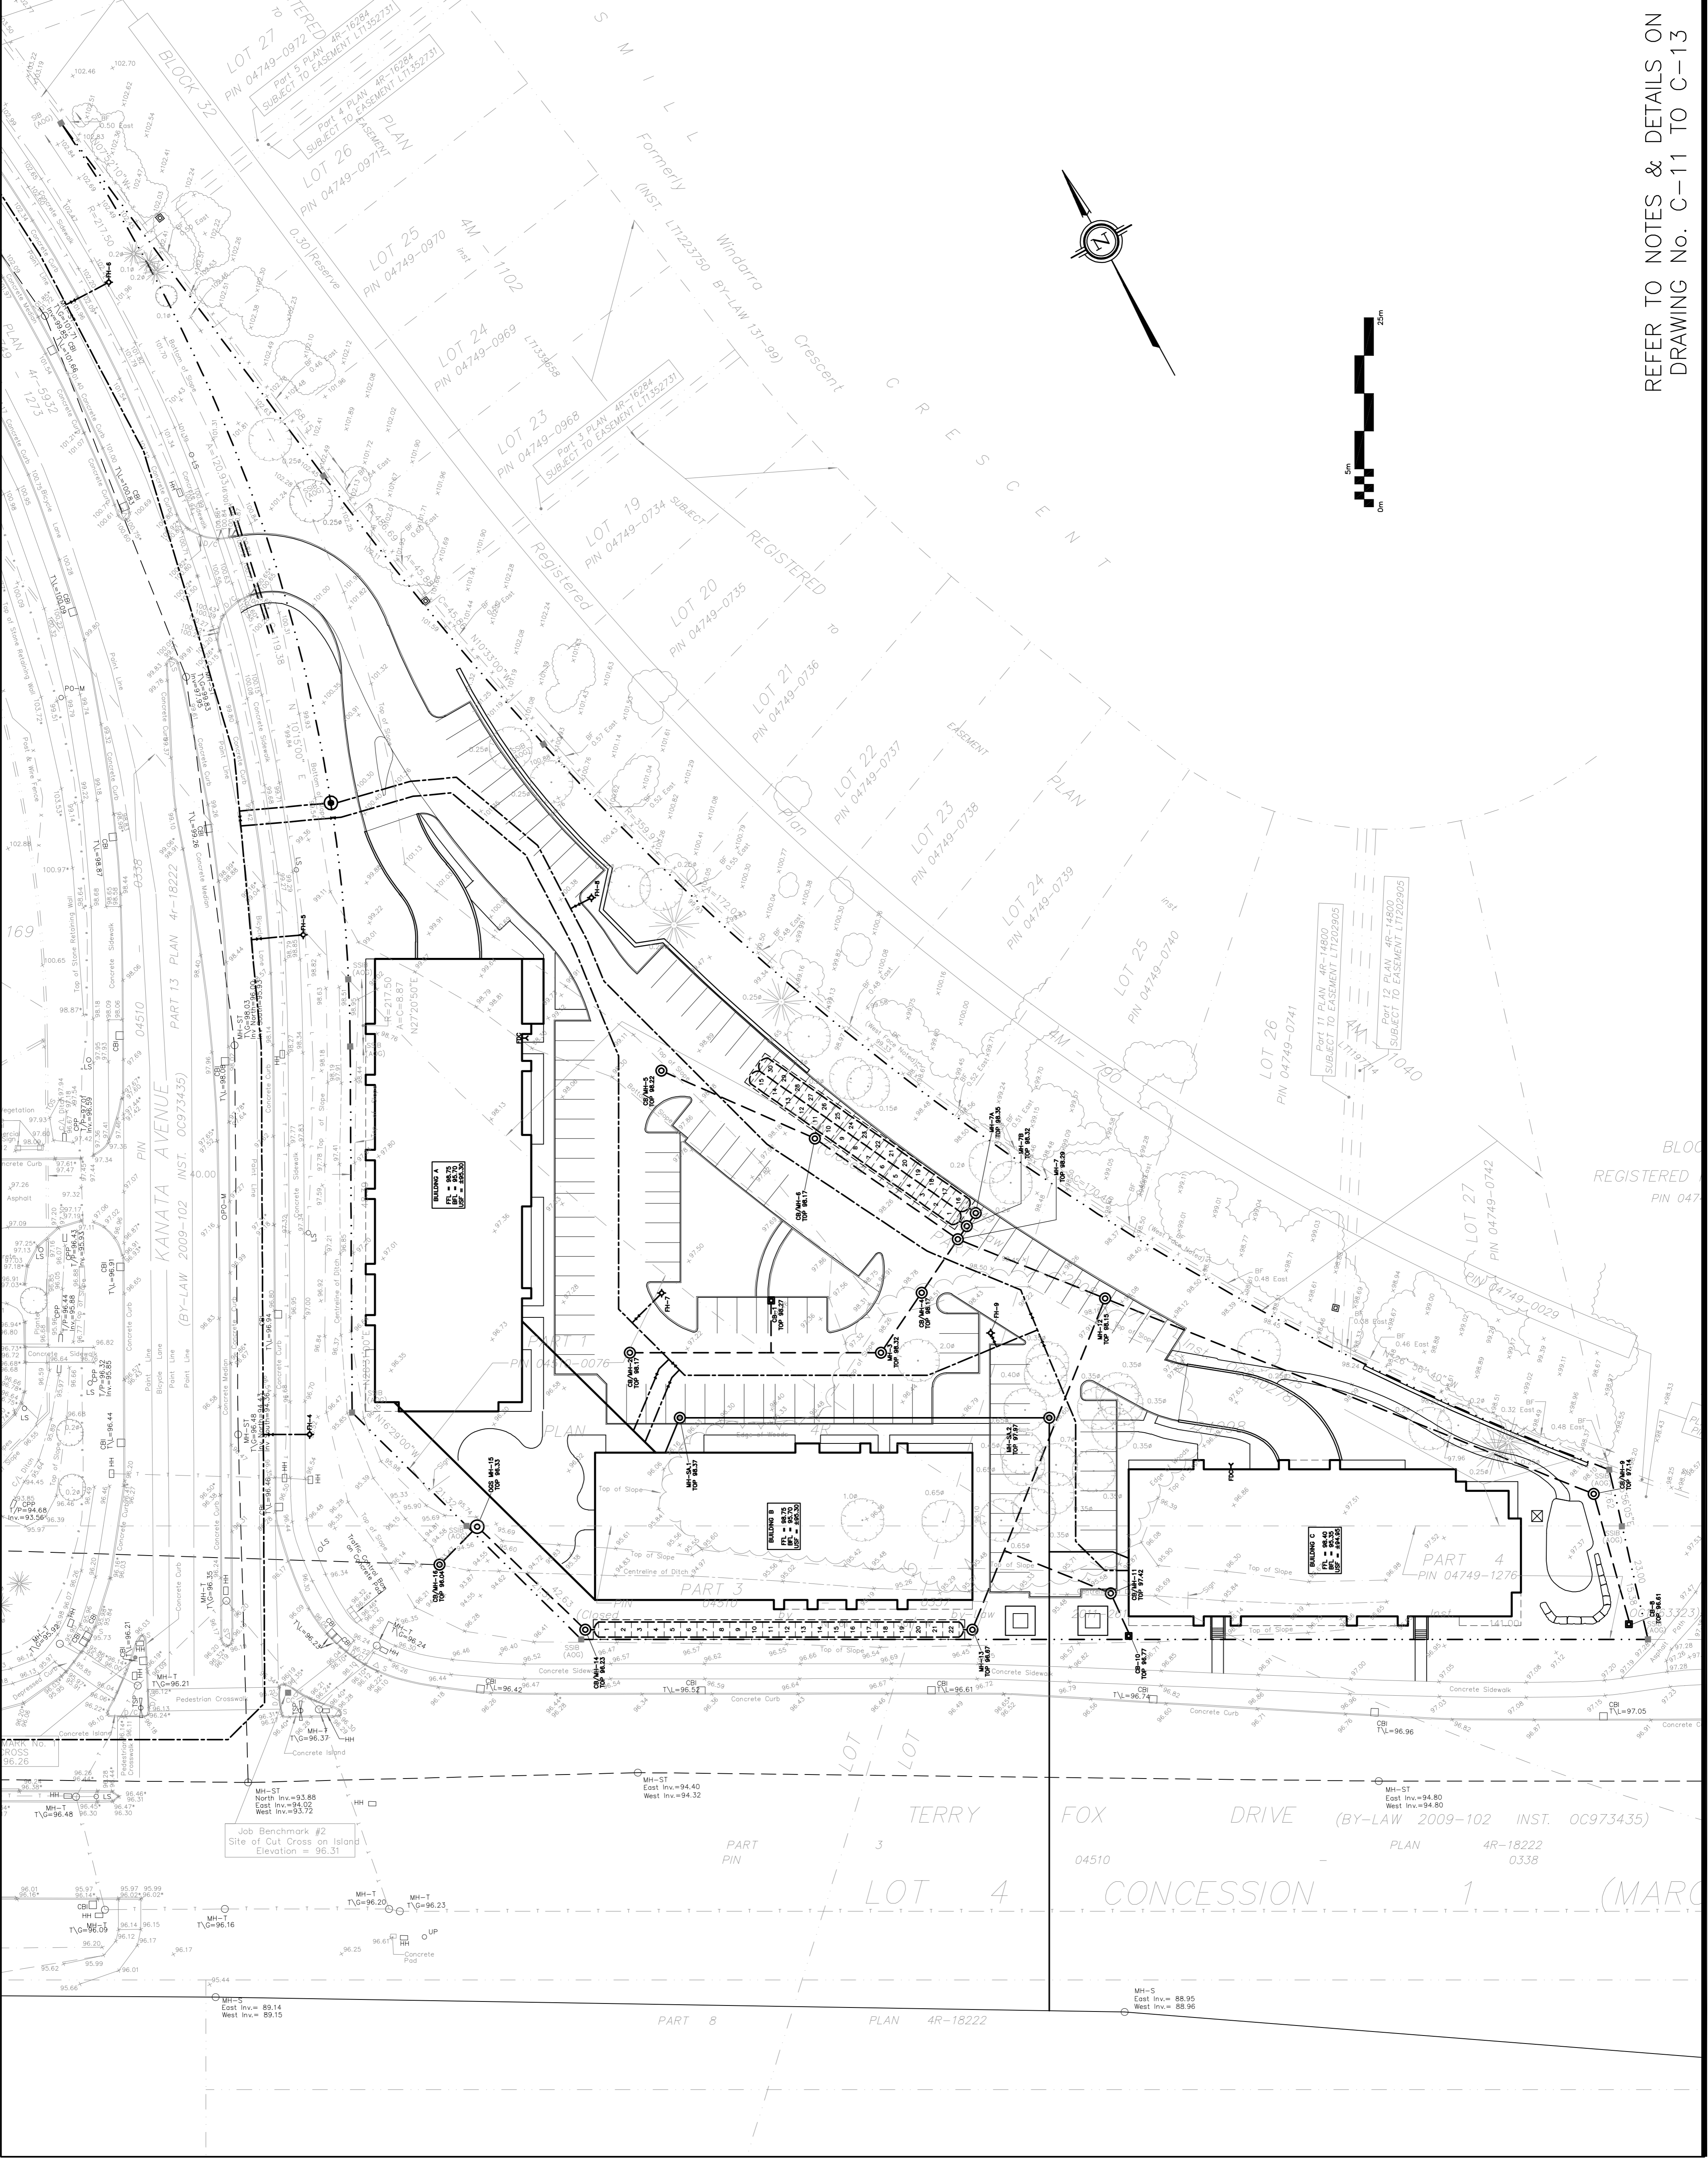

REFER TO NOTES & DETAILS ON  
 DRAWING No. C-11 TO C-13