
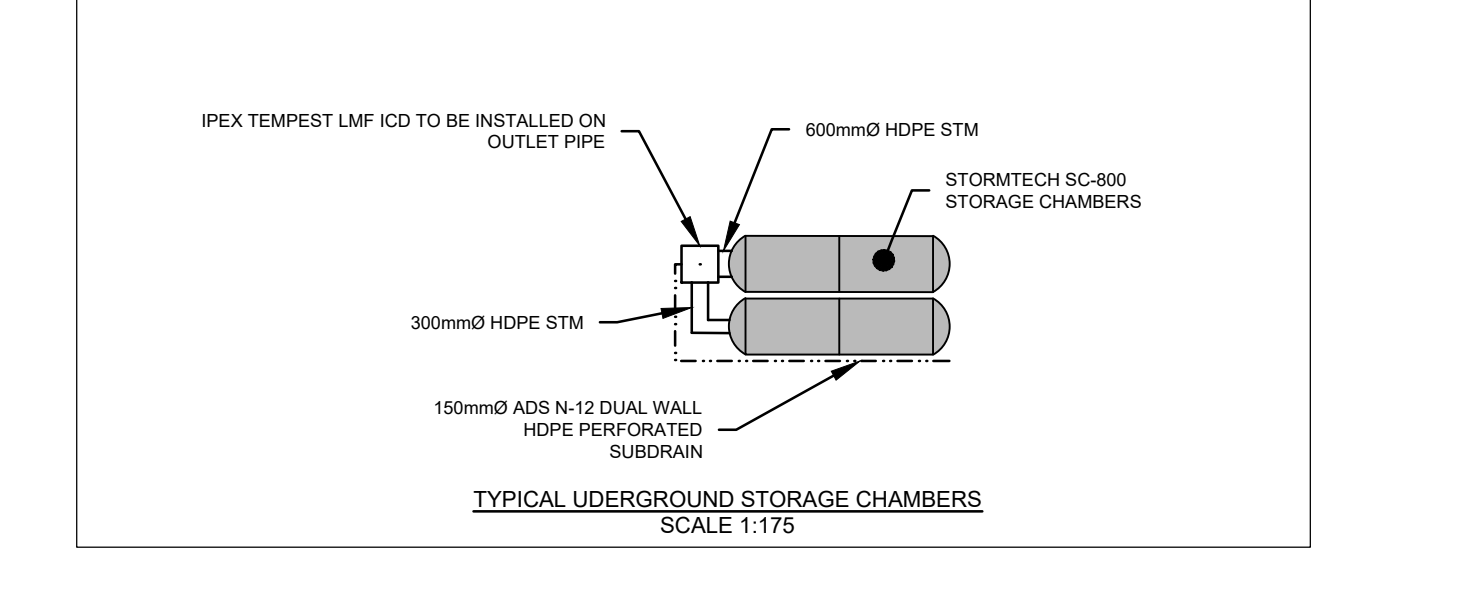



- LEGEND**
- PROPOSED SANITARY MANHOLE & SEWER WITH DIRECTION OF FLOW
  - PROPOSED STORM MANHOLE & SEWER WITH DIRECTION OF FLOW
  - PROPOSED STORM CATCHBASIN MANHOLE & SEWER WITH DIRECTION OF FLOW
  - PROPOSED WATERMAIN AND DIAMETER
  - PROPOSED HYDRANT CW VALVE & LEAD
  - PROPOSED WATERMAIN CAP
  - PROPOSED WATERMAIN BEND AND THRUST BLOCK
  - PROPOSED CATCH BASIN
  - PROPOSED REAR YARD CATCH BASIN
  - PROPOSED SERVICE LATERALS (WATER & SANITARY)
  - EXISTING STORM MANHOLE, SEWER & FLOW DIRECTION
  - EXISTING SAN MANHOLE, SEWER & FLOW DIRECTION
  - EXISTING CATCH BASIN
  - R-3 VALVE CHAMBER(W12) WITH FIRE LINE METER(W32-1)

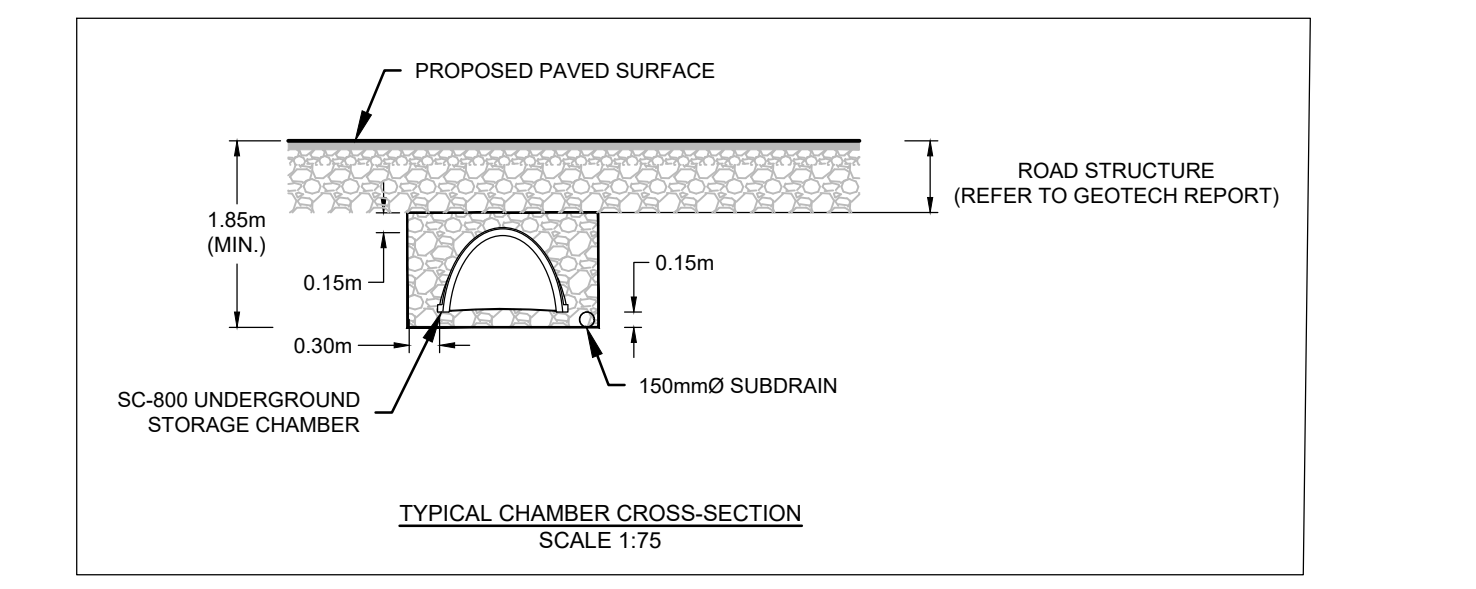

NOTE:  
THE POSITION OF ALL POLE LINES, CONDUITS, WATERMANS, SEWERS AND OTHER UNDERGROUND AND OVERGROUND UTILITIES AND STRUCTURES IS NOT NECESSARILY SHOWN ON THE CONTRACT DRAWINGS, AND WHERE SHOWN, THE ACCURACY OF THE POSITION OF SUCH UTILITIES AND STRUCTURES IS NOT GUARANTEED. BEFORE STARTING WORK, DETERMINE THE EXACT LOCATION OF ALL SUCH UTILITIES AND STRUCTURES AND ASSUME ALL LIABILITY FOR DAMAGE TO THEM.

**PHOENIX HOMES**  
SINCE 1988  
18A BENTLEY AVE  
OTTAWA, ON, K2E 6T8

No.	REVISION	DATE	BY
2	ADDRESS CITY COMMENTS	APR 14/28	MAB
1	SITE PLAN APPLICATION	NOV 5/25	MAB

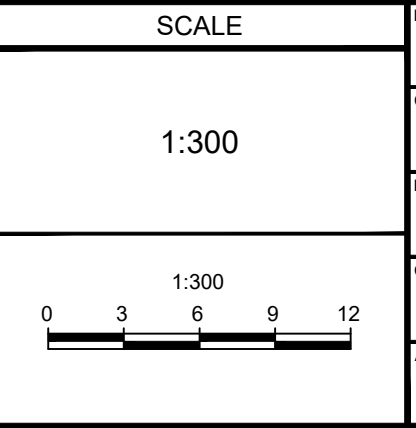

FOR REVIEW ONLY

PROFESSIONAL ENGINEER  
L.R. WILSON  
10180055  
PROVINCE OF ONTARIO

PROFESSIONAL DESIGNER  
M.A. BISSETT  
2028.04.14  
PROVINCE OF ONTARIO

**NOVATECH**  
Engineers, Planners & Landscape Architects  
Suite 200, 240 Michael Cowpland Drive  
Ottawa, Ontario, Canada K2M 1P6  
Telephone: (613) 254-9643  
Facsimile: (613) 254-5867  
Website: www.novatech-eng.com

CITY OF OTTAWA  
3400 WOODROFFE AVENUE

SERVICING PLAN

PROJECT NO: 124147  
REV: 2  
DRAWING NO: 124147-GP

D07-12-25-01568 & D02-02-25-0090