


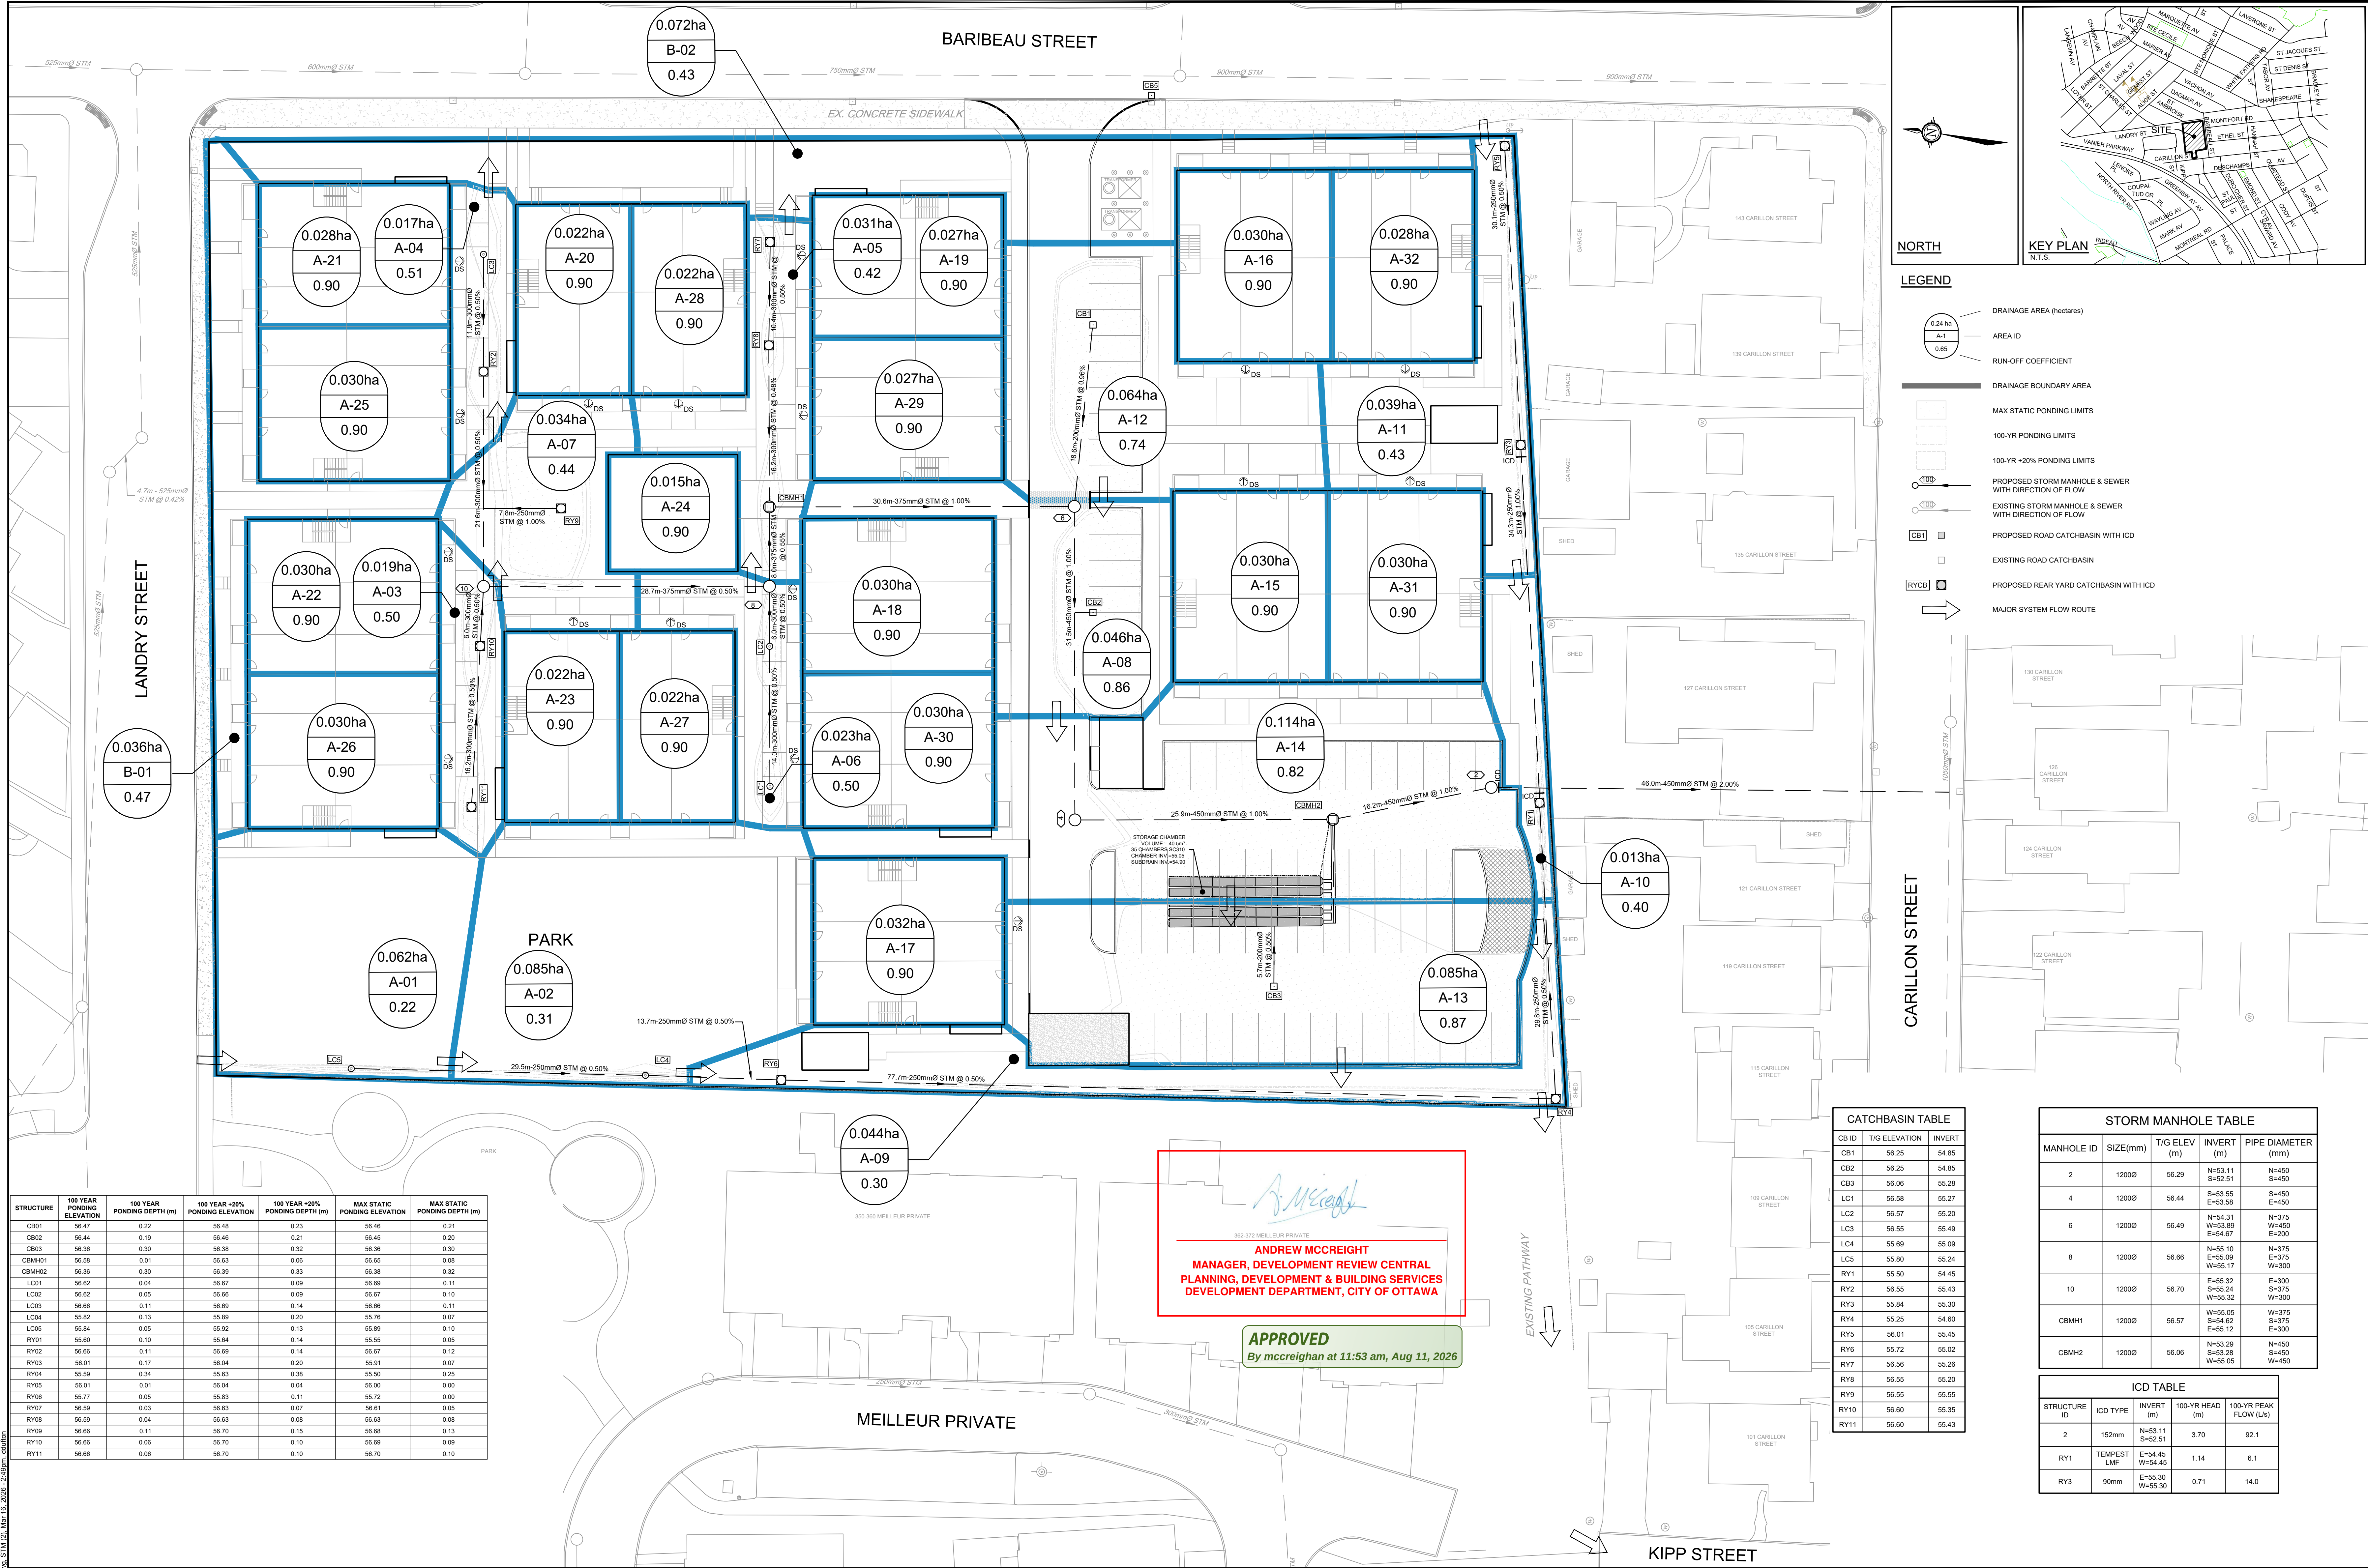

STRUCTURE	100 YEAR PONDING ELEVATION	100 YEAR PONDING DEPTH (m)	100 YEAR +20% PONDING ELEVATION	100 YEAR +20% PONDING DEPTH (m)	MAX STATIC PONDING ELEVATION	MAX STATIC PONDING DEPTH (m)
CB01	56.47	0.22	56.48	0.23	56.46	0.21
CB02	56.44	0.19	56.46	0.21	56.45	0.20
CB03	56.36	0.30	56.38	0.32	56.36	0.30
CBMH01	56.58	0.01	56.63	0.06	56.65	0.08
CBMH02	56.36	0.30	56.39	0.33	56.38	0.32
LC01	56.62	0.24	56.67	0.29	56.69	0.31
LC02	56.62	0.05	56.66	0.09	56.67	0.10
LC03	56.66	0.11	56.69	0.14	56.66	0.11
LC04	55.82	0.13	55.89	0.20	55.76	0.07
LC05	55.84	0.05	55.92	0.13	55.89	0.10
RY01	55.60	0.10	55.64	0.14	55.55	0.05
RY02	56.66	0.11	56.69	0.14	56.67	0.12
RY03	56.01	0.17	56.04	0.20	55.91	0.07
RY04	55.59	0.34	55.63	0.38	55.50	0.25
RY05	56.01	0.01	56.04	0.04	56.00	0.00
RY06	55.77	0.05	55.83	0.11	55.72	0.00
RY07	56.59	0.03	56.63	0.07	56.61	0.05
RY08	56.59	0.04	56.63	0.08	56.63	0.08
RY09	56.66	0.11	56.70	0.15	56.68	0.13
RY10	56.66	0.06	56.70	0.10	56.69	0.09
RY11	56.66	0.06	56.70	0.10	56.70	0.10

CATCHBASIN TABLE			
CB ID	T/G ELEVATION	INVERT	
CB1	56.25	54.85	
CB2	56.25	54.85	
CB3	56.06	55.28	
LC1	56.58	55.27	
LC2	56.57	55.20	
LC3	56.55	55.49	
LC4	55.69	55.09	
LC5	55.80	55.24	
RY1	55.50	54.45	
RY2	56.55	55.43	
RY3	55.84	55.30	
RY4	55.25	54.60	
RY5	56.01	55.45	
RY6	55.72	55.02	
RY7	56.56	55.26	
RY8	56.55	55.20	
RY9	56.55	55.55	
RY10	56.60	55.35	
RY11	56.60	55.43	

STORM MANHOLE TABLE				
MANHOLE ID	SIZE(mm)	T/G ELEV (m)	INVERT (m)	PIPE DIAMETER (mm)
2	1200	56.29	N=53.11 S=52.51	N=450 S=450
4	1200	56.44	S=53.55 E=53.58	S=450 E=450
6	1200	56.49	N=54.31 W=53.89 E=54.67	N=375 W=450 E=200
8	1200	56.66	N=55.10 E=55.09	N=375 E=375
10	1200	56.70	E=55.32 S=55.24 W=55.32	E=300 S=375 W=300
CBMH1	1200	56.57	W=55.05 S=54.62 E=55.12	W=375 S=375 E=300
CBMH2	1200	56.06	N=53.29 S=53.28 W=55.05	N=450 S=450 W=450

ICD TABLE			
STRUCTURE ID	ICD TYPE	INVERT (m)	100-YR HEAD (m)
2	152mm	N=53.11 S=50.51	3.70
RY1	TEMPST LMF	E=54.45 W=54.45	6.1
RY3	90mm	E=55.30 W=55.30	14.0

NOTE:
THE POSITION OF ALL POLE LINES, CONDUITS, WATERMANS, SEWERS AND OTHER UNDERGROUND AND OVERGROUND UTILITIES AND STRUCTURES IS NOT NECESSARILY SHOWN ON THE CONTRACT DRAWINGS, AND WHERE SHOWN, THE ACCURACY OF THE POSITION OF SUCH UTILITIES AND STRUCTURES IS NOT GUARANTEED. BEFORE STARTING WORK, DETERMINE THE EXACT LOCATION OF ALL SUCH UTILITIES AND STRUCTURES AND ASSUME ALL LIABILITY FOR DAMAGE TO THEM.

8.	ISSUED FOR ECA	MAR 24/22	MAB
7.	CITY SUBMISSION - PARK UPDATE	FEB 15/22	MAB
6.	CITY SUBMISSION	JUN 8/21	MAB
5.	CITY SUBMISSION	FEB 5/21	MAB
4.	STORM OUTLET VIA 127 CARILLON	OCT 23/20	MAB
3.	SITE PLAN APPLICATION	AUG 24/20	MAB
2.	RVCA APPROVAL IN PRINCIPAL APPLICATION	MAY 28/20	MAB
1.	ISSUED FOR RVCA REVIEW	MAR 26/20	MAB
REVISION			
No.	REVISION	DATE	BY
11.	MINOR DESIGN UPDATE	MAR 13/26	MAB
12.	SITE PLAN UPDATE	OCT 9/24	MAB
10.	CONCEPT UPDATE	JUN 27/24	MAB
9.	SITE PLAN UPDATE	JUL 15/22	MAB

SCALE
1:250
0 2 4 6 8 10

FOR REVIEW ONLY
DESIGN: LRW
CHECKED: MAB
DRAWN: BRP
CHECKED: LRW
APPROVED: MAB

NOVATECH
Engineers, Planners & Landscape Architects
Suite 200, 240 Michael Cowland Drive
Ottawa, Ontario, Canada K2M 1P6
Telephone: (613) 254-5863
Facsimile: (613) 254-5867
Website: www.novatech-eng.com

CITY OF OTTAWA
200 BARIBEAU STREET
DRAWING NAME: STORM DRAINAGE AREA PLAN
PROJECT No.: 119068
REV: 119068-STM