


STORM OUTLET VIA 127 CARILLION

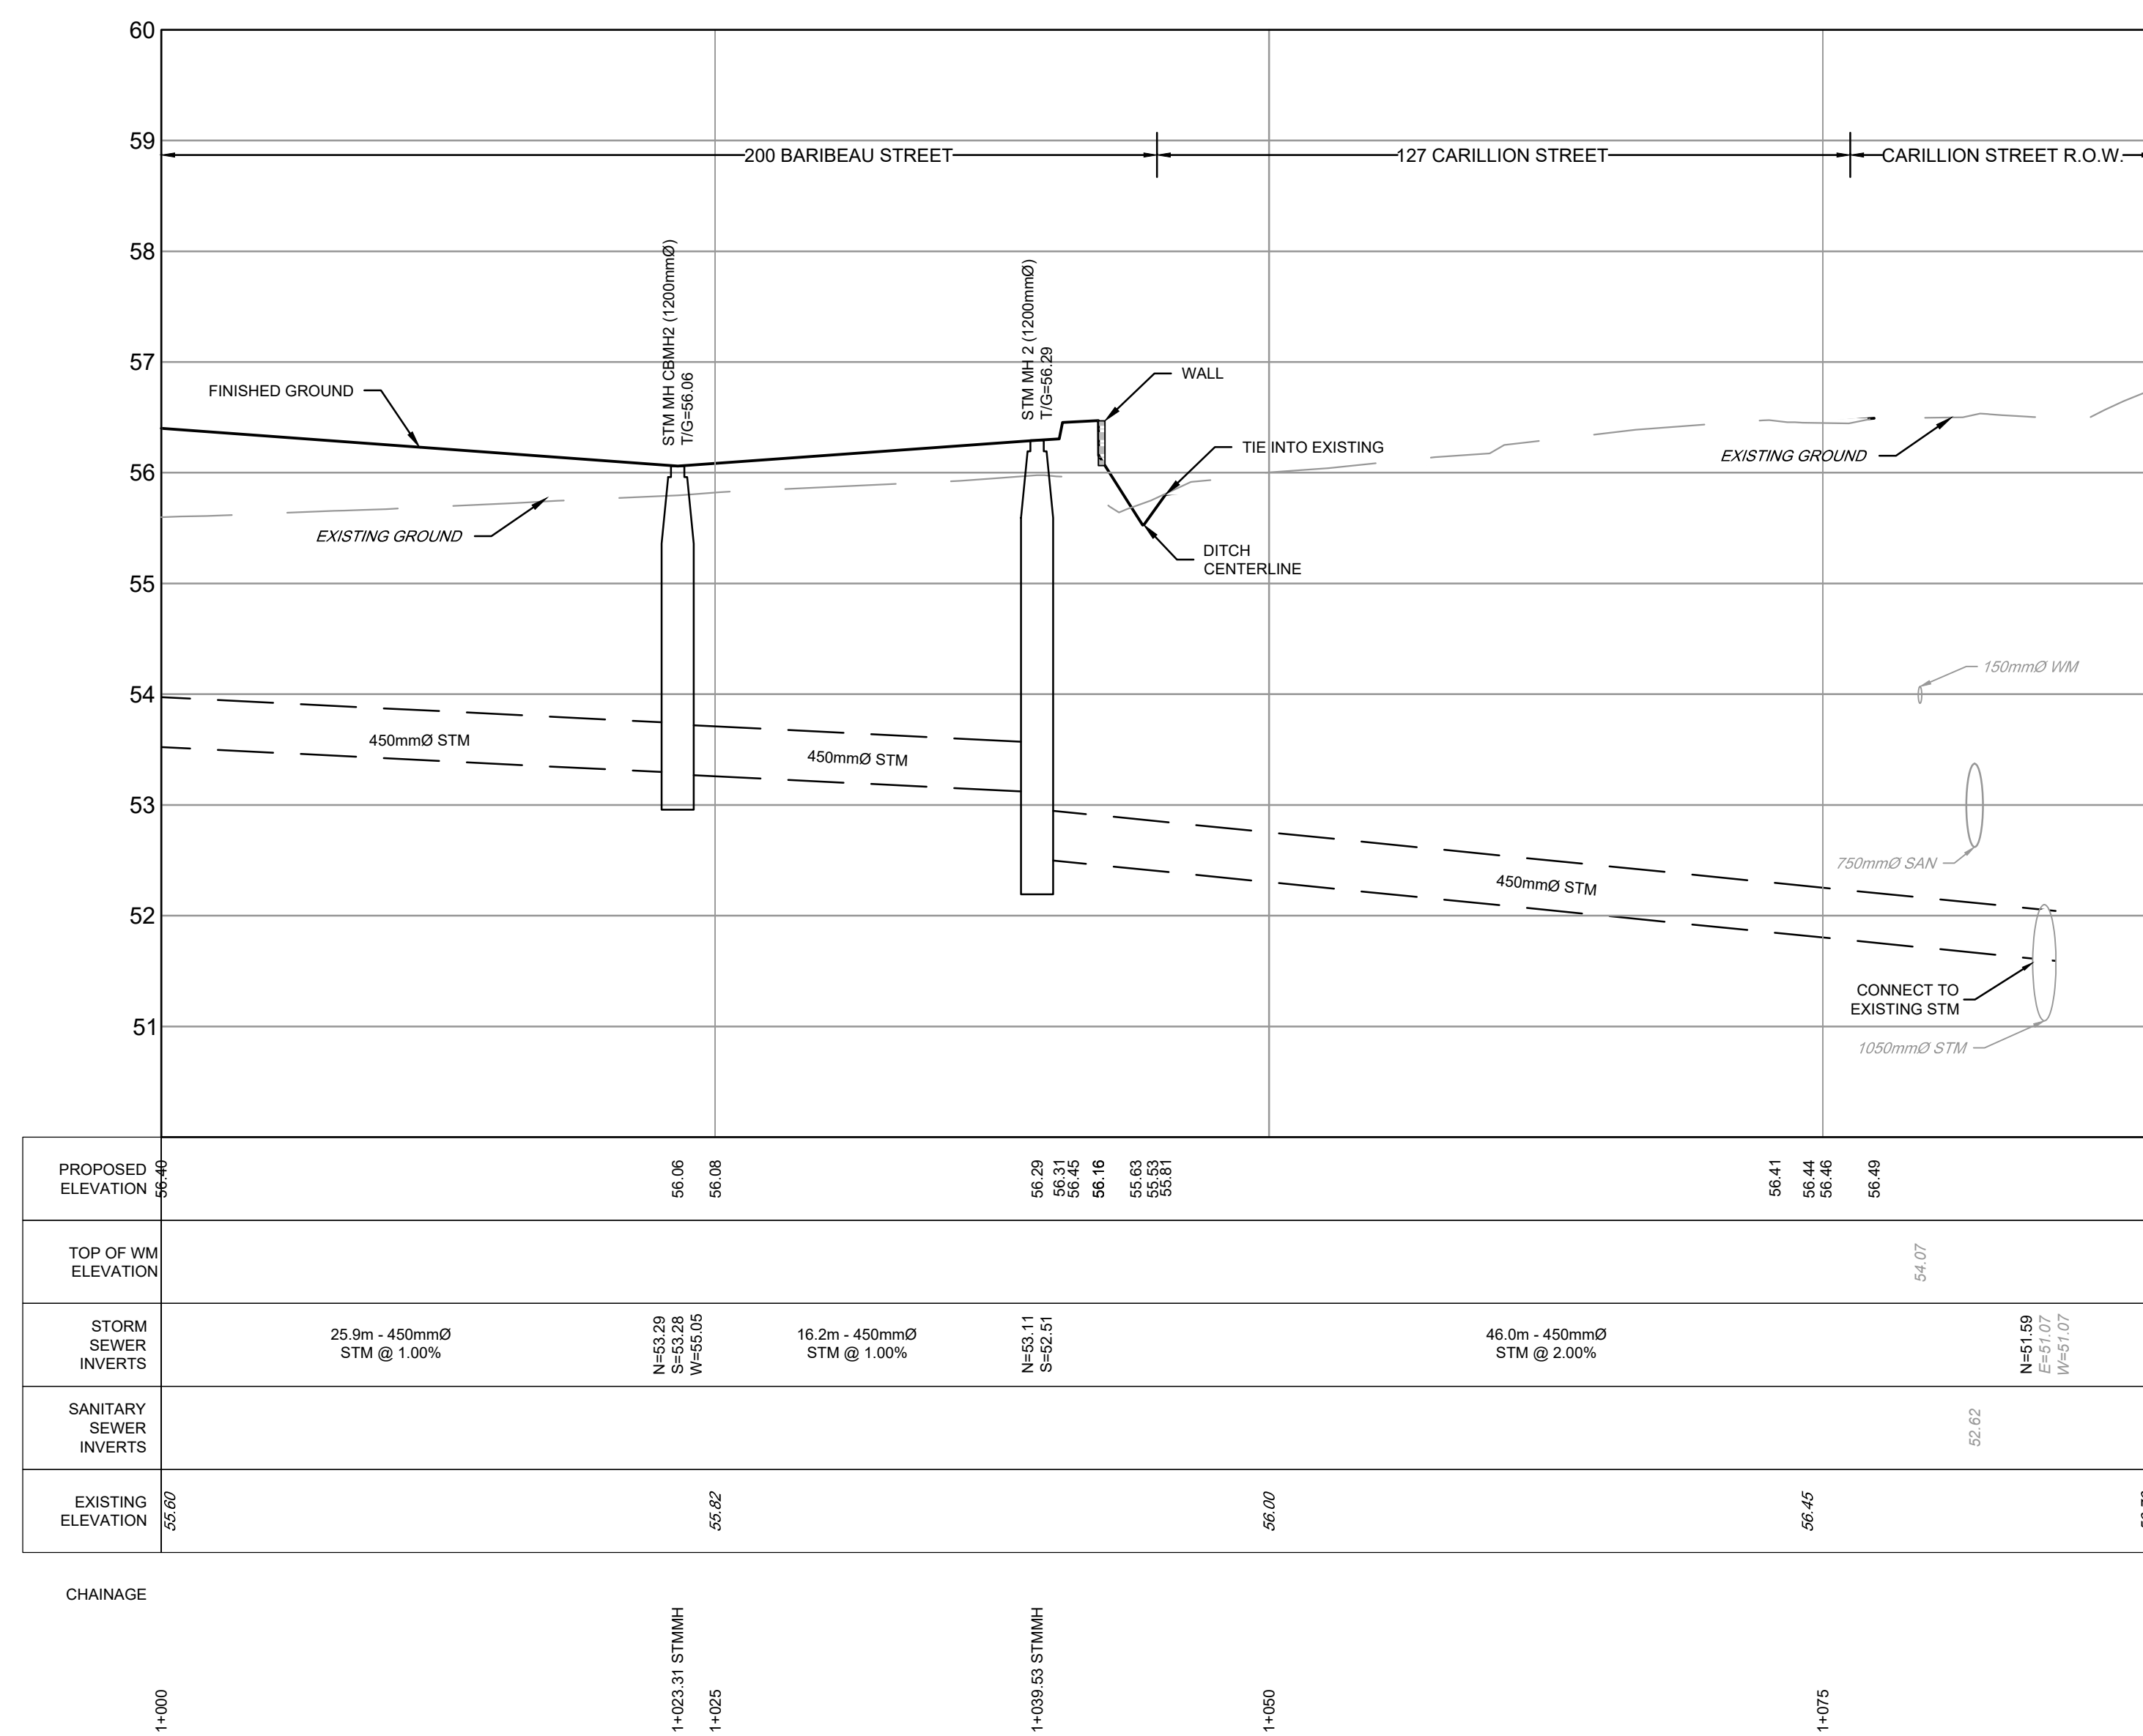

C:\Users\110686240\OneDrive\Documents\PR1121\_Oct 09\_2024\_12:20pm.dwg

NOTE:  
THE POSITION OF ALL POLE LINES, CONDUITS,  
WATERMANS, SEWERS AND OTHER  
UNDERGROUND AND OVERGROUND UTILITIES AND  
STRUCTURES IS NOT NECESSARILY SHOWN ON  
THE CONTRACT DRAWINGS, AND WHERE SHOWN,  
THE ACCURACY OF THE POSITION OF SUCH  
UTILITIES AND STRUCTURES IS NOT GUARANTEED.  
BEFORE STARTING WORK, DETERMINE THE EXACT  
LOCATION OF ALL SUCH UTILITIES AND  
STRUCTURES AND ASSUME ALL LIABILITY FOR  
DAMAGE TO THEM.



| No. | REVISION                       | DATE | BY | No.       | REVISION | DATE | BY |
|-----|--------------------------------|------|----|-----------|----------|------|----|
| 8.  | UNDER DESIGN                   |      |    | XXX       | MAB      |      |    |
| 7.  | SITE PLAN UPDATE               |      |    | JUL 15/22 | MAB      |      |    |
| 6.  | ISSUED FOR ECA                 |      |    | MAR 24/22 | MAB      |      |    |
| 5.  | CITY SUBMISSION                |      |    | OCT 21/21 | MAB      |      |    |
| 4.  | CITY SUBMISSION                |      |    | AUG 3/21  | MAB      |      |    |
| 3.  | CITY SUBMISSION                |      |    | JUN 8/21  | MAB      |      |    |
| 2.  | CITY SUBMISSION                |      |    | FEB 5/21  | MAB      |      |    |
| 1.  | STORM OUTLET VIA 127 CARILLION |      |    | OCT 29/20 | MAB      |      |    |

SCALE

1:250

HORIZONTAL

1:50

VERTICAL

FOR REVIEW ONLY

DESIGN: DTD

CHECKED: LRW

DRAWN: DTD

CHECKED: LRW

APPROVED: MAB

REGISTERED PROFESSIONAL ENGINEER  
L.R. WILSON  
100180055  
PROVINCE OF ONTARIO

REGISTERED PROFESSIONAL ENGINEER  
M.A. BISSETT  
2026.03.13  
PROVINCE OF ONTARIO

**NOVATECH**

Engineers, Planners & Landscape Architects  
Suite 200, 240 Michael Cowpland Drive  
Ottawa, Ontario, Canada K2M 1P6

Telephone: (613) 254-9643  
Facsimile: (613) 254-5867  
Website: www.novatech-eng.com

CITY OF OTTAWA  
DOMINION VILLAGE - 200 BARIBEAU STREET

PLAN AND PROFILE  
STM OUTLET VIA 127 CARILLION  
1+000 to 1+090

PROJECT No.: 119068  
REV: REV #10  
DRAWING No.: 119068-PR1