



Drawing are not to be scaled. Contractor must check and verify all dimensions and conditions on the project and must report any discrepancies to the consultants before proceeding with the work. The use of this drawing or part thereof is forbidden without the written approval of the consultants.

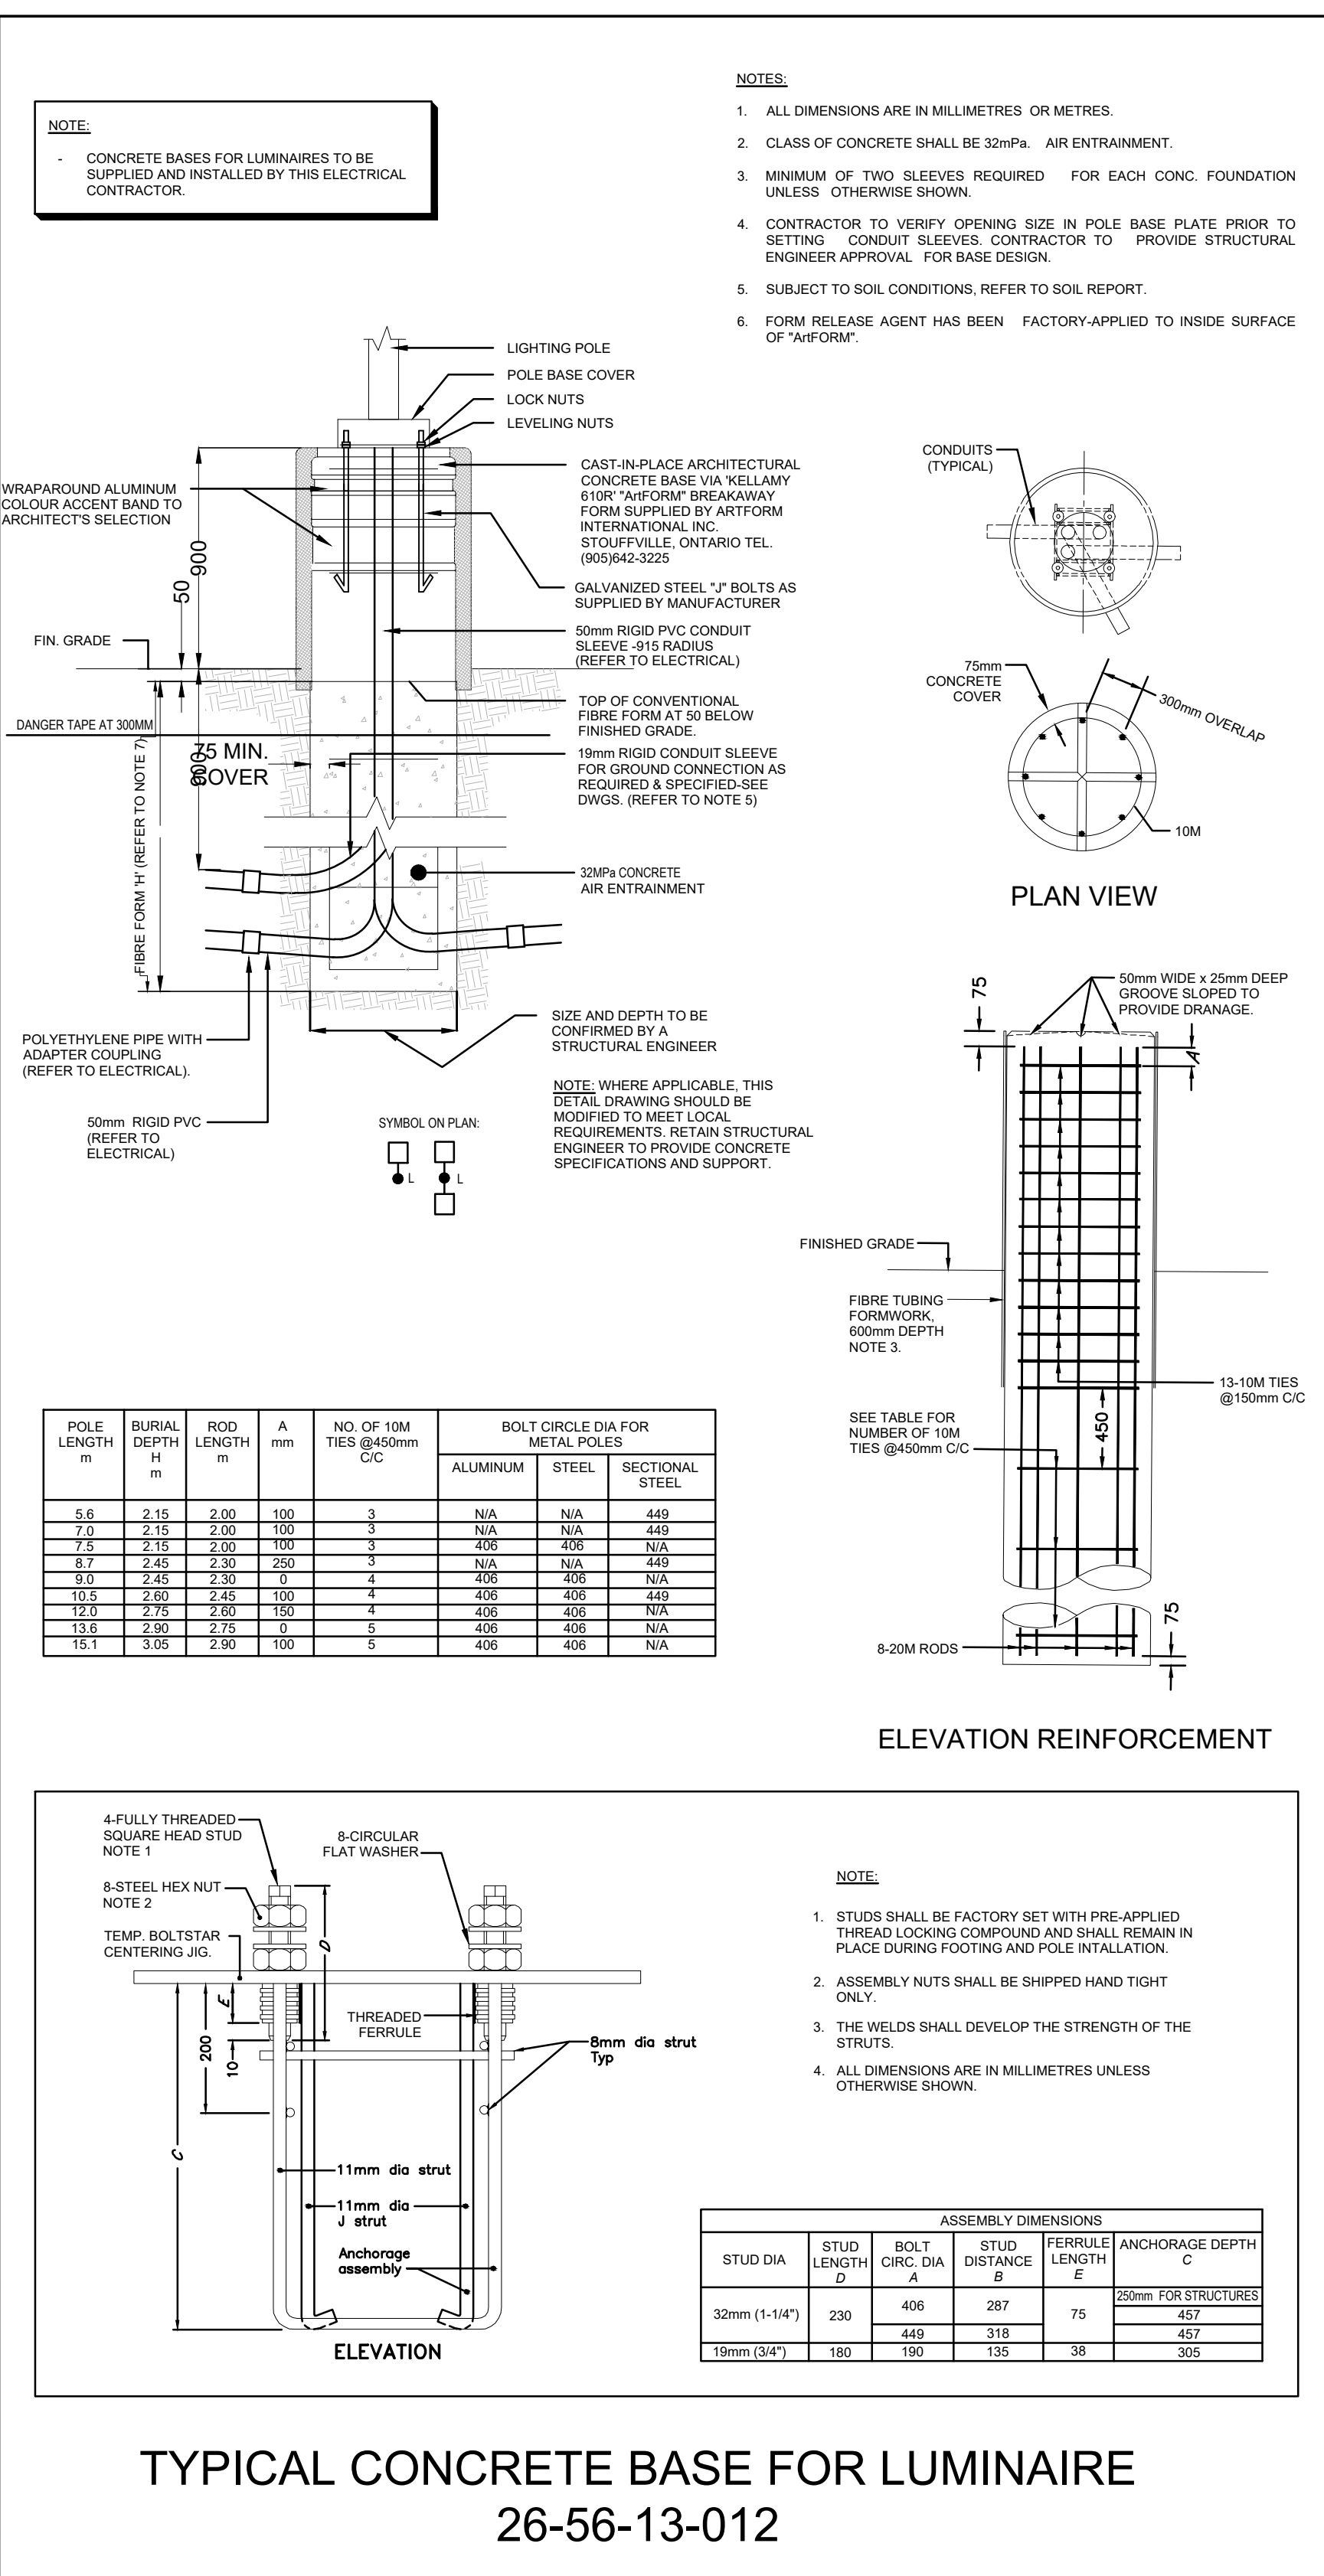

LIGHT FIXTURE SCHEDULE

TYPE	DESCRIPTION
AALL	LUMINAIRE/POLE ASSEMBLY CONSISTING OF A DOUBLE (2) LED LUMINAIRES WITH AN AREA ROUND DISTRIBUTION PATTERN. 347V OUTDOOR USE BALLAST ON A 30"-Ø SQUARE STEEL POLE WITH POLE BASE COVER ON 36" CONCRETE BASE. COLOUR OF FINISH OF POLE/HEAD ARCHITECT/TOWNER SELECTION. LAMPS SHALL BE SUPPLIED WITH THE FIXTURE. FIXTURE TO HAVE FLAT LENS AND BE FULL CUT OFF. COOPER GALLEON SERIES GLEON-SA7C-740-9-5WQ-QM-XX
BBL1	LUMINAIRE/POLE ASSEMBLY CONSISTING OF A SINGLE (1) LED LUMINAIRE WITH A TYPE III DISTRIBUTION PATTERN. 347V OUTDOOR USE BALLAST ON A 30"-Ø SQUARE STEEL POLE WITH POLE BASE COVER ON 36" CONCRETE BASE. COLOUR OF FINISH OF POLE/HEAD TO ARCHITECT/TOWNER SELECTION. LAMPS SHALL BE SUPPLIED WITH THE FIXTURE. FIXTURE TO HAVE FLAT LENS AND BE FULL CUT OFF. FIXTURE TO BE CW HOUSE SIDE SHIELD. COOPER GALLEON SERIES GLEON-SA7C-740-9-13-QM-XX-HSS
CCLL	LUMINAIRE/POLE ASSEMBLY CONSISTING OF A SINGLE (1) LED LUMINAIRE WITH A TYPE IV DISTRIBUTION PATTERN. 347V OUTDOOR USE BALLAST ON A 30"-Ø SQUARE STEEL POLE WITH POLE BASE COVER ON 36" CONCRETE BASE. COLOUR OF FINISH OF POLE/HEAD TO ARCHITECT/TOWNER SELECTION. LAMPS SHALL BE SUPPLIED WITH THE FIXTURE. FIXTURE TO HAVE FLAT LENS AND BE FULL CUT OFF. FIXTURE TO BE CW HOUSE SIDE SHIELD. COOPER GALLEON SERIES GLEON-SA7C-740-9-T4-QM-XX-HSS

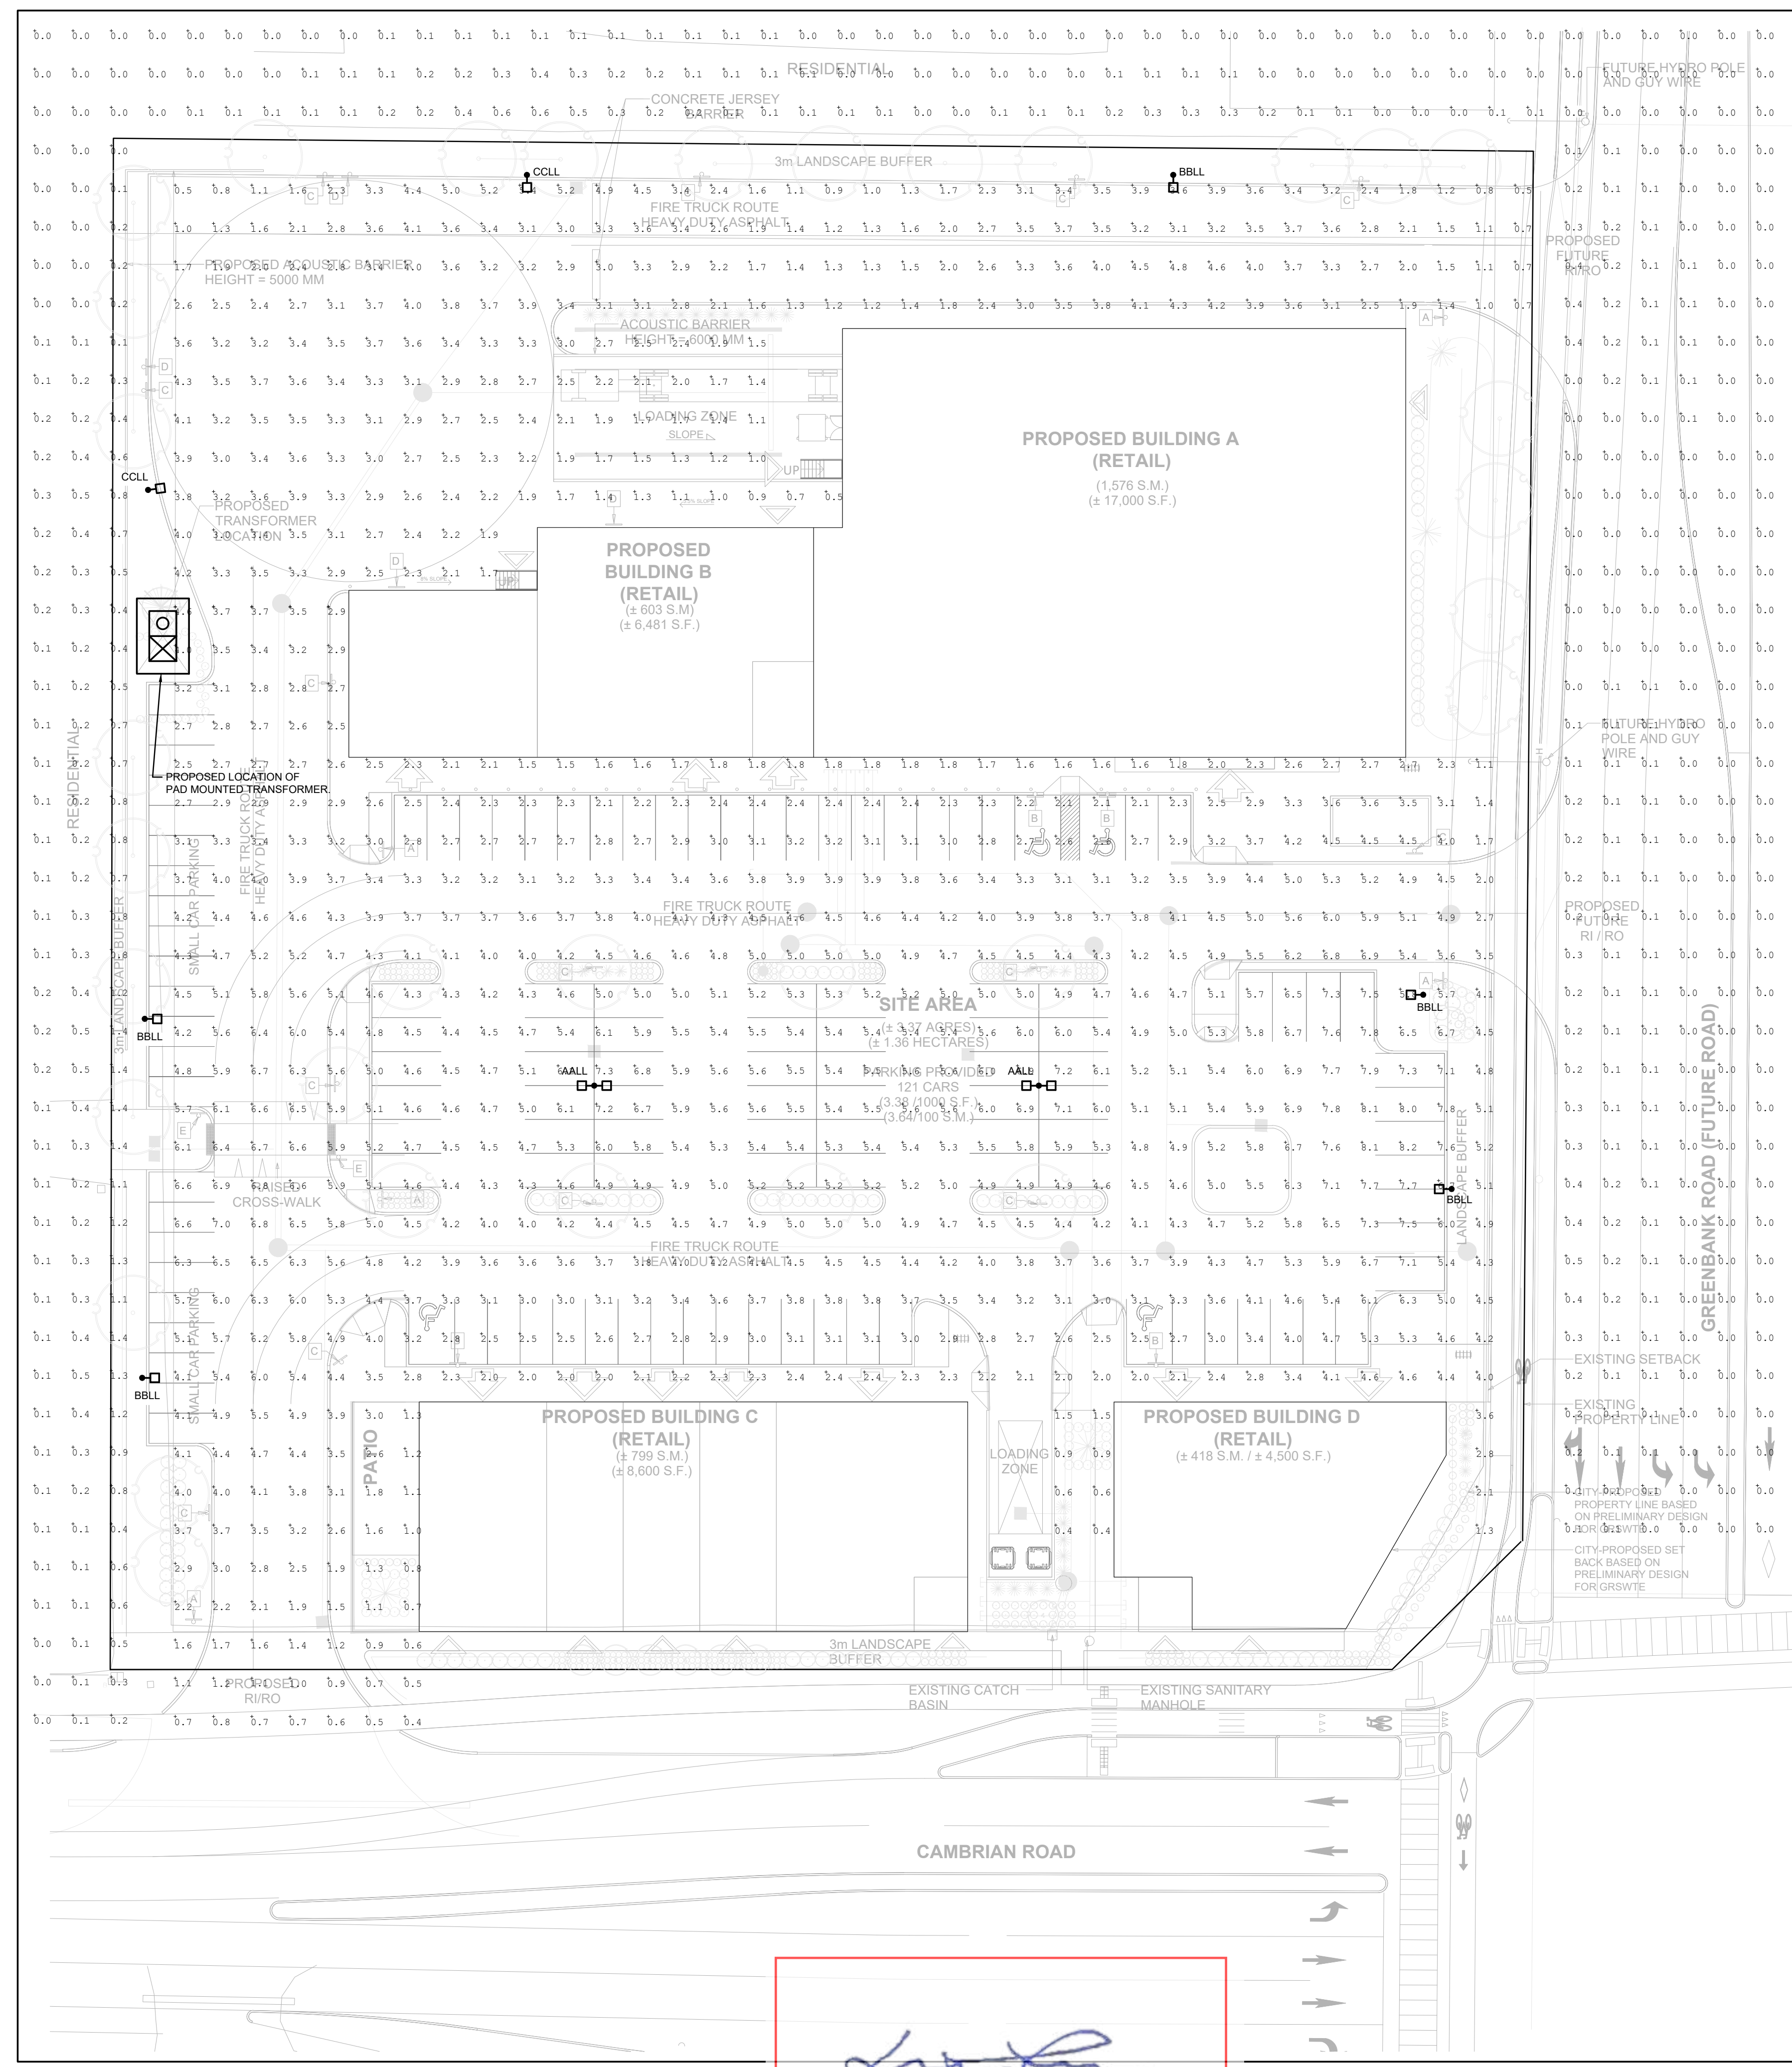

1 ELECTRICAL PHOTOMETRIC SITE PLAN
 SCALE: 1:300

APPROVED
 By Lily Xu at 4:53 pm, May 02, 2025

LILY XU, MCIP, RPP
 MANAGER, DEVELOPMENT REVIEW SOUTH
 PLANNING, DEVELOPMENT, AND BUILDING SERVICES
 DEPARTMENT, CITY OF OTTAWA

PLAN #: 18984 AND DEVELOPMENT #: D07-12-23-0049

#	DATE	DESCRIPTION	BY
5	2024-02-08	ISSUED FOR SITE PLAN CONTROL APPLICATION	BK
4	2023-10-16	ISSUED FOR SITE PLAN CONTROL APPLICATION	BK
3	2023-04-28	ISSUED FOR SITE PLAN CONTROL APPLICATION	BK
2	2023-03-14	ISSUED FOR COORDINATION	BK
1	2022-11-16	ISSUED FOR COORDINATION	BK



PROJECT
CAMBRIAN RD (N. PARCEL)
 BARRHAVEN, ONTARIO

DRAWING
**ELECTRICAL PHOTOMETRIC
 SITE PLAN**

PROJECT NO. 22-013-006	
PROJECT DATE 2022-11-02	
DRAWN BY BD	
CHECKED BY BK	
SCALE AS NOTED	

DRAWING NO. **ESP** REV.