


LIGHTING FIXTURE SCHEDULE										
TYPE	DESCRIPTION	LAMPS					DIMMING OPTION	VOLT	MOUNTING	REMARKS
		QTY	TYPE	WATTS	COLOUR	LUMENS				
A	EXTERIOR BUILDING MOUNTED LIGHT WALL PACK SHALL BE LITHONIA DSXW-1 SERIES.	10	LED	73W	4000K	10,000	134		347	BUILDING MOUNT HEIGHT AS SHOWN - FULL CUT-OFF - BLACK FINISH - 80 CRI - FORWARD THROW MEDIUM DISTRIBUTION - INTEGRAL DRIVER
A1	EXTERIOR BUILDING MOUNTED LIGHT WALL PACK SHALL BE LITHONIA DSXW-1 SERIES.	10	LED	73W	4000K	10,000	134		347	BUILDING MOUNT HEIGHT AS SHOWN - FULL CUT-OFF - BLACK FINISH - 80 CRI - TYPE 4 MEDIUM DISTRIBUTION - INTEGRAL DRIVER

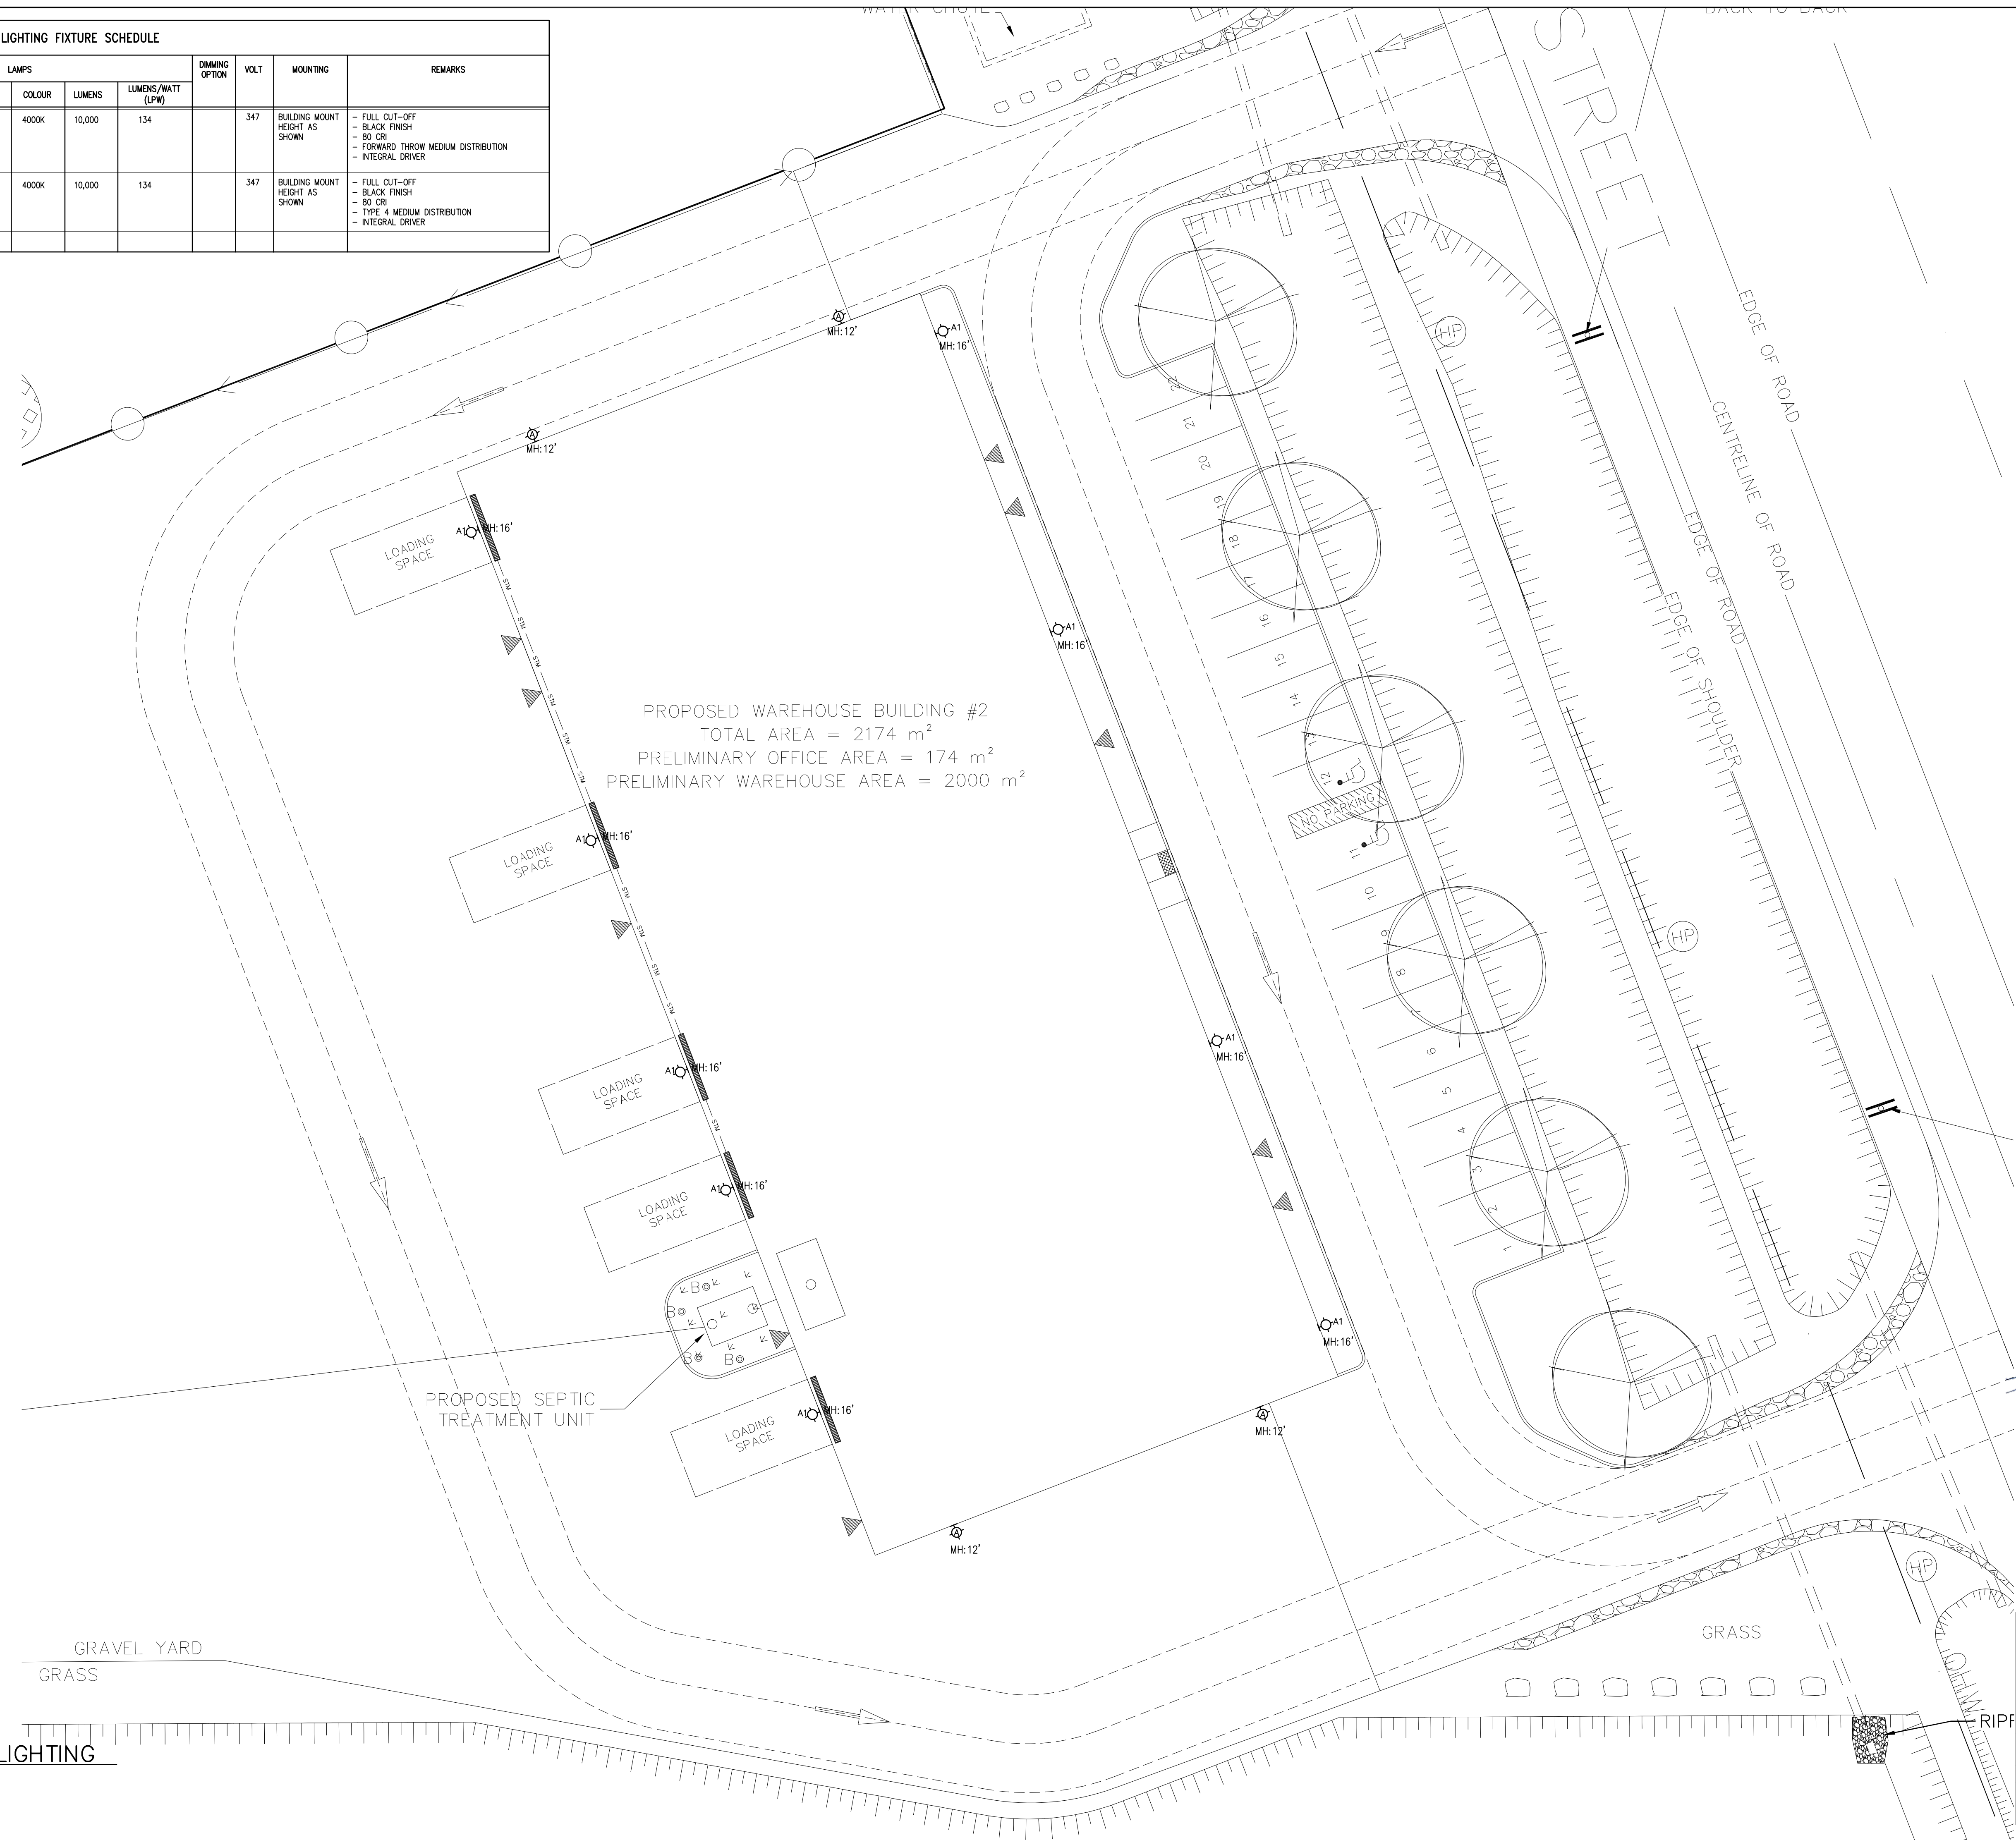

NOTES:

THESE DESIGN DOCUMENTS ARE PREPARED SOLELY FOR THE USE BY THE PARTY WITH WHOM THE DESIGN PROFESSIONAL HAS ENTERED INTO A CONTRACT AND THERE ARE NO REPRESENTATIONS OF ANY KIND MADE BY THE DESIGN PROFESSIONAL TO ANY PARTY WITH WHOM THE DESIGN PROFESSIONAL HAS NOT ENTERED INTO A CONTRACT.

THE PAPER COPY OF THE DRAWINGS ISSUED FOR BUILDING PERMIT AND/OR TENDER WILL TAKE PRECEDENCE OVER ELECTRONIC COPIES.


THE ENGINEER WAIVES ANY AND ALL RESPONSIBILITY AND LIABILITY FOR PROBLEMS THAT ARISE FROM FAILURE TO FOLLOW THESE PLANS, SPECIFICATIONS AND THE DESIGN INTENT THEY CONVEY, OR FOR PROBLEMS WHICH ARISE FROM OTHER FAILURE TO OBTAIN AND / OR FOLLOW ENGINEER'S GUIDANCE WITH RESPECT TO ANY ERRORS, OMISSIONS, INCONSISTENCIES, AMBIGUITIES OR CONFLICTS WHICH ARE ALLEGED.

THIS DRAWING IS THE PROPERTY OF 4C ENG AND ALL COPYRIGHTS ARE RESERVED. NO USE OF THIS DRAWING MAY BE MADE WITHOUT EXPRESS WRITTEN CONSENT.

DO NOT SCALE DRAWINGS.



1.	ISSUED FOR SITE PLAN APPLICATION	MAR 3/25
REV:	DESCRIPTION:	DATE:

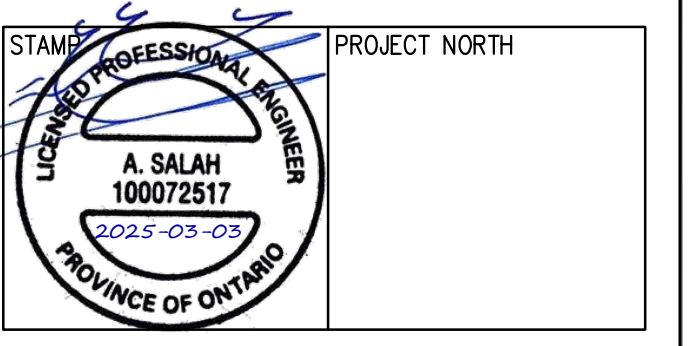

PROJECT:  
**CAMM HEAVY MACHINERY MOVERS LTD., 6622 BANK ST, OTTAWA, ONTARIO**

DRAWING:  
**ELECTRICAL:  
SITE PLAN LIGHTING**

DATE:	DRAWN:	DESIGNED:	CHECKED:
FEB 2025	J.N.	J.N.	A.S.
SCALE: AS SHOWN	DRAWING NO:		E-2
PROJECT NO:	25001		
			OF 1

1 SITE PLAN LIGHTING  
E-2 1/16" = 1'-0"