


Name: H. G. VAN DE GLIND
Number: 100647862

Limitations: Inspecting, designing, and assessing
residential and commercial sewage systems, grading designs
and soil analysis, and overseeing installation and compliance.

Association of Professional Engineers of Ontario

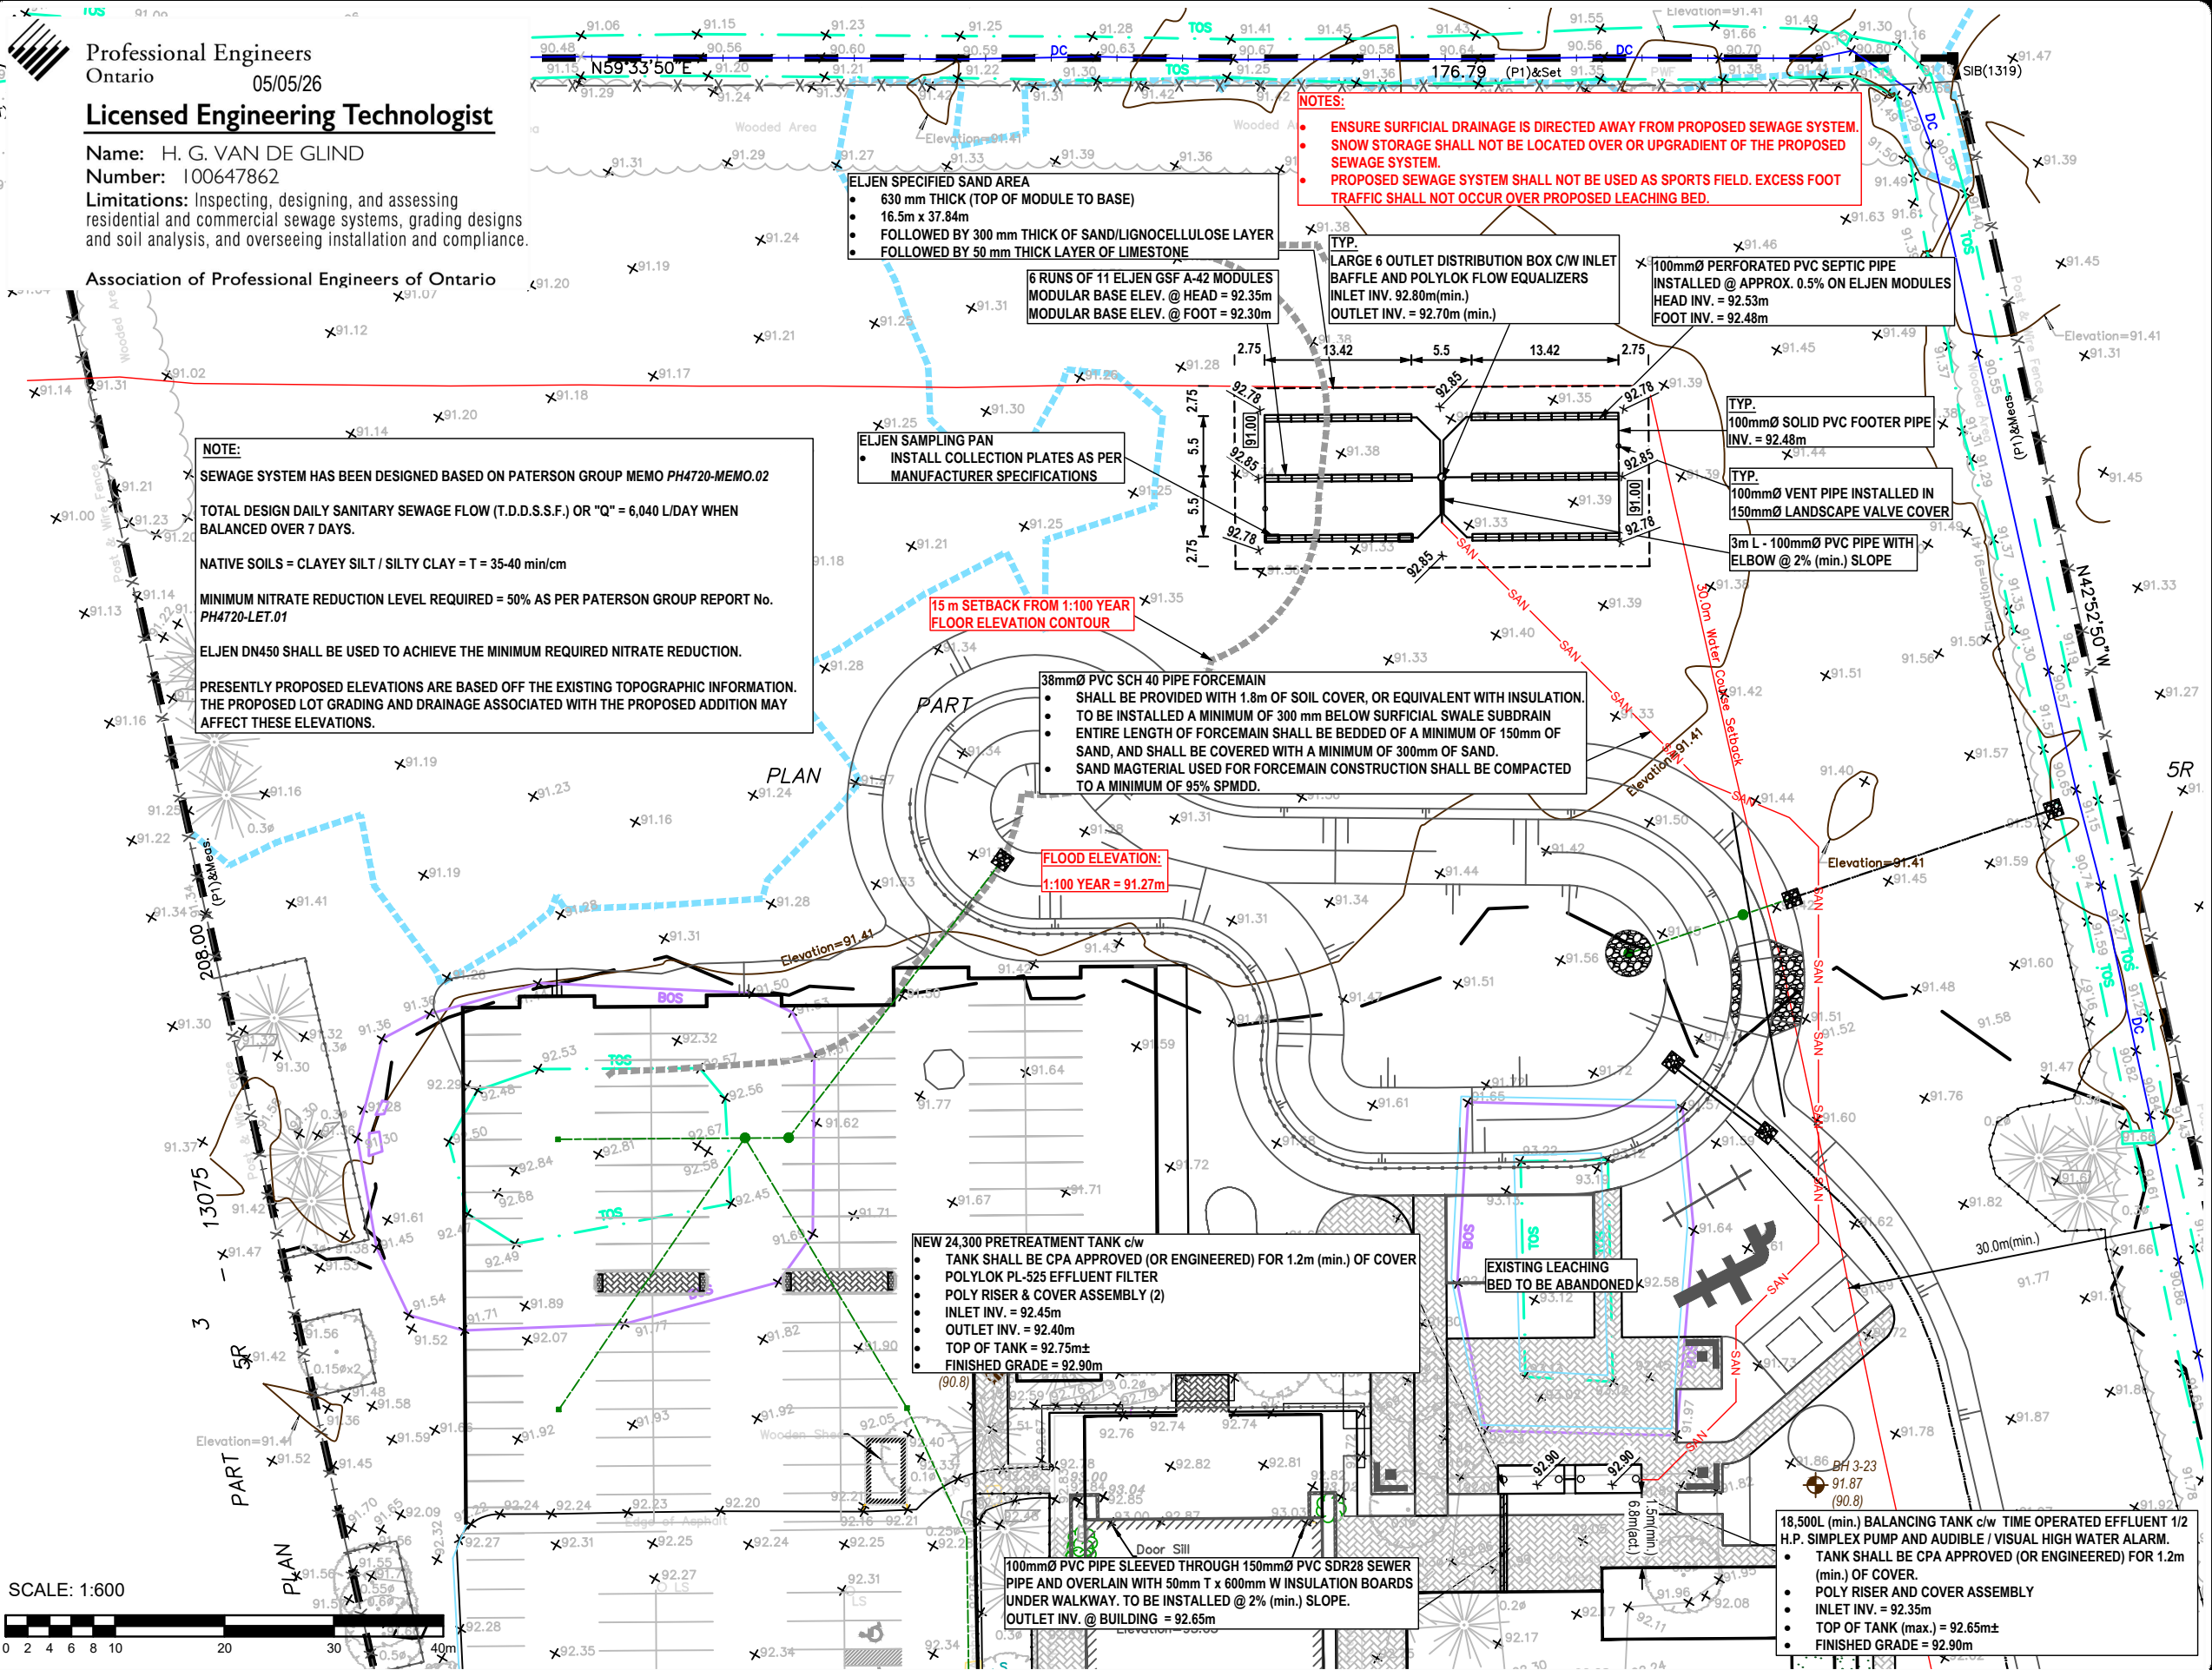

LEGEND:

- Test Hole Location
- x 100.99 Existing Ground Surface Elev. (m)
- x 102.30 Proposed Ground Surface Elev. (m)
- 91.50 Proposed Subgrade Elev. (m)
- (99.99) Ground Water Elev. (m) - 17/07/23
- T/C Top of Foundation Wall
- Existing Structure
- Proposed Structure
- Existing Coniferous Tree
- Existing Deciduous Tree

All units are in meters unless otherwise specified.

REFERENCE:

Base Plan Information obtained from Proposed Site Plan A1.0, dated August 29, 2024, by Lawrence Architect Inc. and from Site Grading Plan No. SG-1, dated September 2024 by Tatham Engineering

DD/MM/YY	DESCRIPTION	REV.
04/05/26	Issued with Revised Site Plan	6
07/01/26	Sewage System Location Revised	5
03/02/25	Issued with PH4720-MEMO.02	4
22/11/24	Proposed Grading Information Added	3
14/11/24	30m Setback Revised to Top of Bank	2
15/10/24	Proposed Grading Information Added	1
13/09/24	Issued for Preliminary Review	0

Consultant:

PATERSON GROUP

9 AURIGA DRIVE
OTTAWA, ON
K2E 7S9
TEL: (613) 226-7381

Client:

**BRUNSTAD
CHRISTIAN CHURCH**

Project:

**PROPOSED ADDITION TO
EXISTING CHURCH**

**1981 CENTURY ROAD
OTTAWA (CARP), ONTARIO**

Drawing:

**SEWAGE SYSTEM
LAYOUT PLAN**

Scale:	1:600	Drawn by:	HV
Date:	05/2026	Checked by:	MK

Drawing No.:

PH4720-1(rev.6)

p:\autocad drawings\hydrogeology\ph4720-1-ph4720-1-brunstad christian church - 1981 century road, ottawa\ph4720-1(rev.6)-client.dwg