
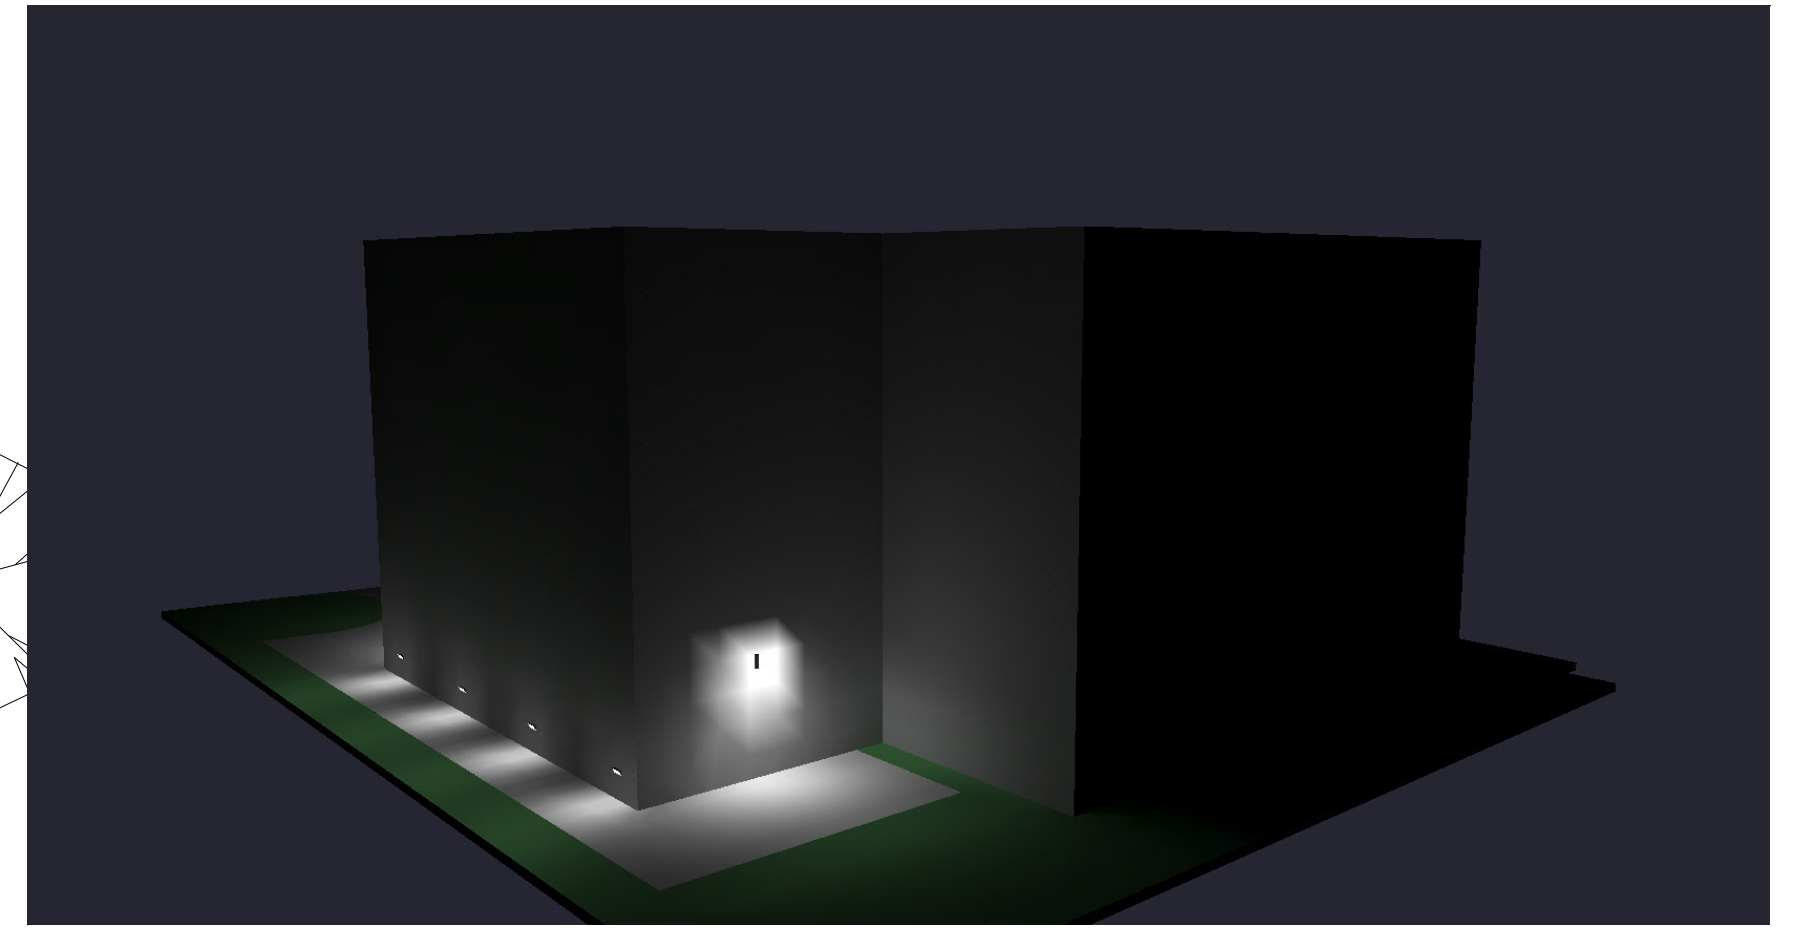
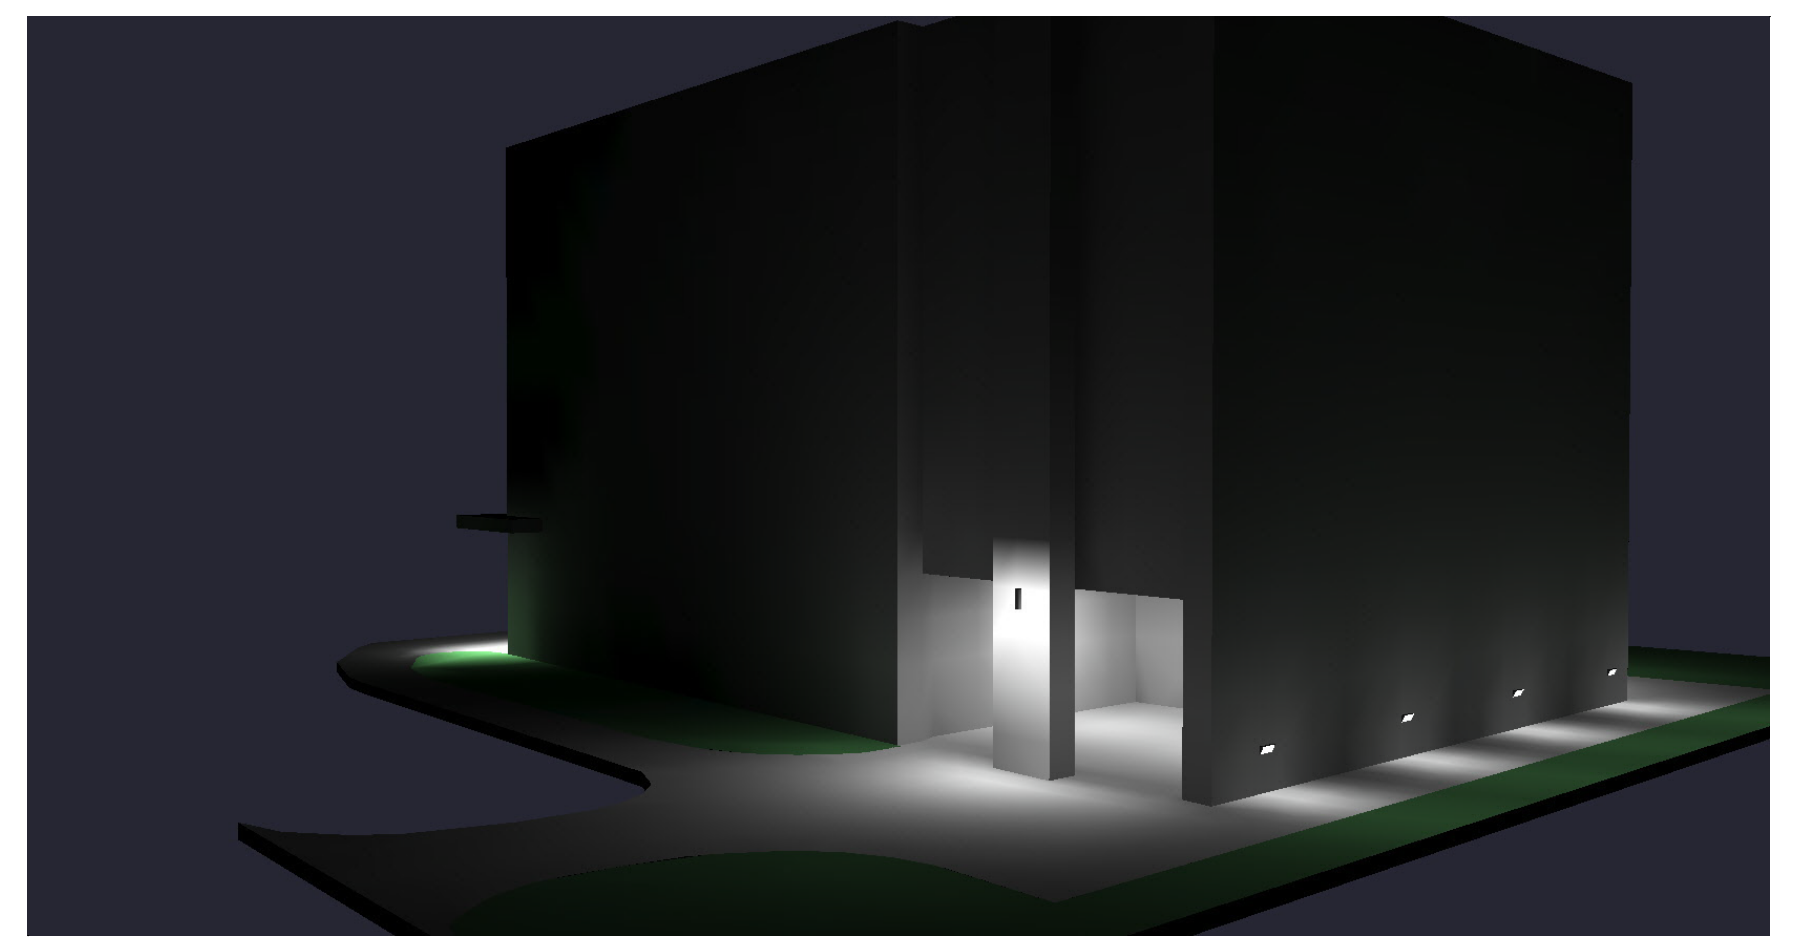


Calculation Summary							
Label	CalcType	Units	Avg	Max	Min	Avg/Min	Max/Min
pathway_Top	Illuminance	Fc	2.86	28.7	0.0	N.A.	N.A.
SPILLAGE	Illuminance	Fc	0.08	0.4	0.0	N.A.	N.A.

Luminaire Schedule						
Symbol	Qty	Label	Arrangement	LLF	Description	Lum. Lumens
⊙	2	EX1	SINGLE	0.900	DALS - FOCUS - CYL05-CC	1125
⊙	2	EX2	SINGLE	0.900	DALS - SHEILD - DSWC07-CC-V-BK	1994
⊙	2	EX3	SINGLE	0.900	TURO - RGD-HS/11/24W/MULTI-K/WH/D	1991
⊙	4	EX4	SINGLE	0.900	DALS - RISE - LSTP12-CC	318

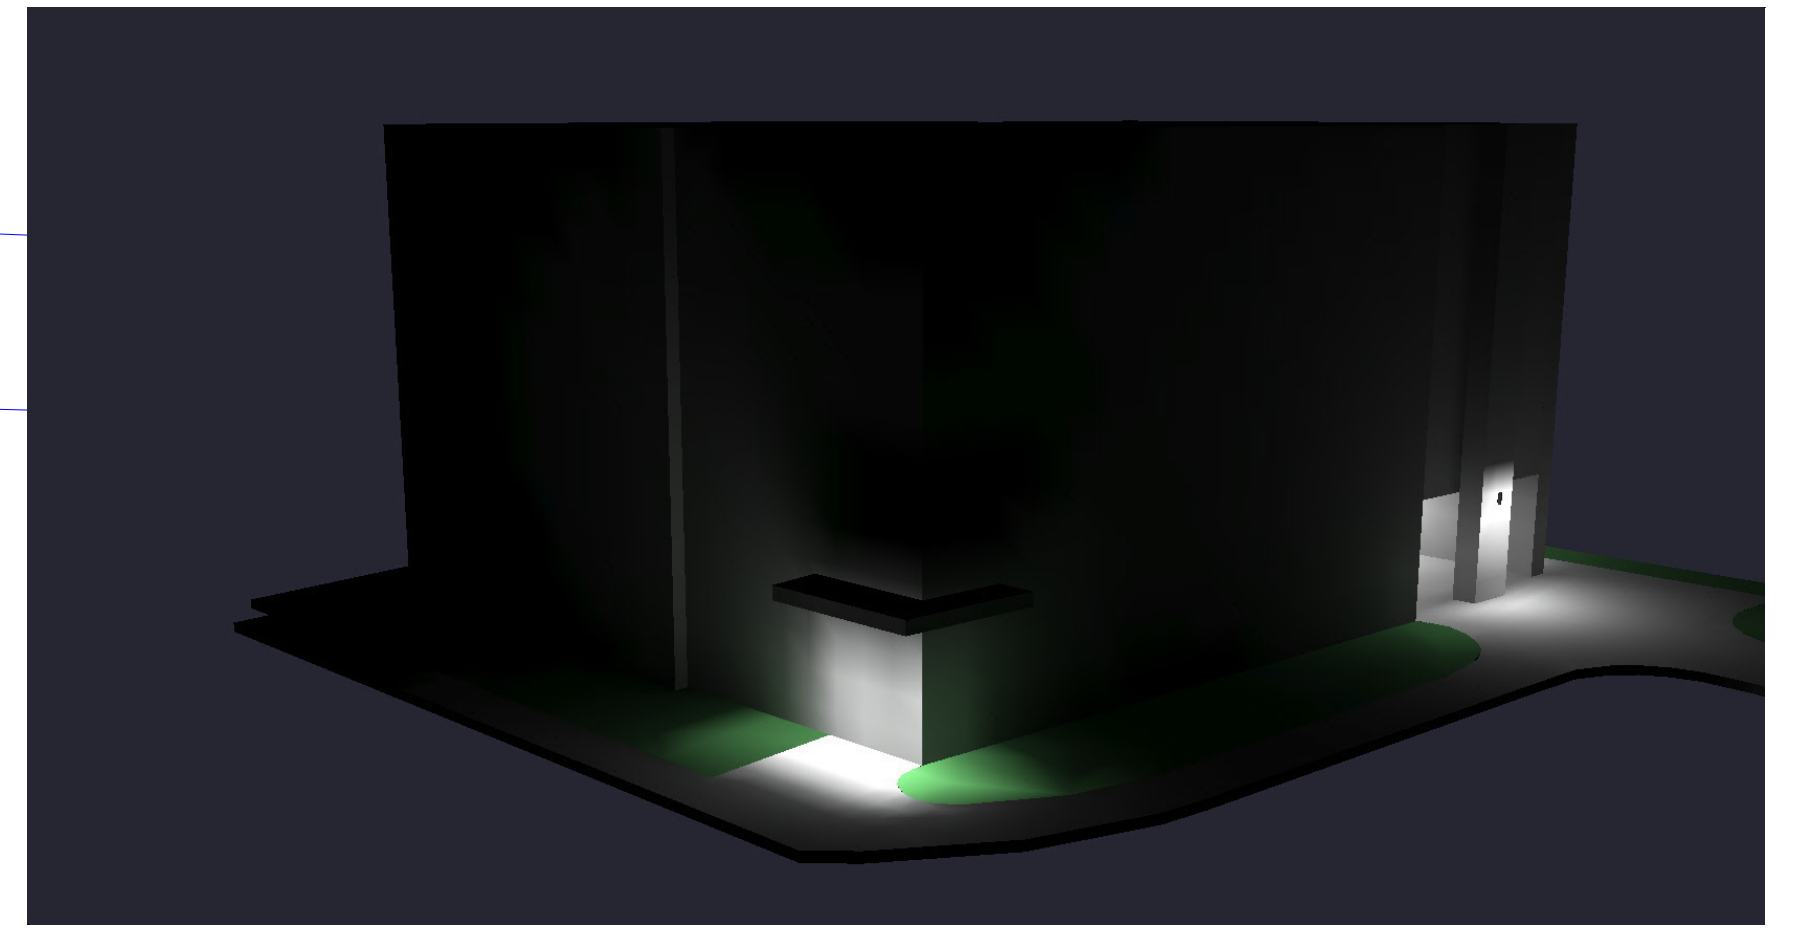

MVP LIGHTING
 Liam Beck
 em: liam@mvp-lighting.ca
 ph: 613-601-2042

Drawn By:
 Checked By:
 Date: 4/17/2025
 Scale:

222 BASELINE RD
 MVP LIGHTING