


# SOUTH MARCH BESS CIVIL PACKAGE

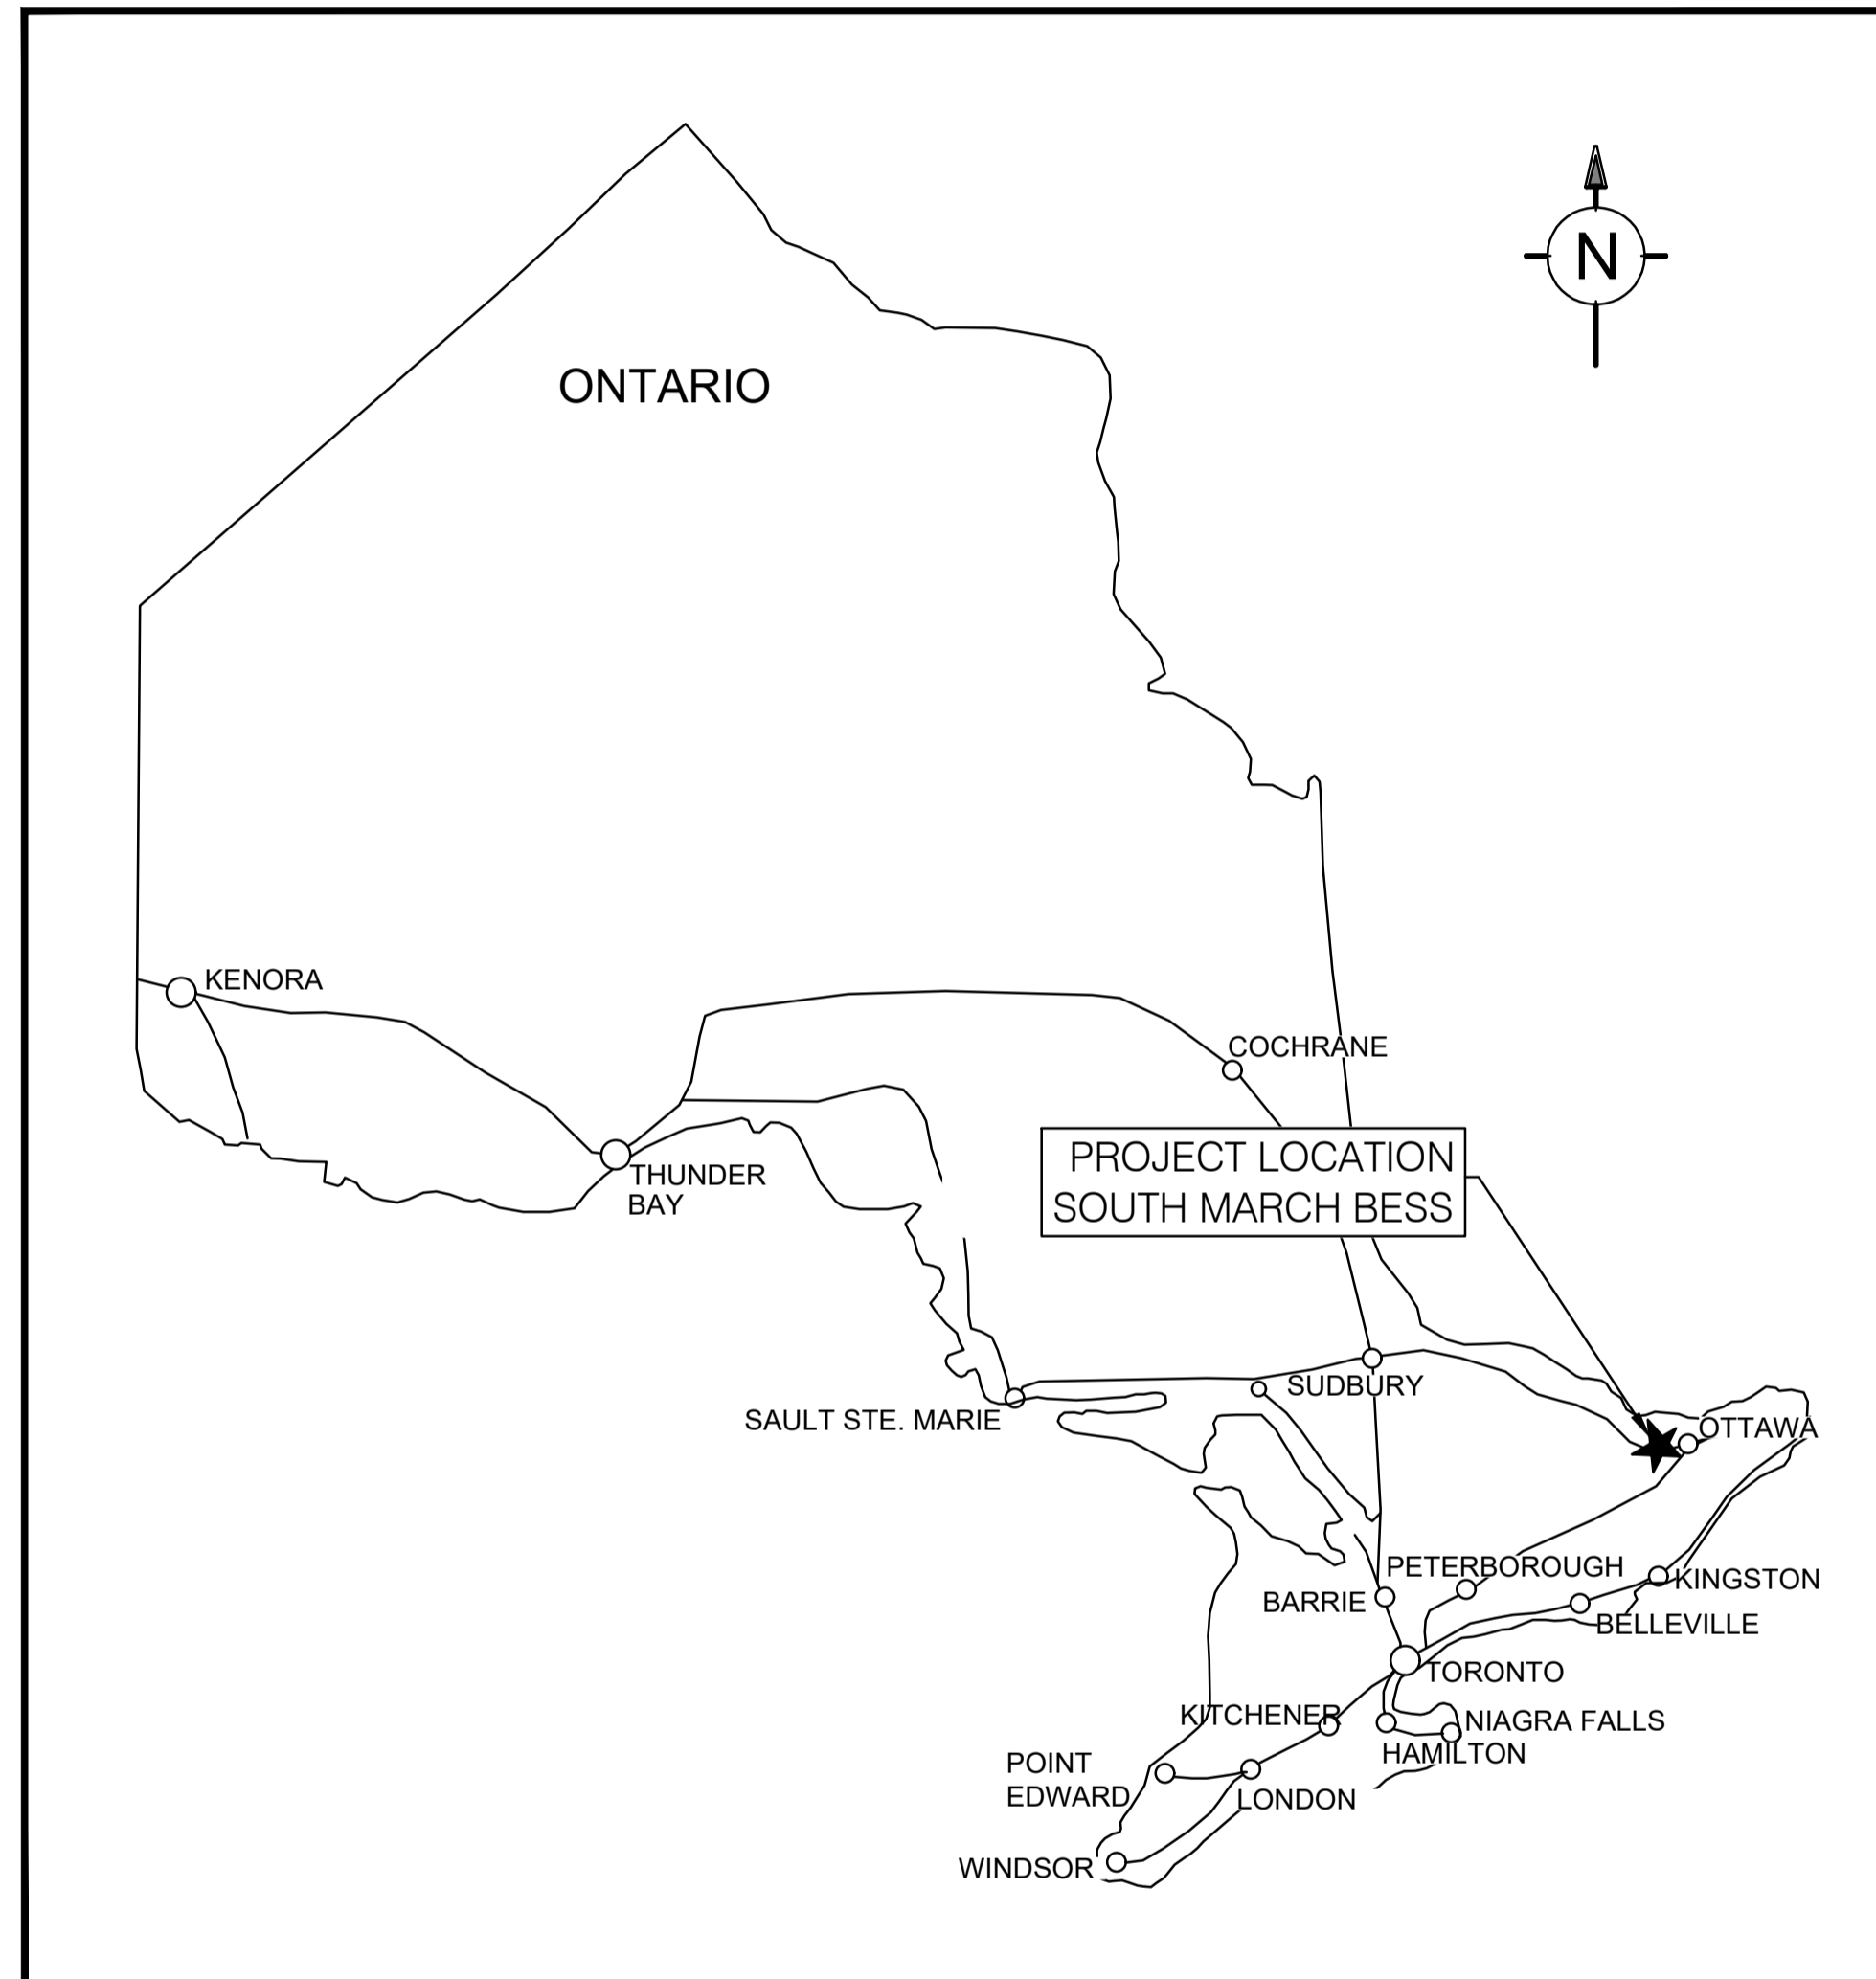

**KEY PLAN**  
SCALE: NTS

DRAWING INDEX				
BBA DRAWING NO.	REV.	DATE	CATEGORY	SHEET DESCRIPTION
7154023-100000-41-D01-0001	AE	2025-11-05	GENERAL	CIVIL COVER PAGE & DRAWING INDEX
7154023-100000-41-D01-0002	AD	2025-11-05	GENERAL	GENERAL NOTES, LEGEND AND ABBREVIATIONS
7154023-100000-41-D20-0001-01	AE	2025-11-05	PLAN	SITE PLAN - SHEET 1
7154023-100000-41-D20-0001-02	AI	2025-11-05	PLAN	SITE PLAN - SHEET 2
7154023-100000-41-D20-0003	AE	2025-11-05	PLAN	SITE SERVICING AND FIRE PROTECTION PLAN
7154023-100000-41-D20-0004	AC	2025-11-05	PLAN & SECTIONS	WET POND
7154023-100000-41-D20-0005	AD	2025-11-05	PLAN	ROAD & FINISHED GRADE
7154023-100000-41-D20-0006	AC	2025-11-05	PROFILES	SITE GRADING
7154023-100000-41-D20-0007	AA	2025-11-05	PLAN	SETBACK FROM EXISTING RESIDENCES
7154023-100000-41-D50-0001	AD	2025-11-05	DETAILS	STORMWATER AND WATER NETWORK
7154023-100000-41-D50-0002	AC	2025-11-05	DETAILS	ROAD AND DRAINAGE DETAILS
7154023-100000-41-D52-0001	AA	2025-11-05	PLAN	ROADS AND DITCHES , KEY PLAN
7154023-100000-41-D52-0002	AA	2025-11-05	PROFILES	ROADS AND DITCHES PROFILES
7154023-100000-41-D52-0003	AA	2025-11-05	PROFILES	ROADS AND DITCHES PROFILES
7154023-100000-41-D70-0001	AE	2025-11-05	PLAN	EROSION AND SEDIMENT CONTROL
7154023-100000-41-D70-0002	AD	2025-11-05	DETAILS	EROSION AND SEDIMENT CONTROL
7154023-100000-41-D90-0001	AC	2025-11-05	STANDARD DETAILS	SECURITY FENCING

**FOR PERMITTING**

DRAWING No.	DESCRIPTION	REV	DESCRIPTION	VERIFIED BY	APPROVED BY	DATE
ENVIRONMENTAL-STANTEC.DWG						
XR-160402040-L-PLANTING.DWG						
241451-SouthMarch_BESS-MTM9-Rev0						
SOUTH MARCH DITCH LINE TOPO						
7154023-402000-47-D20-0001	SOUTH MARCH BESS-250 MW 230KV-34.5 kV SUBSTATION	AA	FOR COMMENTS	E. AMELI	M. SHAHRAKI	2025-03-03
REFERENCE DRAWINGS						
REVISIONS						

SEAL:

**Evologen**  
by Brookfield Renewable

PROJECT: <b>SOUTH MARCH BESS</b>			
2555 AND 2625 MARCHURST RD, OTTAWA			
TITLE: GENERAL CIVIL COVER PAGE & DRAWING INDEX			
DESIGNED BY: B. THOMAS	DRAFTED BY: G. NORMAND		
VERIFIED BY: V. BRUNELLE	APPROVED BY: V. BRUNELLE		
SCALE: N/A	DATE: 2025-03-07		
DRAWING No.:	SHEET:	SIZE:	REV.
<b>7154023-100000-41-D01-0001</b>	<b>01</b>	<b>A1</b>	<b>AE</b>

BY: NORMAND, GABRIEL  
PRINTED: 2025-11-05 16:46:41