


SOUTH MARCH BESS

CIVIL PACKAGE

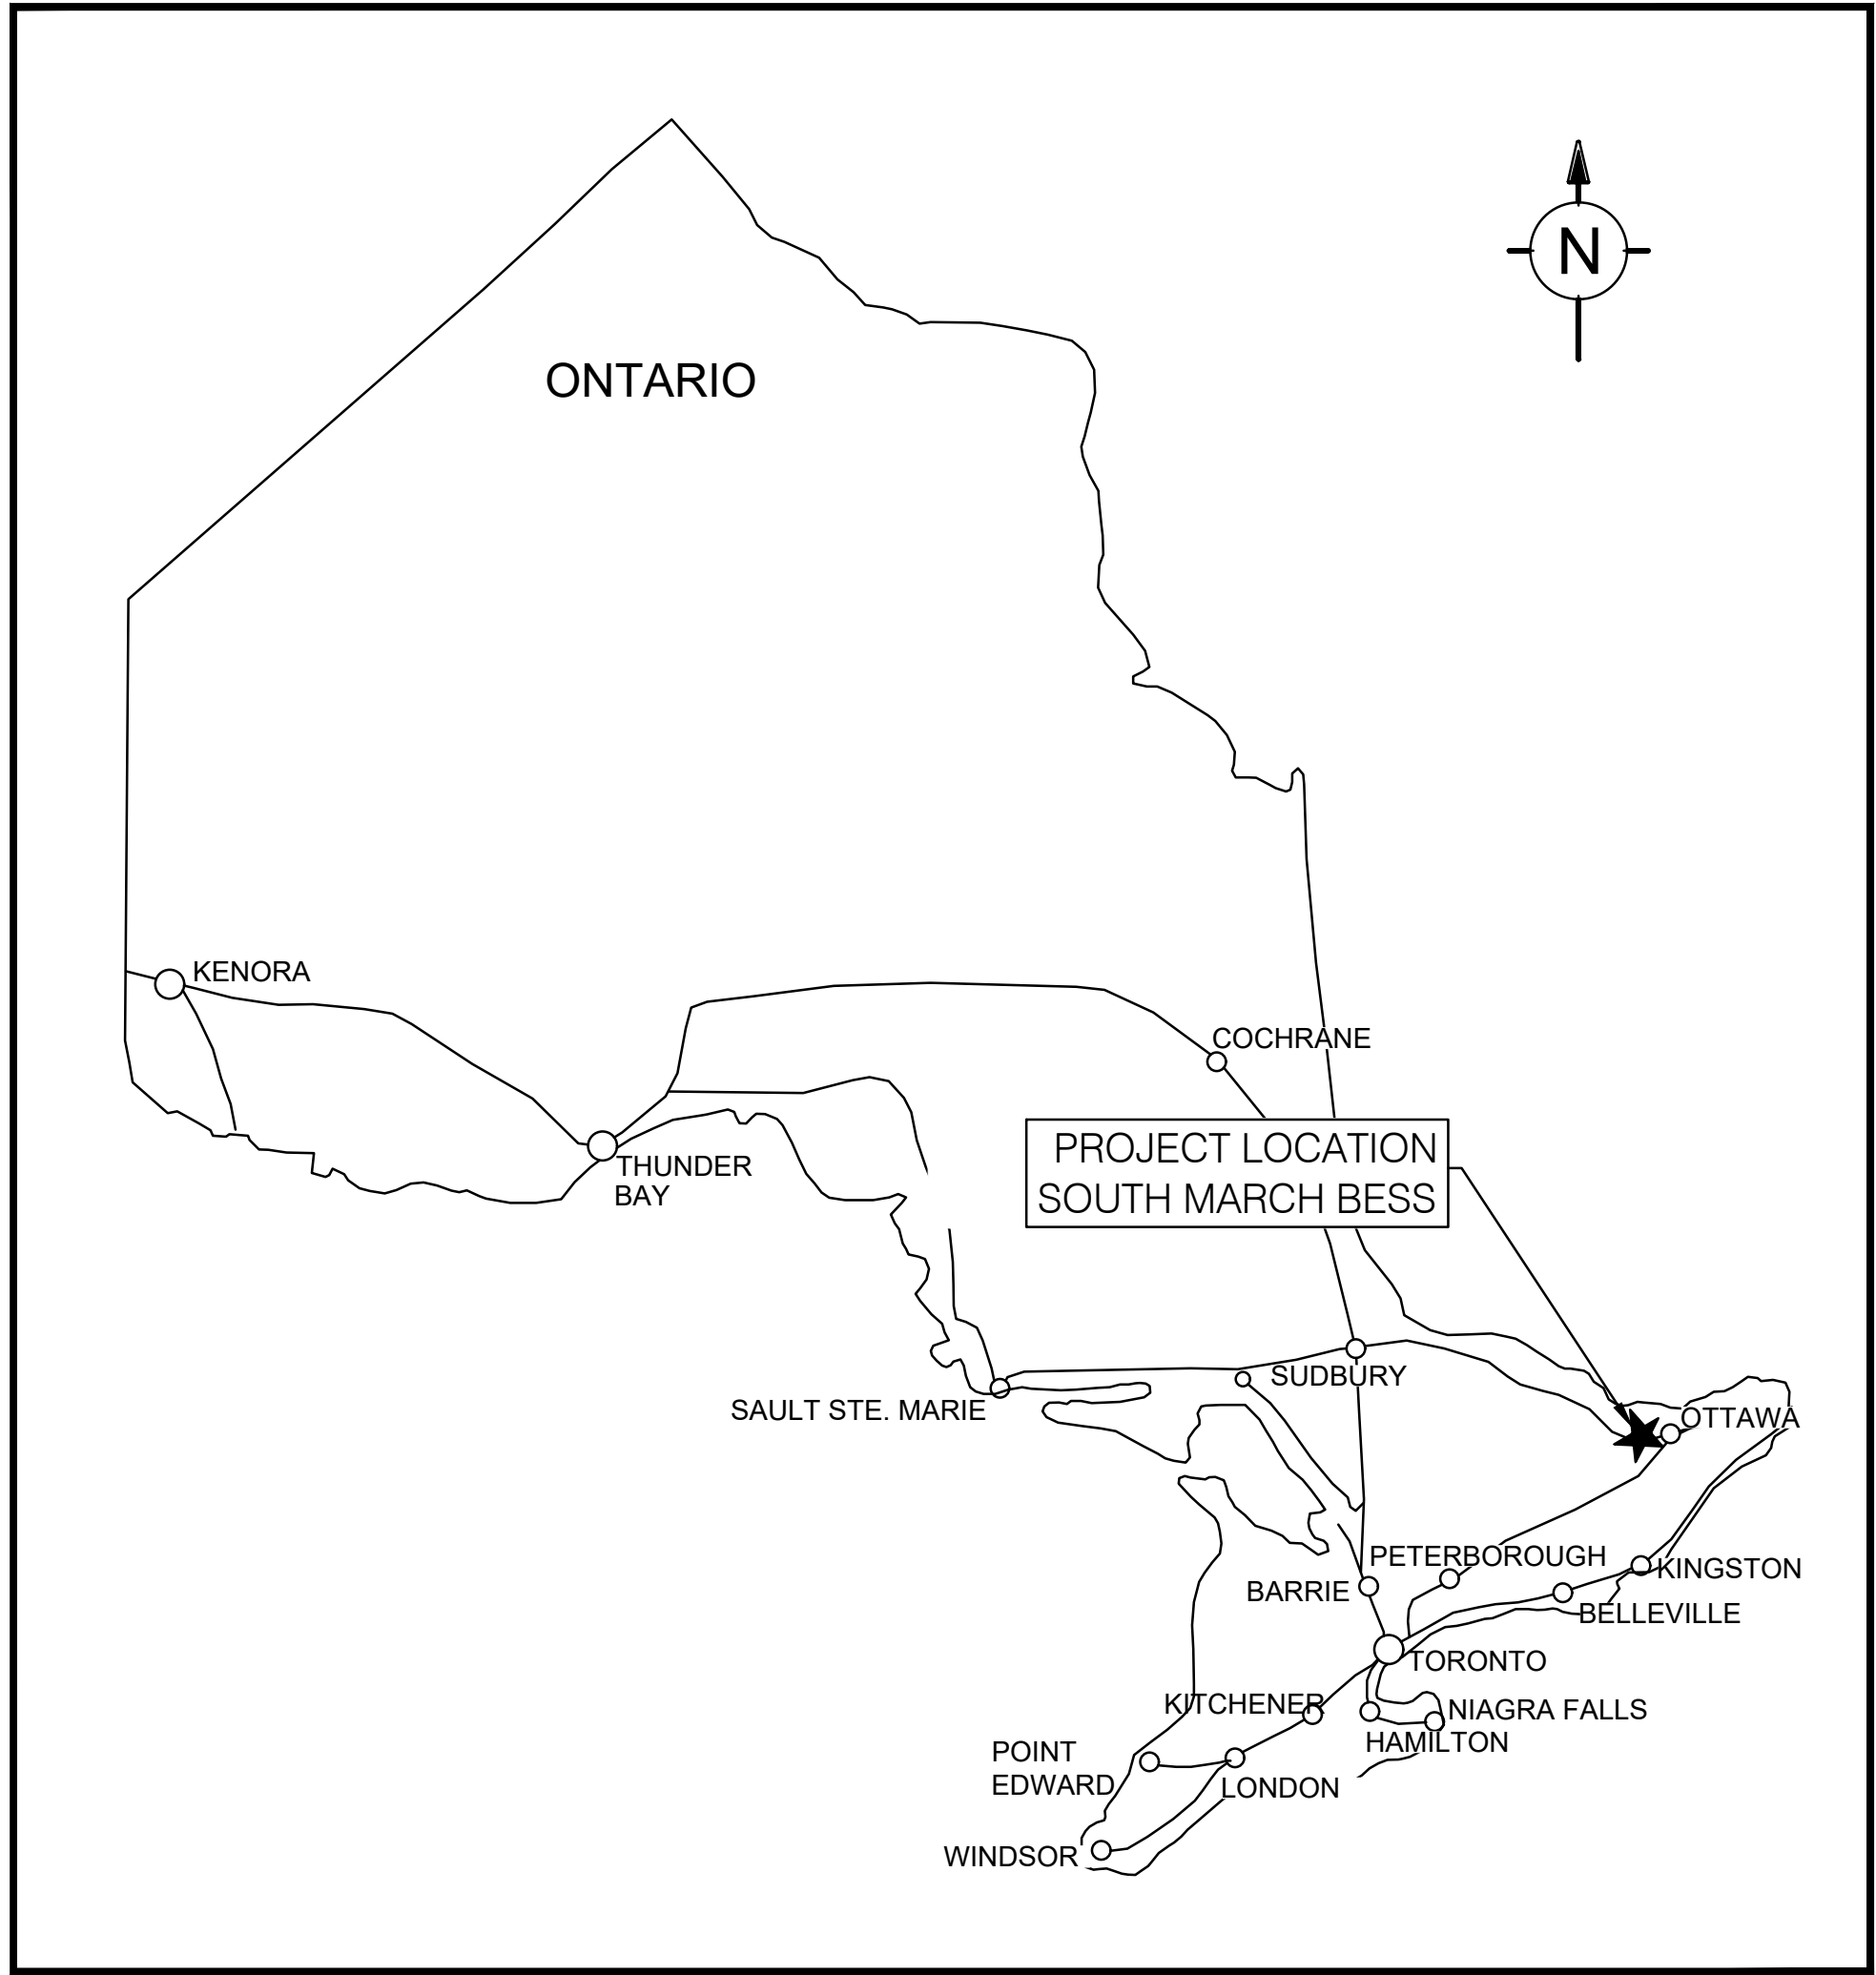

KEY PLAN
SCALE: NTS

DRAWING INDEX				
BBA DRAWING NO.	REV.	DATE	CATEGORY	SHEET DESCRIPTION
7154023-100000-41-D01-0001	AD	2025-07-03	GENERAL	CIVIL COVER PAGE & DRAWING INDEX
7154023-100000-41-D01-0002	AC	2025-06-19	GENERAL	GENERAL NOTES, LEGEND AND ABBREVIATIONS
7154023-100000-41-D20-0001-01	AC	2025-07-03	PLAN	SITE PLAN - SHEET 1
7154023-100000-41-D20-0001-02	AC	2025-07-03	PLAN	SITE PLAN - SHEET 2
7154023-100000-41-D20-0003	AD	2025-07-03	PLAN	SITE SERVICING AND FIRE PROTECTION PLAN
7154023-100000-41-D20-0004	AB	2025-06-19	PLAN & SECTIONS	WET POND
7154023-100000-41-D20-0005	AC	2025-07-03	PLAN	ROAD & FINISHED GRADE
7154023-100000-41-D20-0006	AB	2025-06-19	PROFILES	SITE GRADING
7154023-100000-41-D50-0001	AC	2025-06-19	DETAILS	STORMWATER AND WATER NETWORK
7154023-100000-41-D50-0002	AB	2025-06-19	DETAILS	ROAD AND DRAINAGE DETAILS
7154023-100000-41-D70-0001	AD	2025-07-03	PLAN	EROSION AND SEDIMENT CONTROL
7154023-100000-41-D70-0002	AC	2025-06-19	DETAILS	EROSION AND SEDIMENT CONTROL
7154023-100000-41-D90-0001	AB	2025-06-19	STANDARD DETAILS	SECURITY FENCING

FOR PERMITTING

		AD	FOR PERMITTING	E. AMELI	M. SHAHRAKI	2025-07-03
		AC	FOR PERMITTING	E. AMELI	M. SHAHRAKI	2025-06-19
		AB	FOR COMMENTS	E. AMELI	M. SHAHRAKI	2025-06-04
		AA	FOR COMMENTS	E. AMELI	M. SHAHRAKI	2025-03-03
DRAWING No.	DESCRIPTION	REV	DESCRIPTION	VERIFIED BY	APPROVED BY	DATE
REFERENCE DRAWINGS			REVISIONS			

SEAL:



Evolugen
by Brookfield Renewable

PROJECT: SOUTH MARCH BESS 2555 AND 2625 MARCHURST RD, OTTAWA	
TITLE: GENERAL CIVIL COVER PAGE & DRAWING INDEX	
DESIGNED BY: S. PARK	DRAFTED BY: S. PARK
VERIFIED BY: E. AMELI	APPROVED BY: M. SHAHRAKI
SCALE: N/A	DATE: 2025-03-07
DRAWING No.: 7154023-100000-41-D01-0001	SHEET: 01 SIZE: A1 REV: AD