



LEGEND

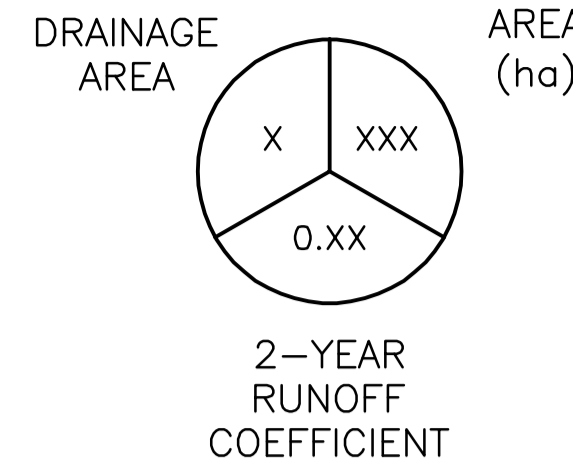

KEY PLAN

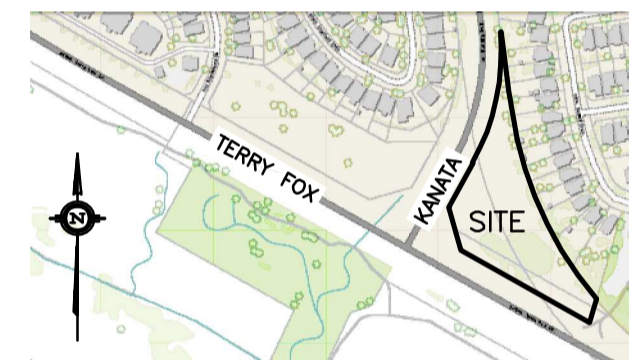


No.	DATE	REVISION
3	JAN 26-26	RE-ISSUED FOR APPROVAL
2	OCT 28-25	RE-ISSUED FOR APPROVAL
1	JUL 11-25	ISSUED FOR APPROVAL

D. B. GRAY ENGINEERING INC.
 Stormwater Management - Grading & Drainage - Storm & Sanitary Sewers - Watermain
 700 Long Point Circle 613-425-8044
 Ottawa, Ontario d.gray@dbgrayengineering.com

Project
PROPOSED 6-STORY APARTMENT BUILDINGS
475 TERRY FOX DRIVE
 OTTAWA, ONTARIO

POST-DEVELOPMENT DRAINAGE PLAN

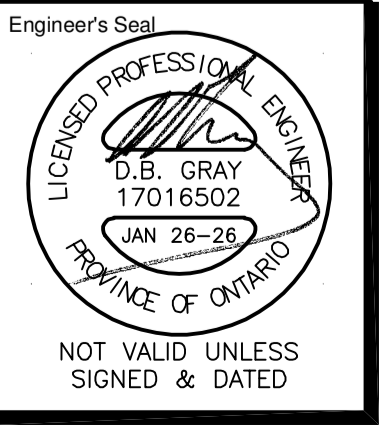

Engineer's Seal
 Drawn D.B.G.
 H. Scale 1:400
 V. Scale
 Date JUL 11-25
 Job No. 24103
 Drawing No.
C-15
 of 19