


18 19 20 100

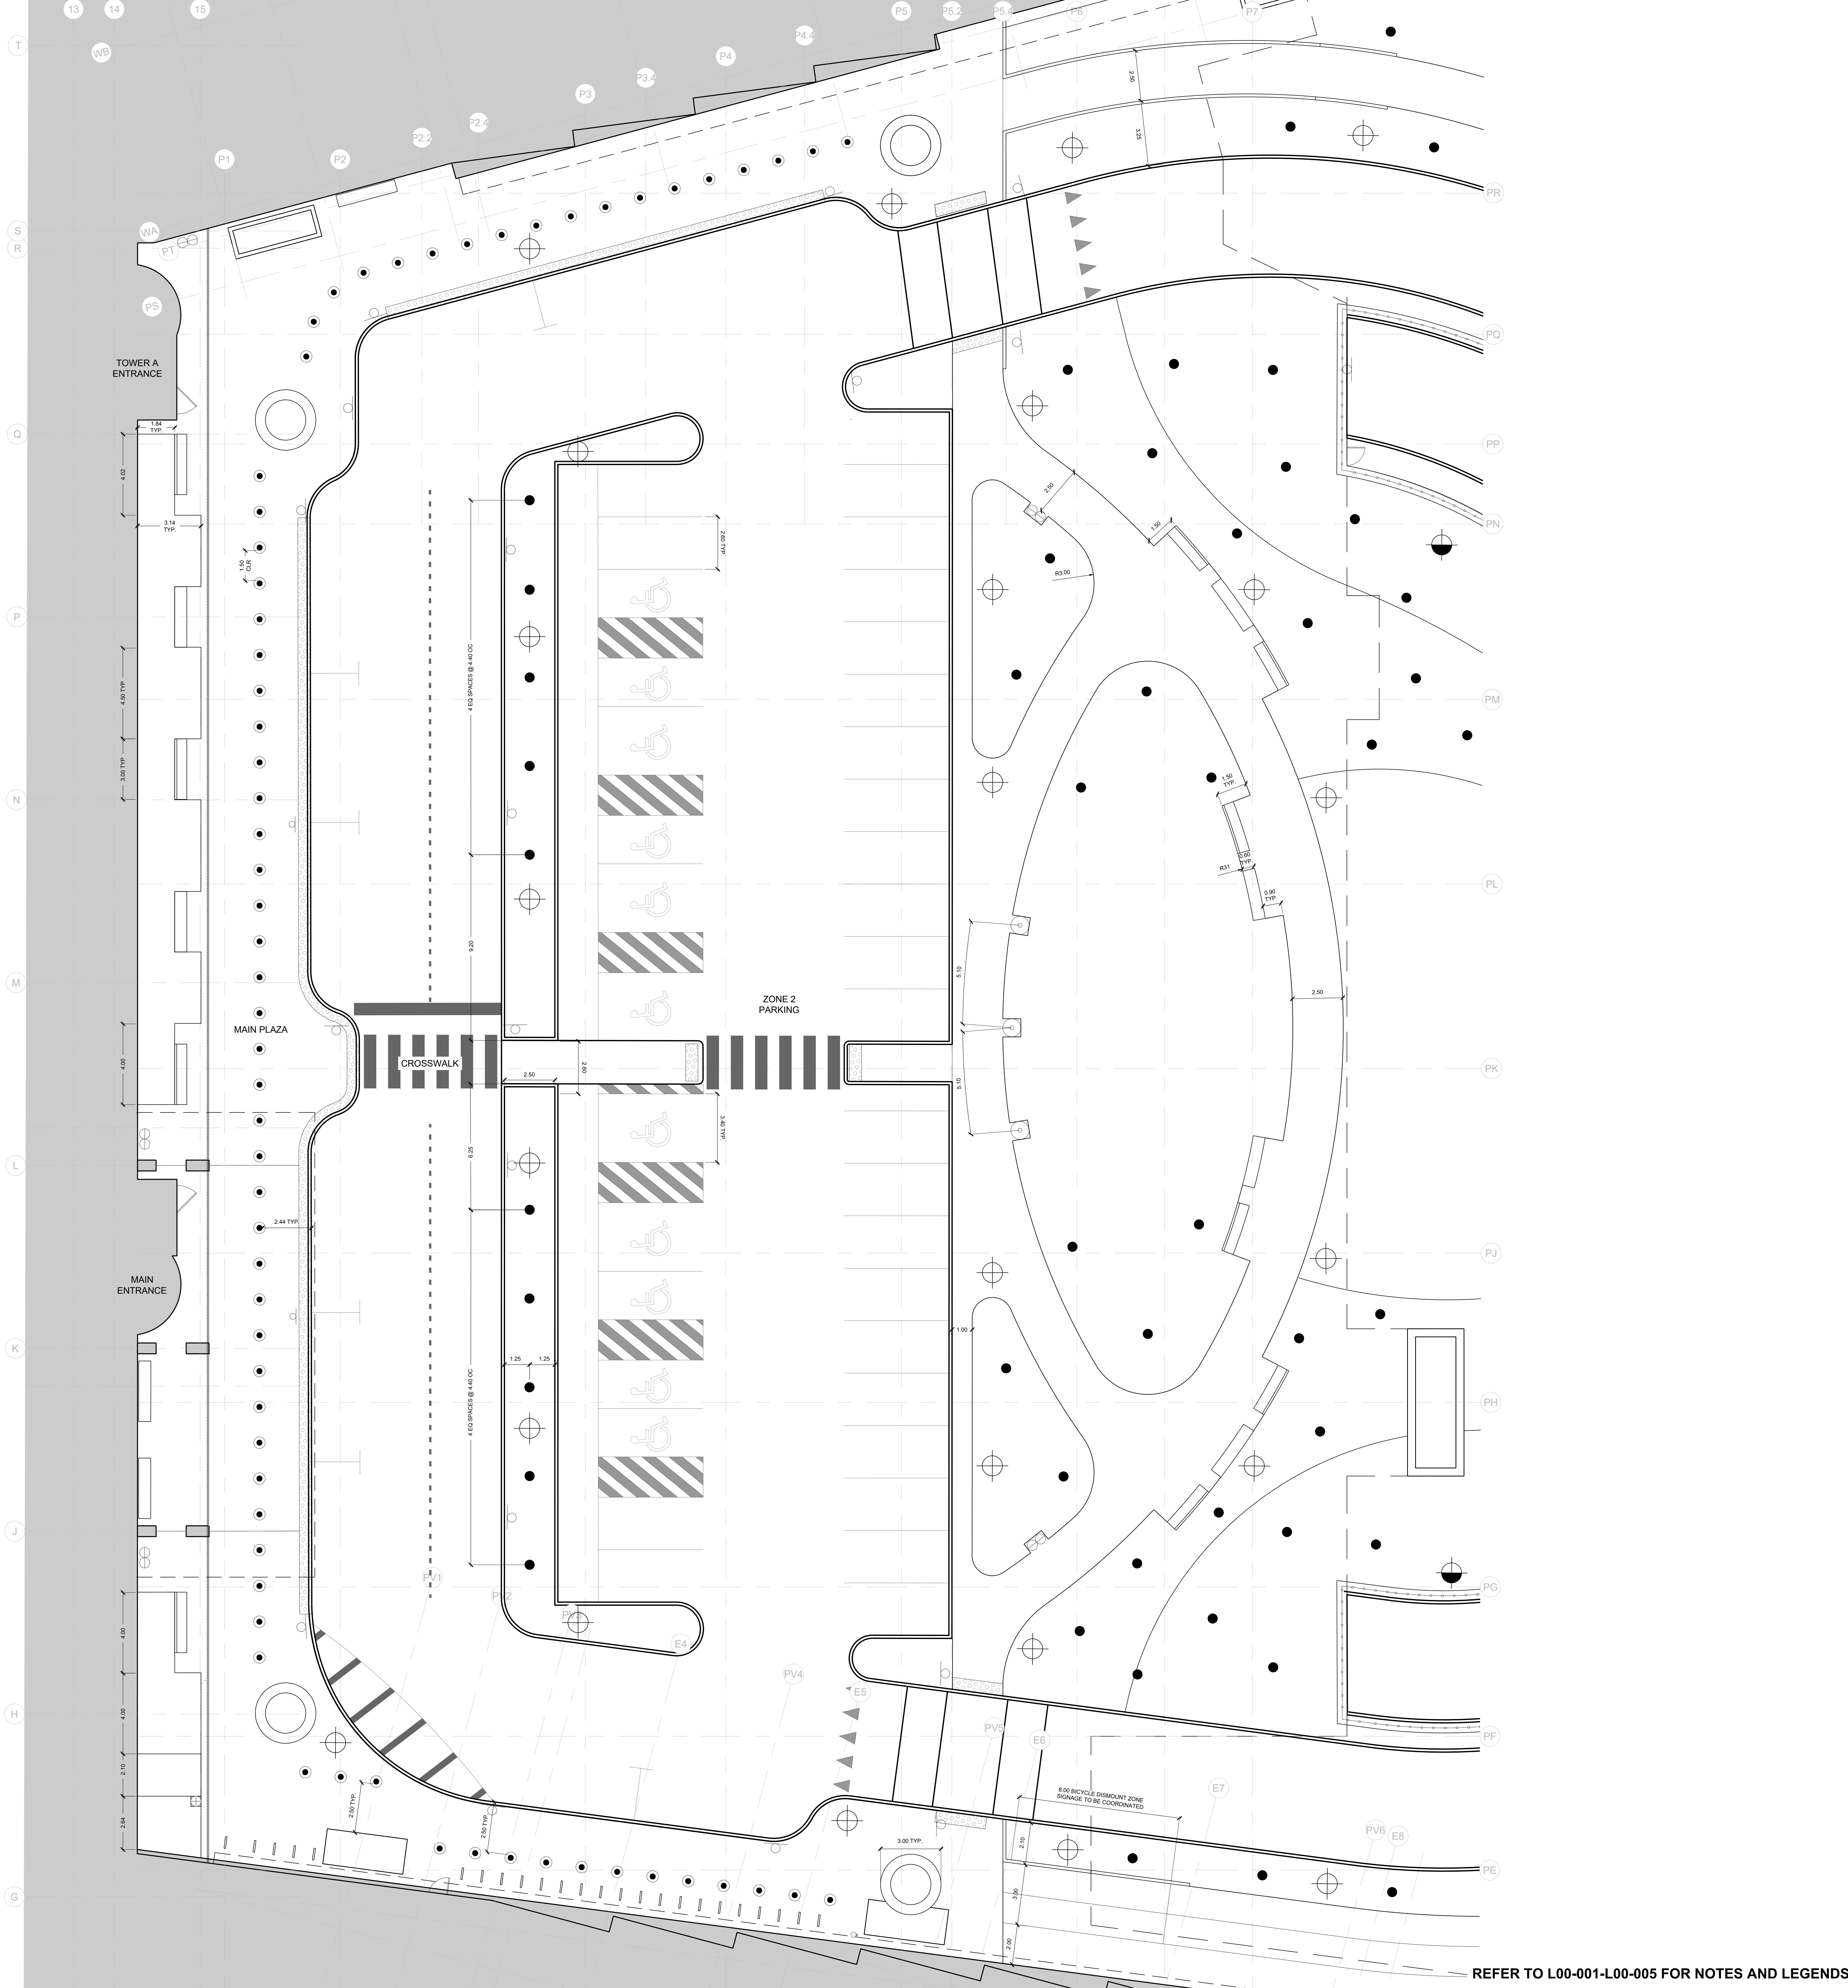

PROJECT
 THE OTTAWA HOSPITAL
 NEW CAMPUS
 DEVELOPMENT -
 PHASE 4 MAIN HOSPITAL
 BUILDING
 900 CARLING AVE. OTTAWA ONTARIO

CLIENT
 The Ottawa Hospital | L'Hôpital d'Ottawa

Infrastructure Ontario

PCL CONSTRUCTION | **EllisDon**

CLIENT PROJECT NO.
 1070002

KEY PLAN
 TRUE NORTH PROJECT NORTH

THIS DRAWING TO BE PRINTED IN COLOUR

04	SITE PLAN CONTROL, RESUBMISSION	2025-01-12
03	85% DD SUBMISSION	2025-09-19
02	SITE PLAN CONTROL, RESUBMISSION	2025-06-05
01	65% DD SUBMISSION	2025-06-05
00	ISSUED	DATE

REVISIONS

DRAWING STATUS
NOT FOR CONSTRUCTION
 DISCREPANCIES MUST BE REPORTED IMMEDIATELY TO THE ARCHITECT BEFORE PROCEEDING. ONLY FIGURED DIMENSIONS ARE TO BE USED. CONTRACTORS MUST CHECK ALL DIMENSIONS ON SITE. THIS DRAWING IS PROTECTED BY COPYRIGHT.
 ALL DIMENSIONS ARE SHOWN IN METRIC.

AUTHOR

PROJECT TEAM
DESIGN/BUILDER PCL/EA JOINT VENTURE
ARCHITECTURAL PARSON ARCHITECTS LIMITED, ZOOHL LAMARIE PRATTE ARCHITECTS, ADAMSON ASSOCIATE ARCHITECTS, 888 ARCHITECTS INC.
STRUCTURAL STEPHENSON ENGINEERING LTD, BOUTHILLET PARIZAU INC.
MECHANICAL HI ANGLUS & ASSOCIATES LTD, CROSSEY ENGINEERING LTD.
ELECTRICAL MELVEY & BIRN INTERNATIONAL INC.
CIVIL HEP CANADA INC.
LANDSCAPE VERTECOUS DESIGN INC, PWP LANDSCAPE ARCHITECTURE
BUILDING CODE UMOG BUILDING CODE CONSULTANTS LTD.
AUTHOR PROJECT NO.
 PCL2301_C

STAMP STAMP

DRAWING TITLE
 LAYOUT PLAN
 ENLARGEMENT
 MAIN ENTRANCE

DRAWN CHECKED
 SCALE AT 40" x 60" DATE 05-JUN-2025
 GRAPHIC SCALE 1:100 SCALE IN METERS

DRAWING NO. L03-106 **REV NO.** 04

REFER TO L00-001-L00-005 FOR NOTES AND LEGENDS