
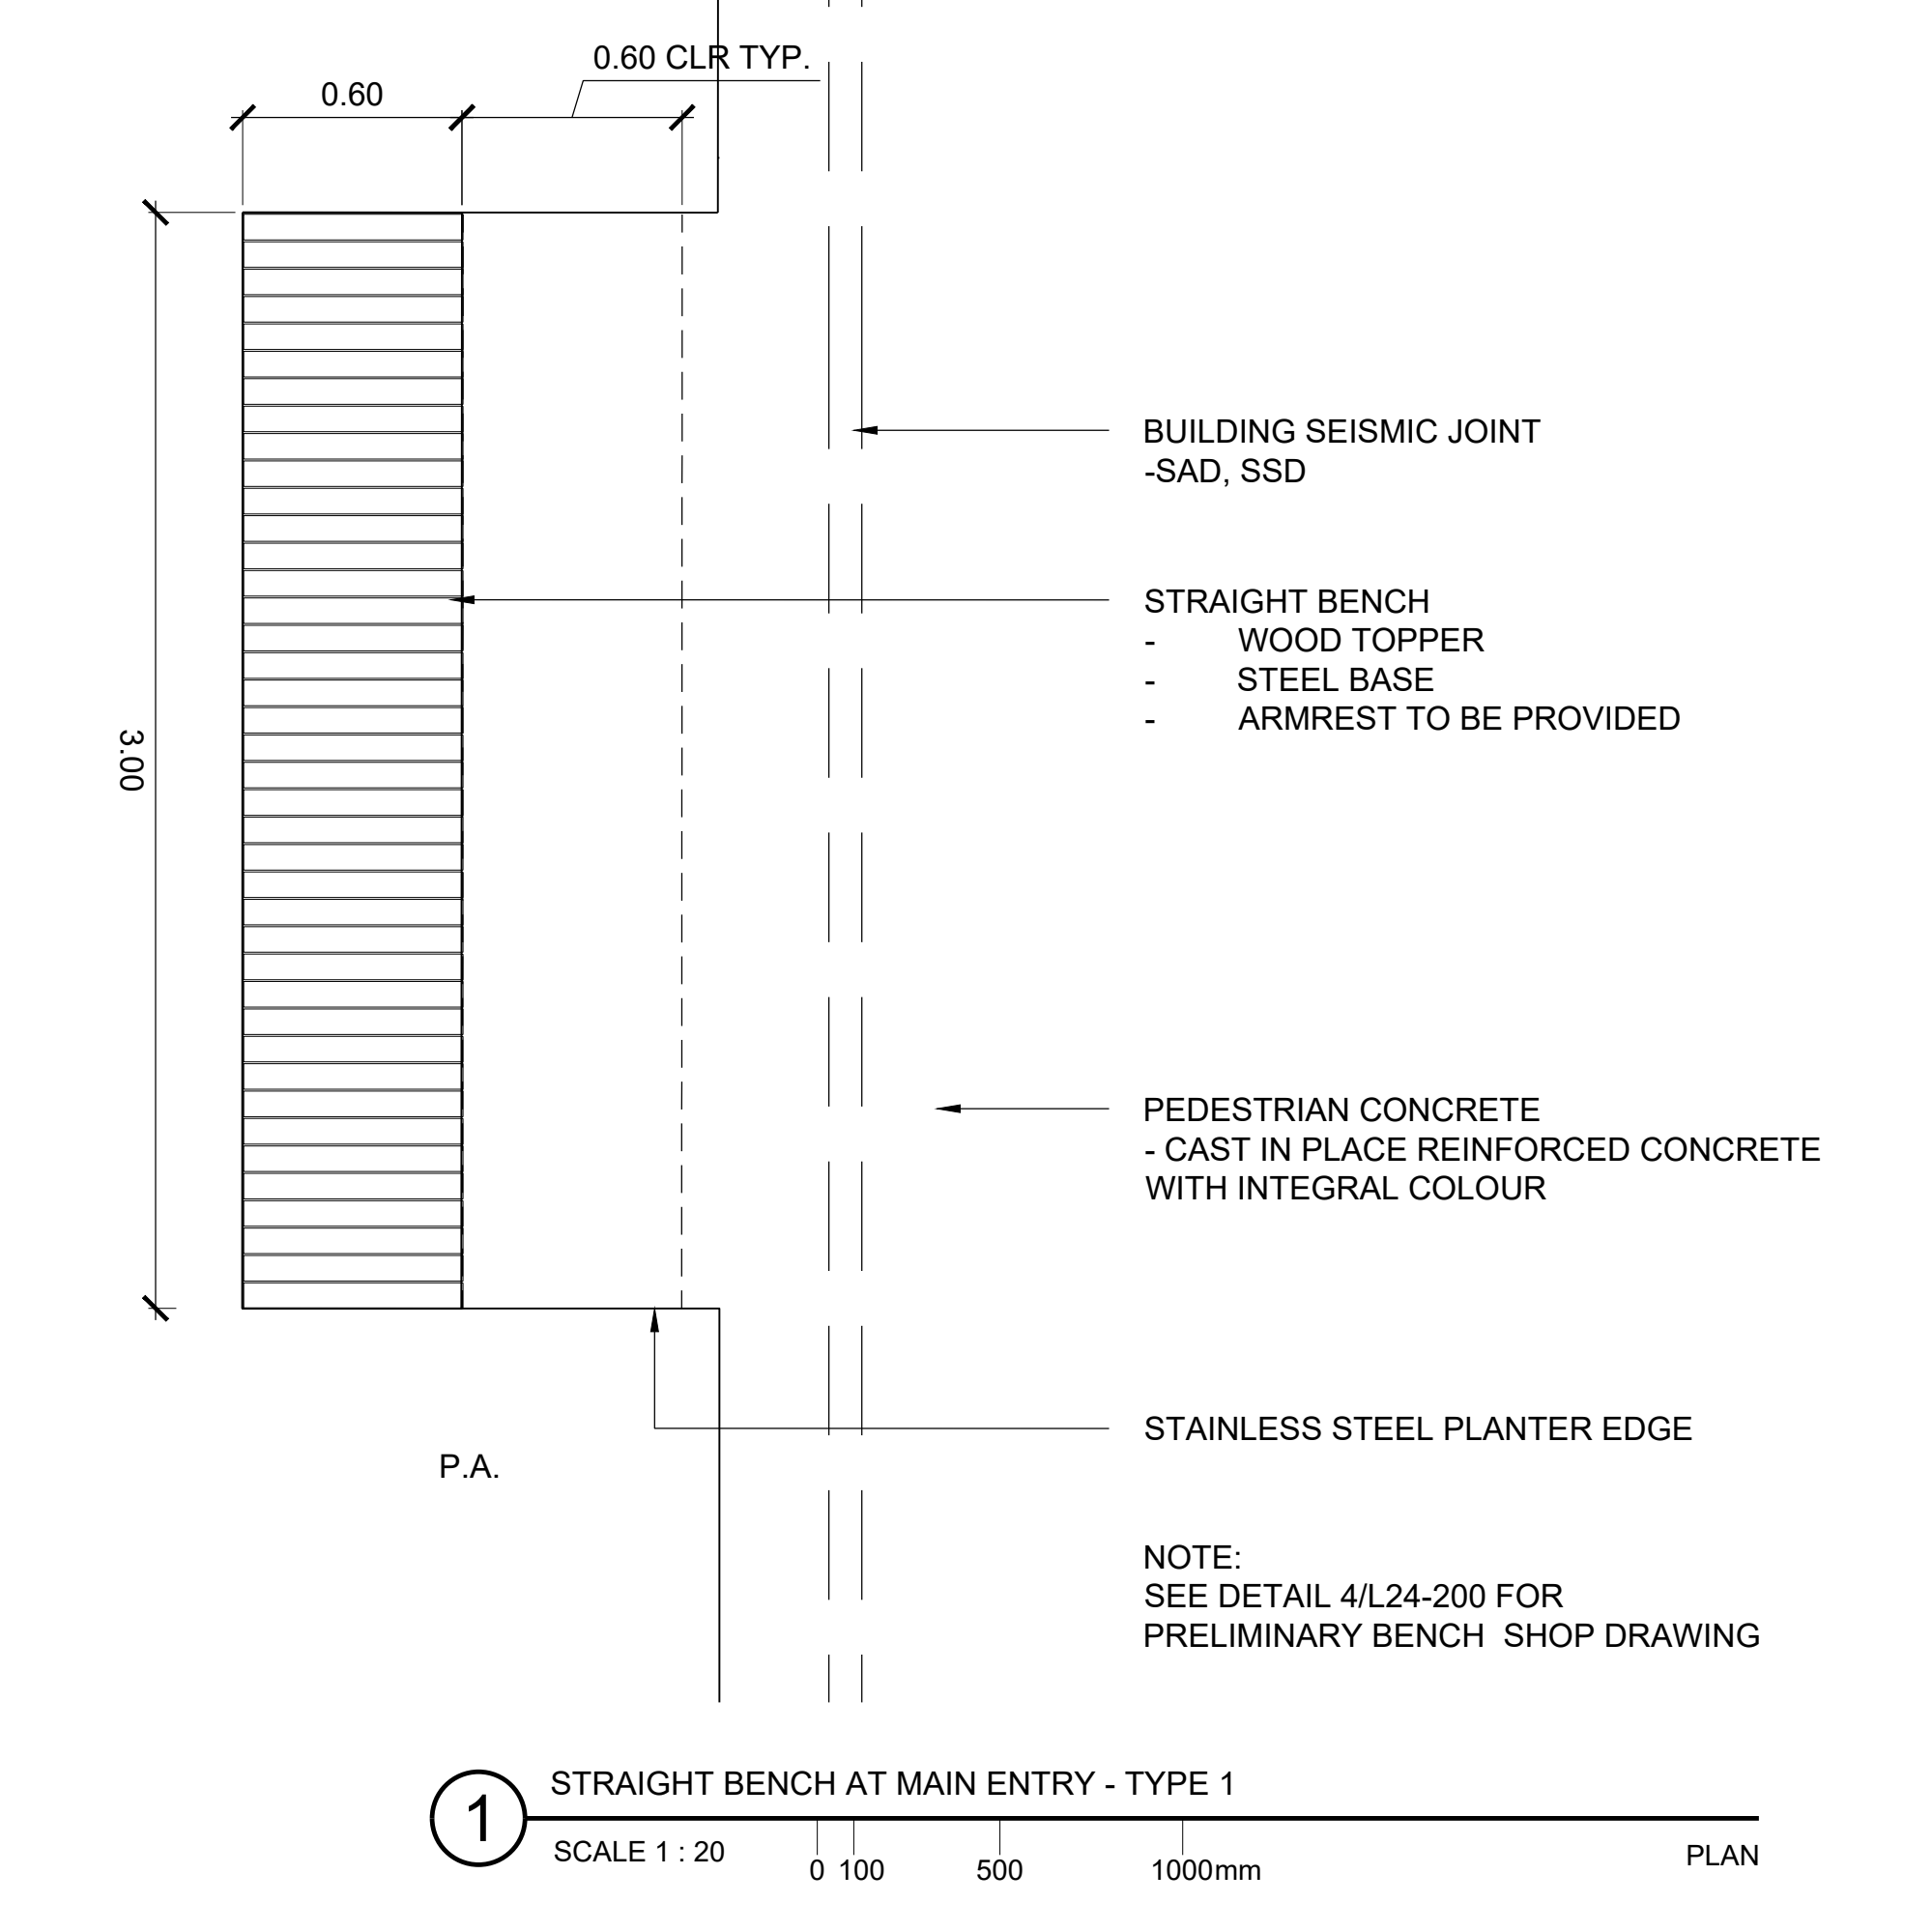
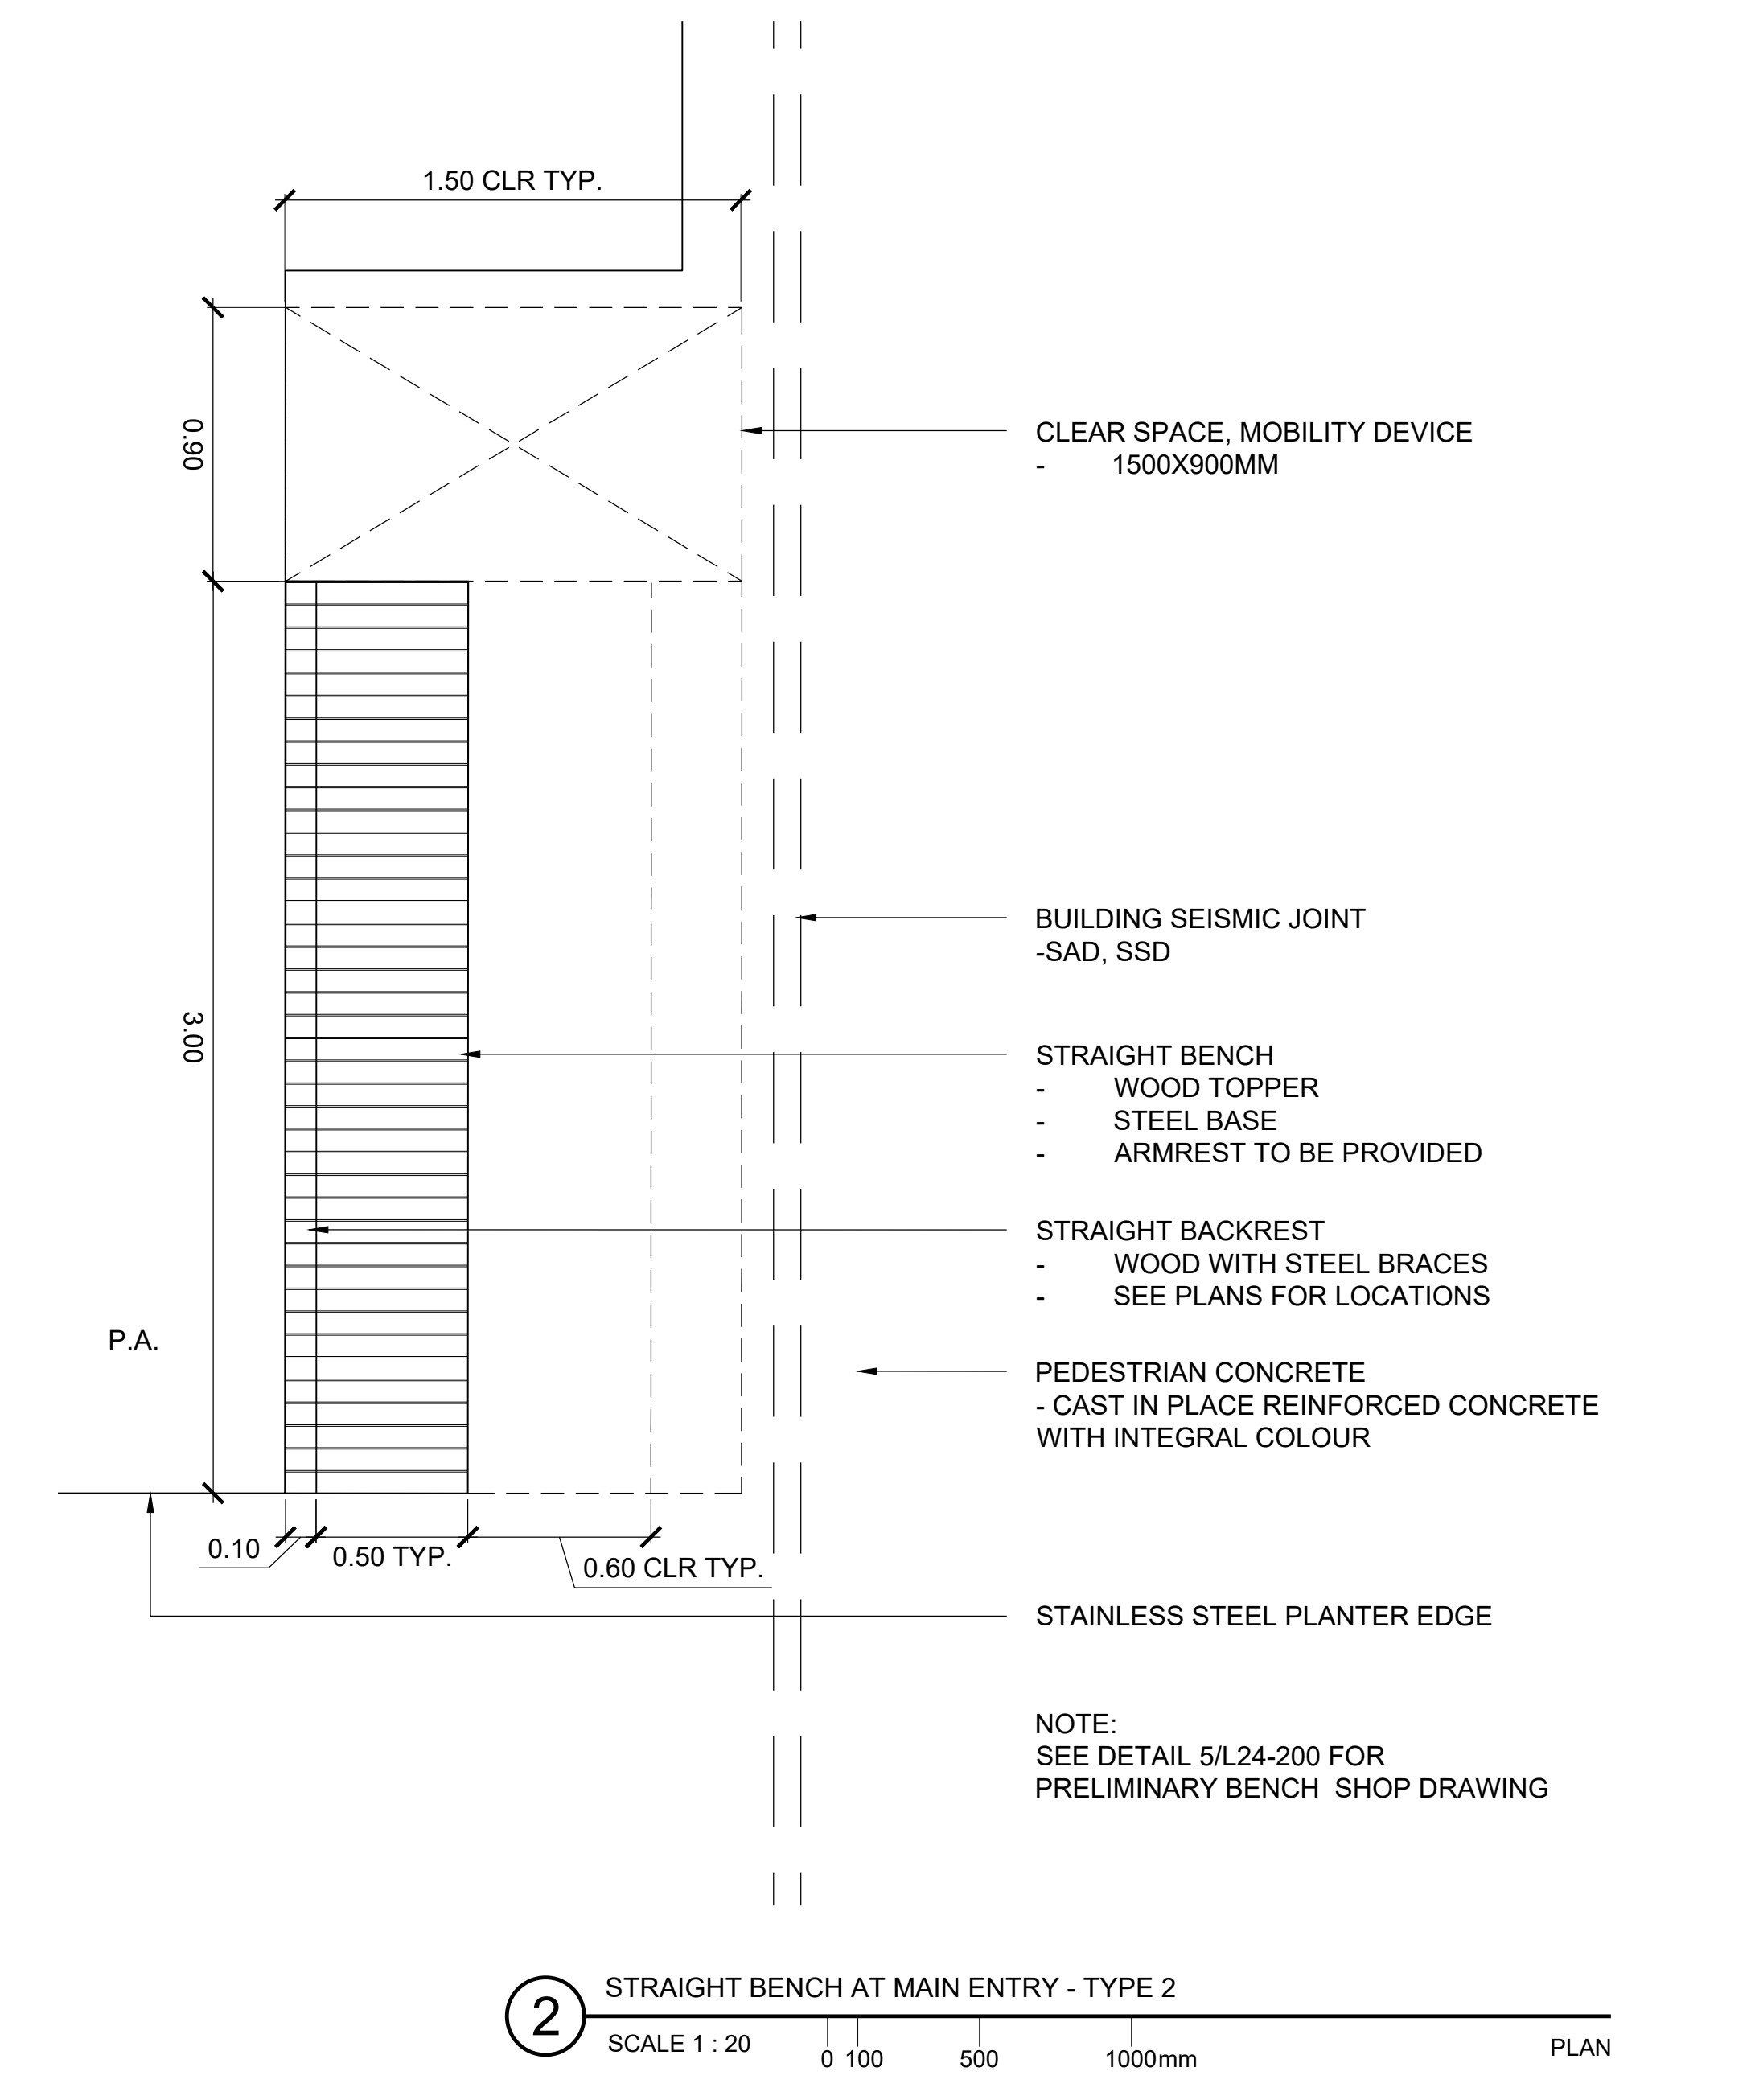
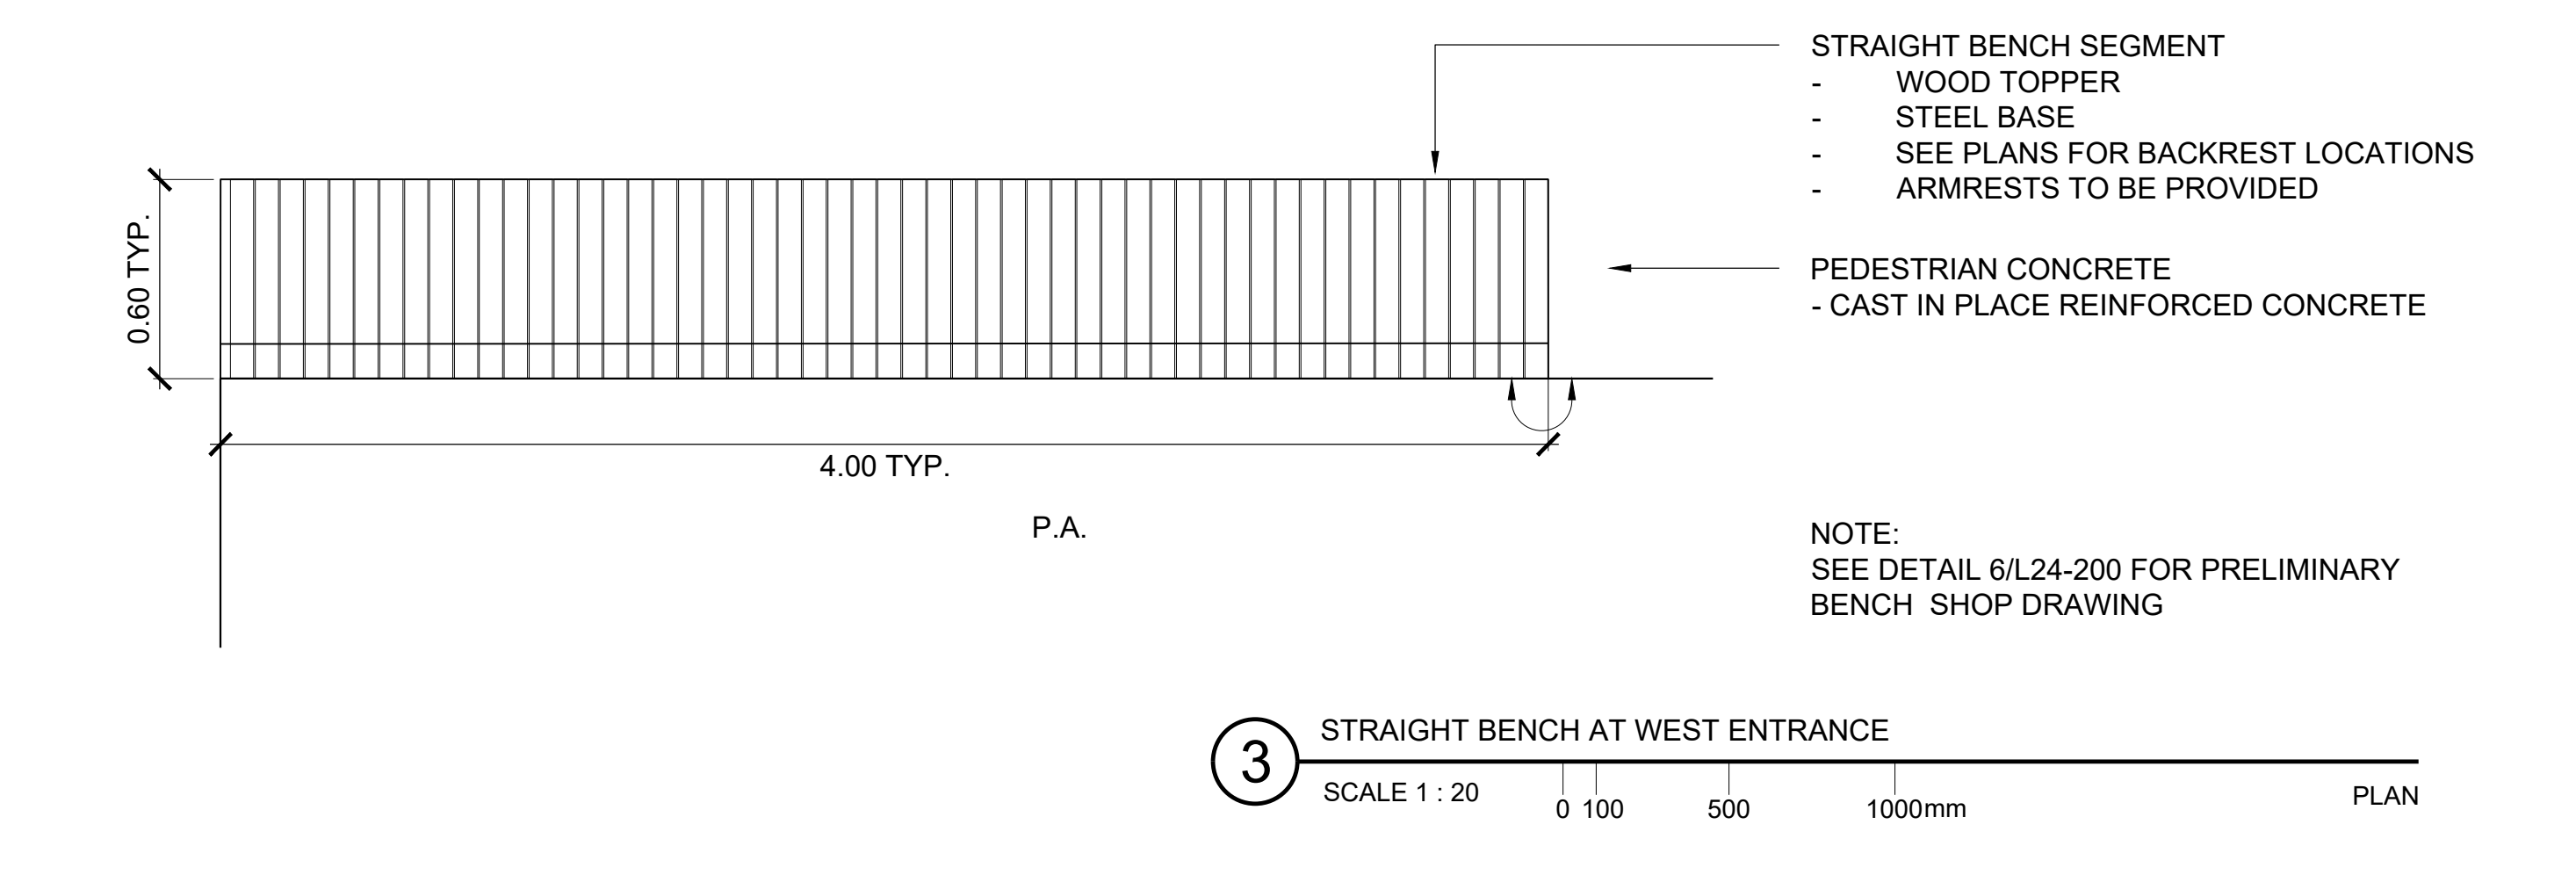
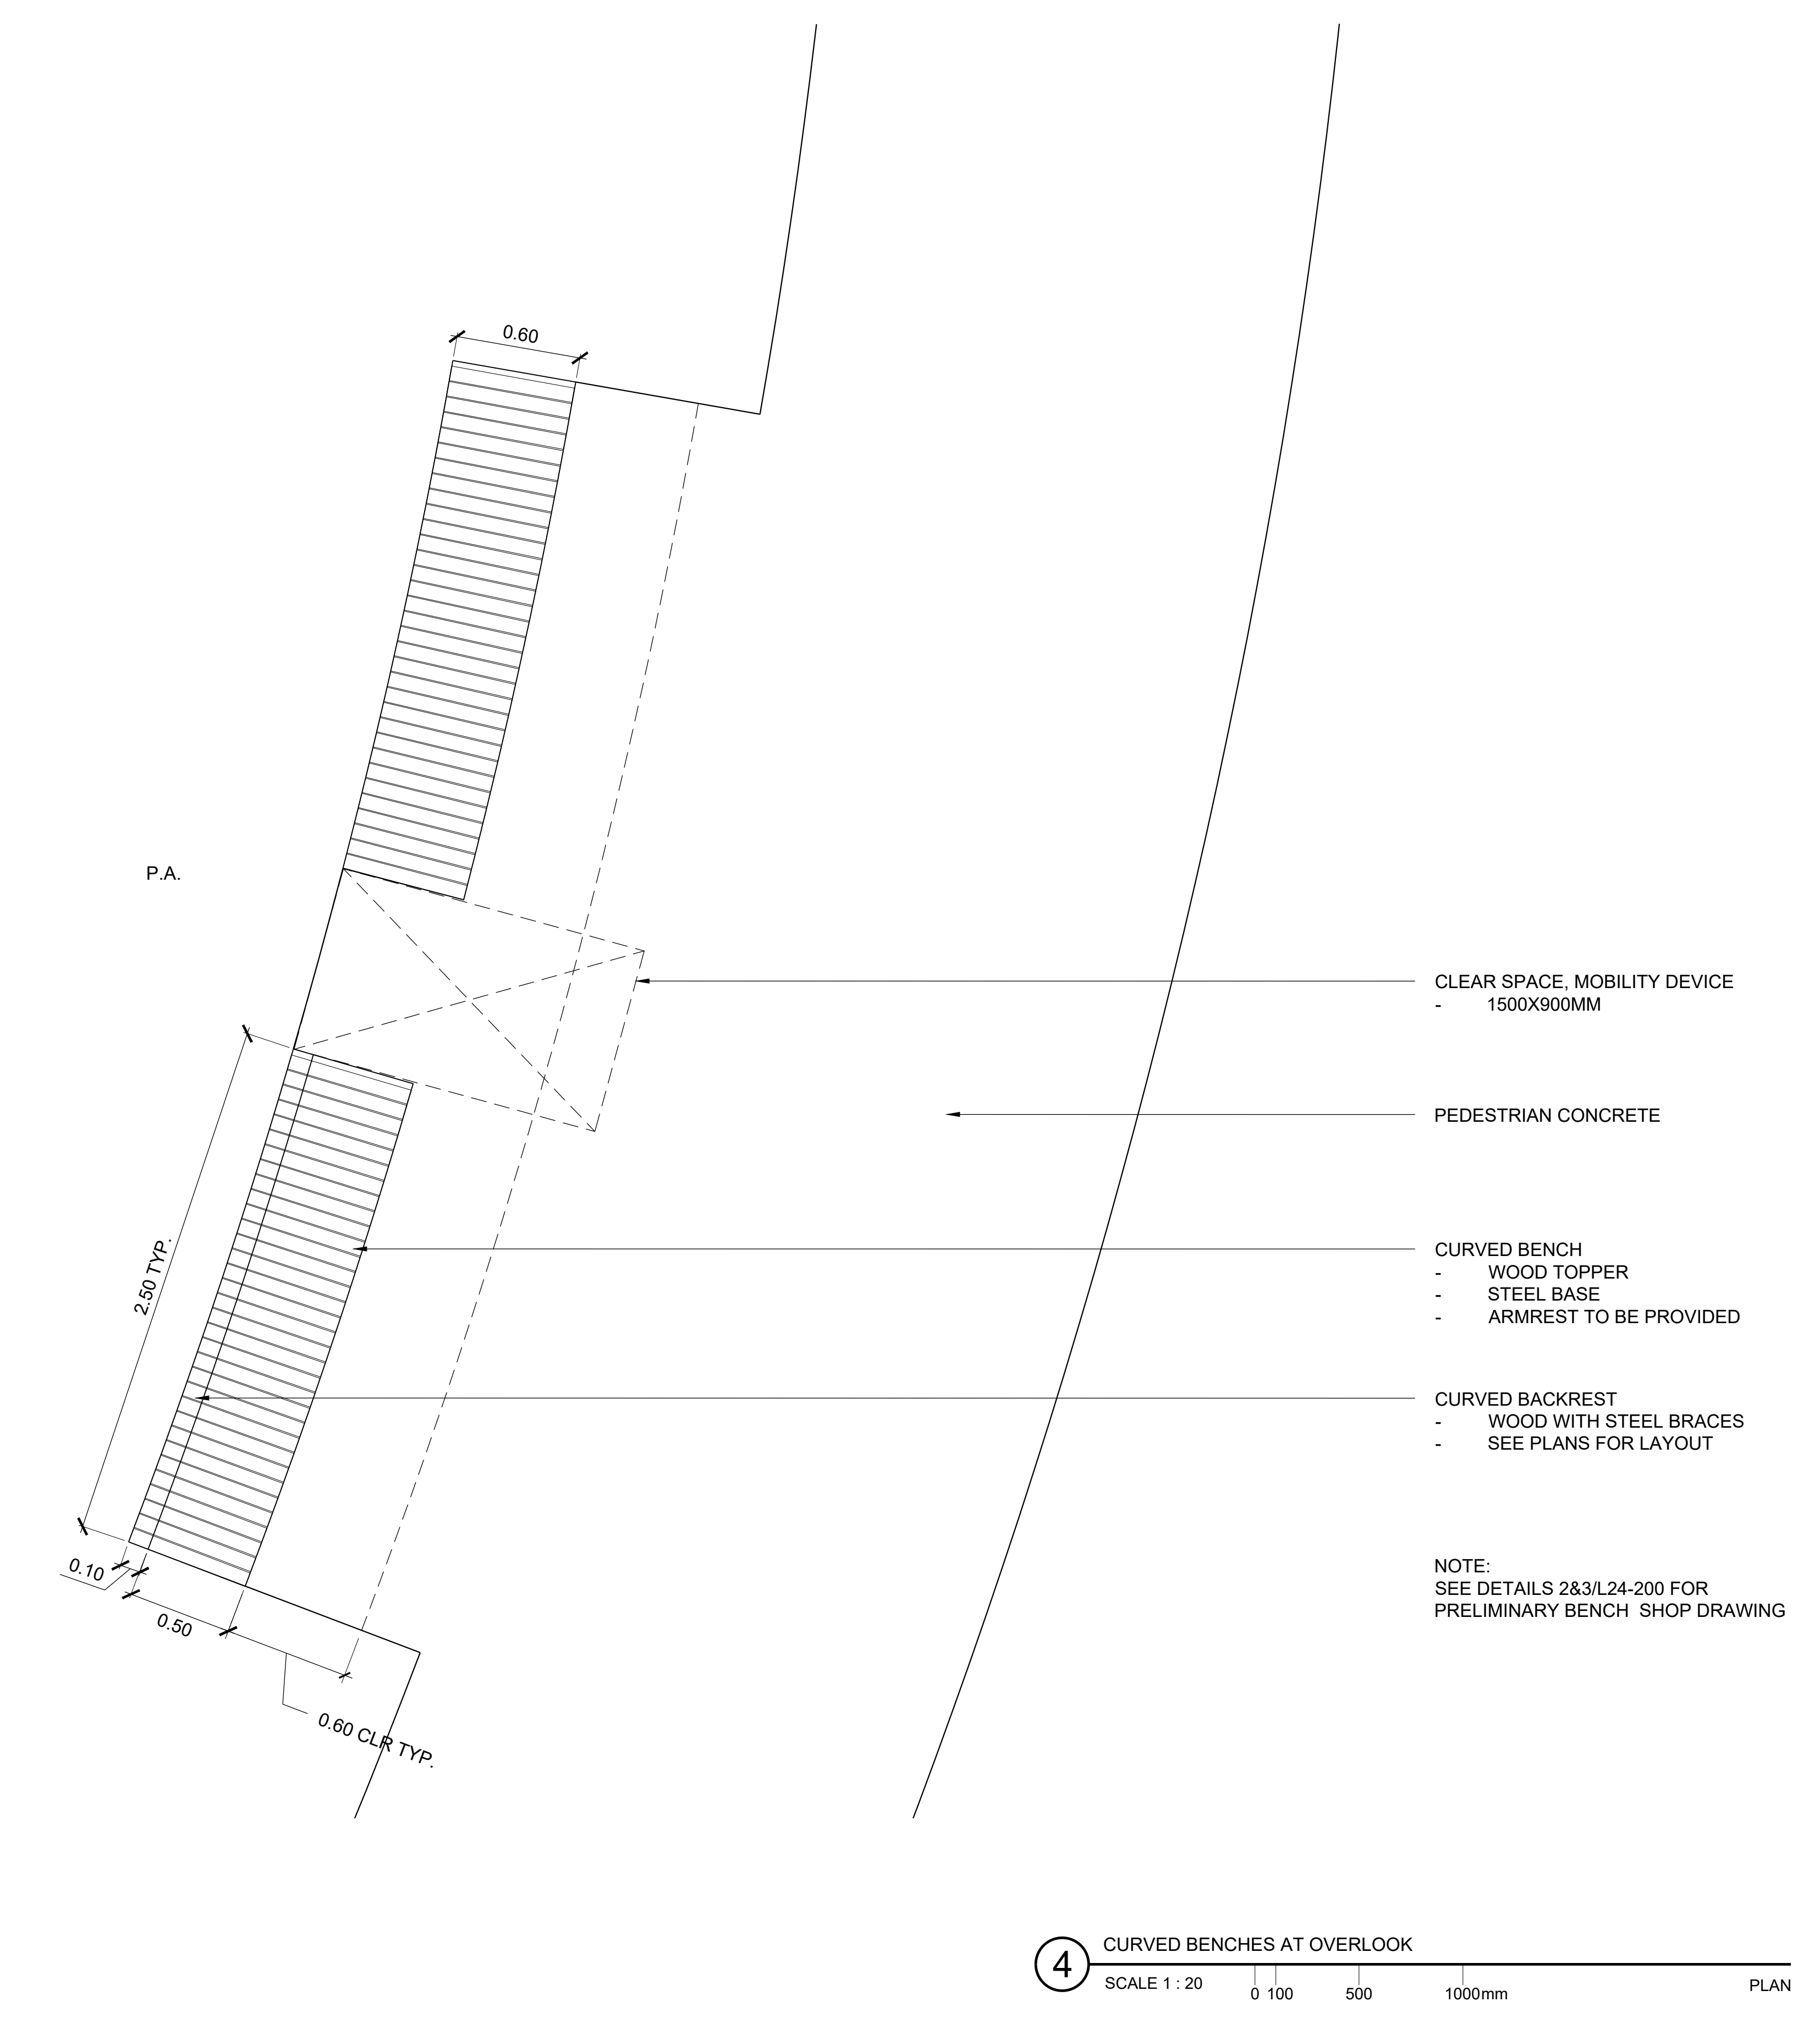
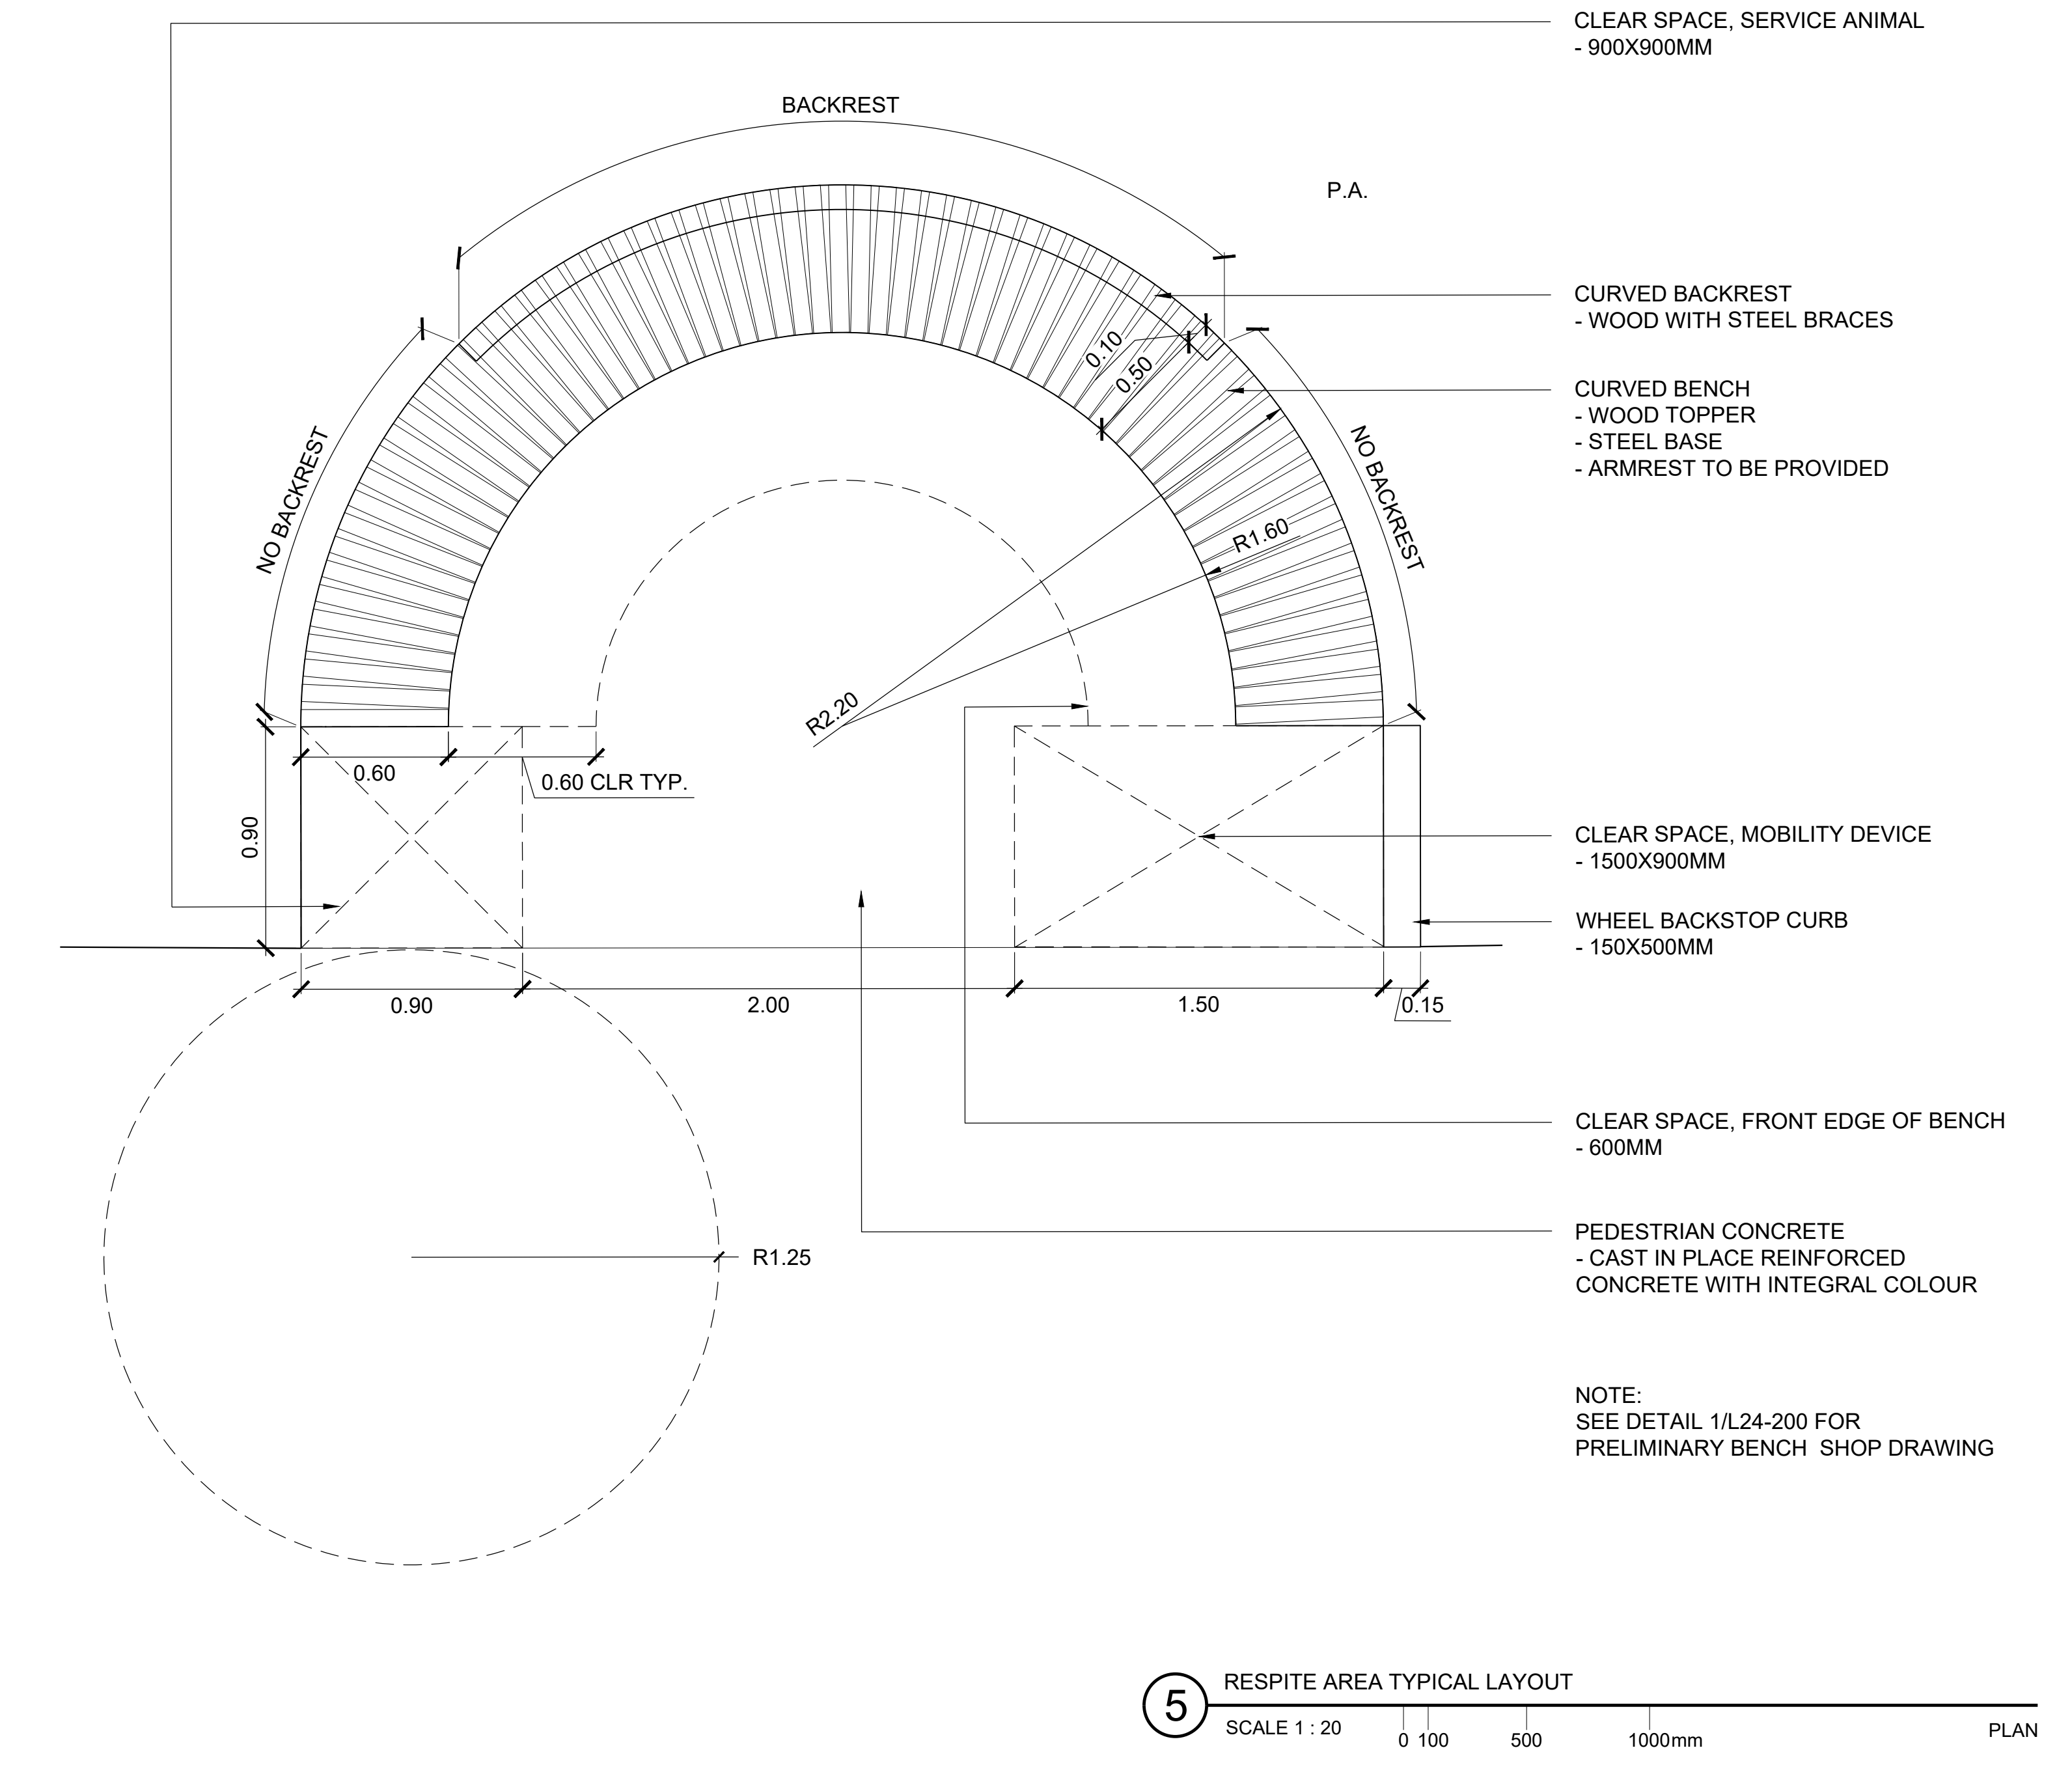
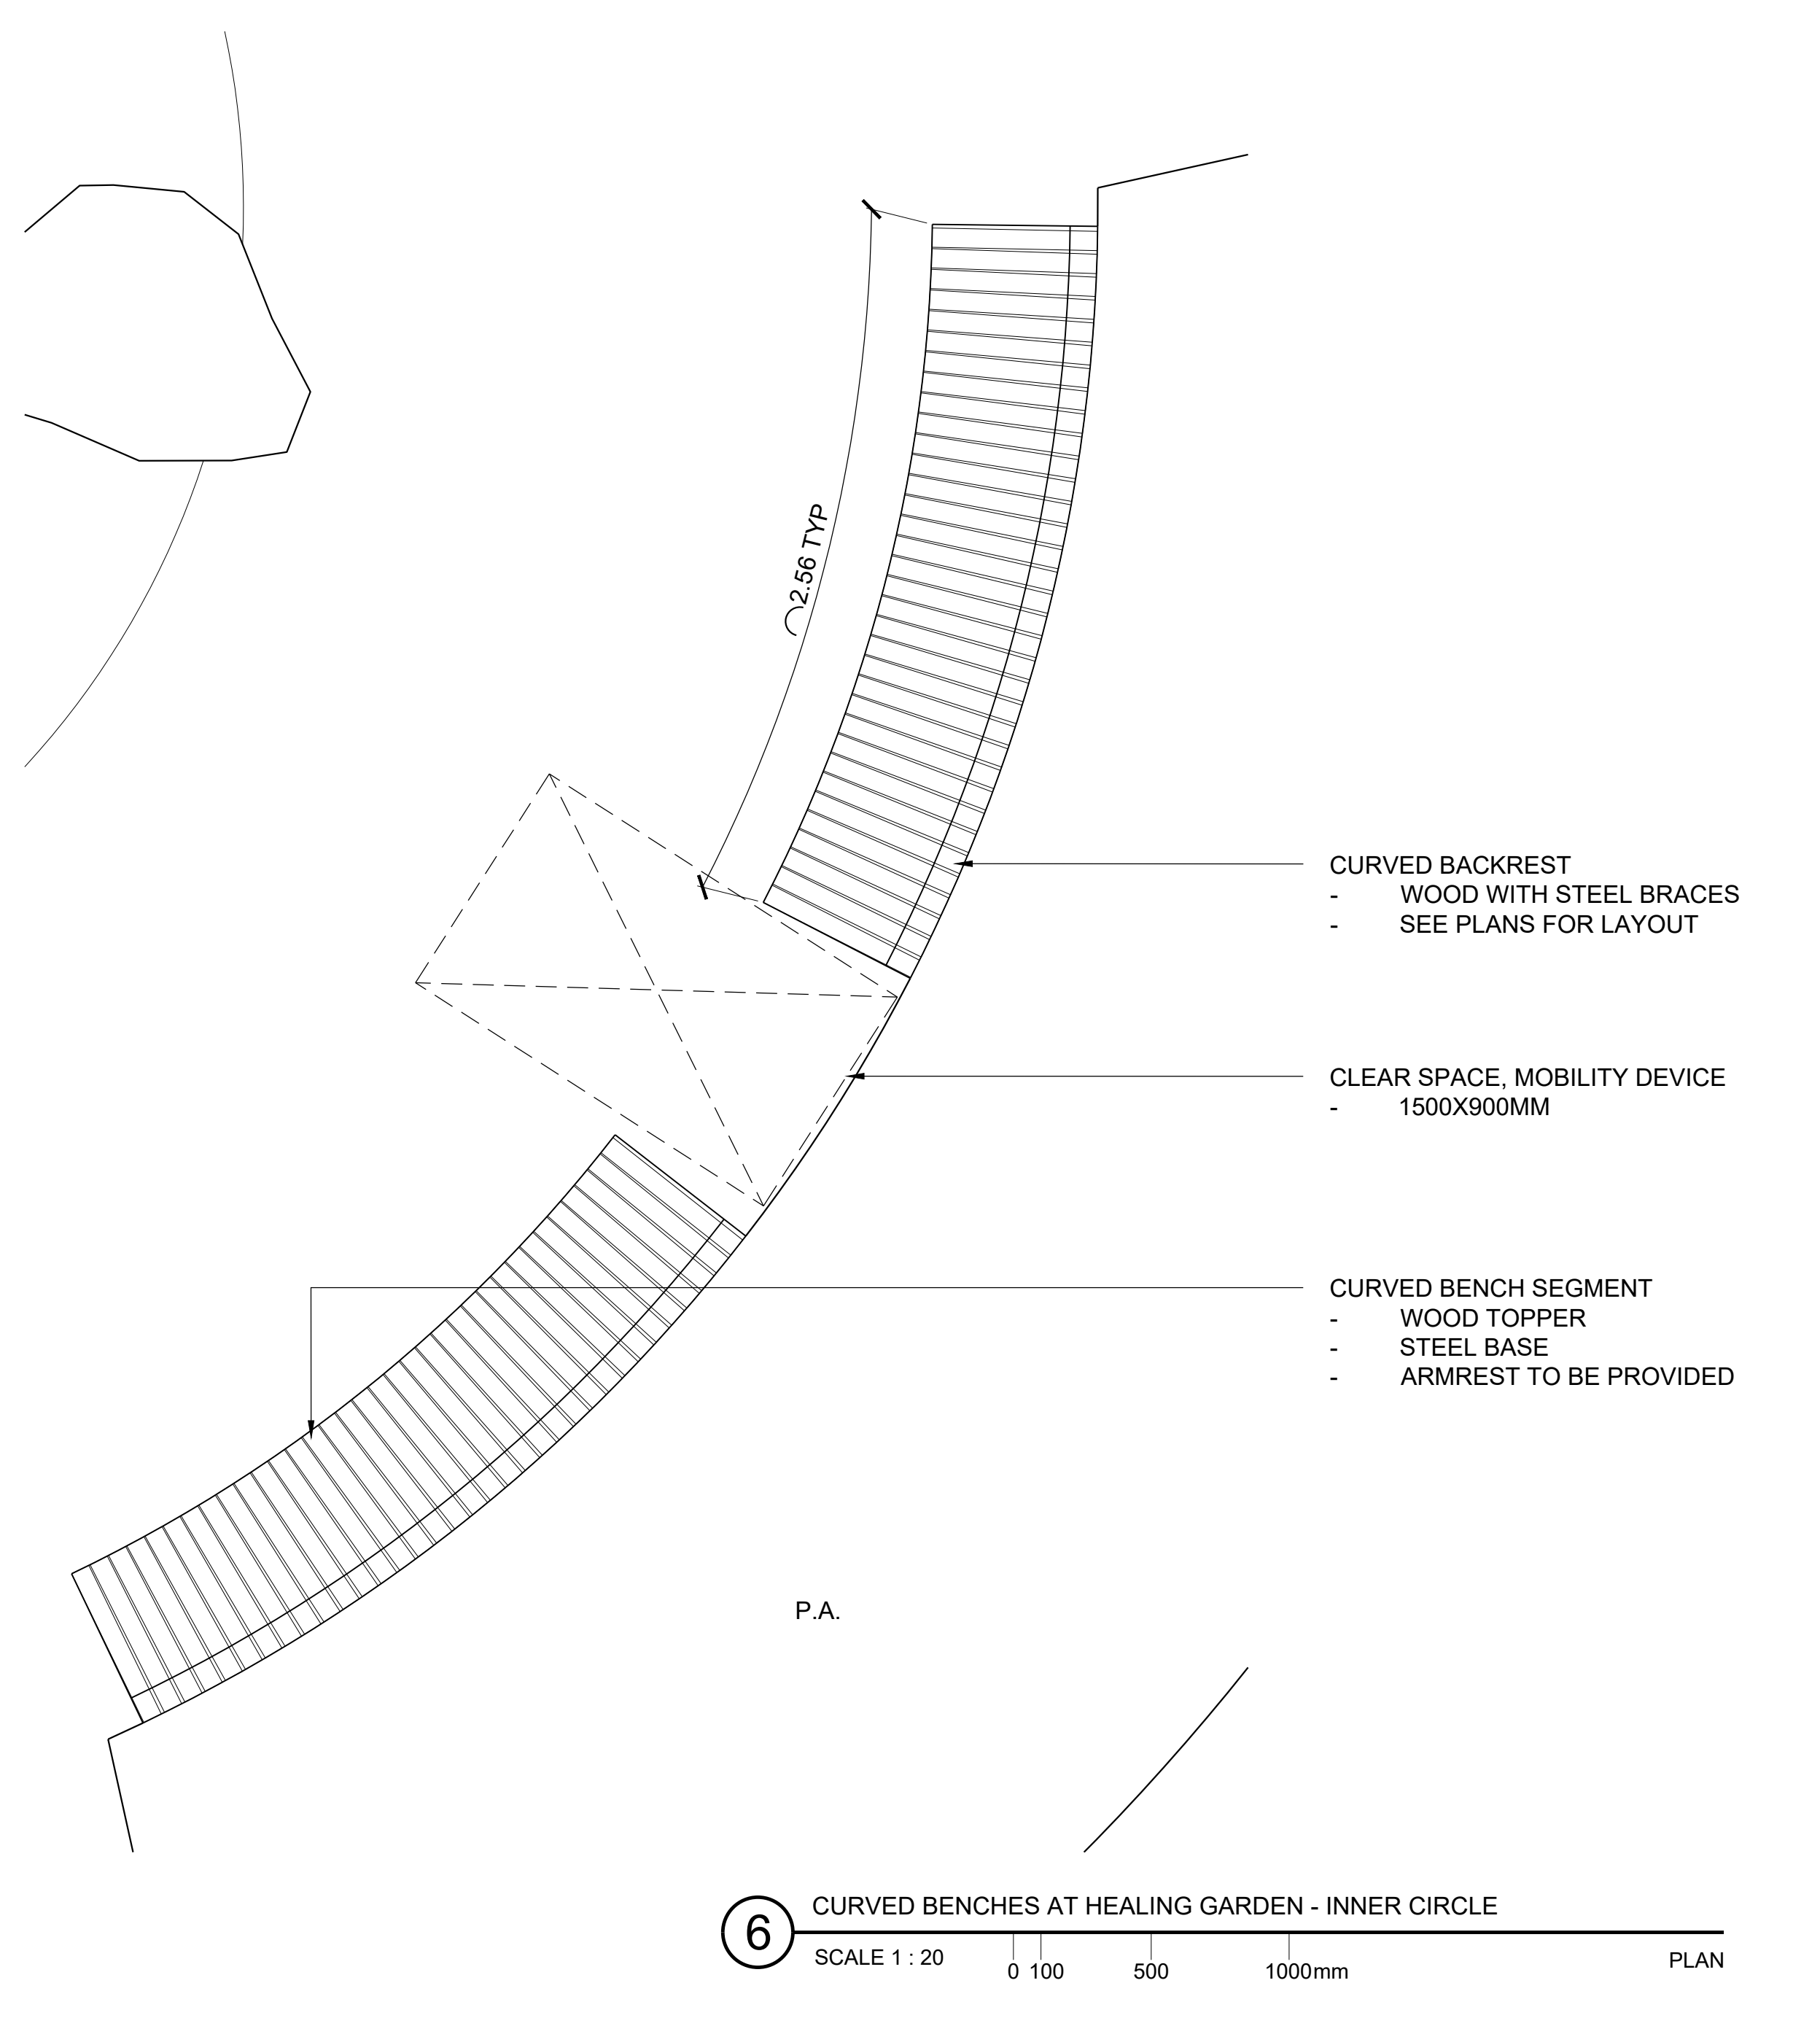
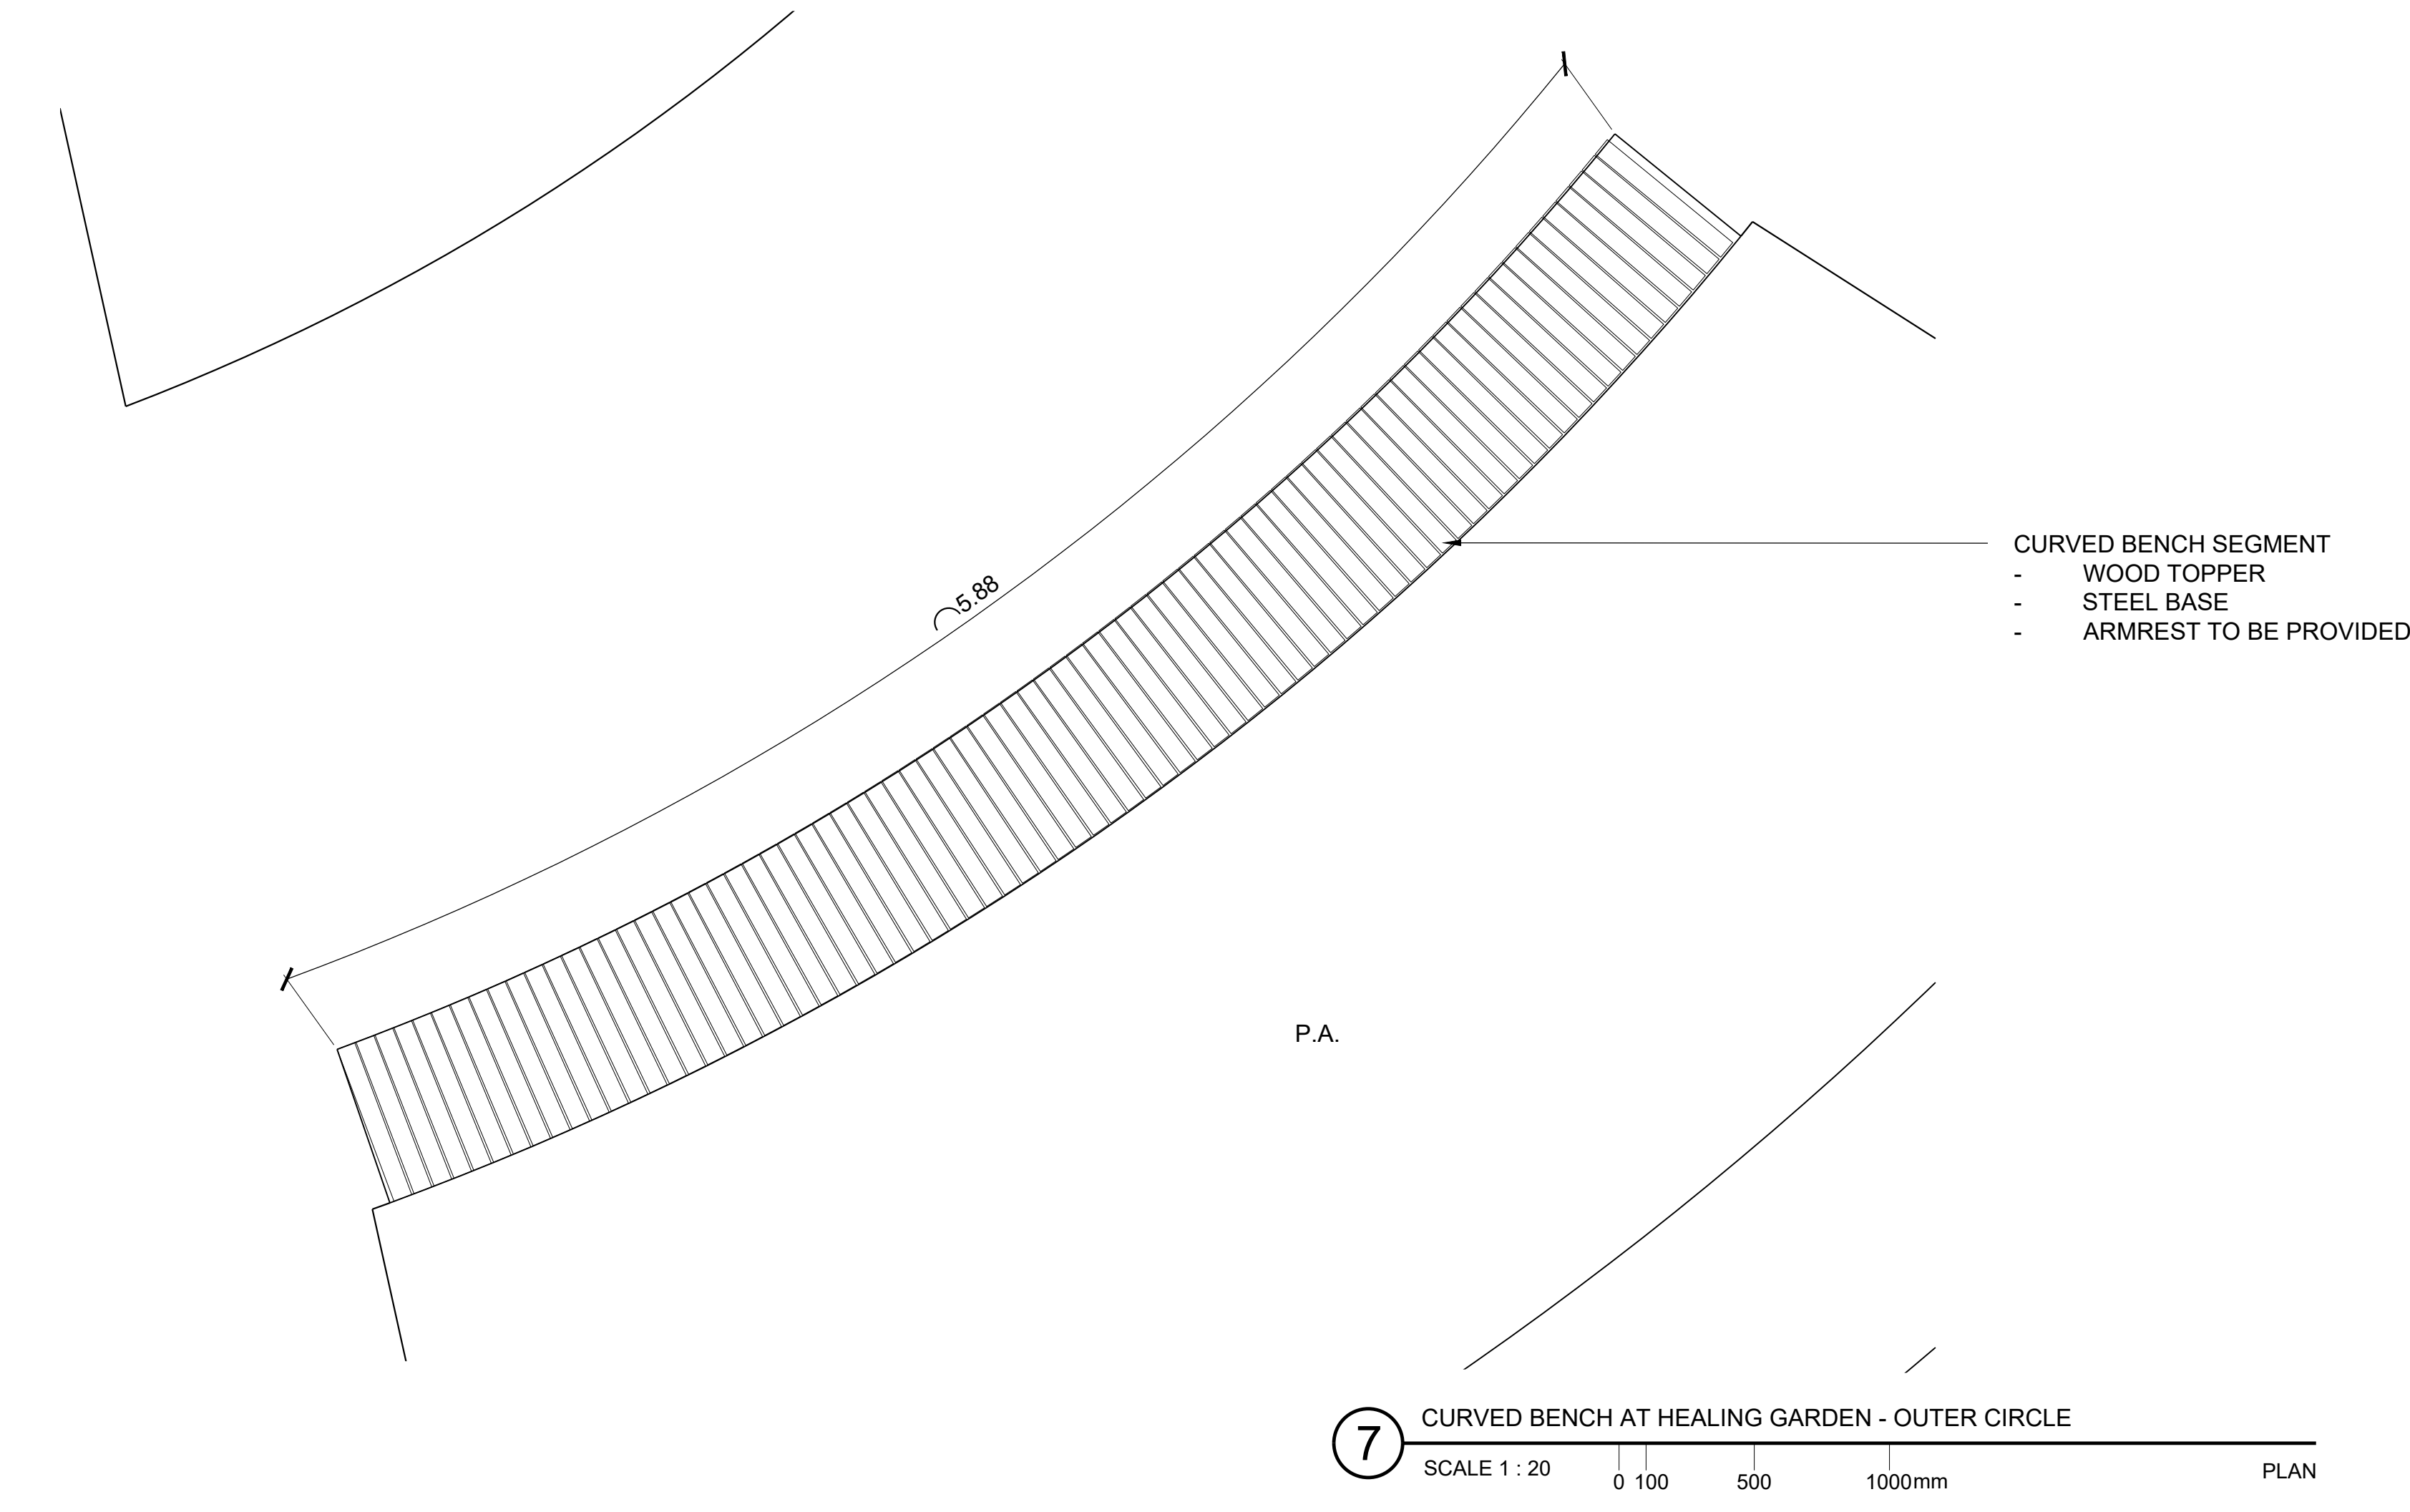


THIS DRAWING IS THE PROPERTY OF PWP AND IS NOT TO BE REPRODUCED OR TRANSMITTED IN ANY FORM OR BY ANY MEANS, ELECTRONIC OR MECHANICAL, WITHOUT THE WRITTEN PERMISSION OF PWP.

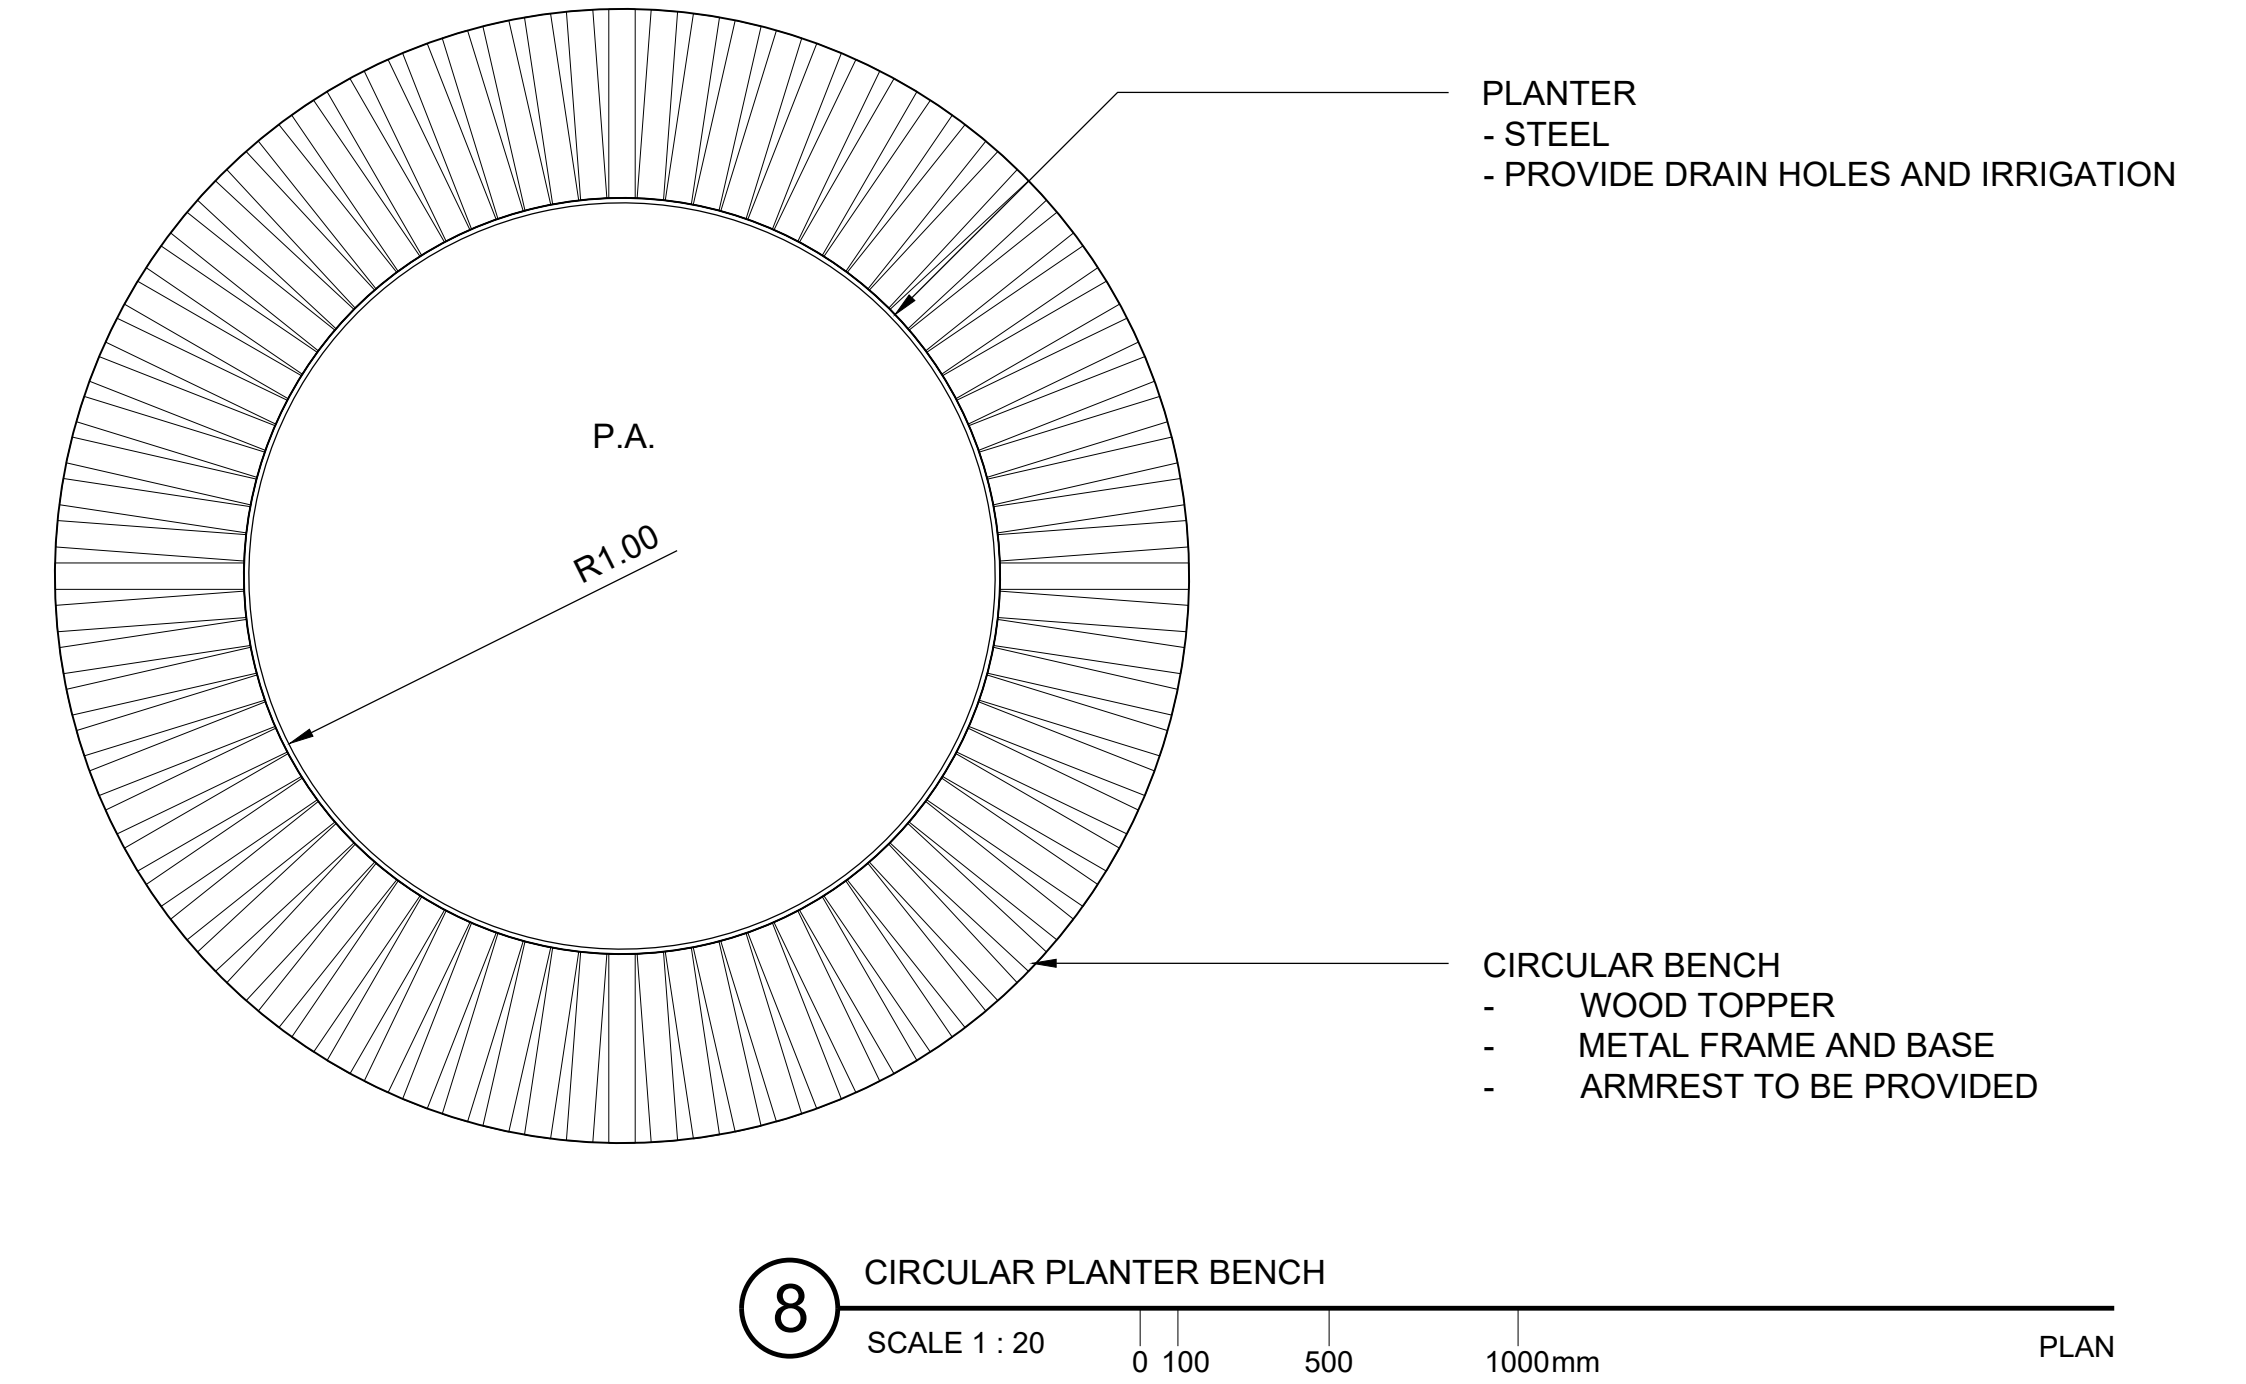

PROJECT
THE OTTAWA HOSPITAL
NEW CAMPUS
DEVELOPMENT -
PHASE 4 MAIN HOSPITAL
BUILDING
900 CARLING AVE. OTTAWA, ONTARIO

CLIENT
The Ottawa Hospital | L'Hôpital d'Ottawa

Infrastructure Ontario

PCL CONSTRUCTION | **EllisDon**

CLIENT PROJECT NO. 1070002

KEY PLAN
TRUE NORTH | PROJECT NORTH

REVISIONS

NO.	DESCRIPTION	DATE
04	SITE PLAN CONTROL, RESUBMISSION	2025-01-13
03	85% DD SUBMISSION	2025-09-18
02	SITE PLAN CONTROL, RESUBMISSION	2025-06-05
01	65% DD SUBMISSION	2025-06-05

DRAWING STATUS

NOT FOR CONSTRUCTION

DISCREPANCIES MUST BE REPORTED IMMEDIATELY TO THE ARCHITECT BEFORE PROCEEDING. ONLY FIGURED DIMENSIONS ARE TO BE USED. CONTRACTORS MUST CHECK ALL DIMENSIONS ON SITE. THIS DRAWING IS PROTECTED BY COPYRIGHT.

ALL DIMENSIONS ARE SHOWN IN METRIC.

AUTHOR
PWP

PROJECT TEAM

DESIGN BUILDER POLIED A JOINT VENTURE

ARCHITECTURAL PARON ARCHITECTS LIMITED
ZOOHL LAMARIE PRATTE ARCHITECTS
ADAMSON ASSOCIATE ARCHITECTS
888 ARCHITECTS INC.

STRUCTURAL STEPHENSON ENGINEERING LTD.
BOUTHILLET PARIZEAU INC.

MECHANICAL HI ANGLIS & ASSOCIATES LTD.
CROSSEY ENGINEERING LTD.

ELECTRICAL MELVEY & BIRN INTERNATIONAL INC.
RFP CANADA INC.

CIVIL VERTECOBS DESIGN INC.
PWP LANDSCAPE ARCHITECTURE

BUILDING CODE UMDS BUILDING CODE CONSULTANTS LTD.

AUTHOR PROJECT NO. PCL2301_C

STAMP

DRAWING TITLE
SITE FURNISHING DETAILS

DRAWN | **CHECKED**

SCALE AT 42" x 60" | **DATE** 05-JUN-2025

GRAPHIC SCALE AS NOTED

DRAWING NO. L24-101 | **REV. NO.** 04