
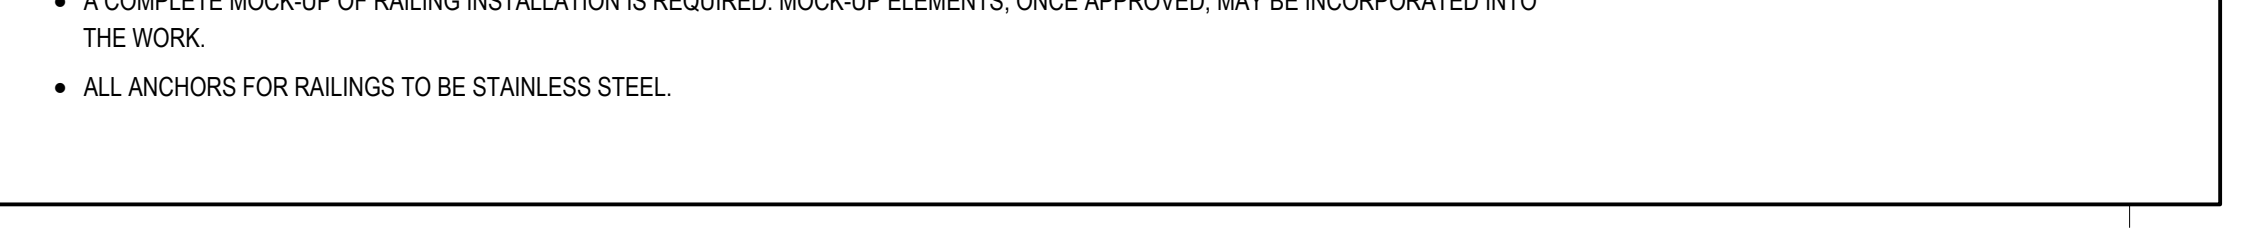
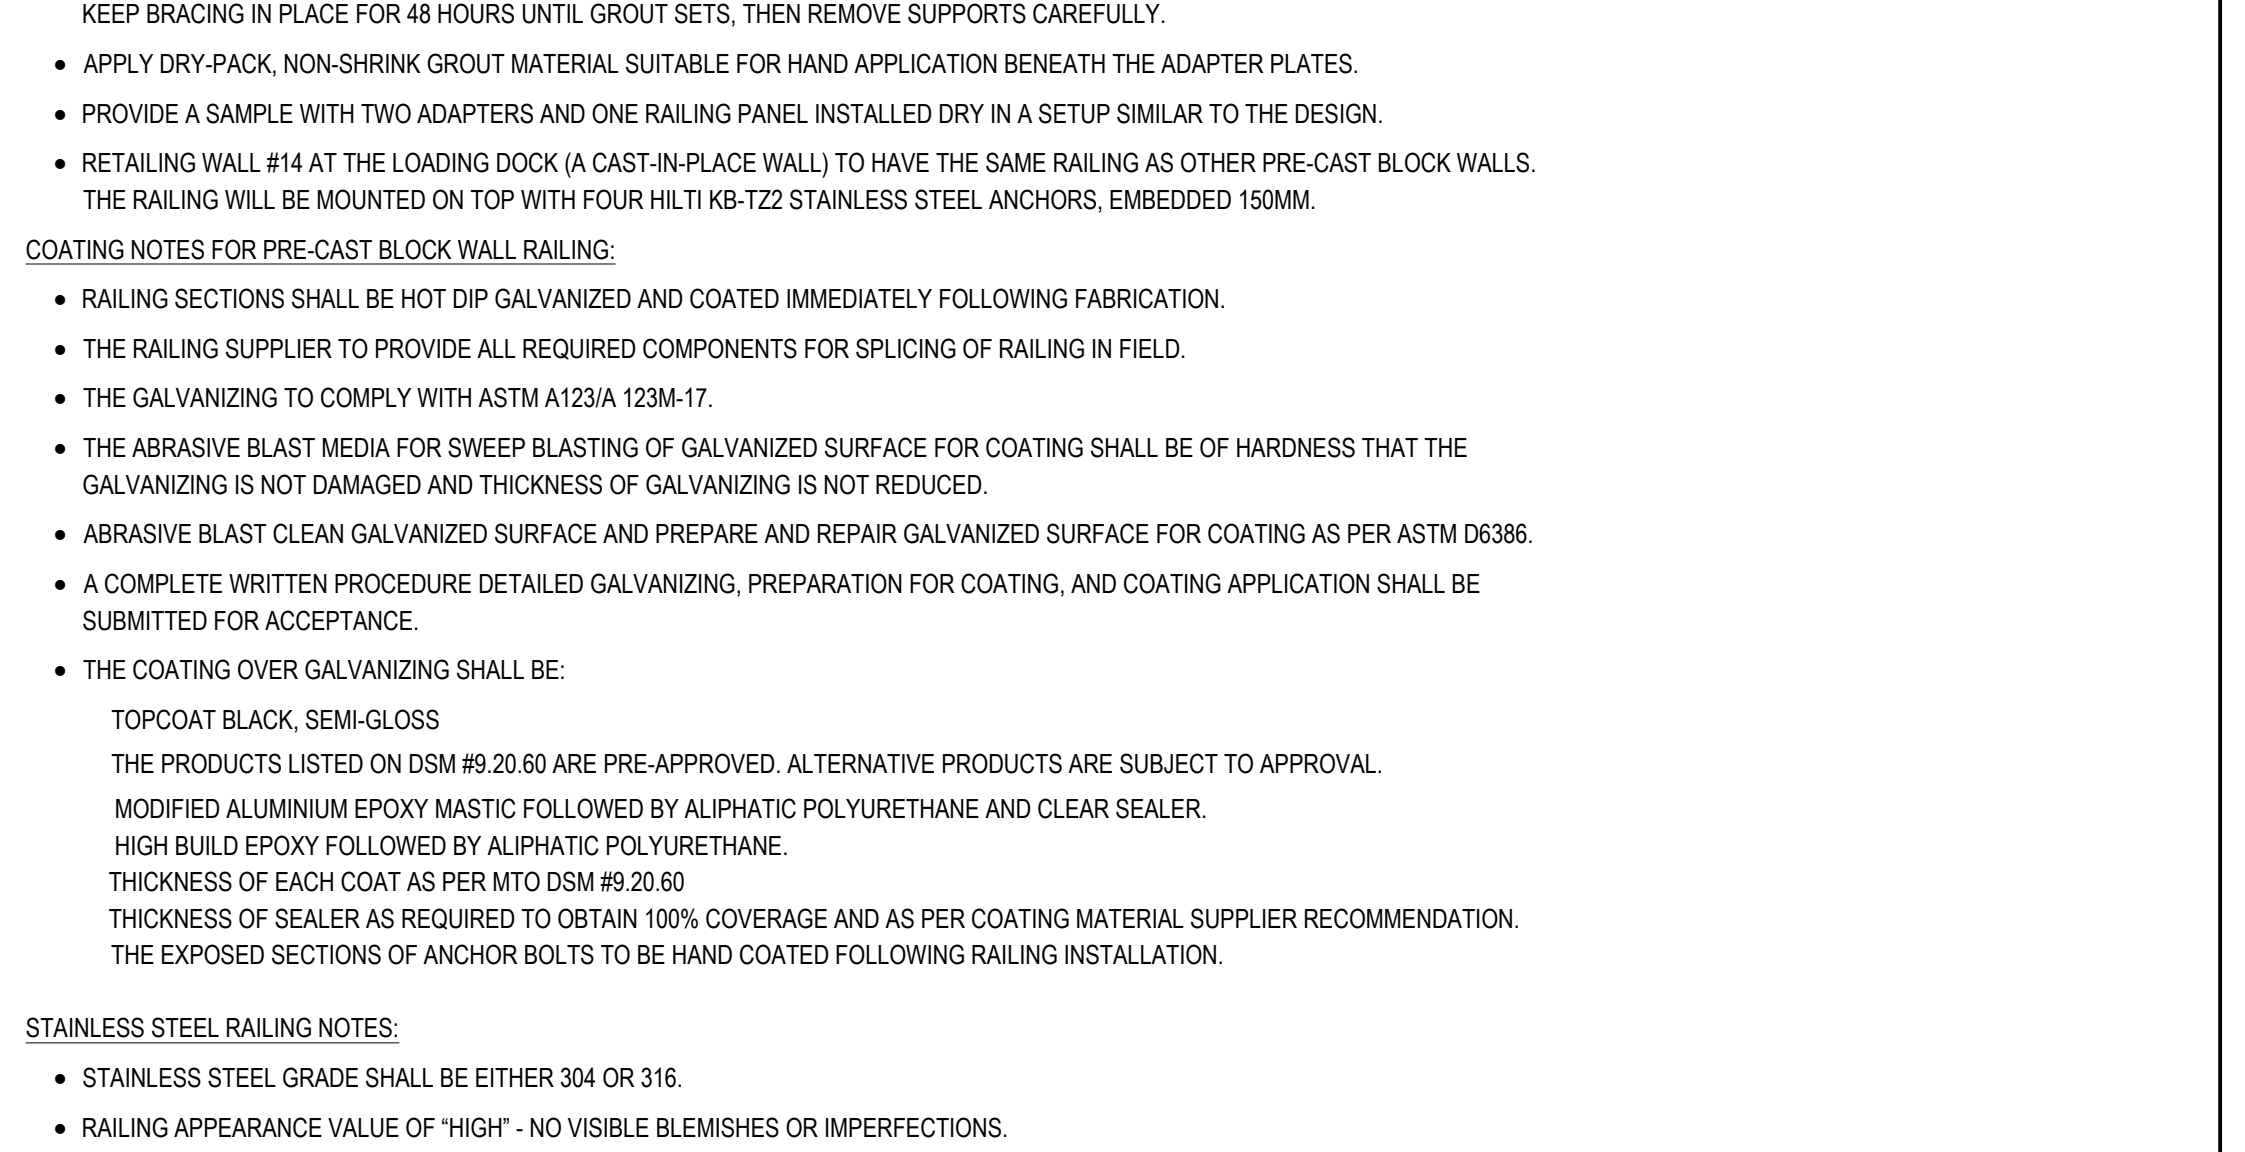
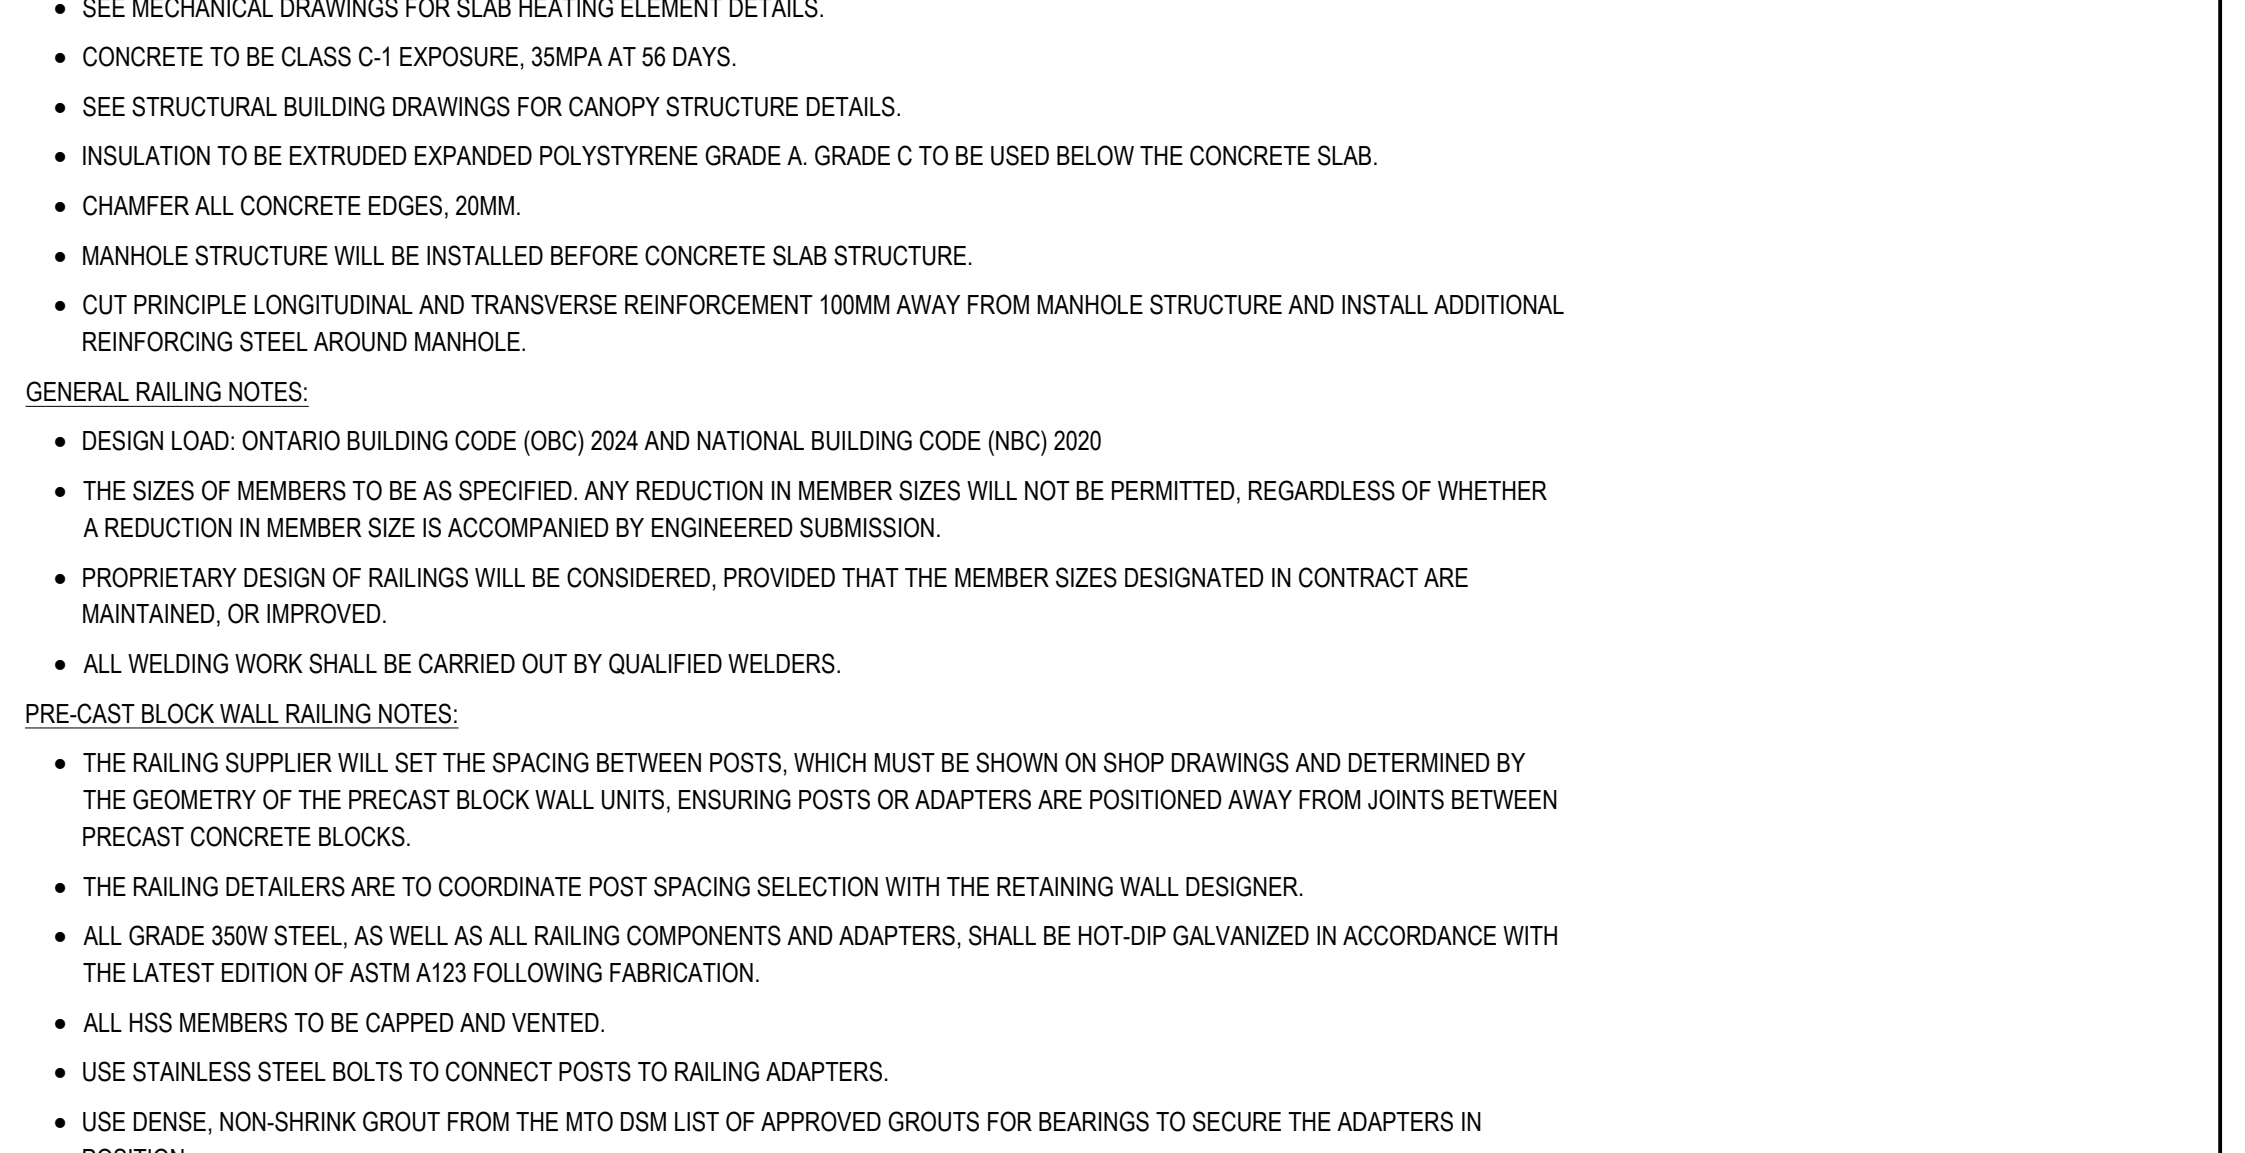
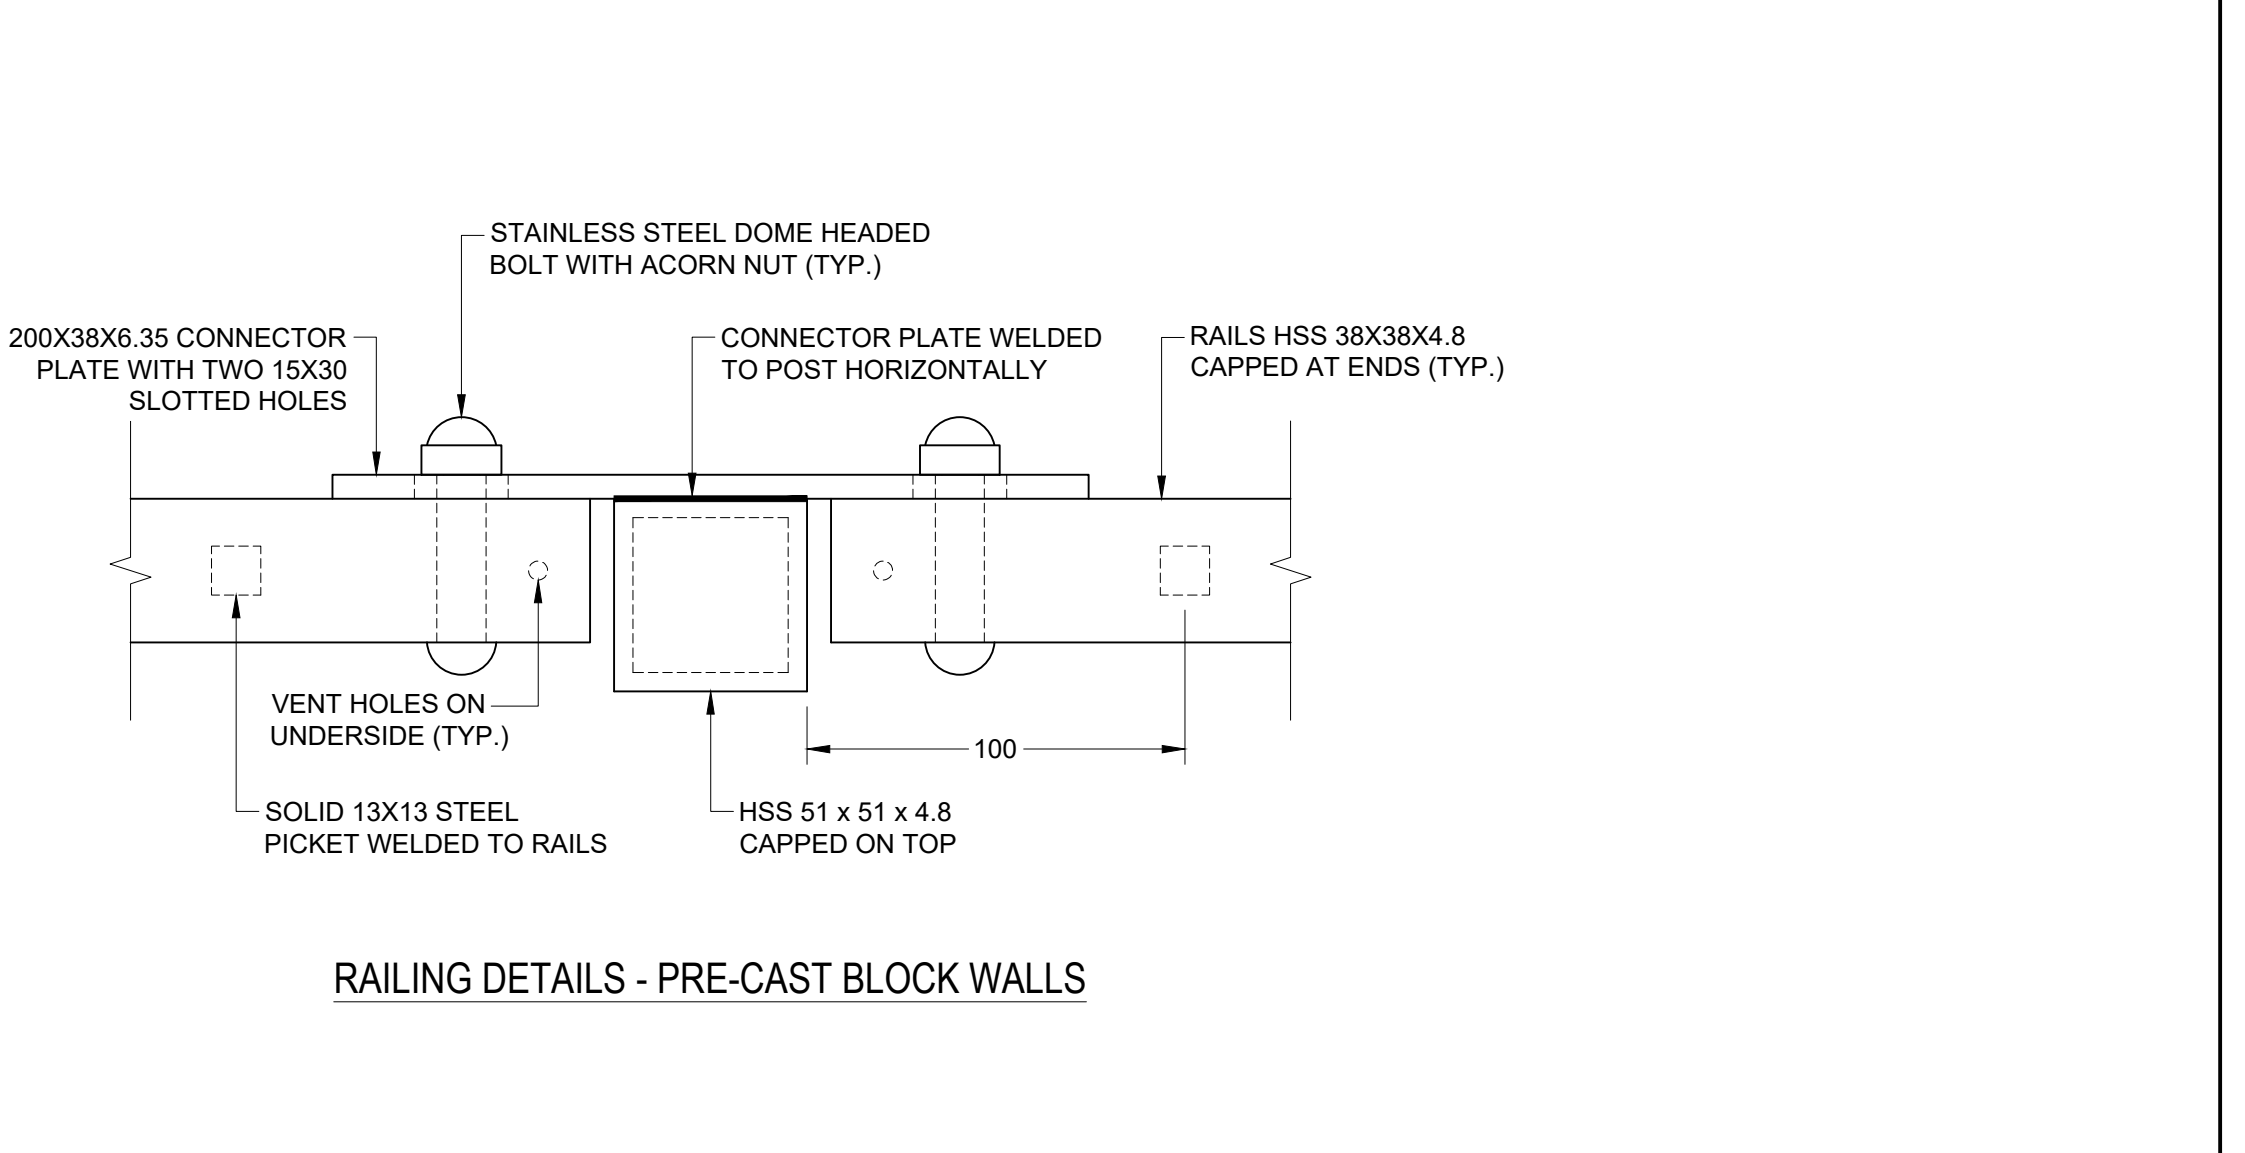
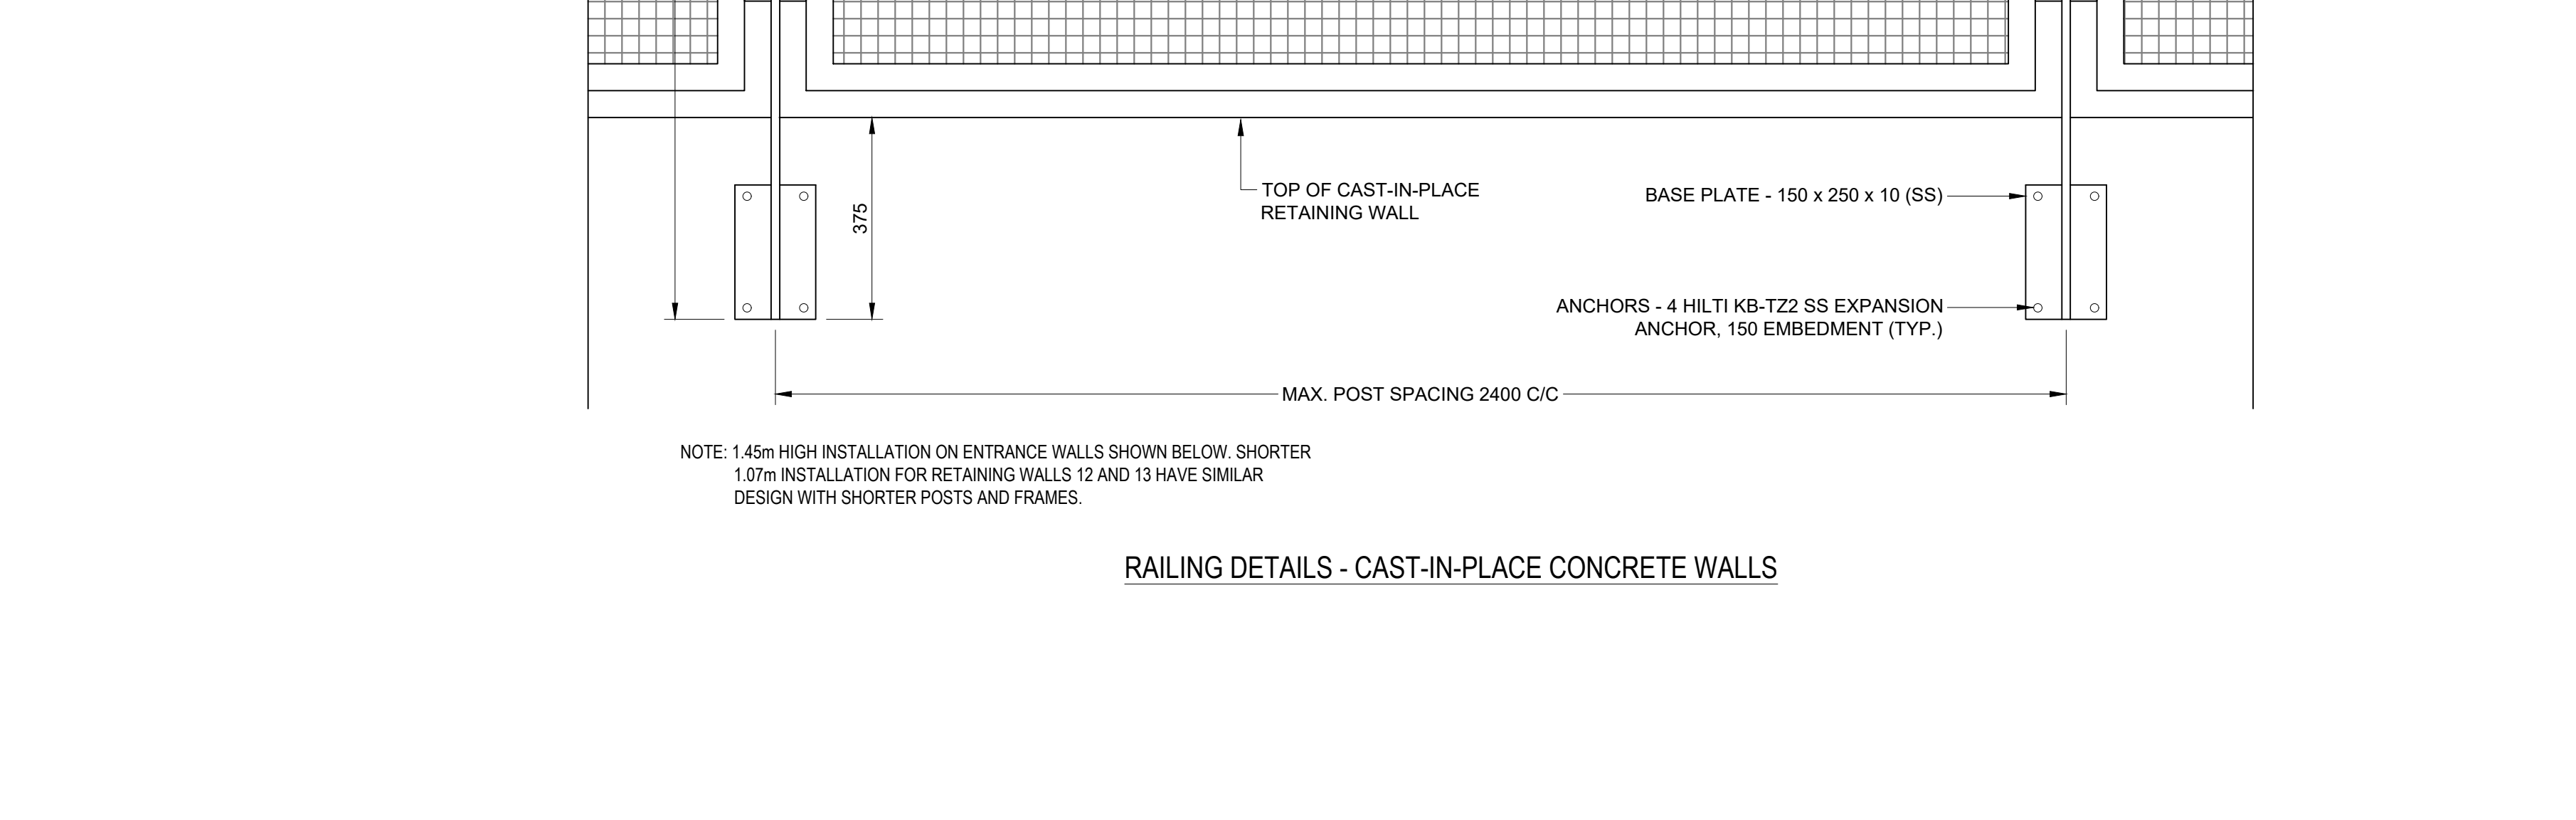
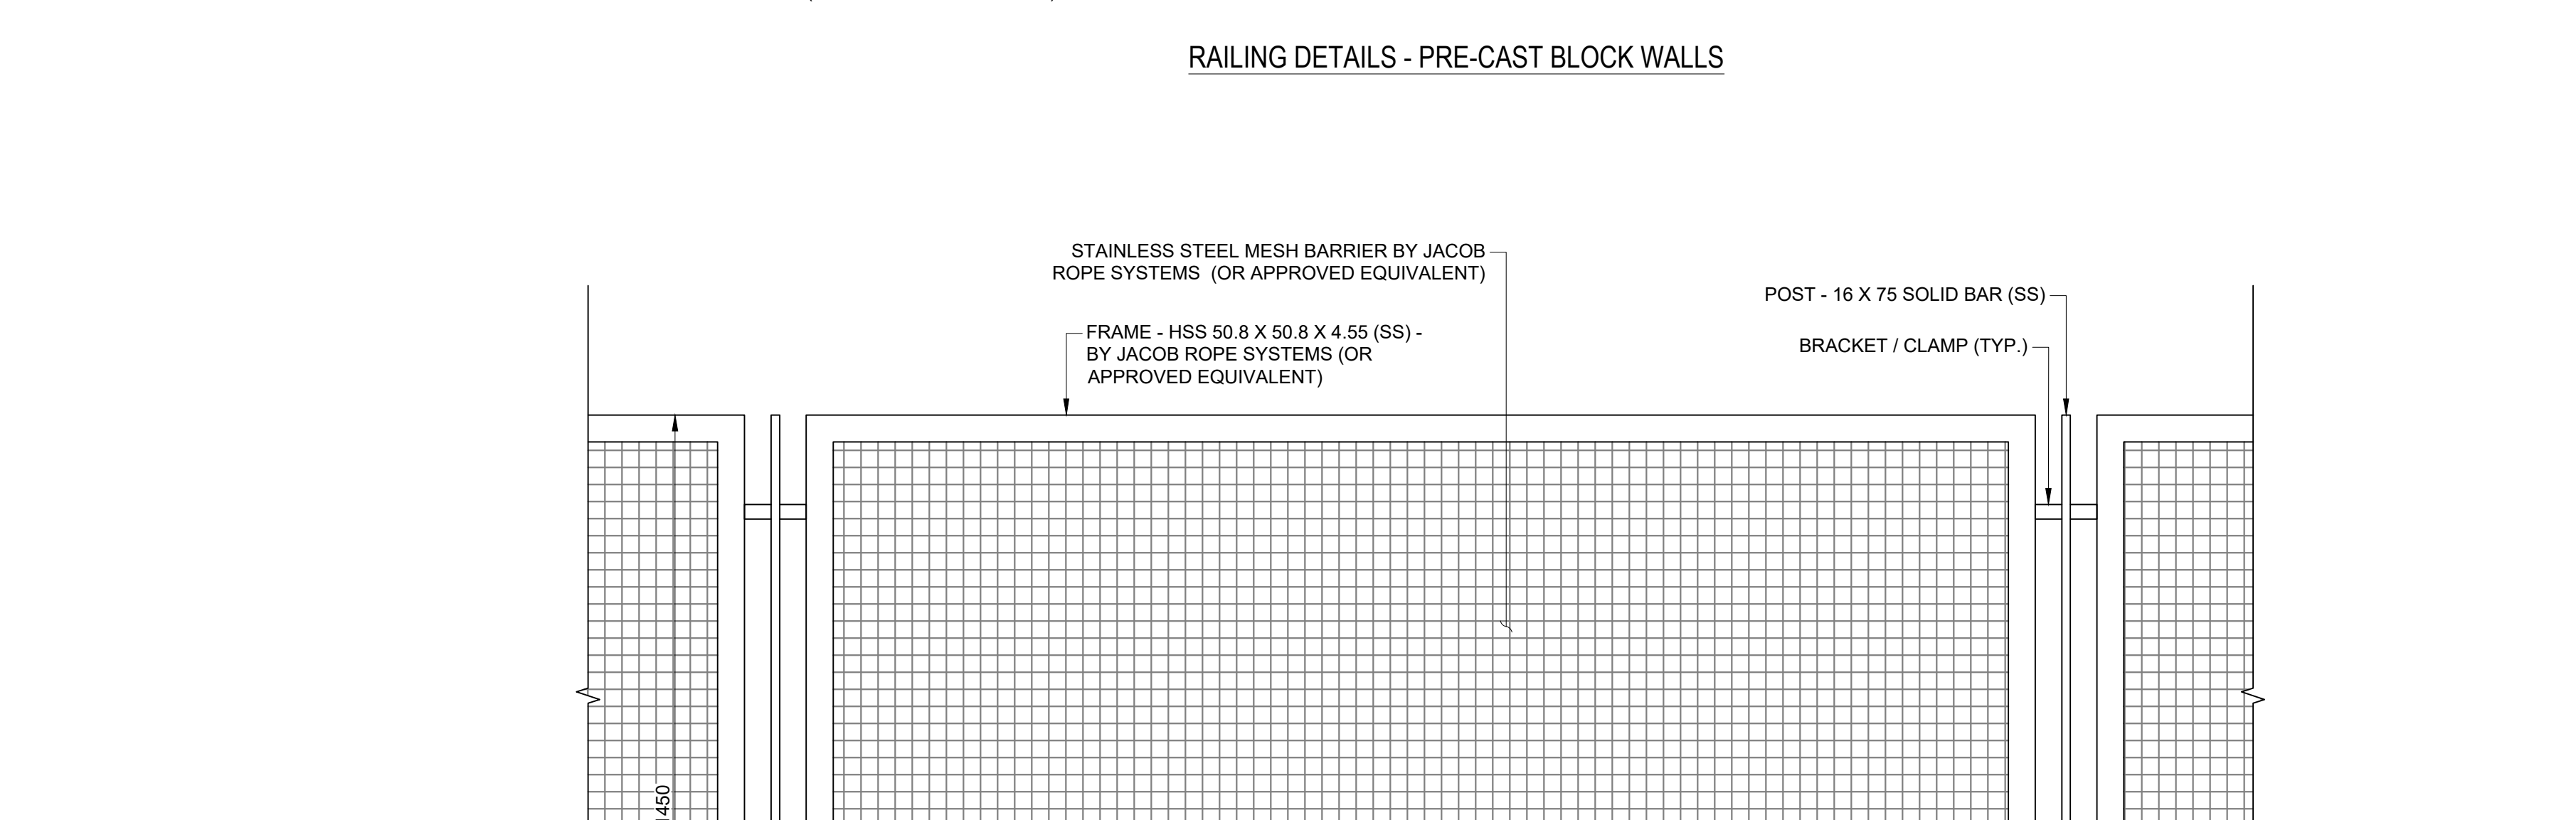
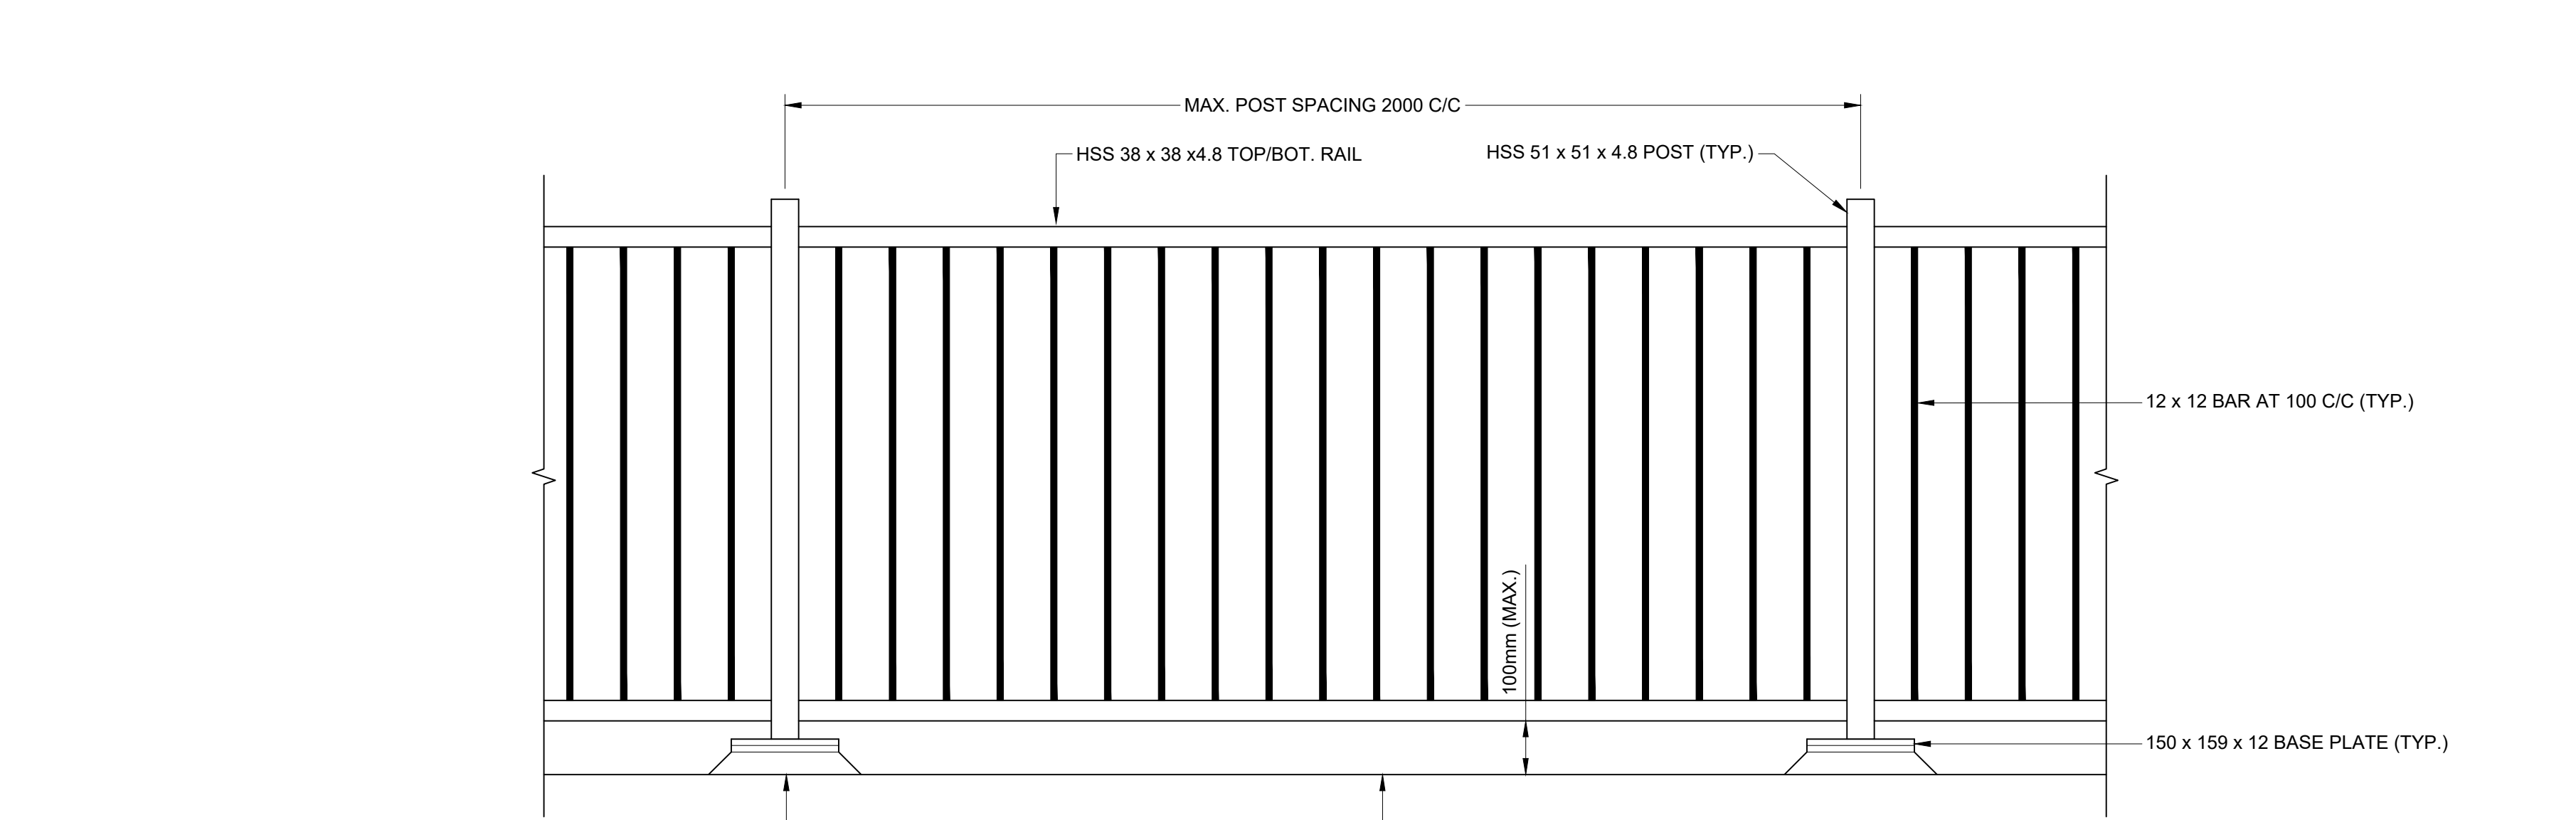
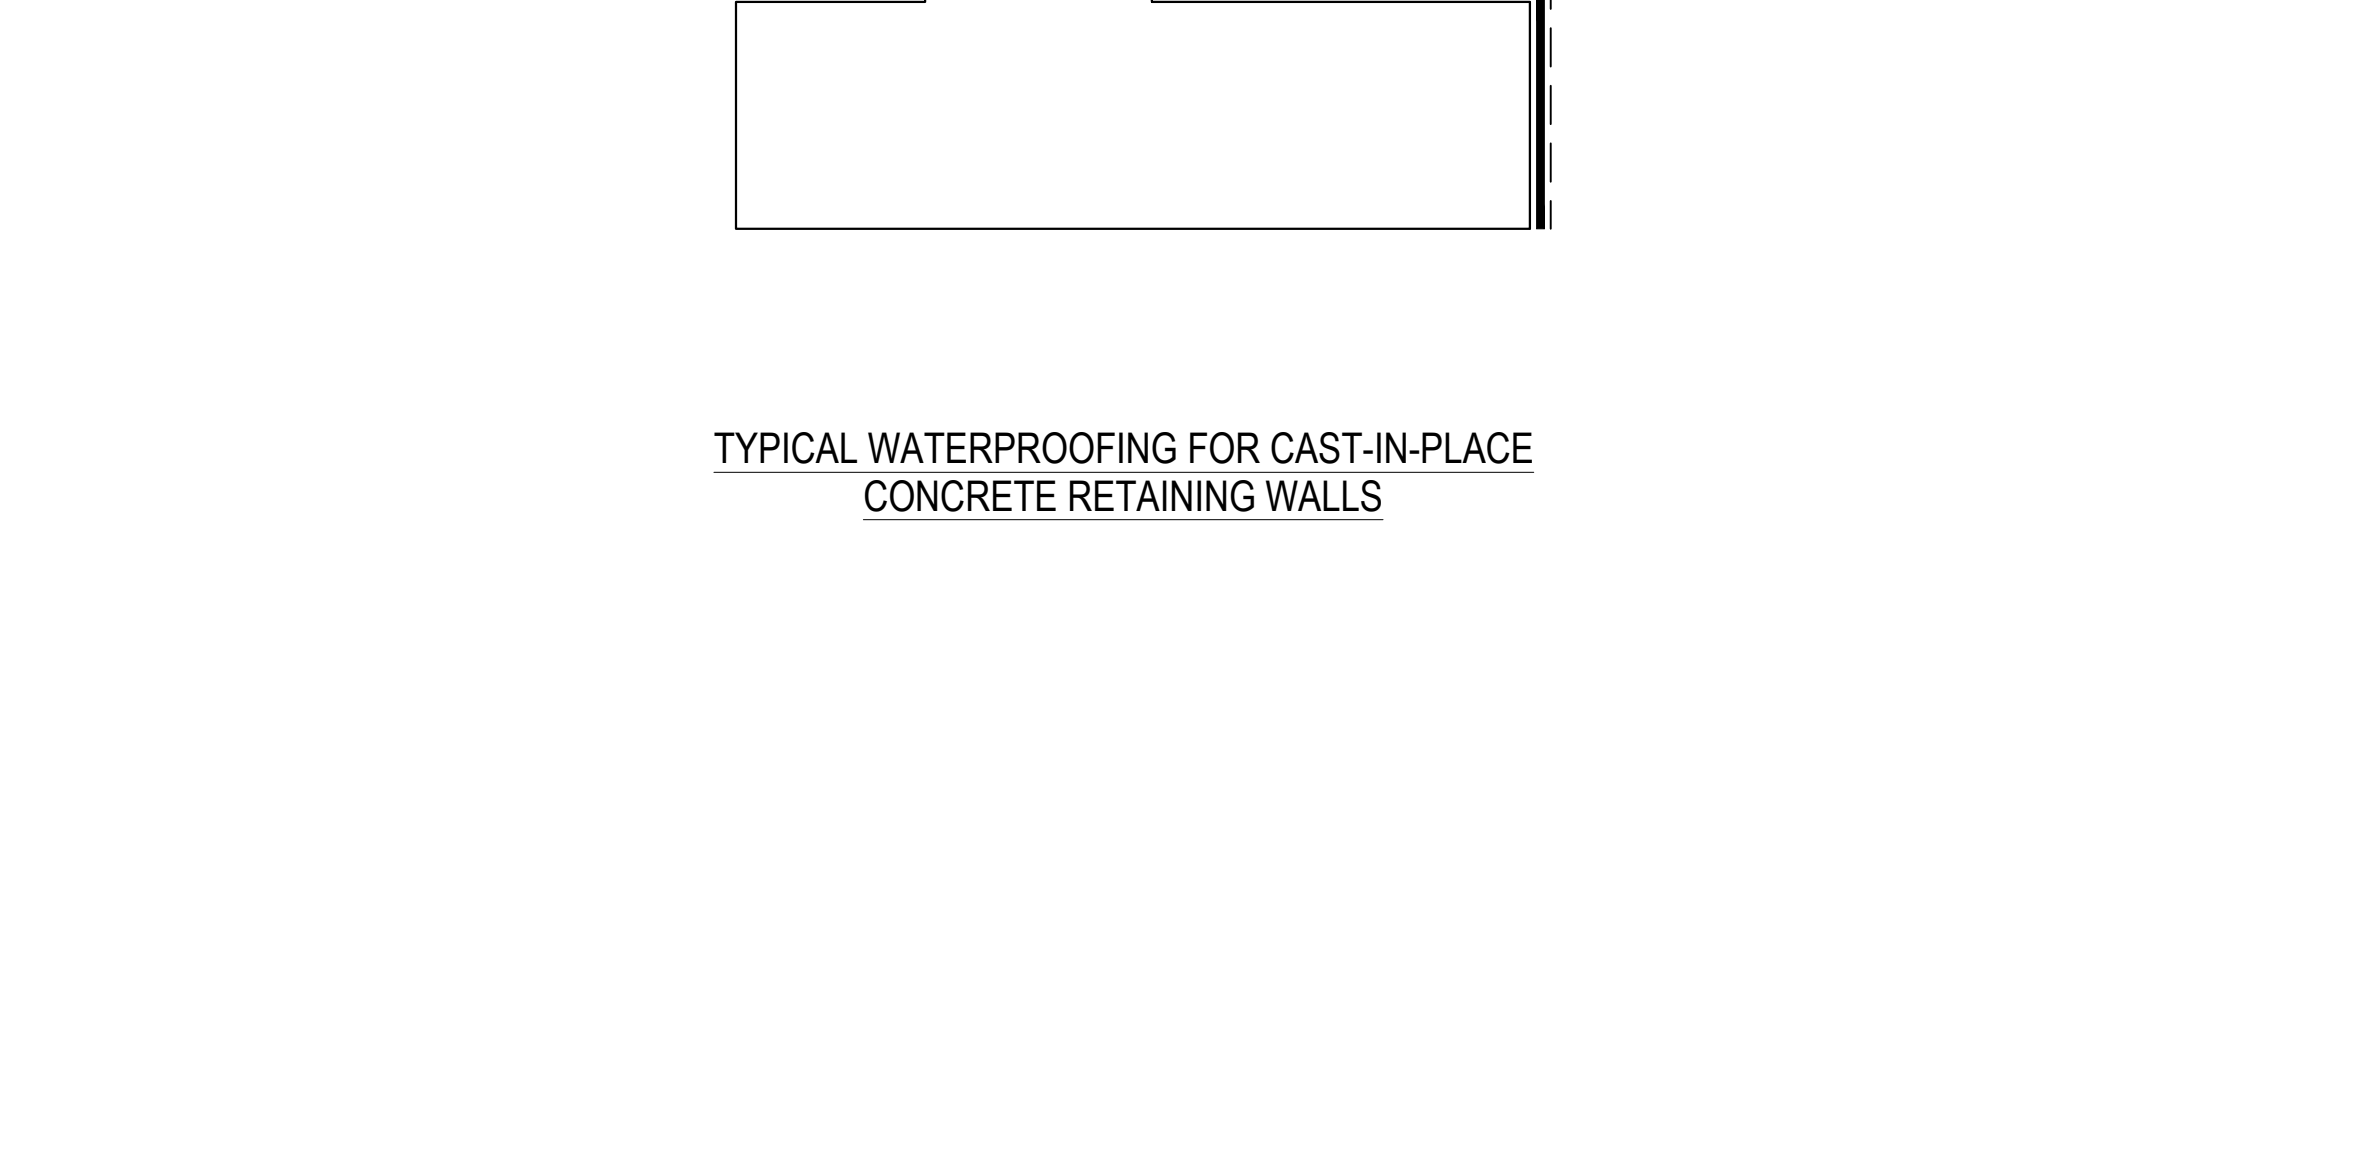
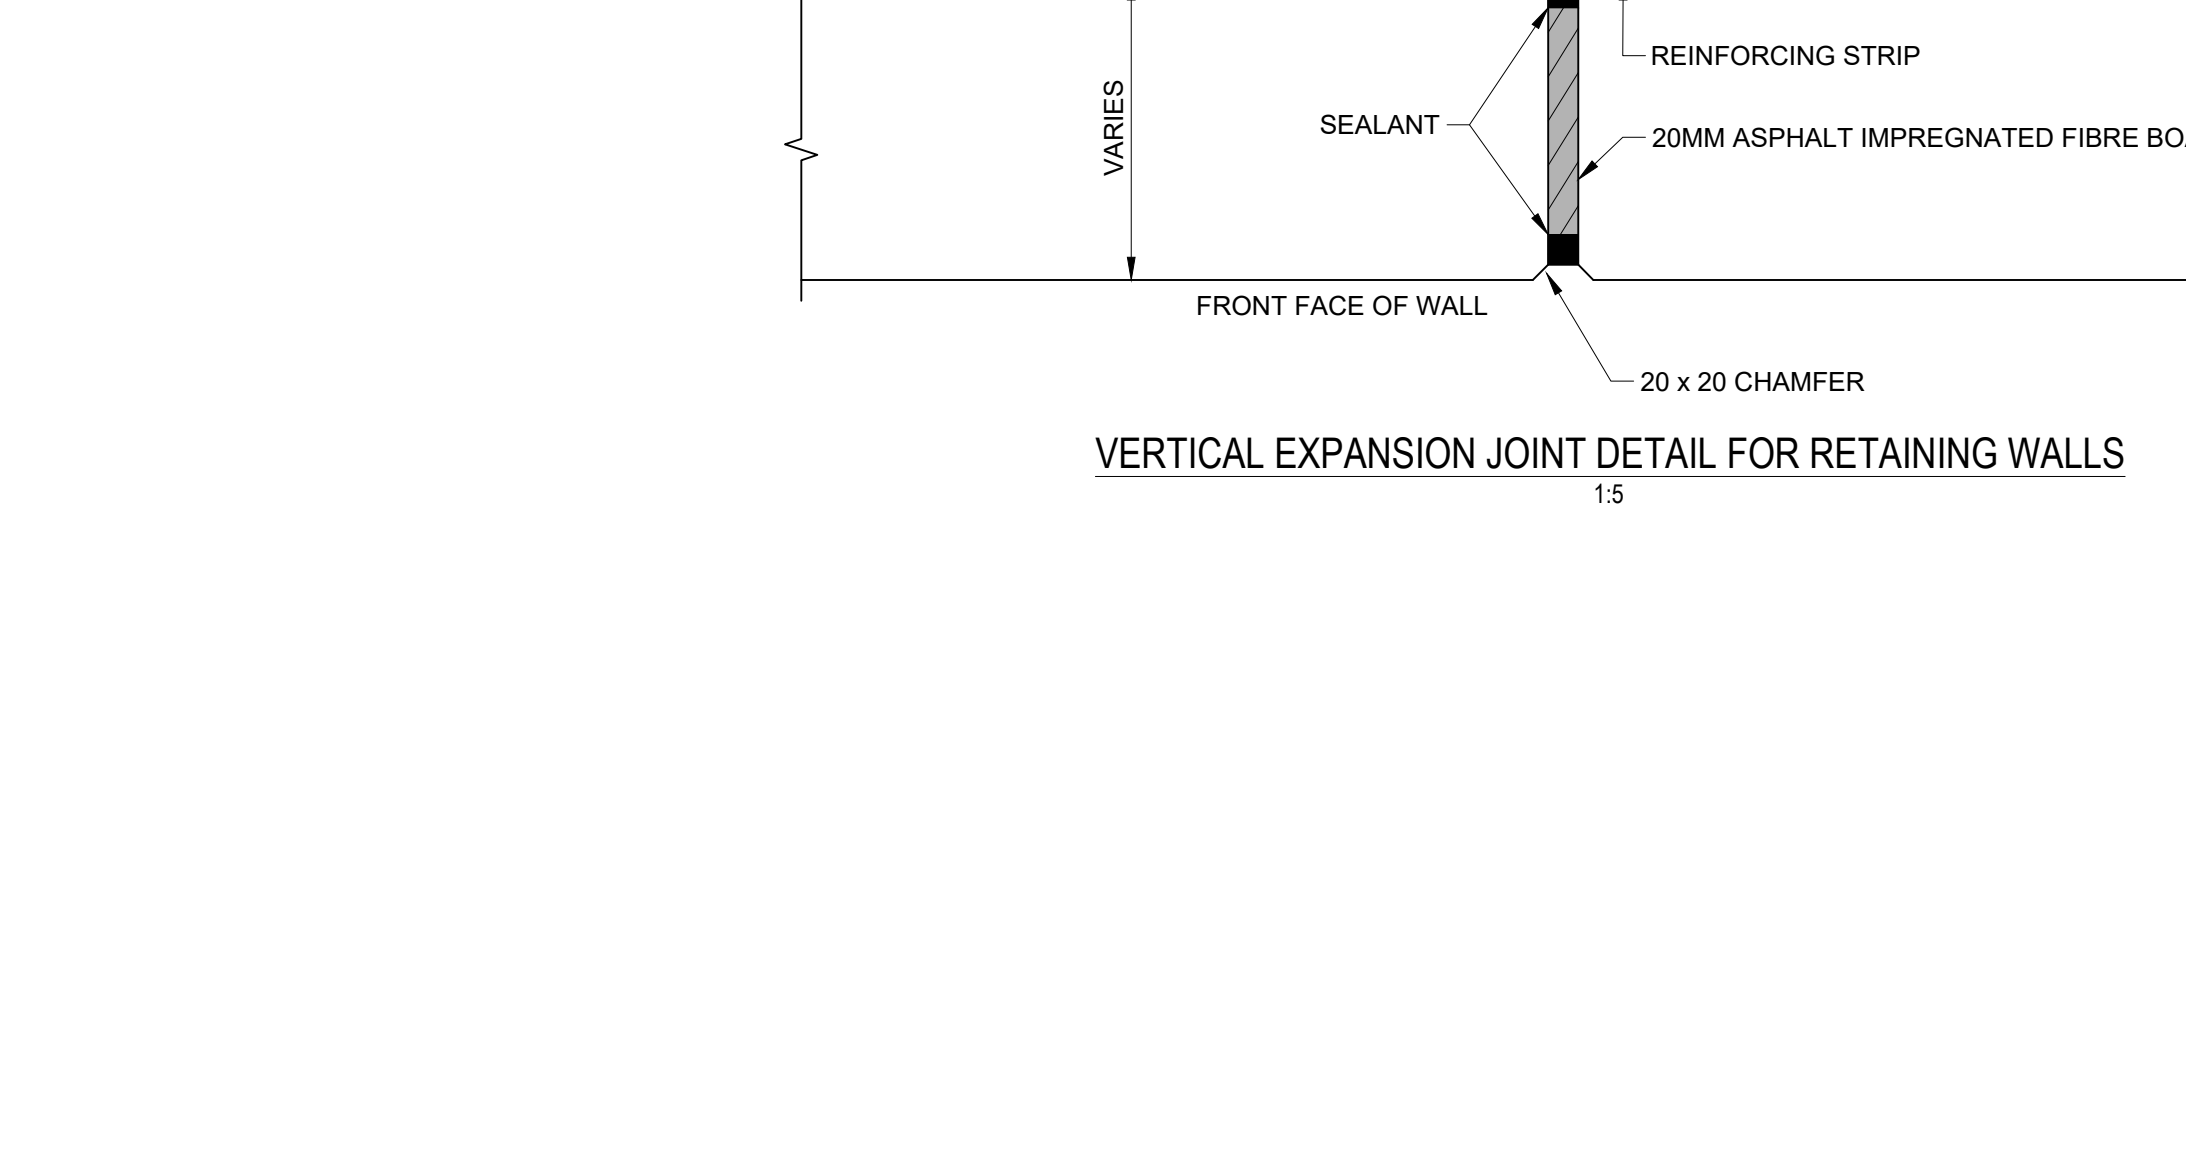
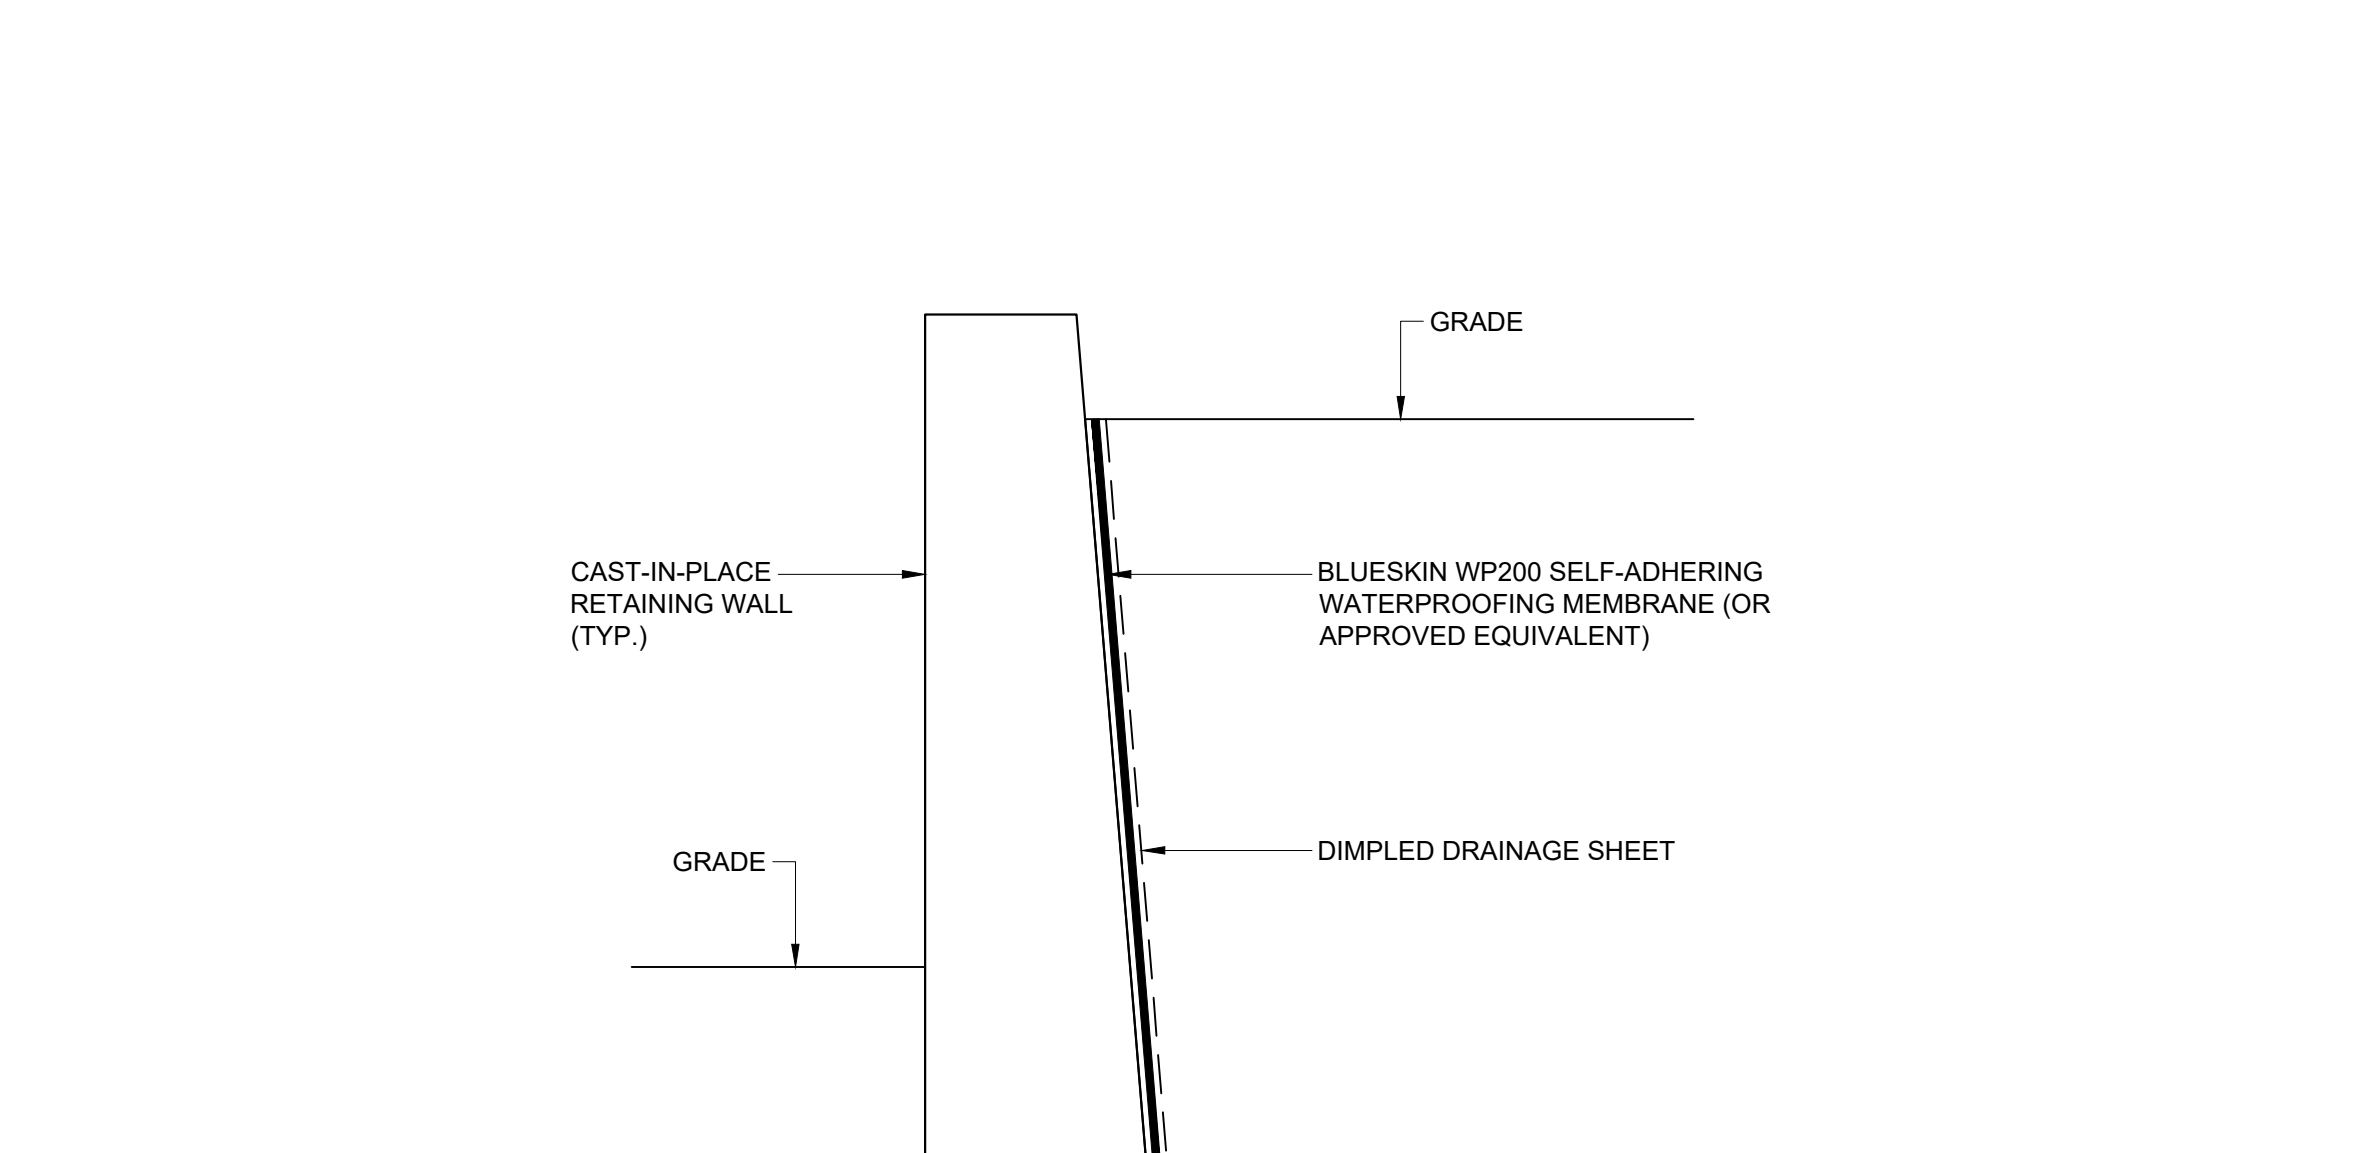
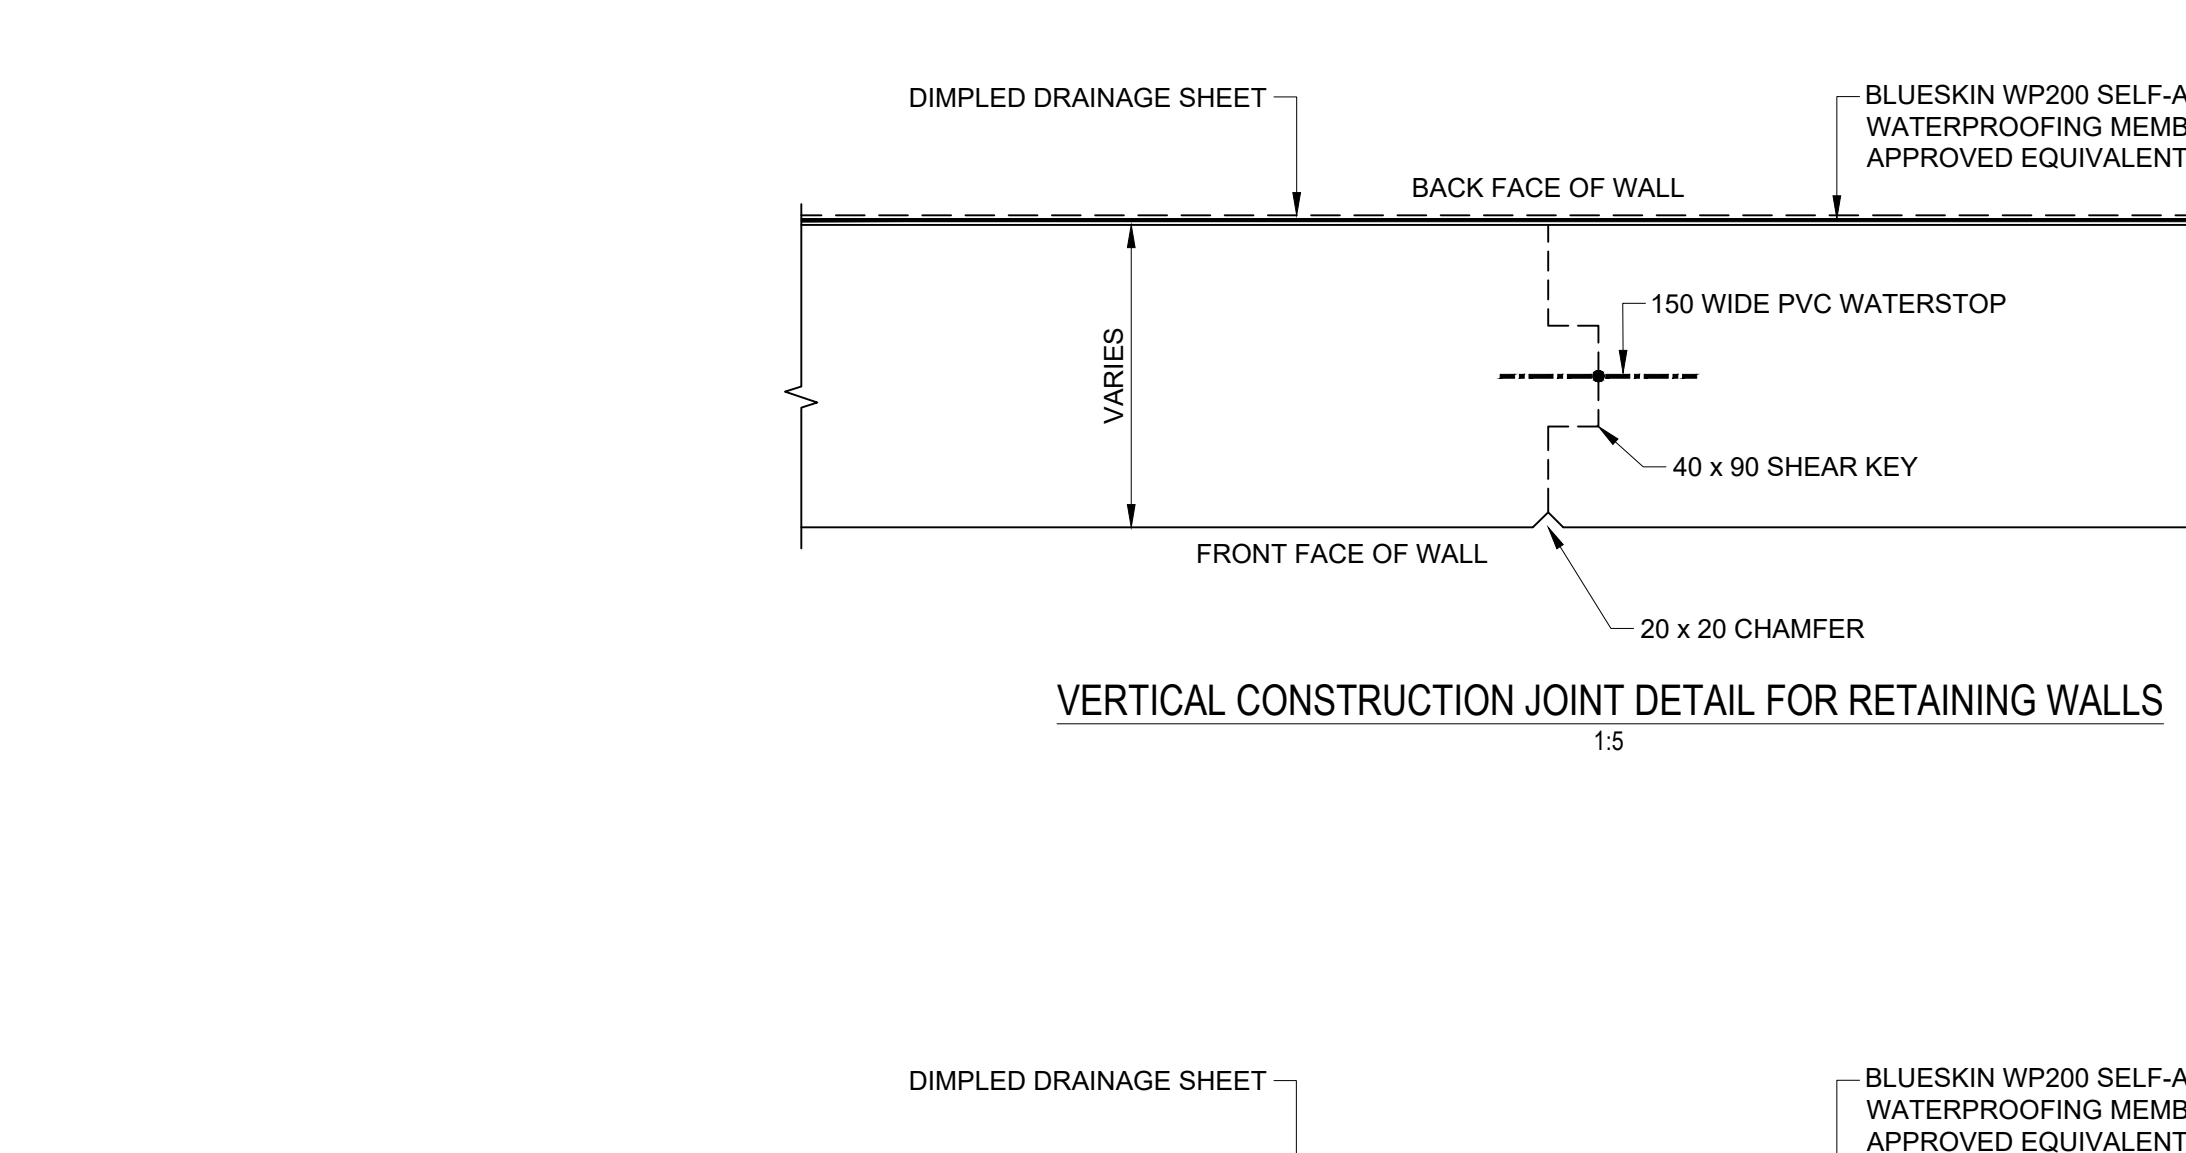
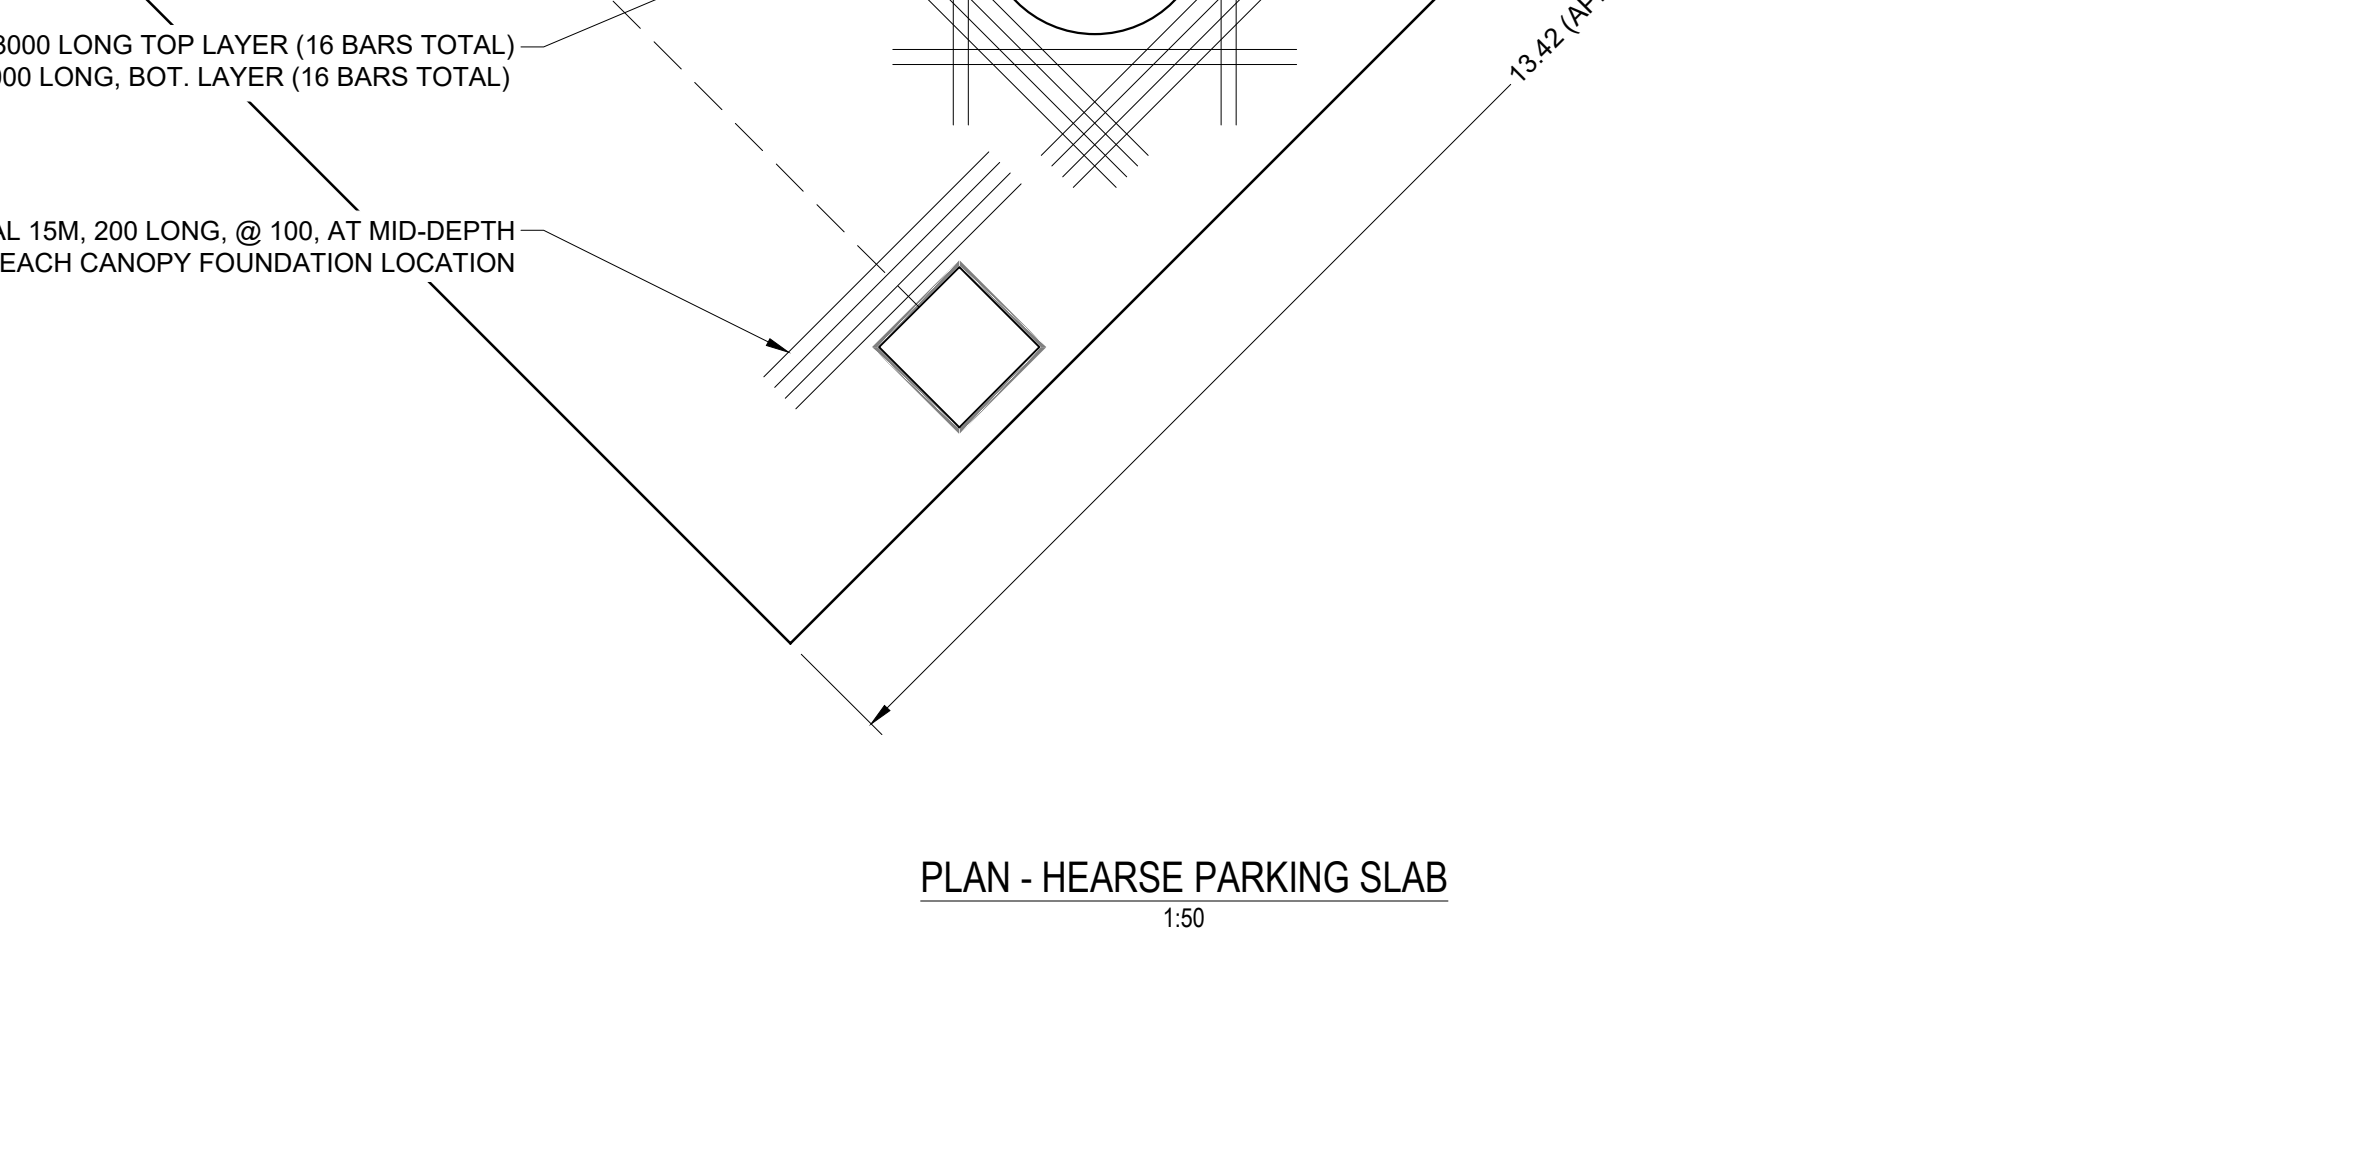
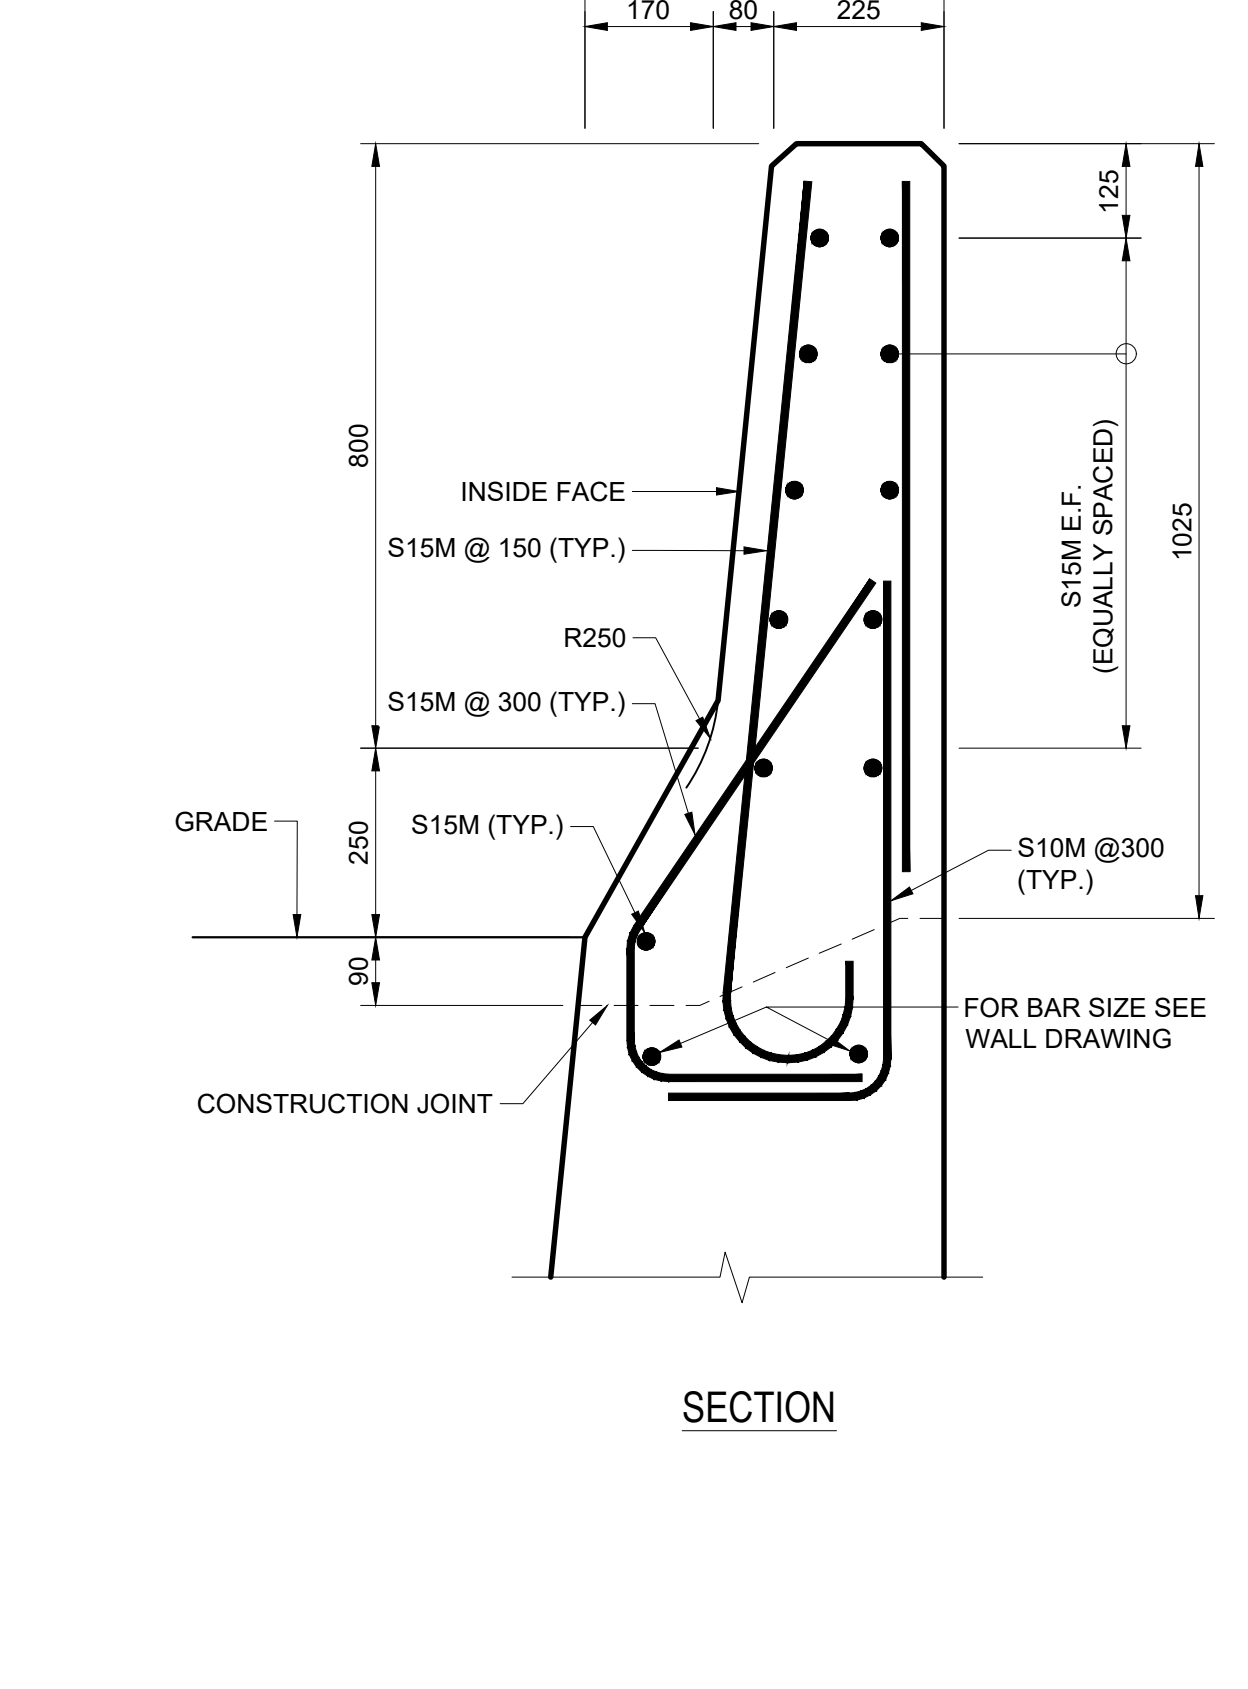
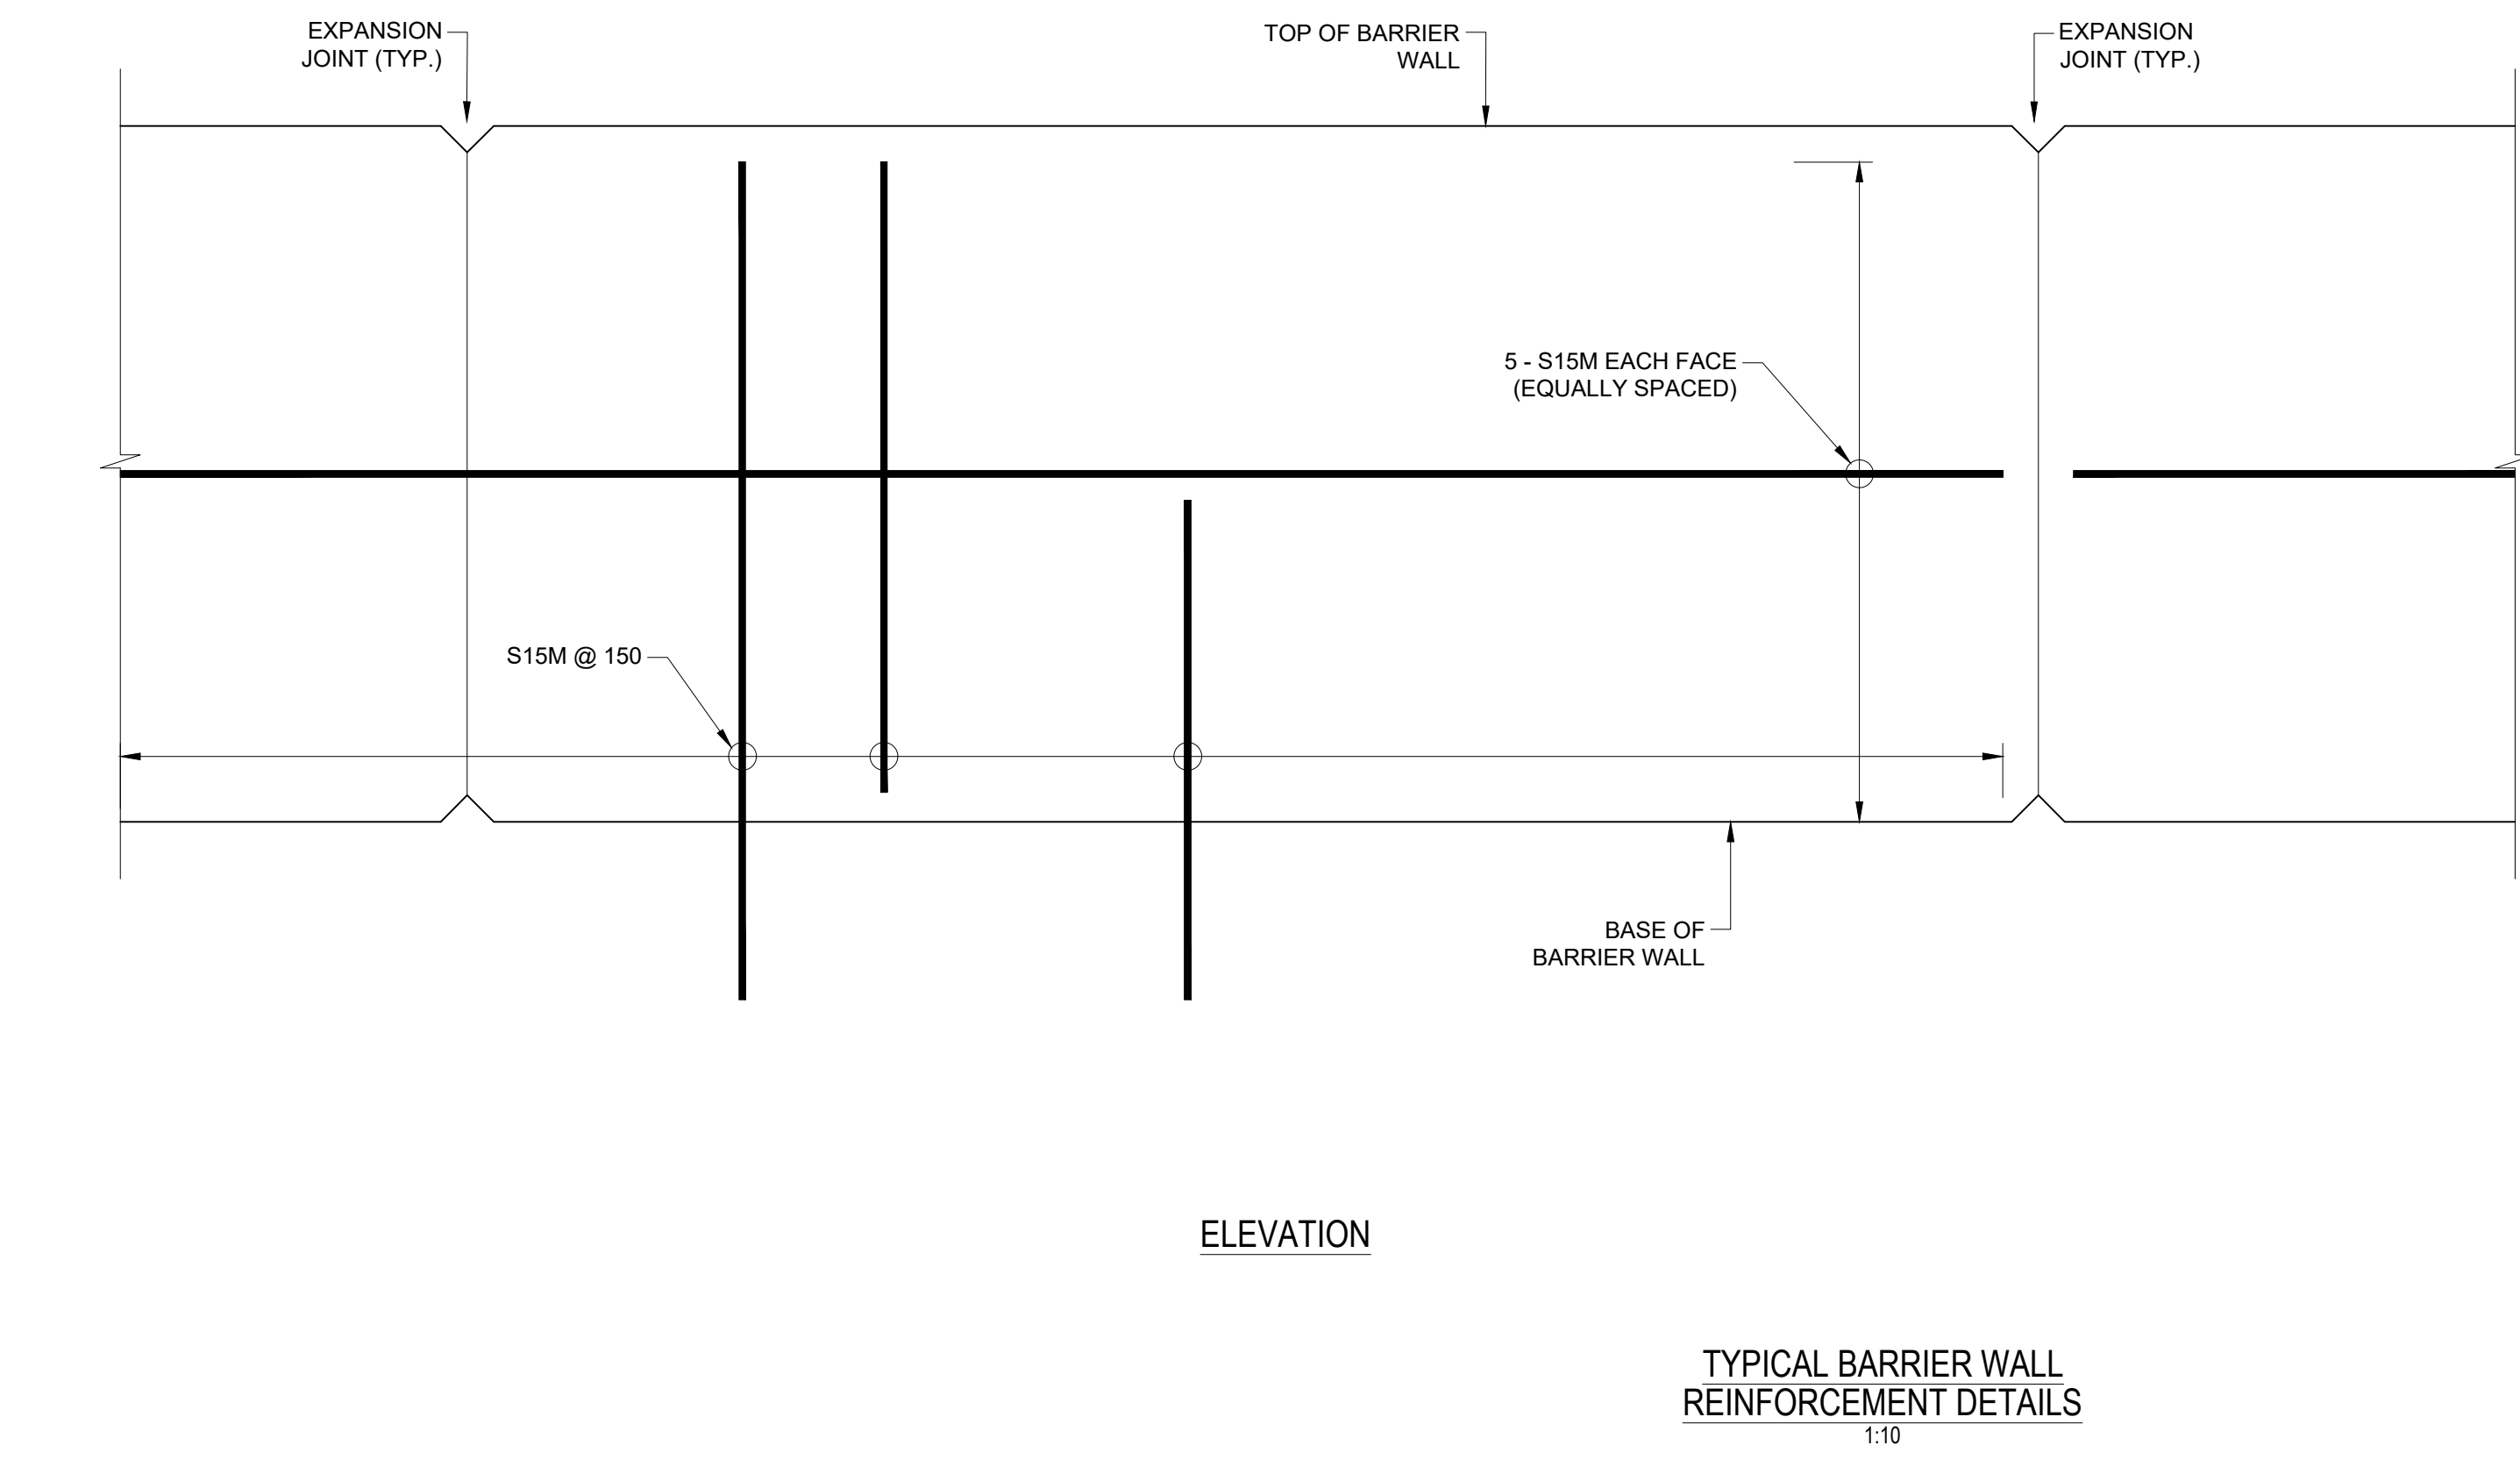
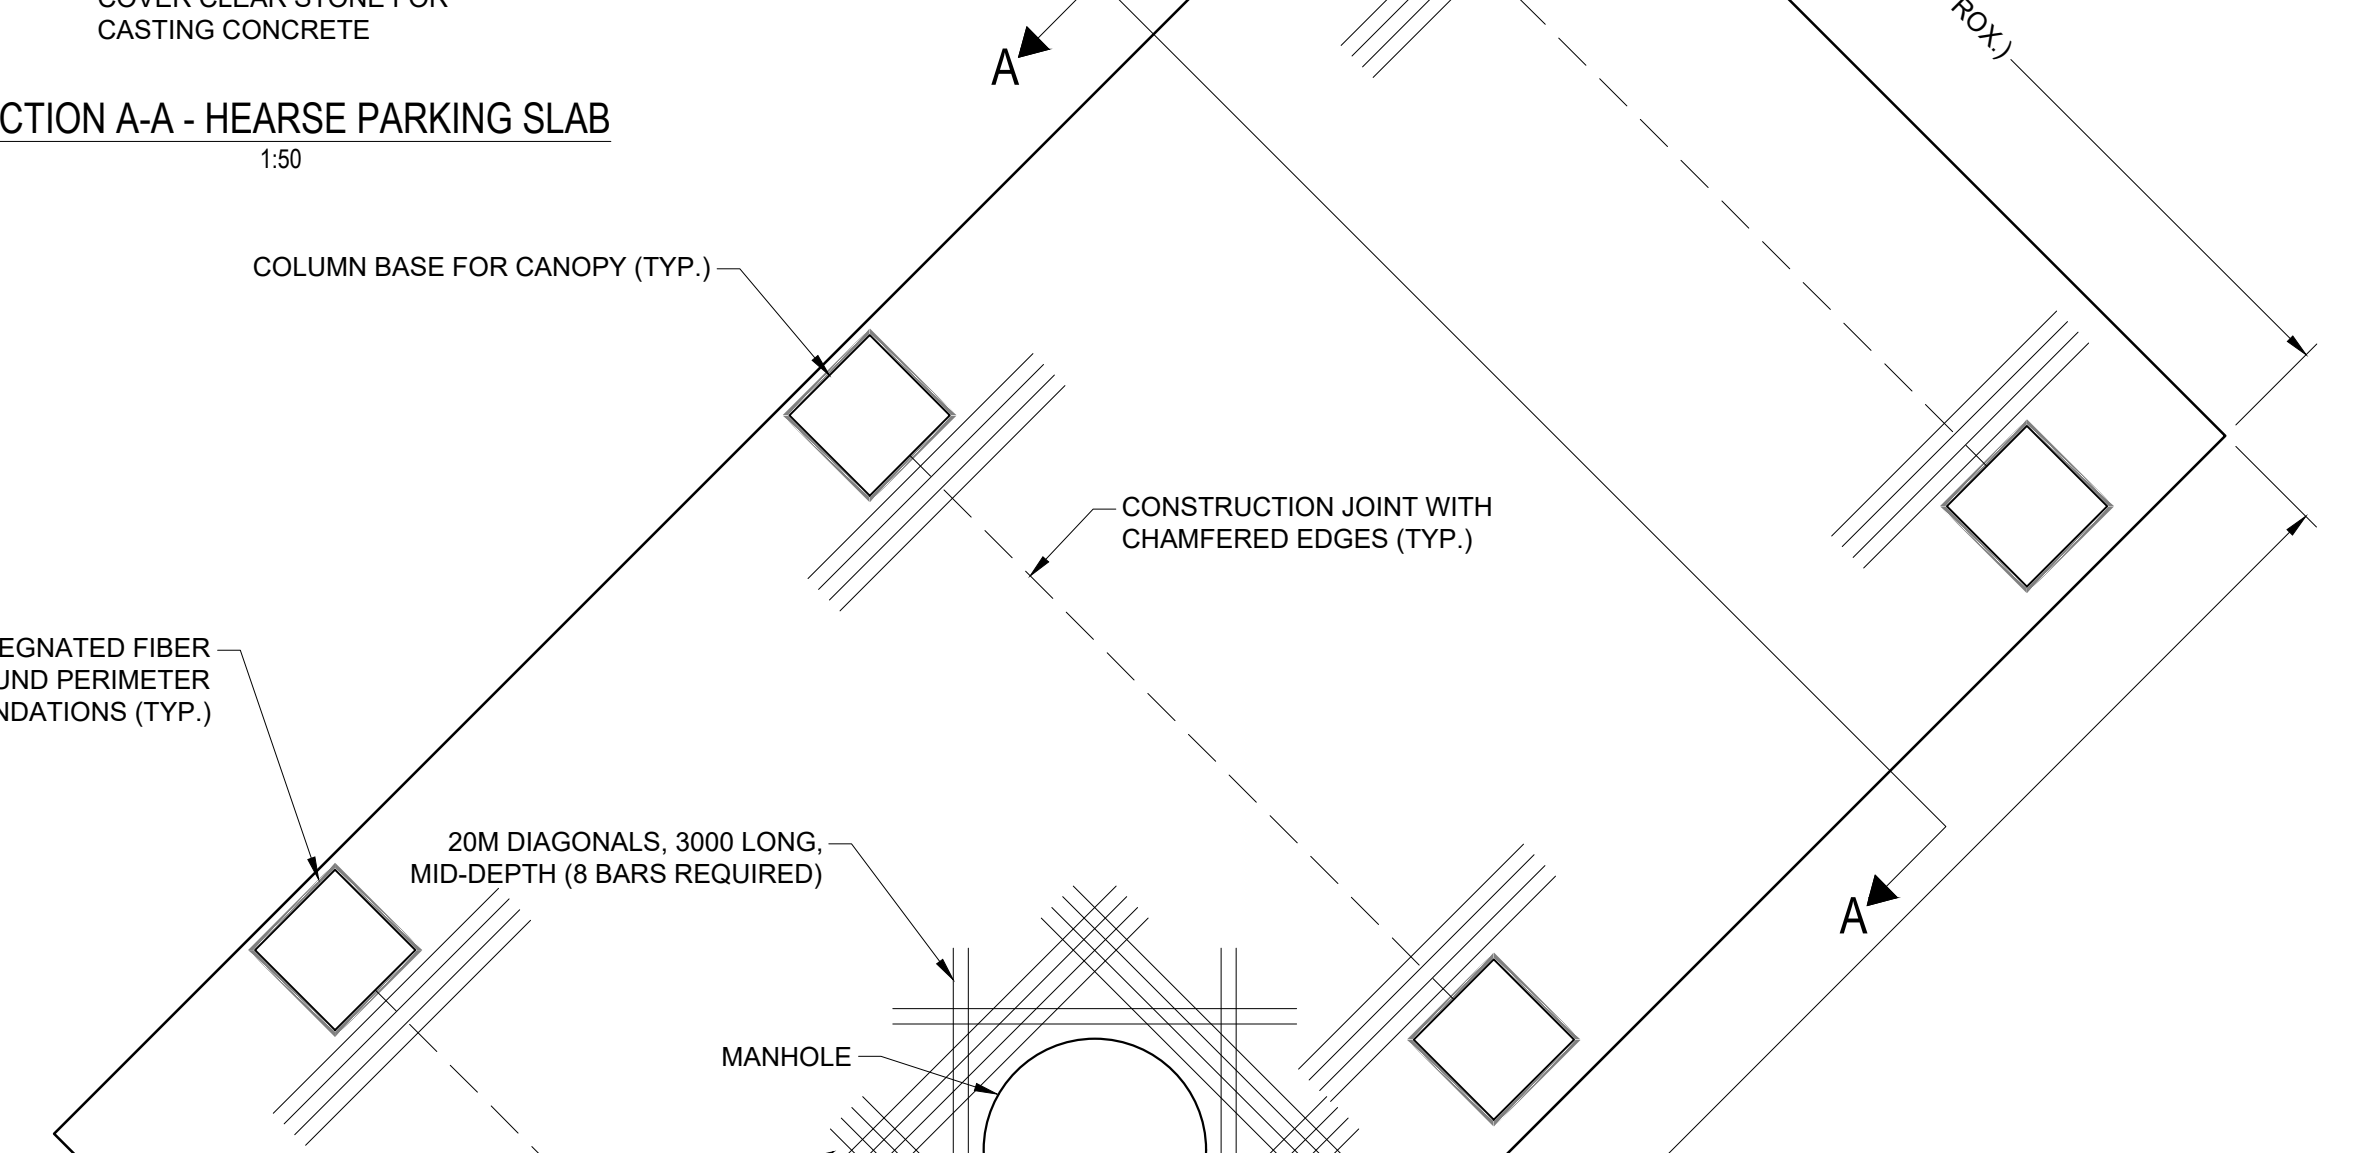
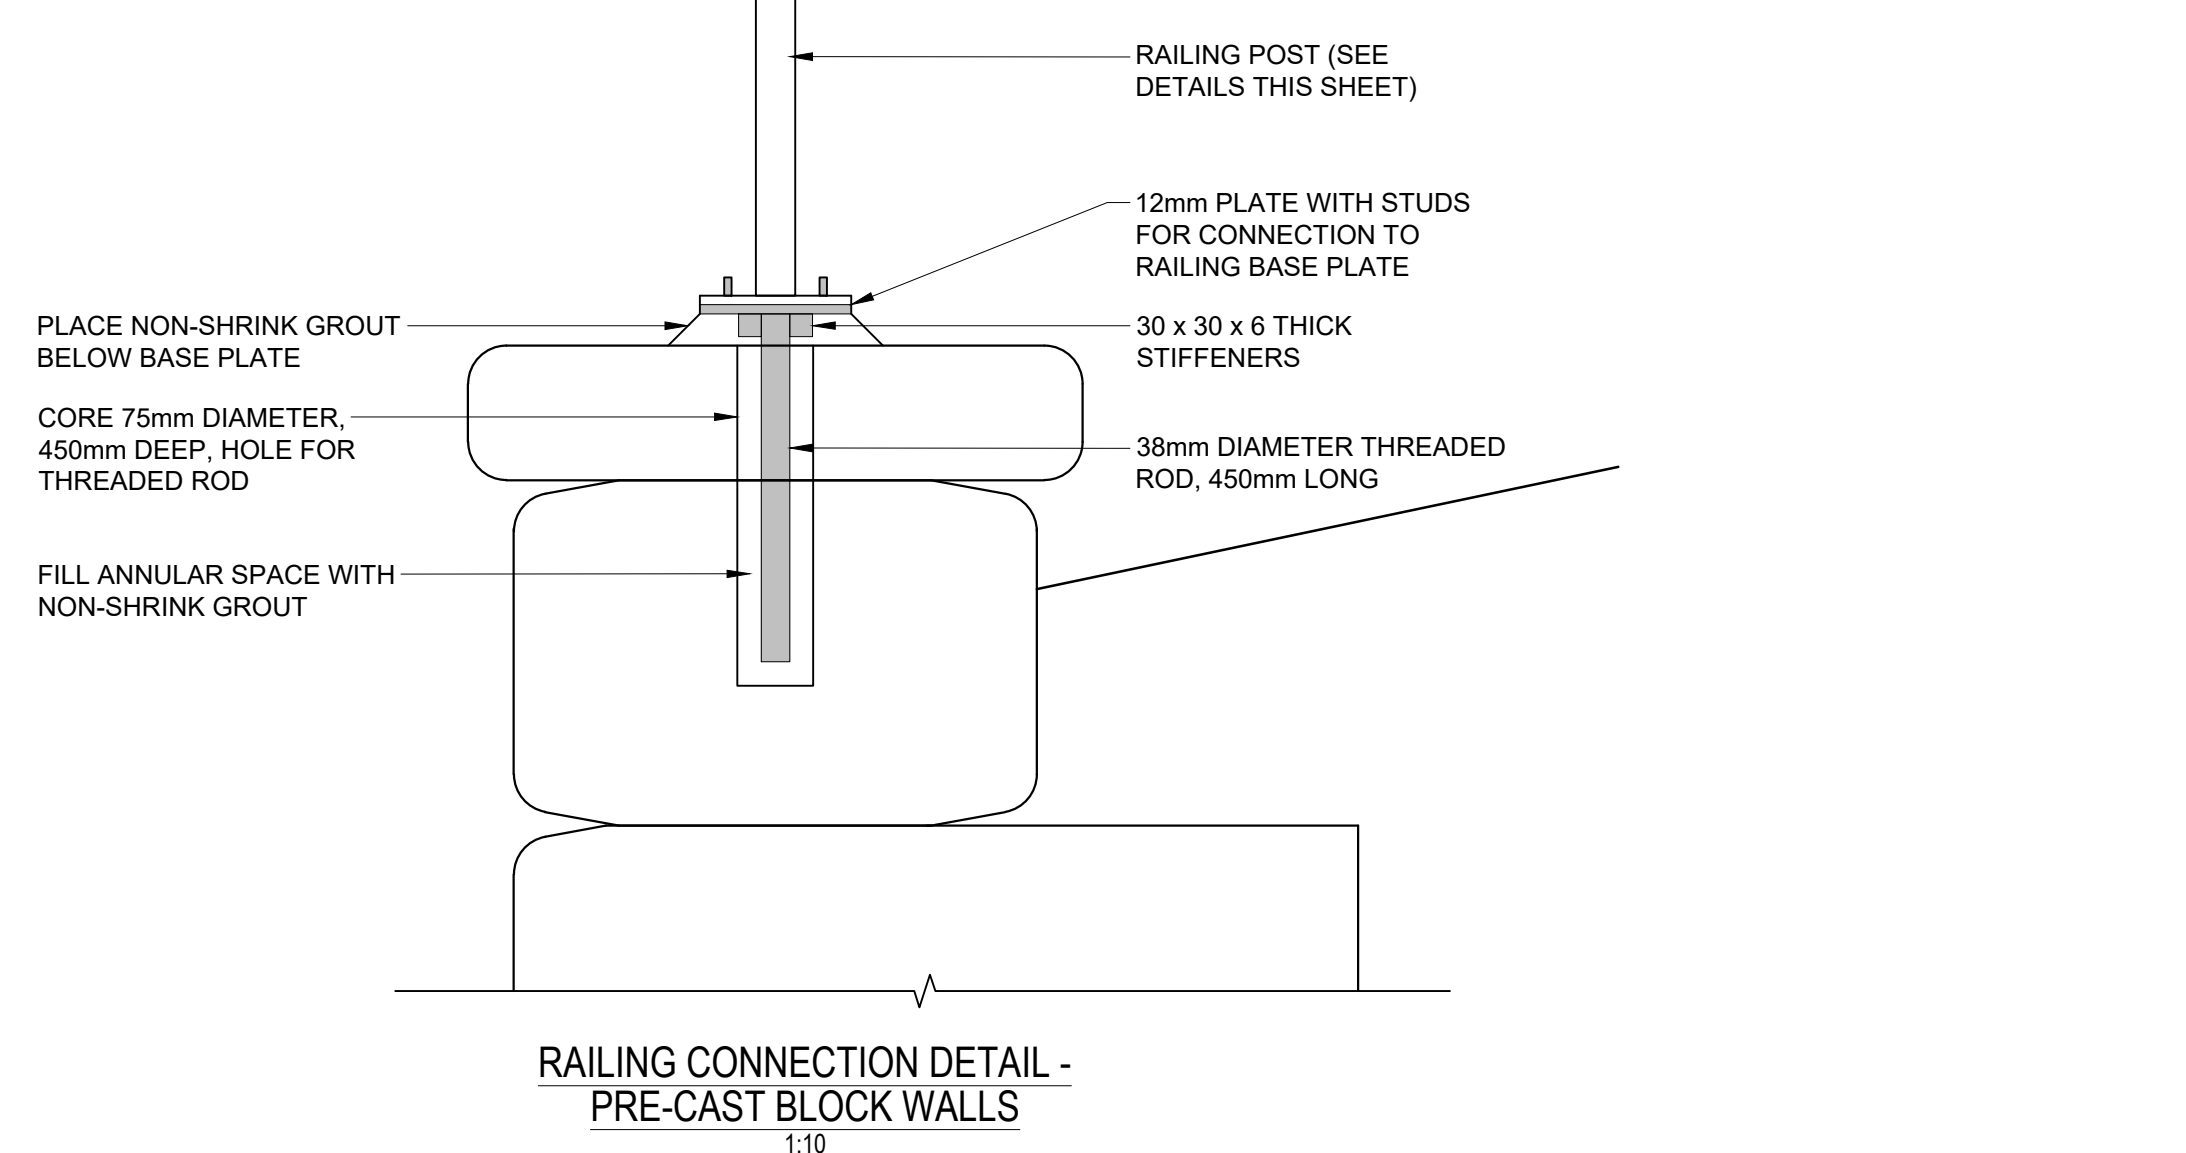
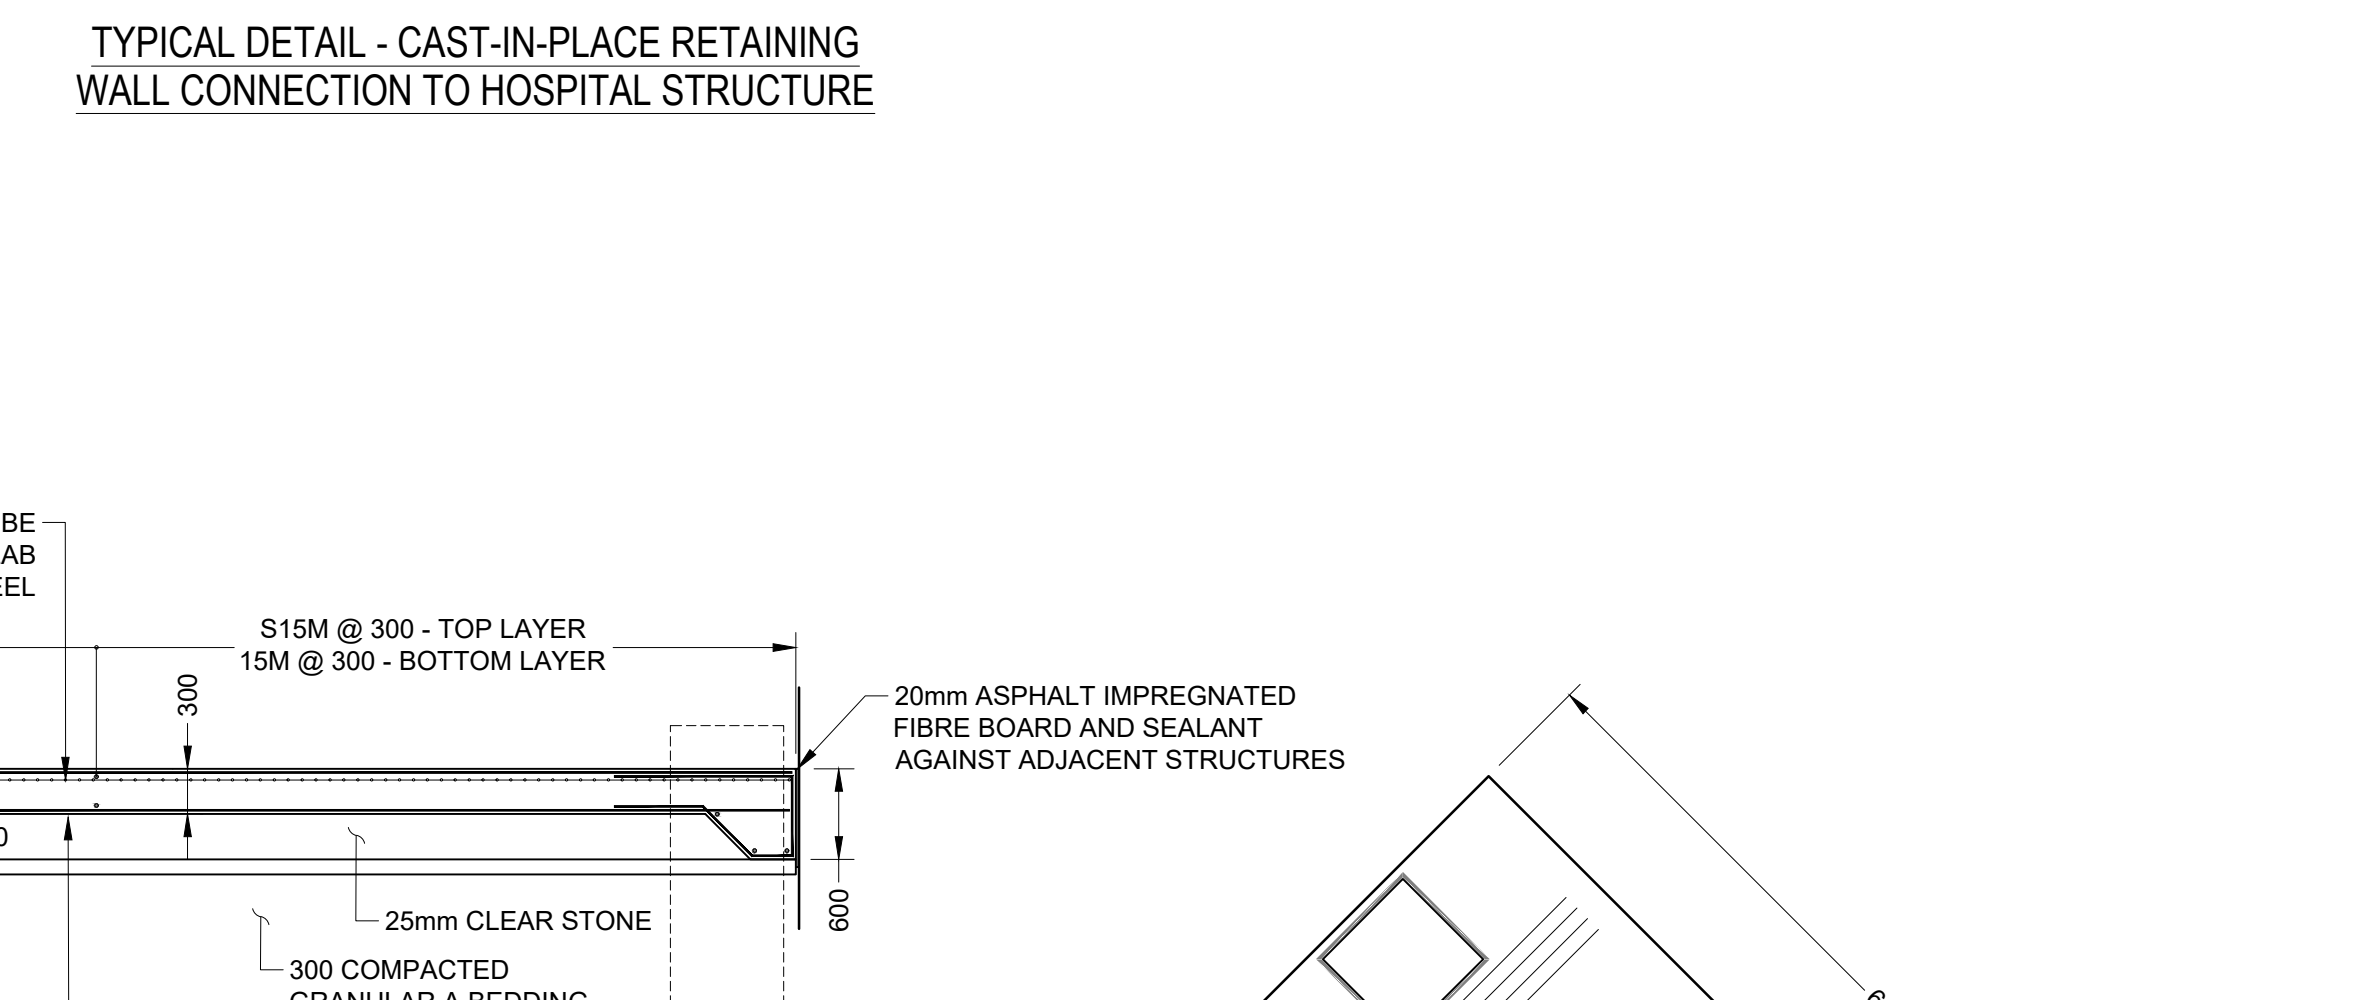
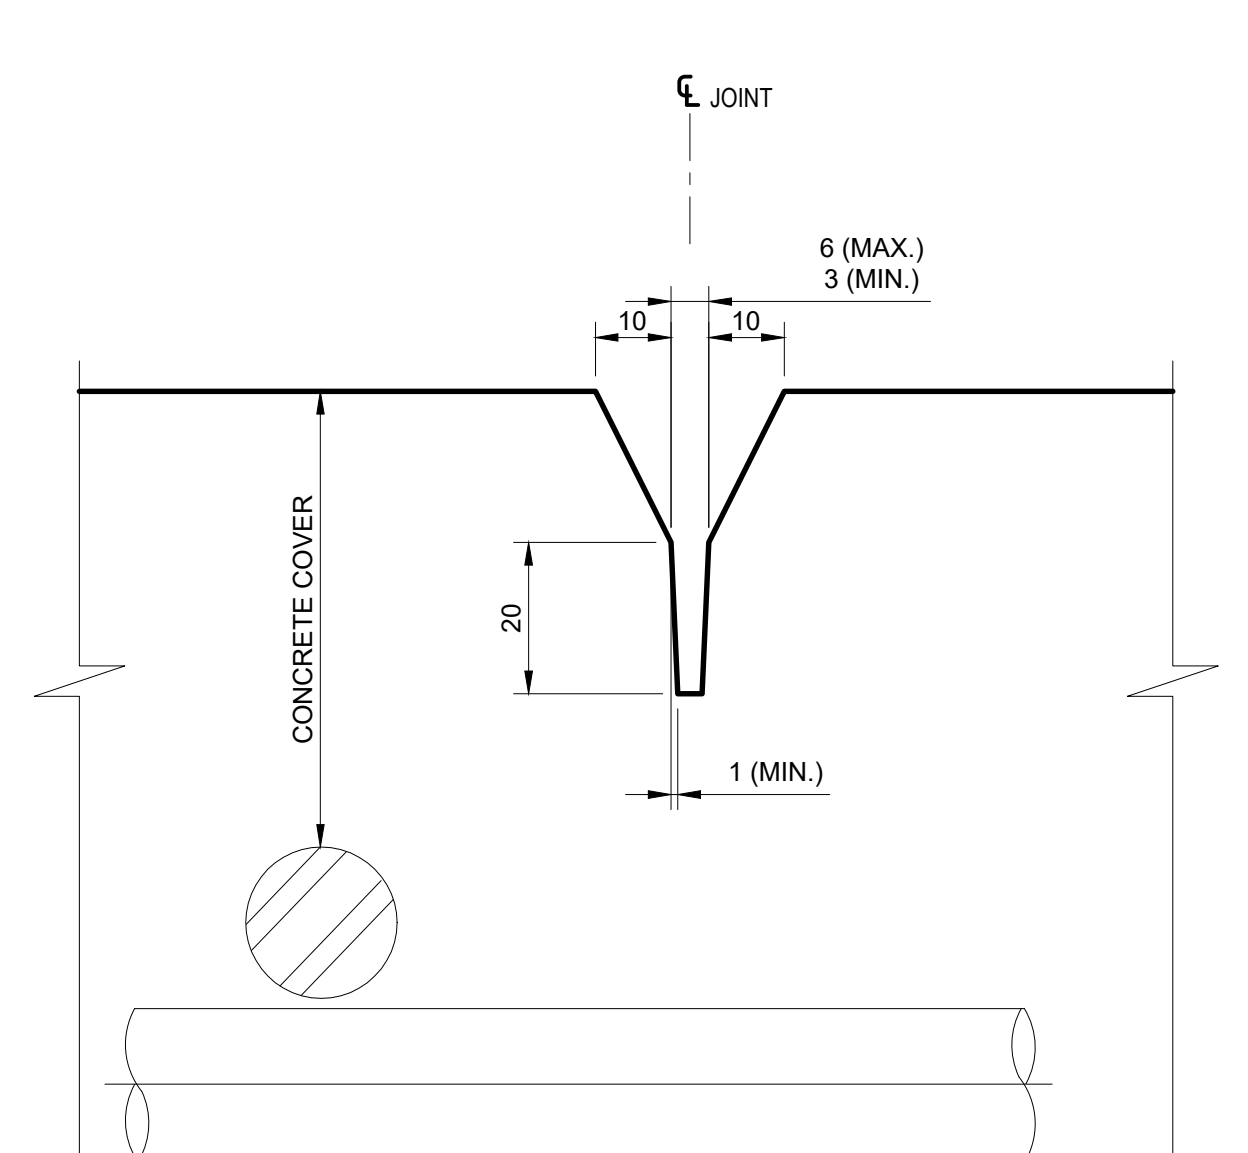
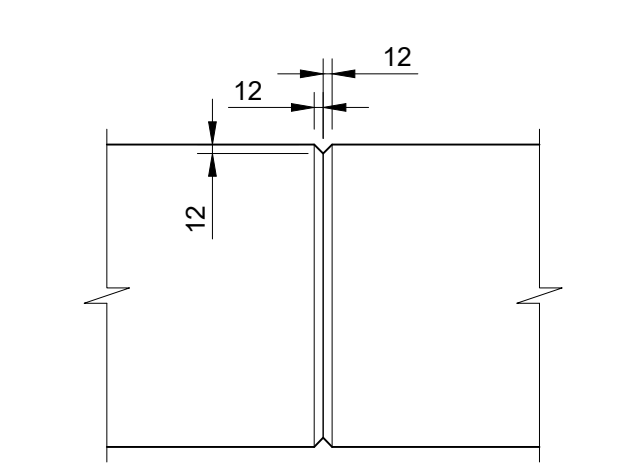
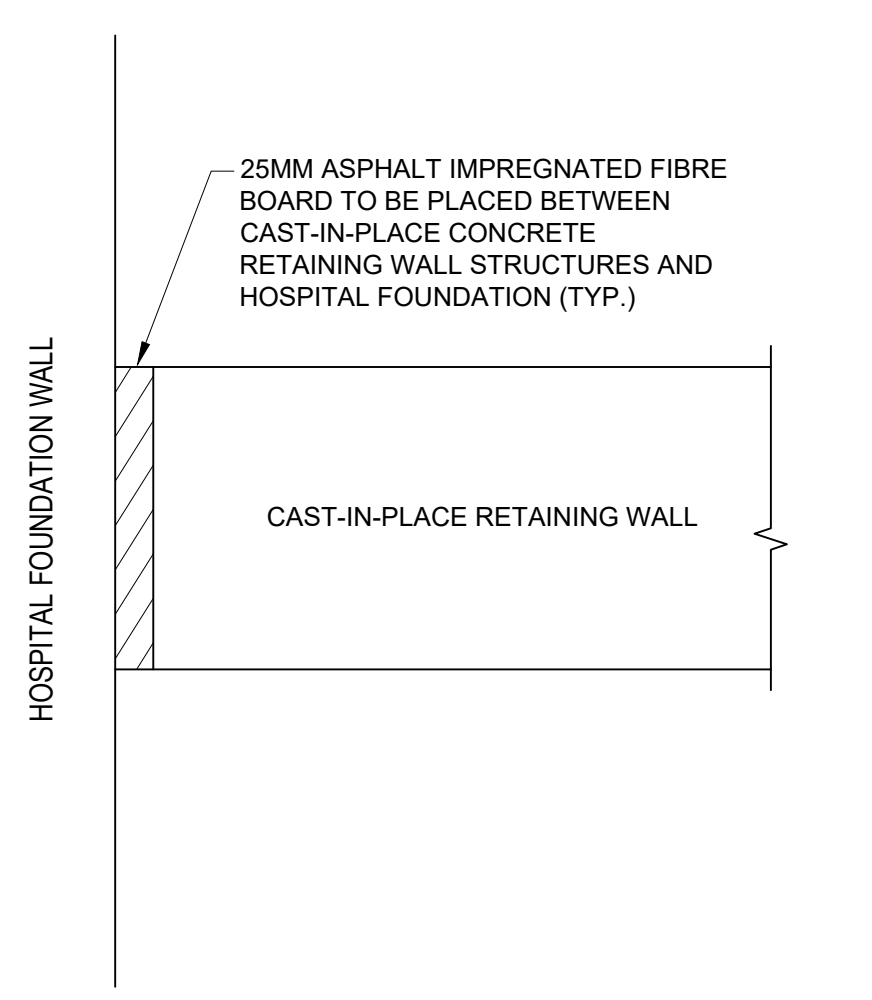


PLOT DATE: 2024-02-28 1:15 PM

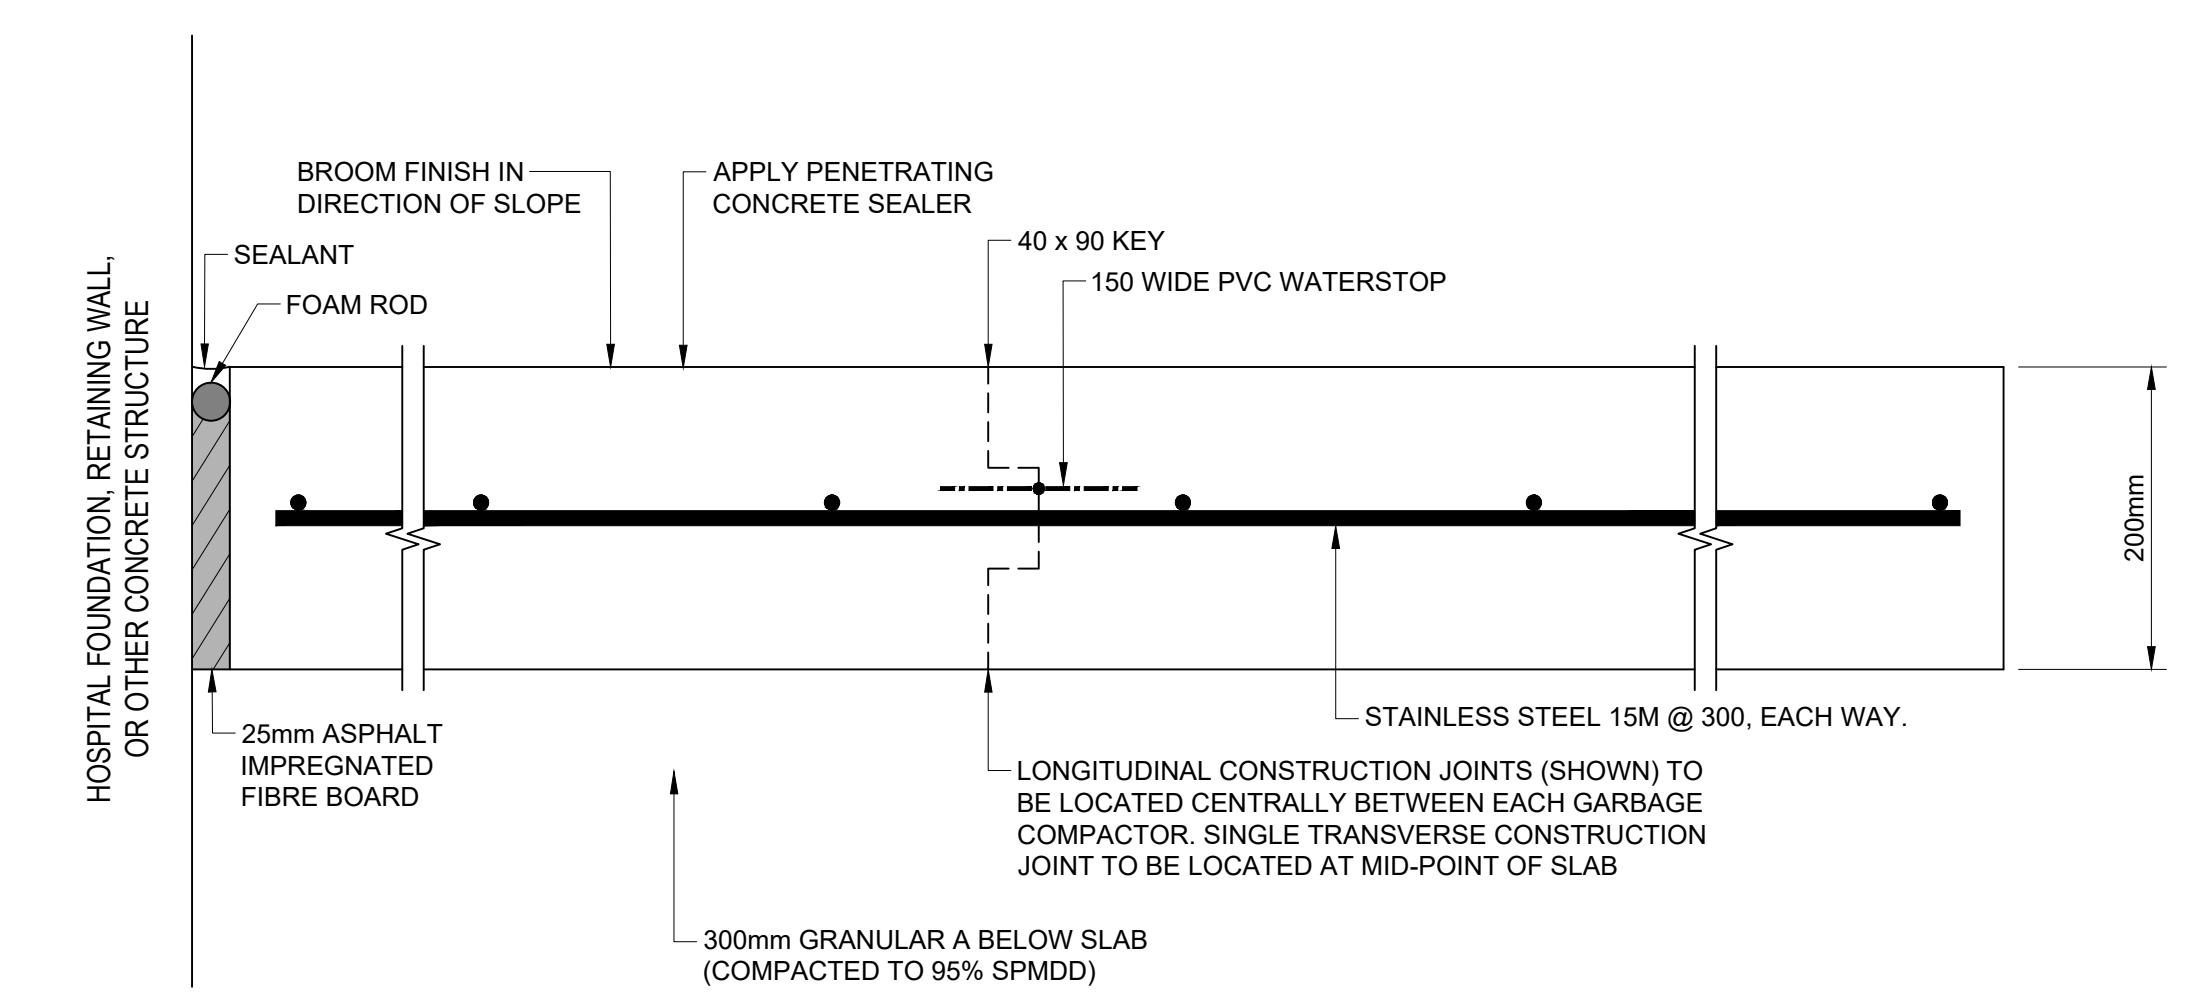

PROJECT
THE OTTAWA HOSPITAL
NEW CAMPUS
DEVELOPMENT -
PHASE 4 MAIN HOSPITAL
BUILDING
900 CARLING AVE, OTTAWA, ONTARIO

CLIENT
The Ottawa Hospital | Hôpital d'Ottawa

Infrastructure Ontario

PCL CONSTRUCTION | **EllisDon**

CLIENT PROJECT NO. 1070002

KEY PLAN
TRUE NORTH | PROJECT NORTH

REVISIONS

04	SITE PLAN CONTROL RESUBMISSION	2026-01-12
03	90% CD SUBMISSION	2025-09-19
02	SITE PLAN CONTROL RESUBMISSION	2025-06-05
01	65% CD SUBMISSION	2025-06-05
NO	ISSUED	DATE

DRAWING STATUS
NOT FOR CONSTRUCTION

DISCREPANCIES MUST BE REPORTED IMMEDIATELY TO THE ARCHITECT BEFORE PROCEEDING. ONLY FIGURED DIMENSIONS ARE TO BE USED. CONTRACTORS MUST CHECK ALL DIMENSIONS ON SITE. THIS DRAWING IS PROTECTED BY COPYRIGHT. ALL DIMENSIONS ARE SHOWN IN METRIC.

AUTLOG
wsp

PROJECT TEAM
DESIGN BUILDER: POLICED, A JOINT VENTURE
ARCHITECTURAL: PARKIN ARCHITECTS LIMITED, JODAN LAMARIE PRATTE ARCHITECTS, ADAMSON ASSOCIATES ARCHITECTS, 888 ARCHITECTS OTTAWA INC.
STRUCTURAL: STERNECHON ENGINEERING LTD., BOUYALLETTE PARISZAL INC.
MECHANICAL: H1 ANGLUS & ASSOCIATES LTD., CROSBY ENGINEERING LTD.
ELECTRICAL: MULVEY & BANANI INTERNATIONAL INC.
CIVIL: WSP CANADA INC.
LANDSCAPE: VERDEDESIGN INC., PFP LANDSCAPE ARCHITECTURE
BUILDING CODE: UMD BUILDING CODE CONSULTANTS LTD.

AUTHOR PROJECT NO. CA0027758.0-51

STAMP

DRAWING TITLE
DETAILS
CAST-IN-PLACE WALLS

DRAWN K. MARTIN | **CHECKED** M. THOM
SCALE AT 47' = 6" | **DATE** 2024-02-28
AS SHOWN

GRAPHIC SCALE
1:250

DRAWING NO. C7-408 | **REV. NO.** 04

PLOT DATE: 2024-02-28 1:15 PM