
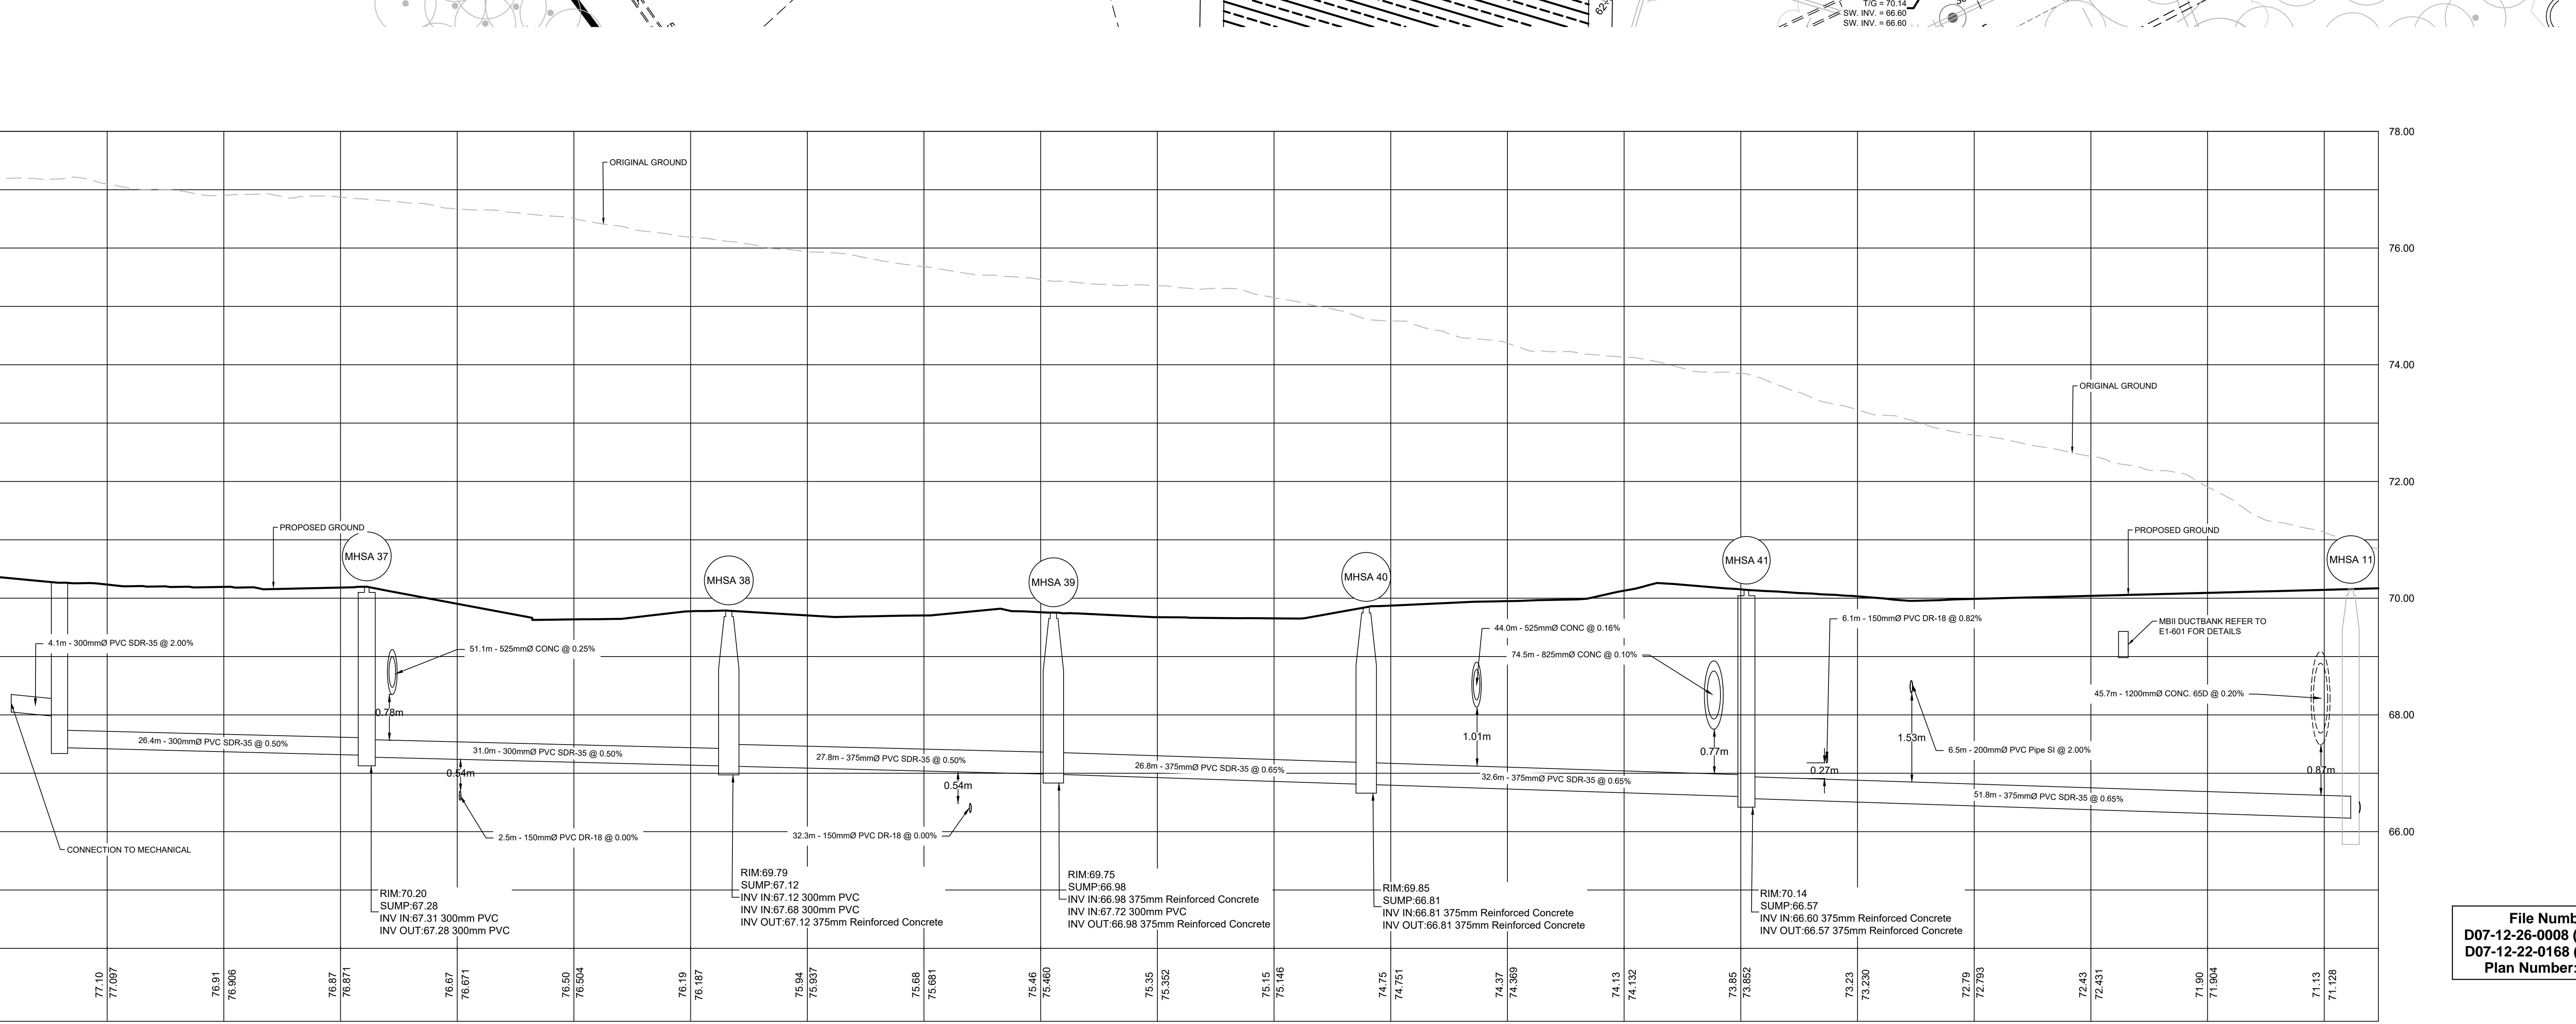
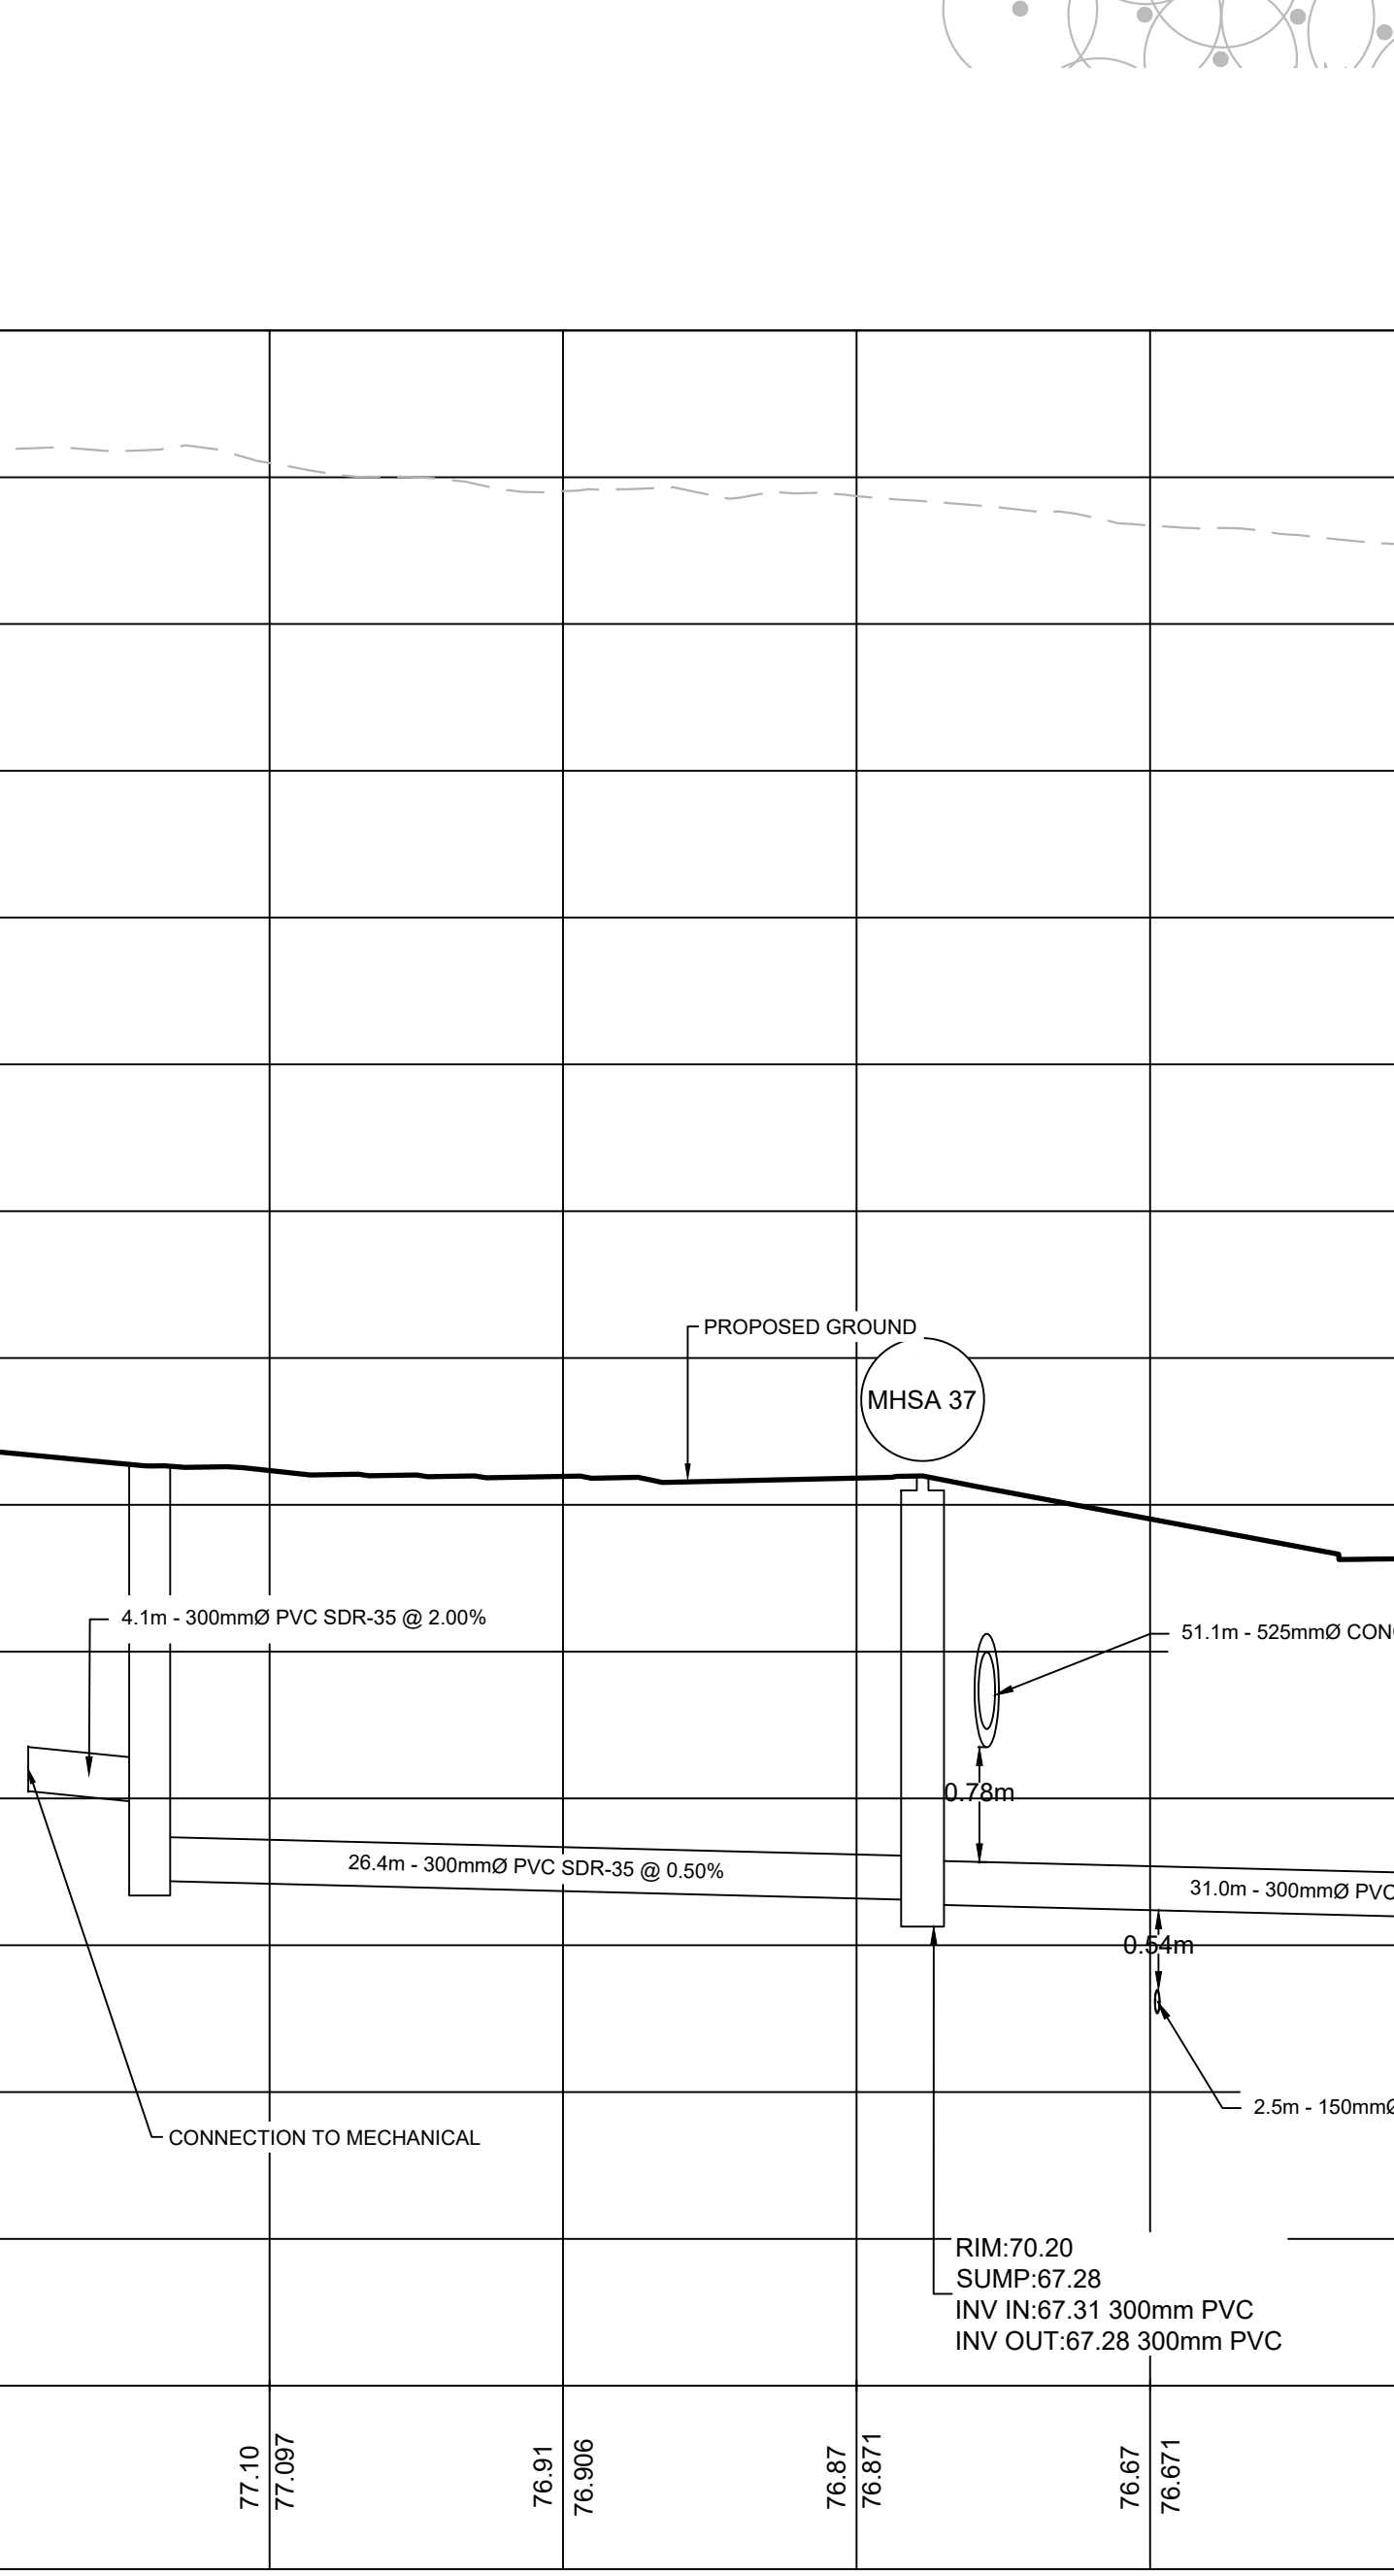
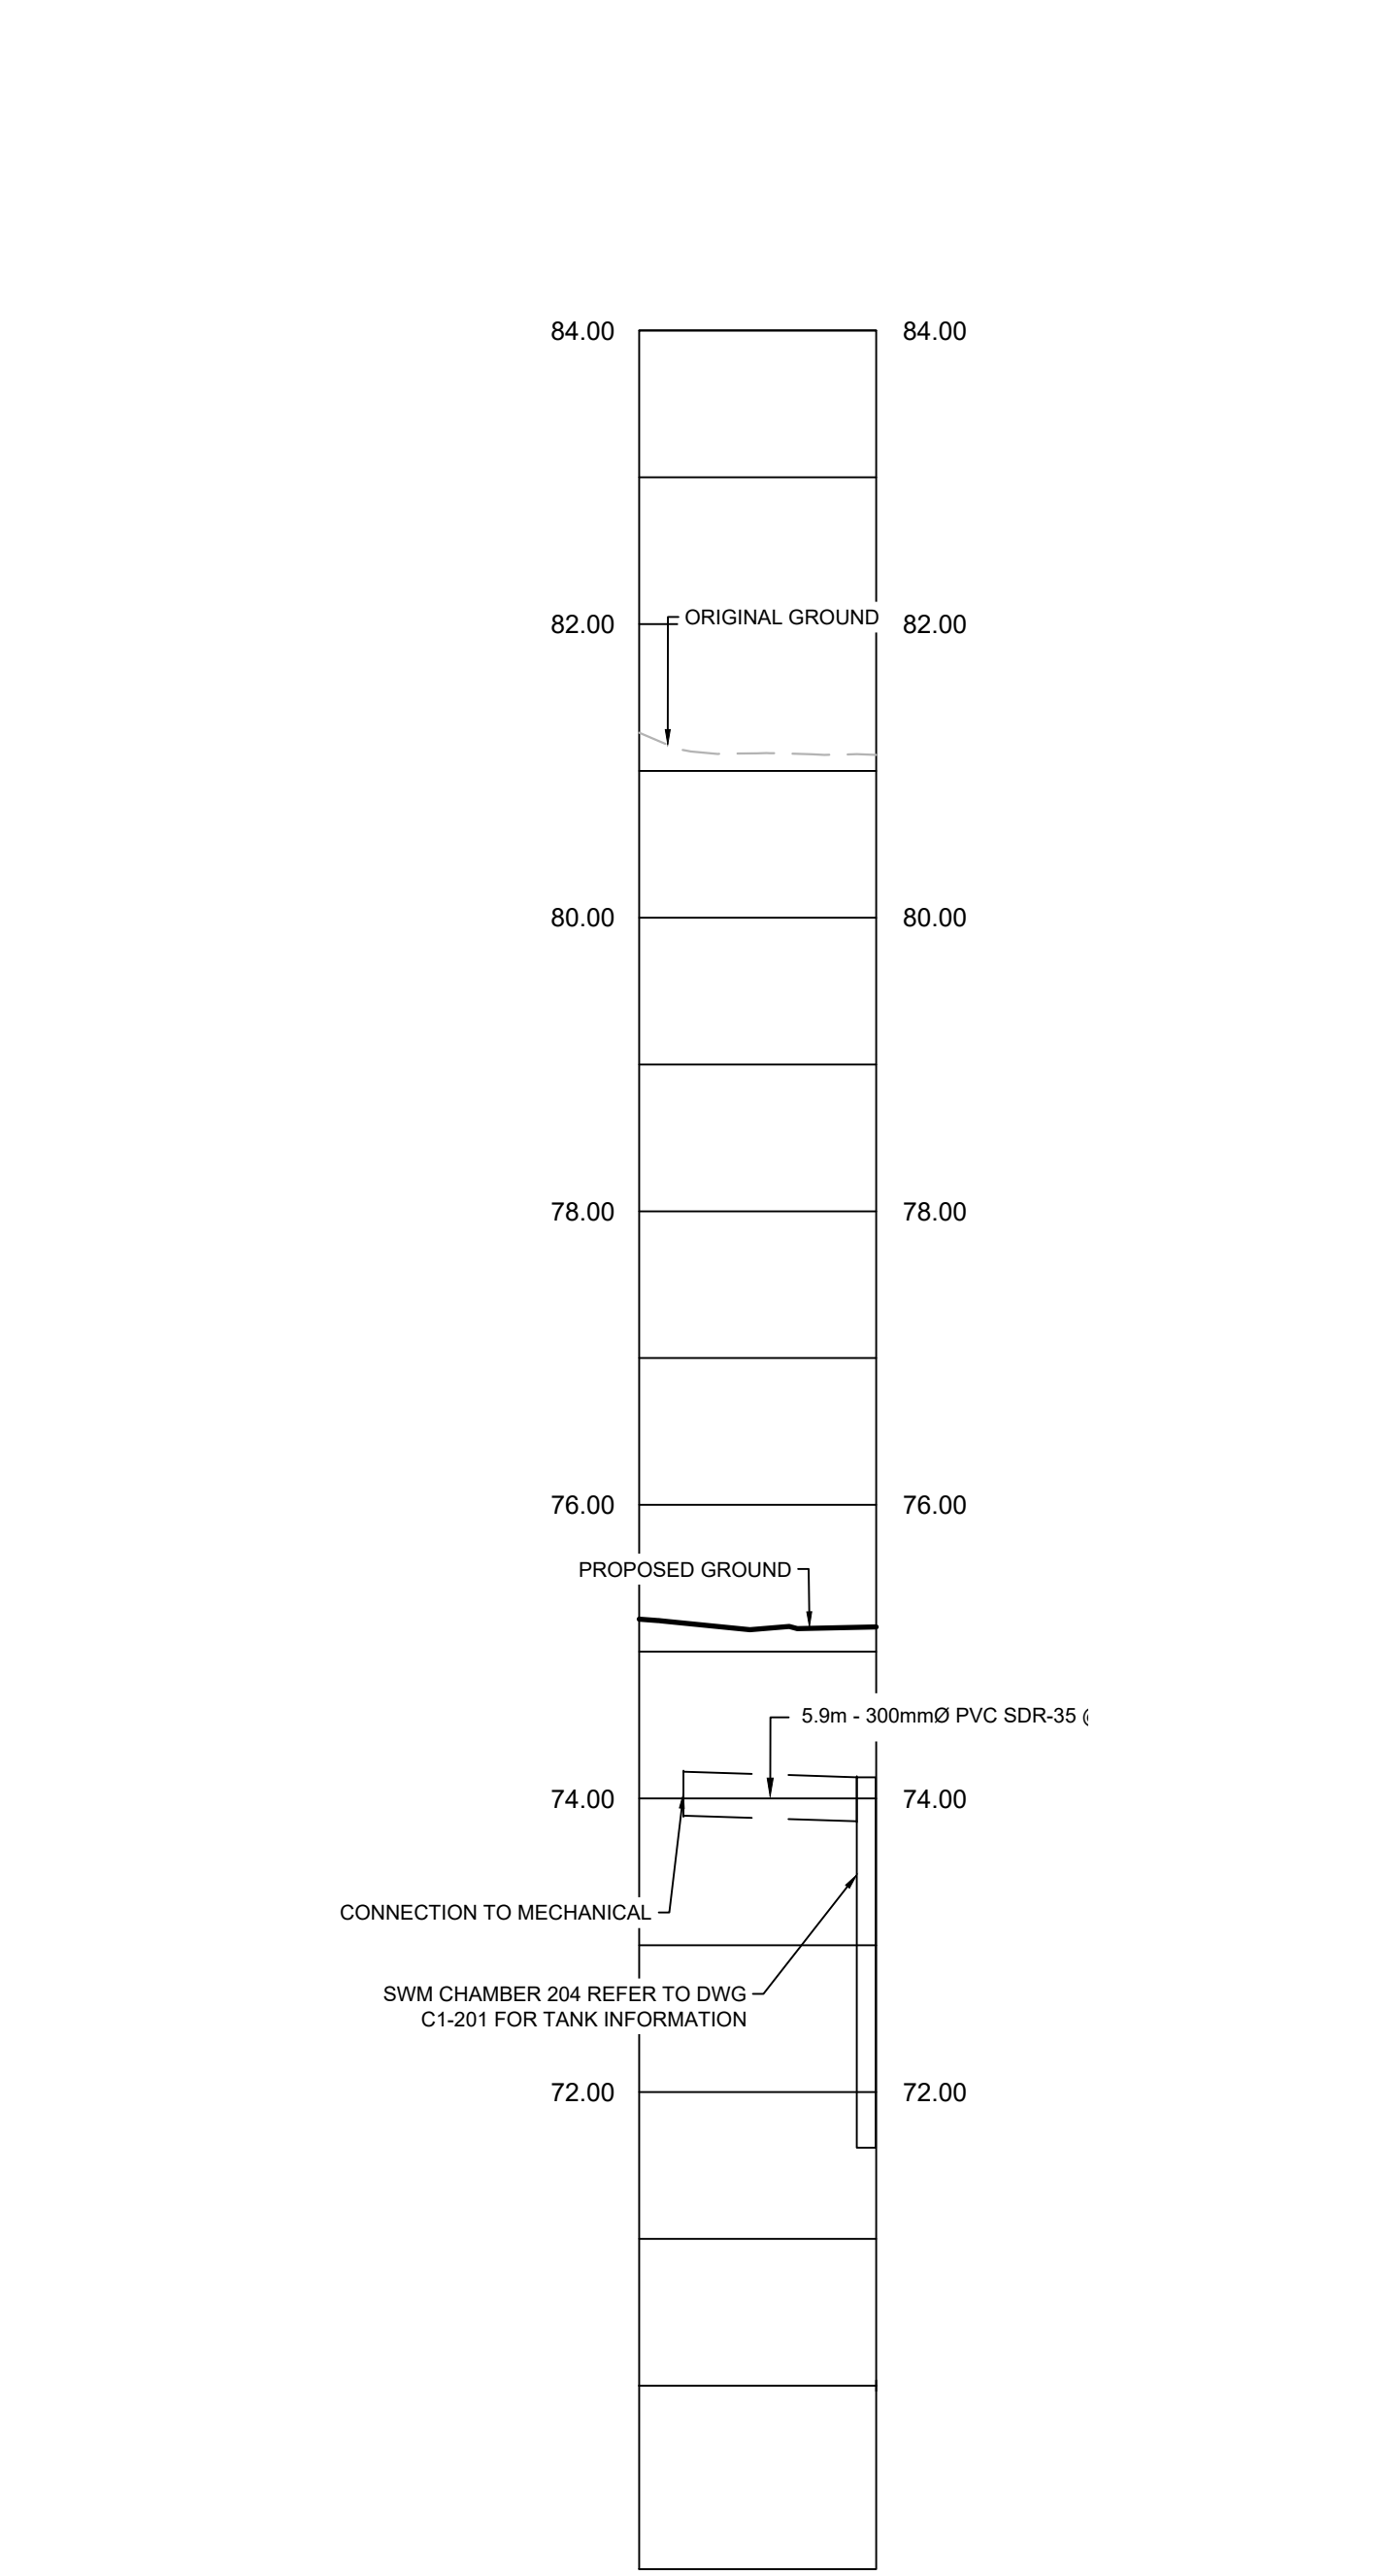
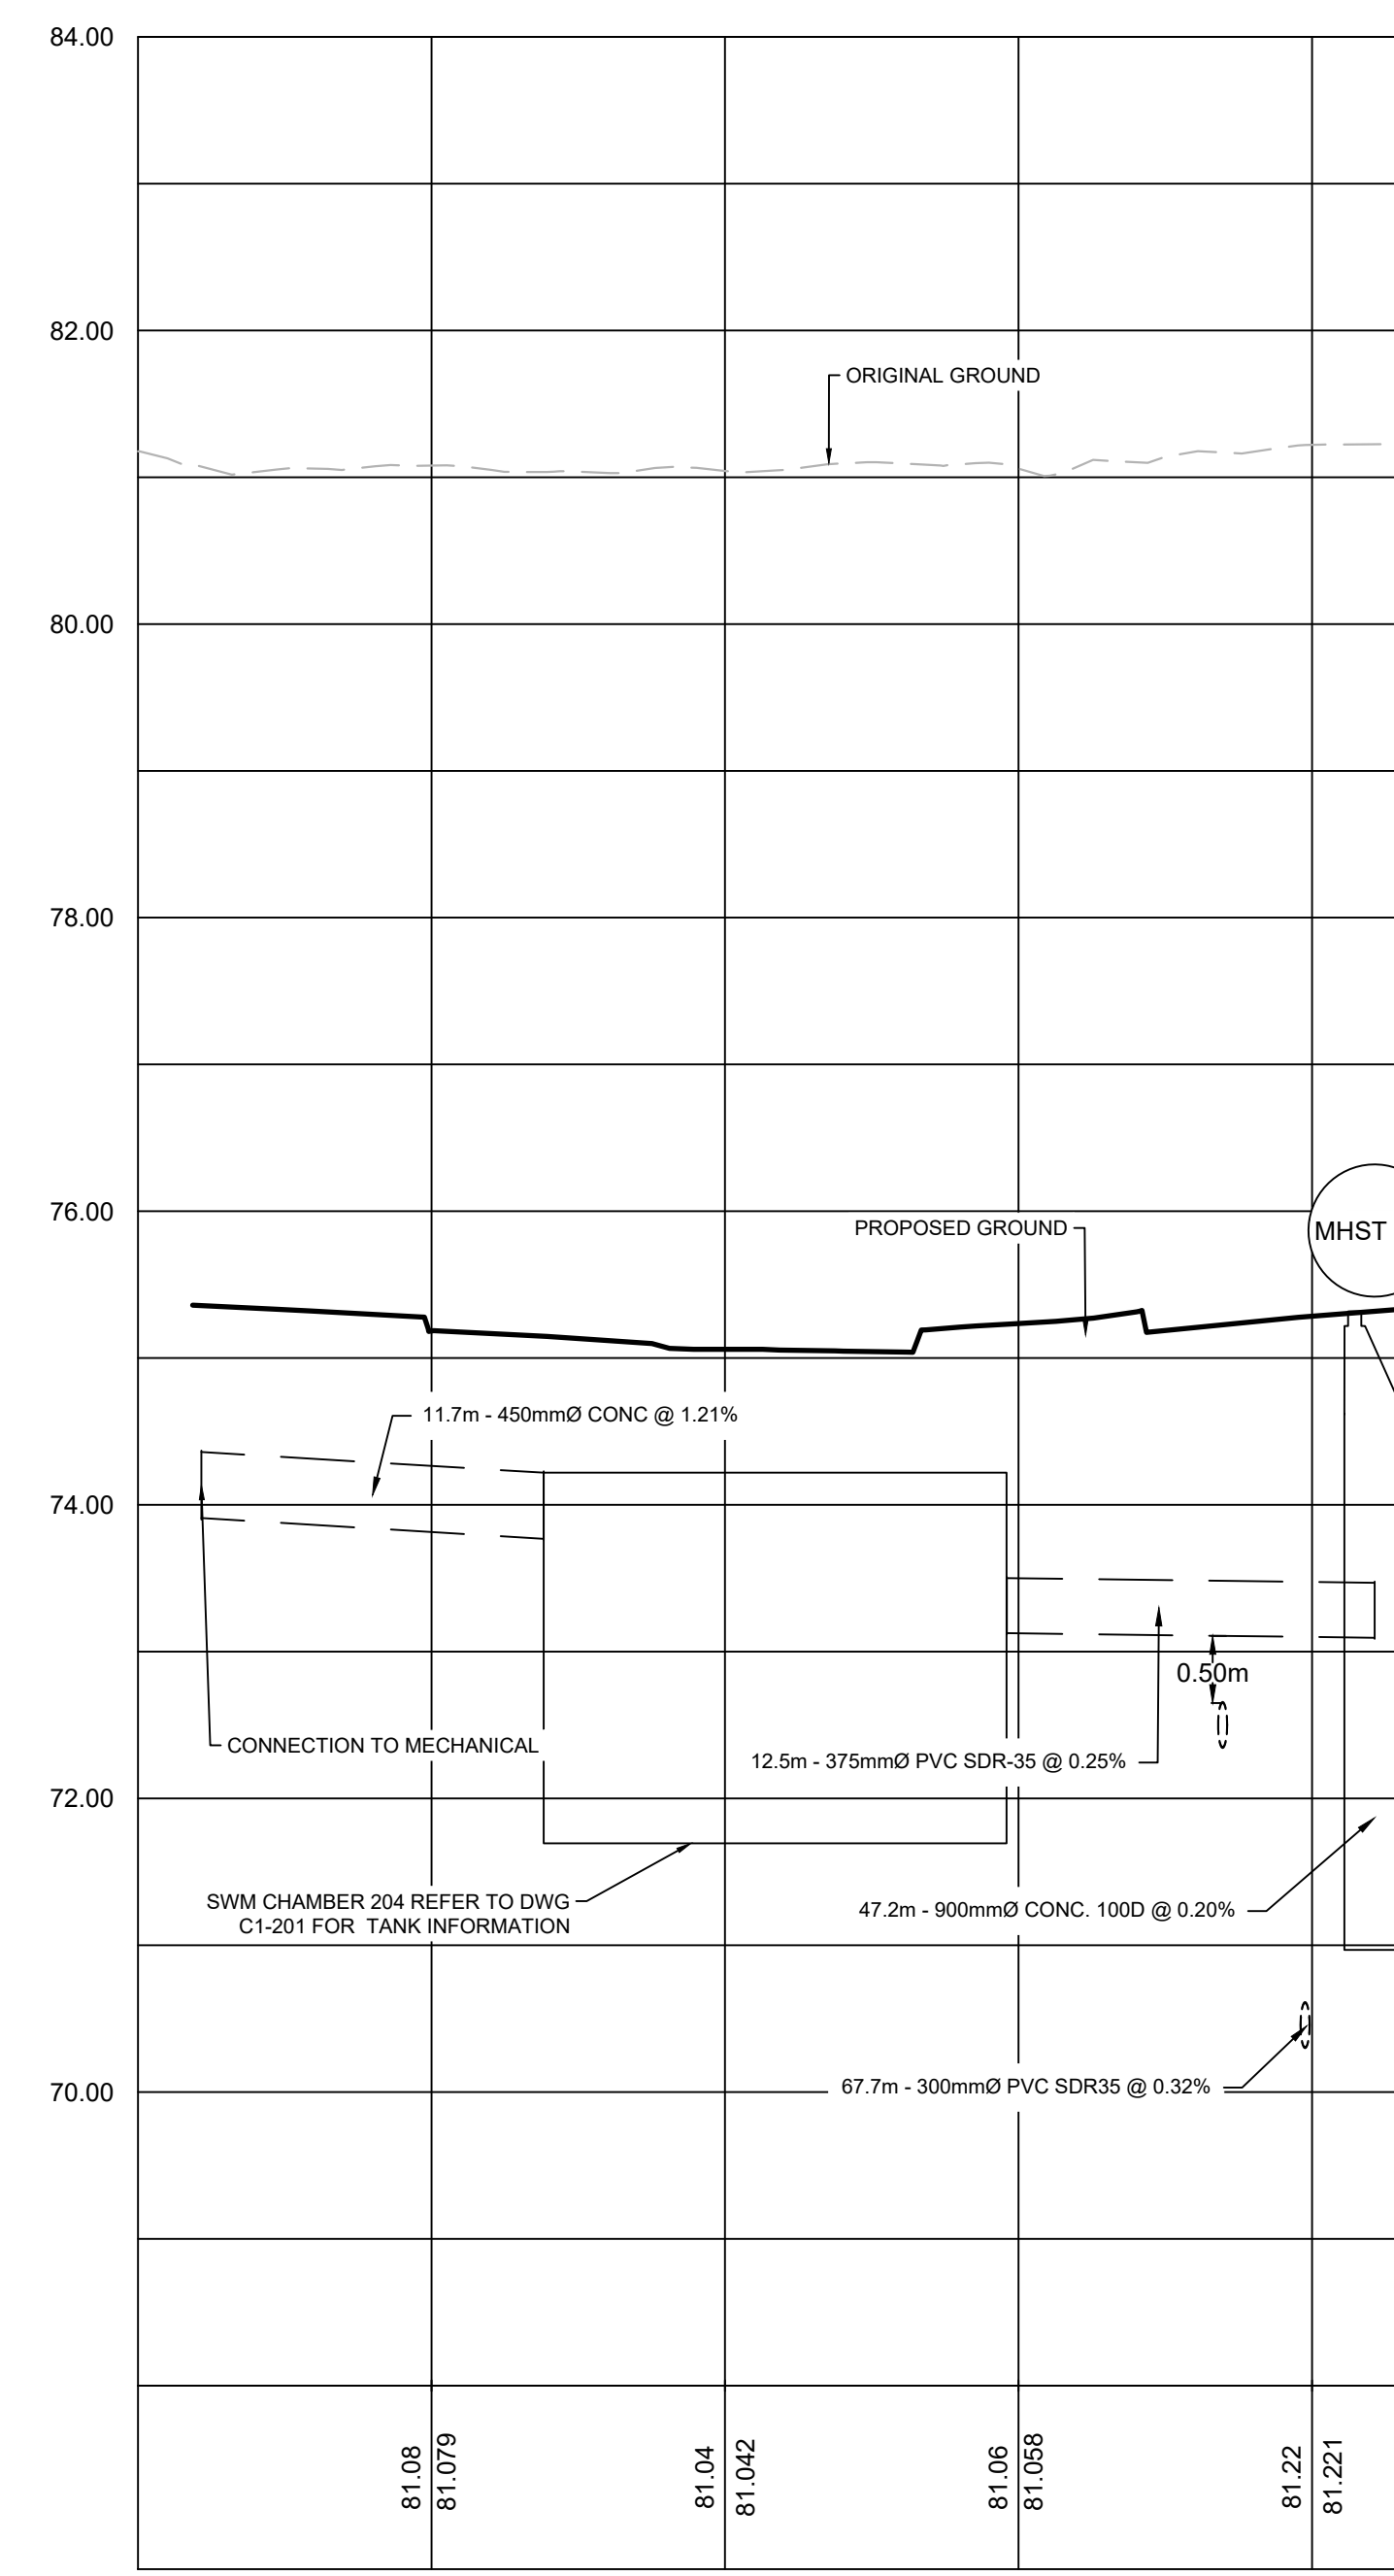
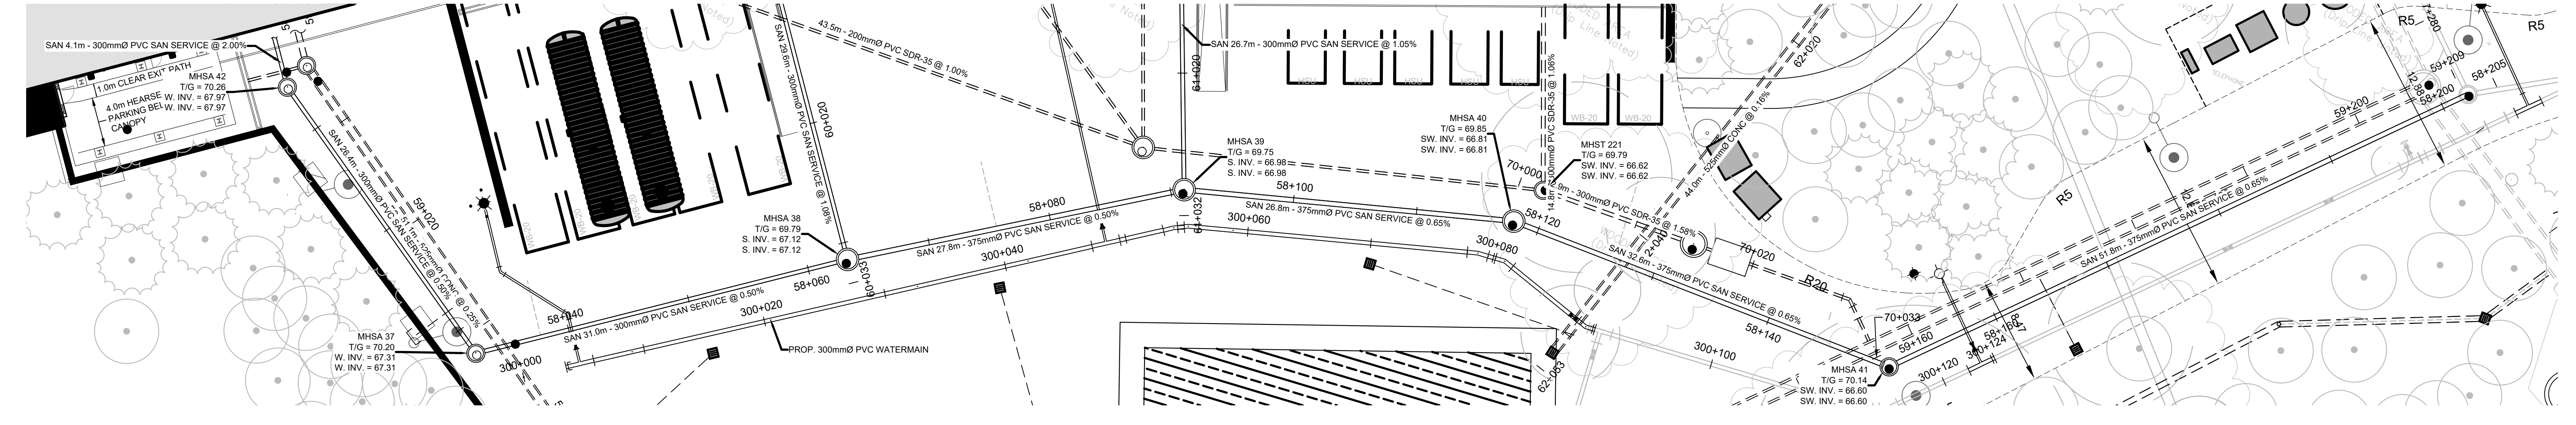
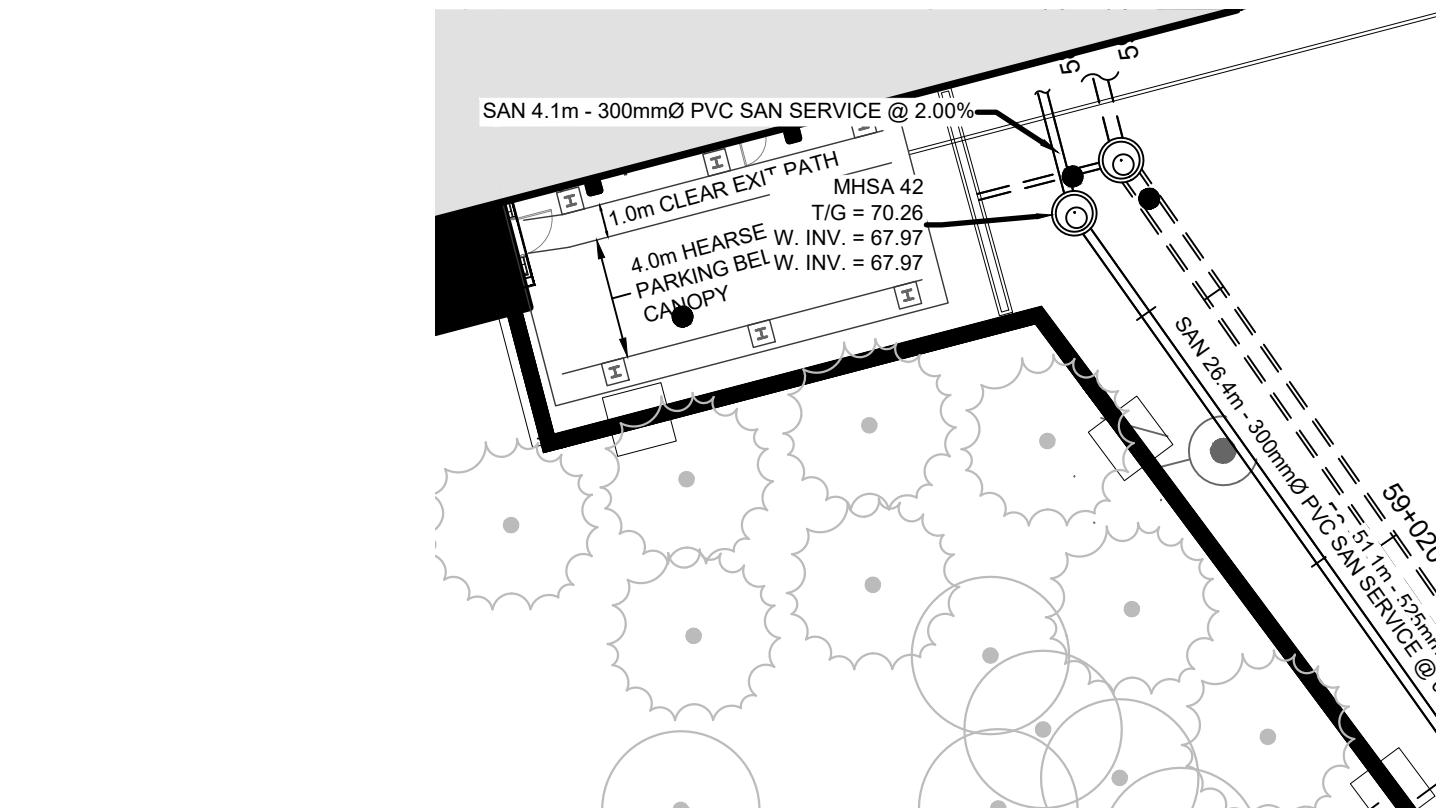
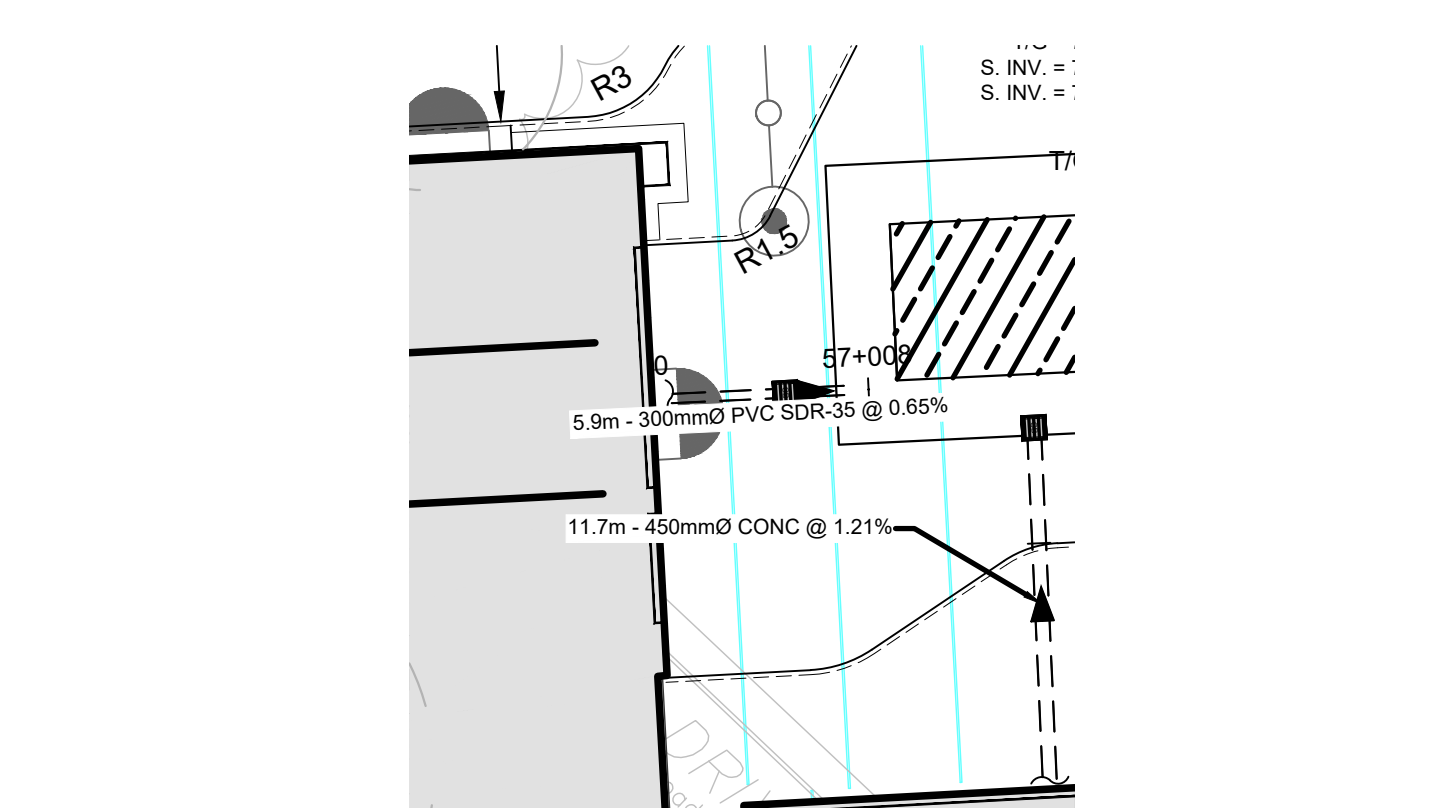
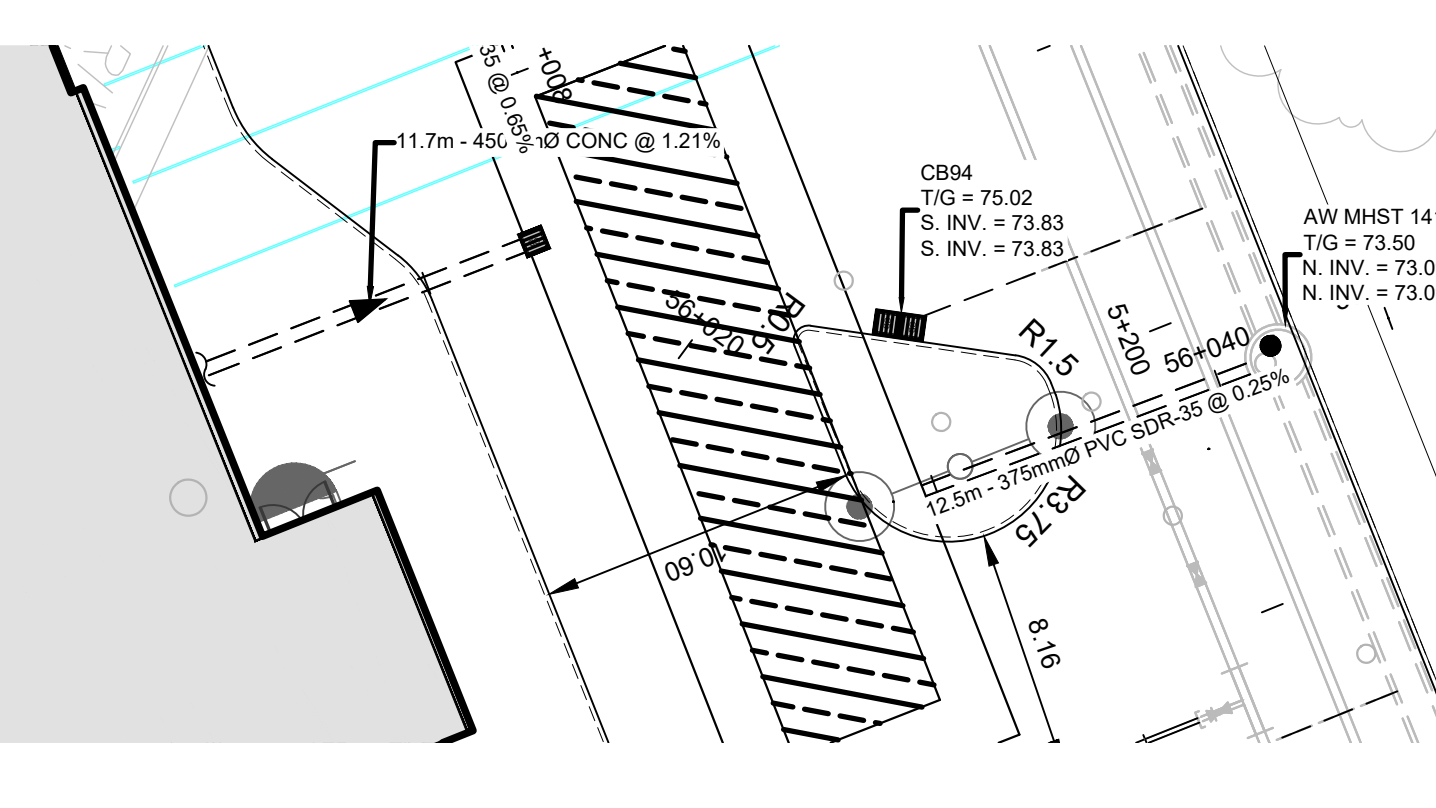
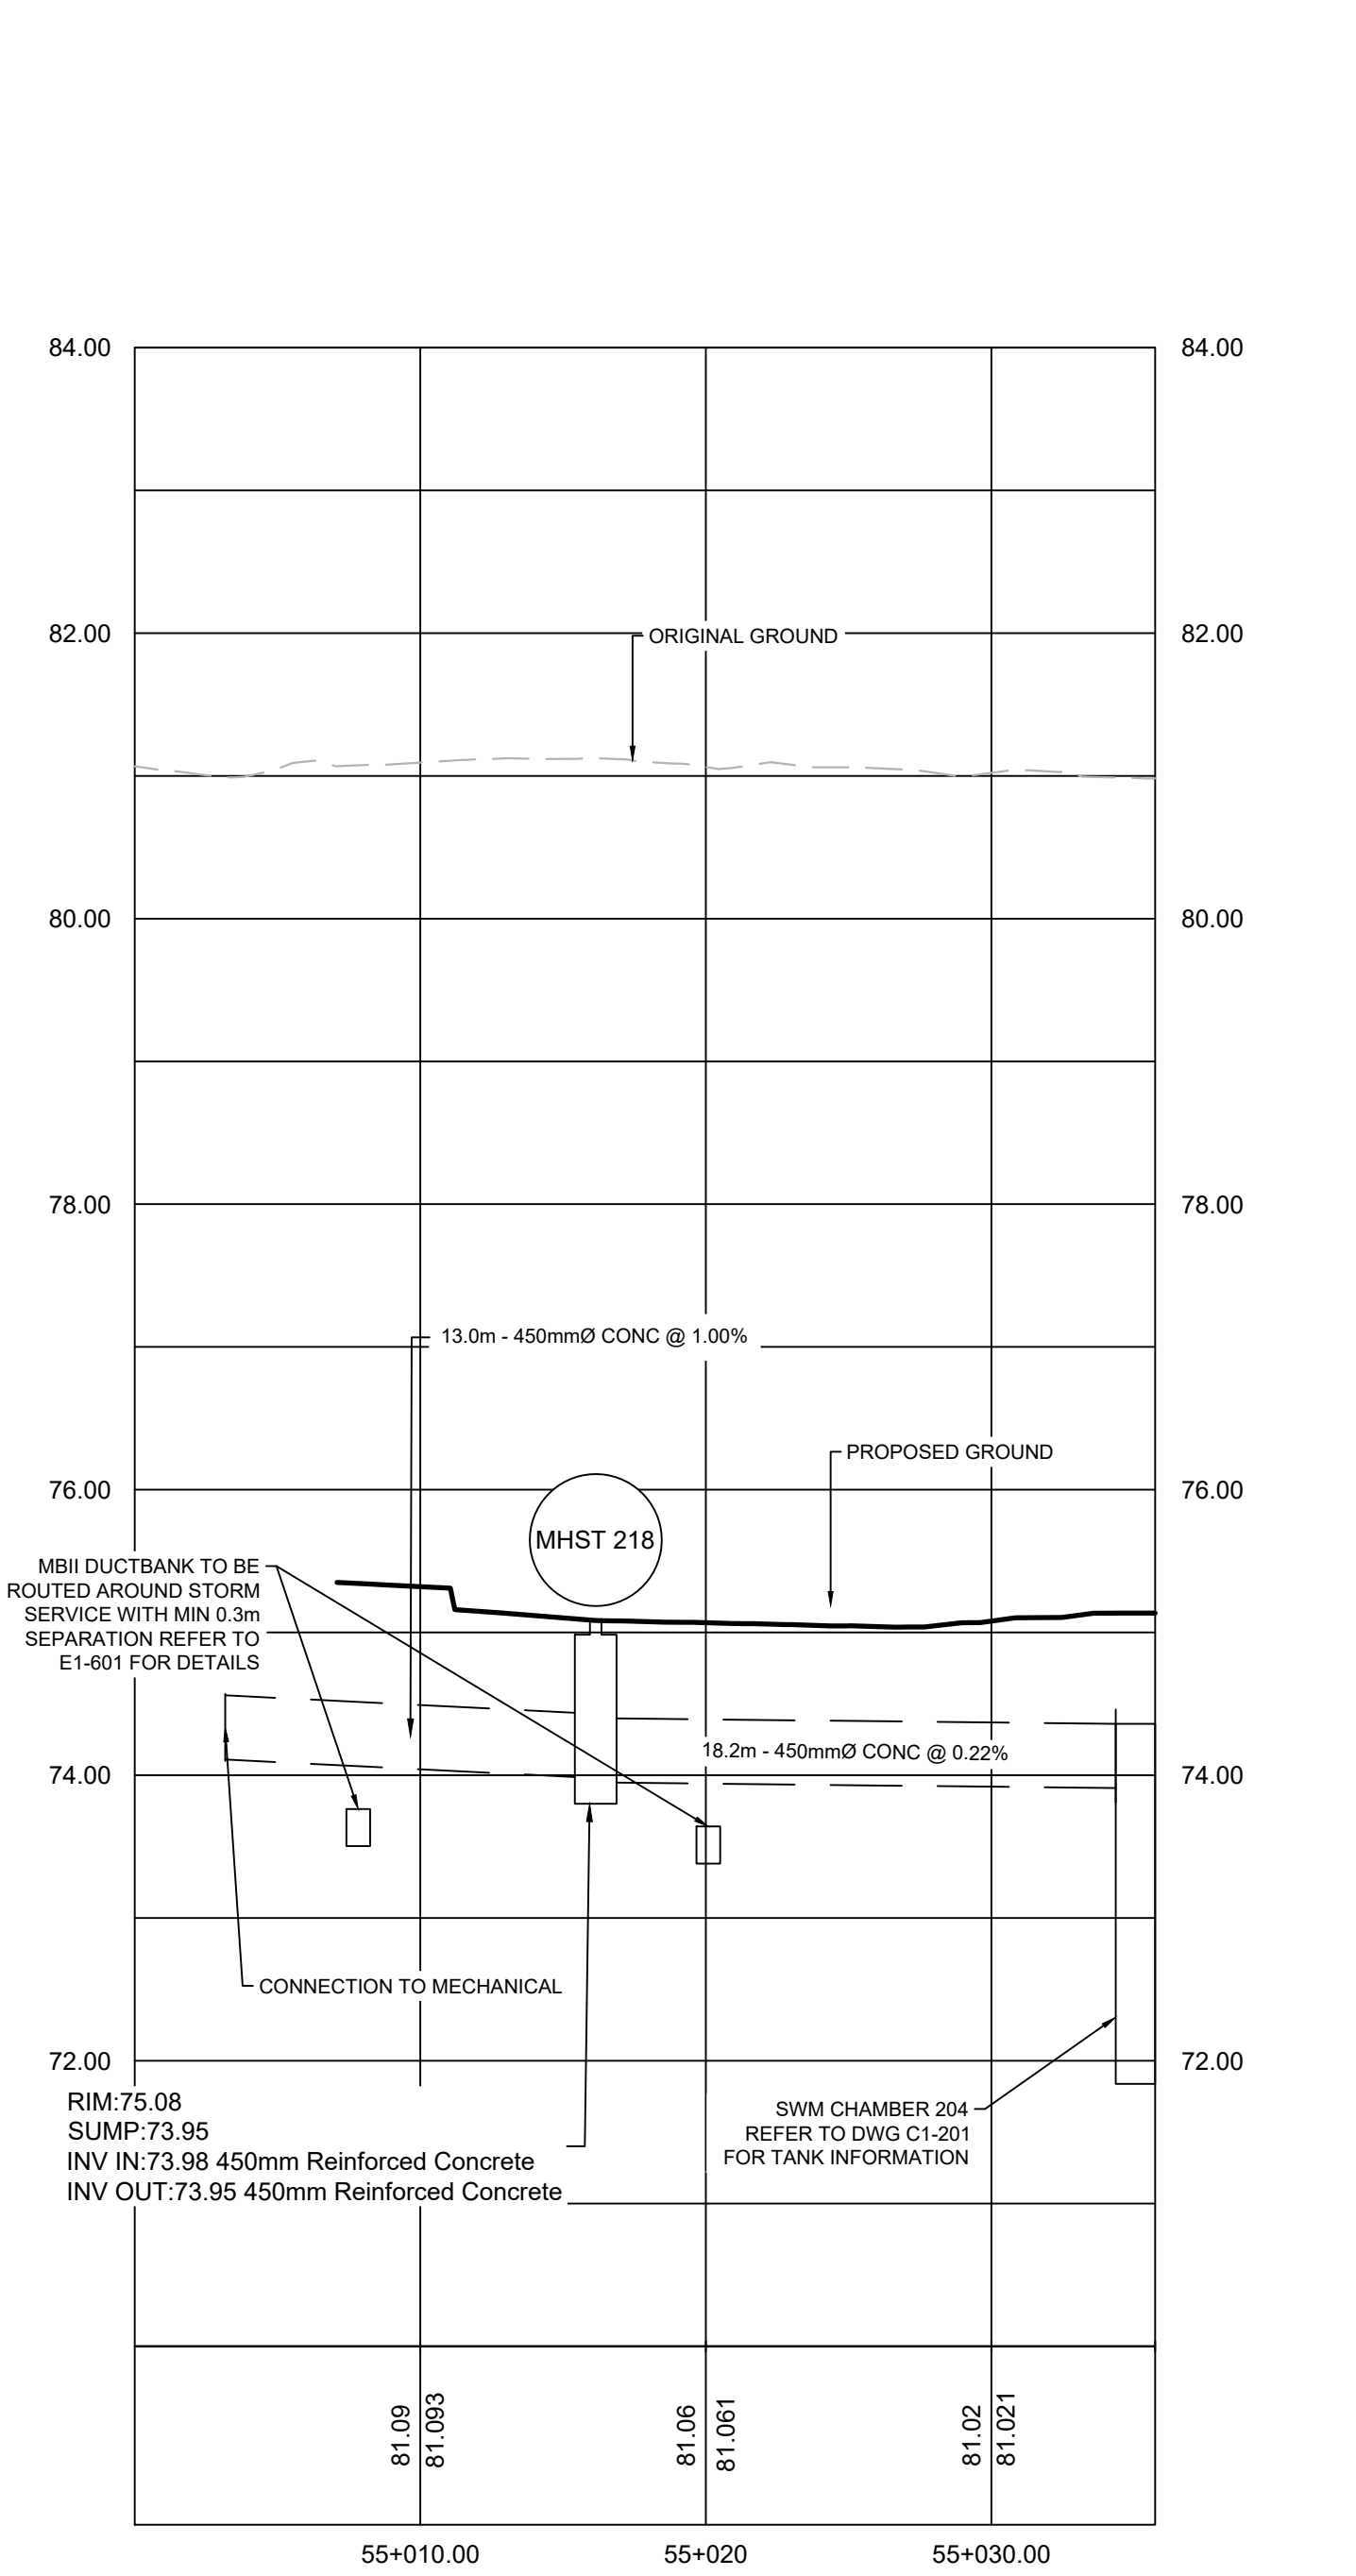
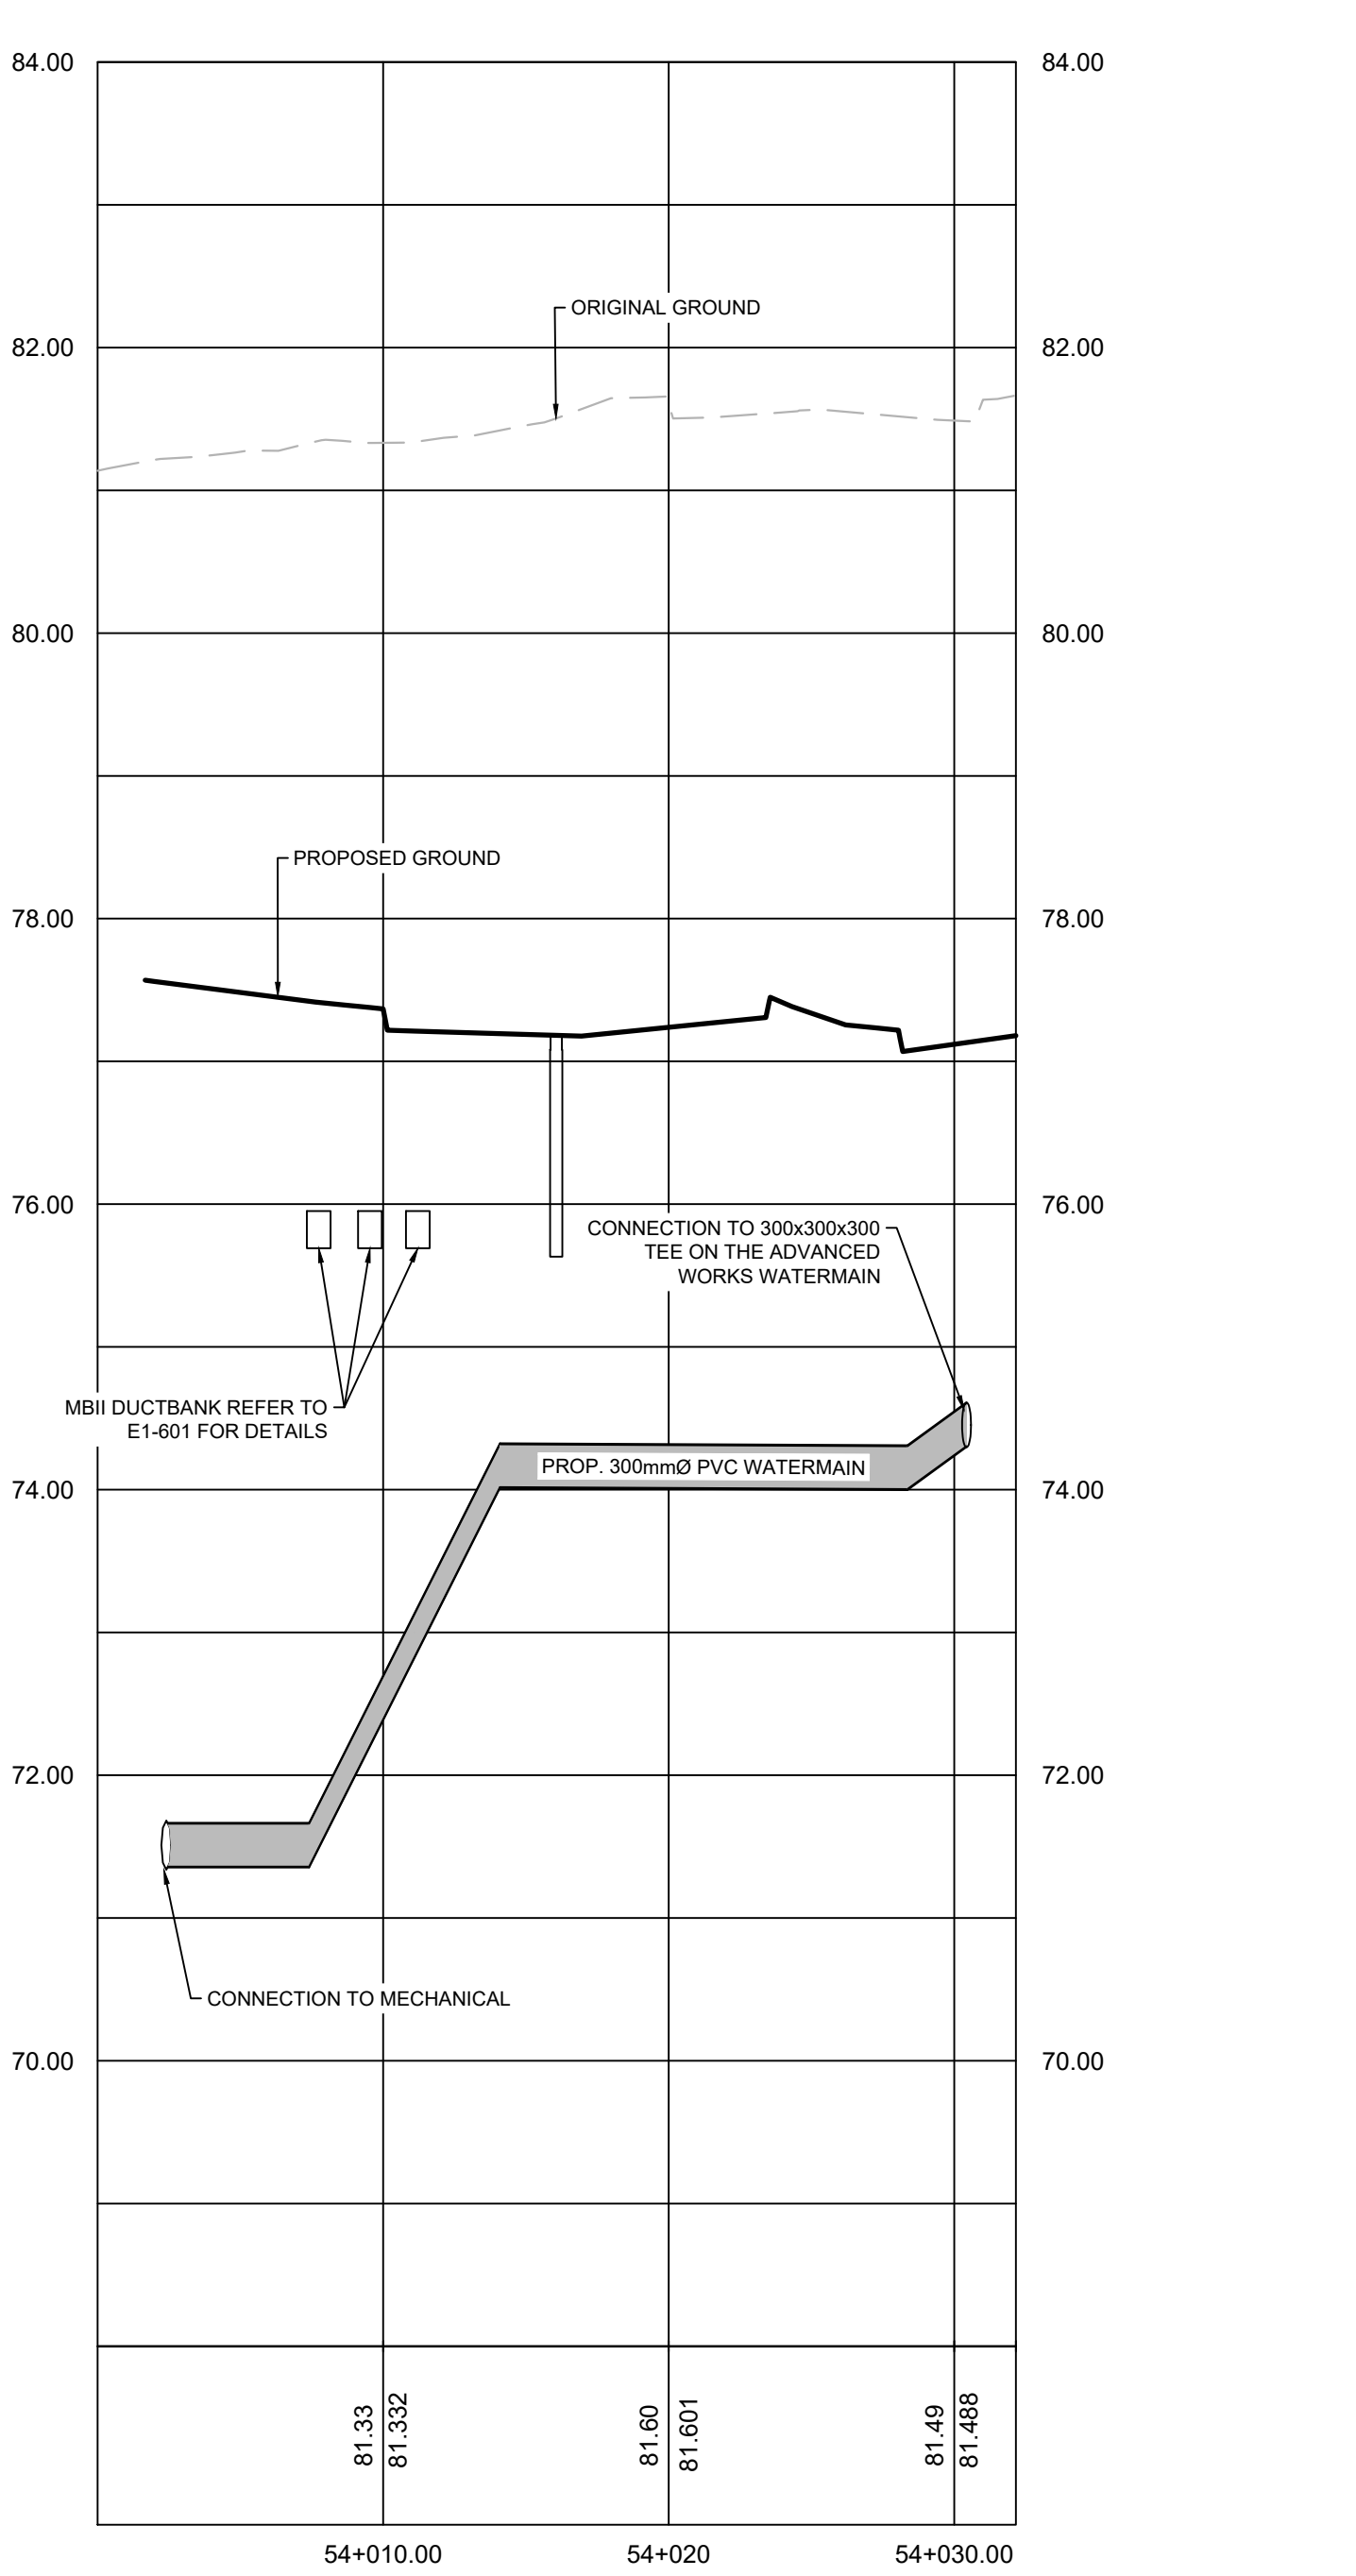
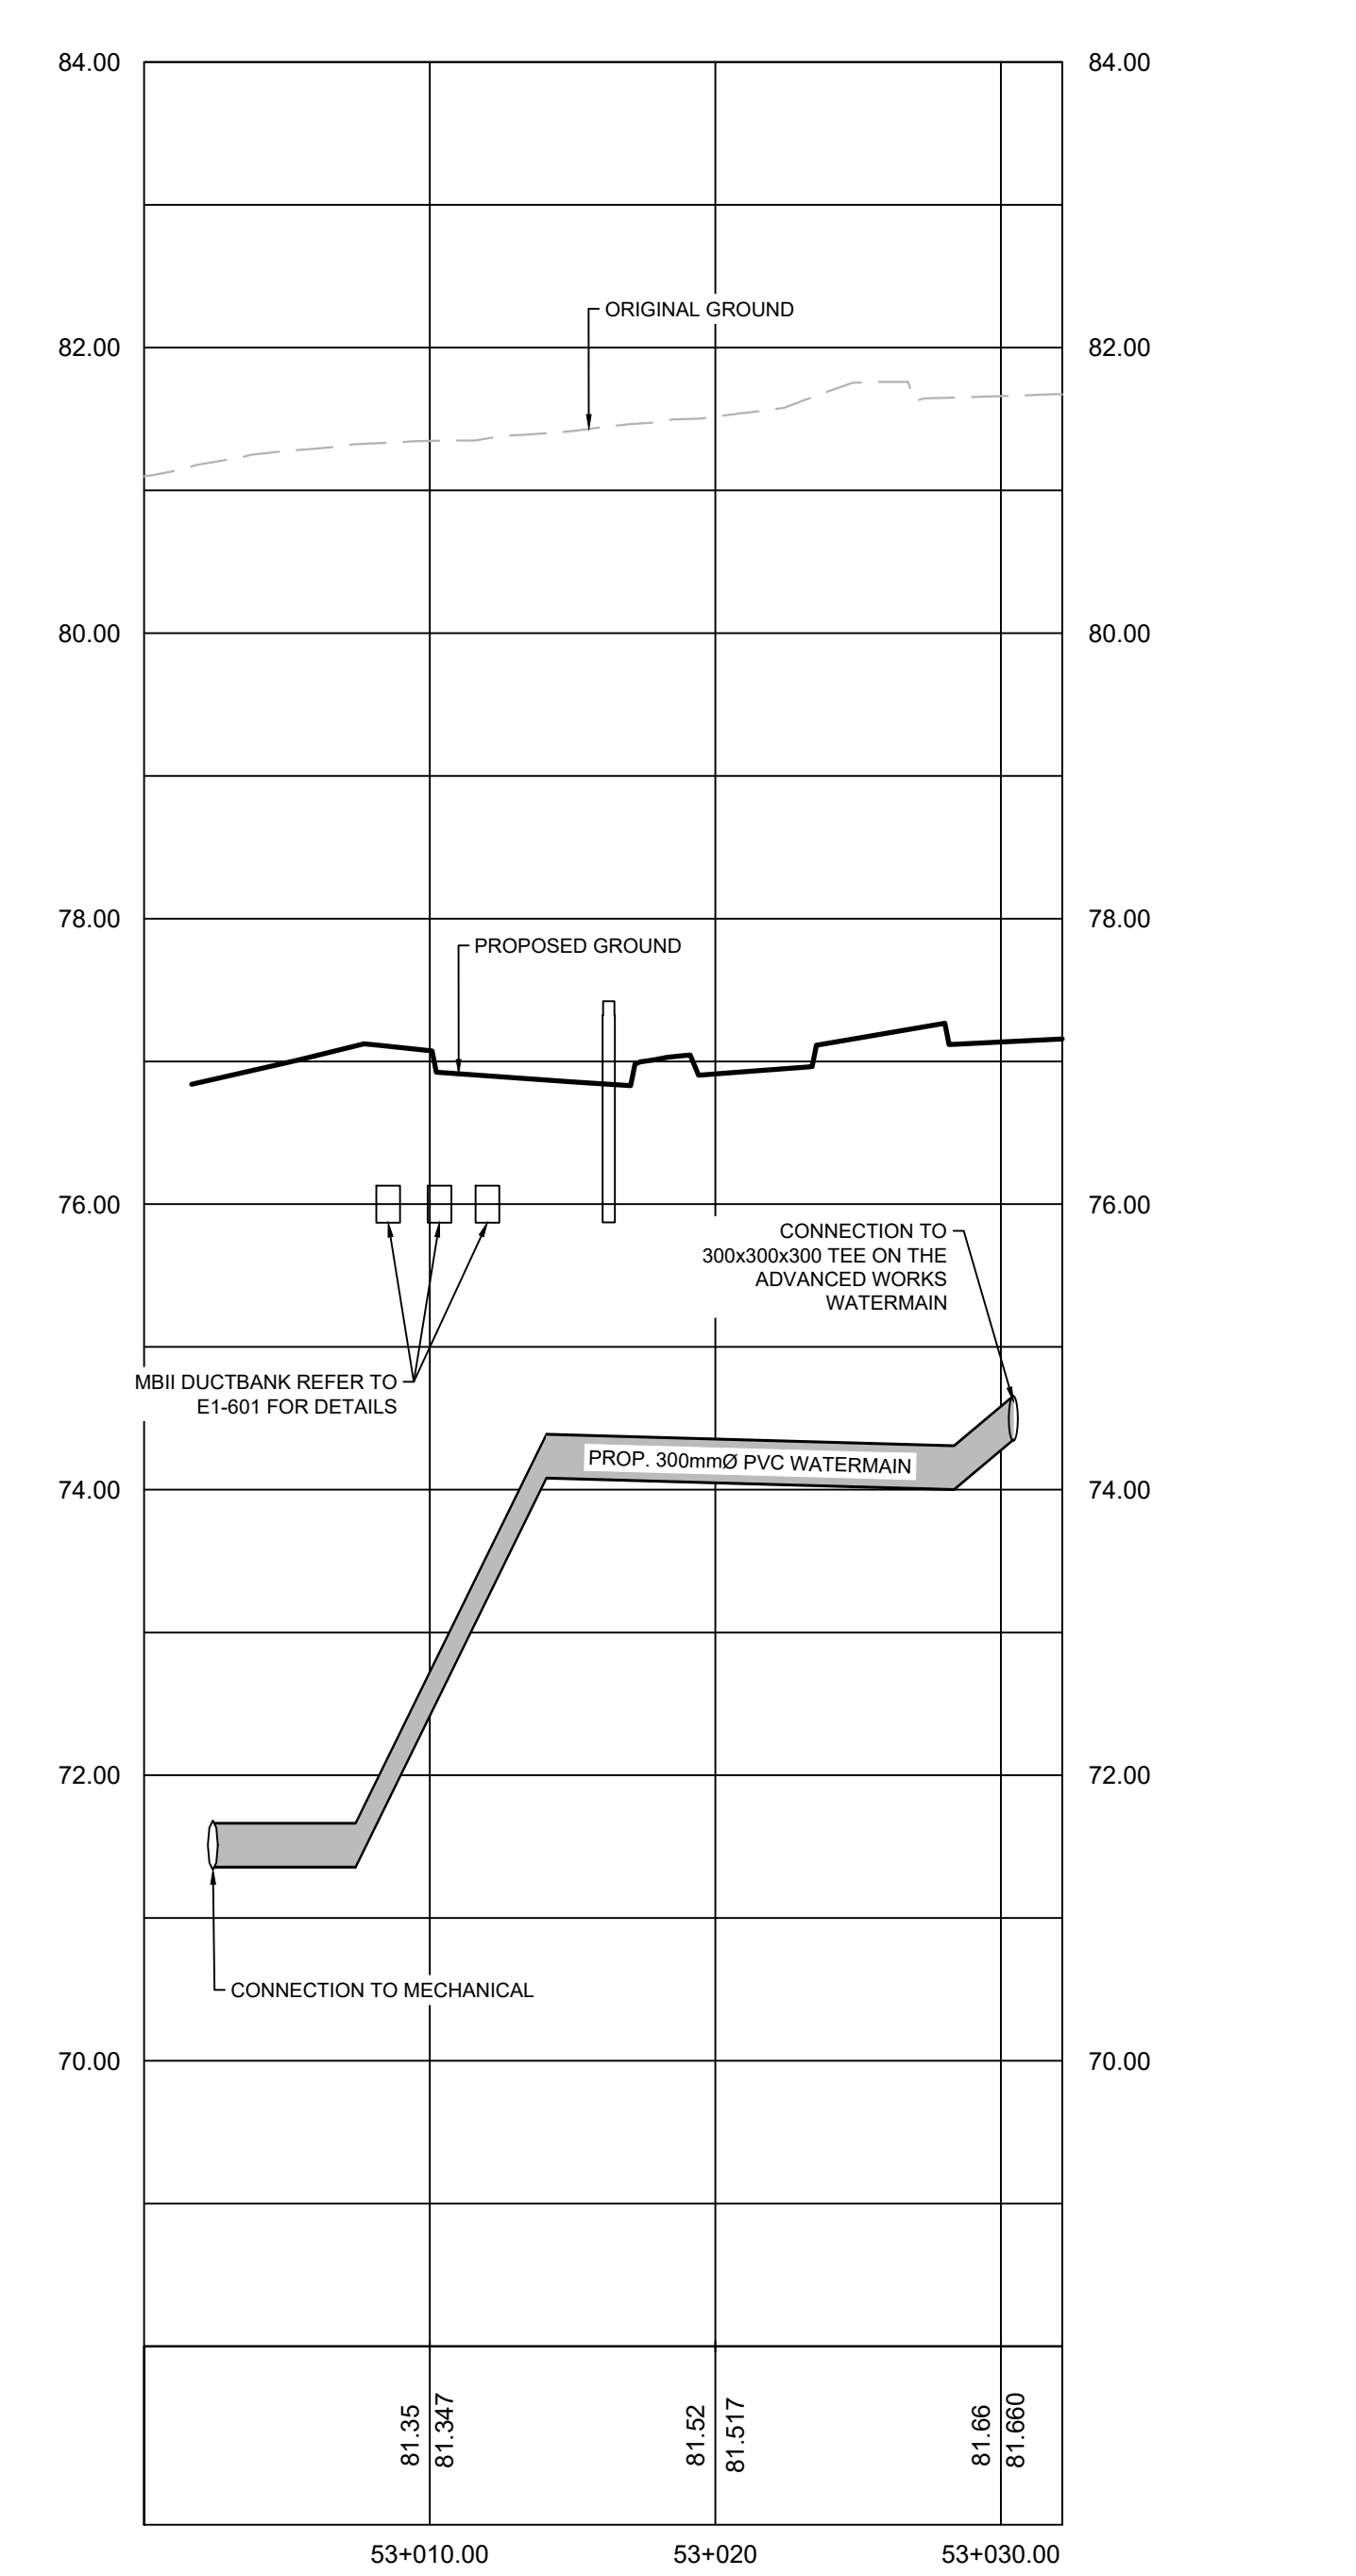
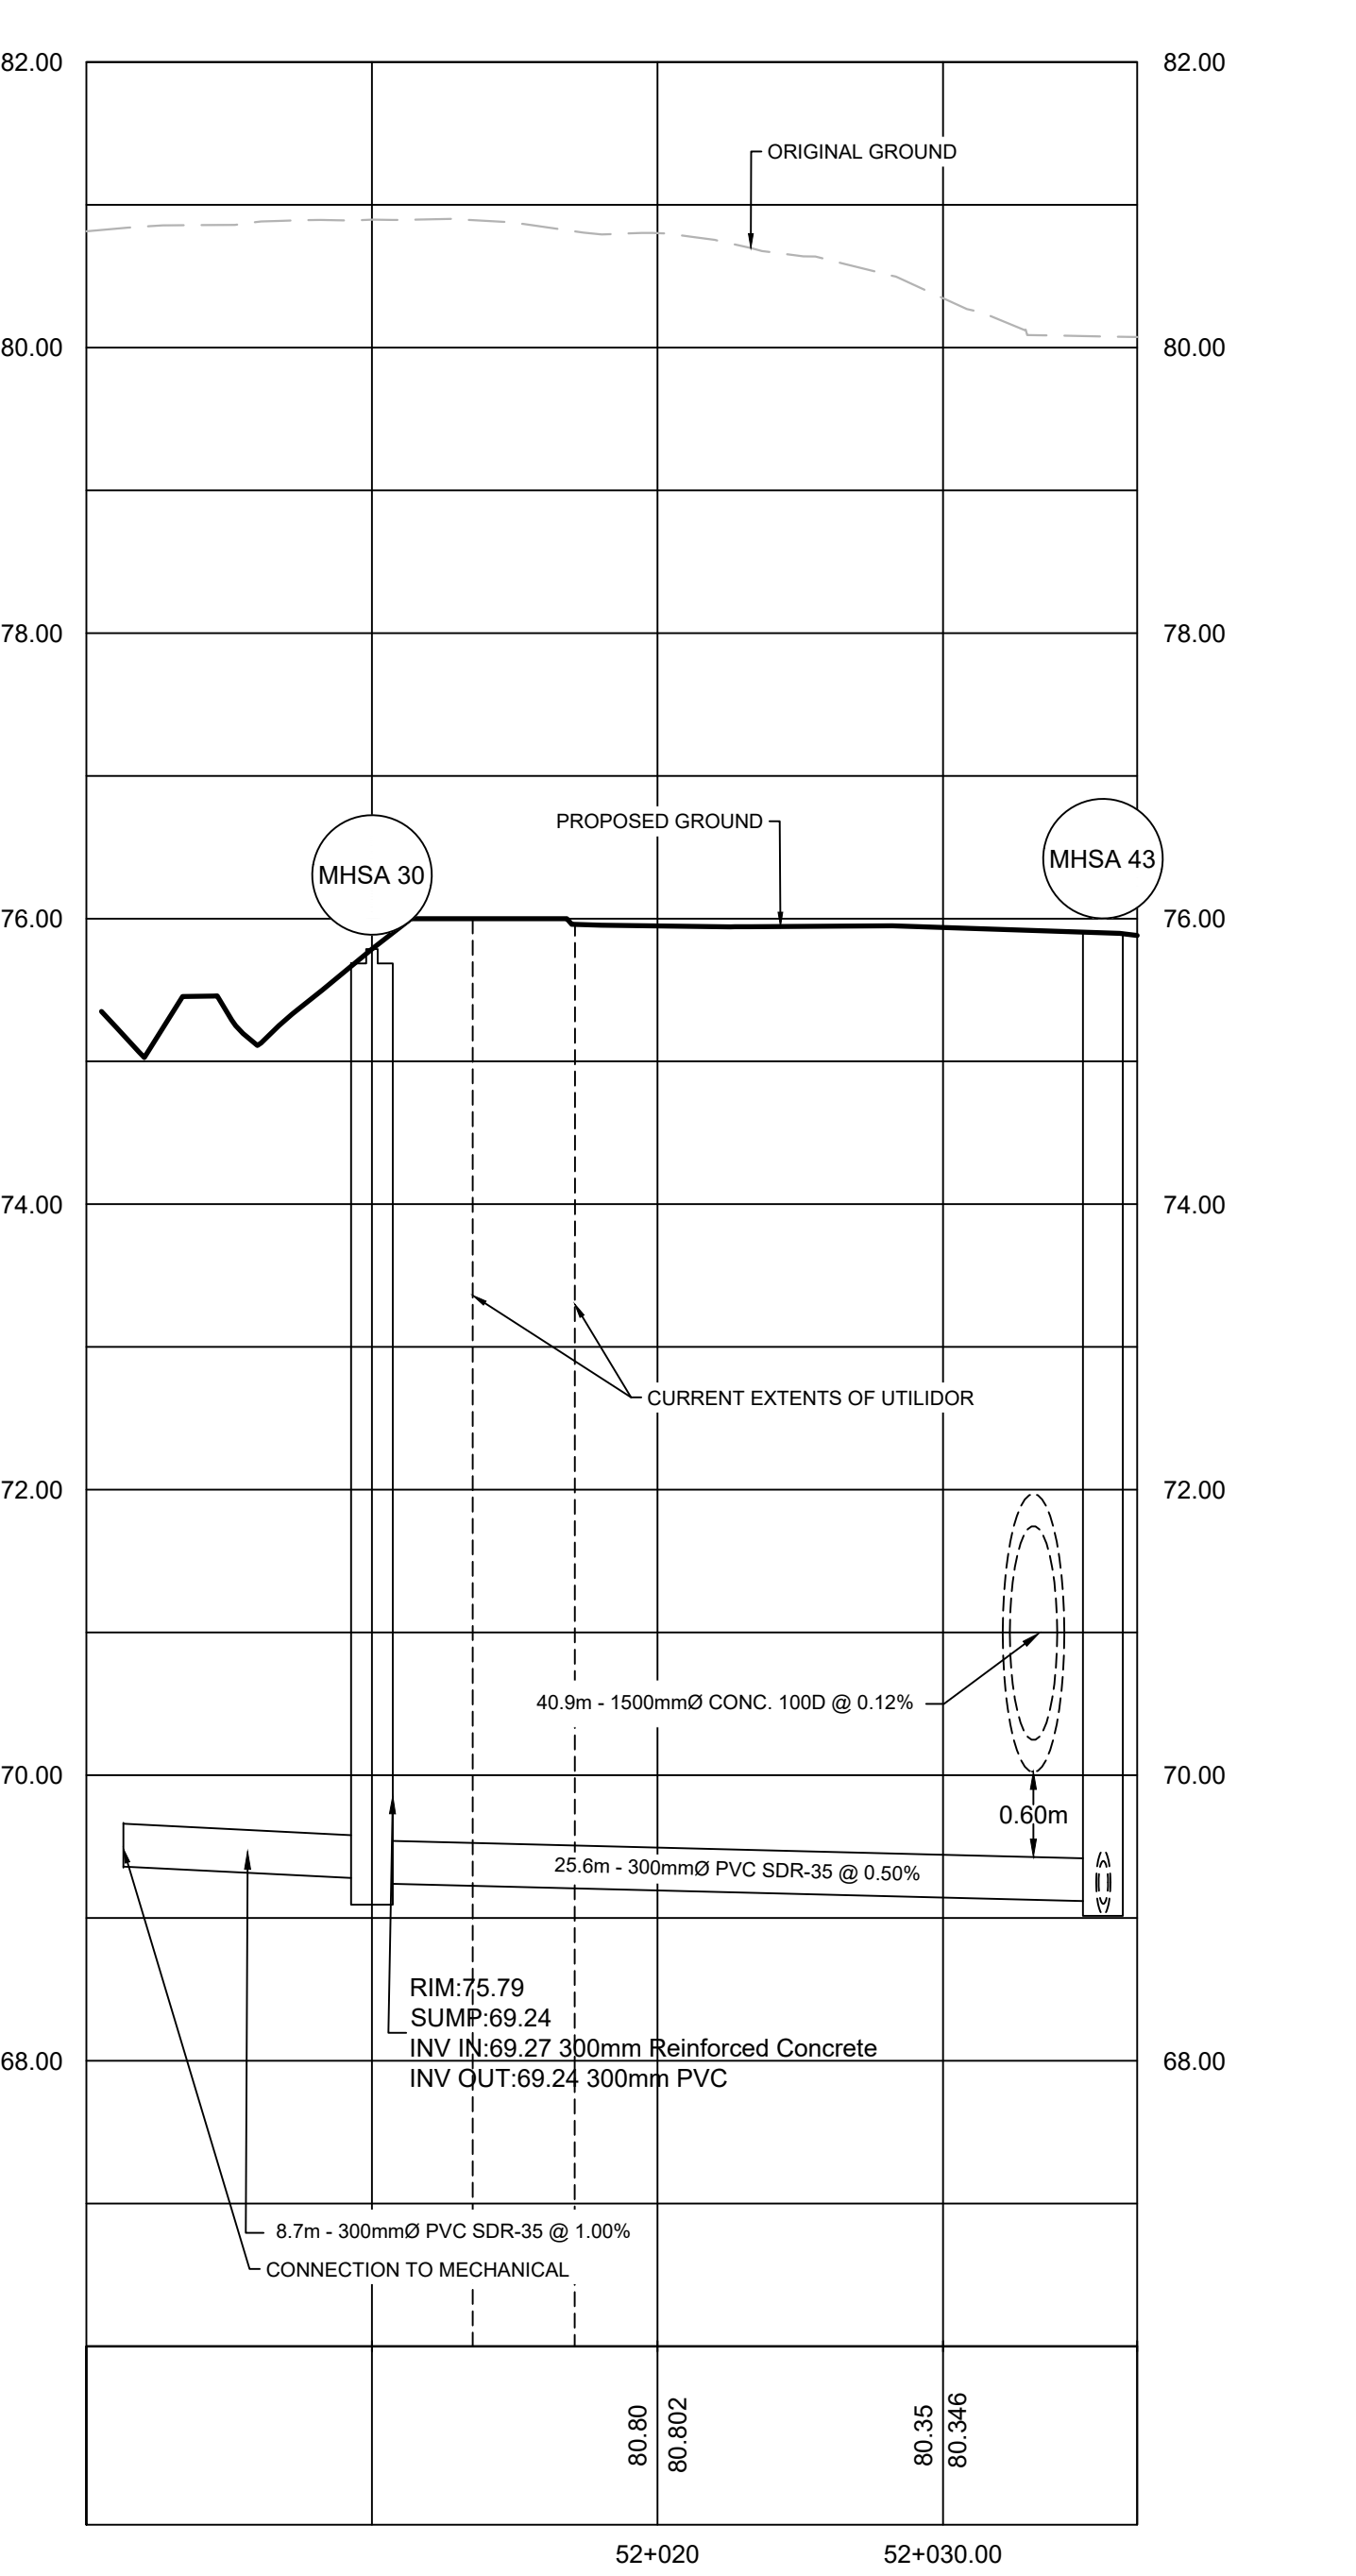
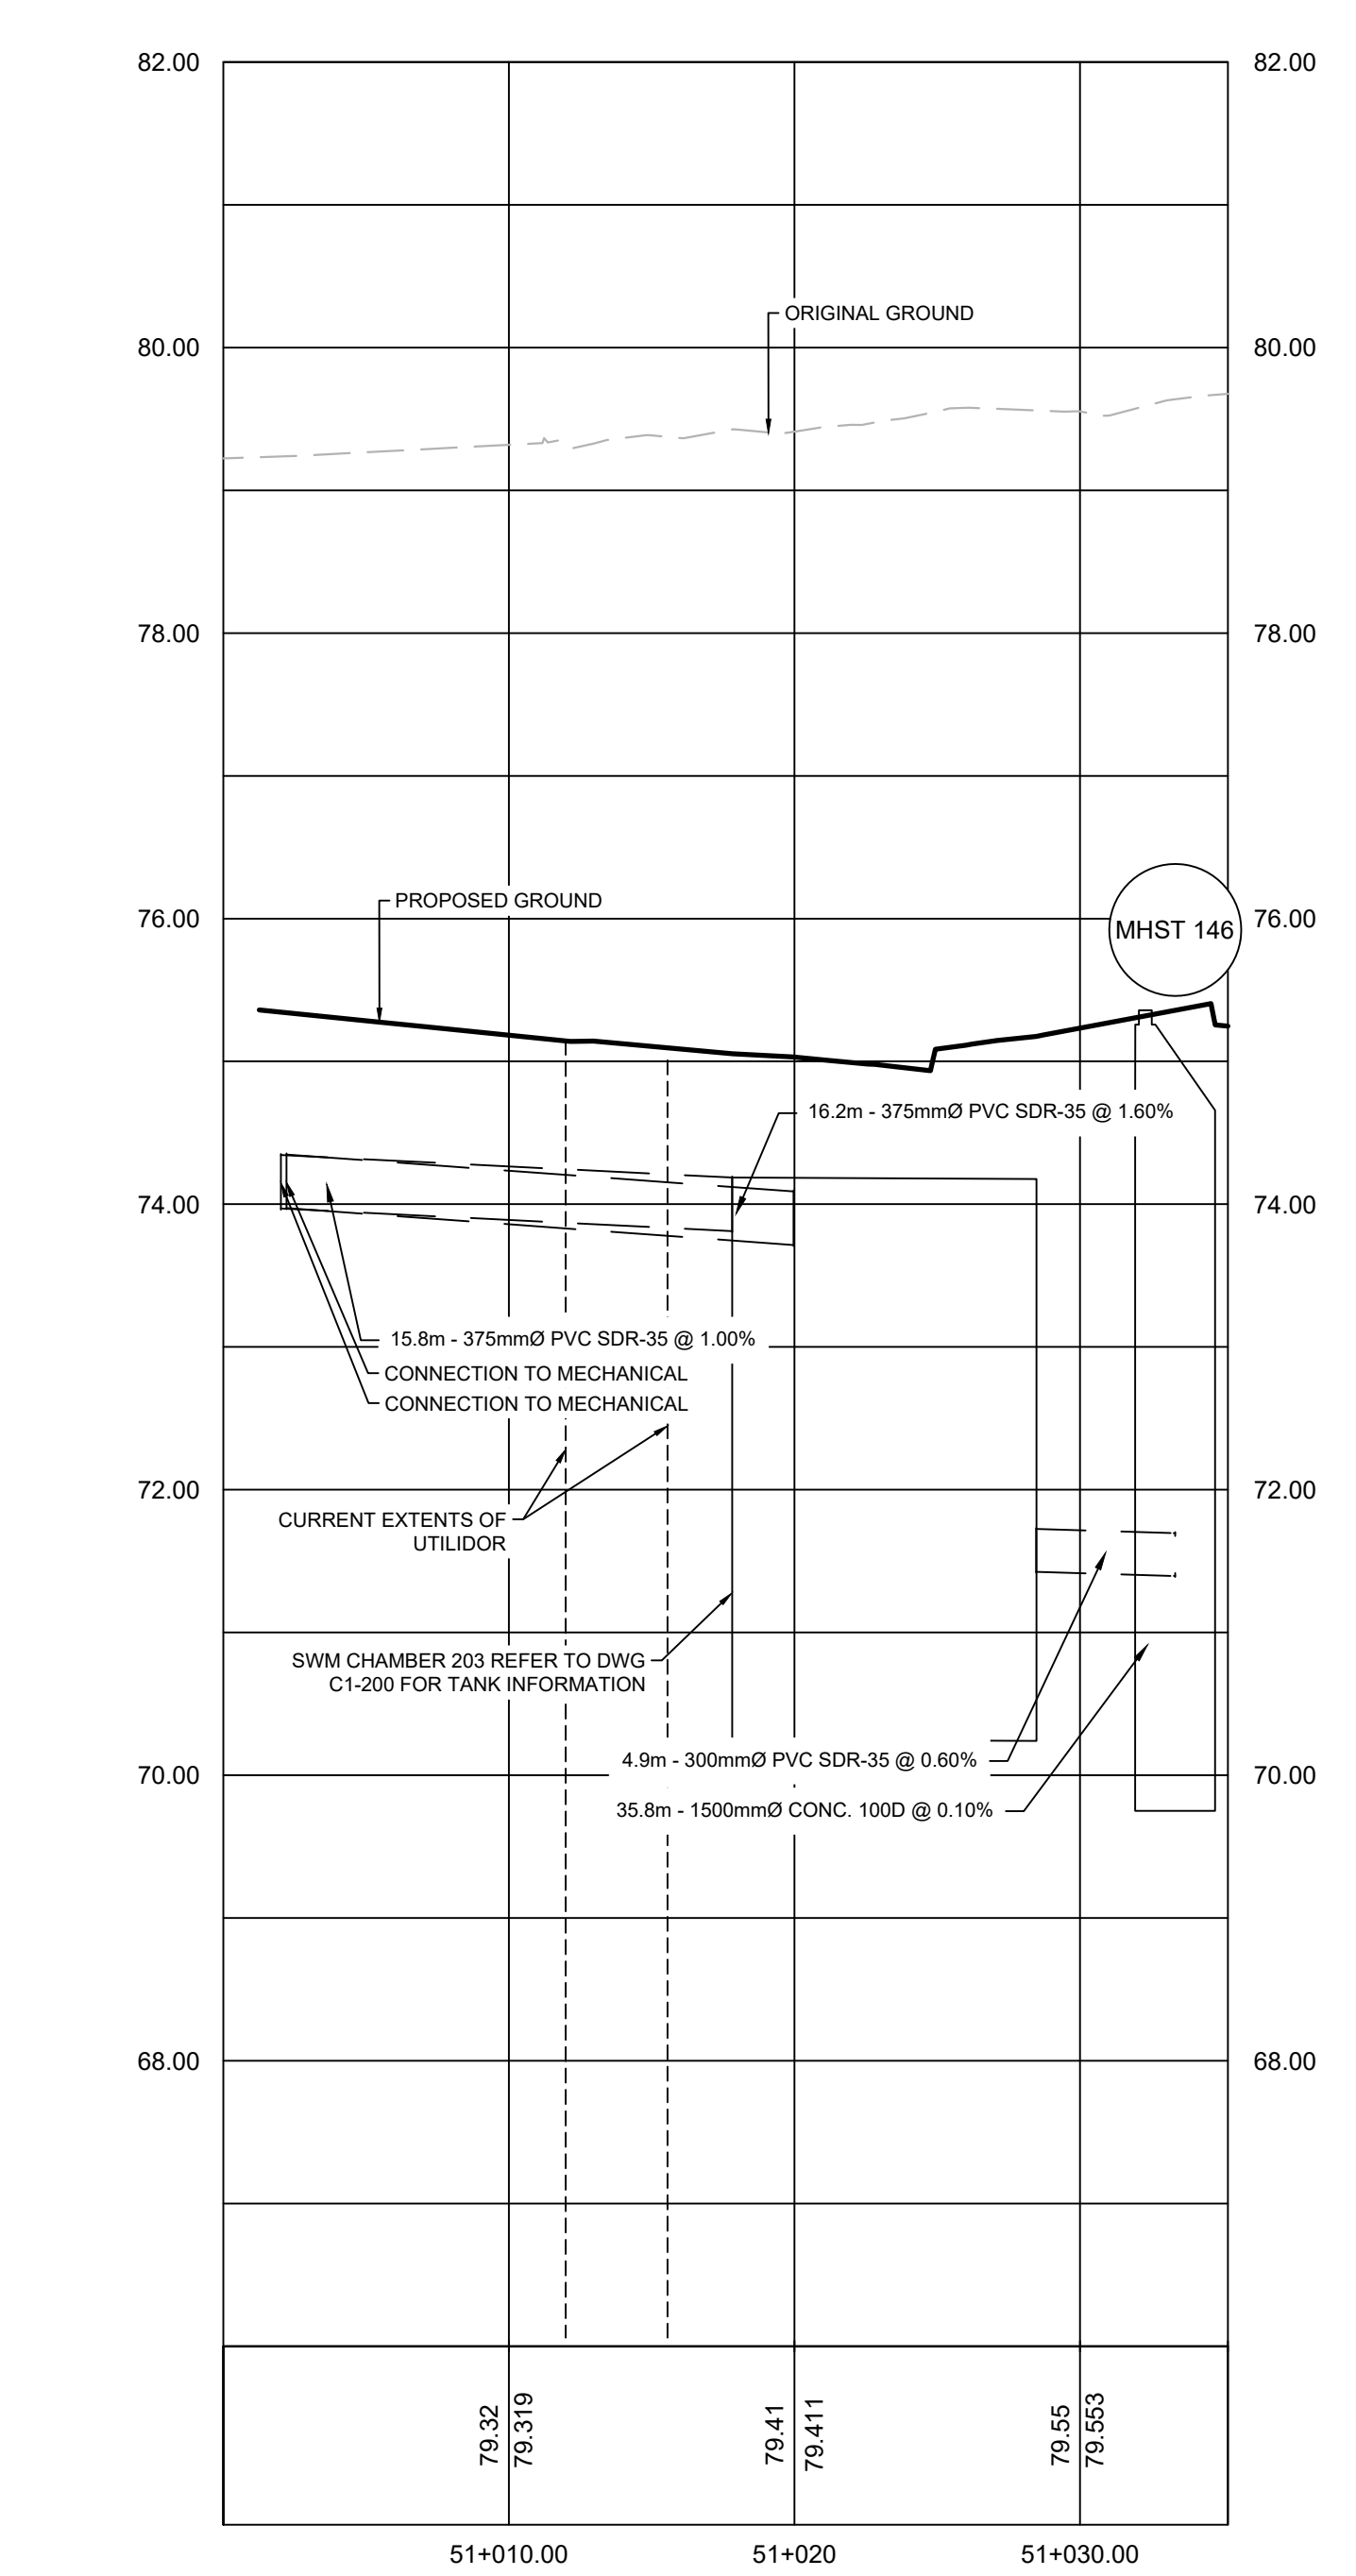
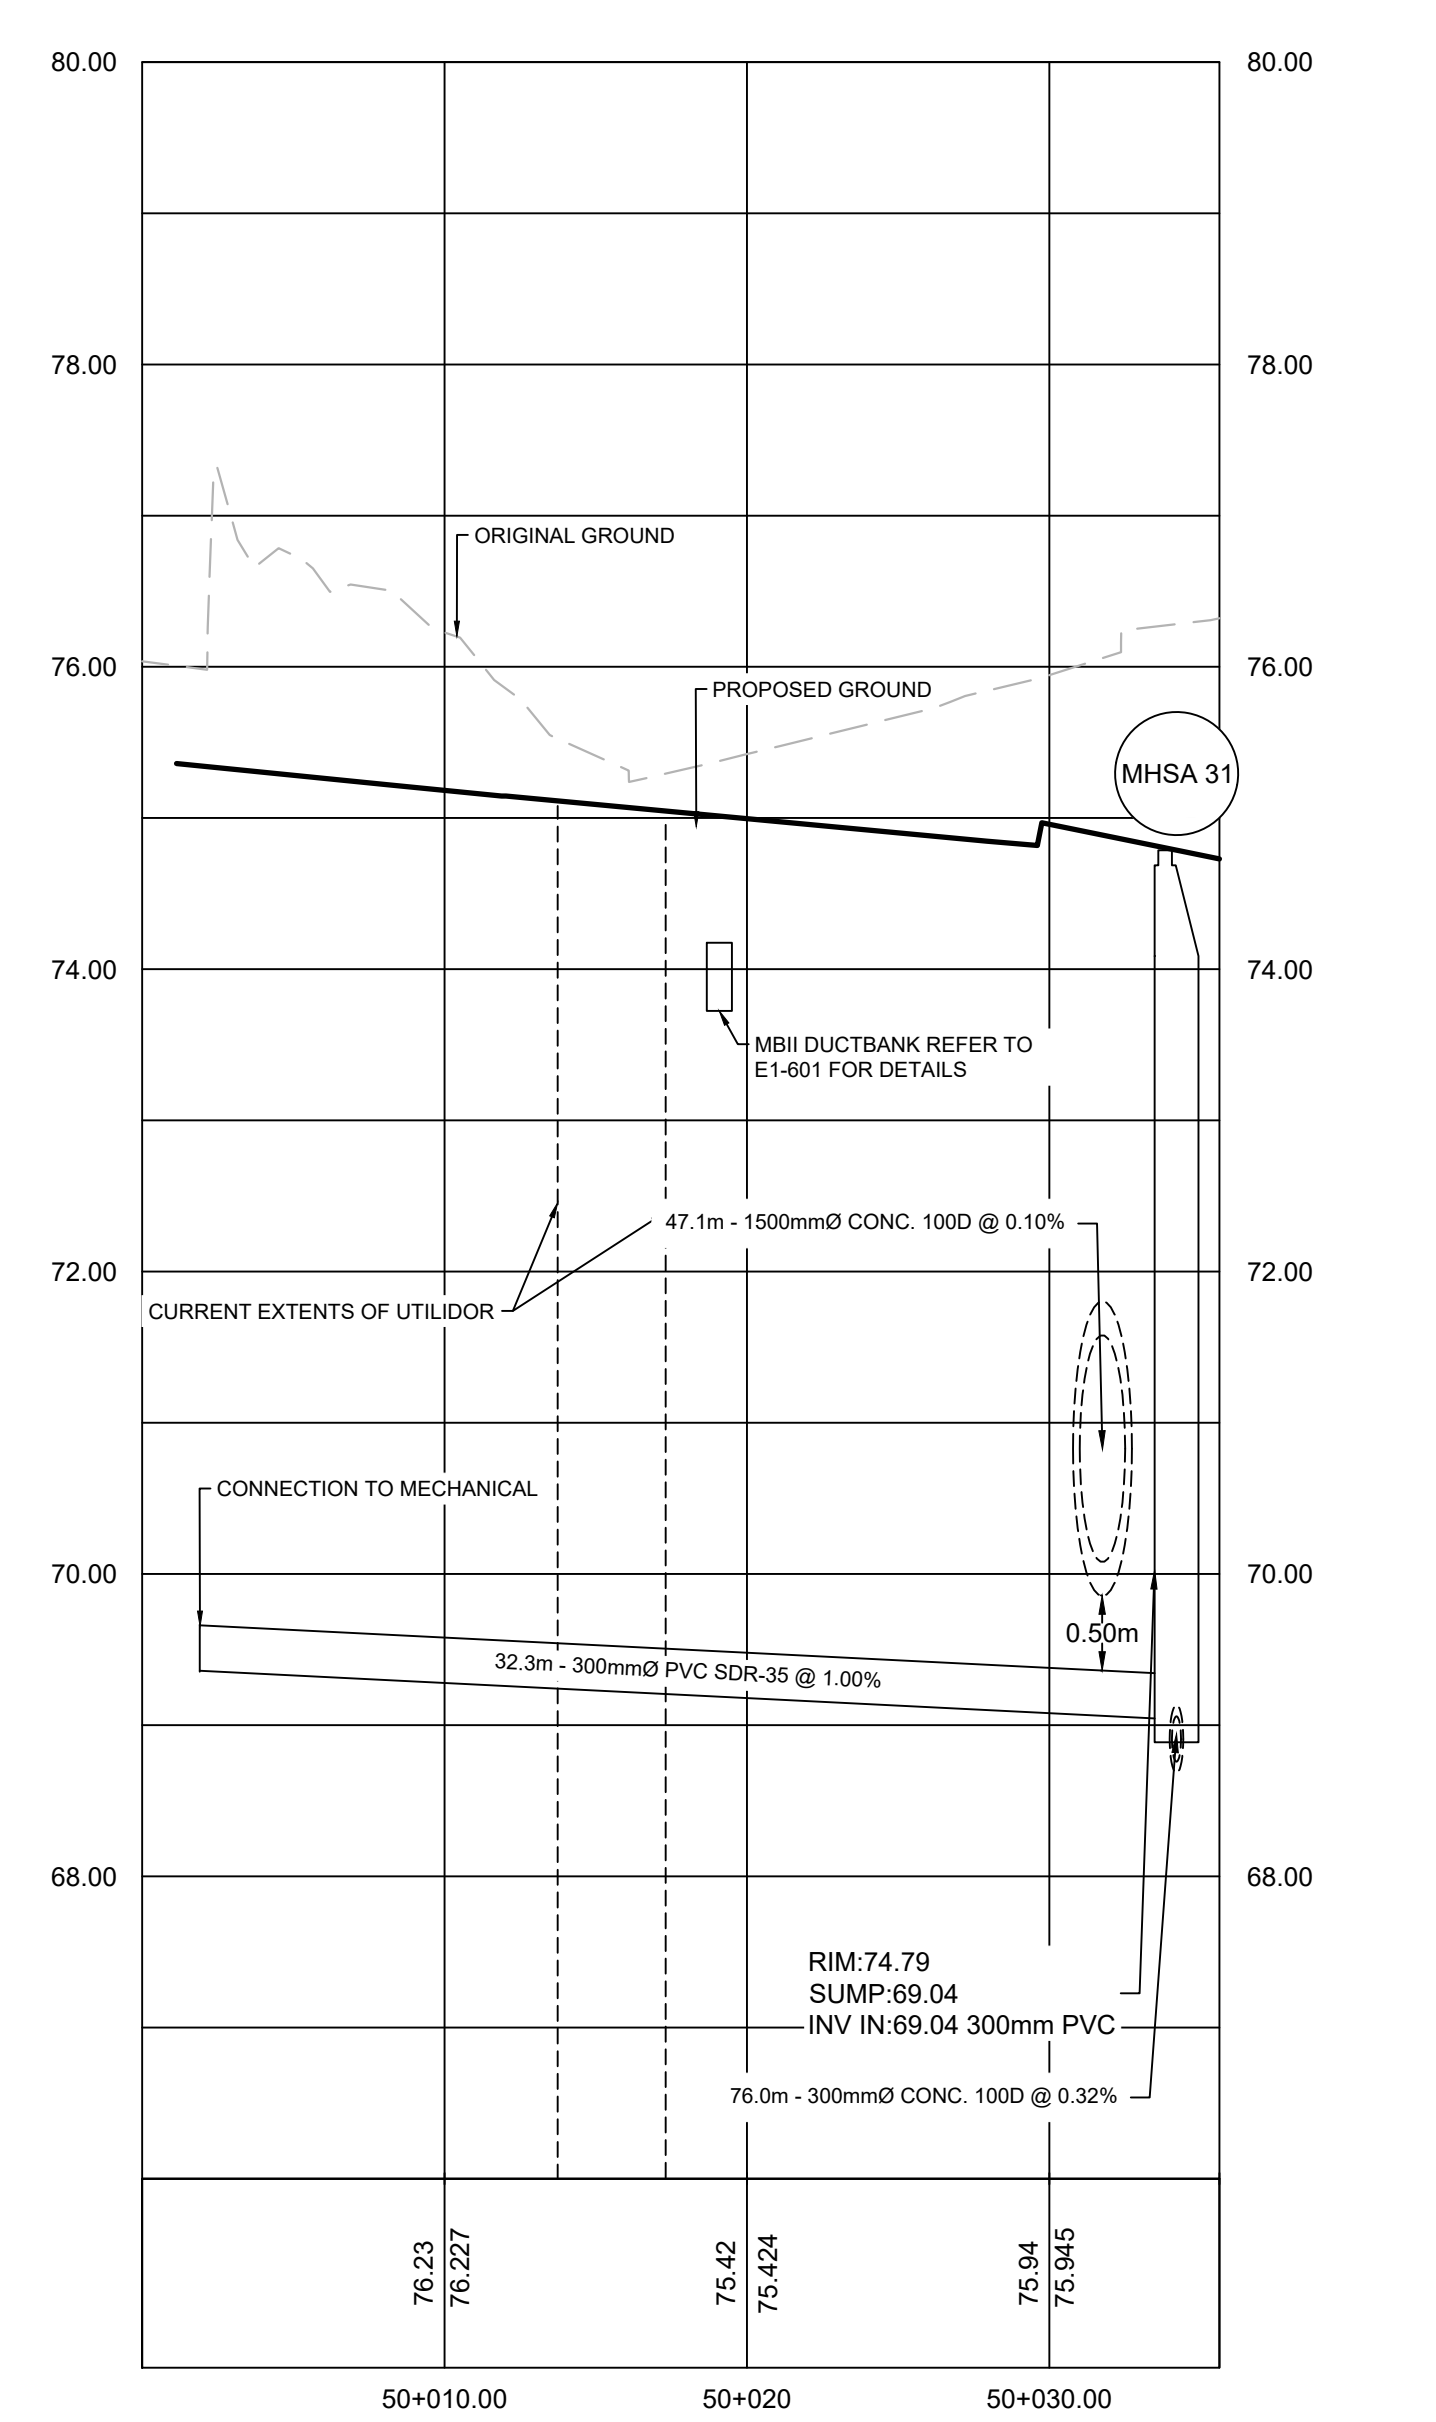
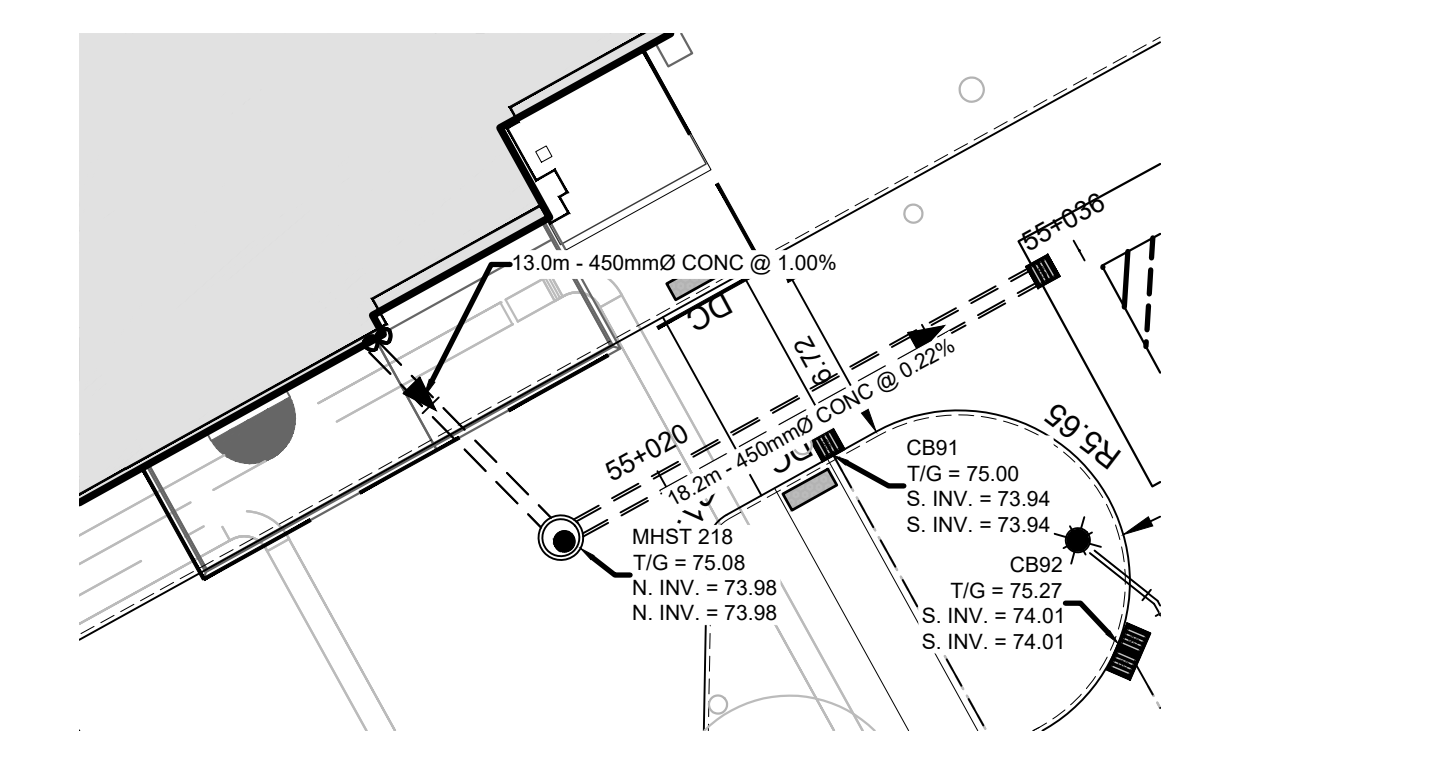
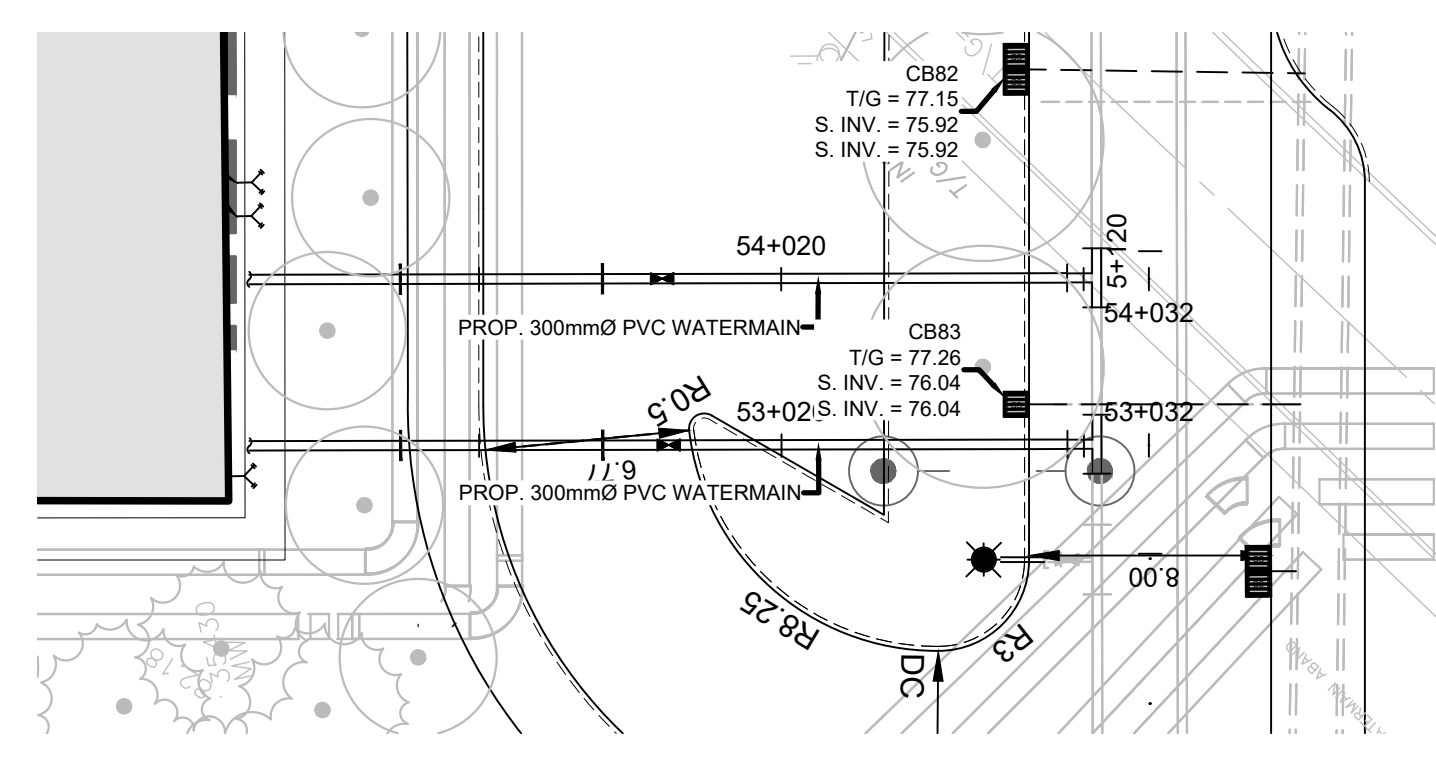
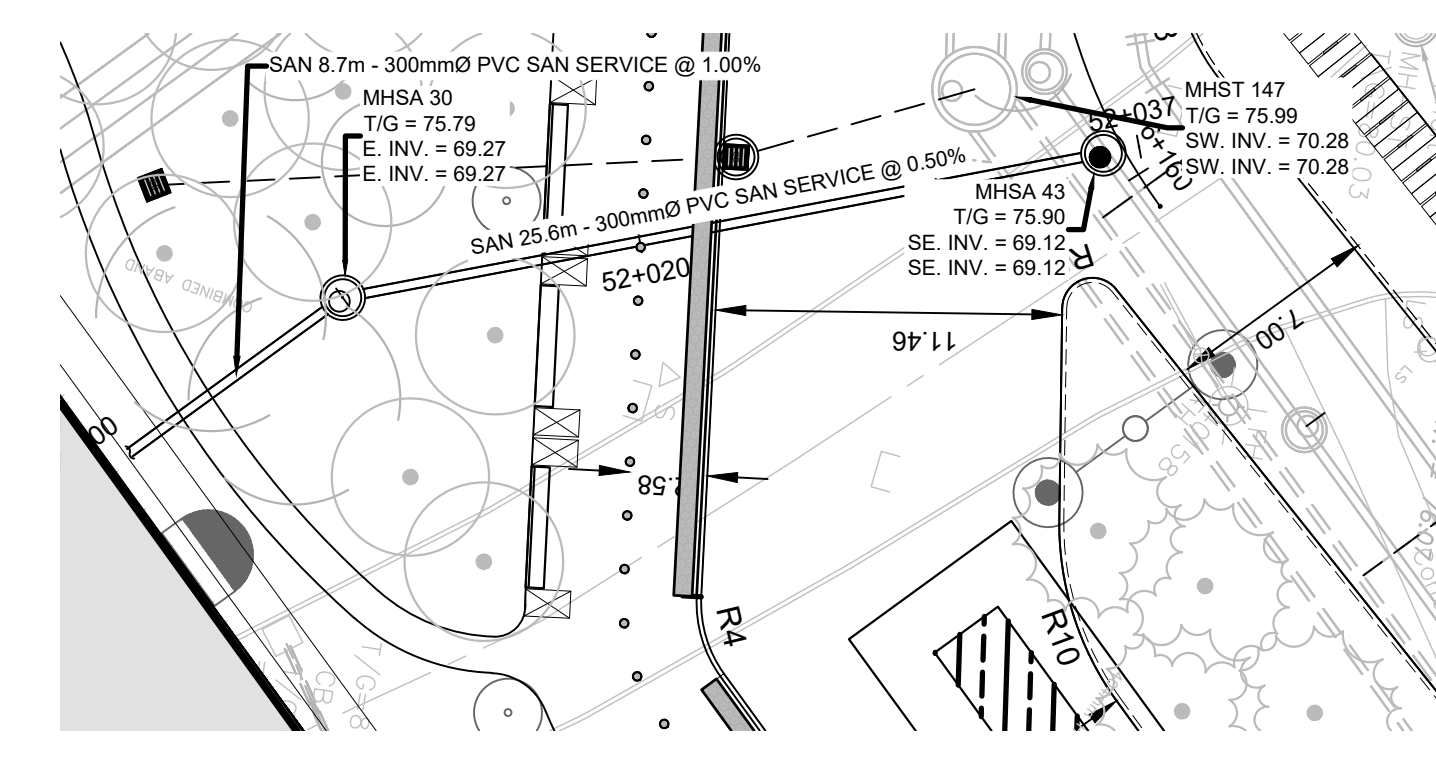
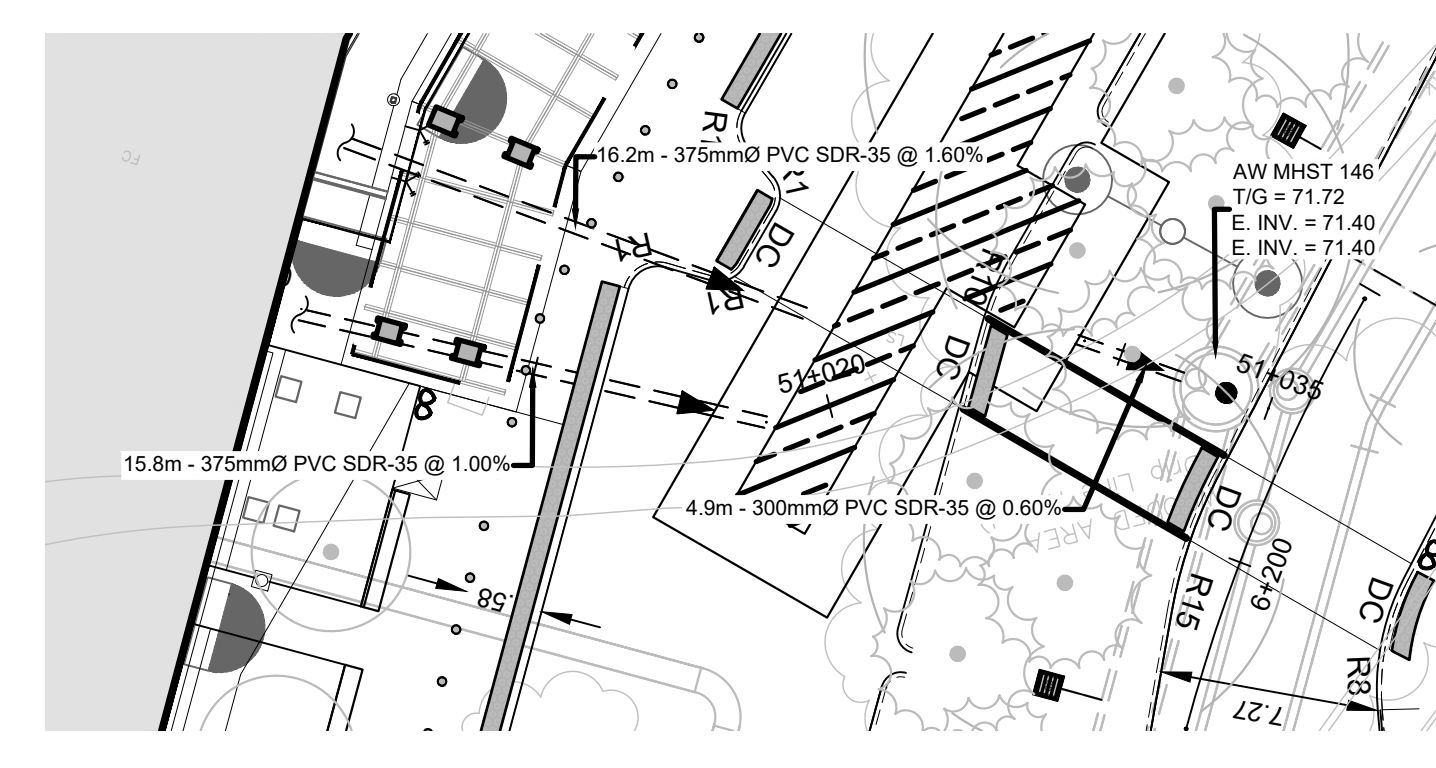


PLOT DATE: 08/14/25 11:58 AM (PLOT DATE) SHEET NO. 1070002-01

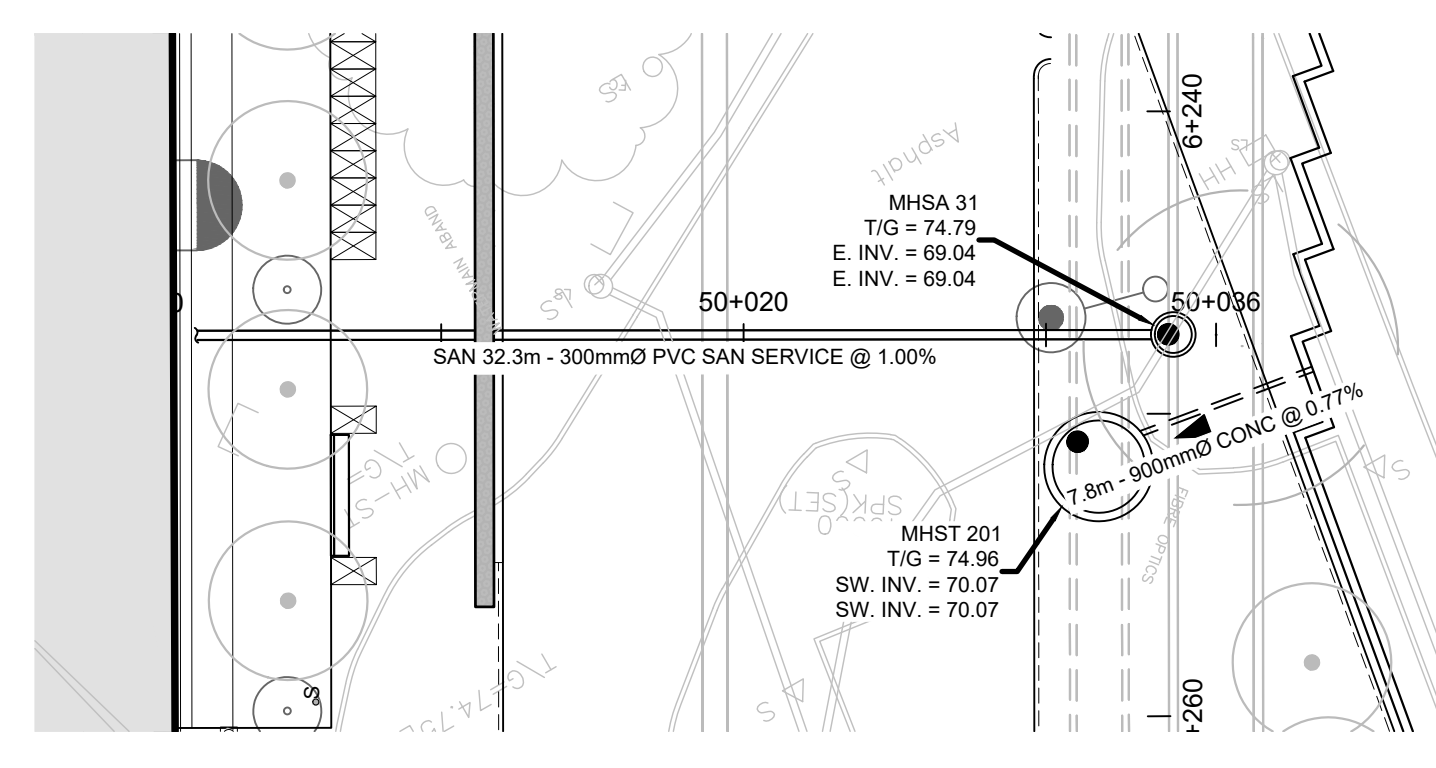

PROJECT
THE OTTAWA HOSPITAL
NEW CAMPUS
DEVELOPMENT -
PHASE 4 MAIN HOSPITAL
BUILDING
 900 CARLING AVE. OTTAWA, ONTARIO

CLIENT
 The Ottawa Hospital | Hôpital d'Ottawa

Infrastructure Ontario

PCL **EllisDon**

CONSTRUCTION

CLIENT PROJECT NO.
 1070002

KEY PLAN
 TRUE NORTH PROJECT NORTH

REVISIONS

07	SITE PLAN CONTROL RESUBMISSION R2	2026-03-27
06	DESIGN BUILD BASELINE SUBMISSION	2026-03-05
05	FOUNDATION PERMIT SUBMISSION	2026-01-13
04	SITE PLAN CONTROL RESUBMISSION	2025-01-12
03	65% DD SUBMISSION	2025-09-19
02	SITE PLAN CONTROL RESUBMISSION	2025-06-05
01	65% DD SUBMISSION	2025-06-05
02	REVISED	DATE

DRAWING STATUS
NOT FOR CONSTRUCTION

DISCREPANCIES MUST BE REPORTED IMMEDIATELY TO THE ARCHITECT BY PHONE OR E-MAIL. ONLY PLOTTED DIMENSIONS ARE TO BE USED. CONTRACTORS MUST CHECK ALL DIMENSIONS ON SITE. THIS DRAWING IS PROTECTED BY COPYRIGHT.

ALL DIMENSIONS ARE SHOWN IN METRIC.

AUTHOR

PROJECT TEAM

DESIGN BUILDER POLARIS A JOINT VENTURE

ARCHITECTURAL PARSON ARCHITECTS LIMITED
 JORDAN LAMARCA PRATTE ARCHITECTS
 ADAMSON ASSOCIATES ARCHITECTS

STRUCTURAL S&S ARCHITECTS OTTAWA INC.
 SALAS OPEN CANADA INC.
 SOUTHLETTLE FARGEAU INC.

MECHANICAL H&A ANGUS & ASSOCIATES LTD.
 SALAS OPEN CANADA INC.

ELECTRICAL MELVEY & BARNUM INTERNATIONAL INC.

CIVIL WSP CANADA INC.

LANDSCAPE VERTICORD DESIGN INC.
 P&P LANDSCAPE ARCHITECTURE

BUILDING CODE LMDG BUILDING CODE CONSULTANTS LTD.

AUTHOR PROJECT NO.
 CA0027758.0-51

STAMP

DRAWING TITLE
PLAN AND PROFILES
1 OF 3

DRAWN L. CURLEY / D. MARATHA **CHECKED** C. GRAHAM

SCALE AT 4" = 40' **DATE** 2024-02-26

GRAPHIC SCALE

DRAWING NO. **REV. NO.**

C1-400 **07**

File Number: D07-12-26-0008 (Revision)
D07-12-23-0168 (Original)
Plan Number: 19424

#19424