


PLOT DATE: 19-SEPT-2025

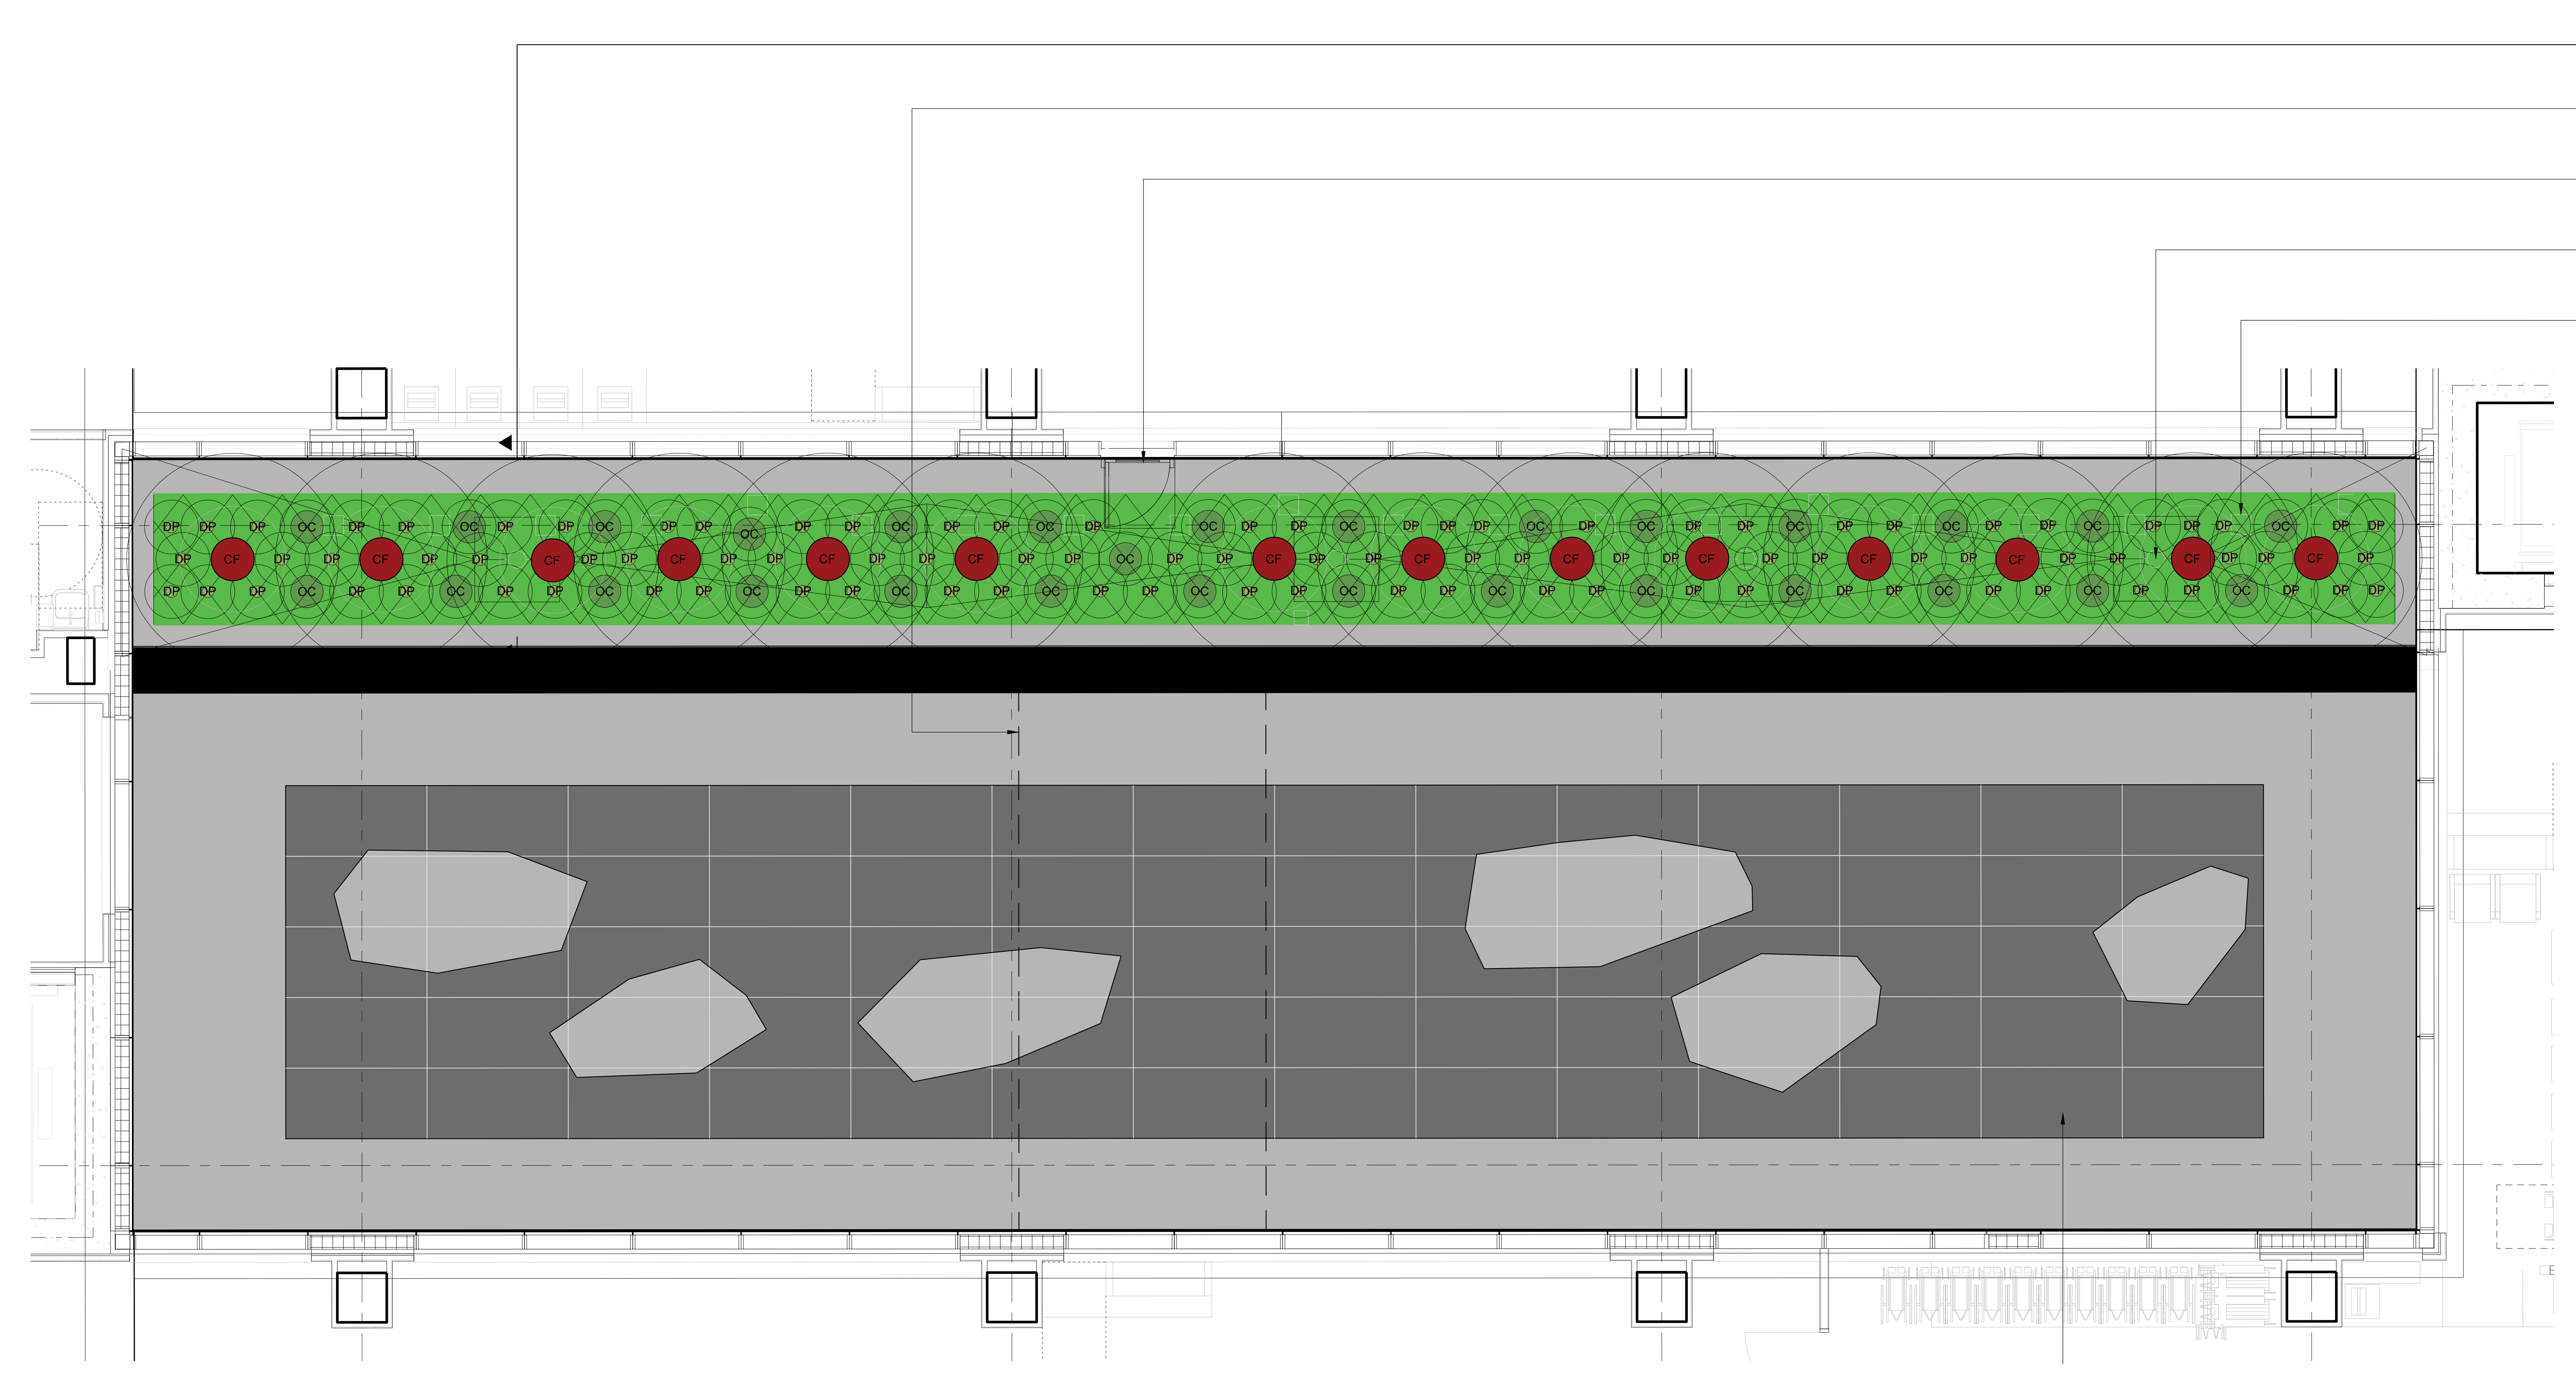

1
L15-112

- CONVENIENCE BRIDGE, ABOVE
- SAD
- MAINTENANCE ACCESS DOOR
- SAD
- ROOF DRAIN
- SAD
- SAFETY TIE-OFF
- SAD

LIGHTWELL			
	Cornus florida	10%	15 GALLON 84"
	Denstaedia punctilobula	68%	1 GALLON 18"
	Osmundastrum cinnamomeum	22%	5 GALLON 36"

1 LEVEL 1 - LIGHTWELL PLANTING SHELF
SCALE: 1/4" = 1' PLANTING ENLARGEMENT

PROJECT
THE OTTAWA HOSPITAL
NEW CAMPUS
DEVELOPMENT -
PHASE 4 MAIN HOSPITAL
BUILDING
900 CARLING AVE. OTTAWA ONTARIO

CLIENT
The Ottawa Hospital | L'Hôpital d'Ottawa

Infrastructure Ontario

PCL CONSTRUCTION | **EllisDon**

CLIENT PROJECT NO. 1070002

KEY PLAN

THIS DRAWING TO BE PRINTED IN COLOUR.

NO.	DESCRIPTION	DATE
02	SITE PLAN CONTROL, RESUBMISSION	2025-01-10
01	95% DD SUBMISSION	2025-09-19
00	ISSUED	

REVISIONS

DRAWING STATUS
NOT FOR CONSTRUCTION

DISCREPANCIES MUST BE REPORTED IMMEDIATELY TO THE ARCHITECT BEFORE PROCEEDING. ONLY FIGURED DIMENSIONS ARE TO BE USED. CONTRACTORS MUST CHECK ALL DIMENSIONS ON SITE. THIS DRAWING IS PROTECTED BY COPYRIGHT.

ALL DIMENSIONS ARE SHOWN IN METRIC.

AUTHOR
PWP

PROJECT TEAM
DESIGN BUILDER PCL ED. A JOINT VENTURE
ARCHITECTURAL PARSON ARCHITECTS LIMITED, JODOH LAMARIE PRATTE ARCHITECTS, ADAMSON ASSOCIATE ARCHITECTS, 888 ARCHITECTS INC.
STRUCTURAL STEPHENSON ENGINEERING LTD., BOUTHILLET PARIZAU INC.
MECHANICAL HI ANGIS & ASSOCIATES LTD., CROSSEY ENGINEERING LTD.
ELECTRICAL WELVEY & BROWN INTERNATIONAL INC.
CIVIL WSP | PARSONS INC.
LANDSCAPE HERSCHELS DESIGN INC., PWP LANDSCAPE ARCHITECTURE
BUILDING CODE LMCG BUILDING CODE CONSULTANTS LTD.

AUTHOR PROJECT NO. PCL2301_C

STAMP

DRAWING TITLE
PLANTING ENLARGEMENTS

DRAWN	CHECKED

SCALE AT 40" x 60" AS NOTED DATE 19-SEPT-2025

GRAPHIC SCALE AS NOTED

DRAWING NO.	REV NO.
L27-116	02