


- LEGEND**
- 200mm Ø WM: PROPOSED WATERMAIN
  - V&VB: VALVE & VALVE BOX
  - HYD: PROPOSED HYDRANT CW VALVE & LEAD
  - T/F=98.45: PROPOSED TOP OF BOTTOM FLANGE
  - BEND: PROPOSED BEND AND THRUSTBLOCK 11.25', 22.5', 45' or TEE (SEE PLAN AND PROFILES)
  - SERVICE CONNECTION STUB (SINGLE): 100mm STORM @ 1.0%, 19mm WATER, 125mm SANITARY @ 1.0%
  - PROPOSED SANITARY MH & SEWER
  - PROPOSED STORM MH & SEWER
  - LYCB: PROPOSED LANDSCAPE TEE CATCHBASIN & PERFORATED SUBDRAIN PER S29, S30, S31
  - LYCB: PROPOSED LANDSCAPE ELBOW CATCHBASIN & PERFORATED SUBDRAIN PER S29, S30, S31
  - RYCBMH: PROPOSED REAR YARD CATCHBASIN MANHOLE & LEAD
  - RYCB: PROPOSED REAR YARD CATCHBASIN & LEAD
  - CB: PROPOSED ROAD CATCHBASIN
  - DIRECTION OF FLOW
  - EXISTING 1.8m CONCRETE SIDEWALK
  - DRAINAGE EASEMENT
  - EXISTING FENCE - CHAINLINK
  - SIDEWALK REINSTATEMENT FOR DEPRESSED CURBS
  - UTILITY EASEMENT
  - PROPOSED OVERLAY

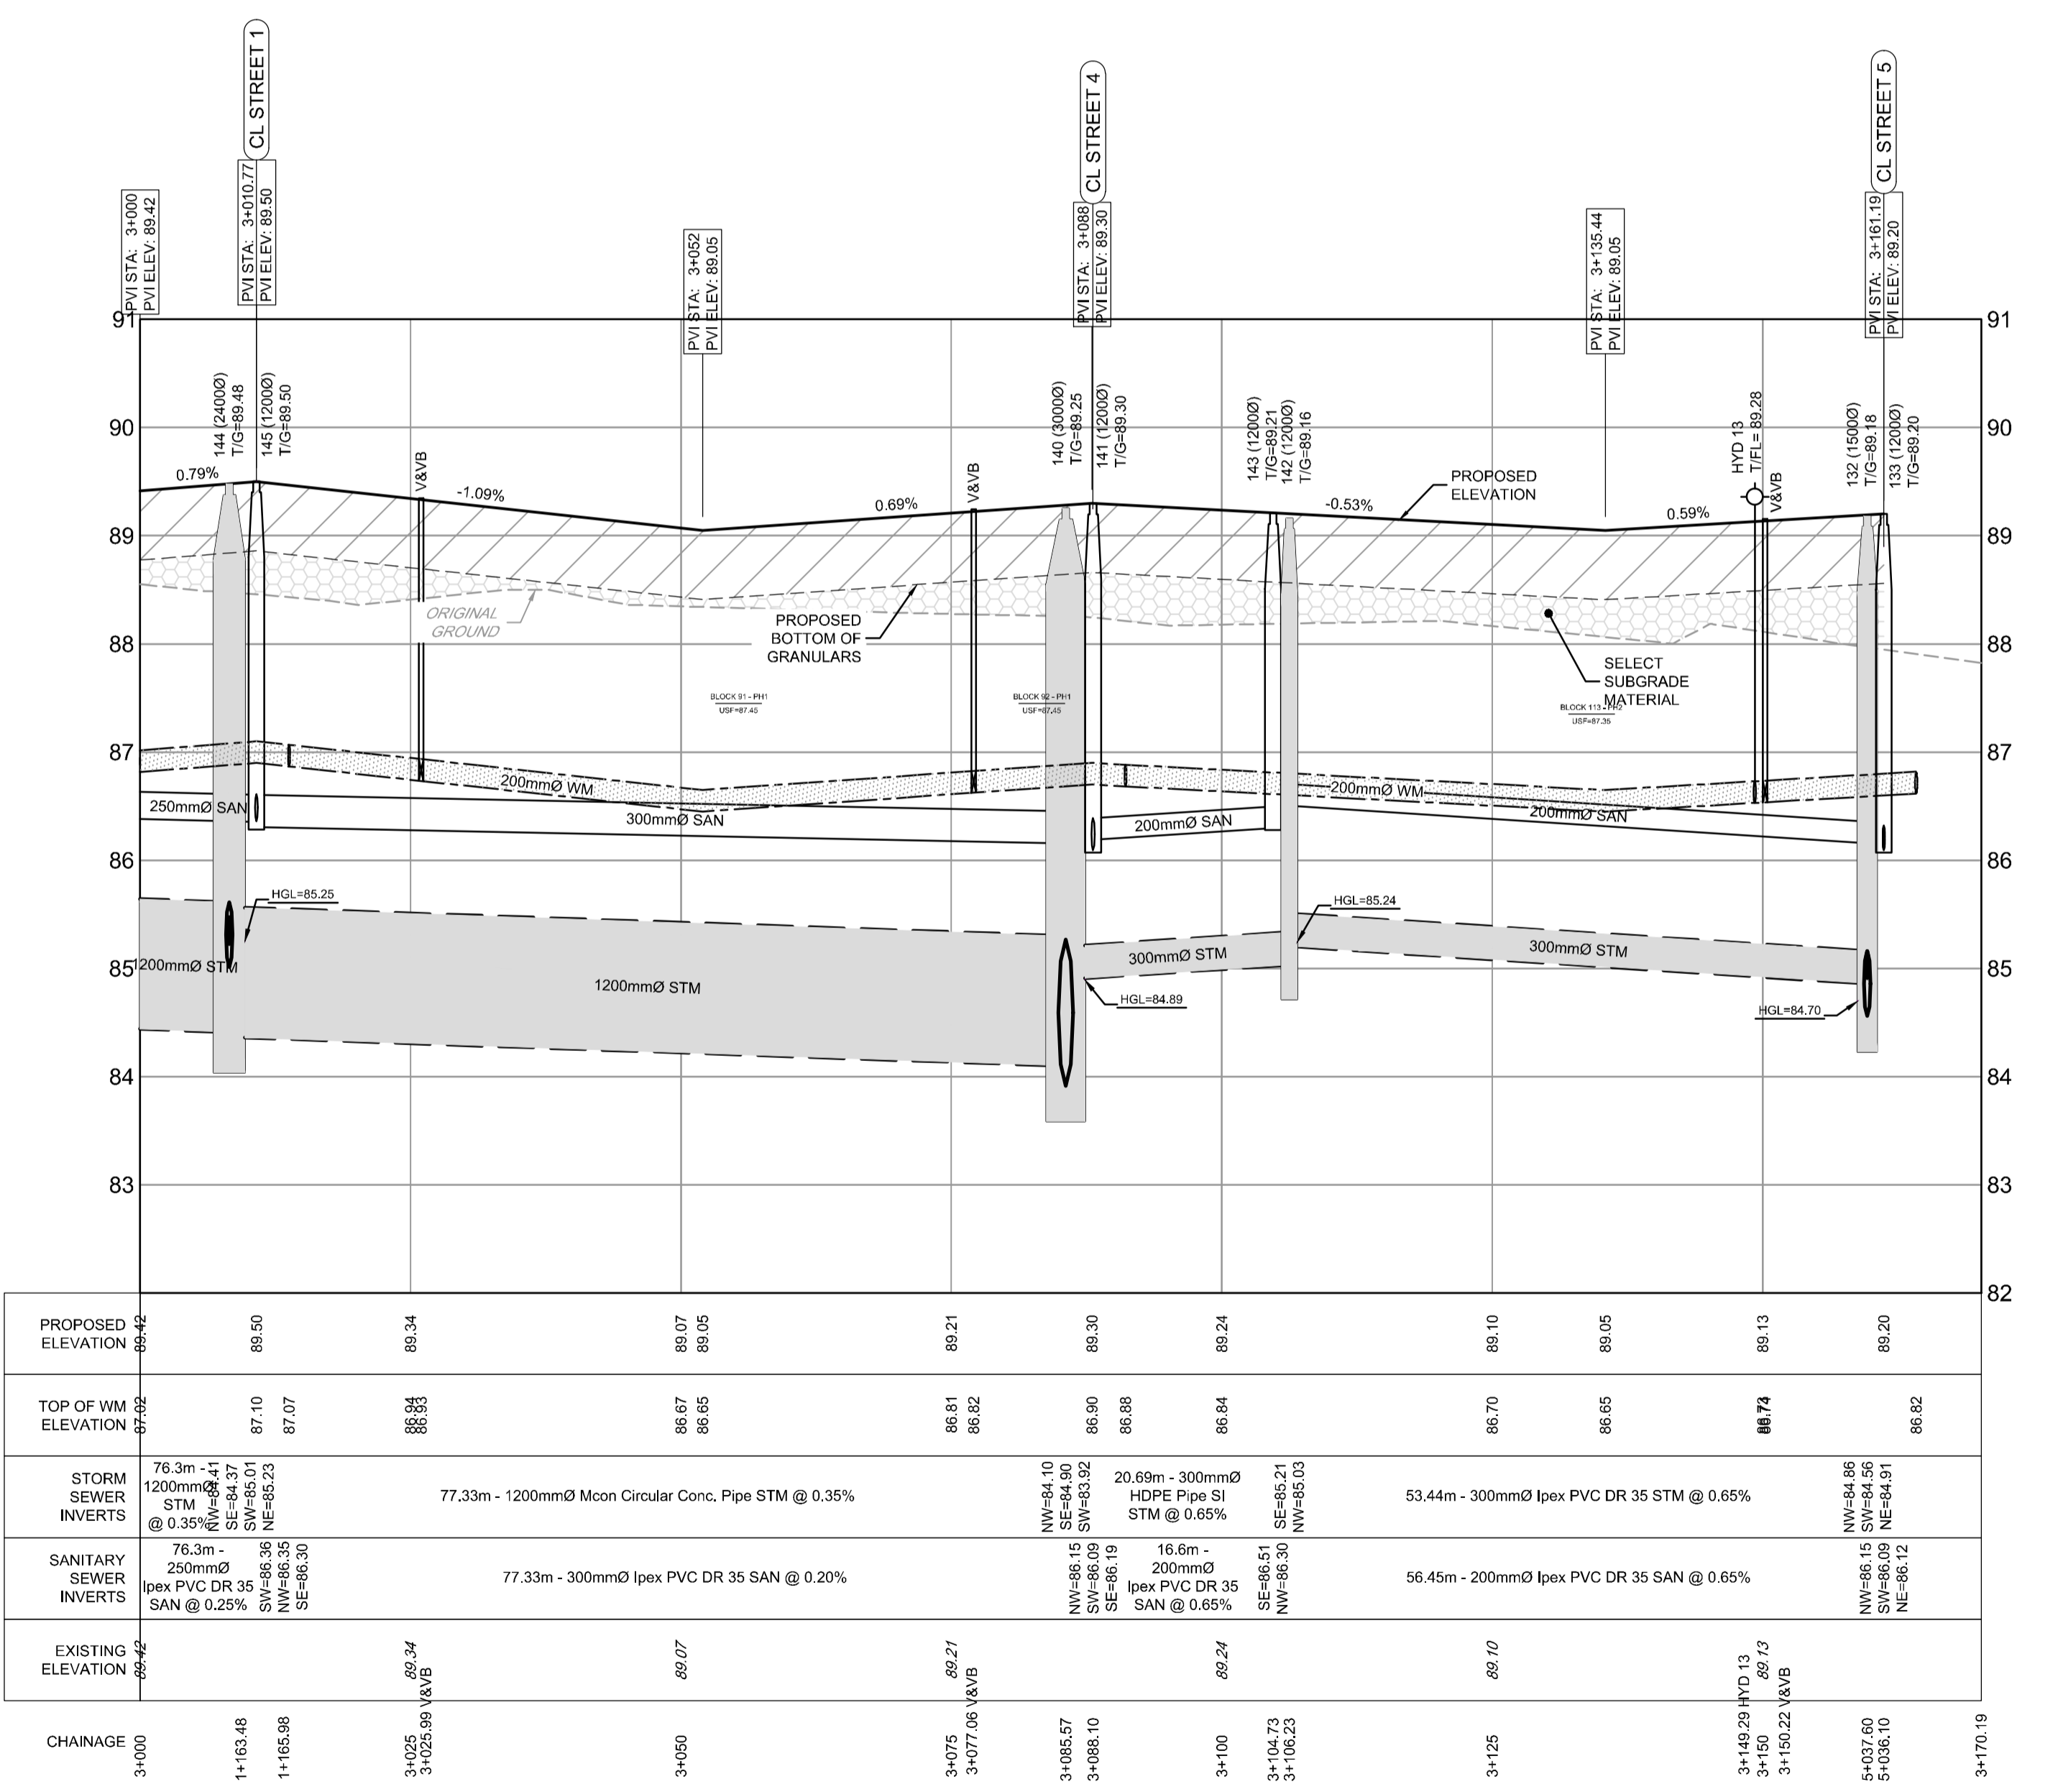

- LEGEND**
- TP 19-17 97.13: TEST PIT LOCATION
  - TOP SOIL
  - SAND
  - SILTY SAND
  - SILTY CLAY
  - GLACIAL TILL
  - WEATHERED BEDROCK

NOTE: THE POSITION OF ALL POLE LINES, CONDUITS, WATERMANS, SEWERS AND OTHER UNDERGROUND AND OVERGROUND UTILITIES AND STRUCTURES IS NOT NECESSARILY SHOWN ON THE CONTRACT DRAWINGS, AND WHERE SHOWN, THE ACCURACY OF THE POSITION OF SUCH UTILITIES AND STRUCTURES IS NOT GUARANTEED. BEFORE STARTING WORK, DETERMINE THE EXACT LOCATION OF ALL SUCH UTILITIES AND STRUCTURES AND ASSUME ALL LIABILITY FOR DAMAGE TO THEM.

**PRELIMINARY**

No.	REVISION	DATE	BY
2.	ISSUED FOR REVIEW	JUN 18/21	BHB
1.	ISSUED FOR DISCUSSION	MAR 5/21	BHB

SCALE: 1 : 500

DESIGN: DJC

CHECKED: BCS

DRAWN: DJC

CHECKED: BCS

APPROVED: BHB

**FOR REVIEW ONLY**

LICENSED PROFESSIONAL ENGINEER  
B. H. BAHIA  
100164647  
June 19, 2021  
PROVINCE OF ONTARIO

**NOVATECH**  
Engineers, Planners & Landscape Architects  
Suite 200, 240 Michael Cowpland Drive  
Ottawa, Ontario, Canada K2M 1P6  
Telephone: (613) 254-9643  
Facsimile: (613) 254-5867  
Website: www.novatech-eng.com

LOCATION: CITY OF OTTAWA THE COMMONS

DRAWING NAME: PLAN AND PROFILE STREET 3 STATION 3+000 TO 3+170

PROJECT No.: 118224-00

REV: REV # 2

DRAWING No.: 118224-PR5